

THE GOLD STAR
MEMORIAL HIGHWAY

MAINE TURNPIKE AUTHORITY

DANIEL E. WATHEN, CHAIR
 ROBERT D. STONE, VICE CHAIR
 MICHAEL J. CIANCHETTE, MEMBER
 JOHN E. DORITY, MEMBER
 ANN R. ROBINSON, MEMBER
 THOMAS J. ZUKE, MEMBER
 KAREN S. DOYLE, MEMBER EX-OFFICIO
 S. PETER MILLS, EXECUTIVE DIRECTOR

YORK TOLL PLAZA MM 7.9 to MM 9.6 CONTRACT 2018.20

VOLUME 2 OF 3


INDEX OF SHEETS

VOLUME 1 HIGHWAY		VOLUME 3 STRUCTURAL	
SHEET NO.	DESCRIPTION	SHEET NO.	DESCRIPTION
1	TITLE SHEET	294-354	STRUCTURAL PLANS
2	LEGEND		<u>MECHANICAL AND ELECTRICAL</u>
3-4	ESTIMATED QUANTITIES AND EARTHWORK SUMMARY		<u>DESCRIPTION</u>
5-6	GENERAL NOTES	355-374	ELECTRICAL PLANS
7-19	TYPICAL SECTIONS AND PAVEMENT DETAILS	375-390	PLUMBING AND FIRE PROTECTION PLANS
20-23	DRAINAGE SUMMARY SHEETS	391-420	MECHANICAL PLANS
24-34	BARRIER DETAILS	421-450	TOLLING SYSTEMS PLANS
35-38	DRAINAGE DETAILS	451-461	SECURITY AND COMMUNICATION PLANS
39	EROSION CONTROL DETAILS		<u>UTILITIES</u>
40-41	MISCELLANEOUS DETAILS		<u>DESCRIPTION</u>
42	RUMBLE STRIP DETAILS	462-464	UTILITY PLANS
43-44	LIMITS OF DISTURBANCE PLANS	465-467	UTILITY DETAILS
45-47	CONSTRUCTION STAGING		<u>ARCHITECTURAL</u>
48-75	MAINTENANCE OF TRAFFIC		<u>DESCRIPTION</u>
76-91	MOT CRITICAL SECTIONS AND DETAILS	468-473	PLAZA PLANS
92-93	CONSTRUCTION SIGN SUMMARY	474-489	ADMINISTRATION BUILDING PLANS
94-111	GENERAL PLANS		
112-116	SITE PLANS		
117-121	STORMWATER TREATMENT PLAN		
122-151	SIGNING AND STRIPING PLANS		
152-166	LIGHTING PLANS		
VOLUME 2 HIGHWAY			
SHEET NO.	DESCRIPTION		
167-198	PROFILES		
199-293	CROSS SECTIONS		

CONTRACT 2018.20



Date: 8/28/2018

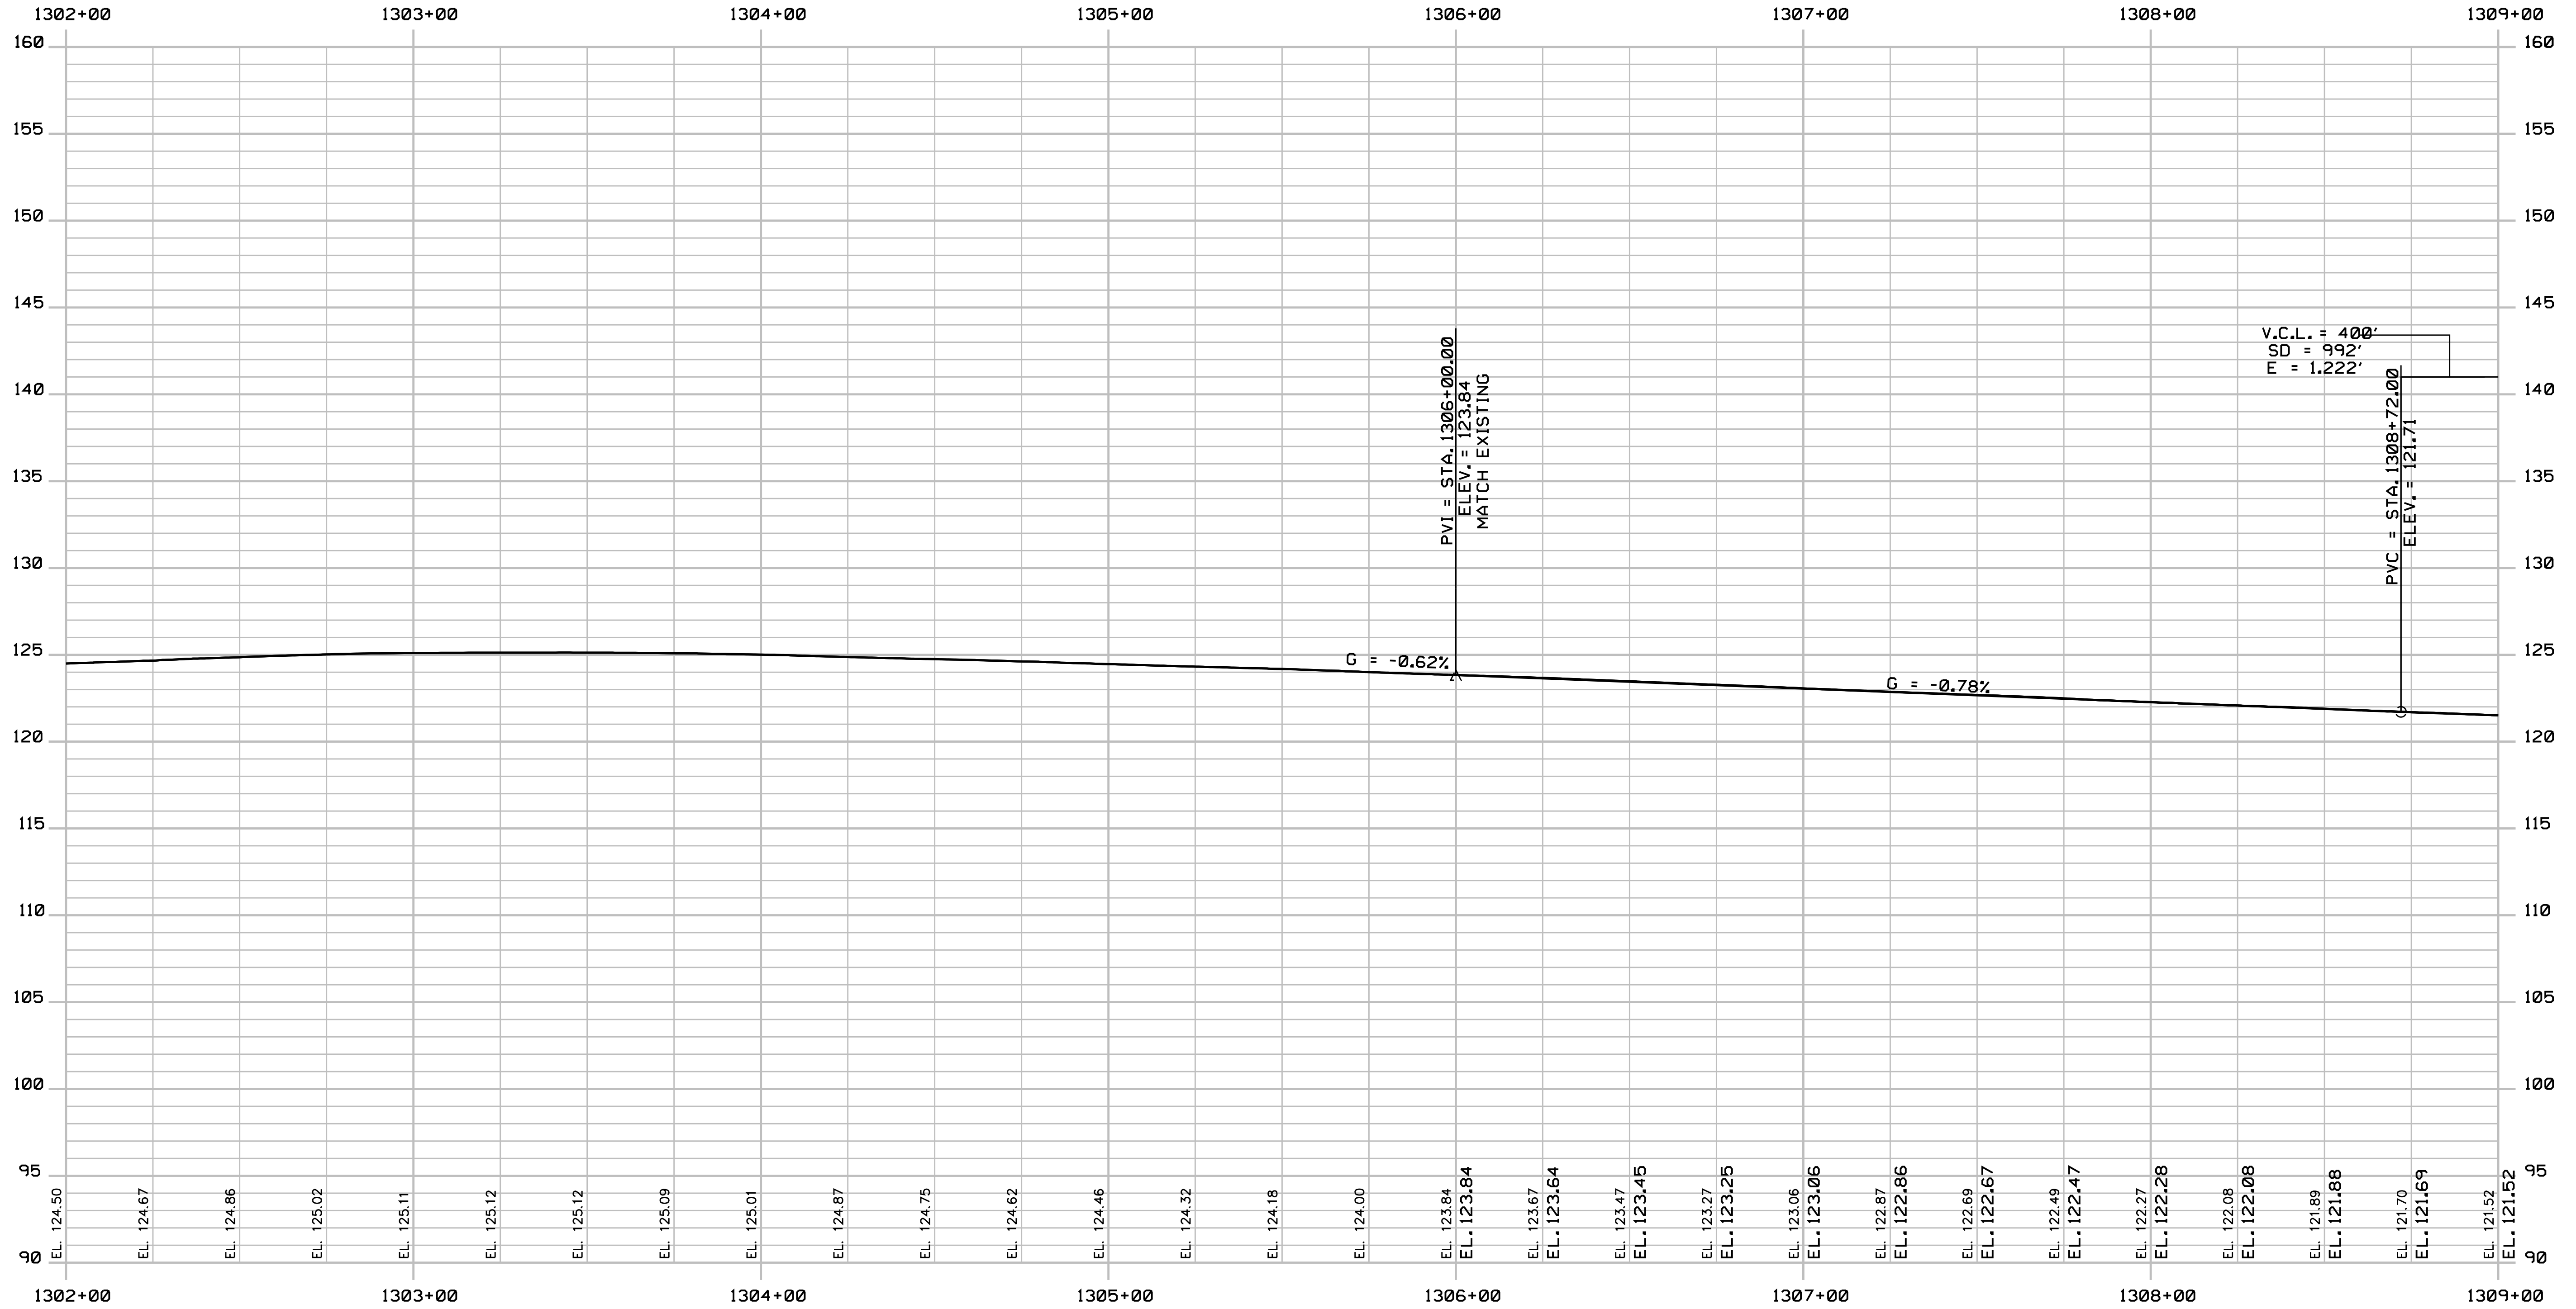

PROFILE

Filename: ...167_Profile_195NB_01.dgn

Scale:
 Horizontal: 1" = 25'
 Vertical: 1" = 5'

No.	Revision	By	Date


Designed by:

JACOBS

CONSULTANT PROJECT MANAGER: T. MORIN

	By	Date	Checked	By	Date
Designed	CSM	7-18	Checked	RRP	7-18
Drawn	SMG	7-18	In Charge of	TWM	7-18

JACOBS ENGINEERING GROUP
 120 ST. JAMES AVENUE
 BOSTON, MA 02116
 TEL (617) 242-9222
 FAX (617) 242-9824



THE GOLD STAR
MEMORIAL HIGHWAY


MTA PROJECT MANAGER: R. NORWOOD

YORK TOLL PLAZA
 I-95 NORTHBOUND PROFILE 1

SHEET NUMBER: PR-01
 CONTRACT: 2018.20
 167 OF 489

Date: 8/28/2018

Filename: ... \168_Profile_195NB_02.dgn

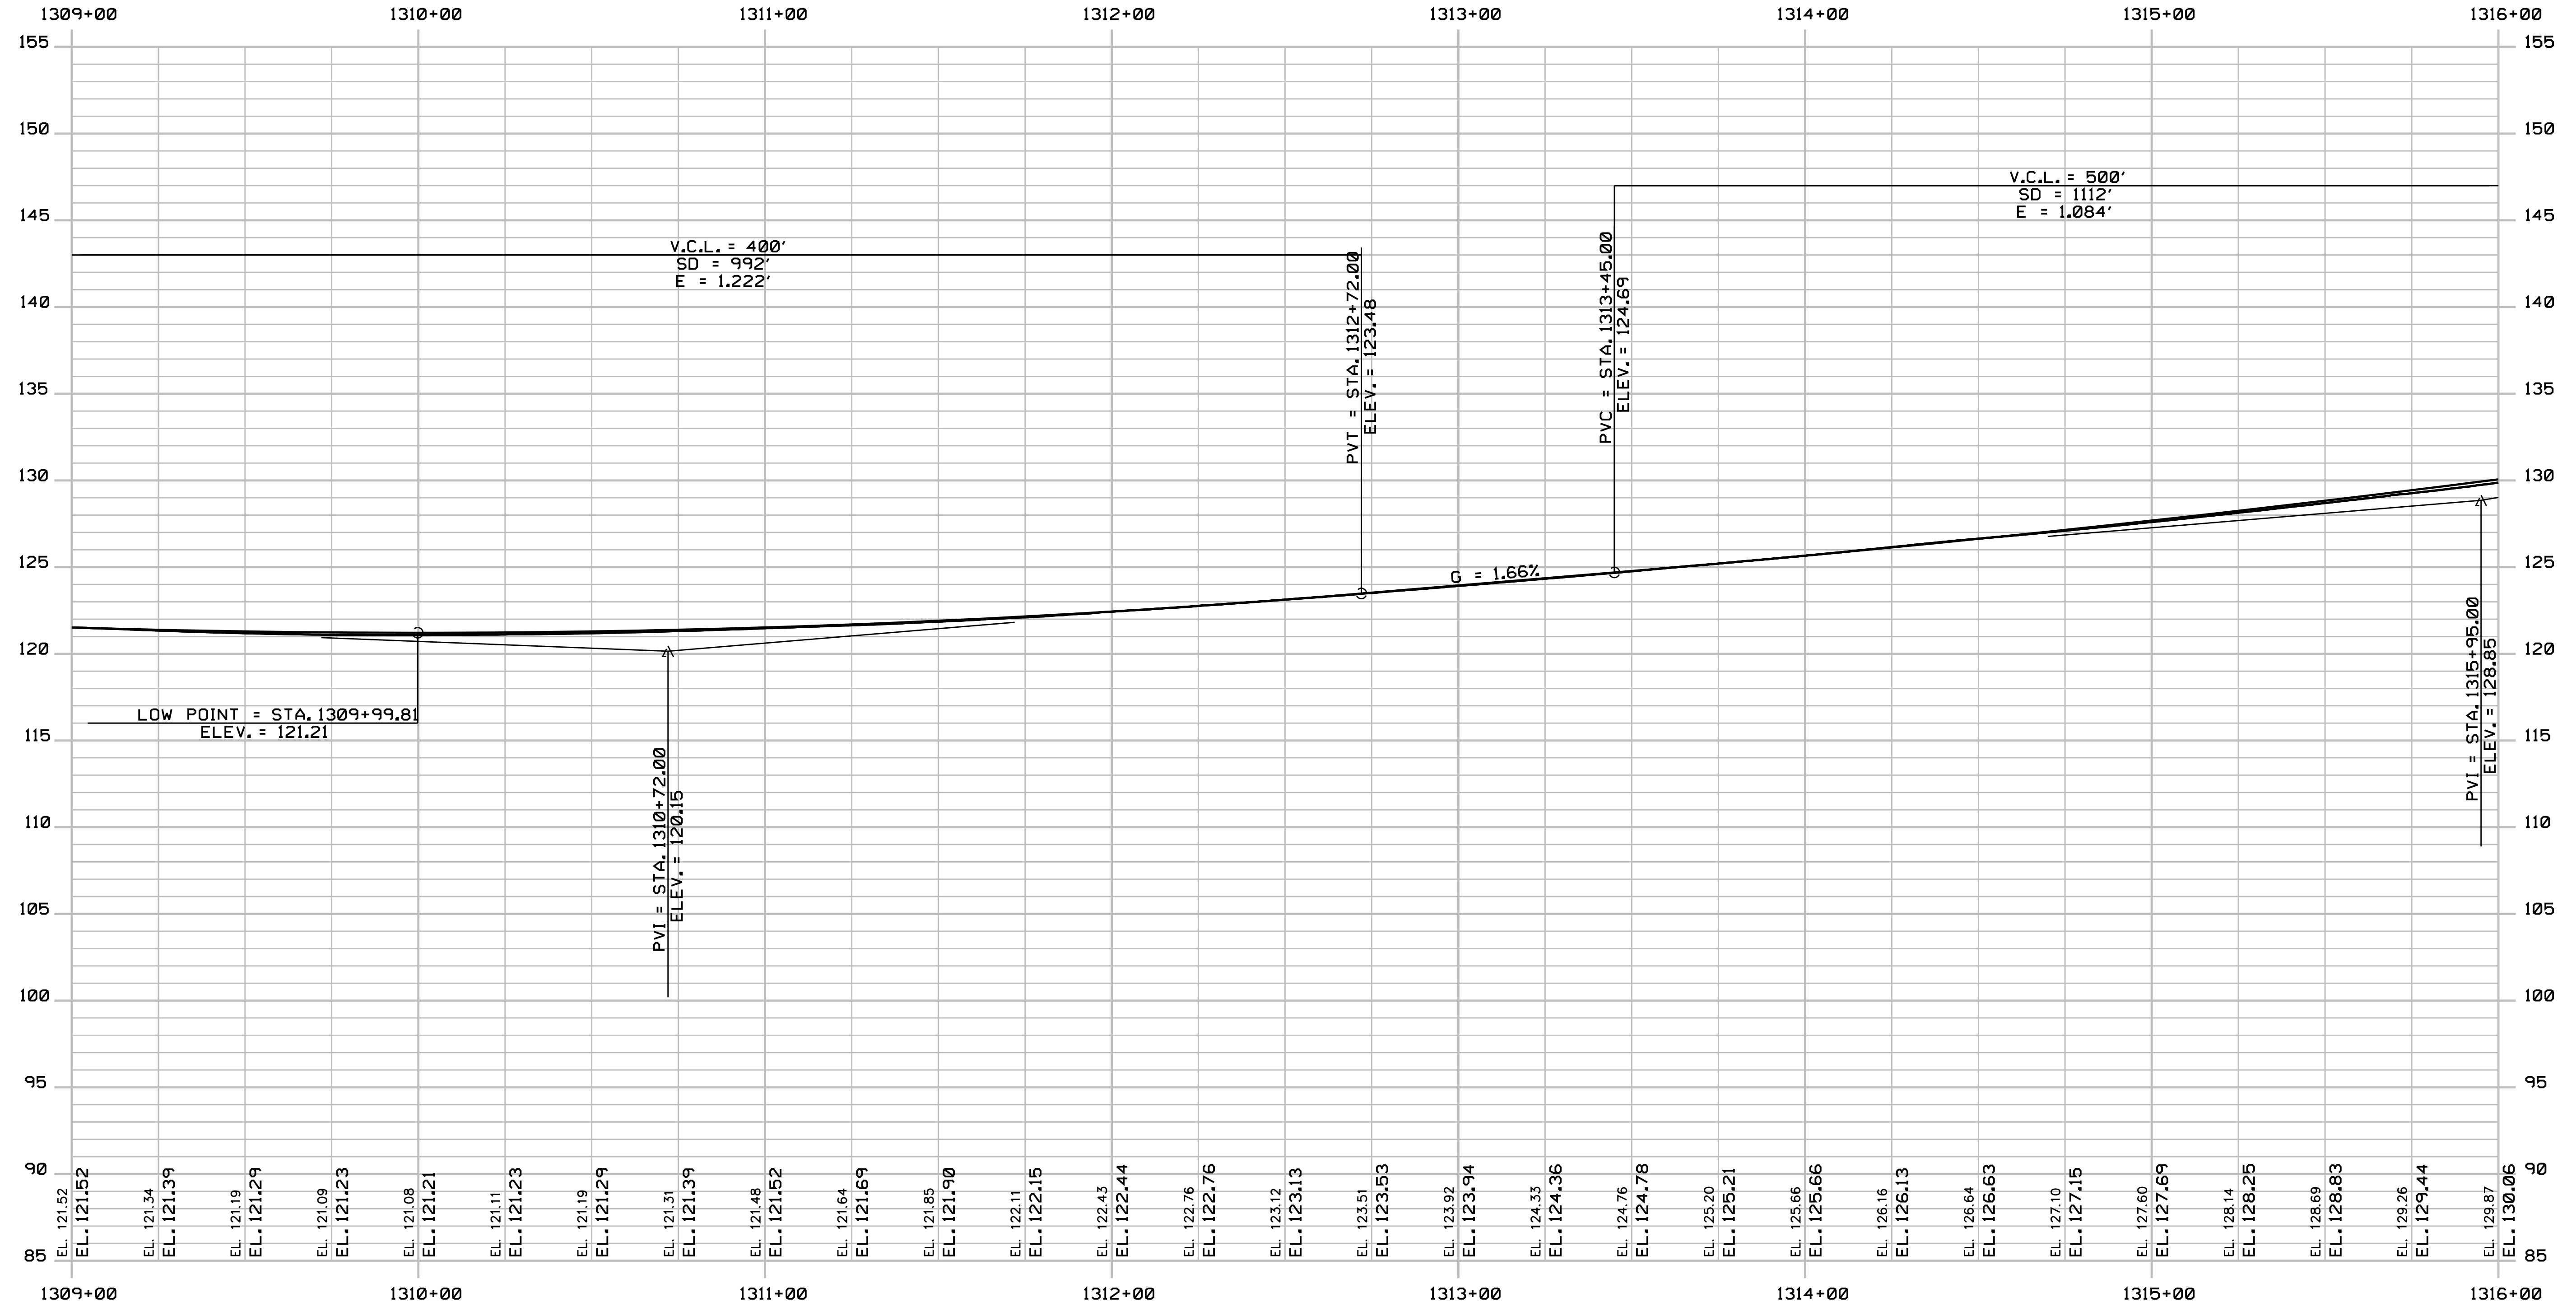

PROFILE

Scale:
 Horizontal: 1" = 25'
 Vertical: 1" = 5'

No.	Revision	By	Date

Designed by:

JACOBS

CONSULTANT PROJECT MANAGER: T. MORIN

	By	Date		By	Date
Designed	CSM	7-18	Checked	RRP	7-18
Drawn	SMG	7-18	In Charge of	TWM	7-18

JACOBS ENGINEERING GROUP
 120 ST. JAMES AVENUE
 BOSTON, MA 02116
 TEL (617) 242-9222
 FAX (617) 242-9824

MAINE TURNPIKE

THE GOLD STAR
 MEMORIAL HIGHWAY

MTA PROJECT MANAGER: R. NORWOOD

YORK TOLL PLAZA

I-95 NORTHBOUND PROFILE 2


SHEET NUMBER: PR-02

CONTRACT: 2018.20

168 OF 489

Date: 8/28/2018

Filename: ... \169_Profile_195NB_03.dgn

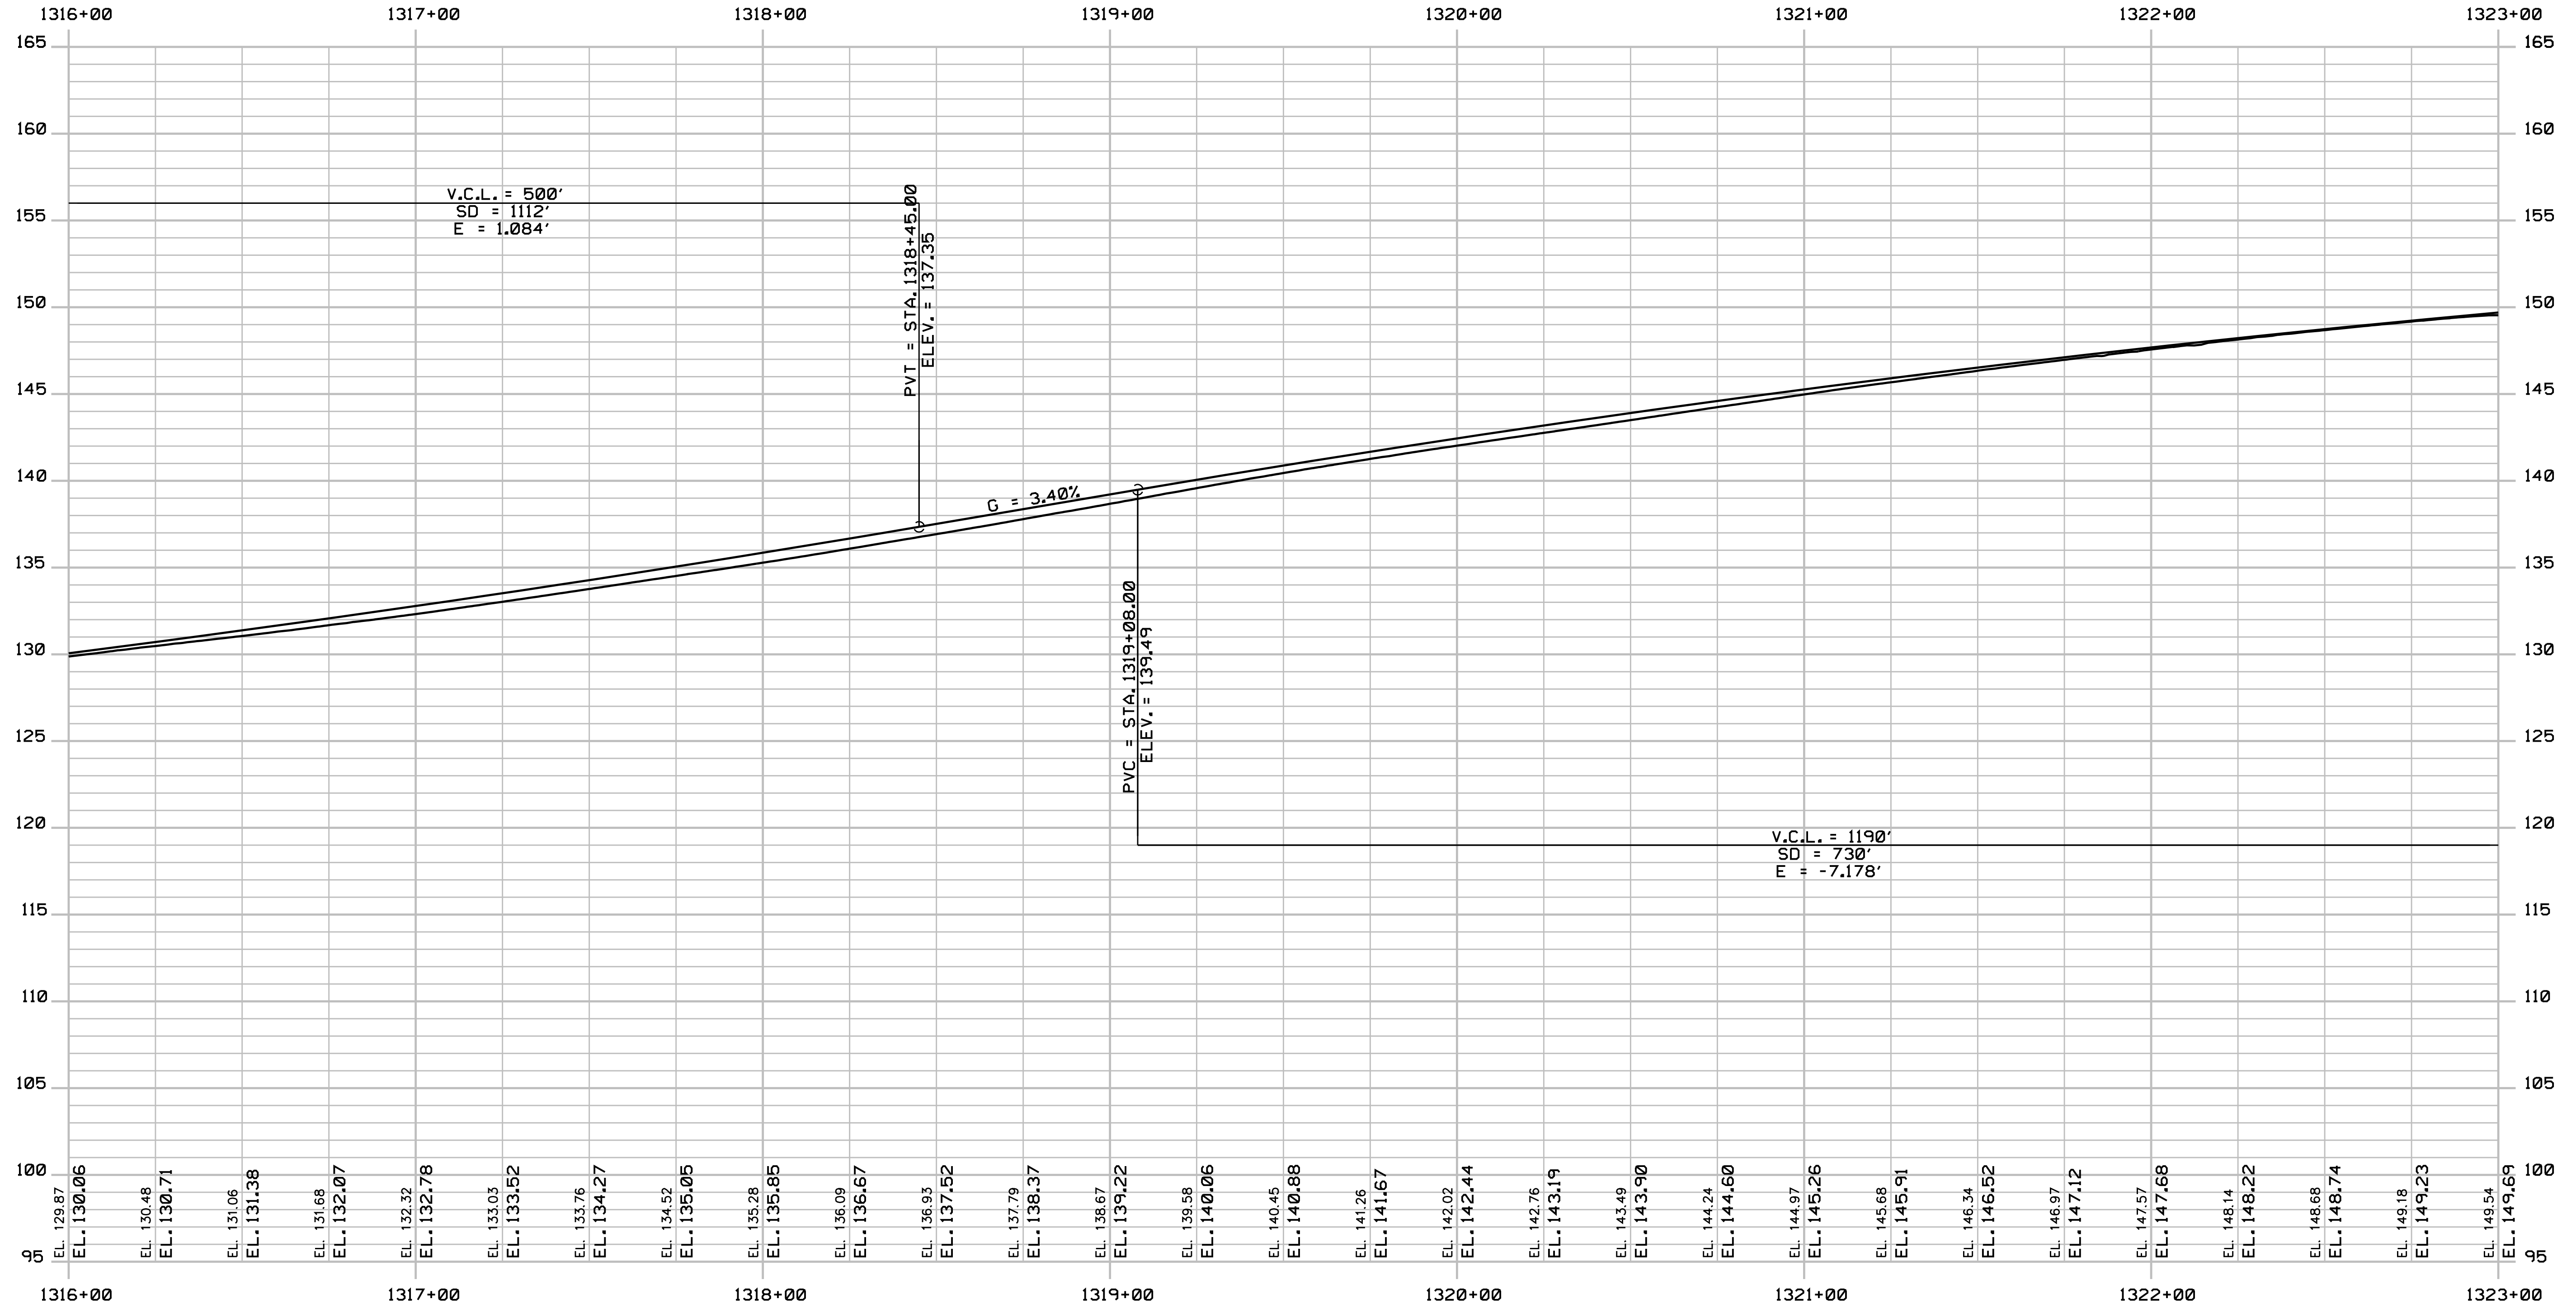

PROFILE

Scale:
 Horizontal: 1" = 25'
 Vertical: 1" = 5'

No.	Revision	By	Date


Designed by:

JACOBS

CONSULTANT PROJECT MANAGER: T. MORIN

	By	Date		By	Date
Designed	CSM	7-18	Checked	RRP	7-18
Drawn	SMG	7-18	In Charge of	TWM	7-18

JACOBS ENGINEERING GROUP
 120 ST. JAMES AVENUE
 BOSTON, MA 02116
 TEL (617) 242-9222
 FAX (617) 242-9824



THE GOLD STAR
 MEMORIAL HIGHWAY


MTA PROJECT MANAGER: R. NORWOOD

YORK TOLL PLAZA
 I-95 NORTHBOUND PROFILE 3


SHEET NUMBER: PR-03
 CONTRACT: 2018.20
 169 OF 489

Date: 8/28/2018

Filename: ... \170_Profile_195NB_04.dgn

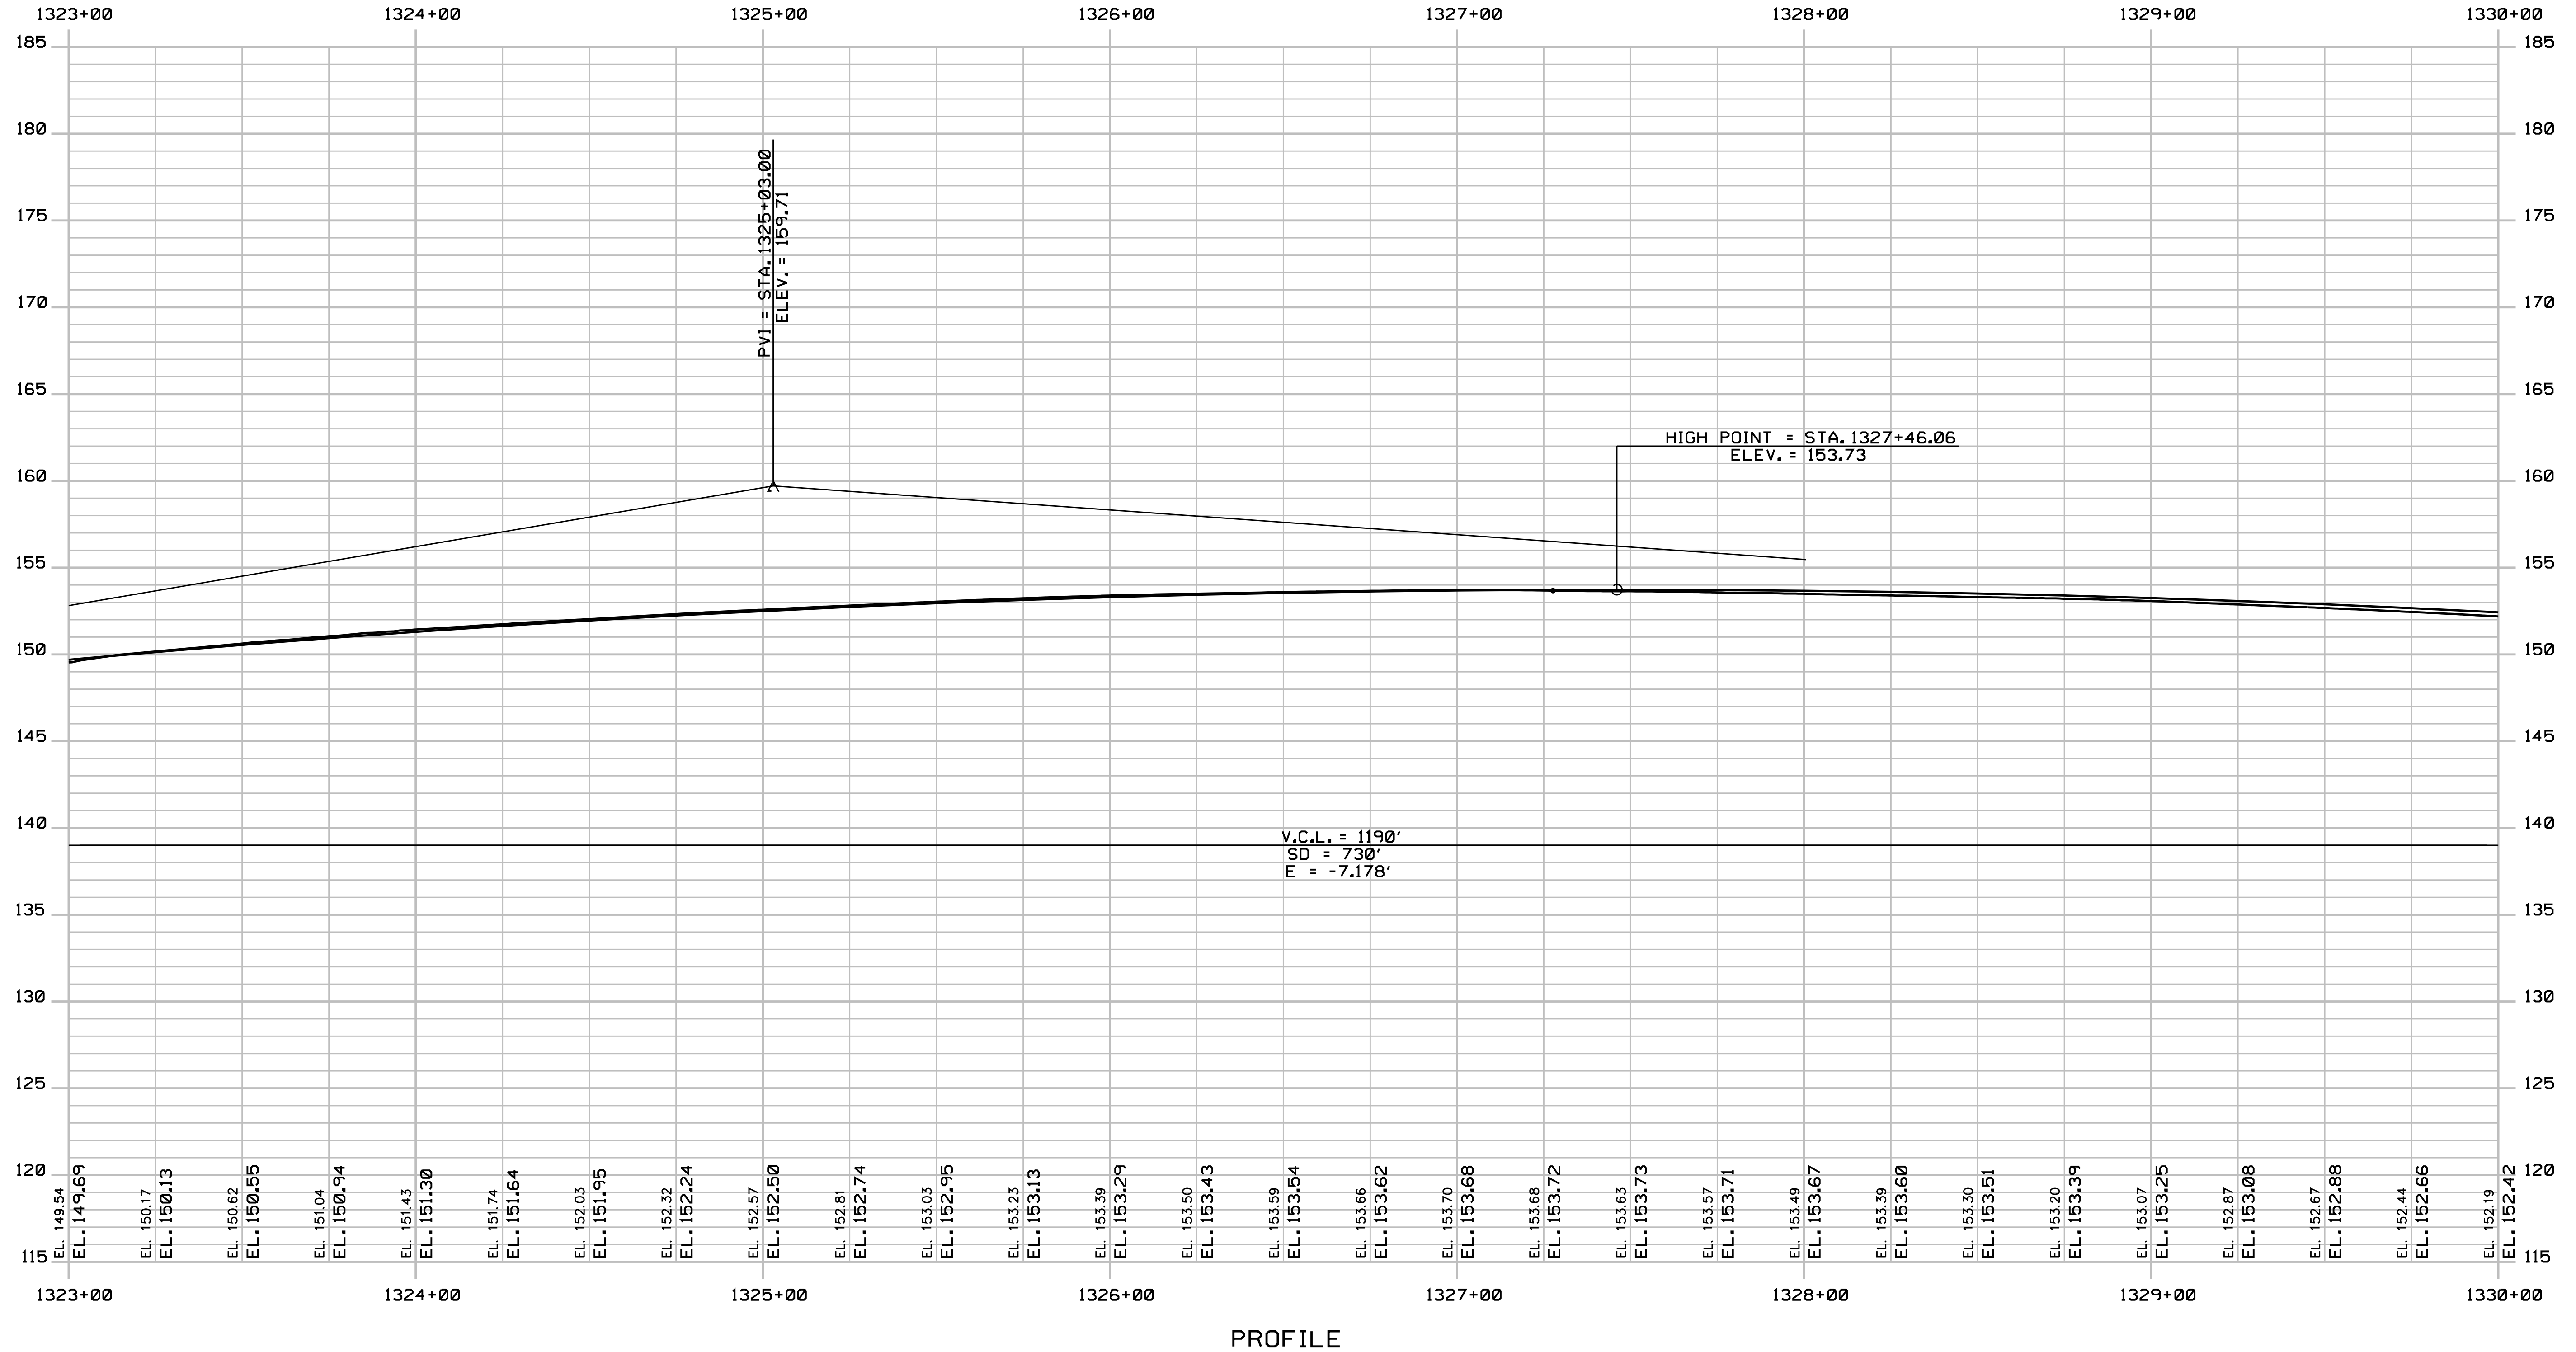

PROFILE

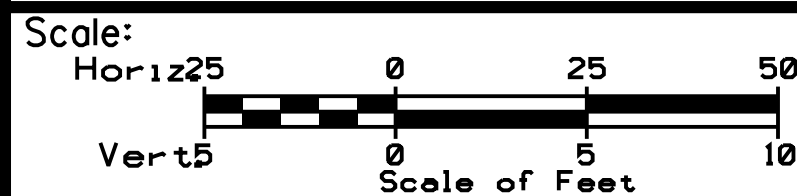

Designed by:



JACOBS ENGINEERING GROUP
120 ST. JAMES AVENUE
BOSTON, MA 02116
TEL (617) 242-9222
FAX (617) 242-9824



THE GOLD STAR
MEMORIAL HIGHWAY

YORK TOLL PLAZA
I-95 NORTHBOUND PROFILE 4

No.	Revision	By	Date

CONSULTANT PROJECT MANAGER: T. MORIN					
	By	Date		By	Date
Designed	CSM	7-18	Checked	RRP	7-18
Drawn	SMG	7-18	In Charge of	TWM	7-18


MTA PROJECT MANAGER: R. NORWOOD

CONTRACT: 2018.20

SHEET NUMBER: PR-04

170 OF 489

Date: 8/28/2018

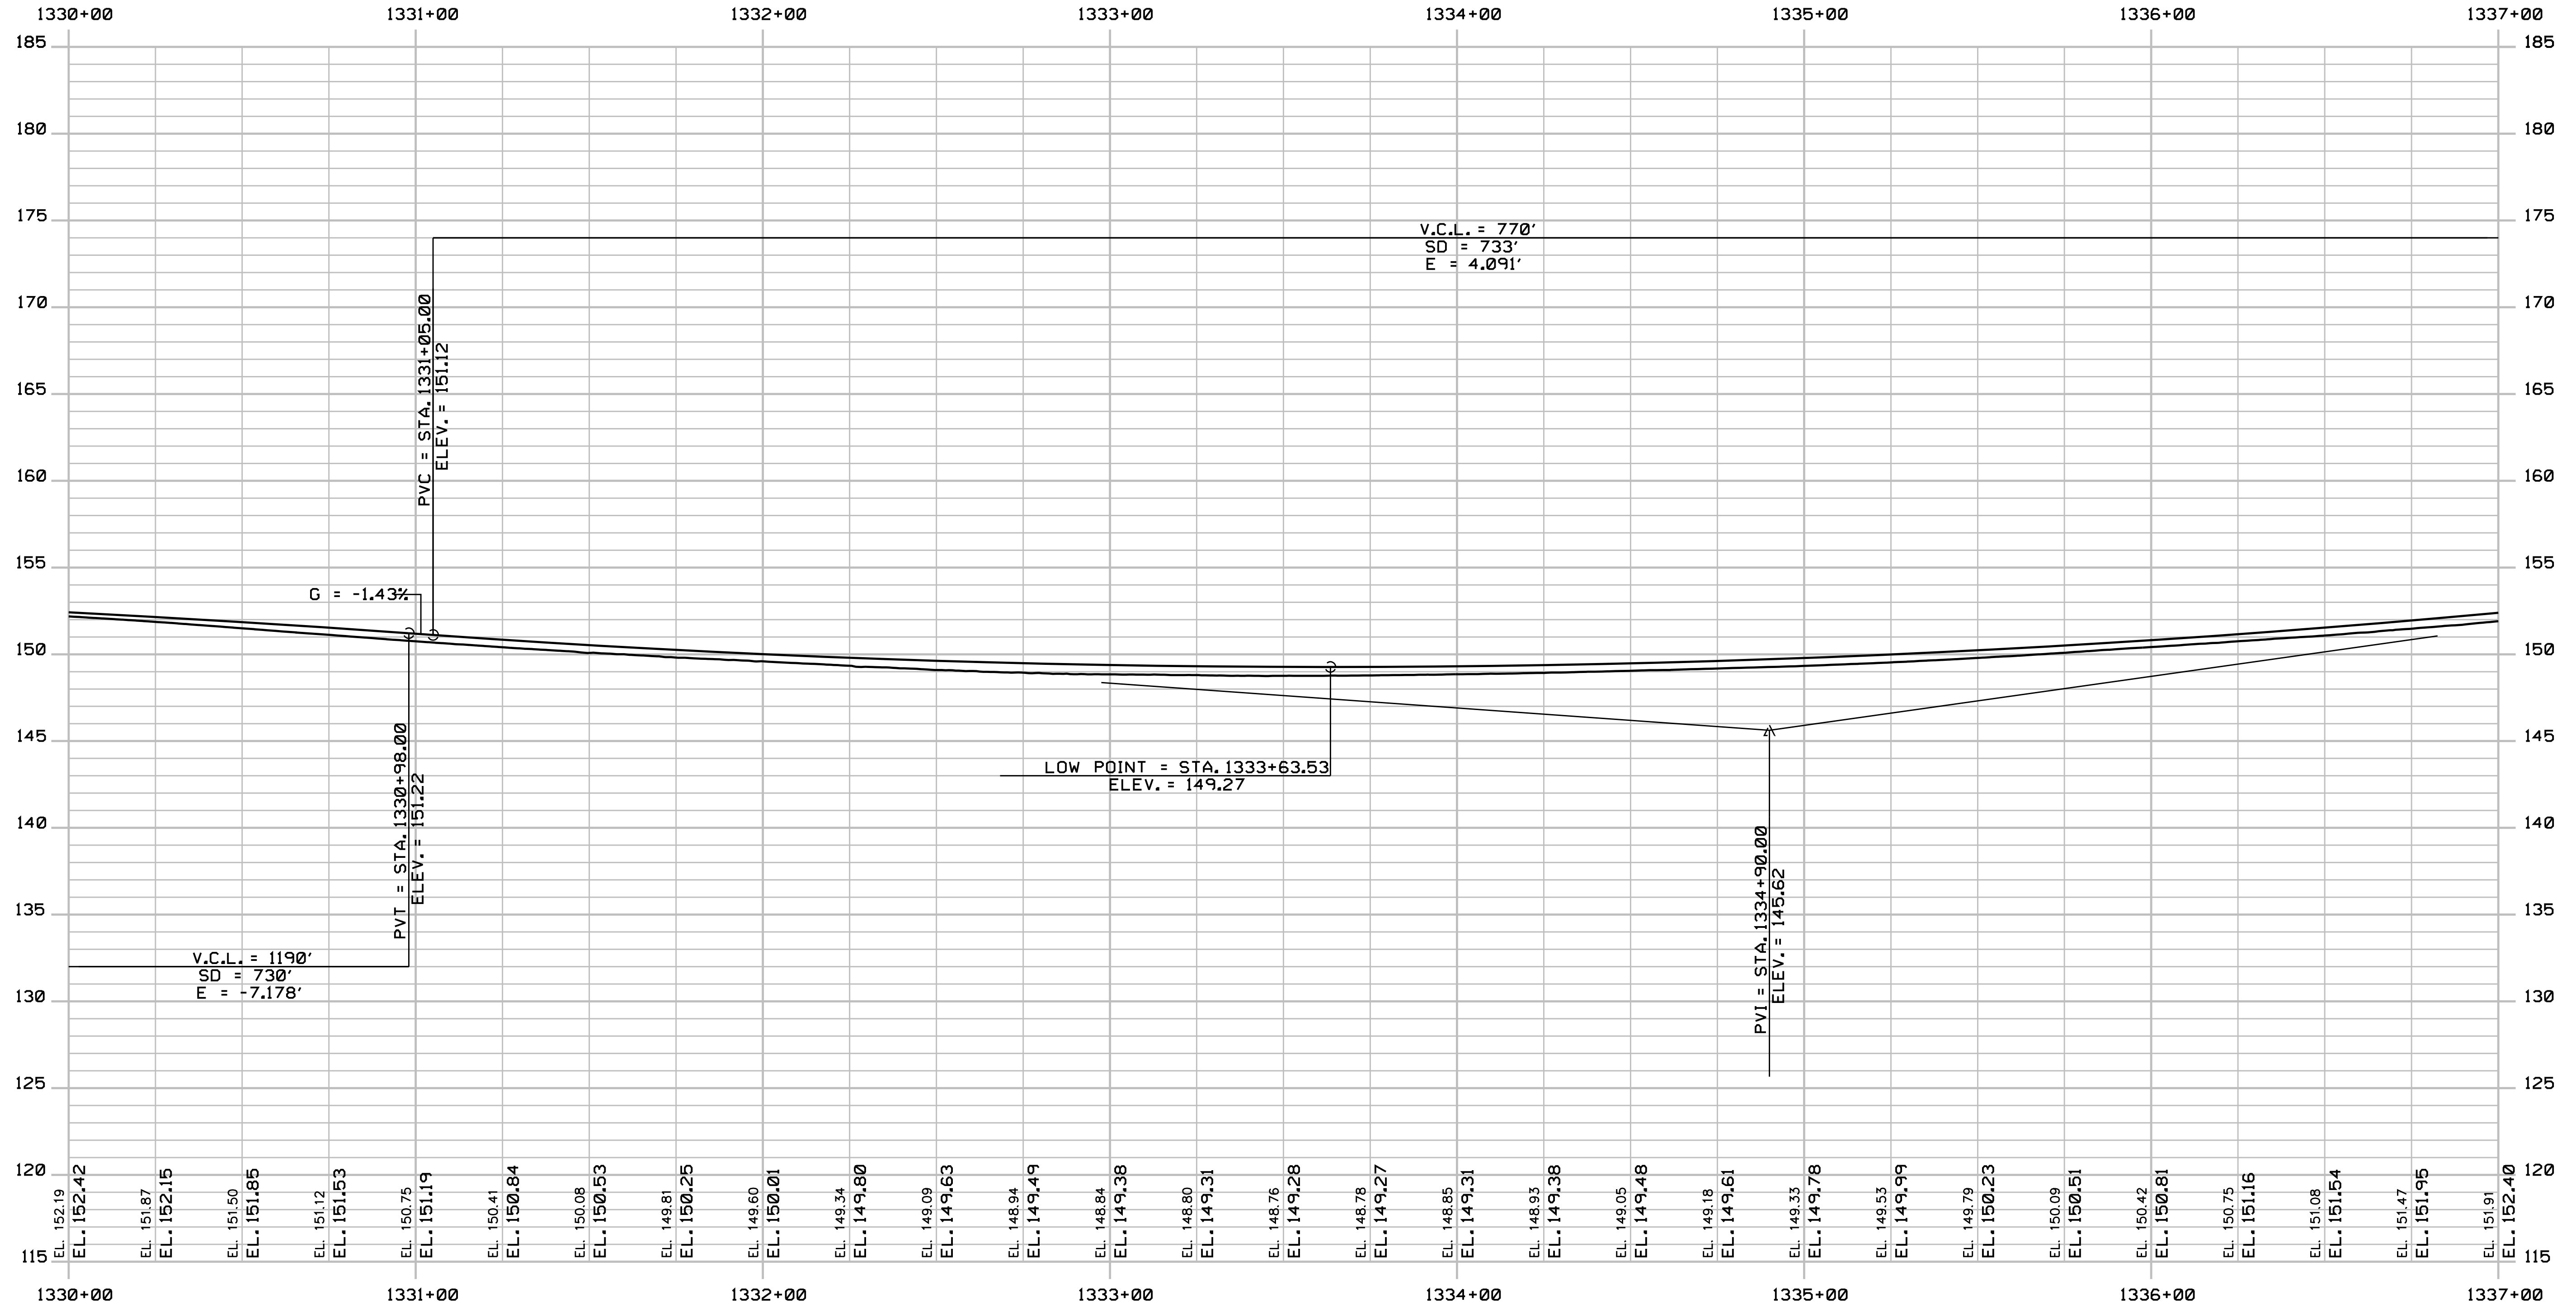

PROFILE

Filename: ...\\171_Profile_195NB_05.dgn

Scale:
 Horizontal: 1" = 25'
 Vertical: 1" = 5'

No.	Revision	By	Date

Designed by:

JACOBS

CONSULTANT PROJECT MANAGER: T. MORIN

	By	Date	Checked	By	Date
Designed	CSM	7-18	Checked	RRP	7-18
Drawn	SMG	7-18	In Charge of	TWM	7-18

JACOBS ENGINEERING GROUP
 120 ST. JAMES AVENUE
 BOSTON, MA 02116
 TEL (617) 242-9222
 FAX (617) 242-9824


THE GOLD STAR
 MEMORIAL HIGHWAY

MTA PROJECT MANAGER: R. NORWOOD

YORK TOLL PLAZA
 I-95 NORTHBOUND PROFILE 5

SHEET NUMBER: PR-05
 CONTRACT: 2018.20
 171 OF 489

Date: 8/28/2018

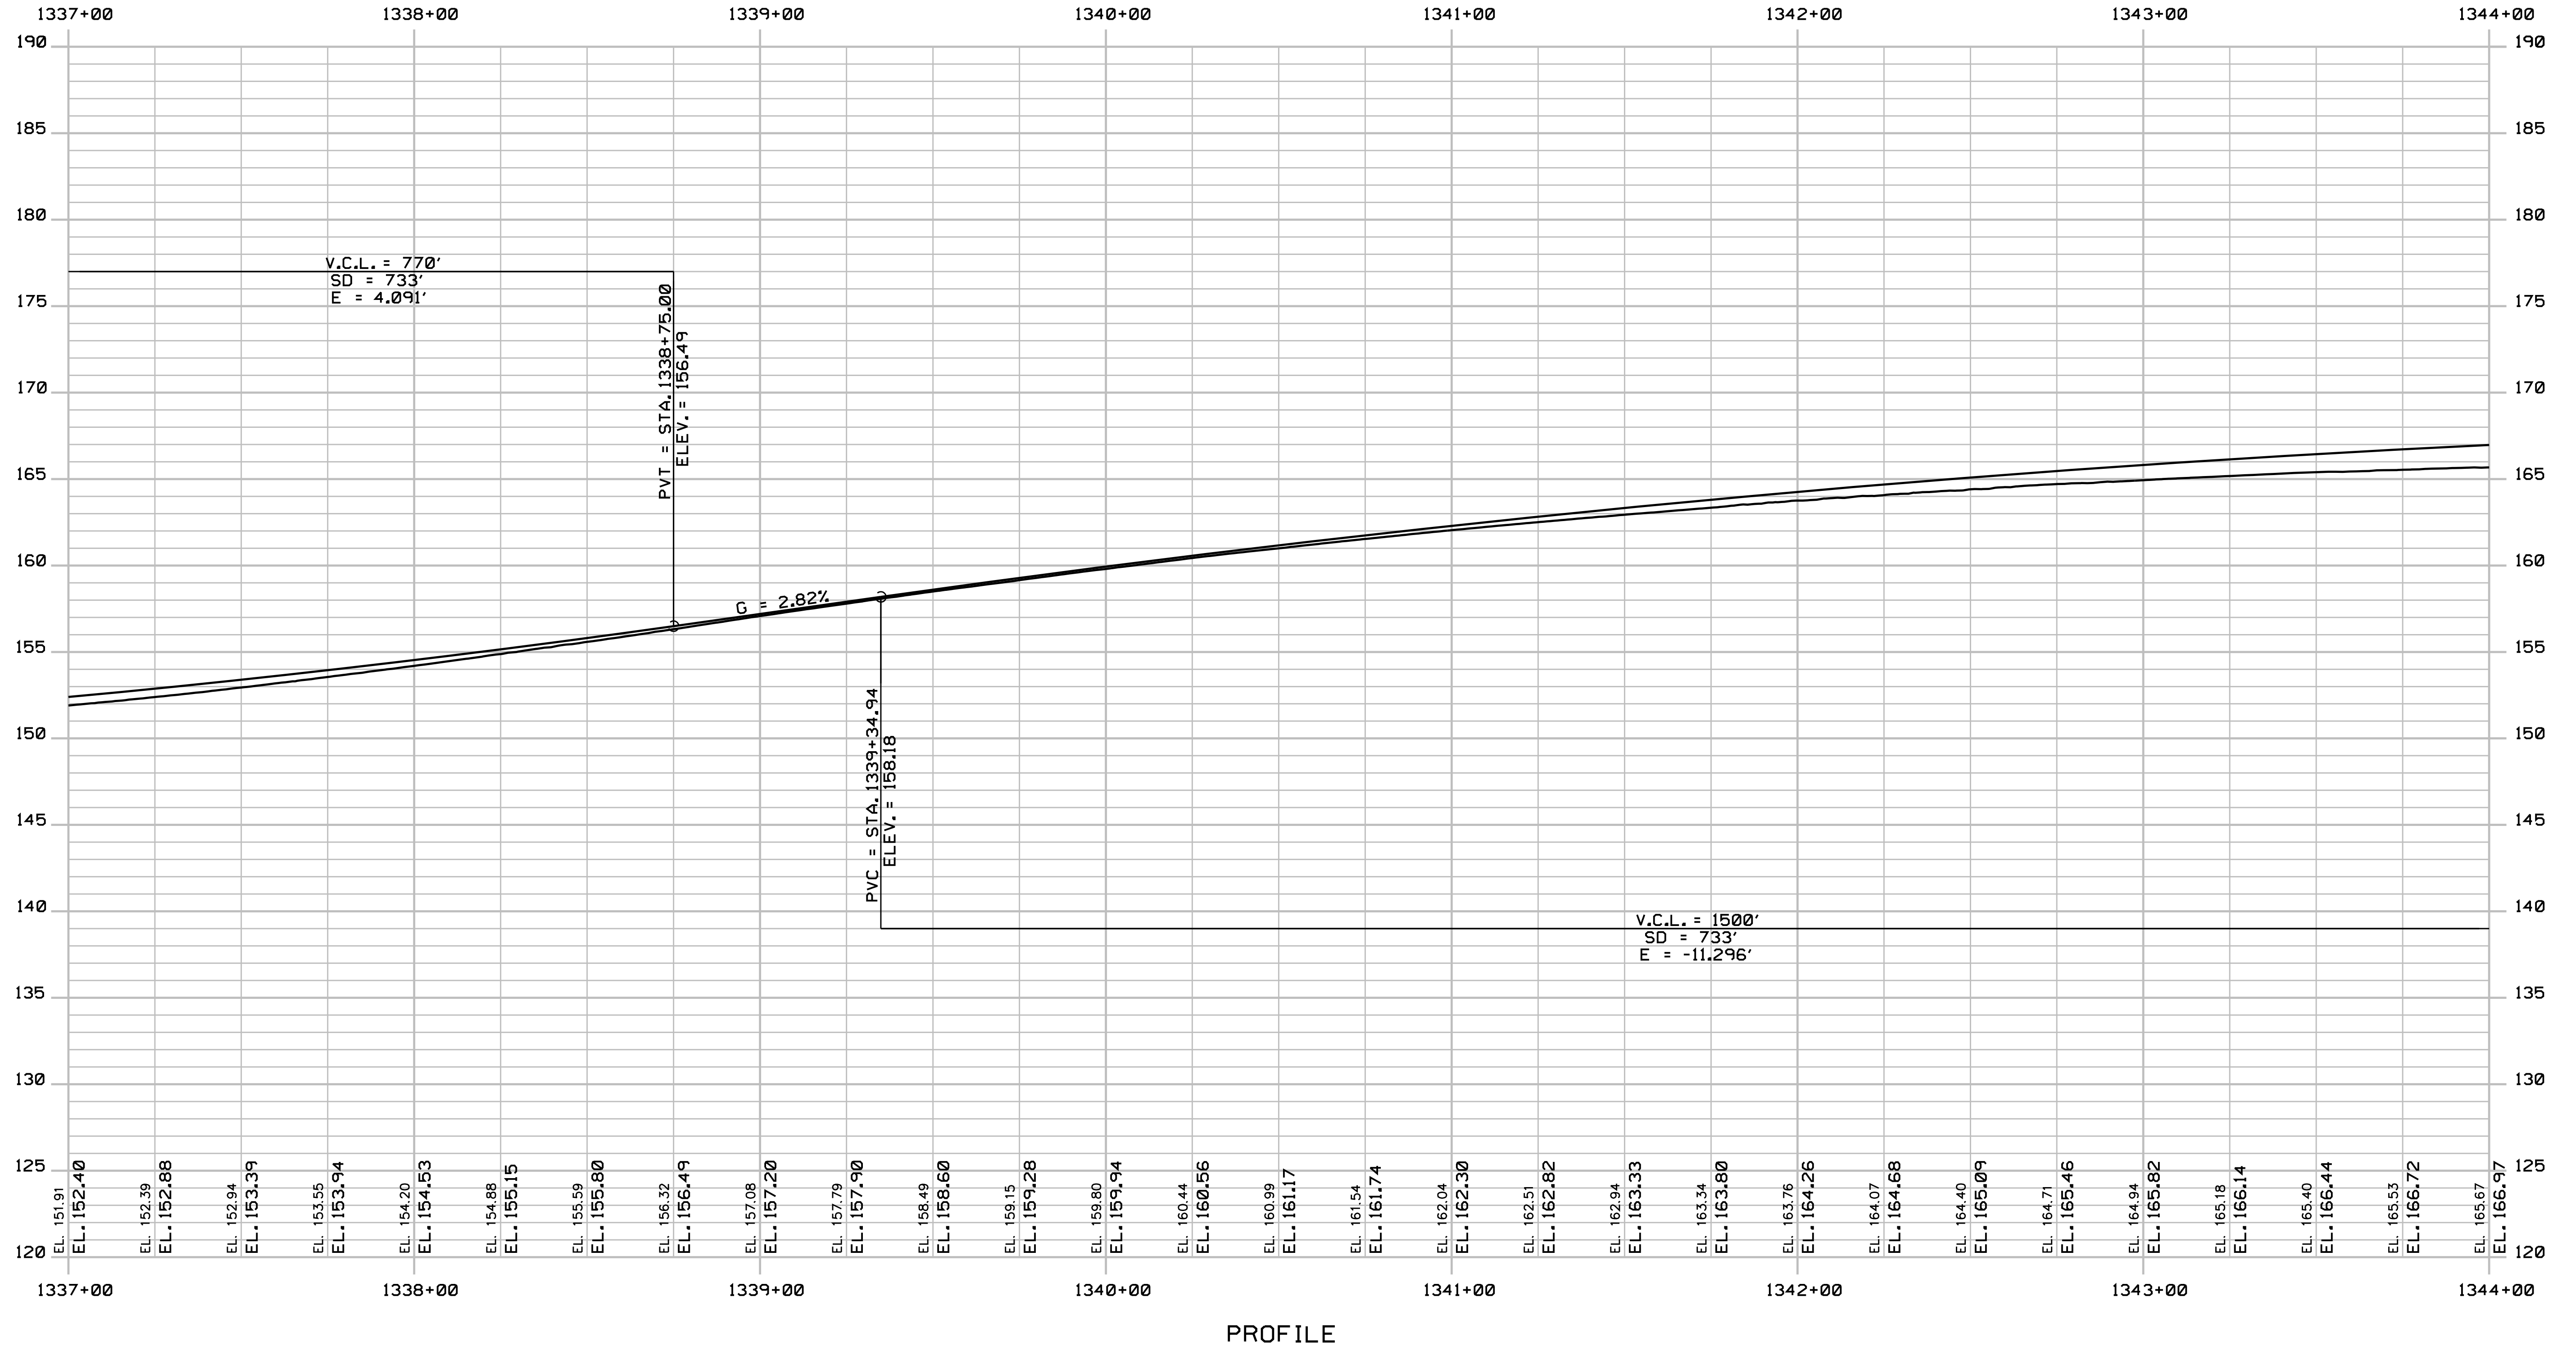

Filename: ...\\172_Profile_195NB_06.dgn

Scale:
Horizontal: 1" = 25'
Vertical: 1" = 5'

No.	Revision	By	Date

Designed by:

JACOBS

CONSULTANT PROJECT MANAGER: T. MORIN

	By	Date		By	Date
Designed	CSM	7-18	Checked	RRP	7-18
Drawn	SMG	7-18	In Charge of	TWM	7-18

JACOBS ENGINEERING GROUP
120 ST. JAMES AVENUE
BOSTON, MA 02116
TEL (617) 242-9222
FAX (617) 242-9824

MAINE TURNPIKE

THE GOLD STAR
MEMORIAL HIGHWAY

MTA PROJECT MANAGER: R. NORWOOD

YORK TOLL PLAZA


I-95 NORTHBOUND PROFILE 6

SHEET NUMBER: PR-06

CONTRACT: 2018.20

172 OF 489

Date: 8/28/2018

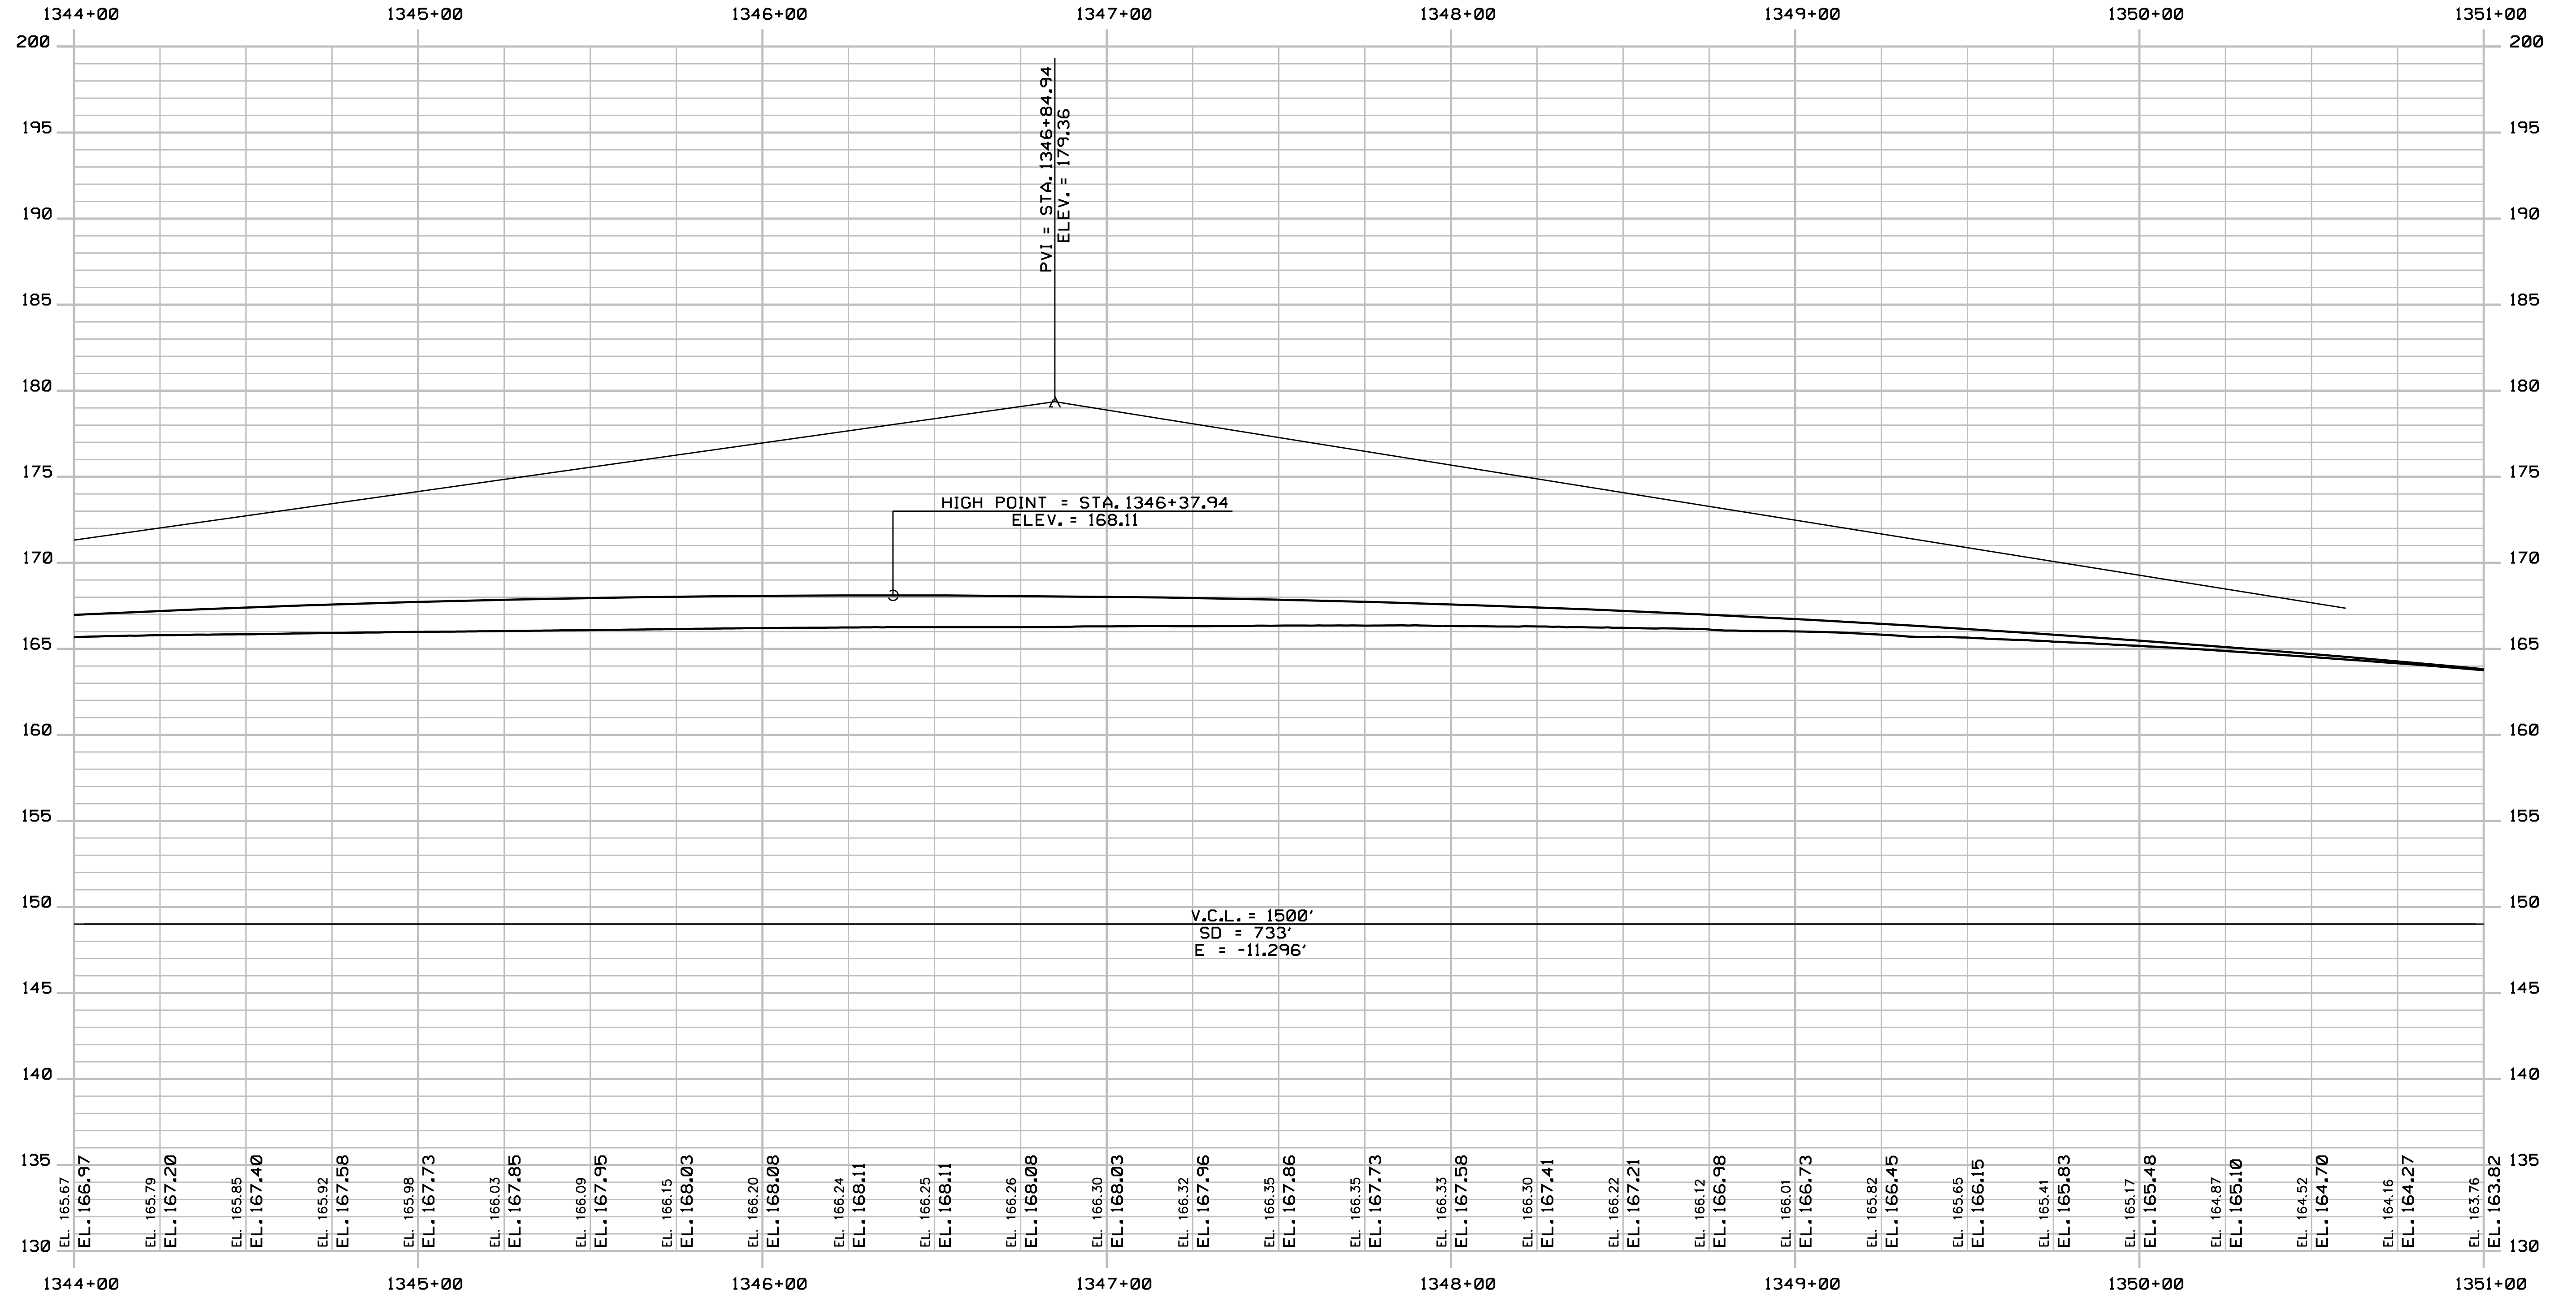

PROFILE

Filename: ...173_Profile_195NB_07.dgn

Scale:
 Horiz 25
 Vert 5
 Scale of Feet

No.	Revision	By	Date

Designed by:

JACOBS

CONSULTANT PROJECT MANAGER: T. MORIN

	By	Date		By	Date
Designed	CSM	7-18	Checked	RRP	7-18
Drawn	SMG	7-18	In Charge of	TWM	7-18

JACOBS ENGINEERING GROUP
 120 ST. JAMES AVENUE
 BOSTON, MA 02116
 TEL (617) 242-9222
 FAX (617) 242-9824

THE GOLD STAR
 MEMORIAL HIGHWAY

MTA PROJECT MANAGER: R. NORWOOD


YORK TOLL PLAZA
 I-95 NORTHBOUND PROFILE 7

SHEET NUMBER: PR-07
 173 OF 489

CONTRACT: 2018.20

Date: 8/28/2018

Filename: ...\\174_Profile_195NB_08.dgn

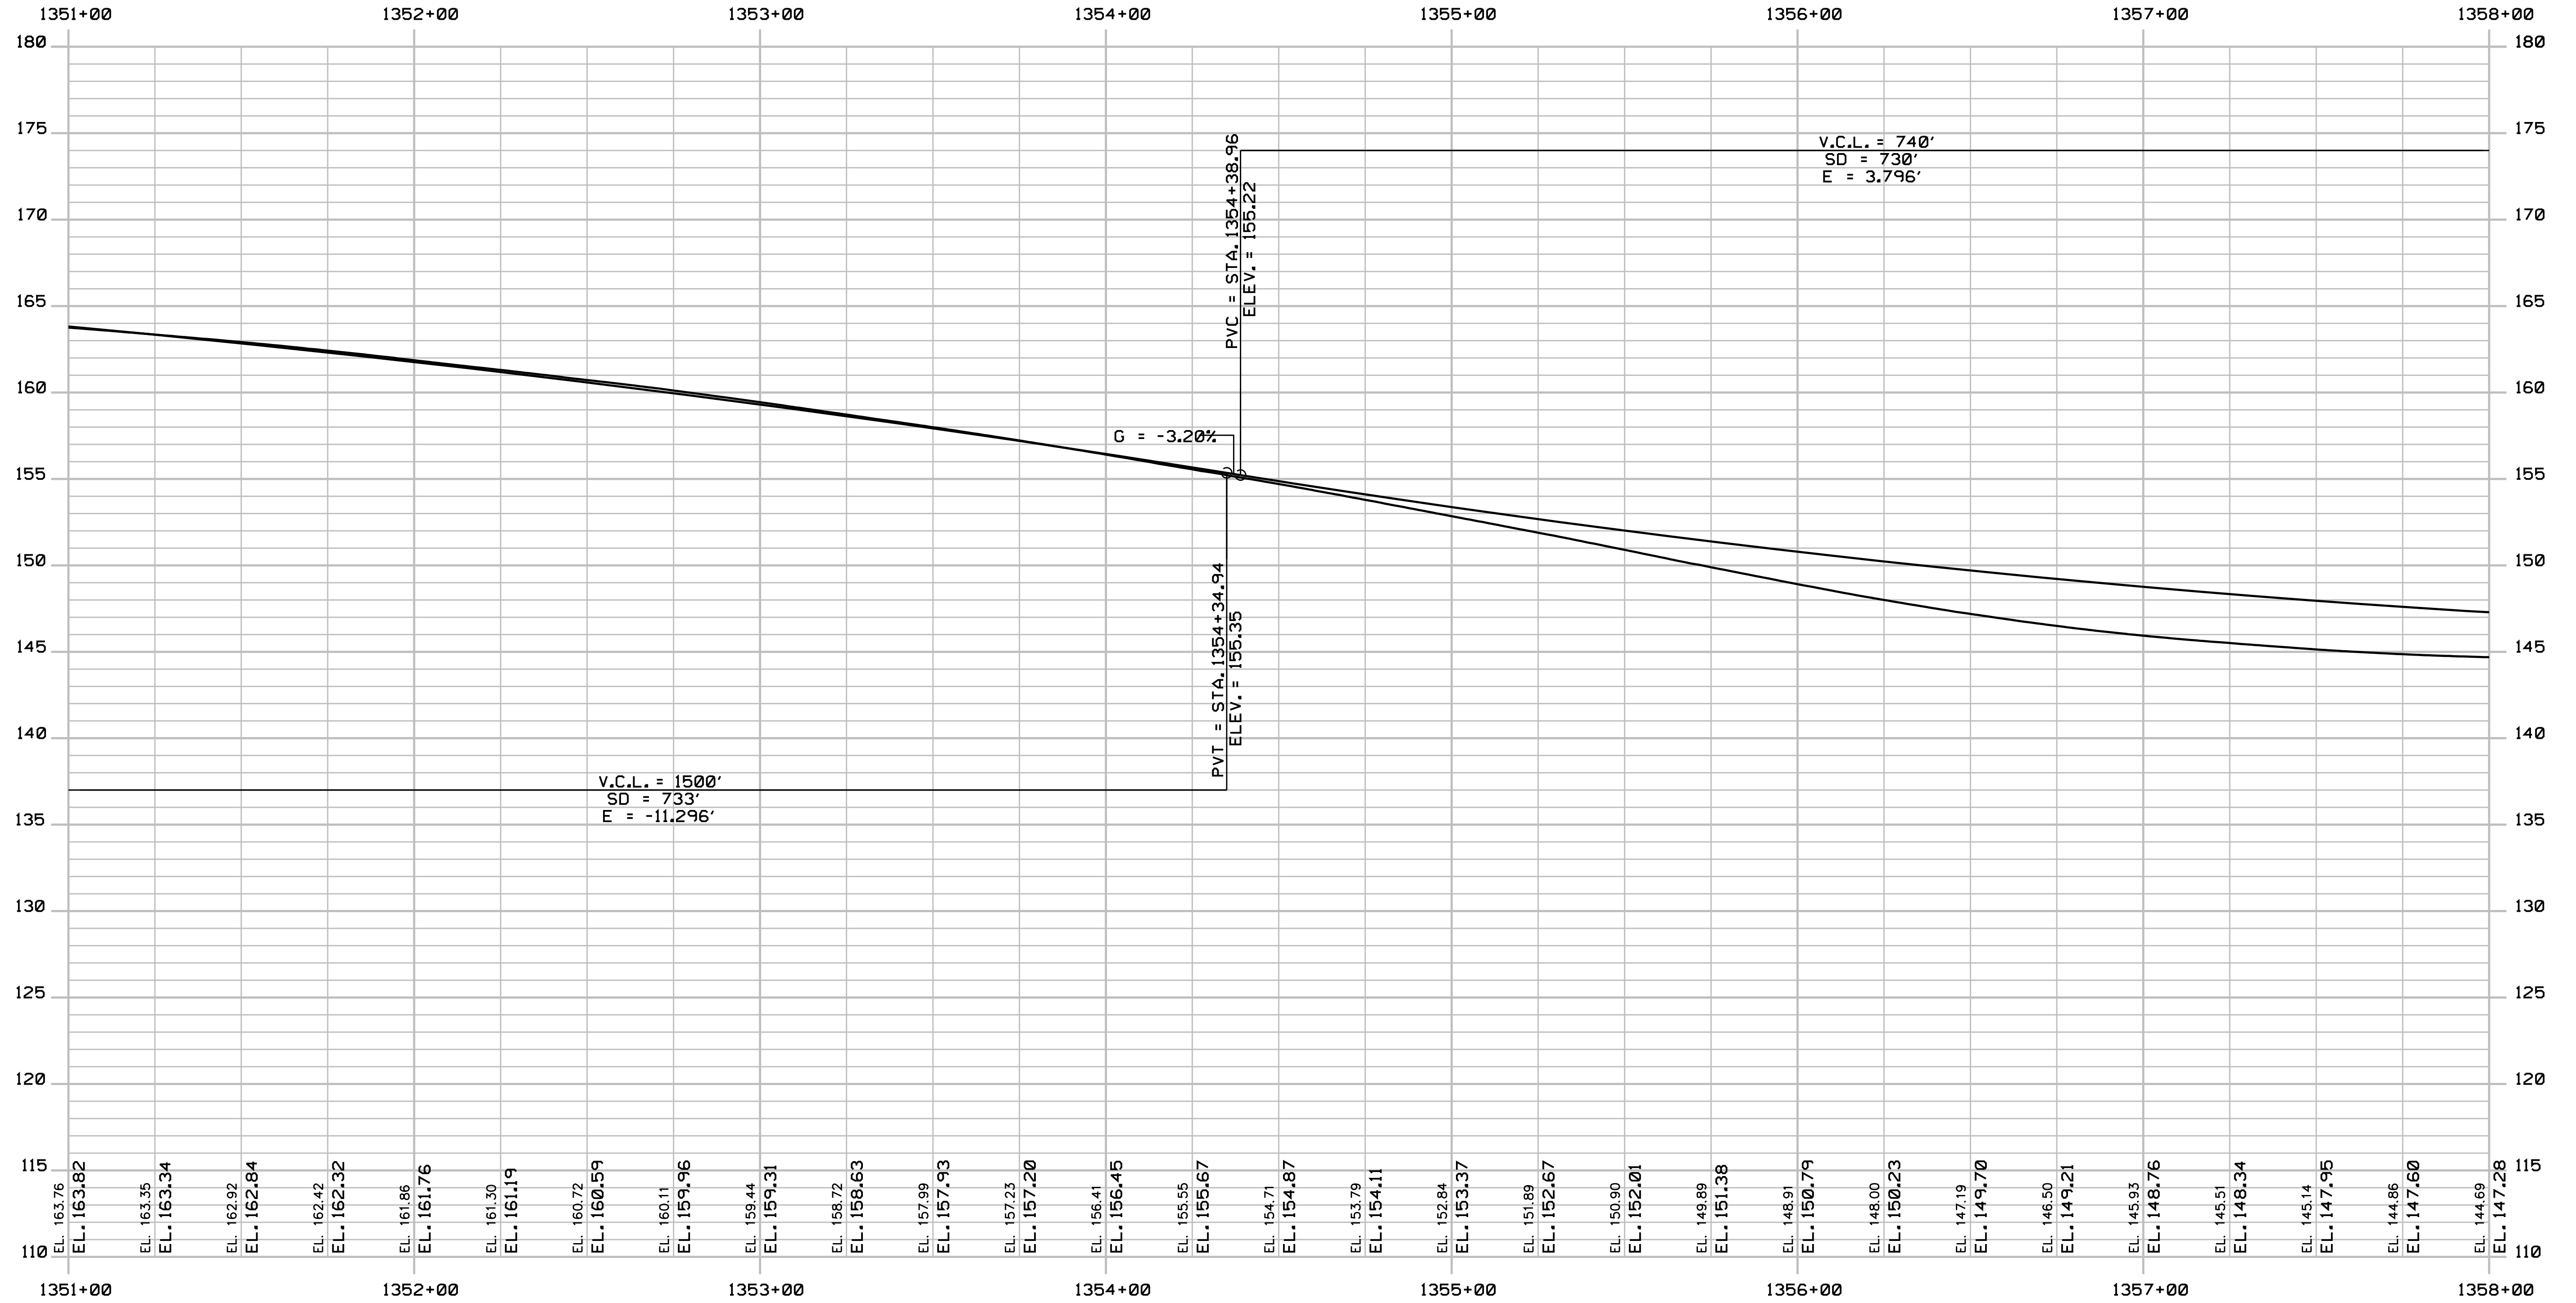

PROFILE

Scale:
 Horiz 25
 Vert 5

Scale of Feet

No.	Revision	By	Date

Designed by:

JACOBS

CONSULTANT PROJECT MANAGER: T. MORIN

	By	Date		By	Date
Designed	CSM	7-18	Checked	RRP	7-18
Drawn	SMG	7-18	In Charge of	TWM	7-18

JACOBS ENGINEERING GROUP
 120 ST. JAMES AVENUE
 BOSTON, MA 02116
 TEL (617) 242-9222
 FAX (617) 242-9824

THE GOLD STAR
 MEMORIAL HIGHWAY

MTA PROJECT MANAGER: R. NORWOOD

YORK TOLL PLAZA

I-95 NORTHBOUND PROFILE 8


SHEET NUMBER: PR-08

CONTRACT: 2018.20

174 OF 489

Date: 8/28/2018

Filename: ... \175_Profile_195NB_09.dgn

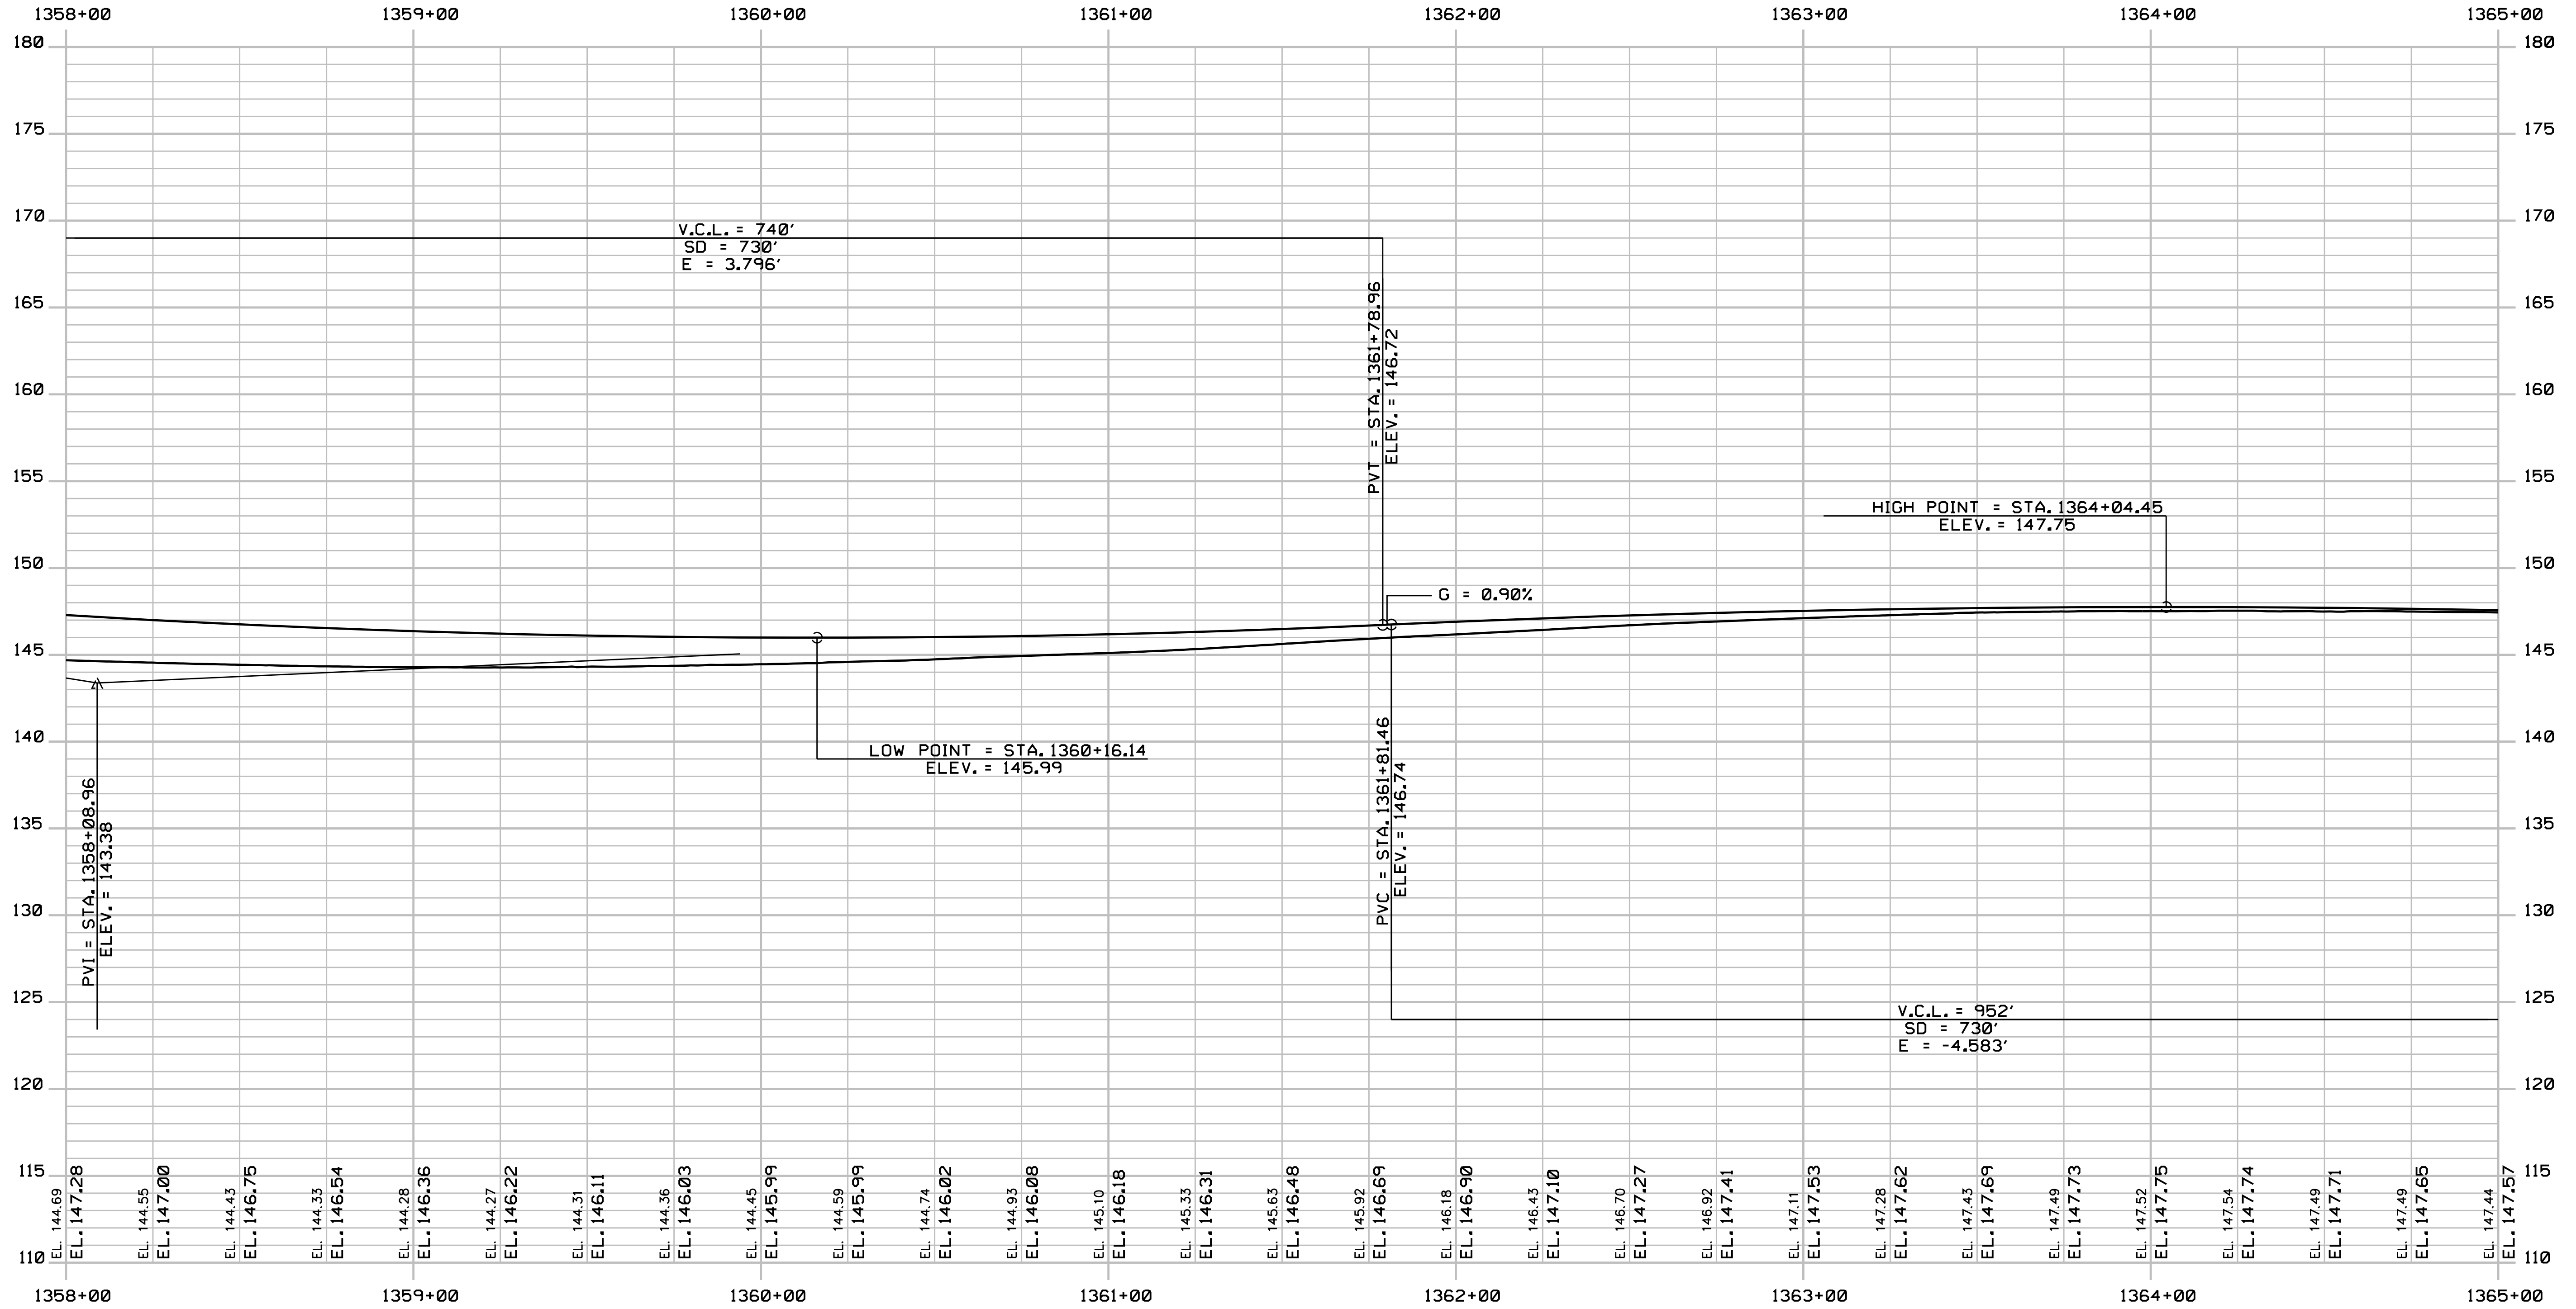

PROFILE

Scale:
Horizontal: 1" = 25'
Vertical: 1" = 5'

No.	Revision	By	Date

Designed by:

JACOBS

CONSULTANT PROJECT MANAGER: T. MORIN

	By	Date		By	Date
Designed	CSM	7-18	Checked	RRP	7-18
Drawn	SMG	7-18	In Charge of	TWM	7-18

JACOBS ENGINEERING GROUP
120 ST. JAMES AVENUE
BOSTON, MA 02116
TEL (617) 242-9222
FAX (617) 242-9824

MAINE TURNPIKE

THE GOLD STAR
MEMORIAL HIGHWAY

MTA PROJECT MANAGER: R. NORWOOD

YORK TOLL PLAZA


I-95 NORTHBOUND PROFILE 9

SHEET NUMBER: PR-09

CONTRACT: 2018.20

175 OF 489

Date: 8/28/2018

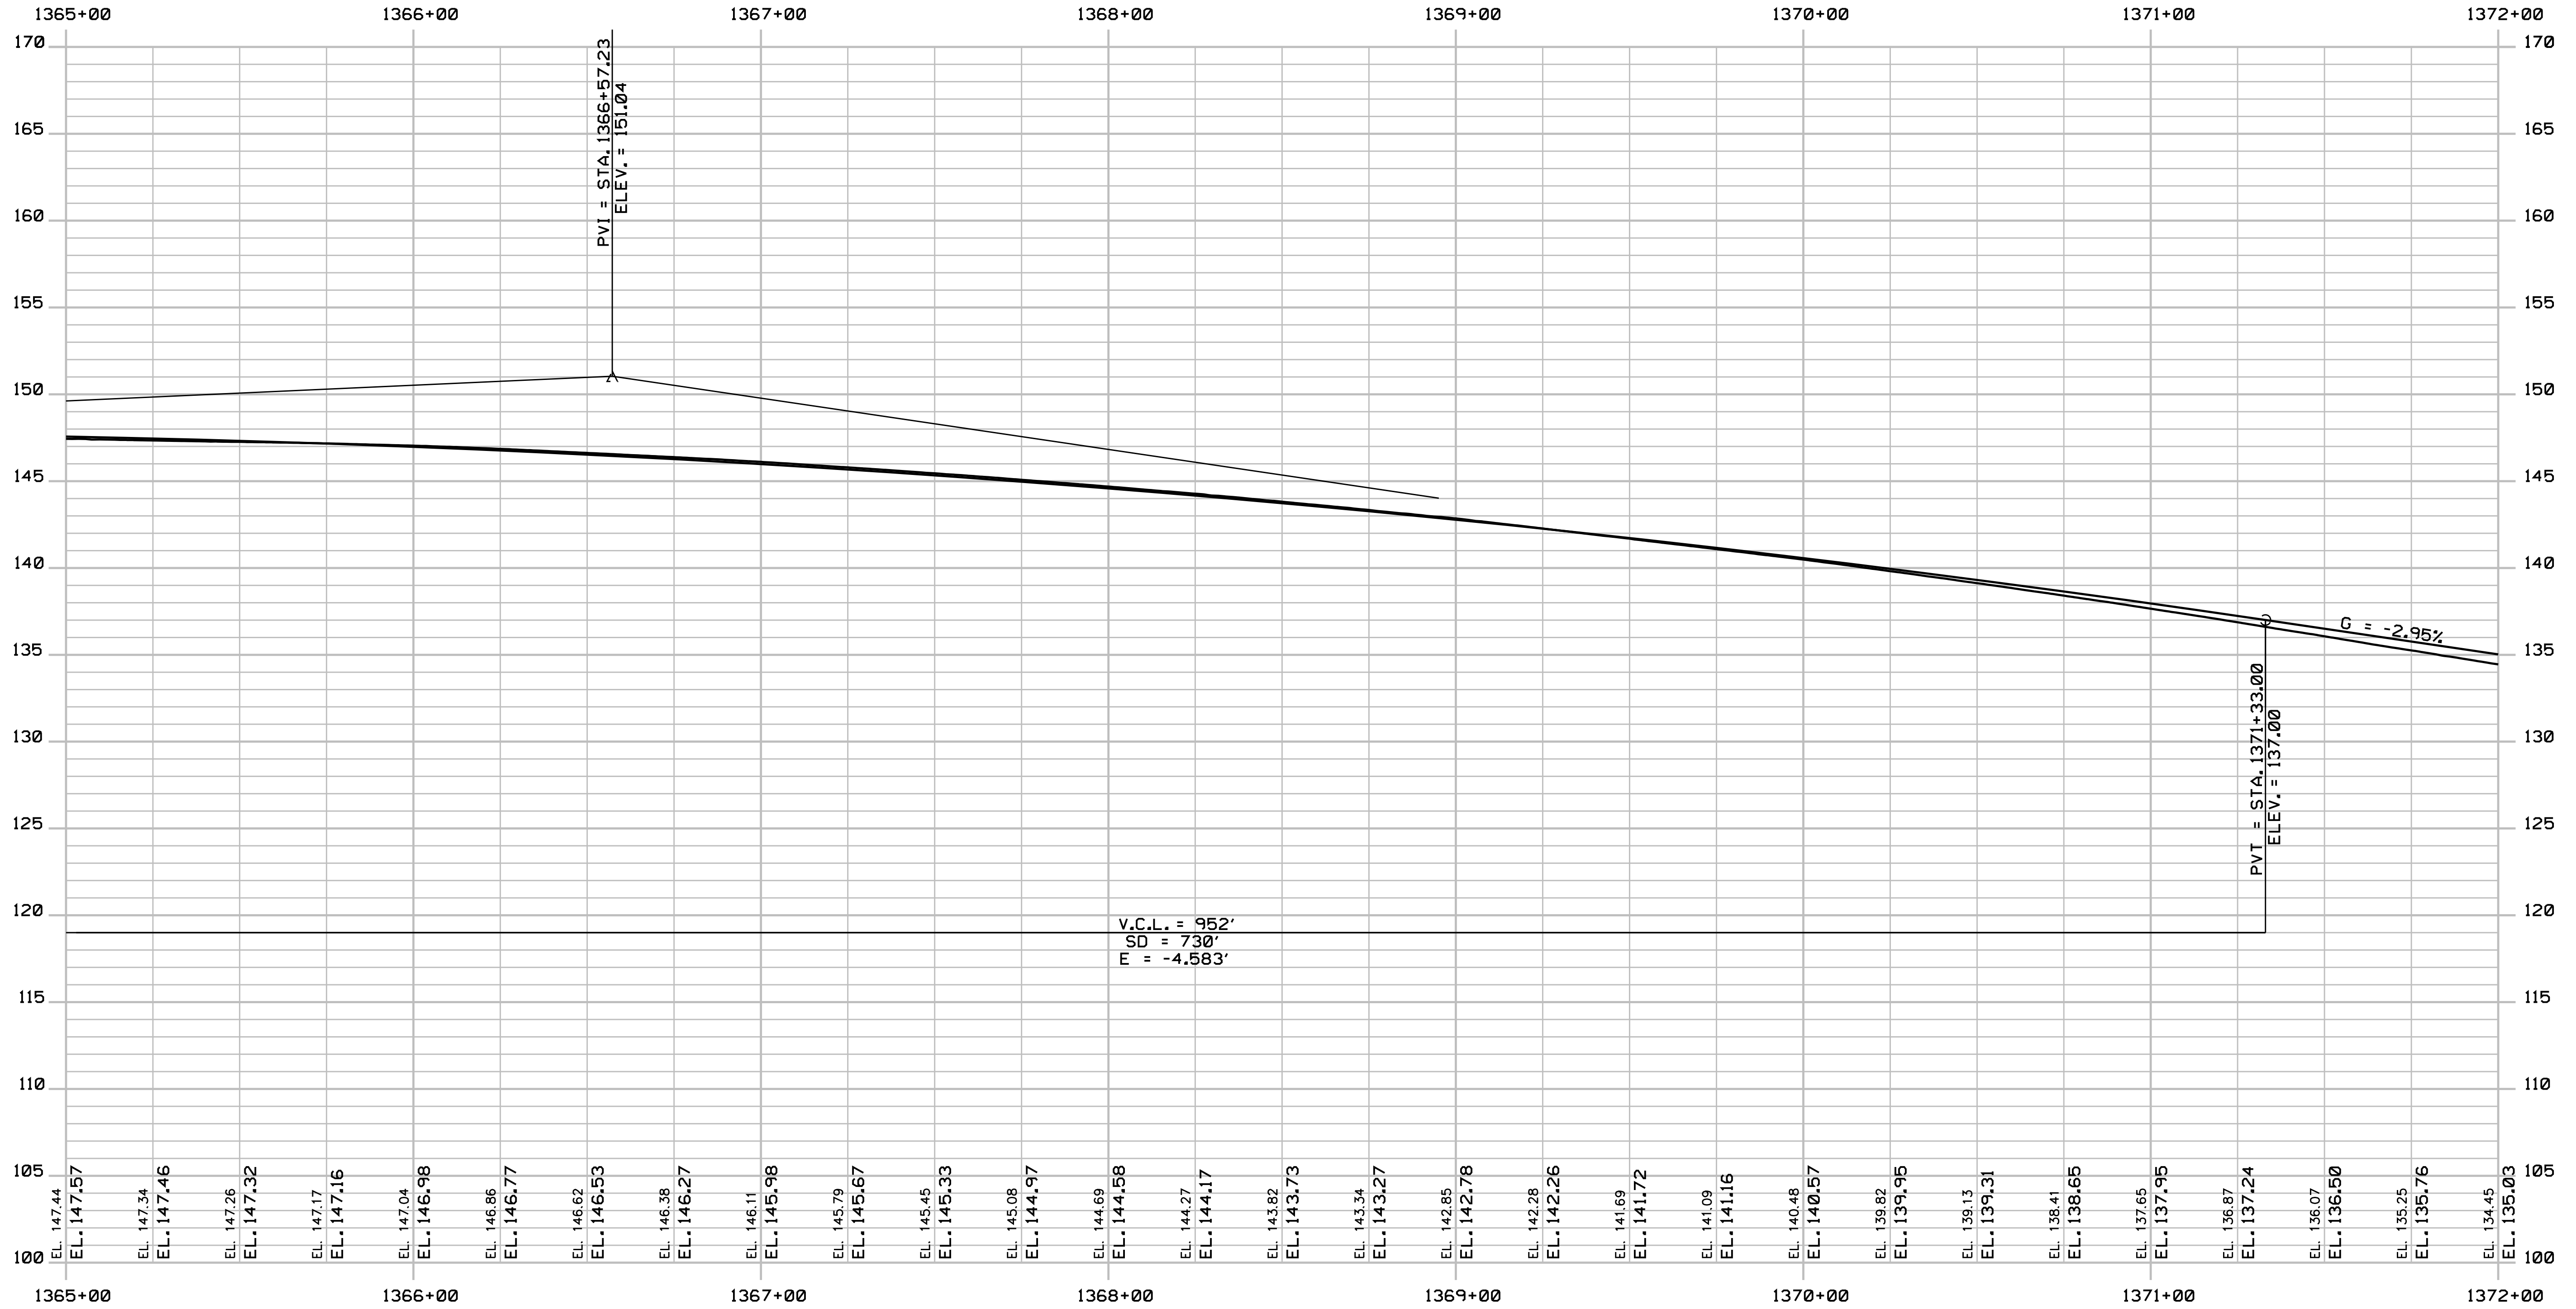

PROFILE

Filename: ... \176_Profile_195NB_10.dgn

Scale:
Horizontal: 1" = 25'
Vertical: 1" = 5'

No.	Revision	By	Date

Designed by:

JACOBS

CONSULTANT PROJECT MANAGER: T. MORIN

	By	Date		By	Date
Designed	CSM	7-18	Checked	RRP	7-18
Drawn	SMG	7-18	In Charge of	TWM	7-18

JACOBS ENGINEERING GROUP
120 ST. JAMES AVENUE
BOSTON, MA 02116
TEL (617) 242-9222
FAX (617) 242-9824

MAINE TURNPIKE

THE GOLD STAR
MEMORIAL HIGHWAY

MTA PROJECT MANAGER: R. NORWOOD

YORK TOLL PLAZA


I-95 NORTHBOUND PROFILE 10

SHEET NUMBER: PR-10

CONTRACT: 2018.20

176 OF 489

Date: 8/28/2018

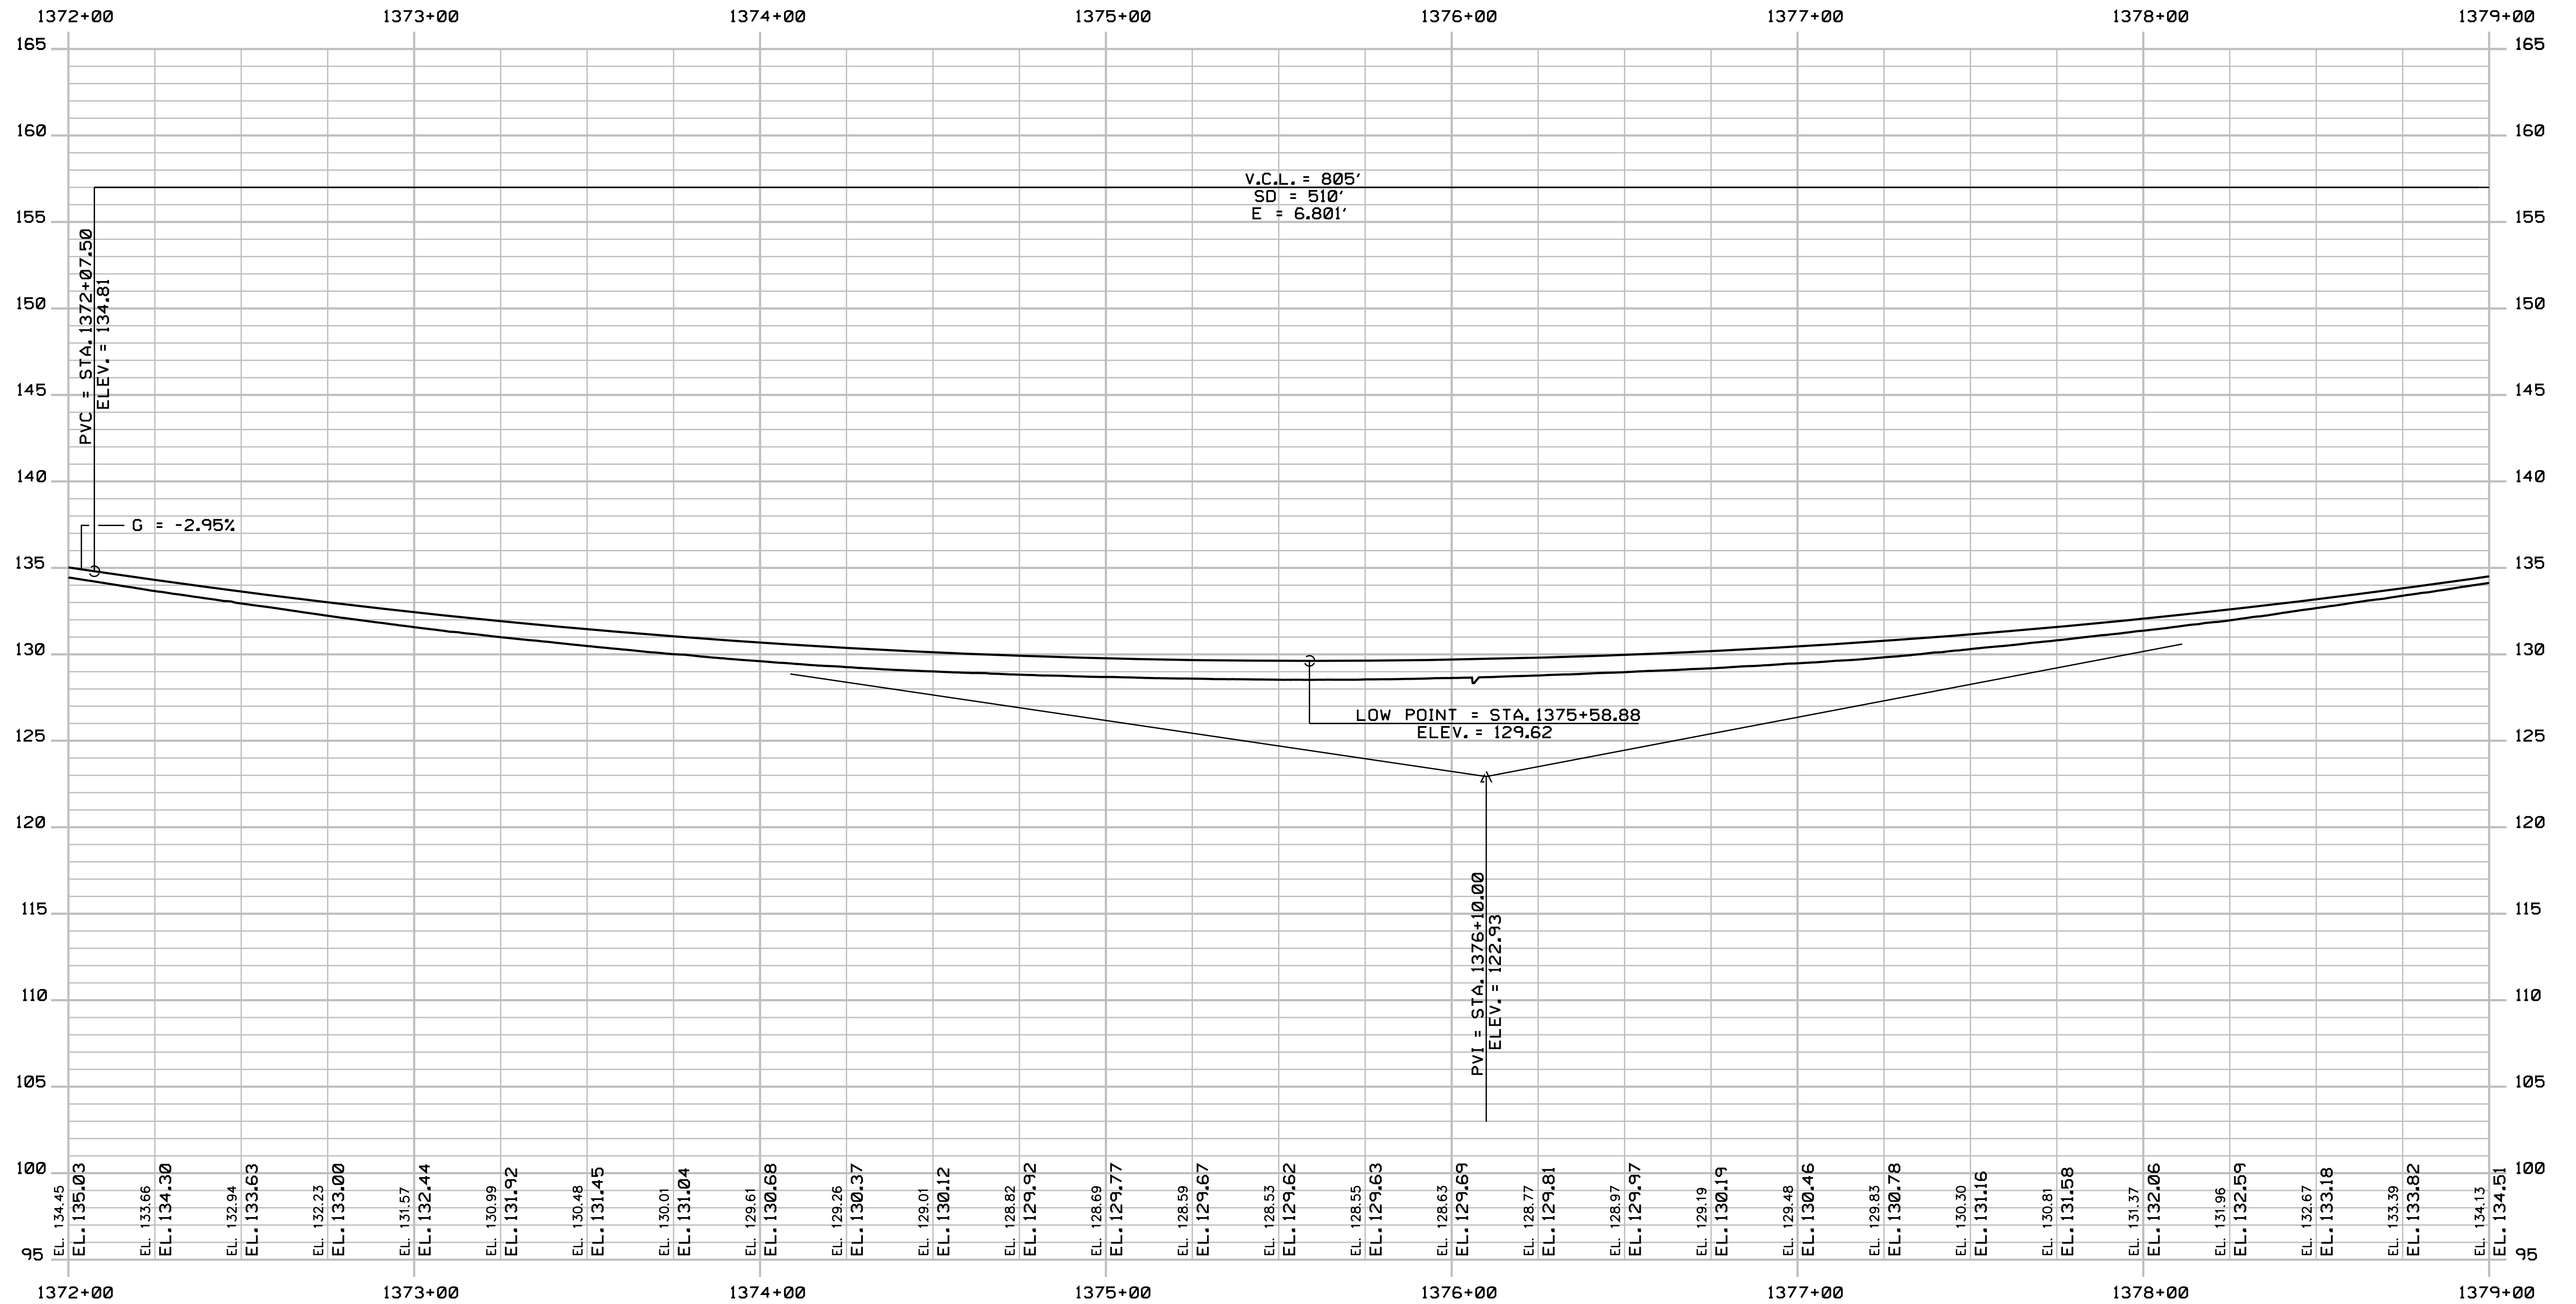

PROFILE

Filename: ...\\177_Profile_195NB_11.dgn

Scale:
Horizontal: 1" = 25'
Vertical: 1" = 10'

No.	Revision	By	Date


Designed by:

JACOBS

CONSULTANT PROJECT MANAGER: T. MORIN

	By	Date		By	Date
Designed	CSM	7-18	Checked	RRP	7-18
Drawn	SMG	7-18	In Charge of	TWM	7-18

JACOBS ENGINEERING GROUP
120 ST. JAMES AVENUE
BOSTON, MA 02116
TEL (617) 242-9222
FAX (617) 242-9824



THE GOLD STAR
MEMORIAL HIGHWAY


MTA PROJECT MANAGER: R. NORWOOD

YORK TOLL PLAZA
I-95 NORTHBOUND PROFILE 11

SHEET NUMBER: PR-11
CONTRACT: 2018.20
177 OF 489

Date: 8/28/2018

Filename: ... \178_Profile_195NB_12.dgn

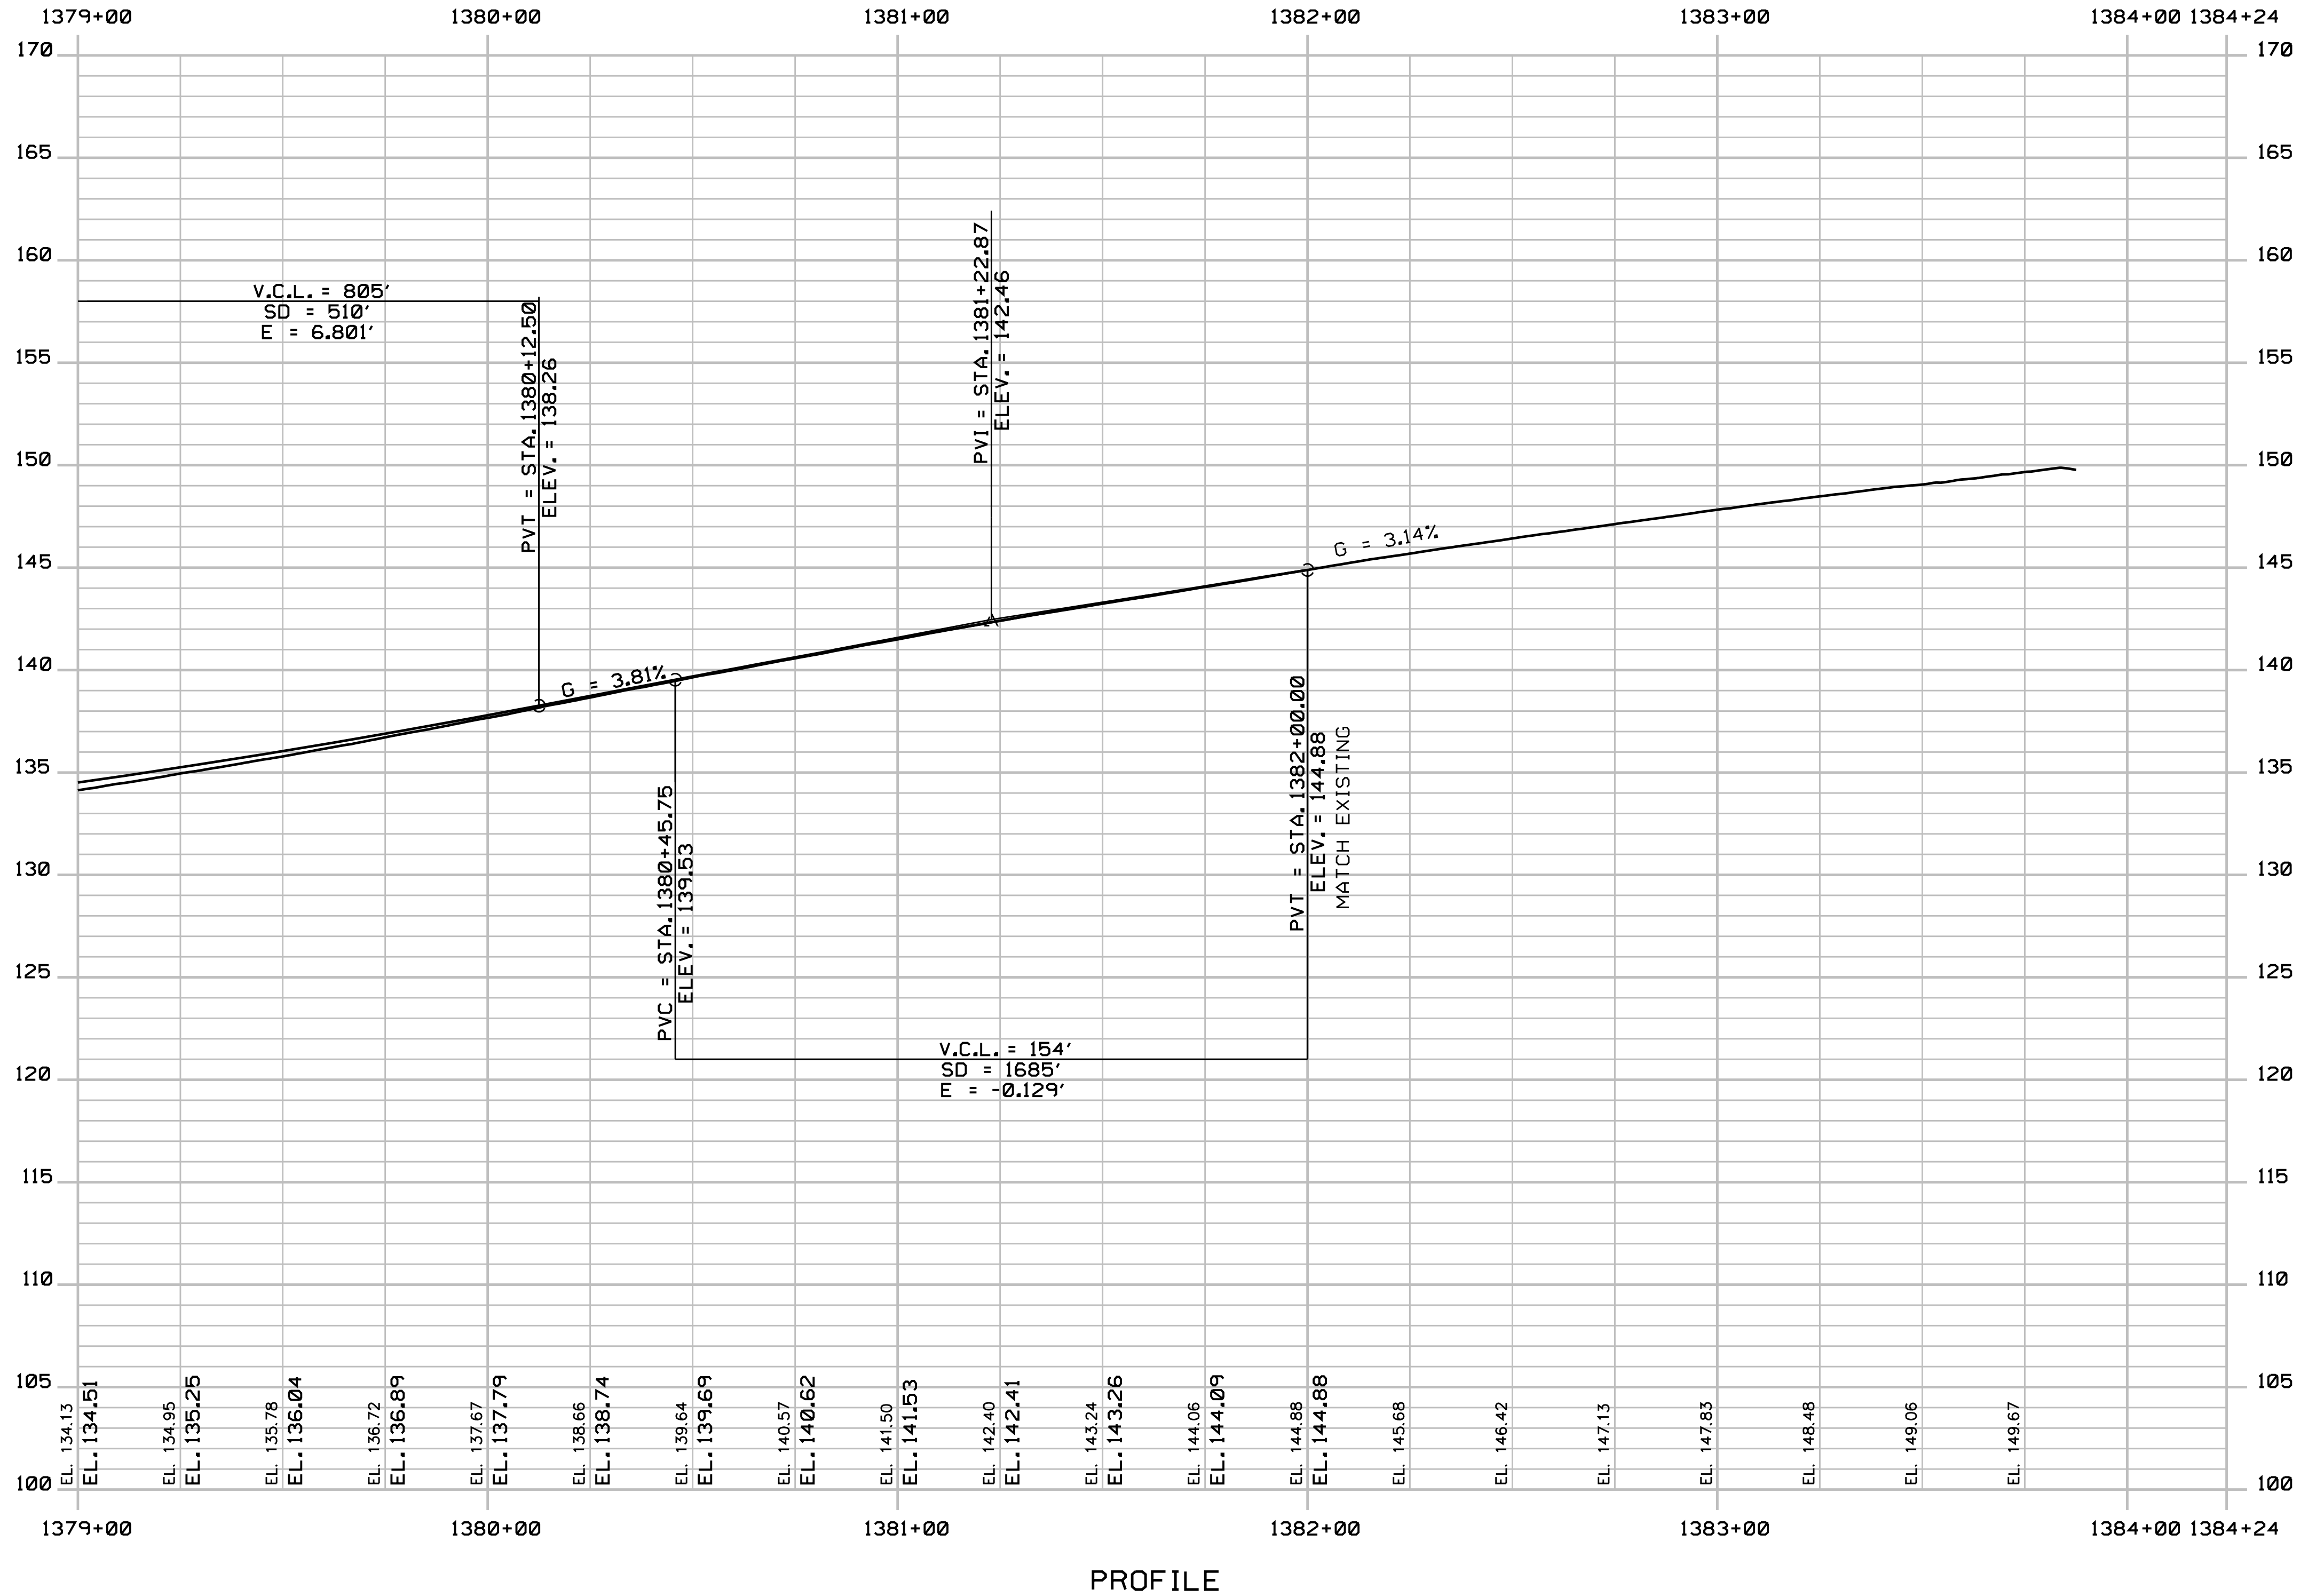

Scale: Horizontal 1" = 25', Vertical 1" = 5'

No.	Revision	By	Date

Designed by:

JACOBS

CONSULTANT PROJECT MANAGER: T. MORIN

	By	Date		By	Date
Designed	CSM	7-18	Checked	RRP	7-18
Drawn	SMG	7-18	In Charge of	TWM	7-18

JACOBS ENGINEERING GROUP
 120 ST. JAMES AVENUE
 BOSTON, MA 02116
 TEL (617) 242-9222
 FAX (617) 242-9824

THE GOLD STAR MEMORIAL HIGHWAY

MTA PROJECT MANAGER: R. NORWOOD

YORK TOLL PLAZA

I-95 NORTHBOUND PROFILE 12


SHEET NUMBER: PR-12

CONTRACT: 2018.20

178 OF 489

Date: 8/28/2018

Filename: ... \179_Profile_195SB_01.dgn

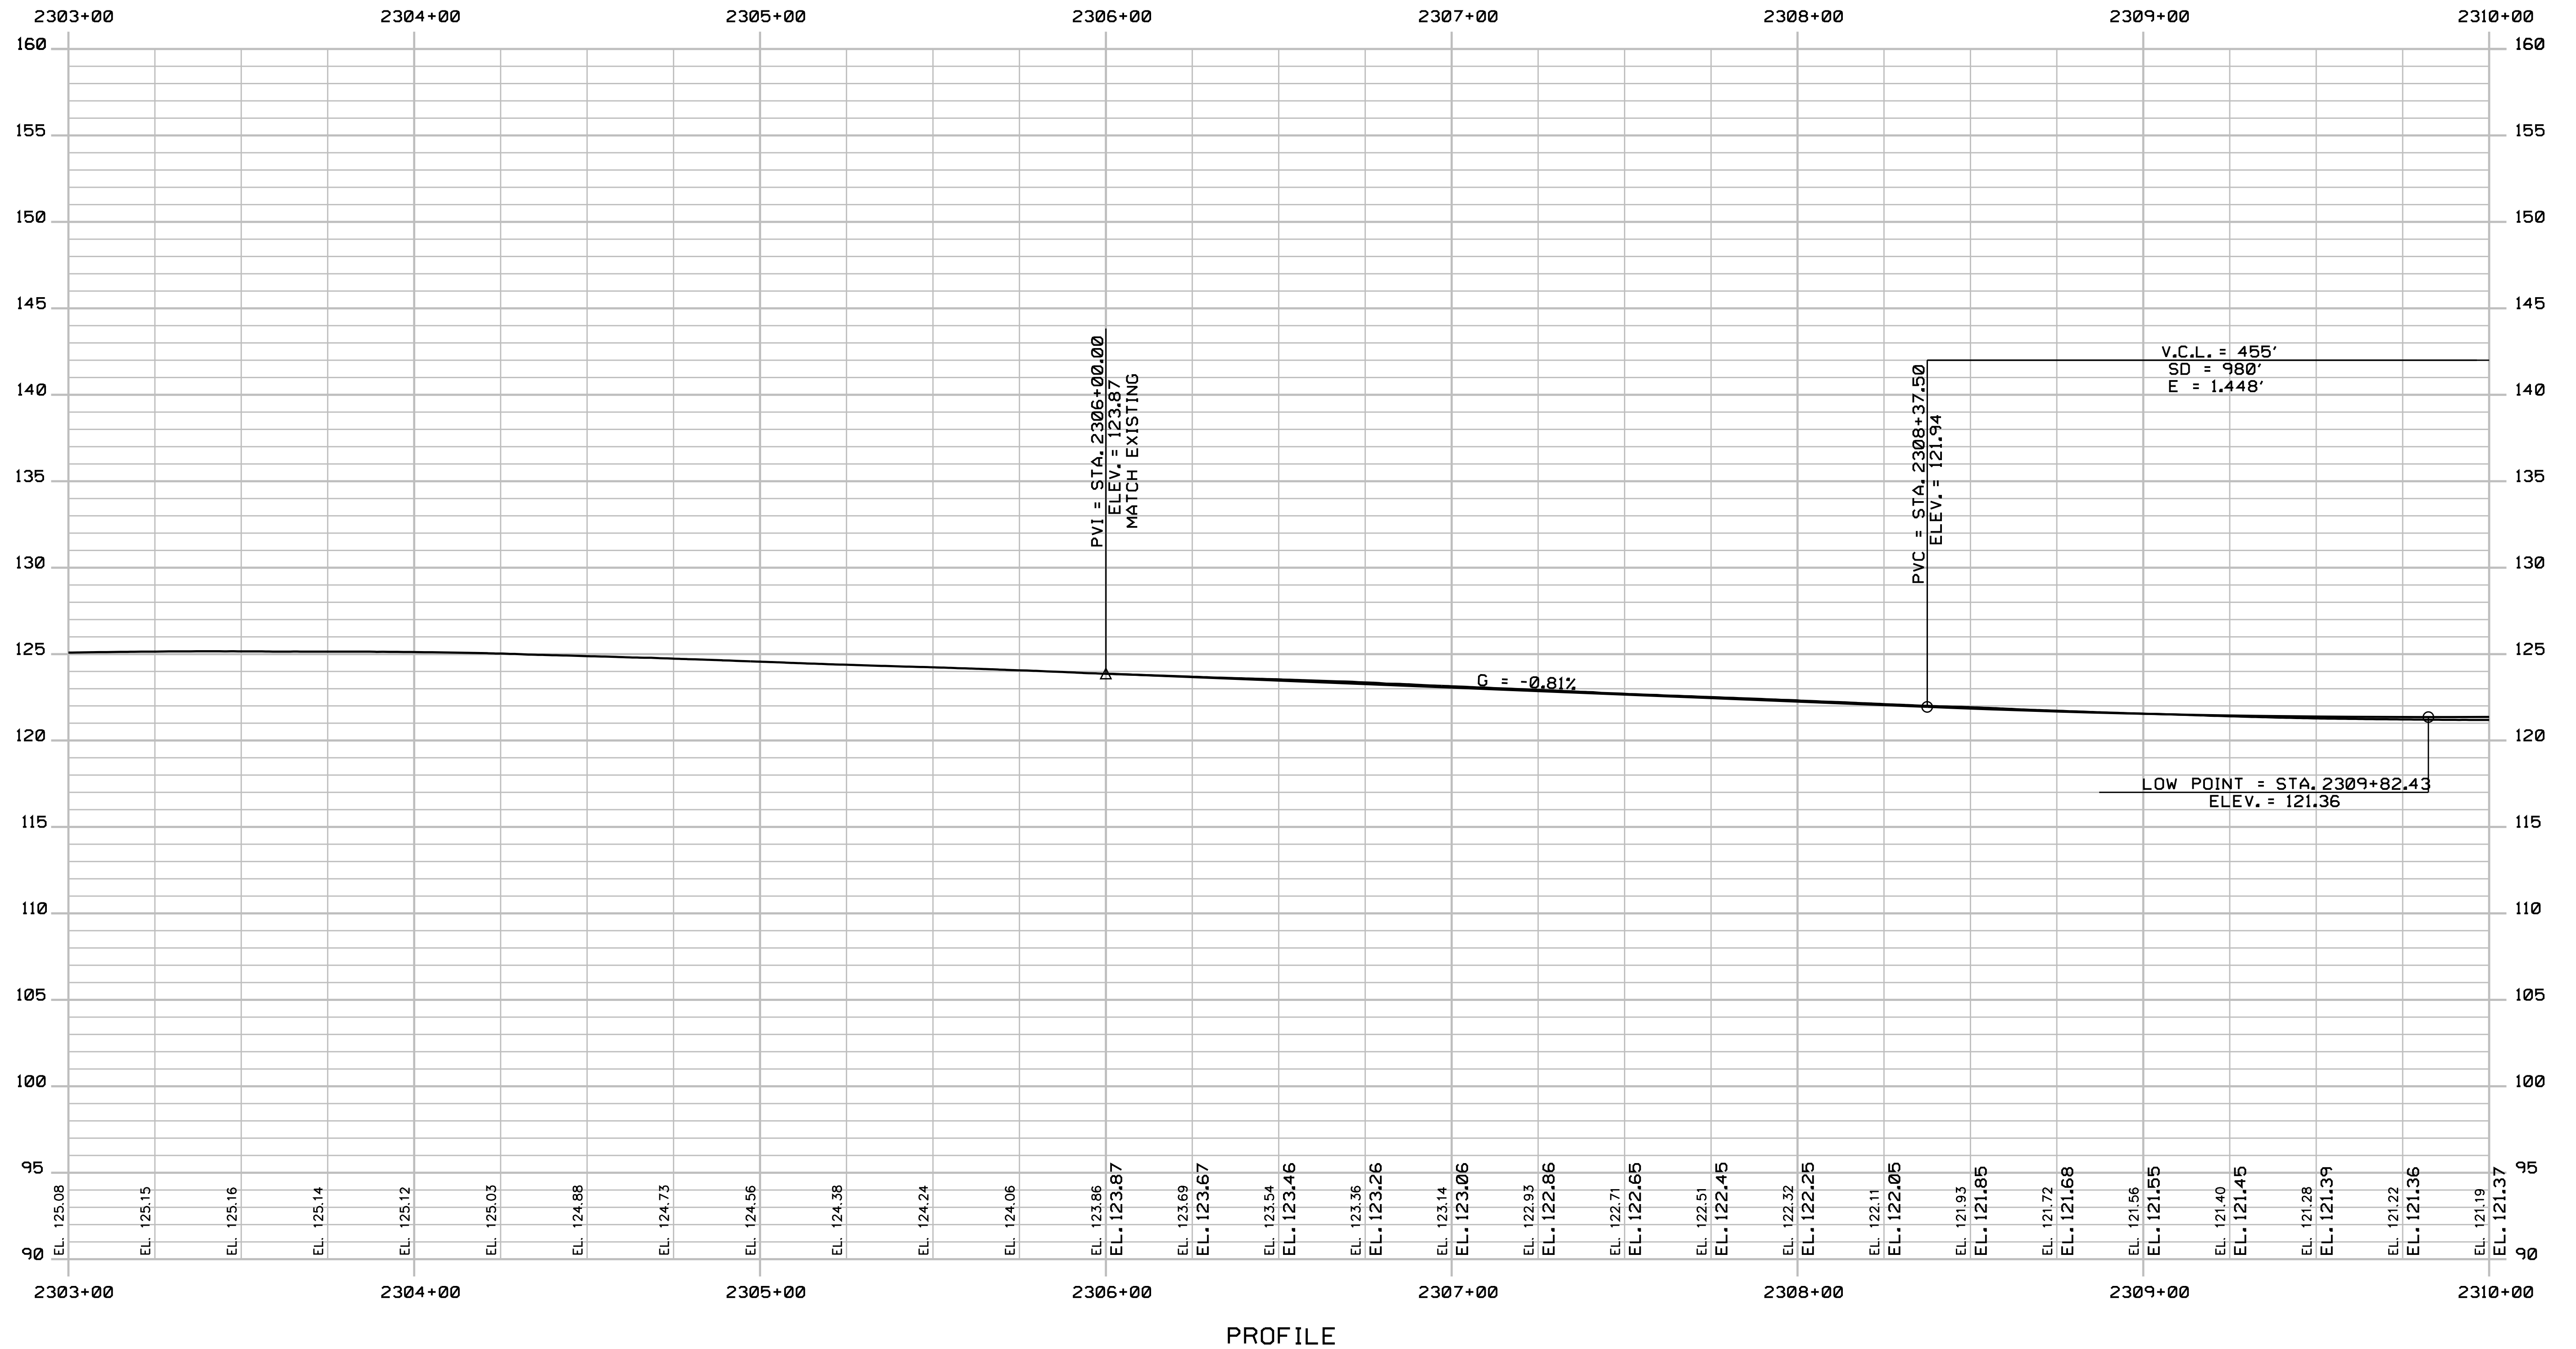

Scale:
 Horizontal: 1" = 25'
 Vertical: 1" = 5'

No.	Revision	By	Date


Designed by:

JACOBS

CONSULTANT PROJECT MANAGER: T. MORIN

	By	Date		By	Date
Designed	CSM	7-18	Checked	RRP	7-18
Drawn	SMG	7-18	In Charge of	TWM	7-18

JACOBS ENGINEERING GROUP
 120 ST. JAMES AVENUE
 BOSTON, MA 02116
 TEL (617) 242-9222
 FAX (617) 242-9824



THE GOLD STAR
 MEMORIAL HIGHWAY


MTA PROJECT MANAGER: R. NORWOOD

YORK TOLL PLAZA
 I-95 SOUTHBOUND PROFILE 1

SHEET NUMBER: PR-13
 CONTRACT: 2018.20
 179 OF 489

Date: 8/28/2018

Filename: ... \180_Profile_195SB_02.dgn

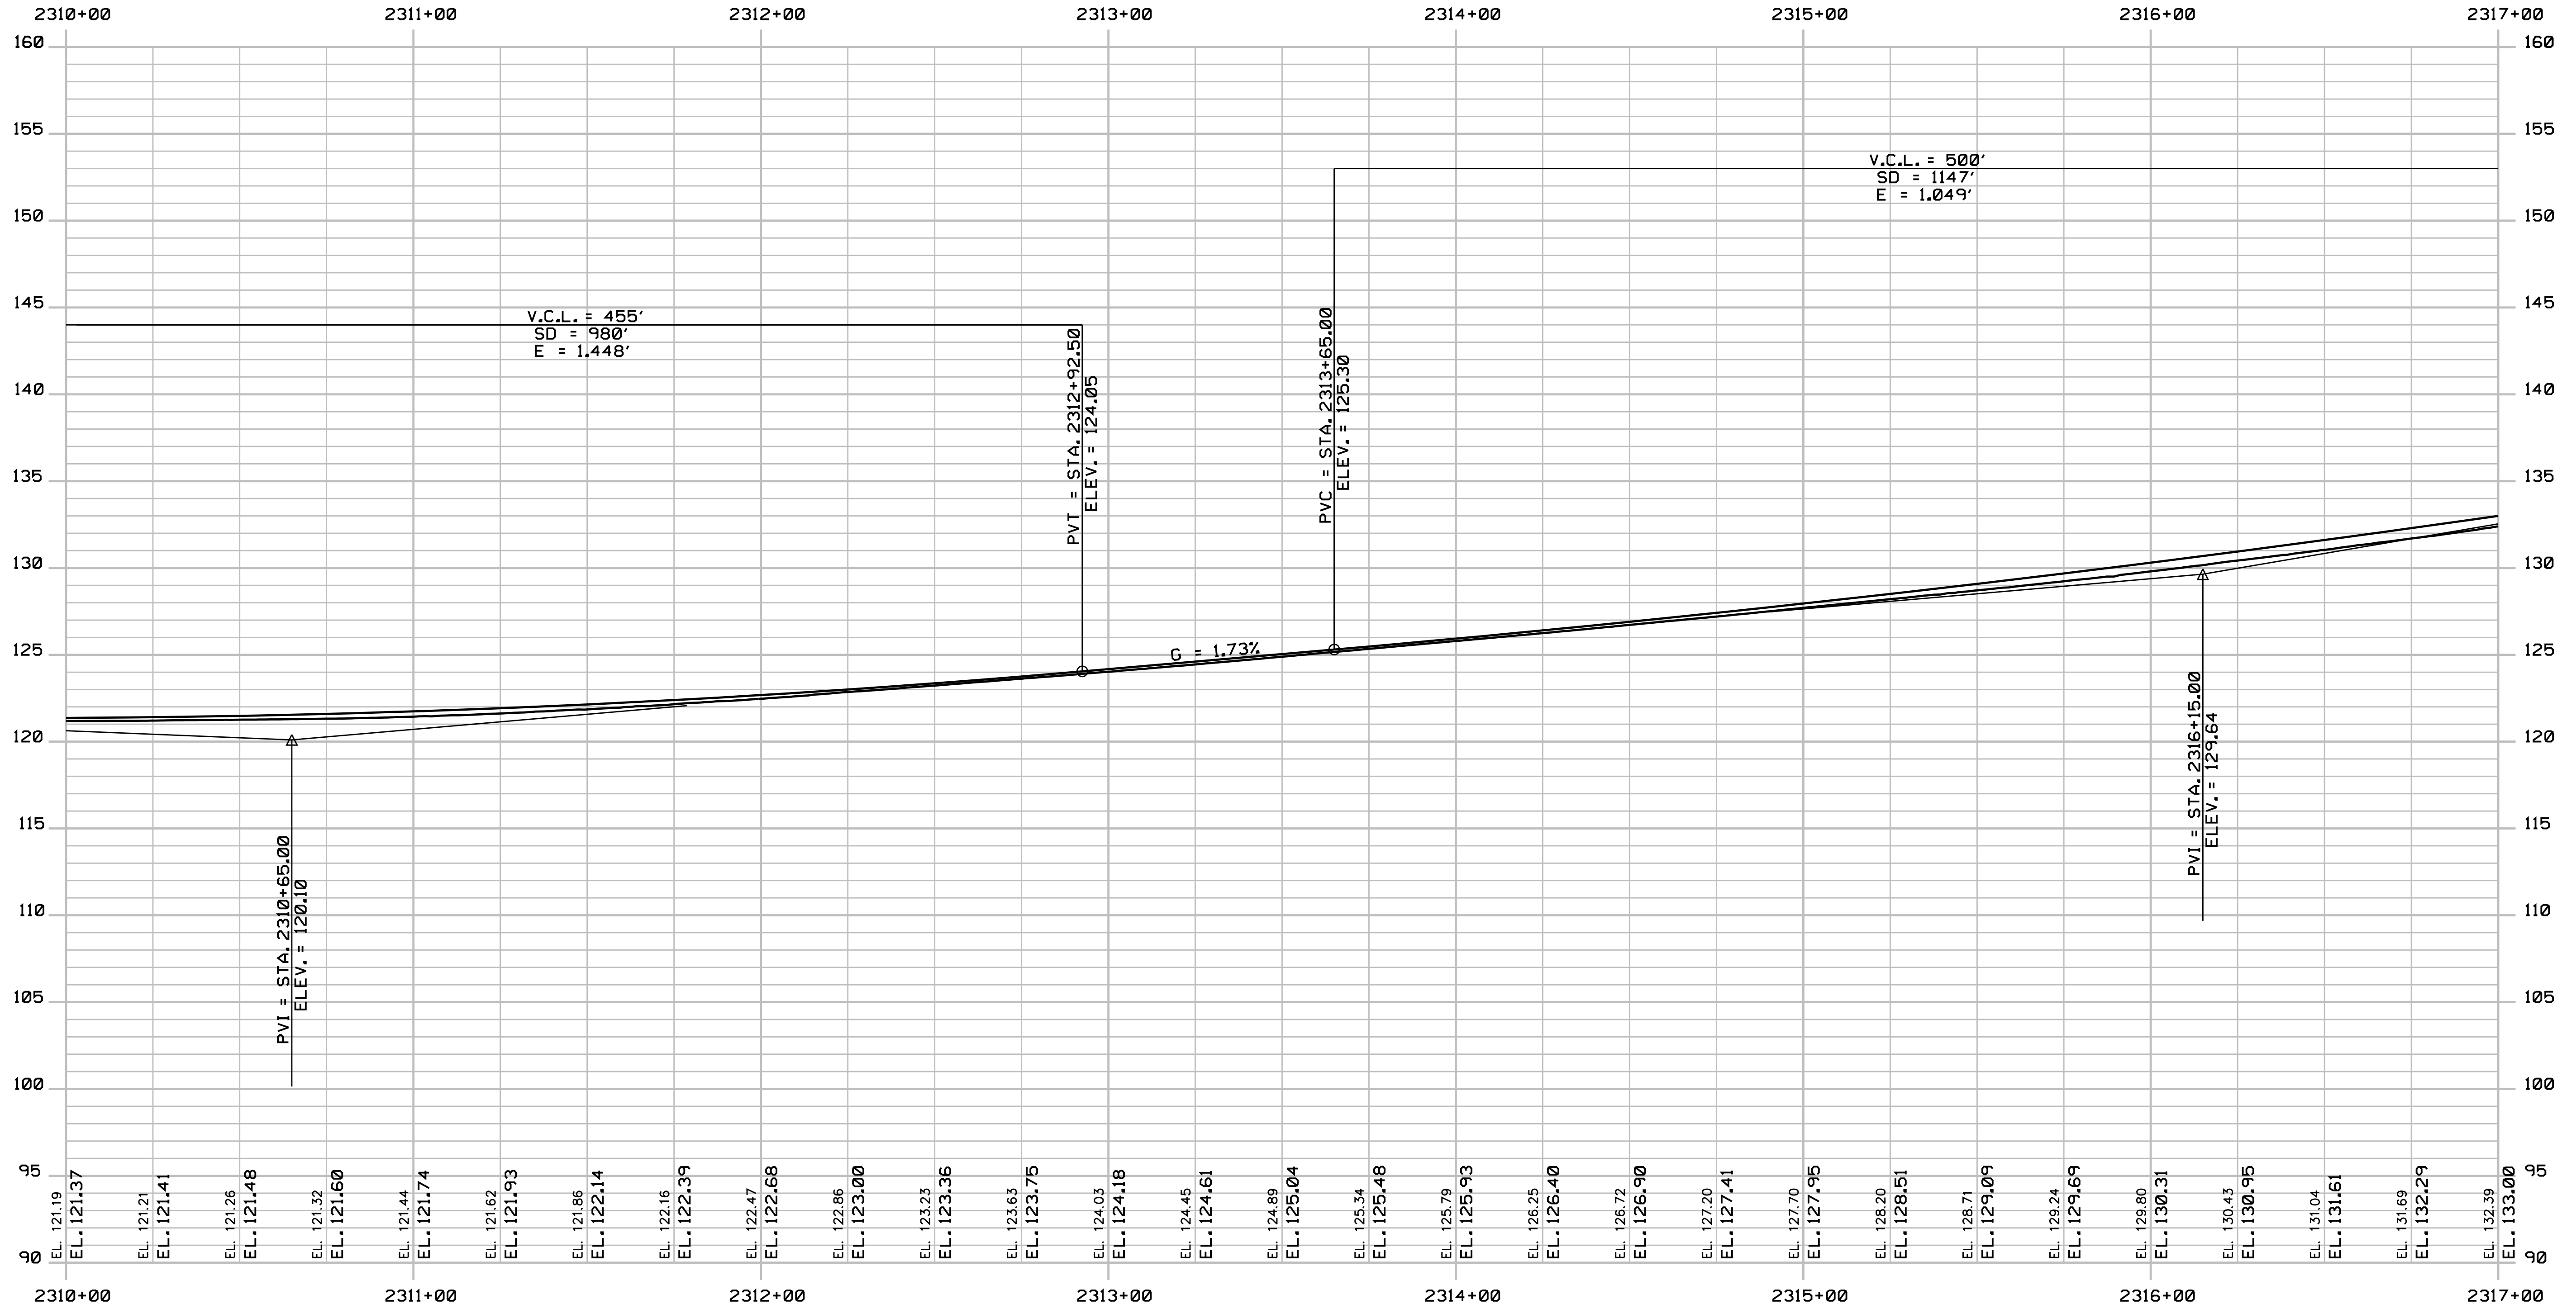

PROFILE

Scale:
 Horizontal: 1" = 25'
 Vertical: 1" = 5'

No.	Revision	By	Date


Designed by:

JACOBS

CONSULTANT PROJECT MANAGER: T. MORIN

	By	Date		By	Date
Designed	CSM	7-18	Checked	RRP	7-18
Drawn	SMG	7-18	In Charge of	TWM	7-18

JACOBS ENGINEERING GROUP
 120 ST. JAMES AVENUE
 BOSTON, MA 02116
 TEL (617) 242-9222
 FAX (617) 242-9824



THE GOLD STAR
 MEMORIAL HIGHWAY


MTA PROJECT MANAGER: R. NORWOOD

YORK TOLL PLAZA
 I-95 SOUTHBOUND PROFILE 2

SHEET NUMBER: PR-14
 180 OF 489

CONTRACT: 2018.20

Date: 8/28/2018

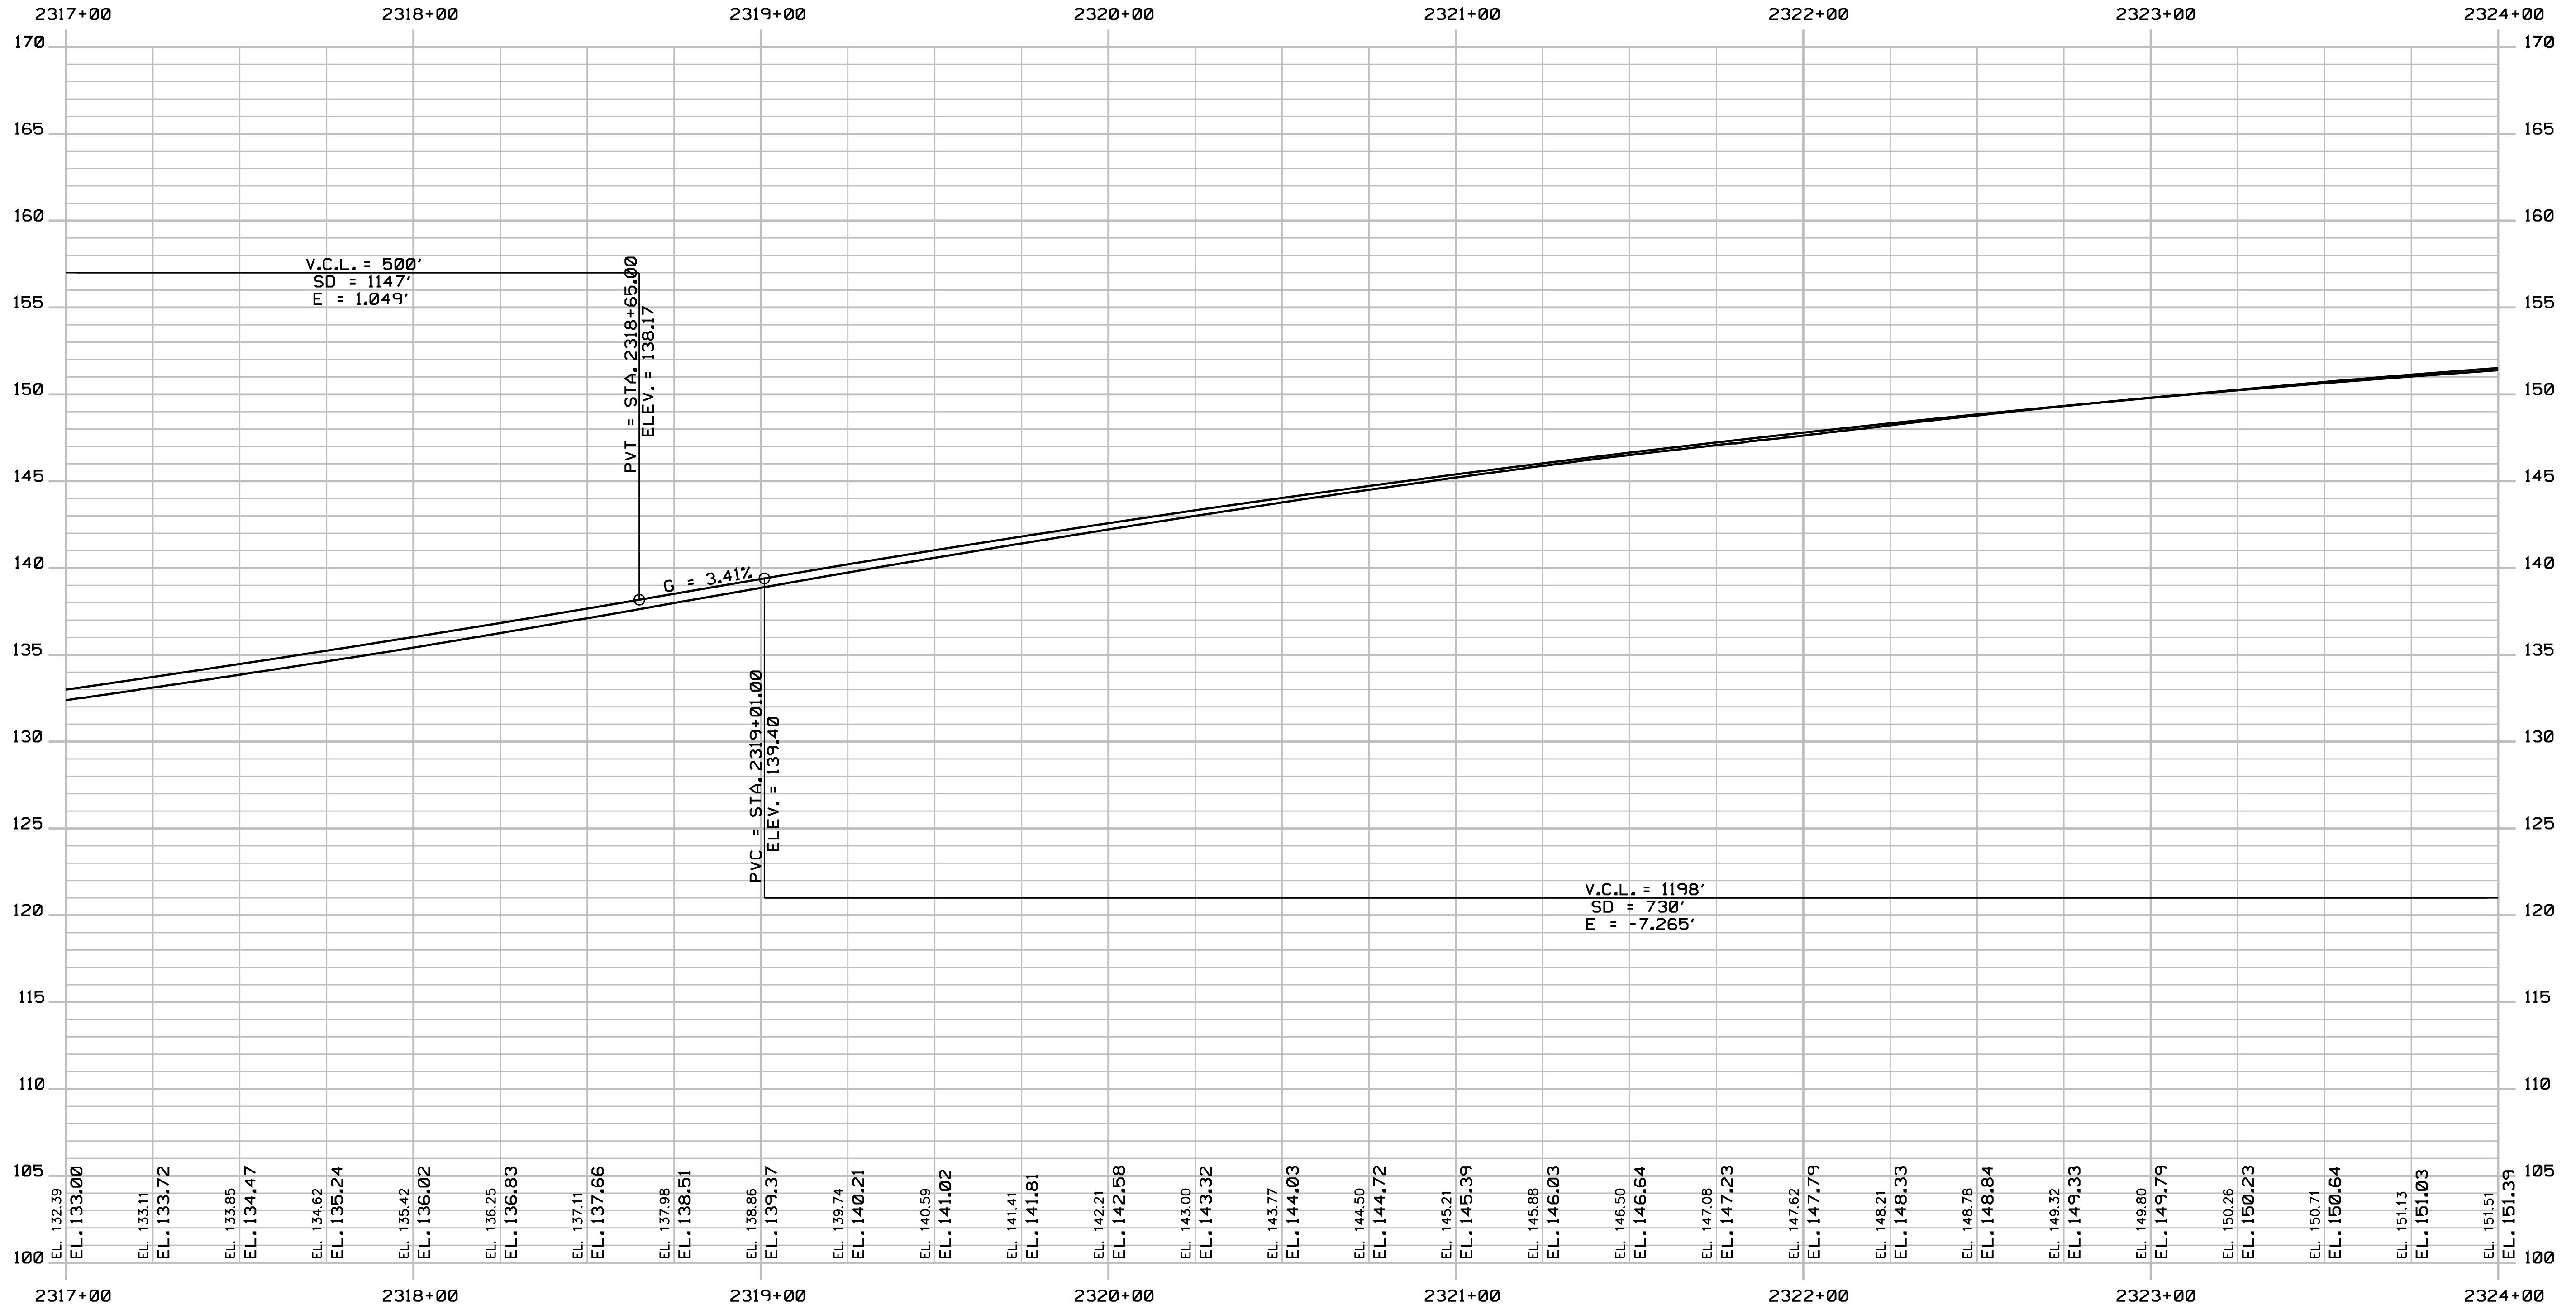

PROFILE

Filename: ... \181_Profile_1955B_03.dgn

Scale:
 Horizontal: 1" = 25'
 Vertical: 1" = 5'

No.	Revision	By	Date

Designed by:

JACOBS

CONSULTANT PROJECT MANAGER: T. MORIN

	By	Date		By	Date
Designed	CSM	7-18	Checked	RRP	7-18
Drawn	SMG	7-18	In Charge of	TWM	7-18

JACOBS ENGINEERING GROUP
 120 ST. JAMES AVENUE
 BOSTON, MA 02116
 TEL (617) 242-9222
 FAX (617) 242-9824

MAINE TURNPIKE

THE GOLD STAR
 MEMORIAL HIGHWAY

MTA PROJECT MANAGER: R. NORWOOD

YORK TOLL PLAZA

I-95 SOUTHBOUND PROFILE 3


SHEET NUMBER: PR-15

CONTRACT: 2018.20

181 OF 489

Date: 8/28/2018

Filename: ... \182_Profile_195SB_04.dgn

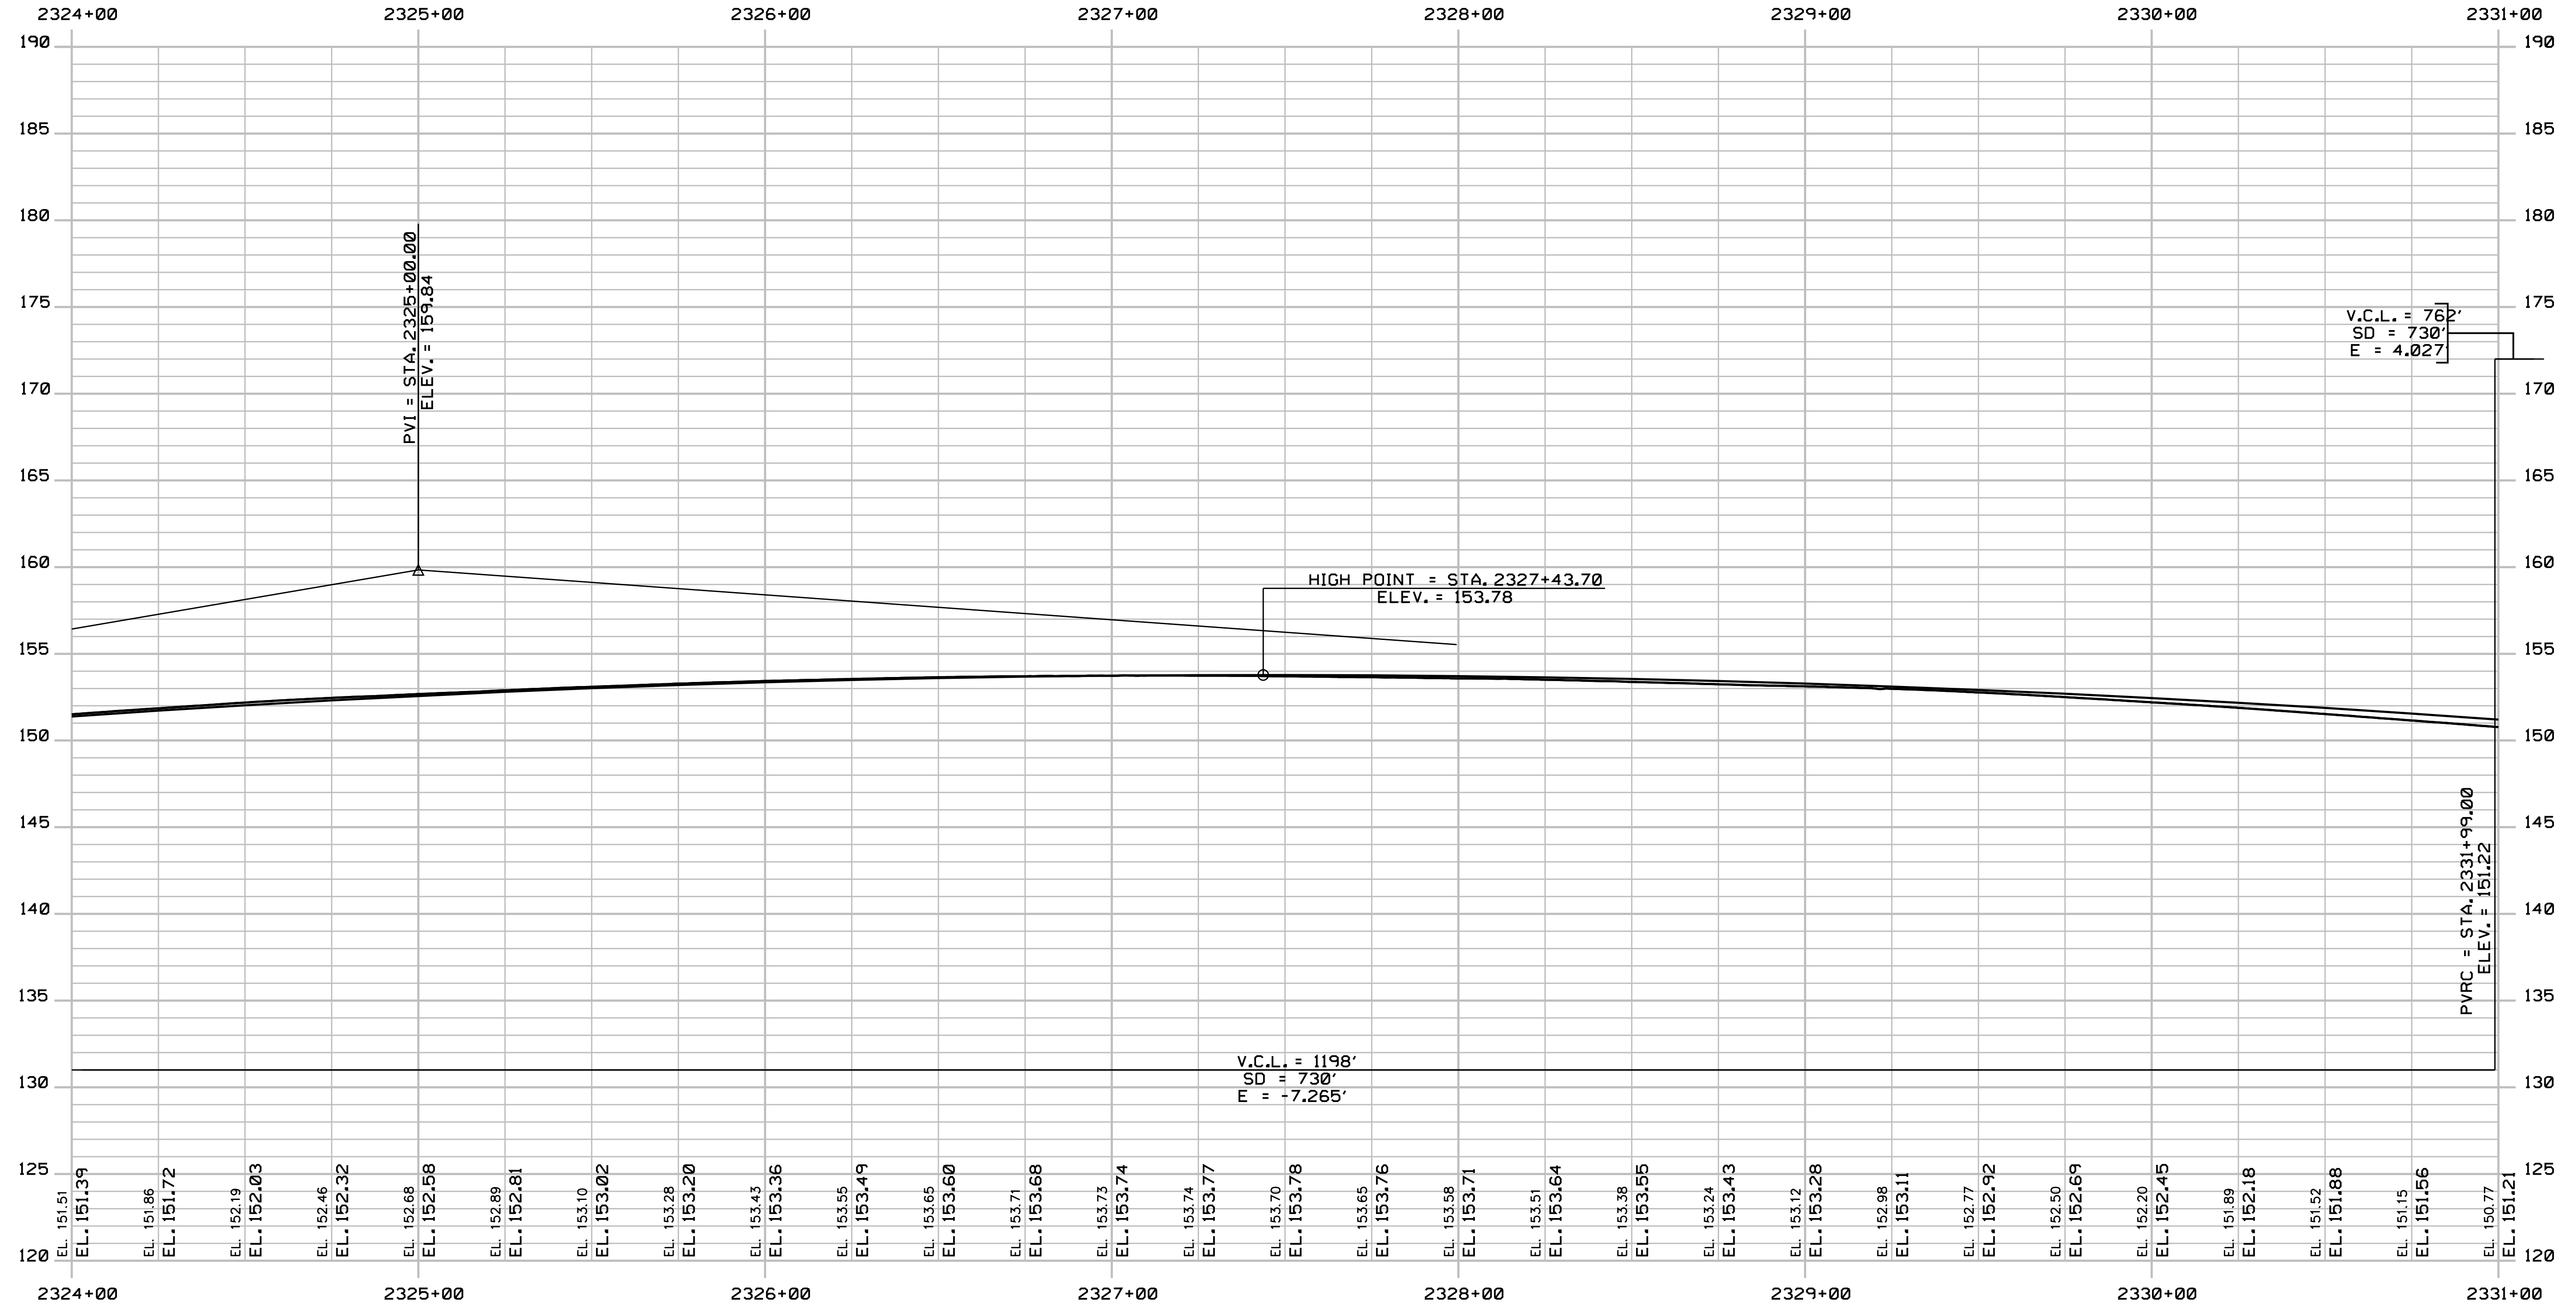

PROFILE

Scale:
 Horizontal: 1" = 25'
 Vertical: 1" = 5'

No.	Revision	By	Date


Designed by:

JACOBS

CONSULTANT PROJECT MANAGER: T. MORIN

	By	Date		By	Date
Designed	CSM	7-18	Checked	RRP	7-18
Drawn	SMG	7-18	In Charge of	TWM	7-18

JACOBS ENGINEERING GROUP
 120 ST. JAMES AVENUE
 BOSTON, MA 02116
 TEL (617) 242-9222
 FAX (617) 242-9824



THE GOLD STAR
 MEMORIAL HIGHWAY

MTA PROJECT MANAGER: R. NORWOOD


YORK TOLL PLAZA
 I-95 SOUTHBOUND PROFILE 4

SHEET NUMBER: PR-16
 182 OF 489

CONTRACT: 2018.20

Date: 8/28/2018

Filename: ... \183_Profile_195SB_05.dgn

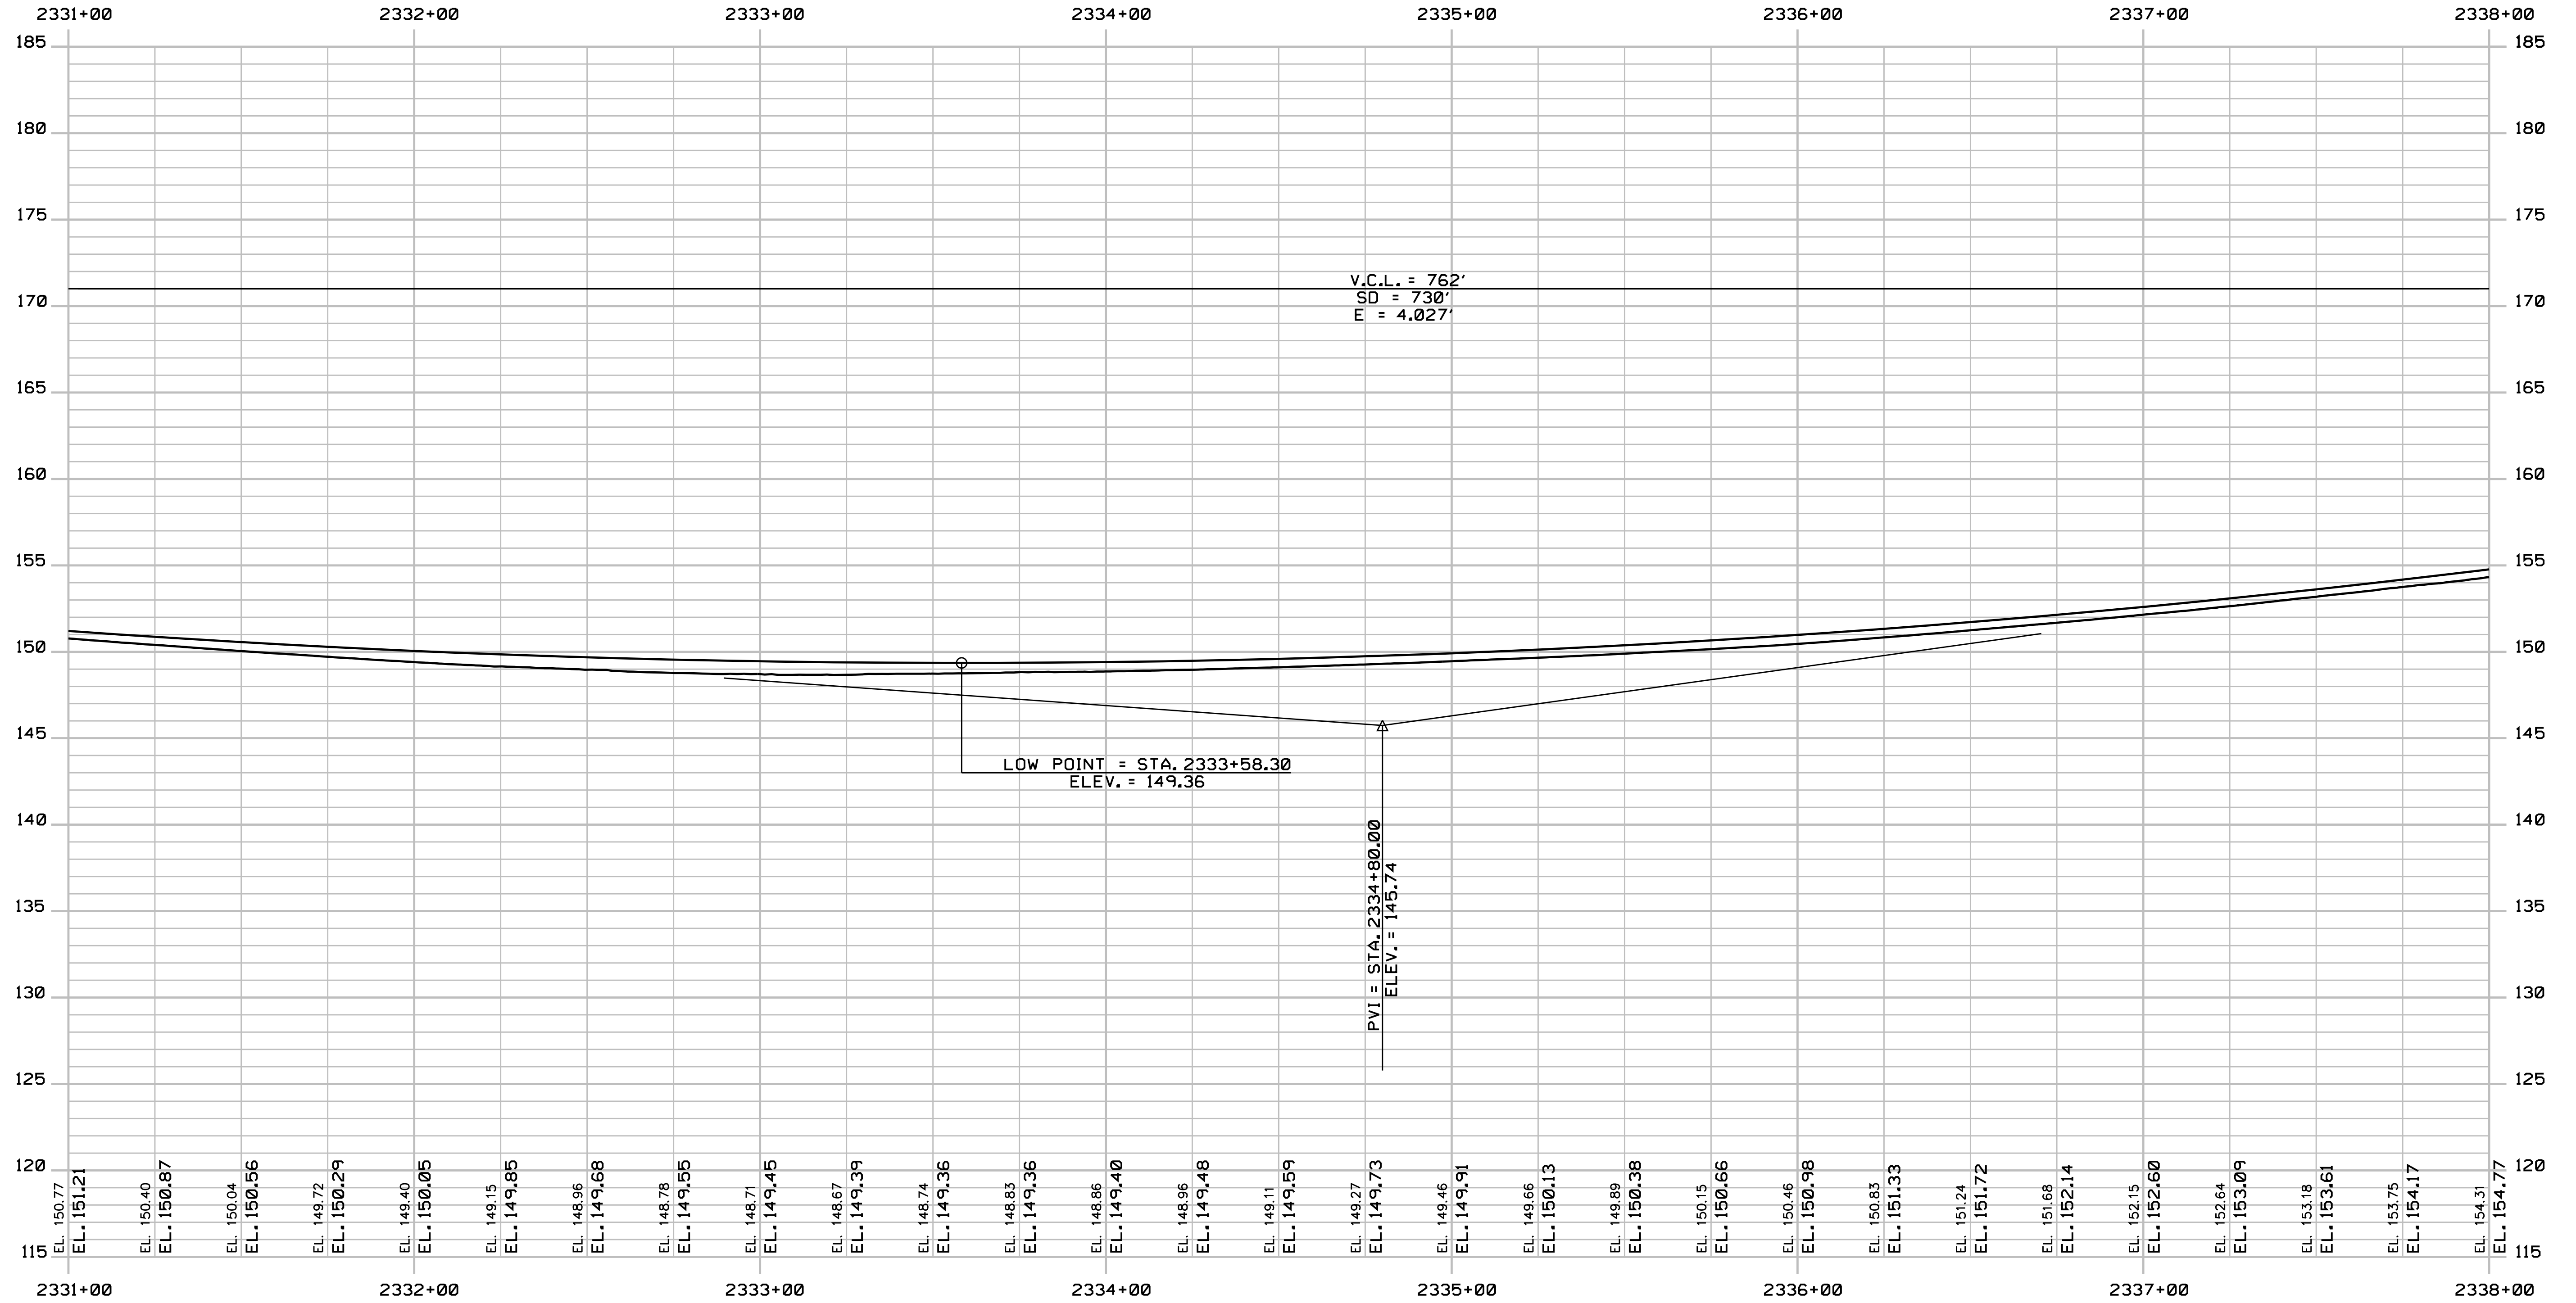

PROFILE

Scale:
 Horiz 25
 Vert 5
 Scale of Feet

No.	Revision	By	Date

Designed by:

JACOBS

CONSULTANT PROJECT MANAGER: T. MORIN

	By	Date		By	Date
Designed	CSM	7-18	Checked	RRP	7-18
Drawn	SMG	7-18	In Charge of	TWM	7-18

JACOBS ENGINEERING GROUP
 120 ST. JAMES AVENUE
 BOSTON, MA 02116
 TEL (617) 242-9222
 FAX (617) 242-9824

THE GOLD STAR
 MEMORIAL HIGHWAY

MTA PROJECT MANAGER: R. NORWOOD

YORK TOLL PLAZA

I-95 SOUTHBOUND PROFILE 5


SHEET NUMBER: PR-17

CONTRACT: 2018.20

183 OF 489

Date: 8/28/2018

Filename: ... \184_Profile_195SB_06.dgn

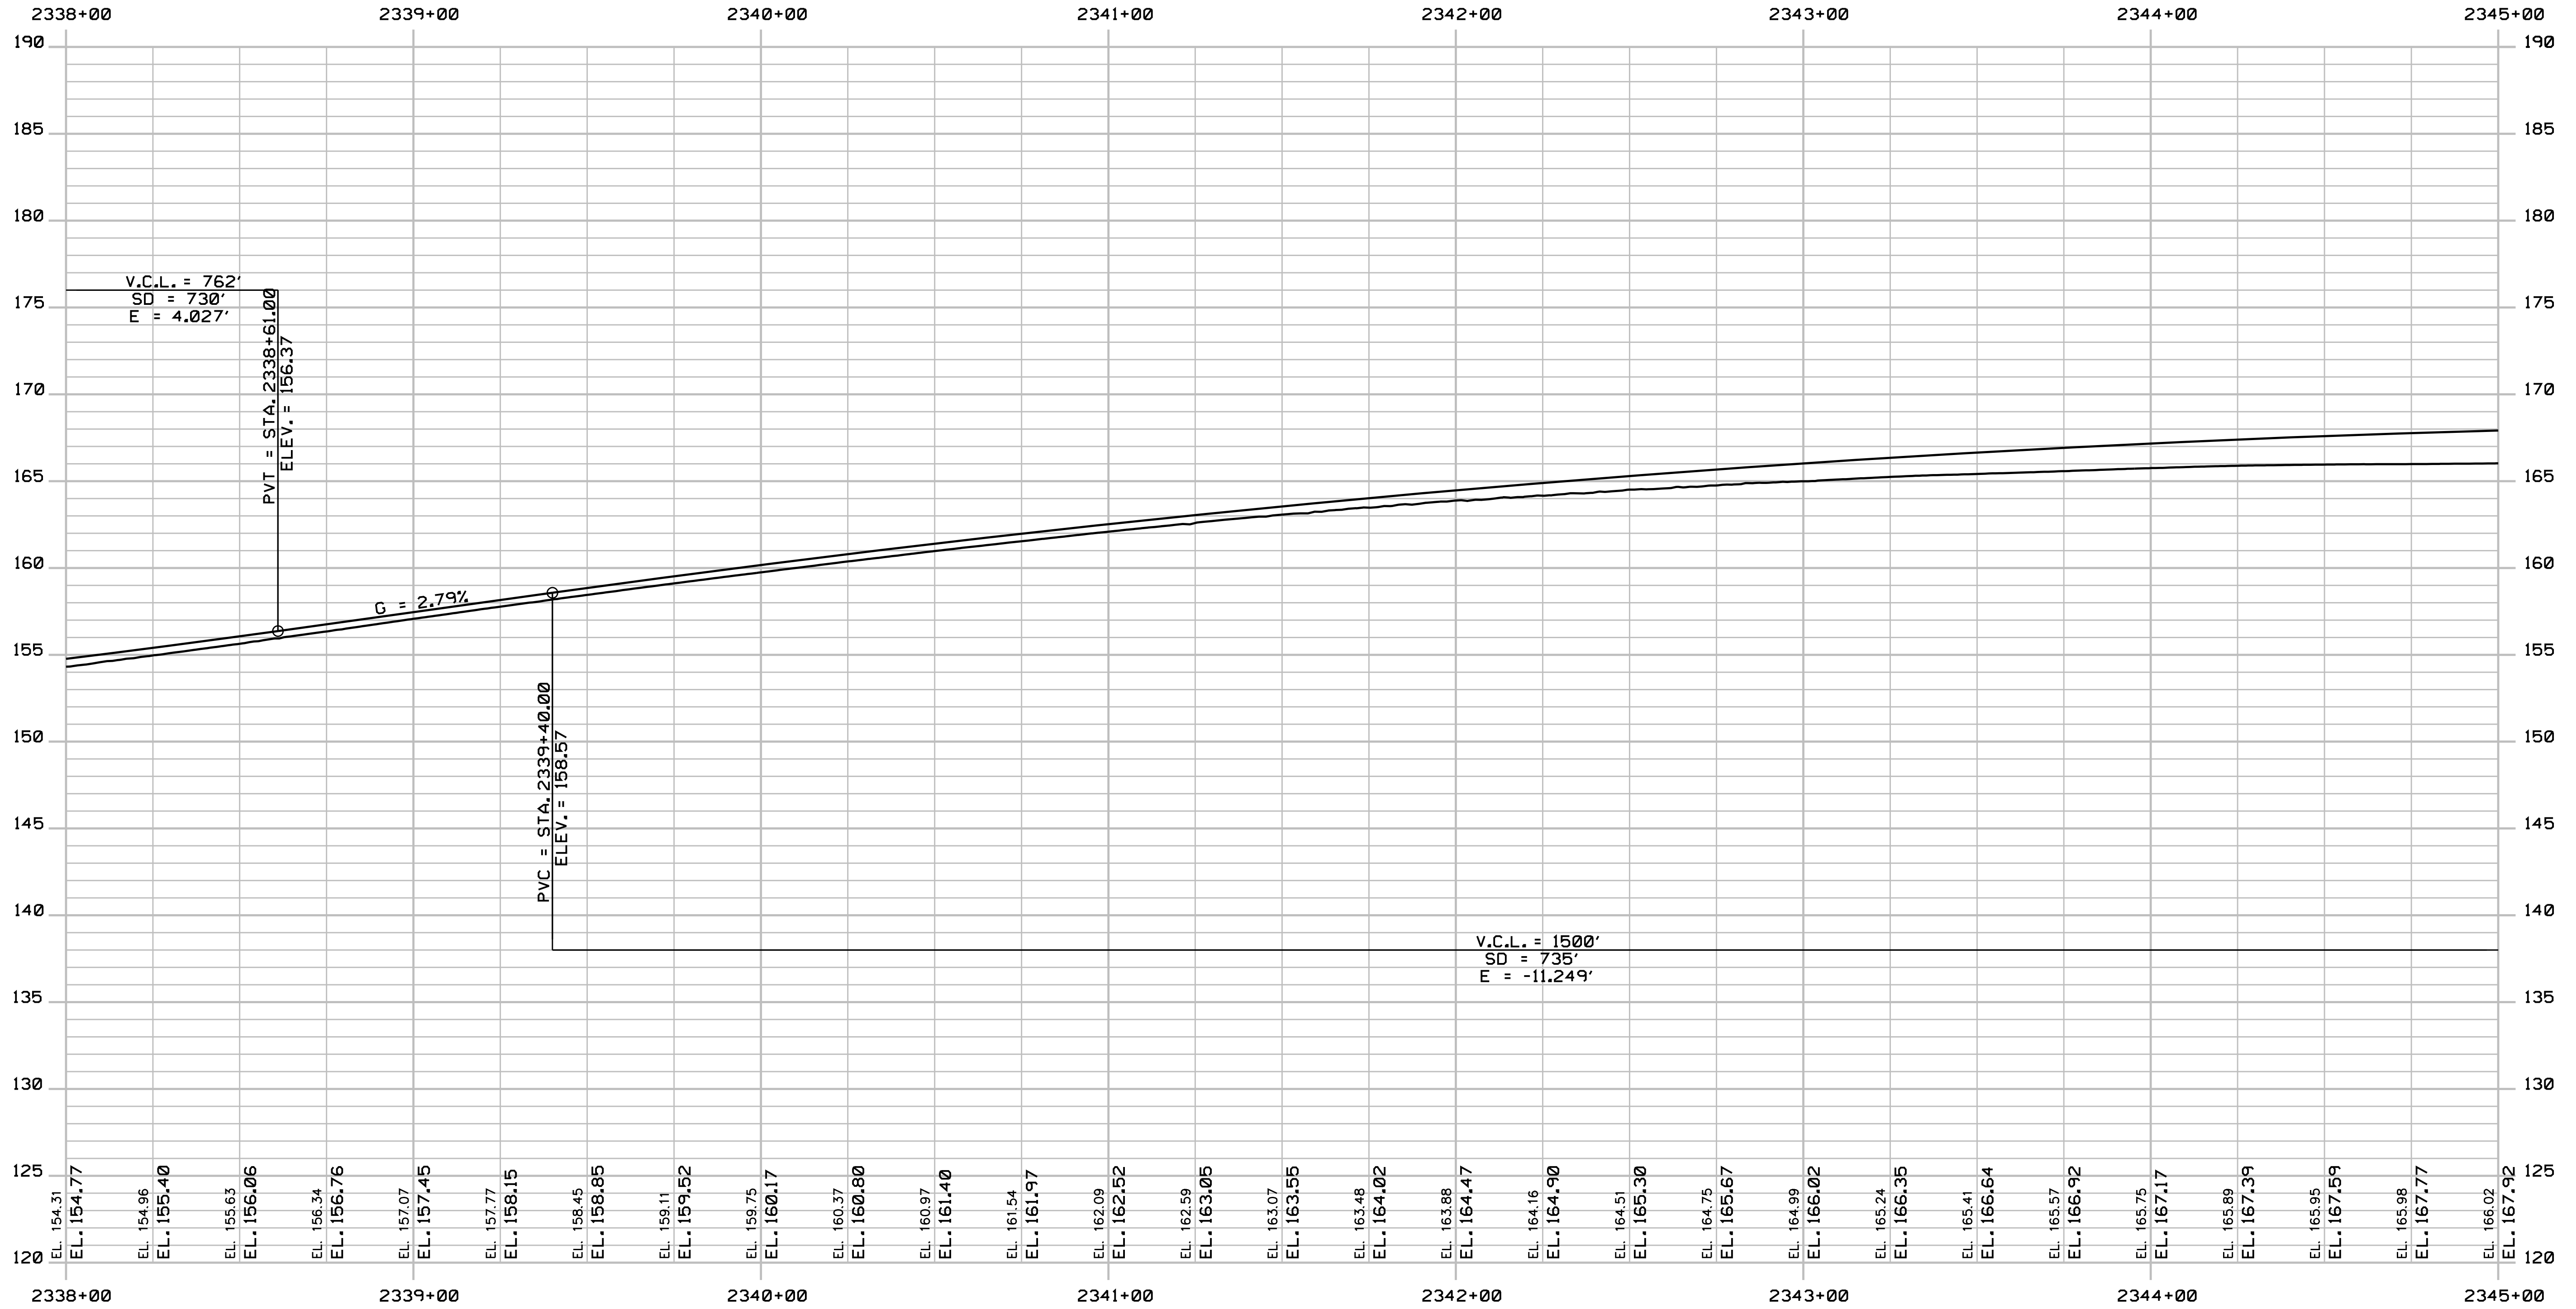

PROFILE

Scale:
 Horizontal: 0 25 50
 Vertical: 0 5 10
 Scale of Feet

No.	Revision	By	Date

Designed by:

JACOBS

CONSULTANT PROJECT MANAGER: T. MORIN

	By	Date	Checked	By	Date
Designed	CSM	7-18	Checked	RRP	7-18
Drawn	SMG	7-18	In Charge of	TWM	7-18

JACOBS ENGINEERING GROUP
 120 ST. JAMES AVENUE
 BOSTON, MA 02116
 TEL (617) 242-9222
 FAX (617) 242-9824

MAINE TURNPIKE

THE GOLD STAR
 MEMORIAL HIGHWAY

MTA PROJECT MANAGER: R. NORWOOD

YORK TOLL PLAZA

I-95 SOUTHBOUND PROFILE 6


SHEET NUMBER: PR-18

CONTRACT: 2018.20

184 OF 489

Date: 8/28/2018

Filename: ... \185_Profile_195SB_07.dgn

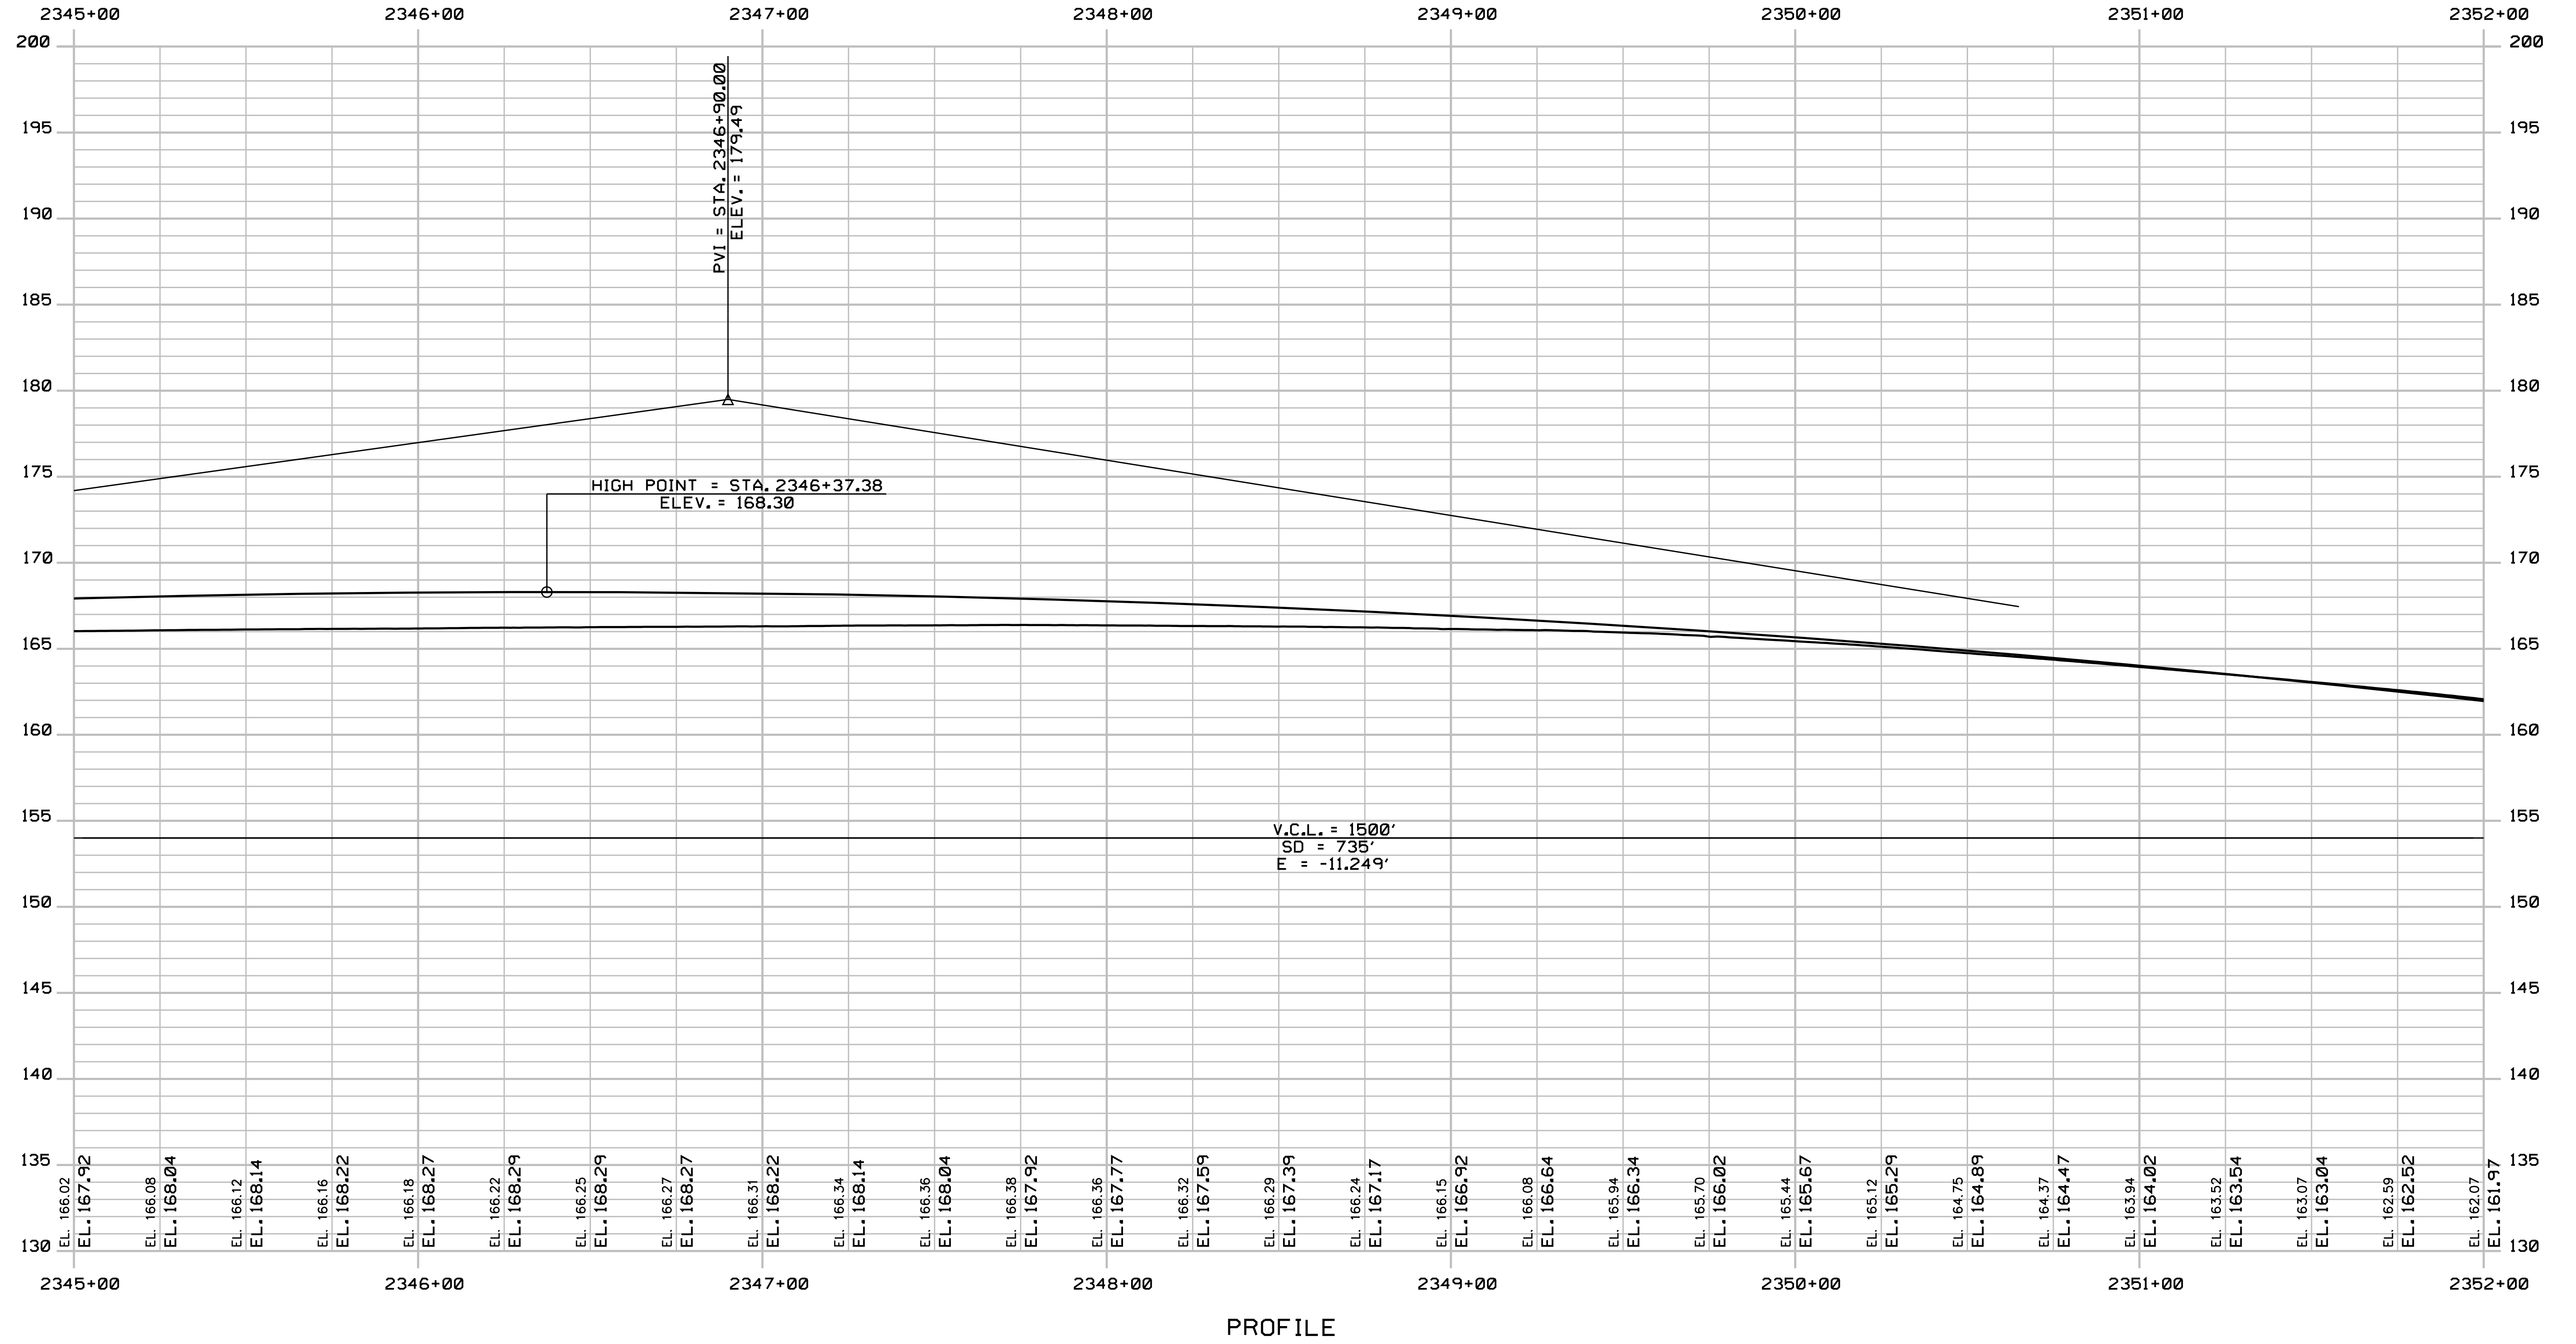

Scale:
 Horiz 25
 Vert 5
 Scale of Feet

No.	Revision	By	Date

Designed by:

JACOBS

CONSULTANT PROJECT MANAGER: T. MORIN

	By	Date		By	Date
Designed	CSM	7-18	Checked	RRP	7-18
Drawn	SMG	7-18	In Charge of	TWM	7-18

JACOBS ENGINEERING GROUP
 120 ST. JAMES AVENUE
 BOSTON, MA 02116
 TEL (617) 242-9222
 FAX (617) 242-9824

MAINE TURNPIKE

THE GOLD STAR
 MEMORIAL HIGHWAY

MTA PROJECT MANAGER: R. NORWOOD

YORK TOLL PLAZA


I-95 SOUTHBOUND PROFILE 7

SHEET NUMBER: PR-19

CONTRACT: 2018.20

185 OF 489

Date: 8/28/2018

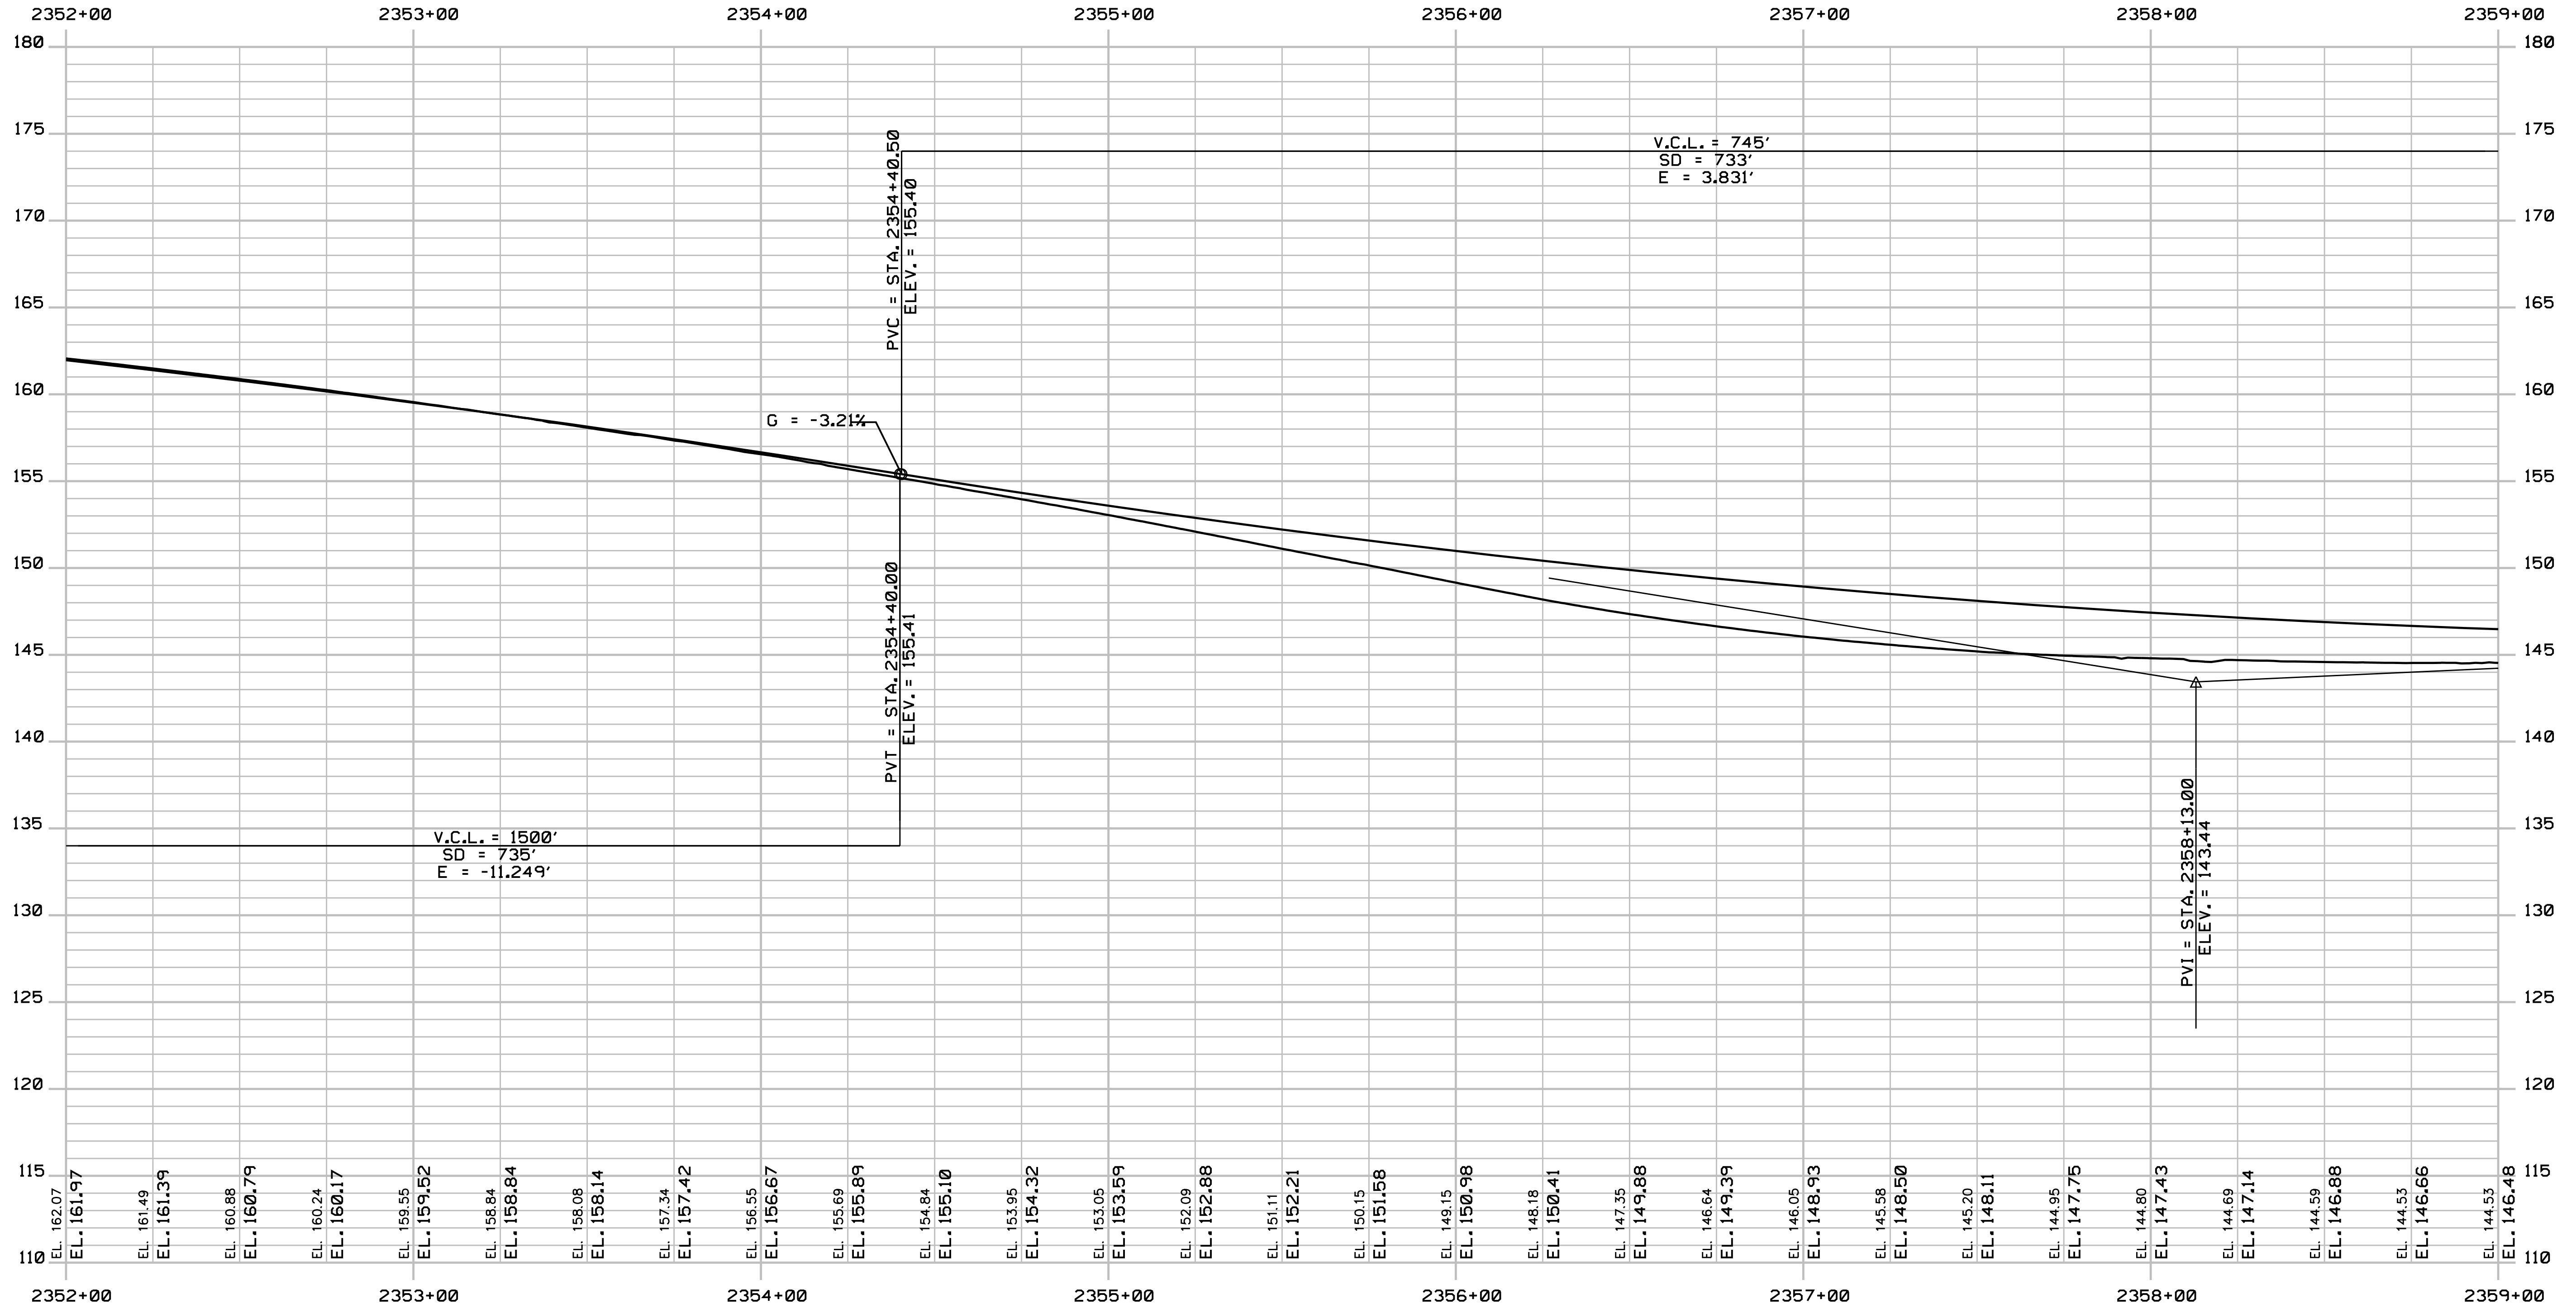

PROFILE

Filename: ... \186_Profile_195SB_08.dgn

Scale:
Horiz 25
Vert 5

Scale of Feet

No.	Revision	By	Date

Designed by:

JACOBS

CONSULTANT PROJECT MANAGER: T. MORIN

	By	Date		By	Date
Designed	CSM	7-18	Checked	RRP	7-18
Drawn	SMG	7-18	In Charge of	TWM	7-18

JACOBS ENGINEERING GROUP
120 ST. JAMES AVENUE
BOSTON, MA 02116
TEL (617) 242-9222
FAX (617) 242-9824

MAINE TURNPIKE

THE GOLD STAR
MEMORIAL HIGHWAY

MTA PROJECT MANAGER: R. NORWOOD

YORK TOLL PLAZA

I-95 SOUTHBOUND PROFILE 8


SHEET NUMBER: PR-20

CONTRACT: 2018.20

186 OF 489

Date: 8/28/2018

Filename: ... \187_Profile_195SB_09.dgn

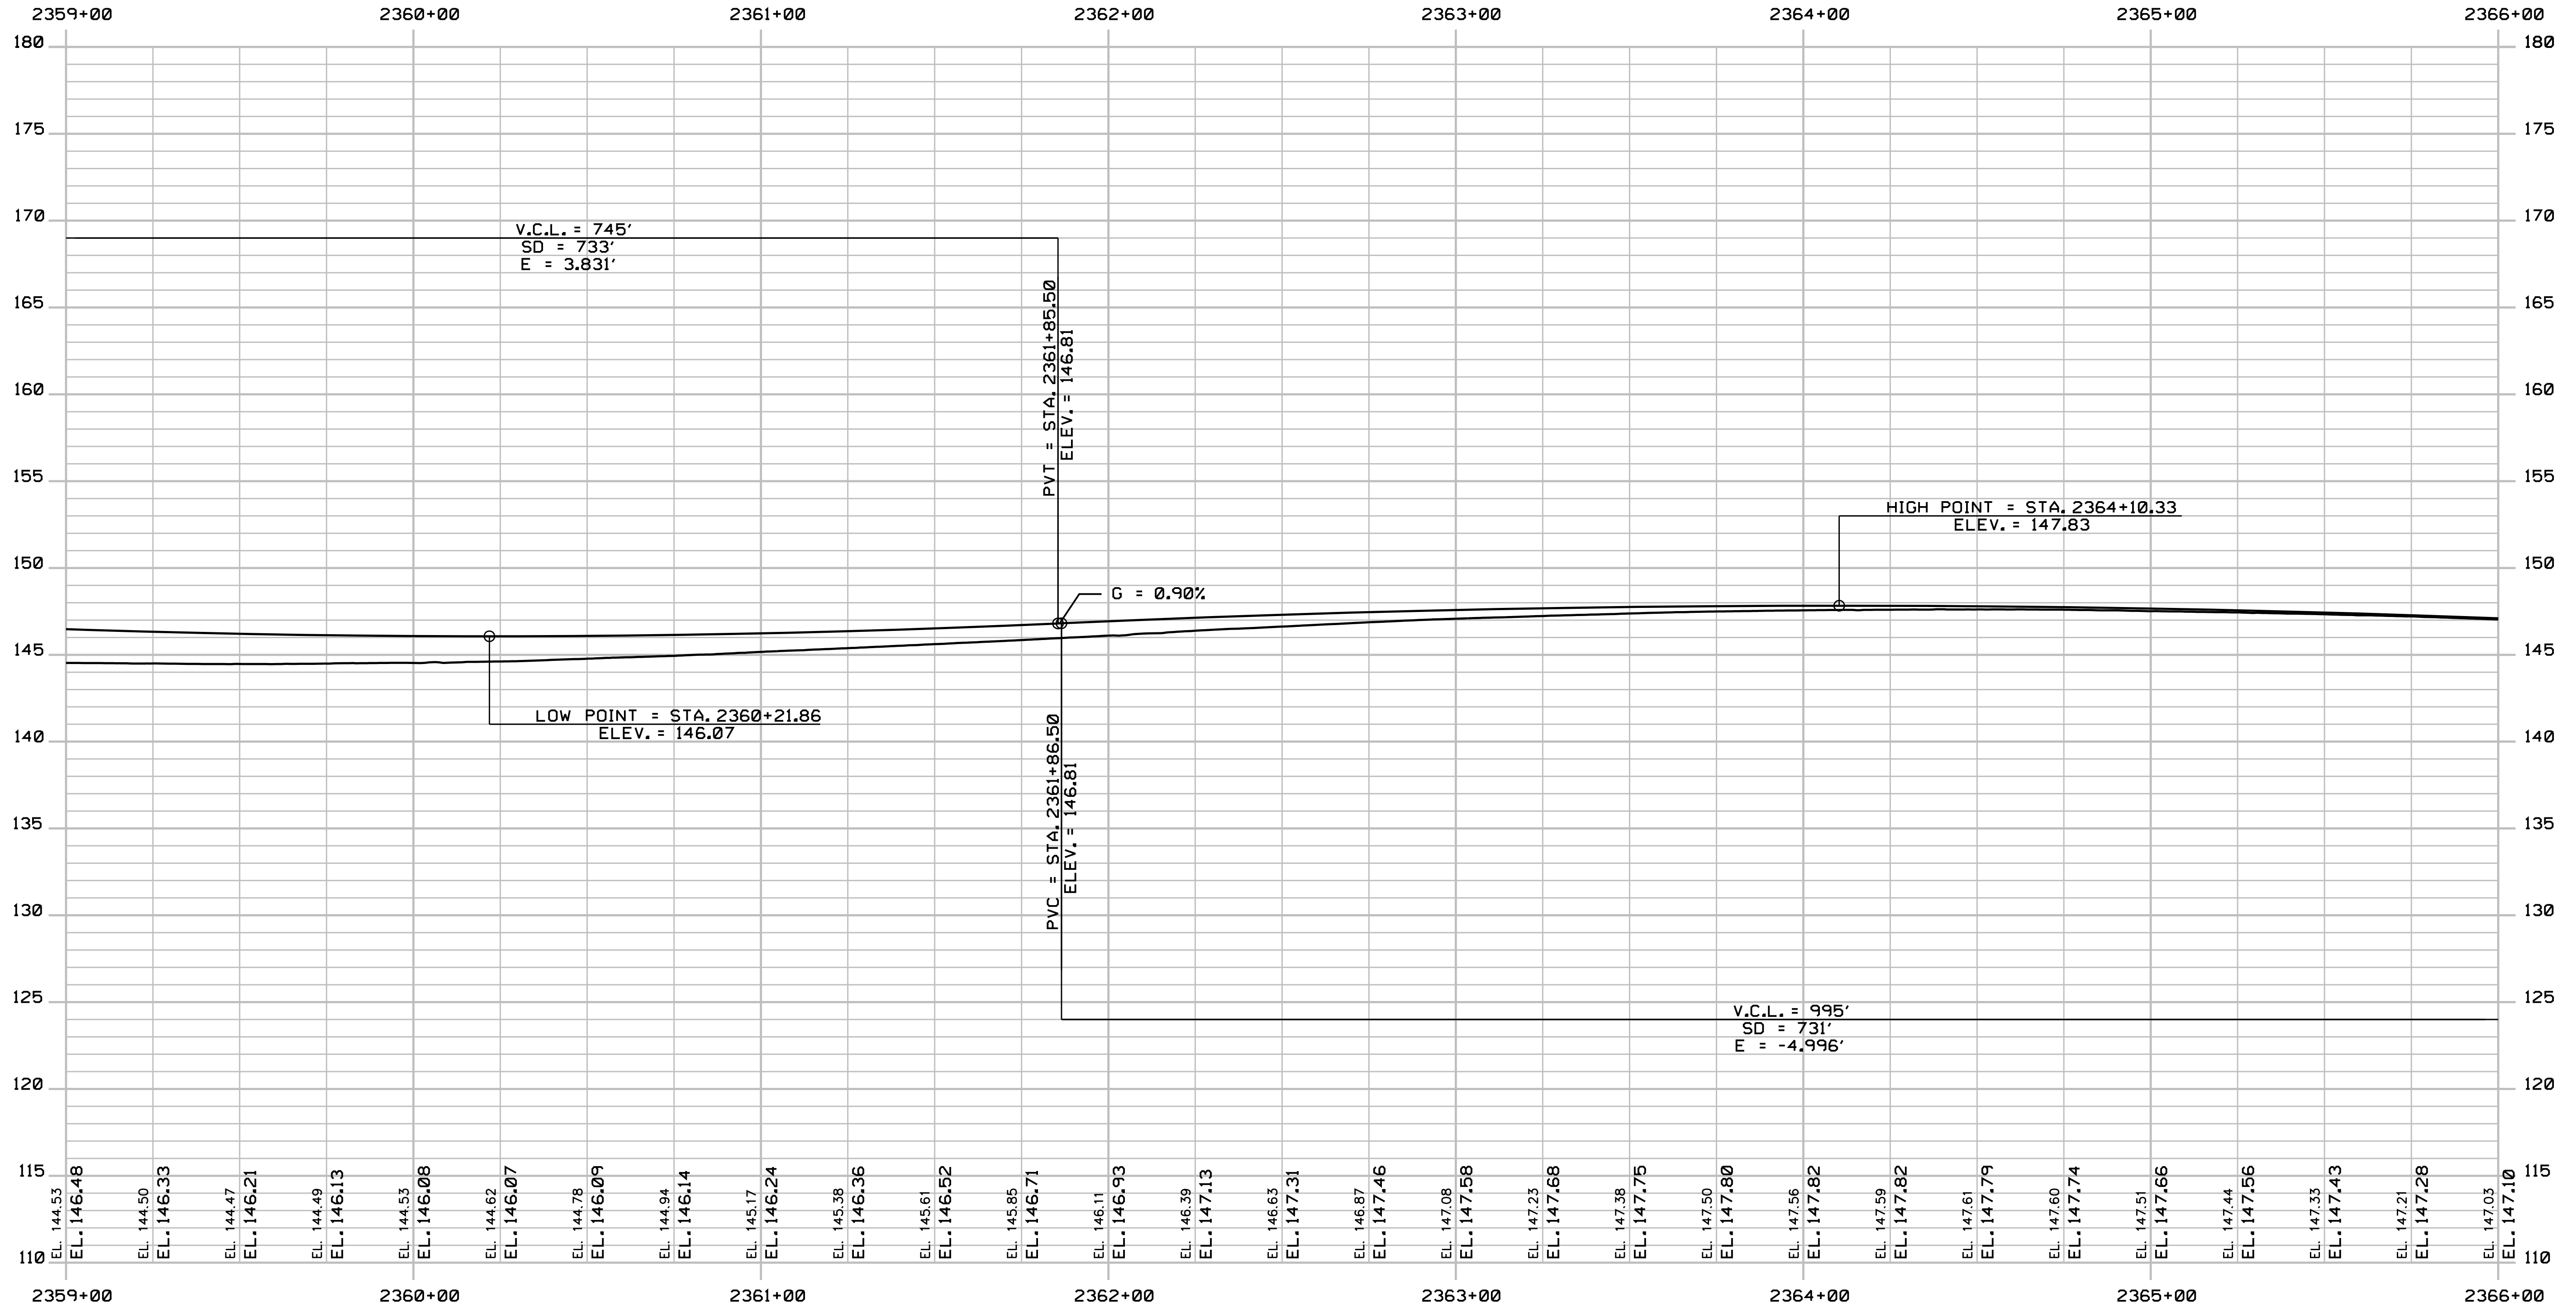

PROFILE

Scale:
 Horiz 25
 Vert 5

No.	Revision	By	Date

Designed by:

JACOBS

CONSULTANT PROJECT MANAGER: T. MORIN

	By	Date		By	Date
Designed	CSM	7-18	Checked	RRP	7-18
Drawn	SMG	7-18	In Charge of	TWM	7-18

JACOBS ENGINEERING GROUP
 120 ST. JAMES AVENUE
 BOSTON, MA 02116
 TEL (617) 242-9222
 FAX (617) 242-9824

THE GOLD STAR
 MEMORIAL HIGHWAY

MTA PROJECT MANAGER: R. NORWOOD

YORK TOLL PLAZA


I-95 SOUTHBOUND PROFILE 9

SHEET NUMBER: PR-21

CONTRACT: 2018.20

187 OF 489

Date: 8/28/2018

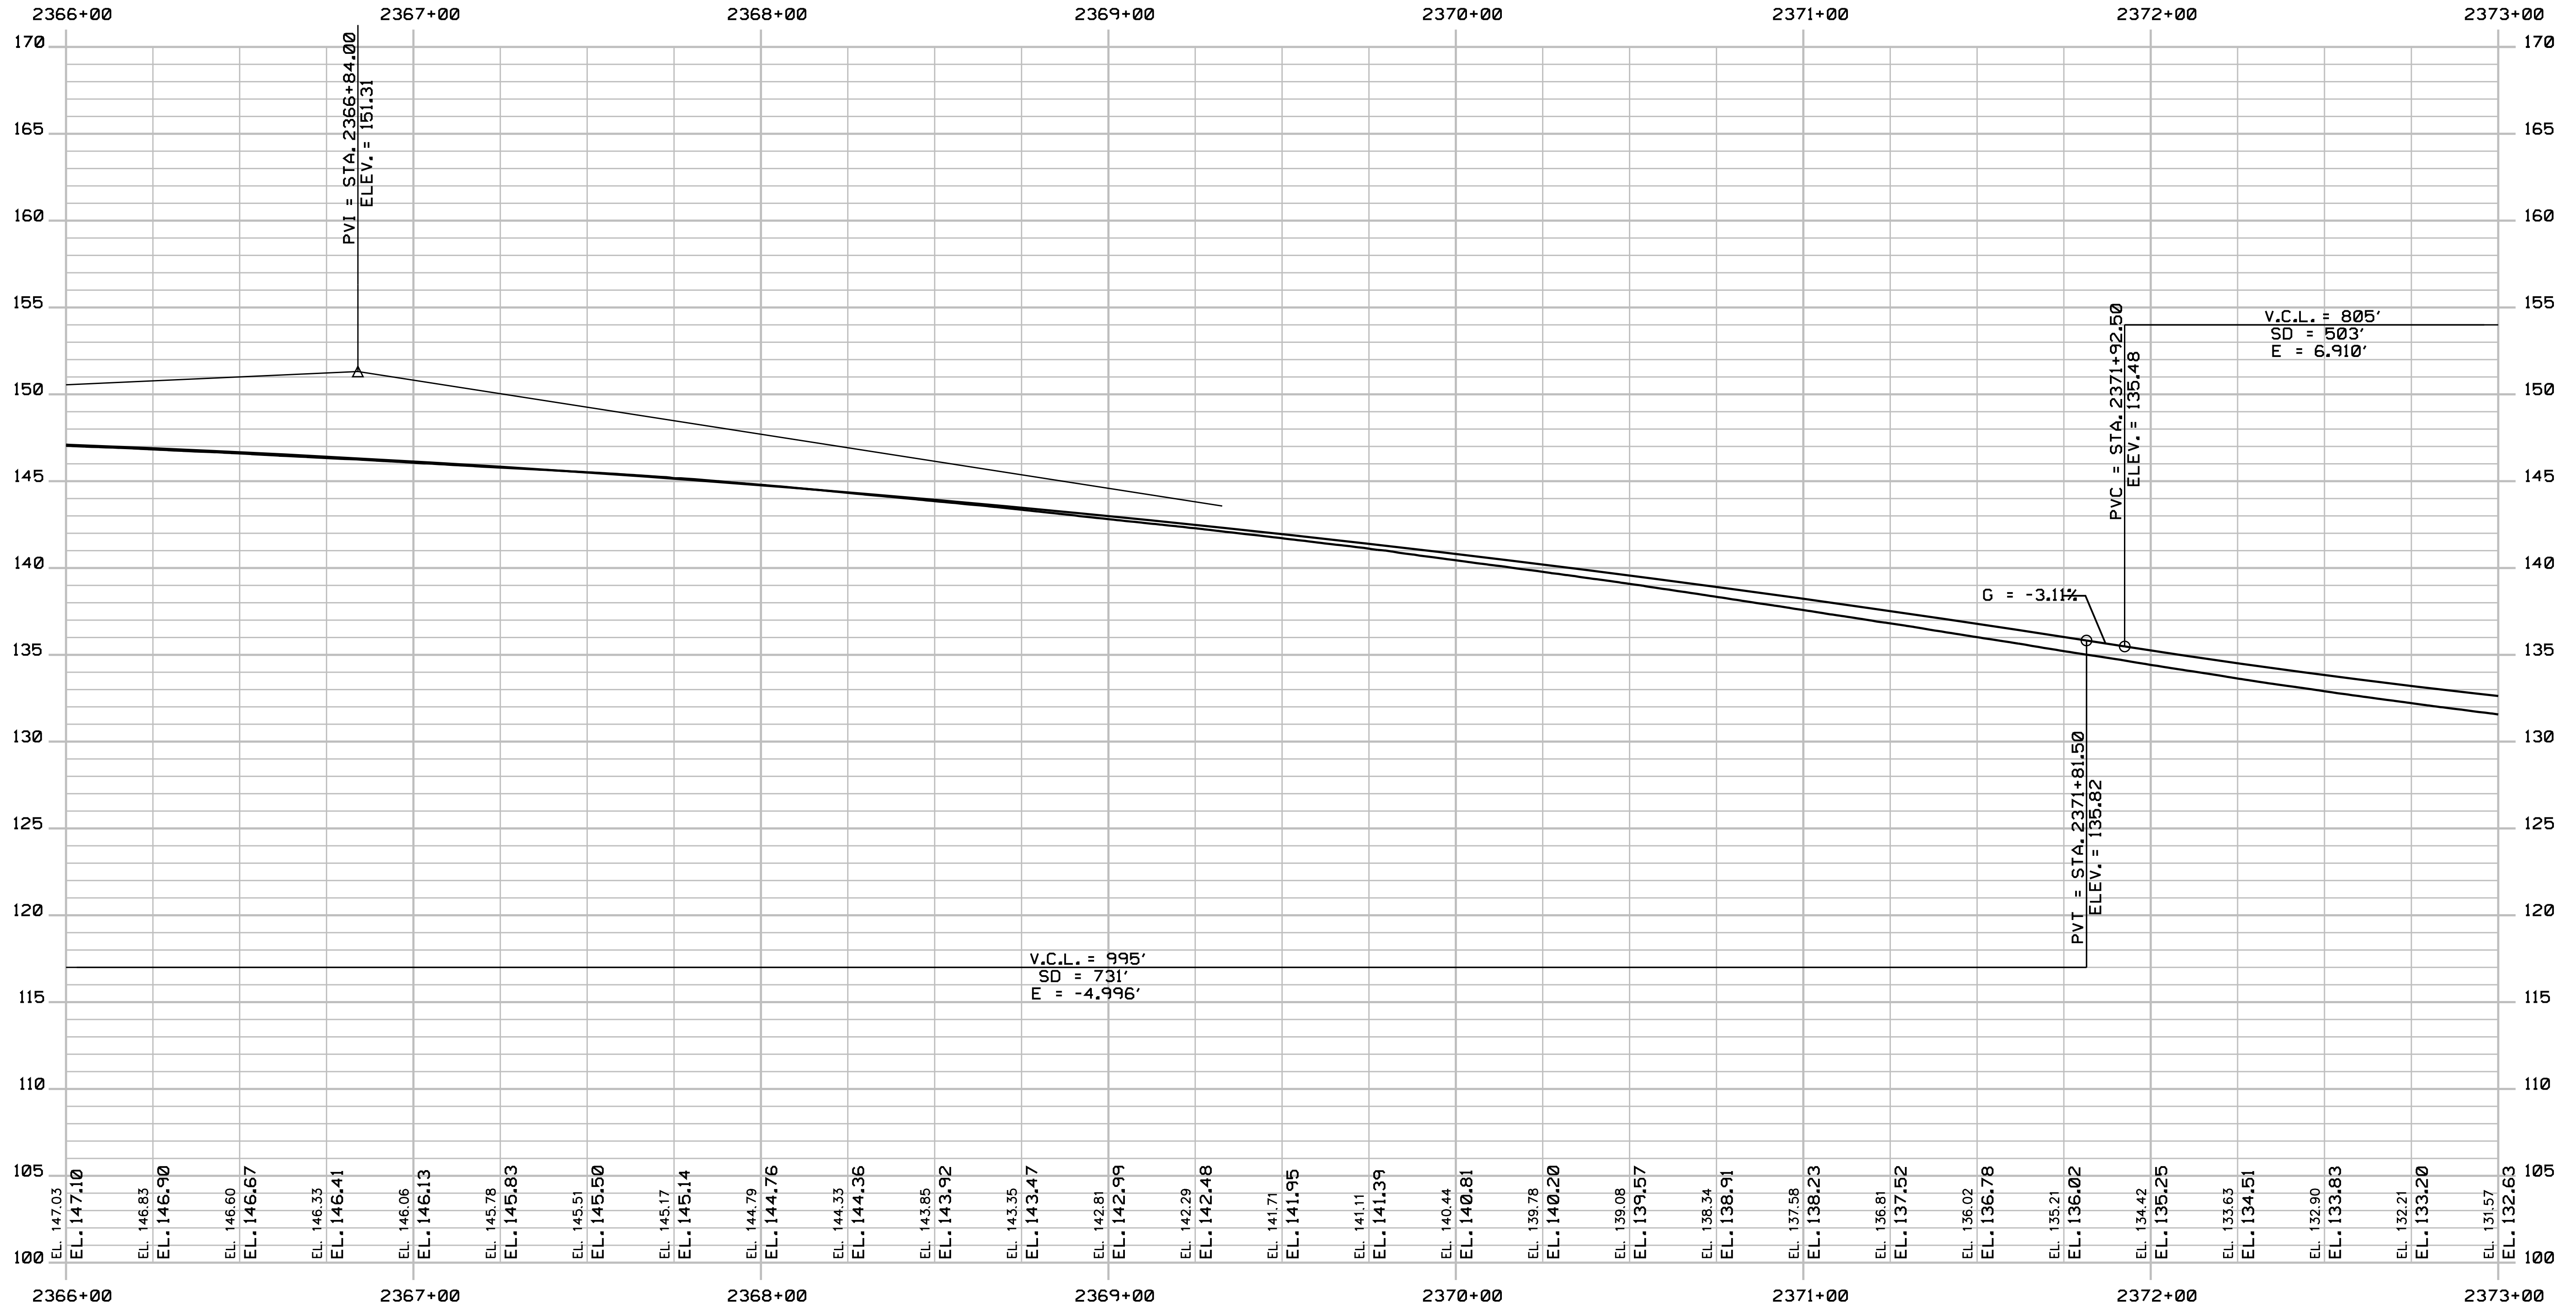

PROFILE

Filename: ... \188_Profile_195SB_10.dgn

Scale:
 Horizontal: 1" = 25'
 Vertical: 1" = 5'

No.	Revision	By	Date

Designed by:

JACOBS

CONSULTANT PROJECT MANAGER: T. MORIN

	By	Date		By	Date
Designed	CSM	7-18	Checked	RRP	7-18
Drawn	SMG	7-18	In Charge of	TWM	7-18

JACOBS ENGINEERING GROUP
 120 ST. JAMES AVENUE
 BOSTON, MA 02116
 TEL (617) 242-9222
 FAX (617) 242-9824

THE GOLD STAR
 MEMORIAL HIGHWAY


MTA PROJECT MANAGER: R. NORWOOD

YORK TOLL PLAZA
 I-95 SOUTHBOUND PROFILE 10

SHEET NUMBER: PR-22
 188 OF 489

CONTRACT: 2018.20

Date: 8/28/2018

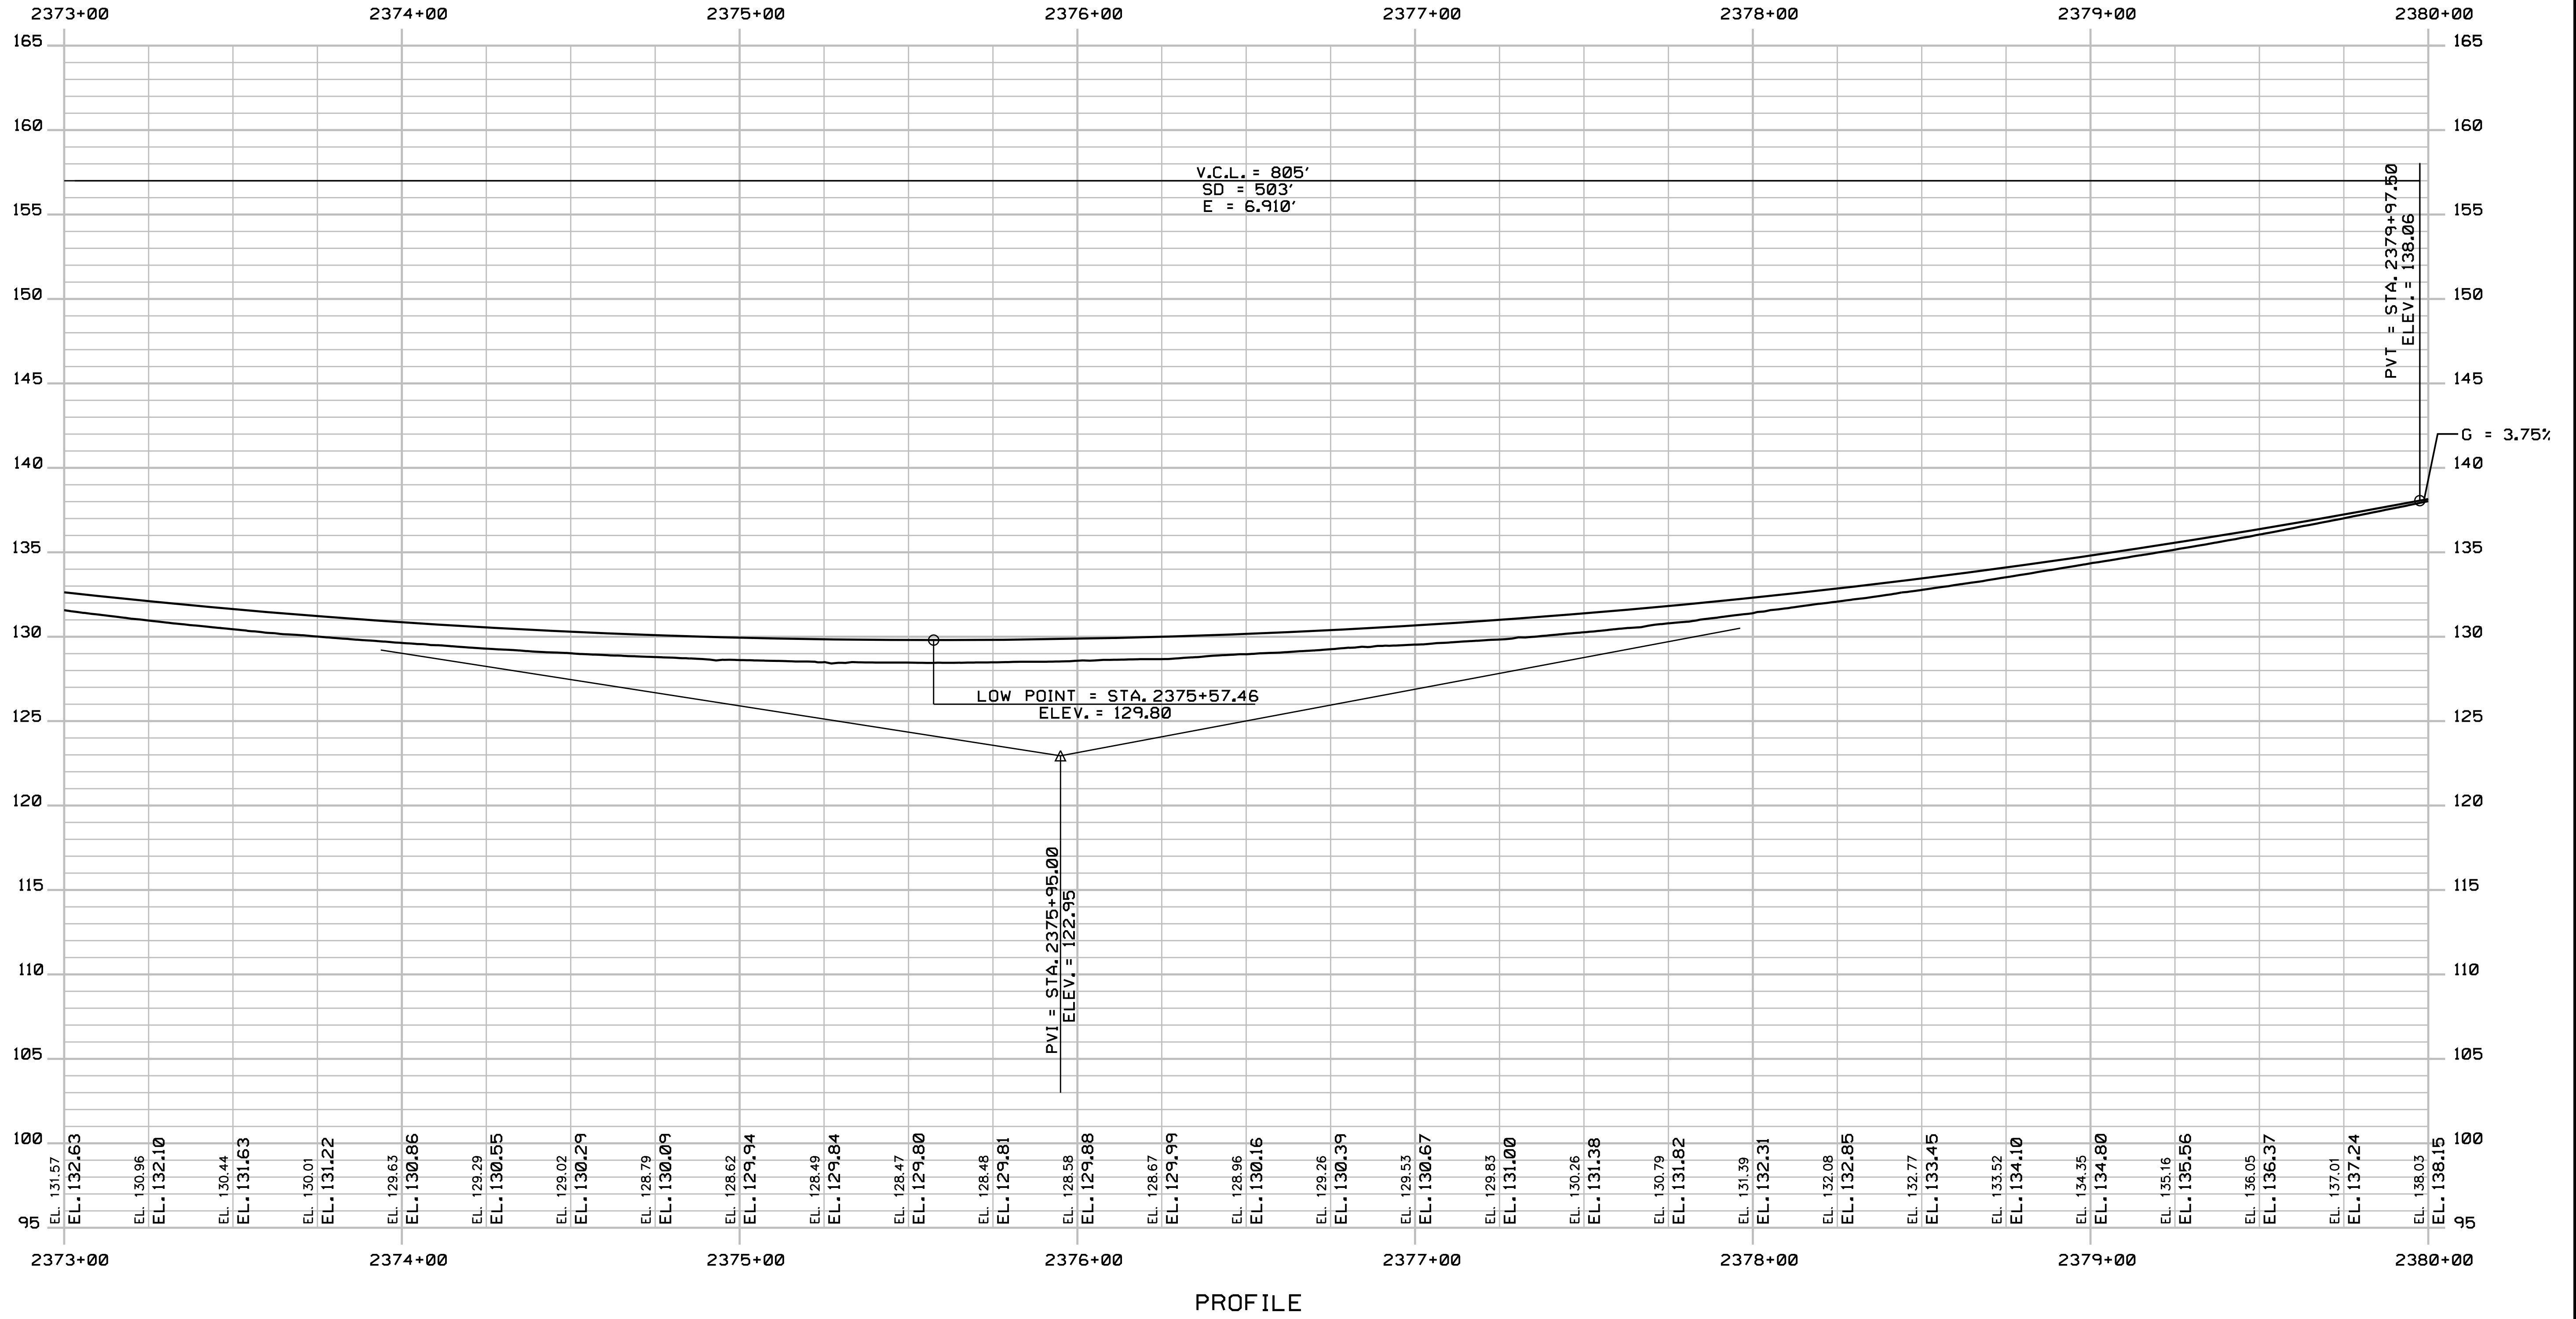

Filename: ... \189_Profile_195SB_11.dgn

Scale:
 Horizontal: 1" = 25'
 Vertical: 1" = 5'

No.	Revision	By	Date

Designed by:

JACOBS

CONSULTANT PROJECT MANAGER: T. MORIN

	By	Date		By	Date
Designed	CSM	7-18	Checked	RRP	7-18
Drawn	SMG	7-18	In Charge of	TWM	7-18

JACOBS ENGINEERING GROUP
 120 ST. JAMES AVENUE
 BOSTON, MA 02116
 TEL (617) 242-9222
 FAX (617) 242-9824

THE GOLD STAR
MEMORIAL HIGHWAY


MTA PROJECT MANAGER: R. NORWOOD

YORK TOLL PLAZA
 I-95 SOUTHBOUND PROFILE 11

SHEET NUMBER: PR-23
 189 OF 489

CONTRACT: 2018.20

Date: 8/28/2018

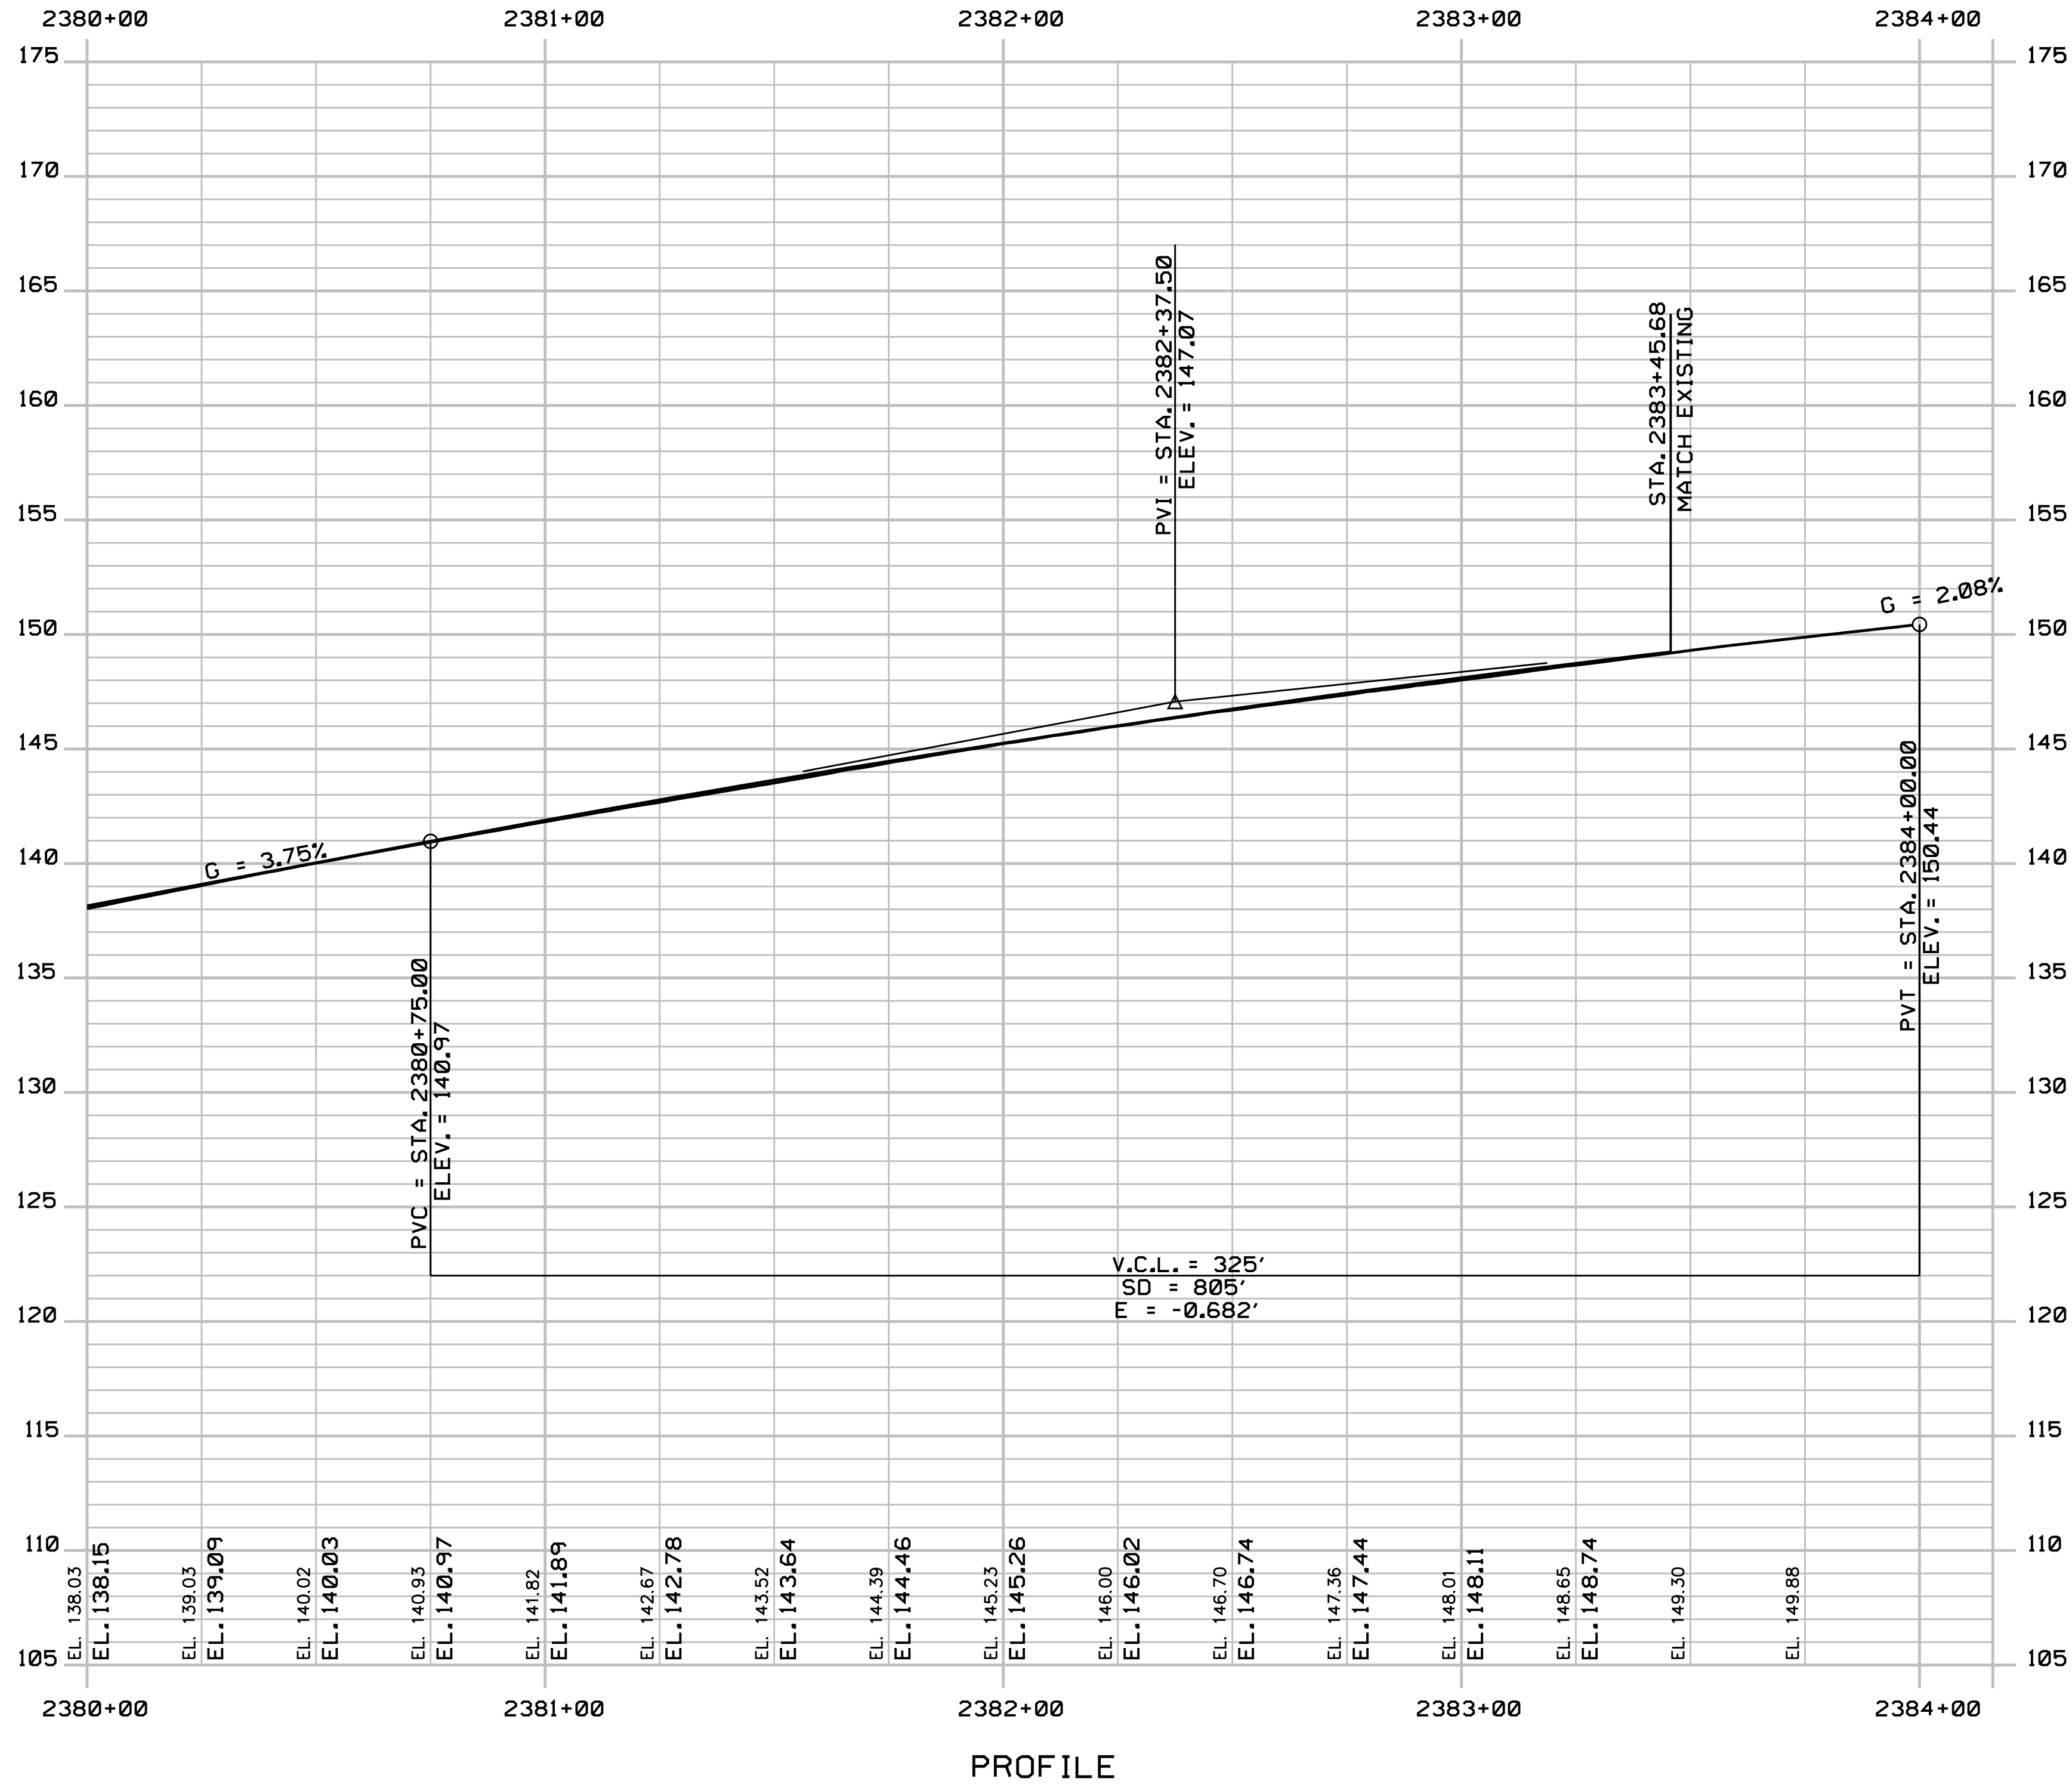

Filename: ... \190_Profile_195SB_12.dgn

Scale:
 Horizontal: 1" = 25'
 Vertical: 1" = 5'

No.	Revision	By	Date

Designed by:

JACOBS

CONSULTANT PROJECT MANAGER: T. MORIN

	By	Date		By	Date
Designed	CSM	7-18	Checked	RRP	7-18
Drawn	SMG	7-18	In Charge of	TWM	7-18

JACOBS ENGINEERING GROUP
 120 ST. JAMES AVENUE
 BOSTON, MA 02116
 TEL (617) 242-9222
 FAX (617) 242-9824

THE GOLD STAR
 MEMORIAL HIGHWAY


MTA PROJECT MANAGER: R. NORWOOD

YORK TOLL PLAZA
 I-95 SOUTHBOUND PROFILE 12

SHEET NUMBER: PR-24
 CONTRACT: 2018.20
 190 OF 489

Date: 8/28/2018

Filename: ... \191_Profile_195NB_Cash_01.dgn

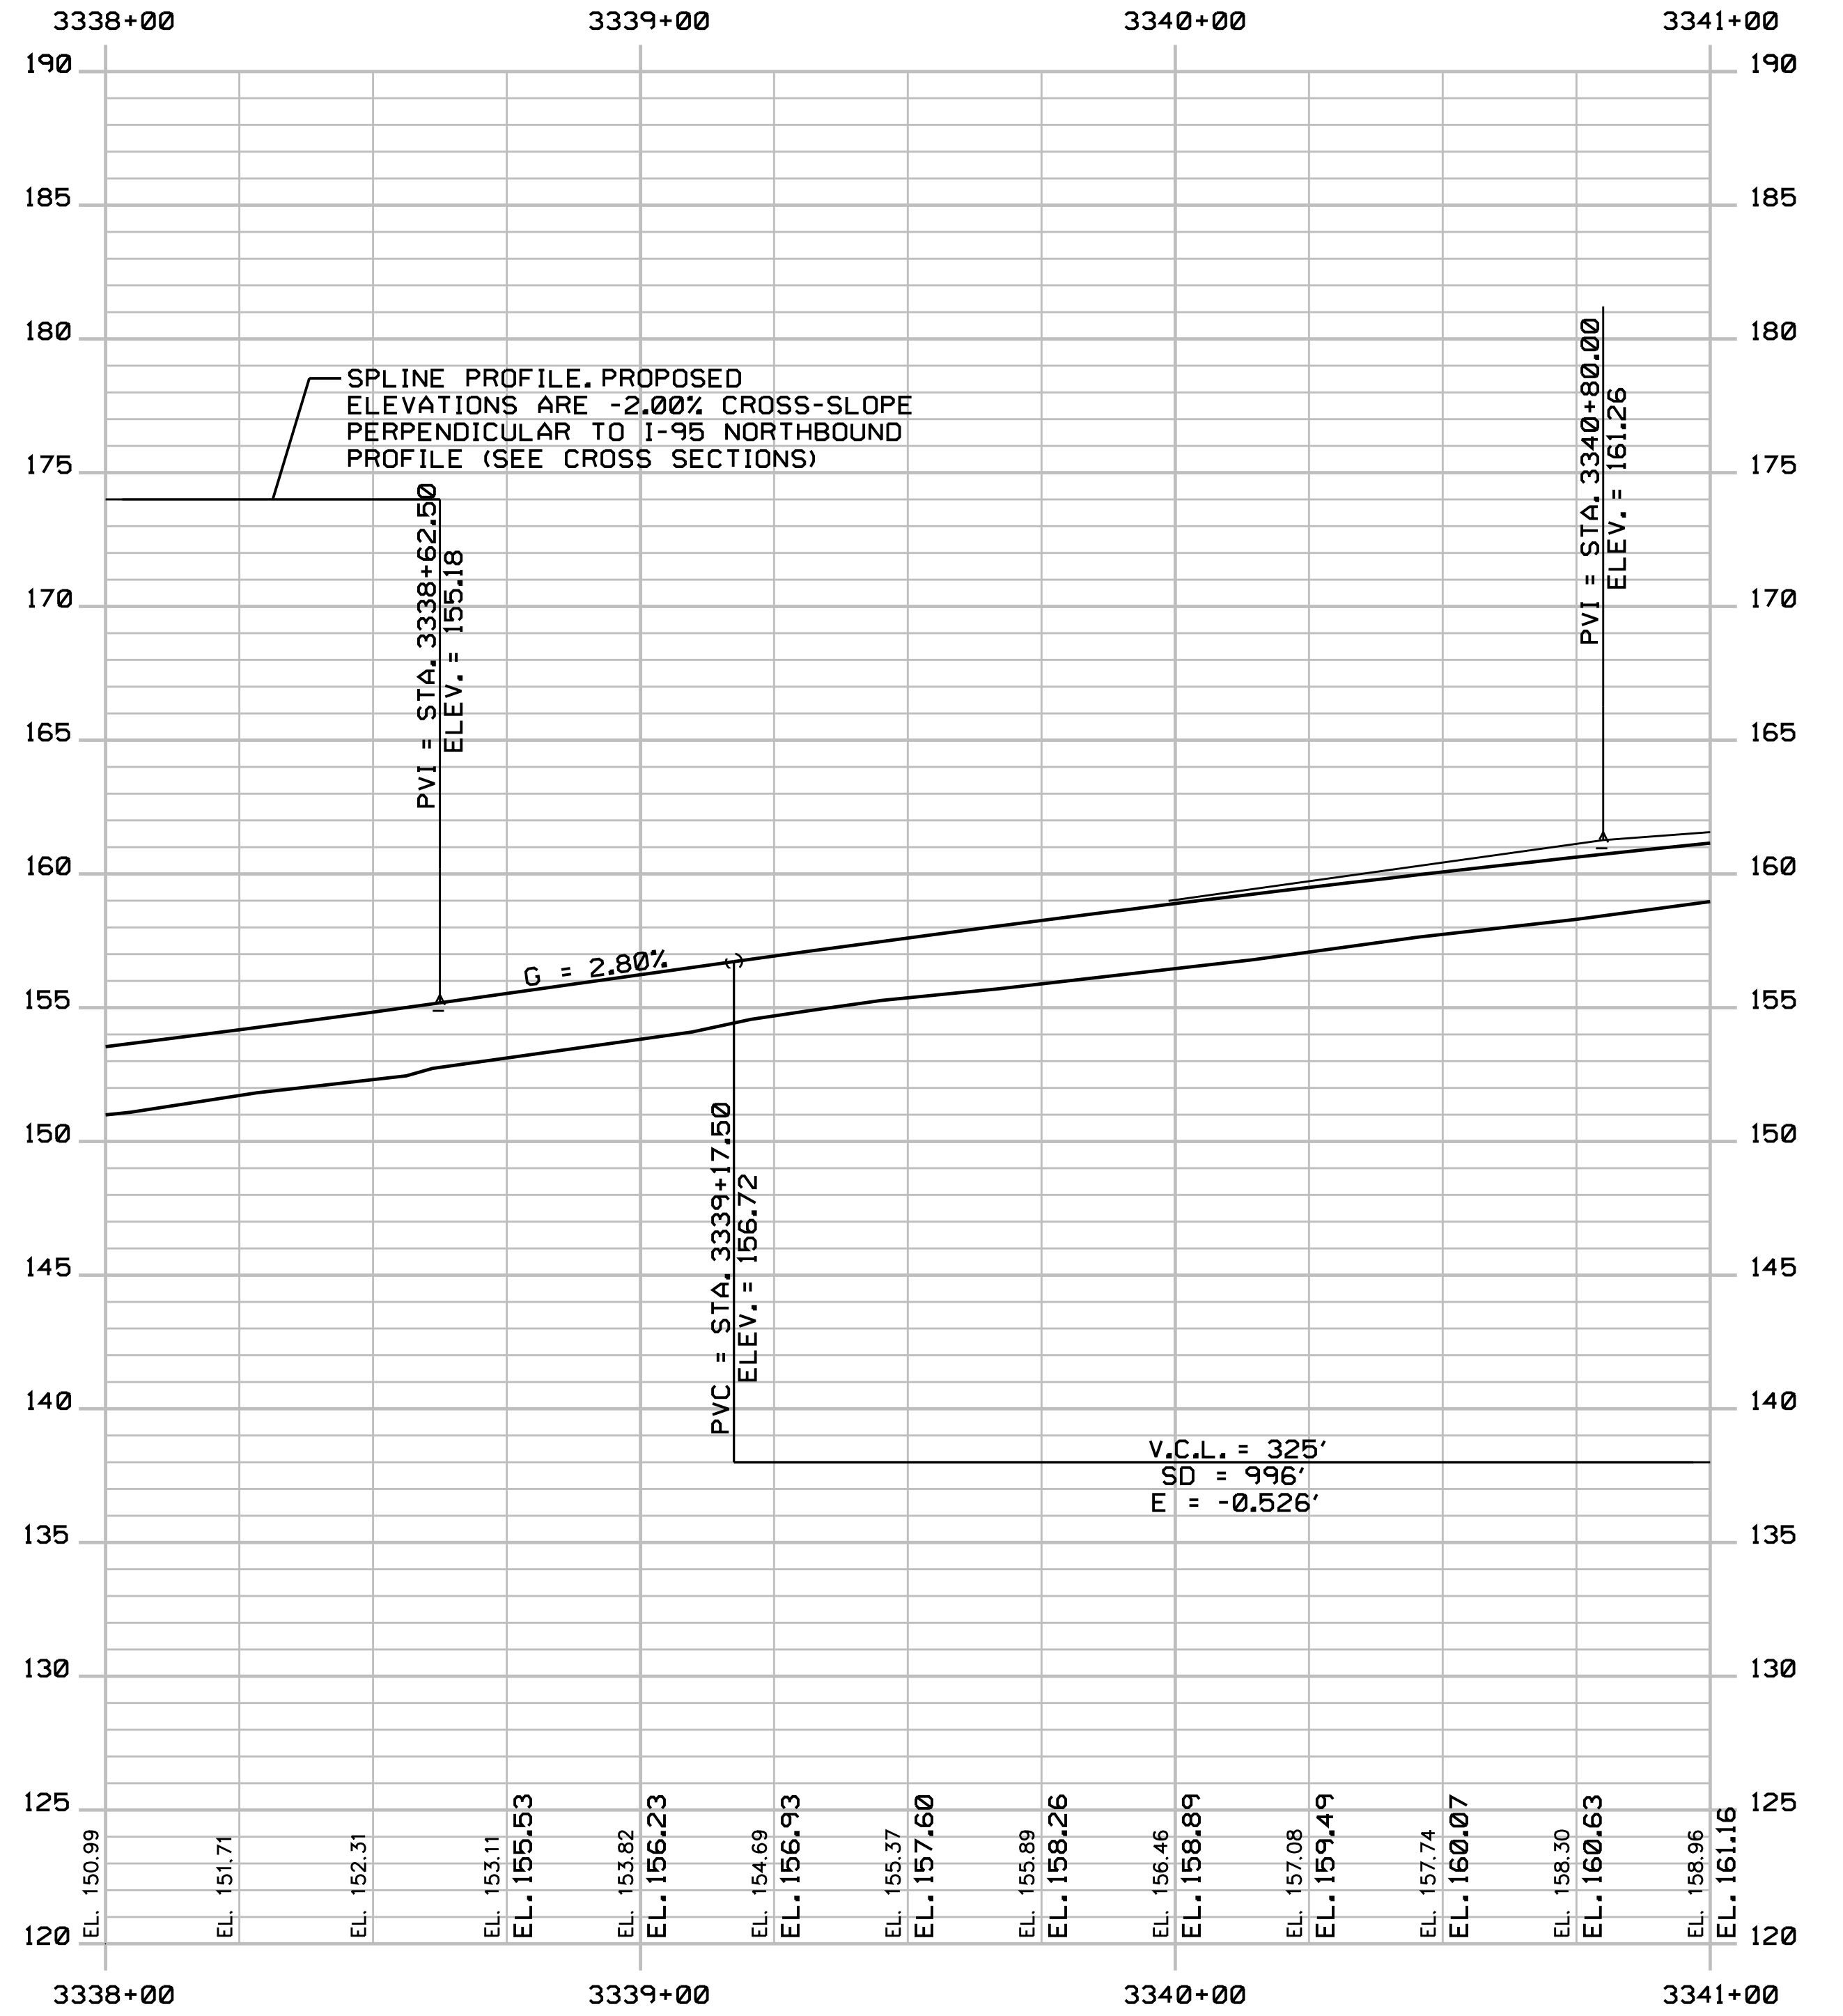

PROFILE

Scale:
Horiz 25
Vert 5

No.	Revision	By	Date

Designed by:

JACOBS

CONSULTANT PROJECT MANAGER: T. MORIN

	By	Date		By	Date
Designed	CSM	7-18	Checked	RRP	7-18
Drawn	SMG	7-18	In Charge of	TWM	7-18

JACOBS ENGINEERING GROUP
120 ST. JAMES AVENUE
BOSTON, MA 02116
TEL (617) 242-9222
FAX (617) 242-9824

THE GOLD STAR
MEMORIAL HIGHWAY

MTA PROJECT MANAGER: R. NORWOOD

YORK TOLL PLAZA


I-95 NORTHBOUND CASH PROFILE 1

SHEET NUMBER: PR-25

CONTRACT: 2018.20

191 OF 489

Date: 8/28/2018

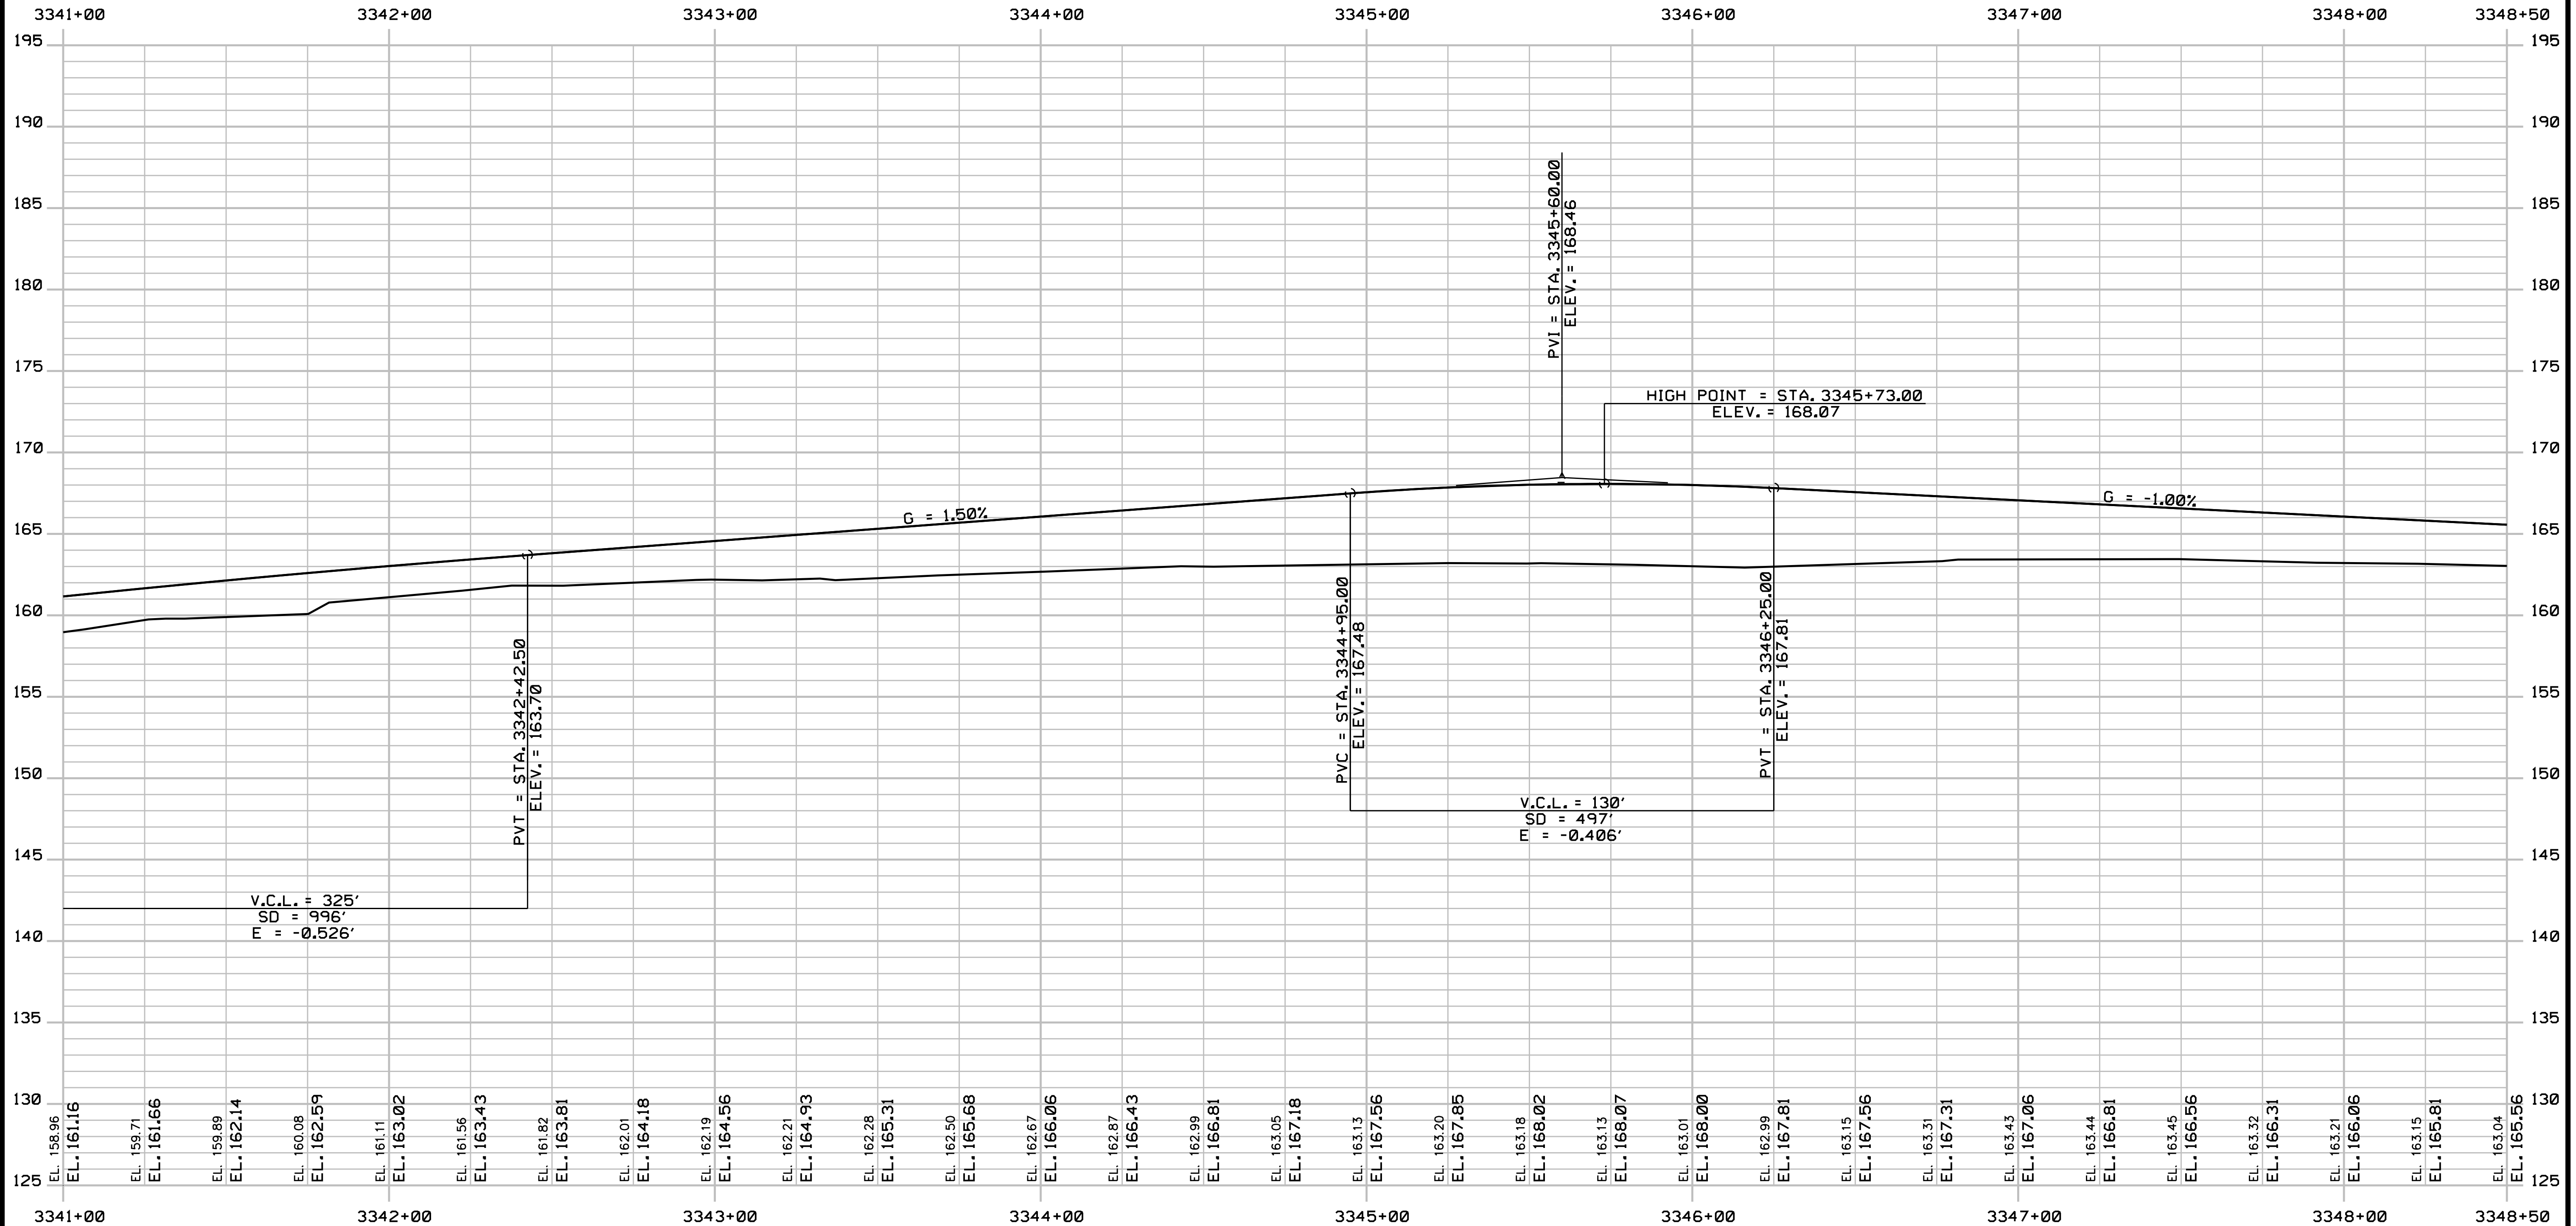

PROFILE

3341+00	3342+00	3343+00	3344+00	3345+00	3346+00	3347+00	3348+00	3348+50
EL. 158.96 EL. 161.16	EL. 159.71 EL. 161.66	EL. 159.89 EL. 162.14	EL. 160.08 EL. 162.59	EL. 161.11 EL. 163.02	EL. 161.56 EL. 163.43	EL. 161.82 EL. 163.81	EL. 162.01 EL. 164.18	EL. 162.19 EL. 164.56
EL. 162.21 EL. 164.93	EL. 162.28 EL. 165.31	EL. 162.50 EL. 165.68	EL. 162.67 EL. 166.06	EL. 162.87 EL. 166.43	EL. 162.99 EL. 166.81	EL. 163.05 EL. 167.18	EL. 163.13 EL. 167.56	EL. 163.20 EL. 167.85
EL. 163.18 EL. 168.02	EL. 163.13 EL. 168.07	EL. 163.01 EL. 168.00	EL. 162.99 EL. 167.81	EL. 163.15 EL. 167.56	EL. 163.31 EL. 167.31	EL. 163.43 EL. 167.06	EL. 163.44 EL. 166.81	EL. 163.45 EL. 166.56
EL. 163.32 EL. 166.31	EL. 163.21 EL. 166.06	EL. 163.15 EL. 165.81	EL. 163.04 EL. 165.56					

Filename: ... \192_Profile_195NBCash_02.dgn

Scale:
 Horizontal: 1" = 25'
 Vertical: 1" = 5'

No.	Revision	By	Date


Designed by:

JACOBS

CONSULTANT PROJECT MANAGER: T. MORIN

Designed	By	Date	Checked	By	Date
	CSM	7-18		RRP	7-18
Drawn	By	Date	In Charge of	By	Date
	SMG	7-18		TWM	7-18

JACOBS ENGINEERING GROUP
 120 ST. JAMES AVENUE
 BOSTON, MA 02116
 TEL (617) 242-9222
 FAX (617) 242-9824



THE GOLD STAR
MEMORIAL HIGHWAY

MTA PROJECT MANAGER: R. NORWOOD


YORK TOLL PLAZA

I-95 NORTHBOUND CASH PROFILE 2

SHEET NUMBER: PR-26
 CONTRACT: 2018.20
 192 OF 489

Date: 8/28/2018

Filename: ... \193_Profile_195NBCash_03.dgn

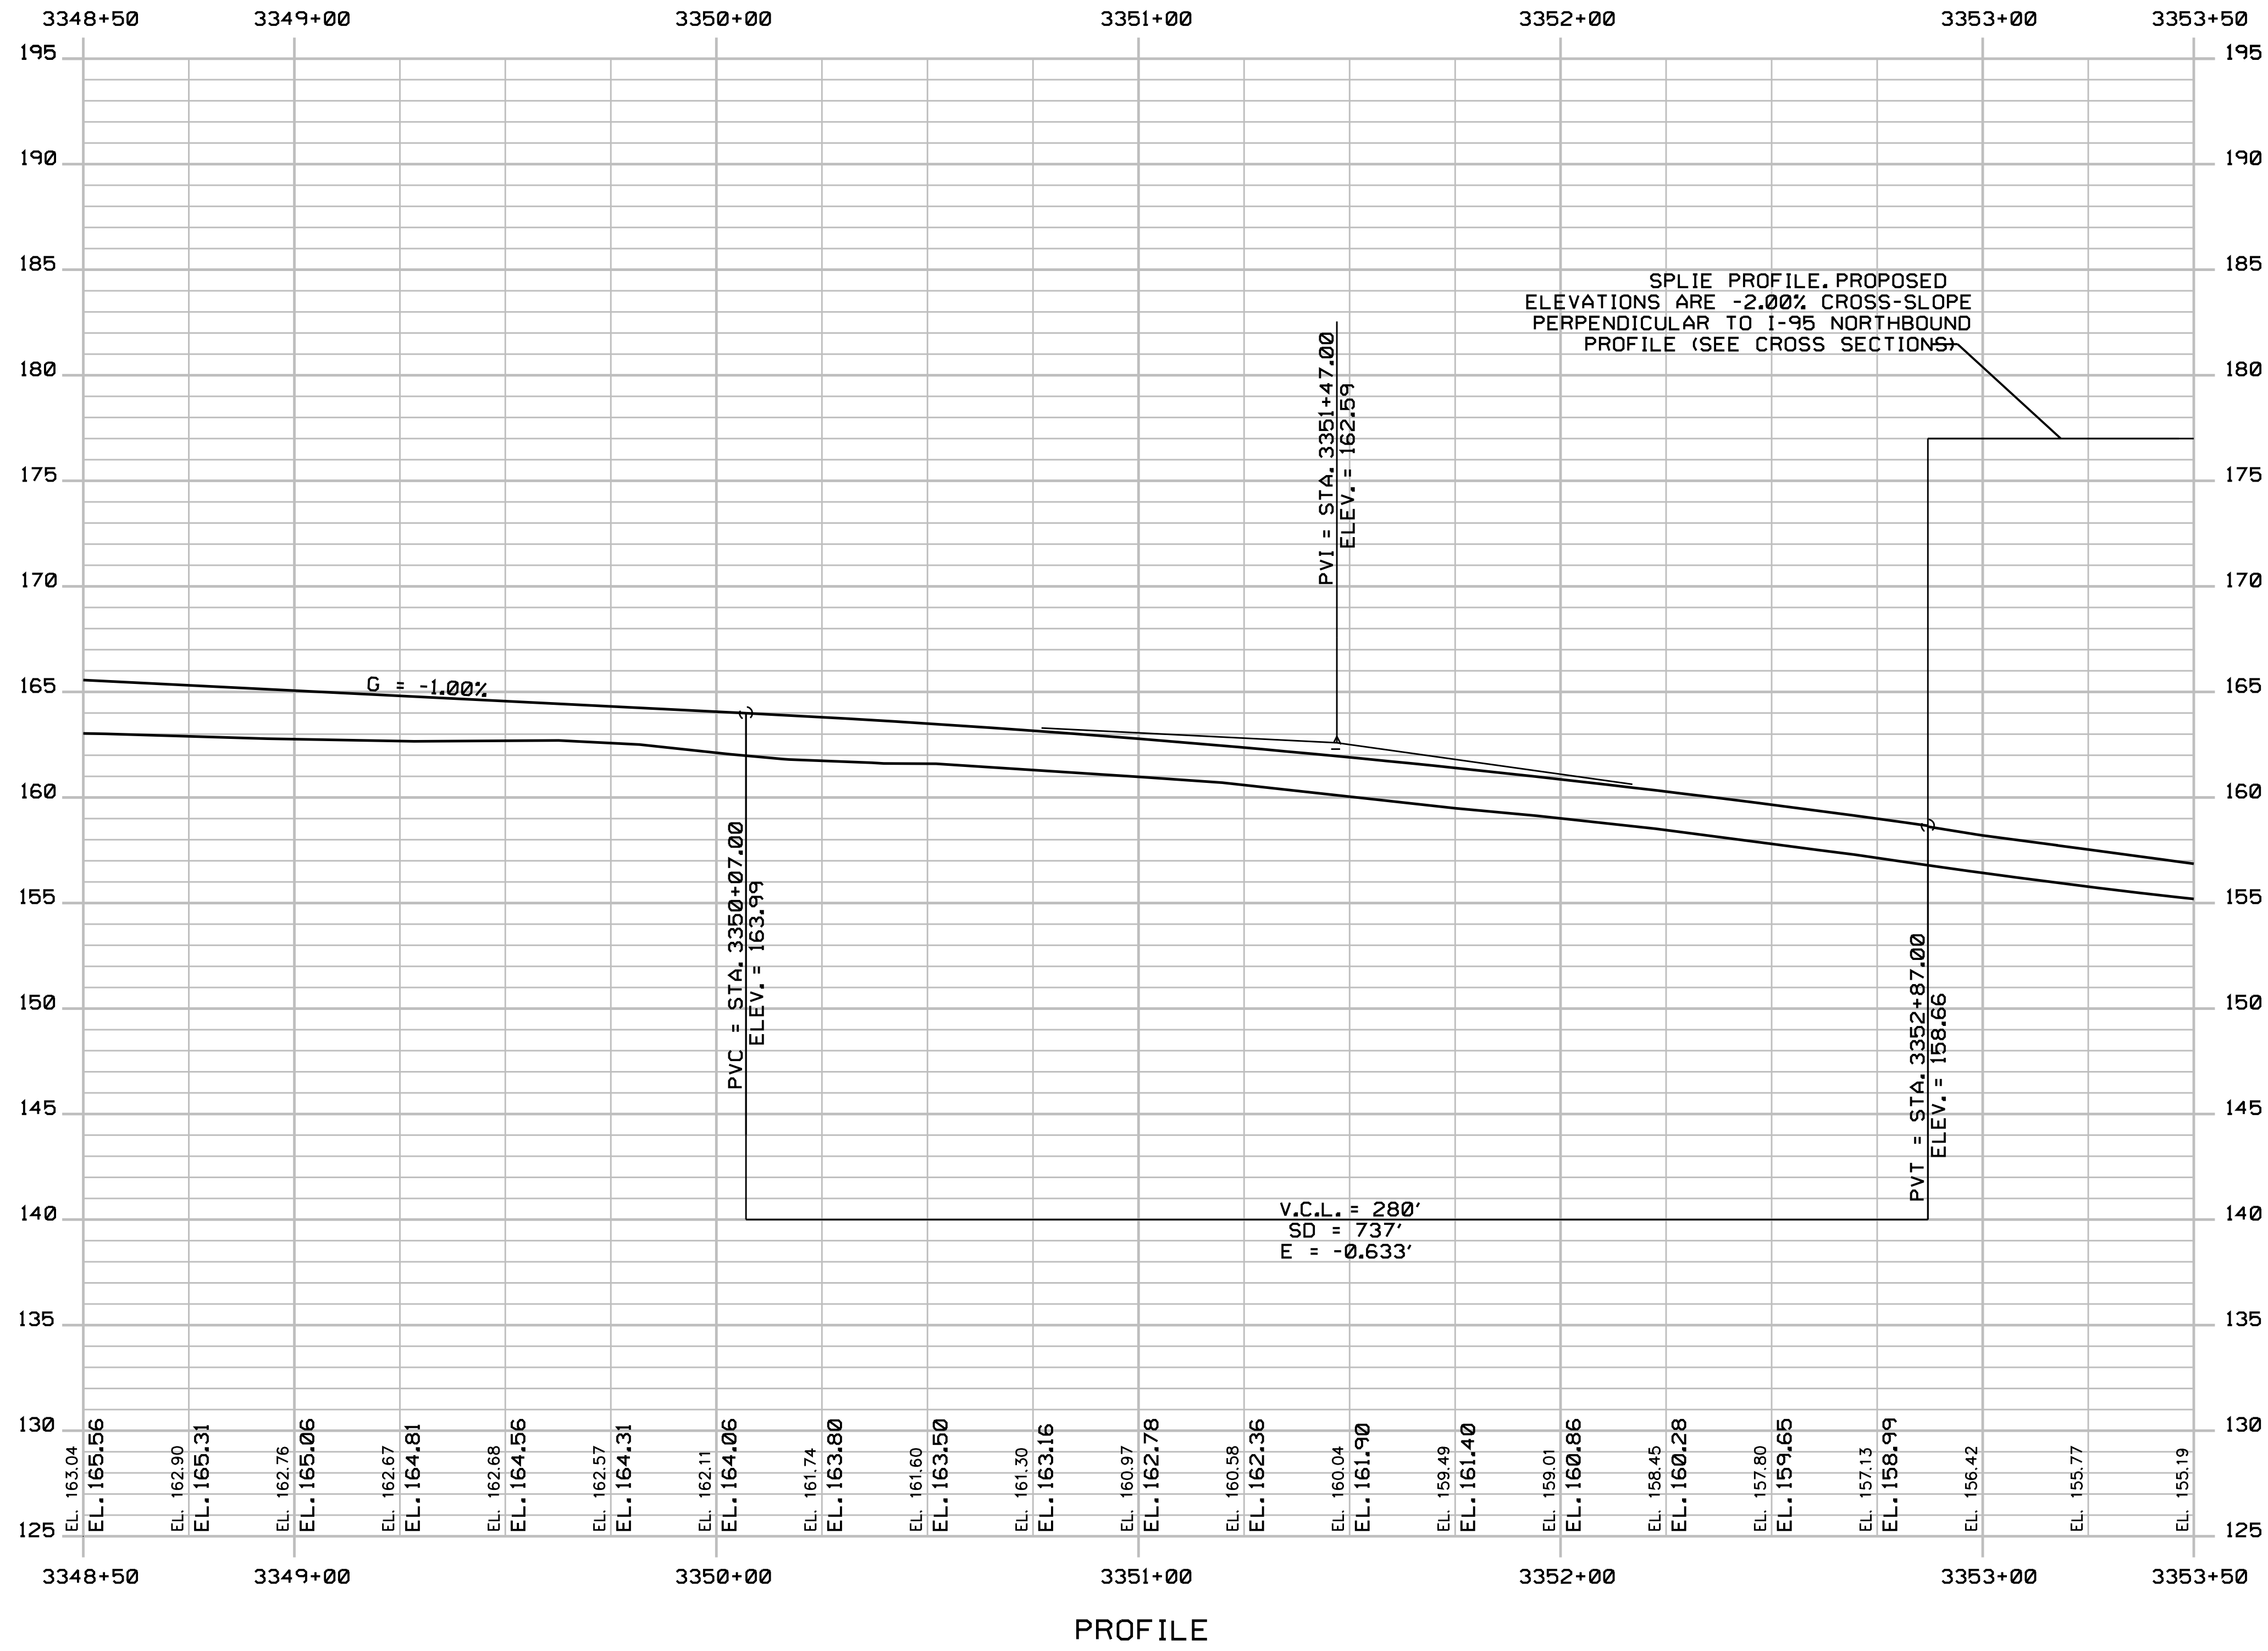

Scale:
 Horiz 25
 Vert 5
 Scale of Feet

No.	Revision	By	Date


Designed by:

JACOBS

CONSULTANT PROJECT MANAGER: T. MORIN

	By	Date		By	Date
Designed	CSM	7-18	Checked	RRP	7-18
Drawn	SMG	7-18	In Charge of	TWM	7-18

JACOBS ENGINEERING GROUP
 120 ST. JAMES AVENUE
 BOSTON, MA 02116
 TEL (617) 242-9222
 FAX (617) 242-9824



 THE GOLD STAR
 MEMORIAL HIGHWAY

MTA PROJECT MANAGER: R. NORWOOD

YORK TOLL PLAZA

I-95 NORTHBOUND CASH PROFILE 3


SHEET NUMBER: PR-27

CONTRACT: 2018.20

193 OF 489

Date: 8/28/2018

Filename: ... \194_Profile_195SBCash_01.dgn

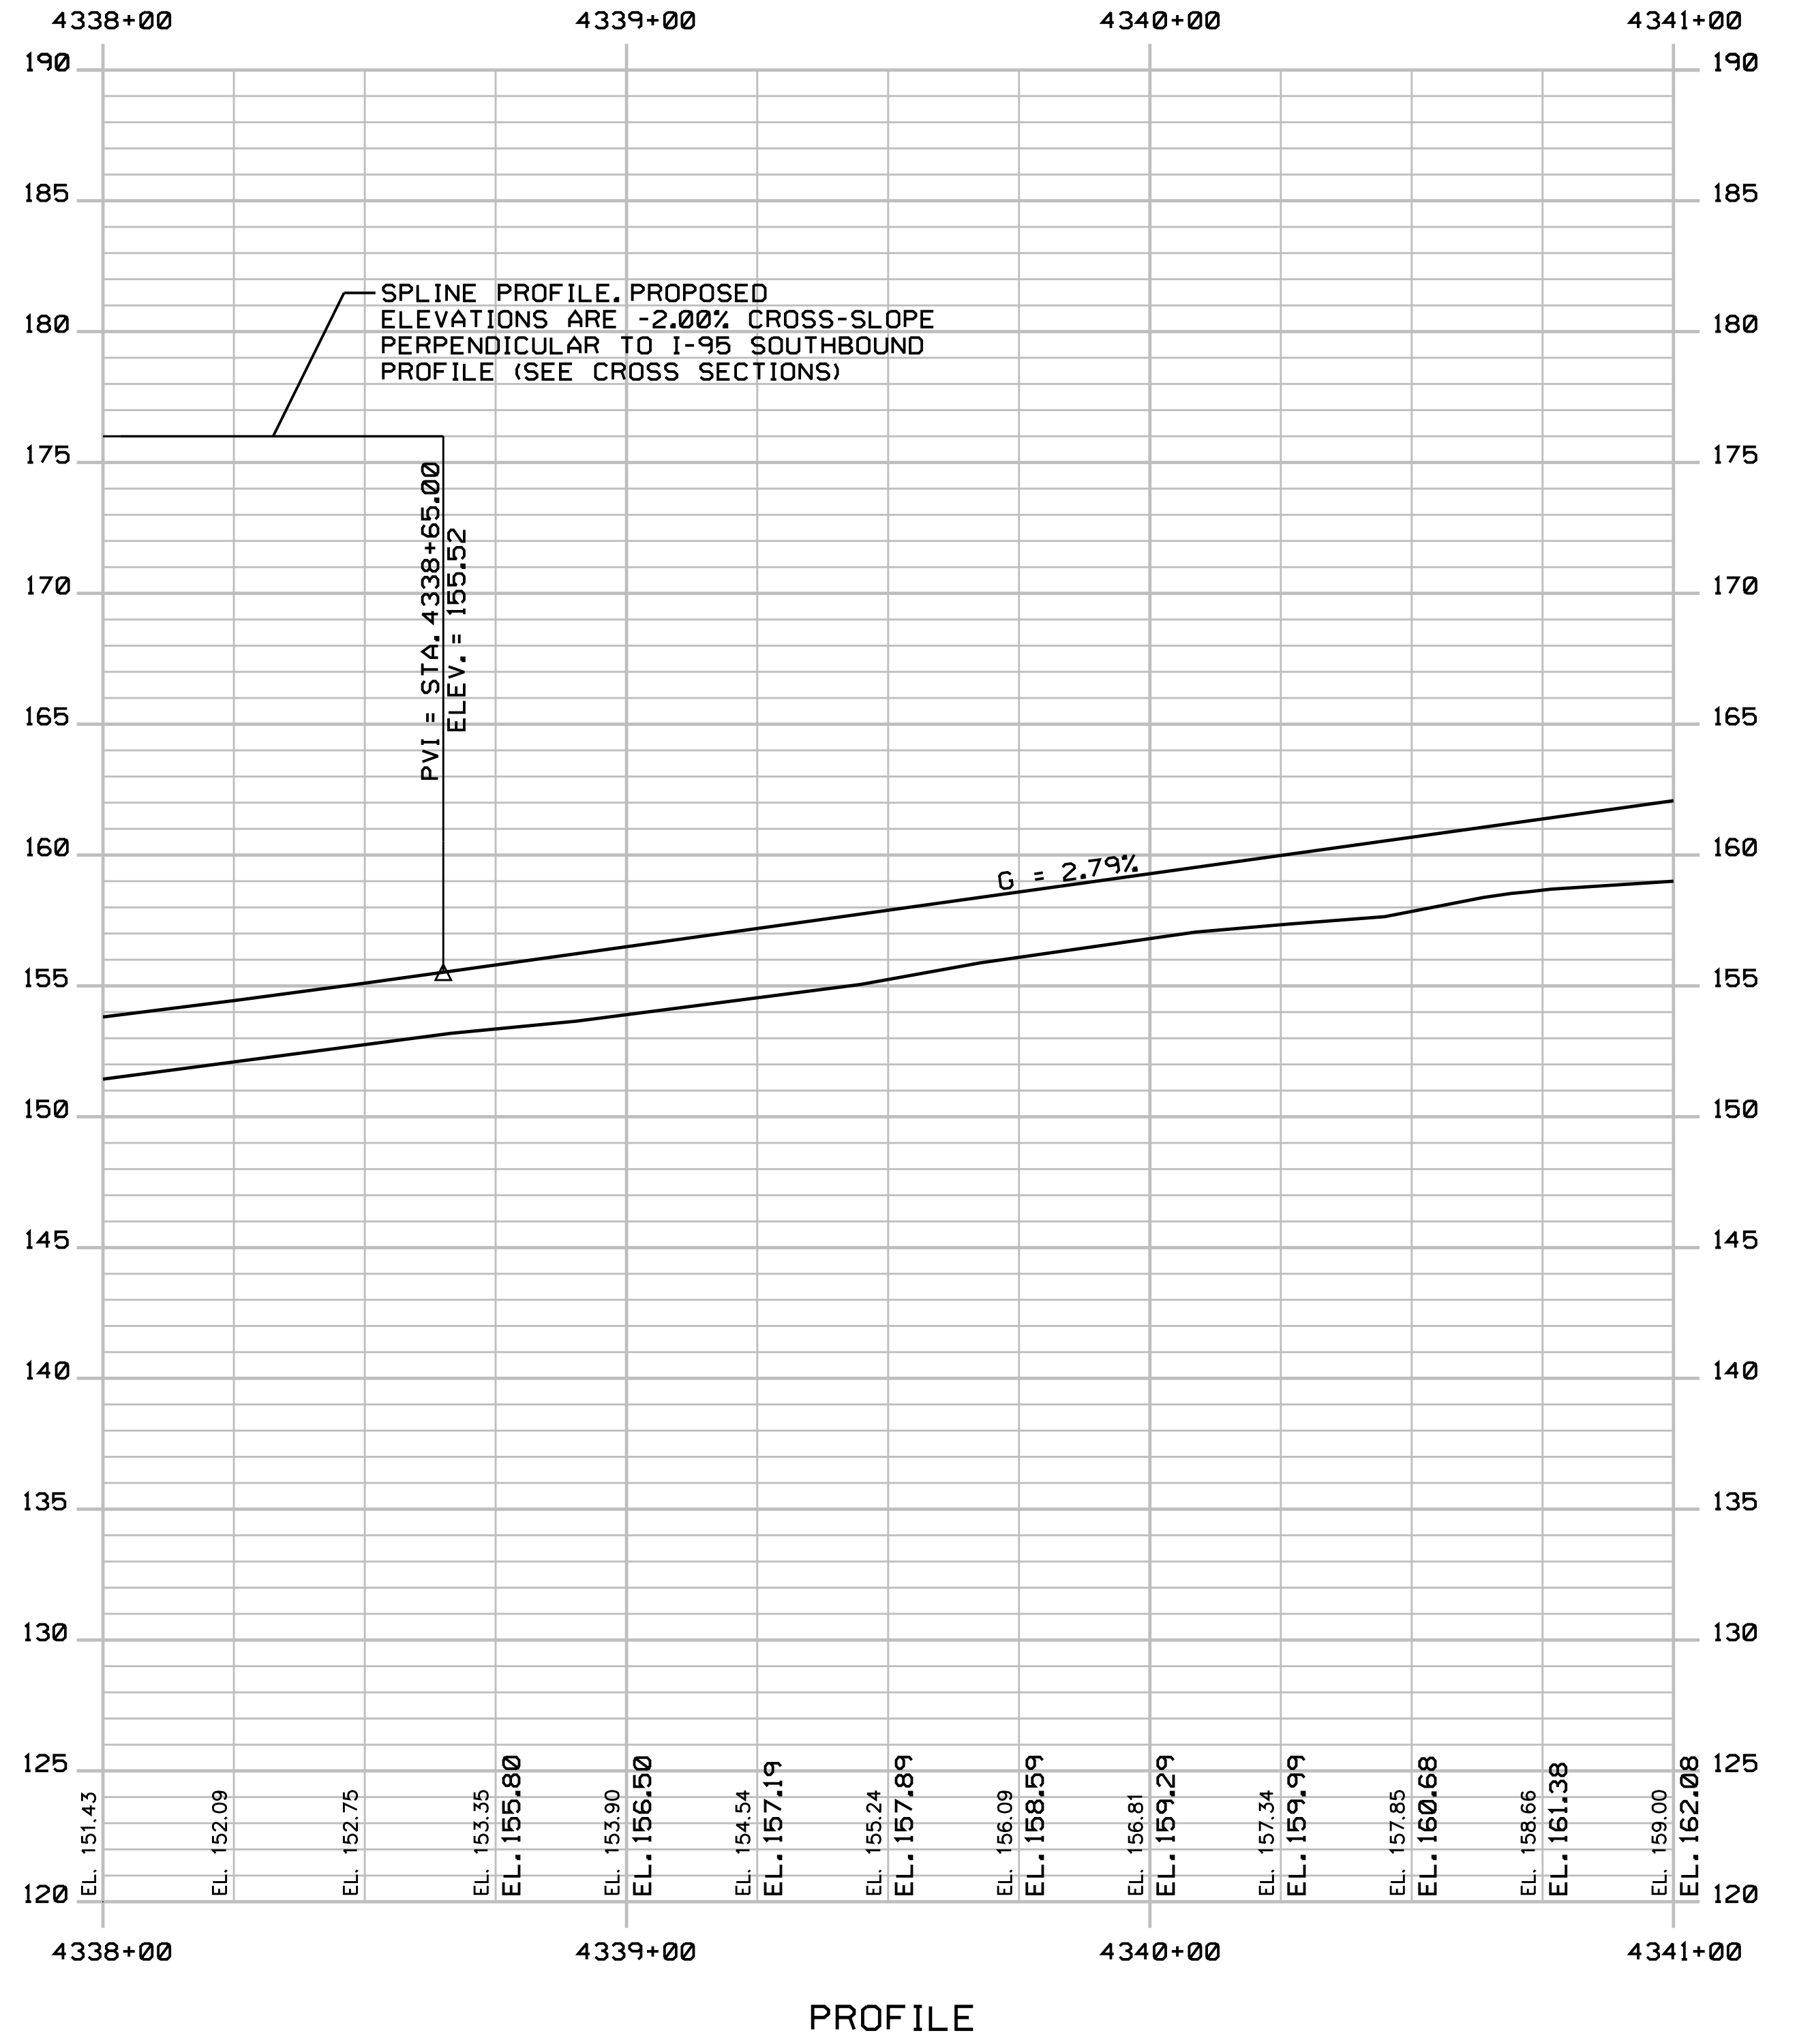

Scale:
 Horiz 25
 Vert 5

Scale of Feet

No.	Revision	By	Date

Designed by:

JACOBS

CONSULTANT PROJECT MANAGER: T. MORIN

	By	Date		By	Date
Designed	CSM	7-18	Checked	RRP	7-18
Drawn	SMG	7-18	In Charge of	TWM	7-18

JACOBS ENGINEERING GROUP
 120 ST. JAMES AVENUE
 BOSTON, MA 02116
 TEL (617) 242-9222
 FAX (617) 242-9824

MAINE TURNPIKE

THE GOLD STAR
 MEMORIAL HIGHWAY

MTA PROJECT MANAGER: R. NORWOOD

YORK TOLL PLAZA

I-95 SOUTHBOUND CASH PROFILE 1


SHEET NUMBER: PR-28

CONTRACT: 2018.20

194 OF 489

Date: 8/28/2018

Filename: ... \195_Profile_195SBCash_02.dgn

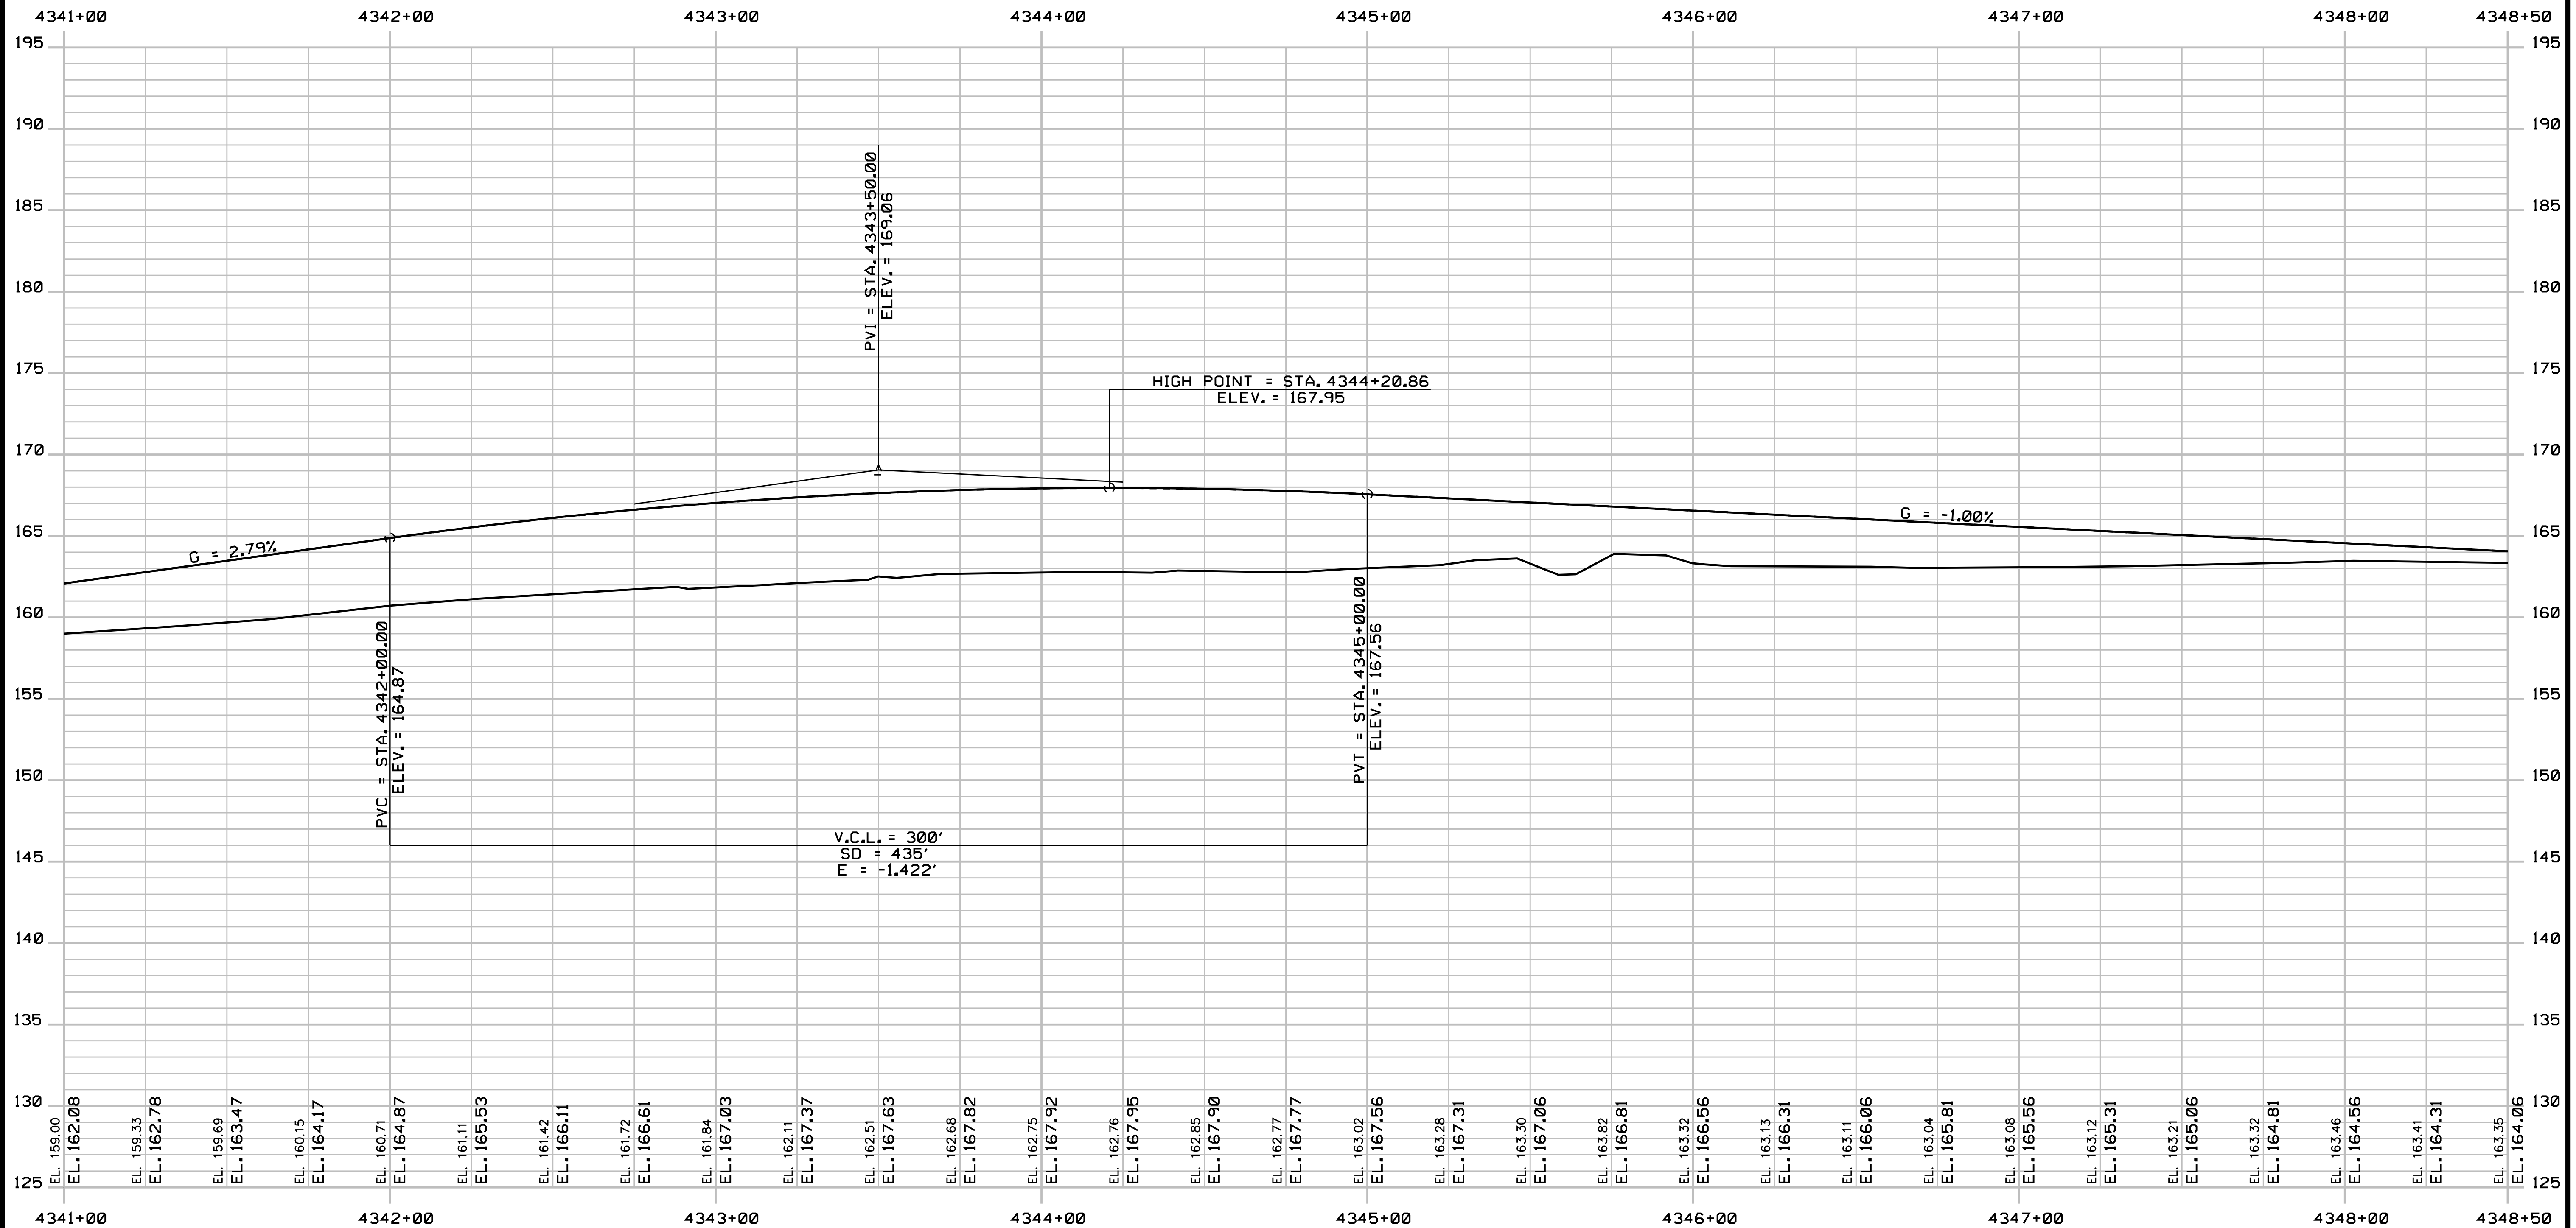

4341+00 4342+00 4343+00 4344+00 4345+00 4346+00 4347+00 4348+00 4348+50

Scale:
 Horizontal: 0 25 50
 Vertical: 0 5 10
 Scale of Feet

No.	Revision	By	Date

Designed by:

JACOBS

CONSULTANT PROJECT MANAGER: T. MORIN

	By	Date		By	Date
Designed	CSM	7-18	Checked	RRP	7-18
Drawn	SMG	7-18	In Charge of	TWM	7-18

JACOBS ENGINEERING GROUP
 120 ST. JAMES AVENUE
 BOSTON, MA 02116
 TEL (617) 242-9222
 FAX (617) 242-9824

MAINE TURNPIKE

THE GOLD STAR
 MEMORIAL HIGHWAY

MTA PROJECT MANAGER: R. NORWOOD

YORK TOLL PLAZA


I-95 SOUTHBOUND CASH PROFILE 2

SHEET NUMBER: PR-29

CONTRACT: 2018.20

195 OF 489

Date: 8/28/2018

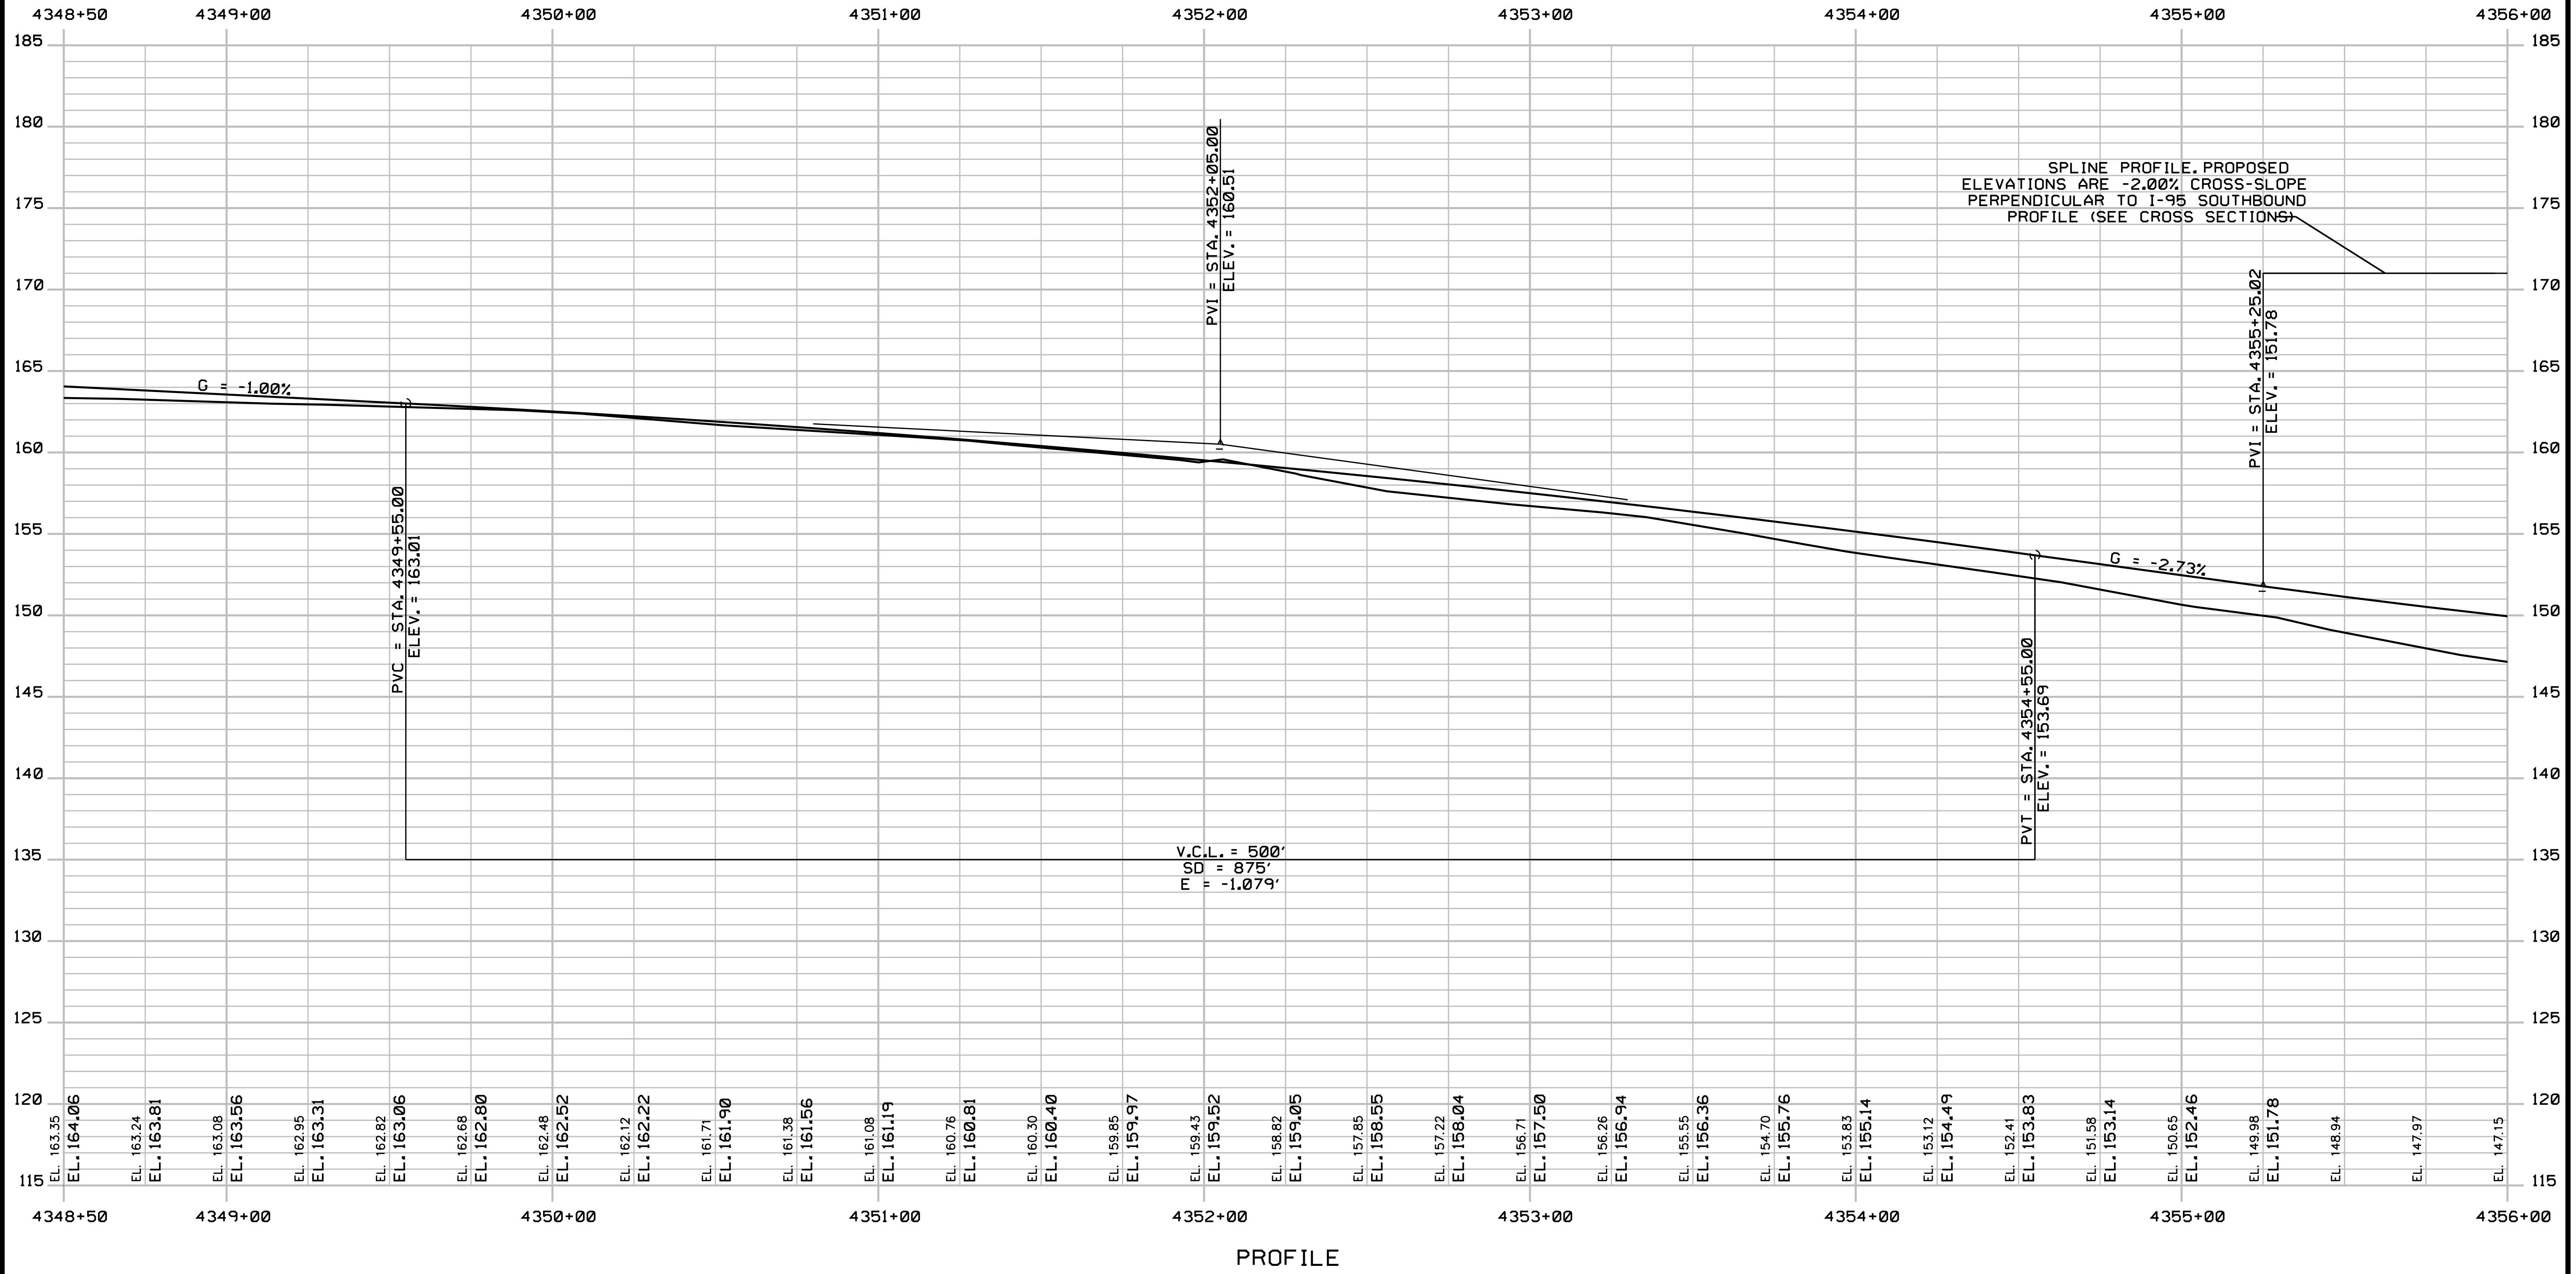

SPLINE PROFILE, PROPOSED
ELEVATIONS ARE -2.00% CROSS-SLOPE
PERPENDICULAR TO I-95 SOUTHBOUND
PROFILE (SEE CROSS SECTIONS)

Filename: ... \196_Profile_195SBCash_03.dgn

Scale:
 Horizontal: 1" = 25'
 Vertical: 1" = 5'

No.	Revision	By	Date


Designed by:

JACOBS

CONSULTANT PROJECT MANAGER: T. MORIN

	By	Date		By	Date
Designed	CSM	7-18	Checked	RRP	7-18
Drawn	SMG	7-18	In Charge of	TWM	7-18

JACOBS ENGINEERING GROUP
 120 ST. JAMES AVENUE
 BOSTON, MA 02116
 TEL (617) 242-9222
 FAX (617) 242-9824



THE GOLD STAR
MEMORIAL HIGHWAY

MTA PROJECT MANAGER: R. NORWOOD

YORK TOLL PLAZA


I-95 SOUTHBOUND CASH PROFILE 3

SHEET NUMBER: PR-30
196 OF 489

CONTRACT: 2018.20

Date: 8/28/2018

Filename: ... \197_Profile_AccessRd_01.dgn

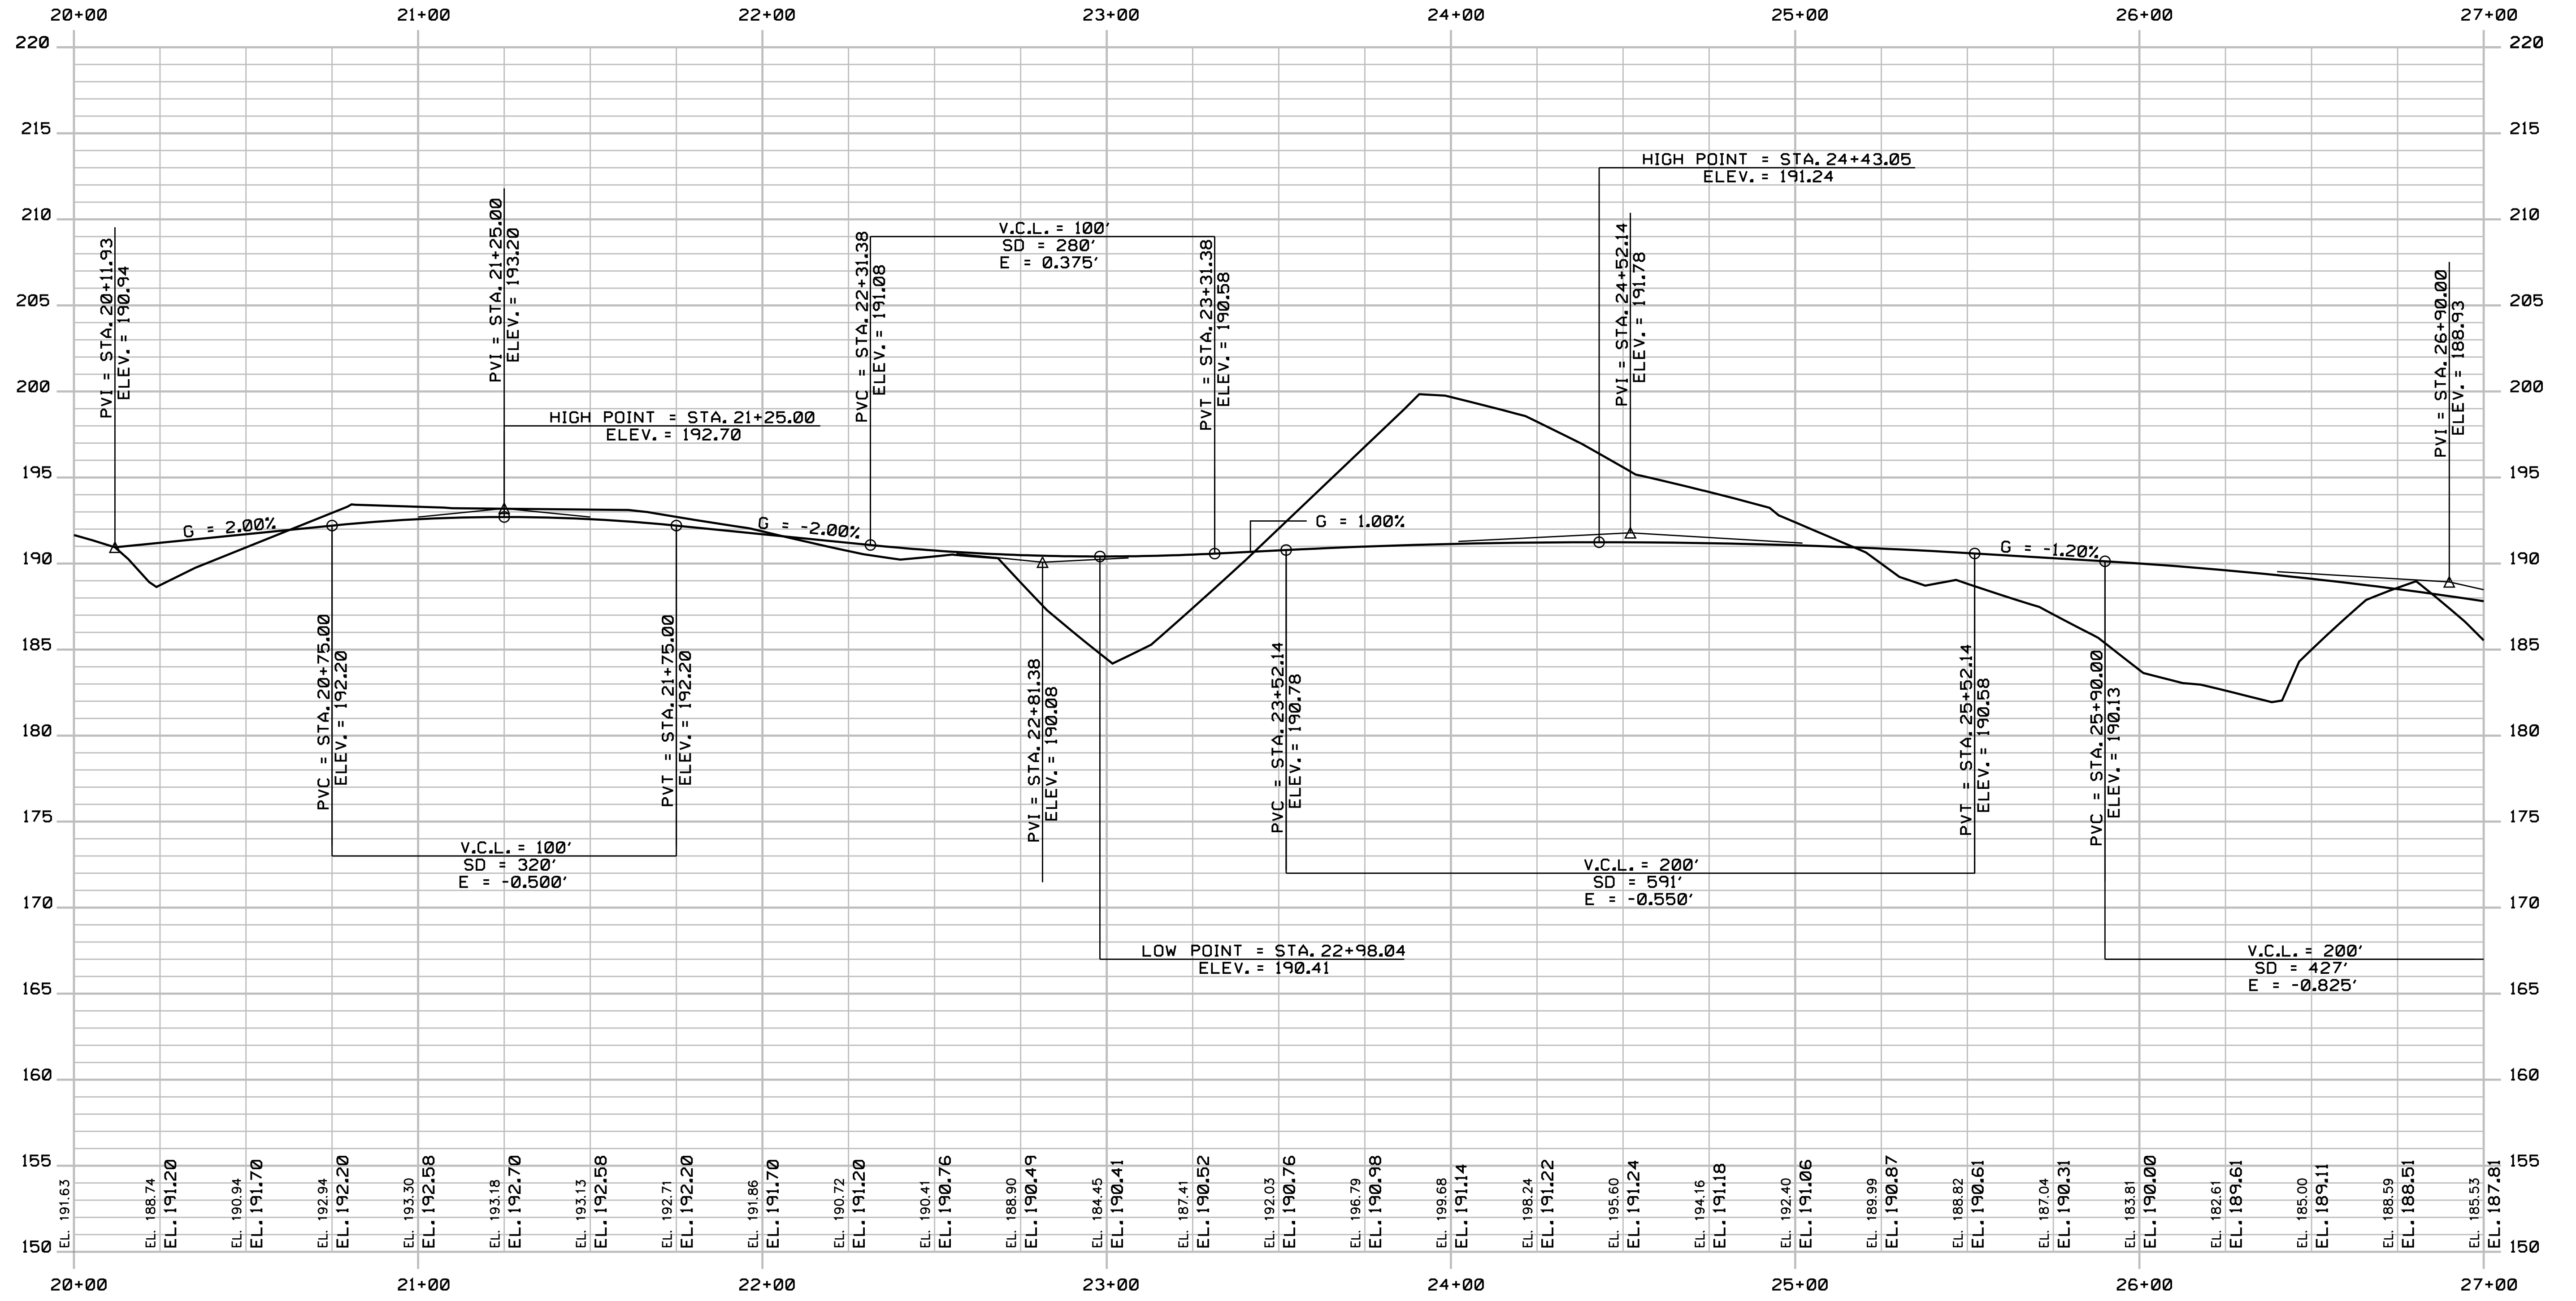

PROFILE

Scale:
 Horiz 25
 Vert 5
 Scale of Feet

No.	Revision	By	Date

Designed by:

JACOBS

CONSULTANT PROJECT MANAGER: T. MORIN

	By	Date		By	Date
Designed	CSM	7-18	Checked	RRP	7-18
Drawn	SMG	7-18	In Charge of	TWM	7-18

JACOBS ENGINEERING GROUP
 120 ST. JAMES AVENUE
 BOSTON, MA 02116
 TEL (617) 242-9222
 FAX (617) 242-9824

MAINE TURNPIKE


THE GOLD STAR MEMORIAL HIGHWAY

MTA PROJECT MANAGER: R. NORWOOD

YORK TOLL PLAZA
 ACCESS ROAD PROFILE 1

SHEET NUMBER: PR-31
 CONTRACT: 2018.20
 197 OF 489

Date: 8/28/2018

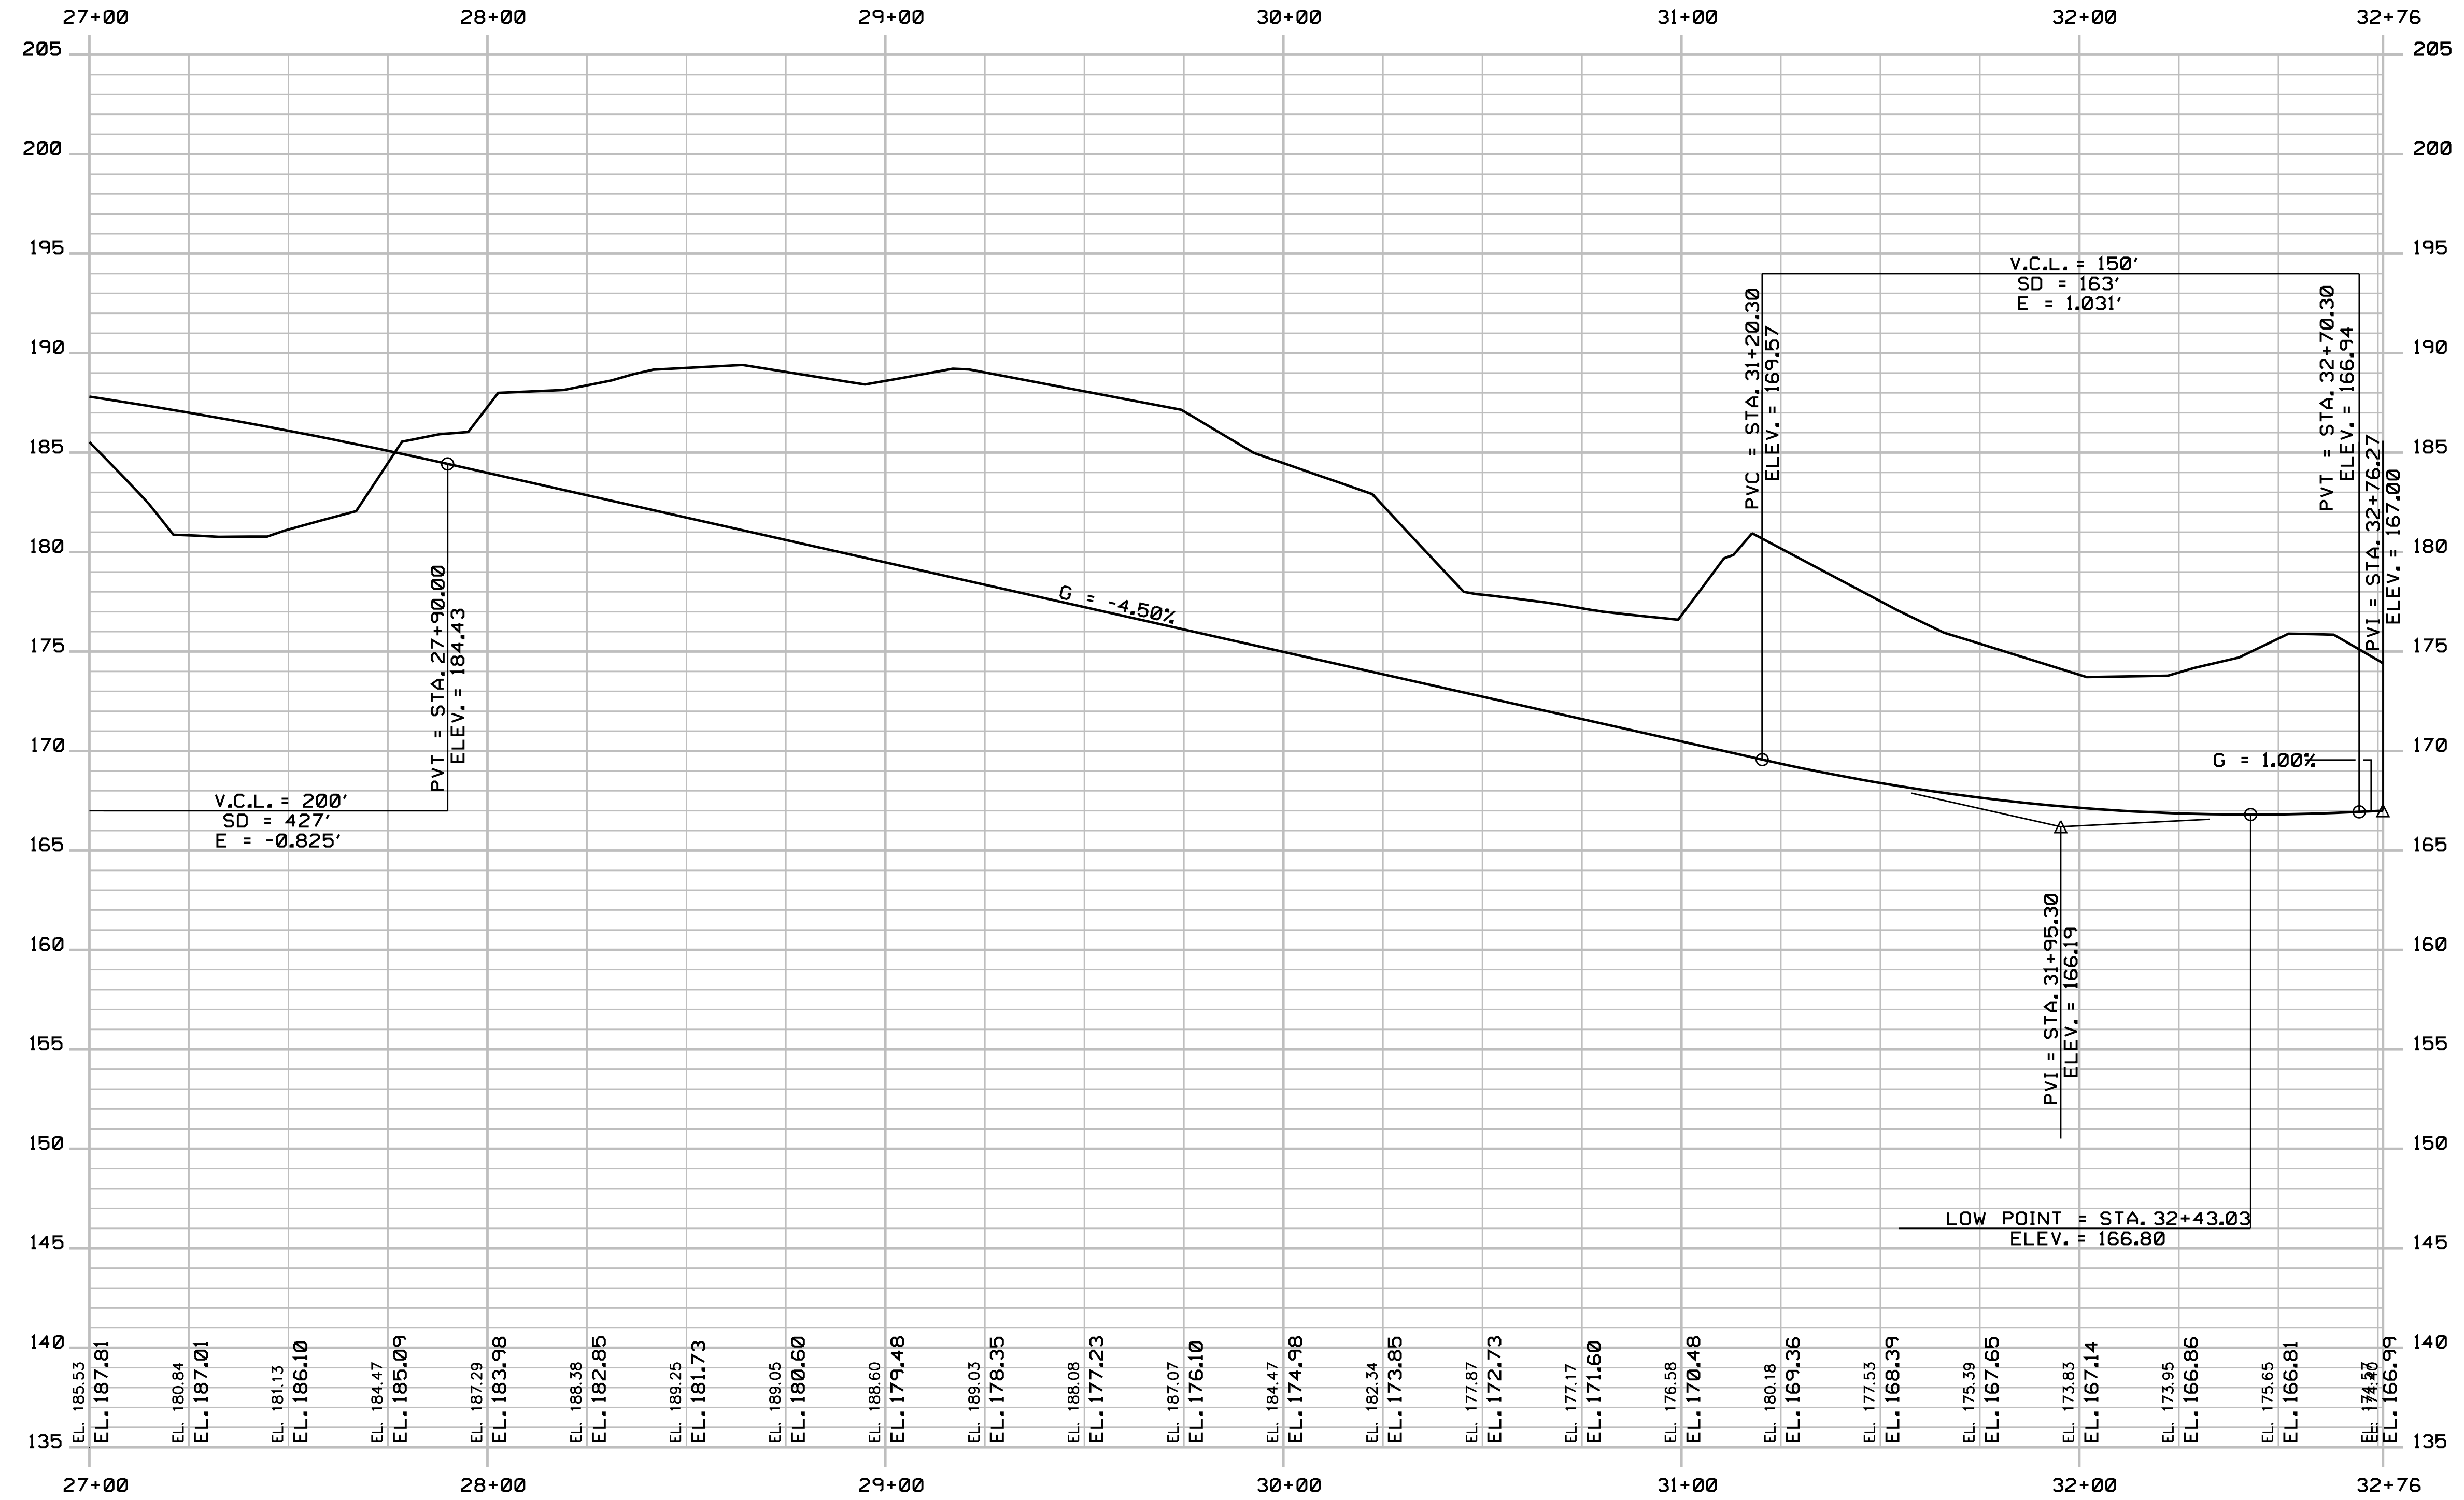

PROFILE

Filename: ... \198_Profile_AccessRd_02.dgn

Scale:
 Horiz 25
 Vert 5
 Scale of Feet

No.	Revision	By	Date

Designed by:

JACOBS

CONSULTANT PROJECT MANAGER: T. MORIN

	By	Date		By	Date
Designed	CSM	7-18	Checked	RRP	7-18
Drawn	SMG	7-18	In Charge of	TWM	7-18

JACOBS ENGINEERING GROUP
 120 ST. JAMES AVENUE
 BOSTON, MA 02116
 TEL (617) 242-9222
 FAX (617) 242-9824

THE GOLD STAR
 MEMORIAL HIGHWAY


MTA PROJECT MANAGER: R. NORWOOD

YORK TOLL PLAZA
 ACCESS ROAD PROFILE 2

SHEET NUMBER: PR-32
 CONTRACT: 2018.20
 198 OF 489

Date: 8/31/2018

Filename: ...00259637\Xsect1_195.dgn

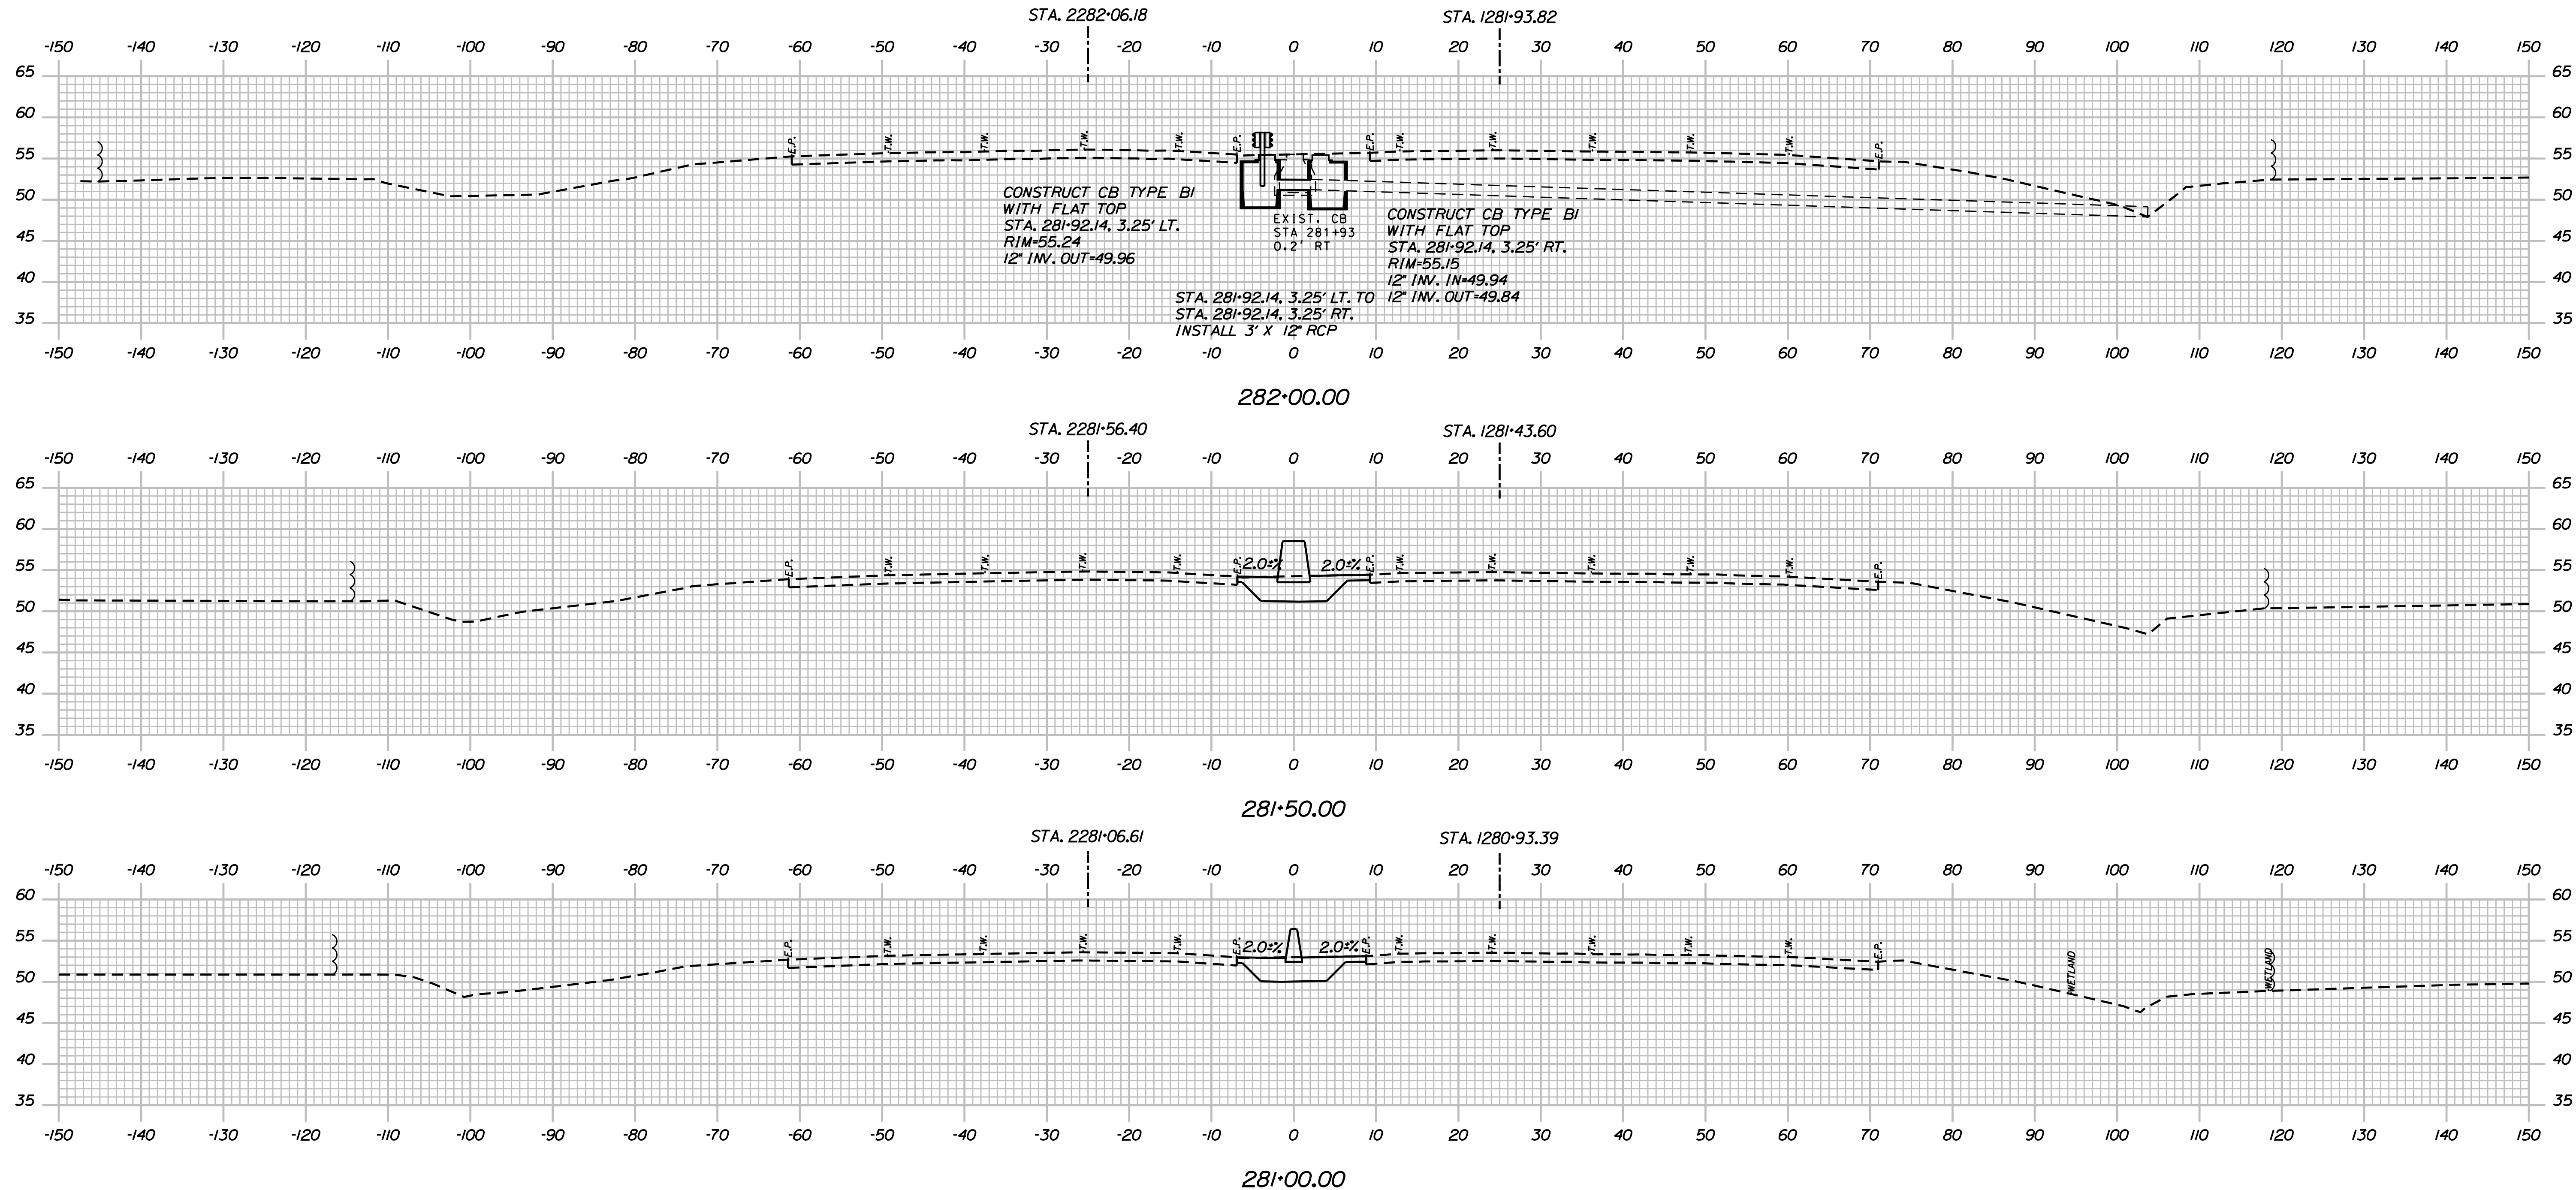

Scale:

No.	Revision	By	Date

Designed by:

JACOBS

CONSULTANT PROJECT MANAGER: T. MORIN

	By	Date		By	Date
Designed	AMS	7-18	Checked	CSM	7-18
Drawn	SMG	7-18	In Charge of	TWM	7-18

JACOBS ENGINEERING GROUP
 120 ST. JAMES AVENUE
 BOSTON, MA 02116
 TEL (617) 242-9222
 FAX (617) 242-9824

THE GOLD STAR MEMORIAL HIGHWAY

MTA PROJECT MANAGER: R. NORWOOD

YORK TOLL PLAZA

I-95 CROSS SECTIONS
 STA. 281+00 TO STA. 282+00




SHEET NUMBER: XS-01

CONTRACT: 2018.20

199 OF 489

Date: 8/28/2018

Filename: ...002596371\Xsect12_195.dgn

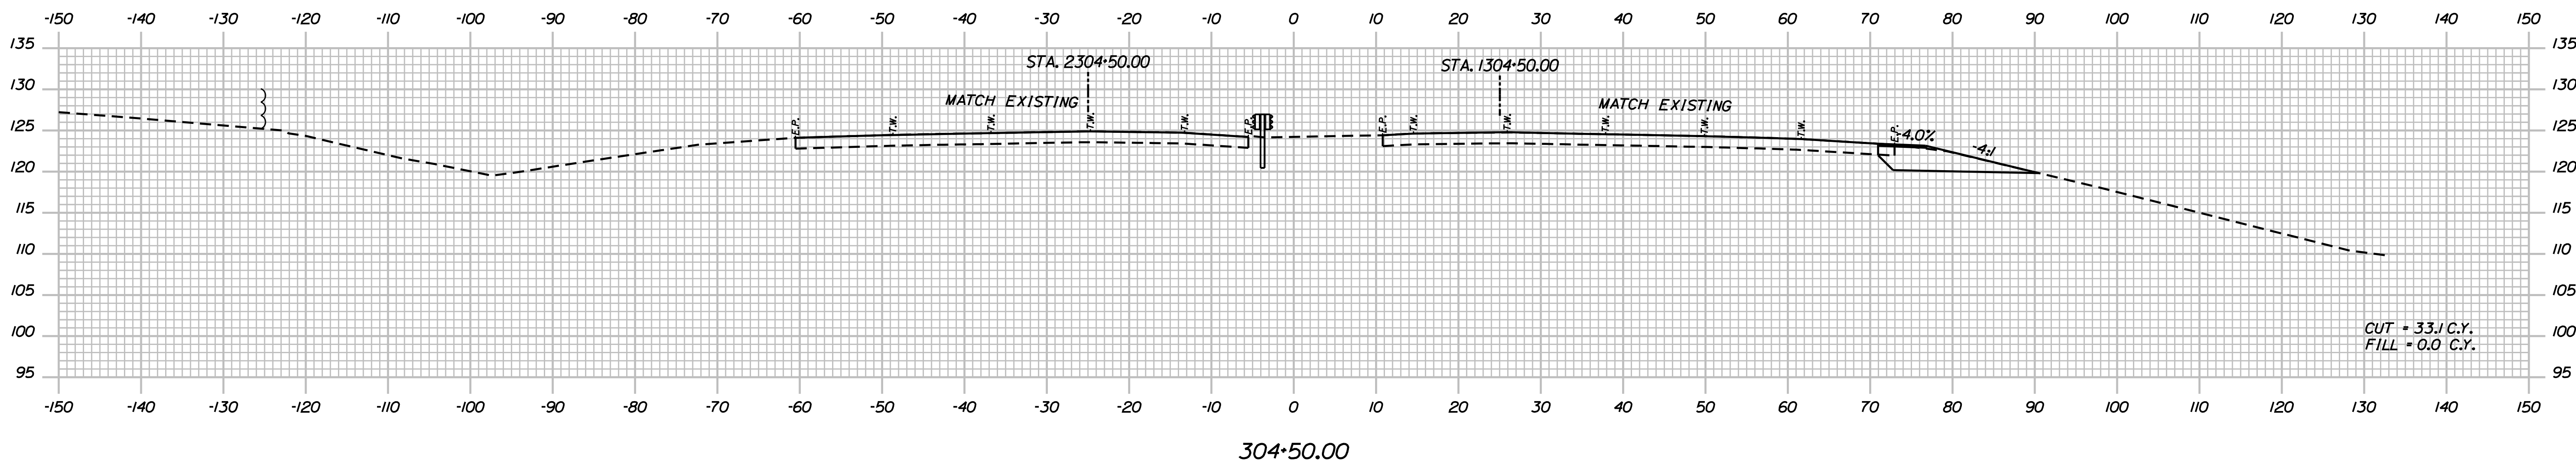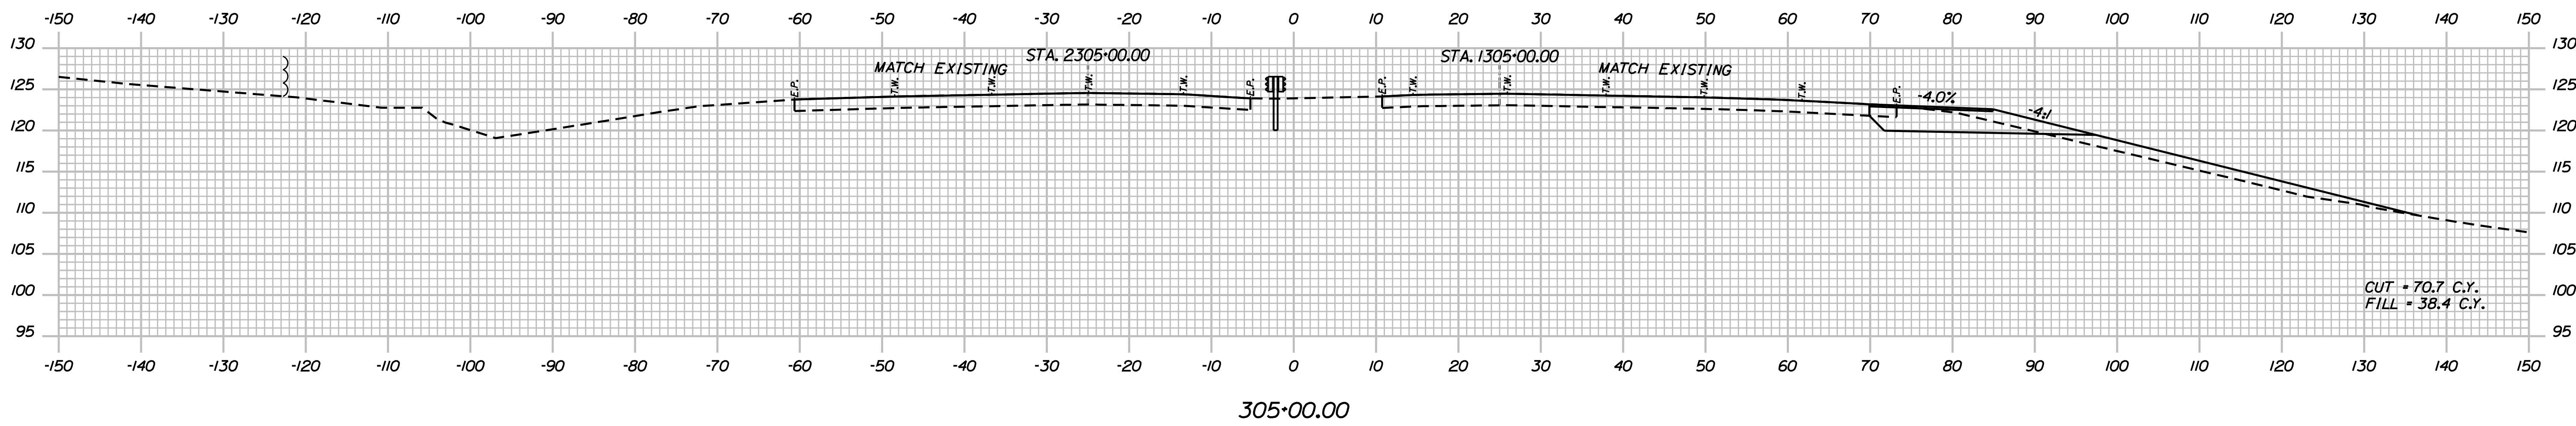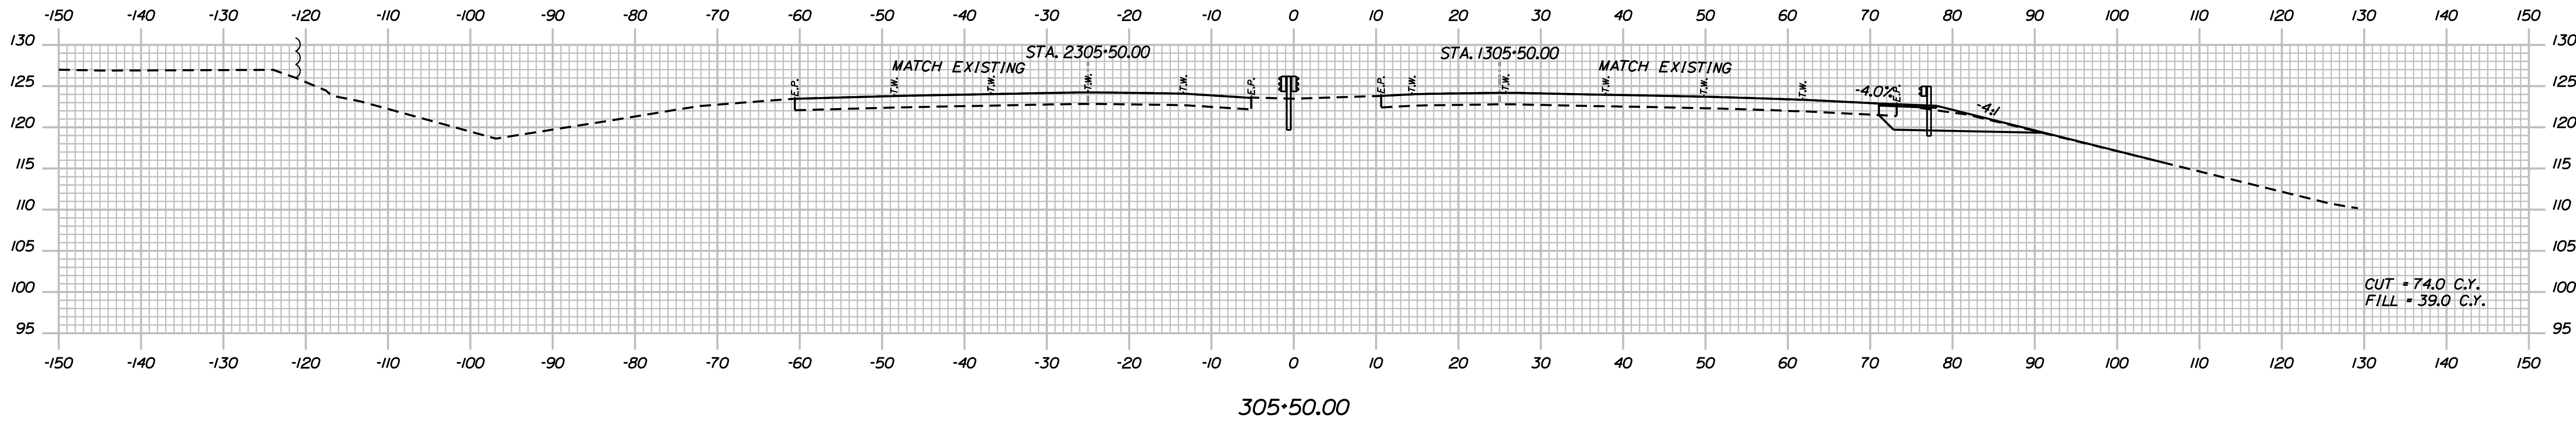

Scale: Scale of Feet

No.	Revision	By	Date

Designed by:

JACOBS

CONSULTANT PROJECT MANAGER: T. MORIN

	By	Date		By	Date
Designed	AMS	7-18	Checked	CSM	7-18
Drawn	SMG	7-18	In Charge of	TWM	7-18

JACOBS ENGINEERING GROUP
 120 ST. JAMES AVENUE
 BOSTON, MA 02116
 TEL (617) 242-9222
 FAX (617) 242-9824

**THE GOLD STAR
 MEMORIAL HIGHWAY**

MTA PROJECT MANAGER: R. NORWOOD

YORK TOLL PLAZA

I-95 CROSS SECTIONS
 STA. 304+50 TO STA. 305+50




SHEET NUMBER: XS-02

CONTRACT: 2018.20

200 OF 489

Date: 8/28/2018

Filename: ...0259637\Xsect12_195.dgn

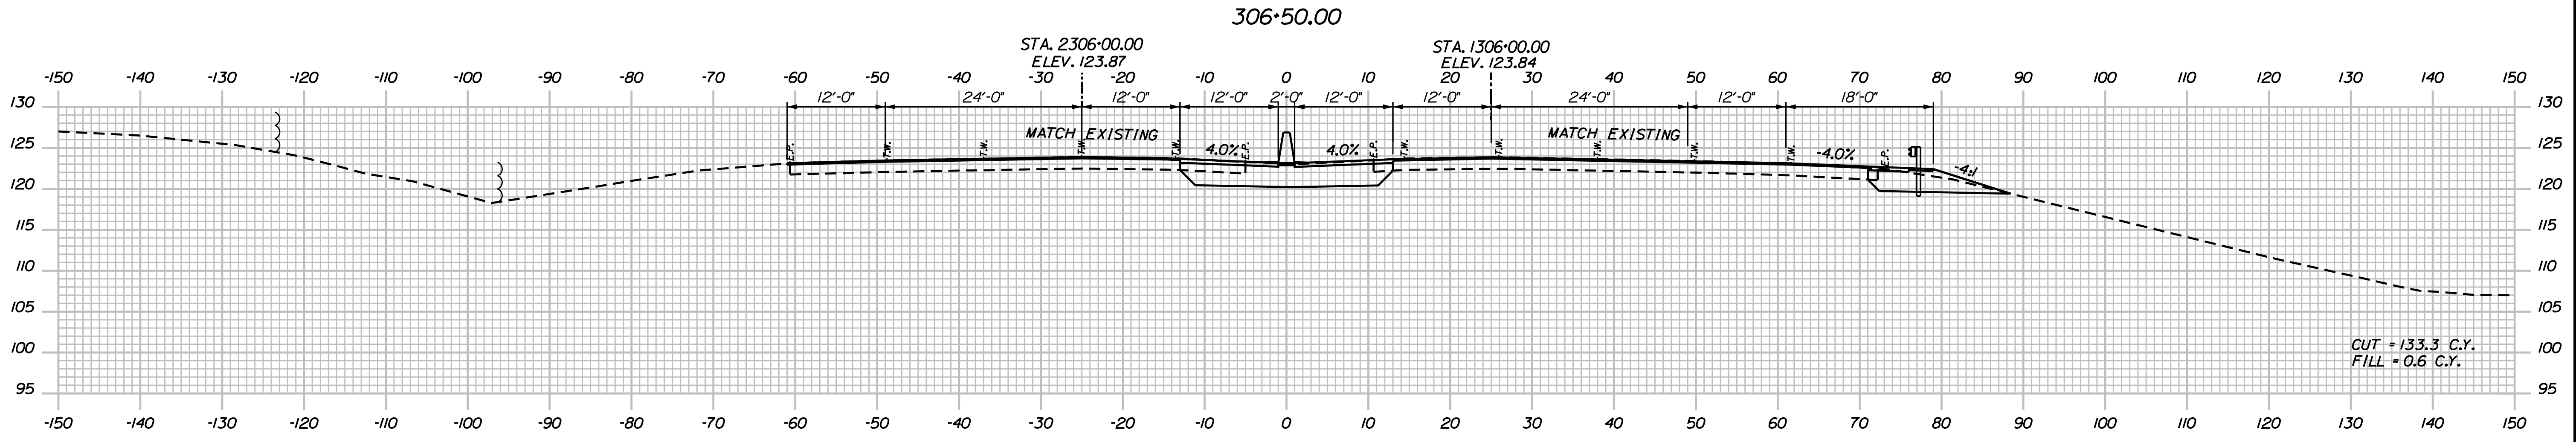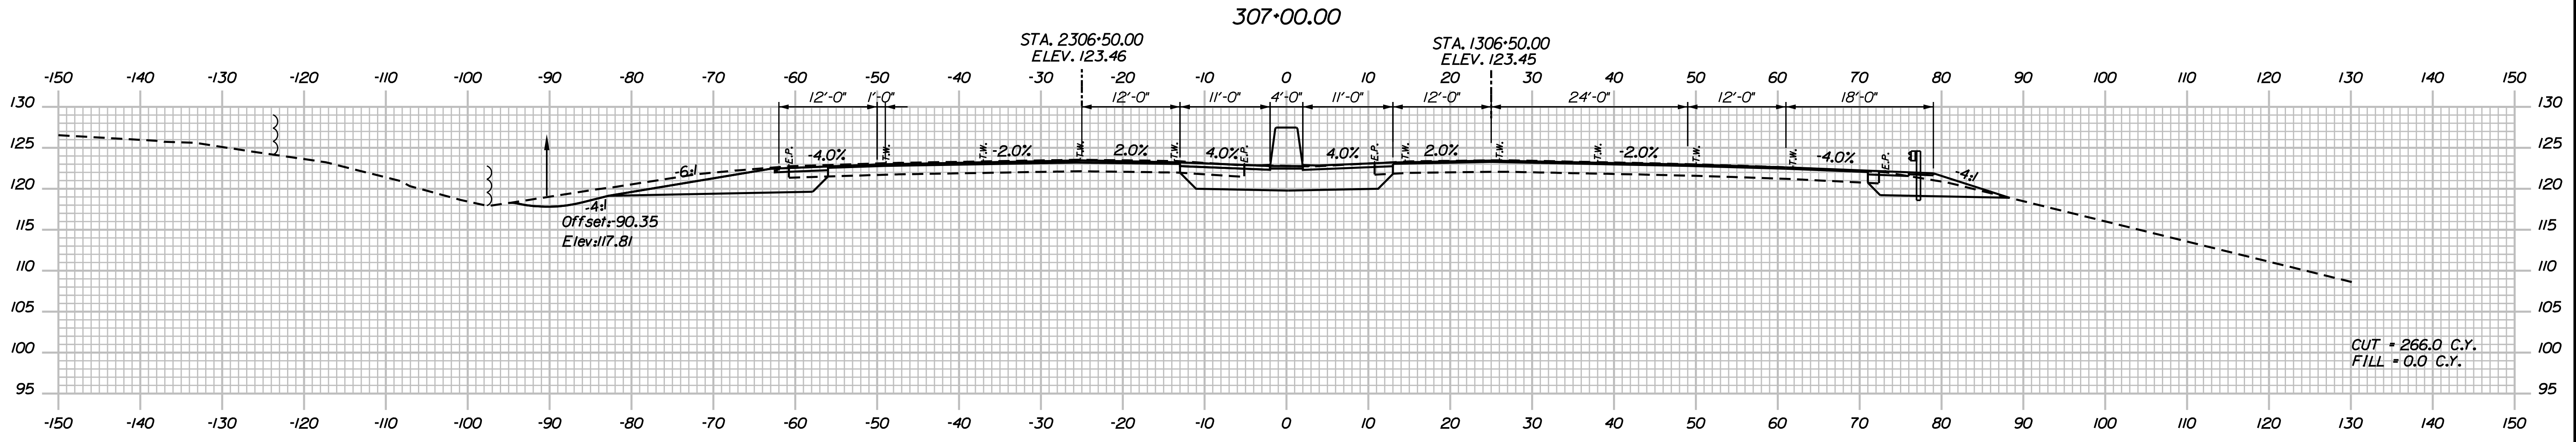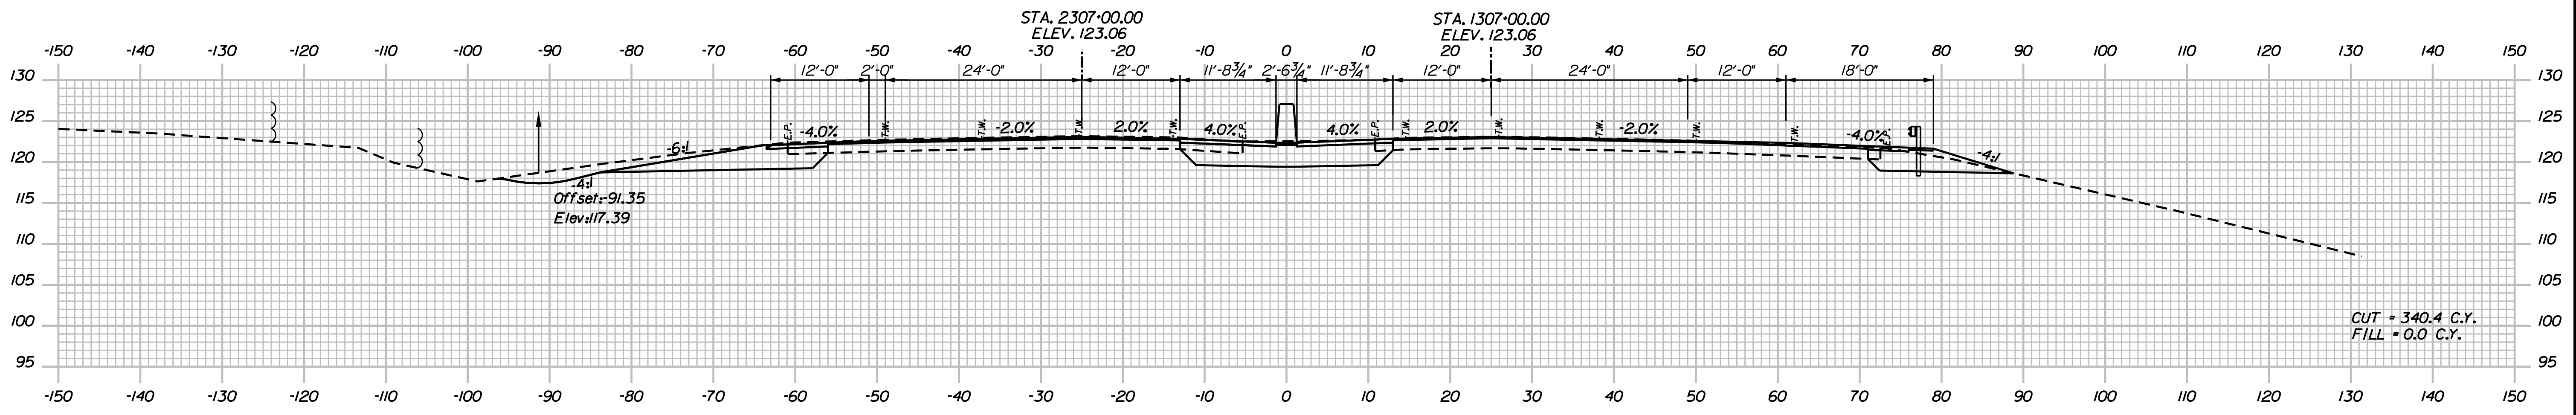

Scale: Scale of Feet

No.	Revision	By	Date

Designed by:

JACOBS

CONSULTANT PROJECT MANAGER: T. MORIN

	By	Date		By	Date
Designed	AMS	7-18	Checked	CSM	7-18
Drawn	SMG	7-18	In Charge of	TWM	7-18

JACOBS ENGINEERING GROUP
 120 ST. JAMES AVENUE
 BOSTON, MA 02116
 TEL (617) 242-9222
 FAX (617) 242-9824

MAINE TURNPIKE

THE GOLD STAR MEMORIAL HIGHWAY

MTA PROJECT MANAGER: R. NORWOOD

YORK TOLL PLAZA

I-95 CROSS SECTIONS
 STA. 306+00 TO STA. 307+00





SHEET NUMBER: XS-03

CONTRACT: 2018.20

2010F 489

Date: 8/28/2018

Filename: ...02596371\Xsect12_195.dgn

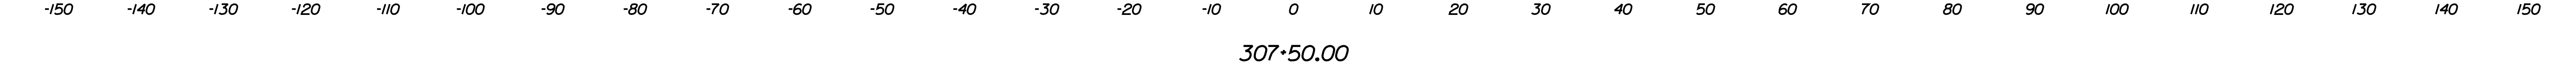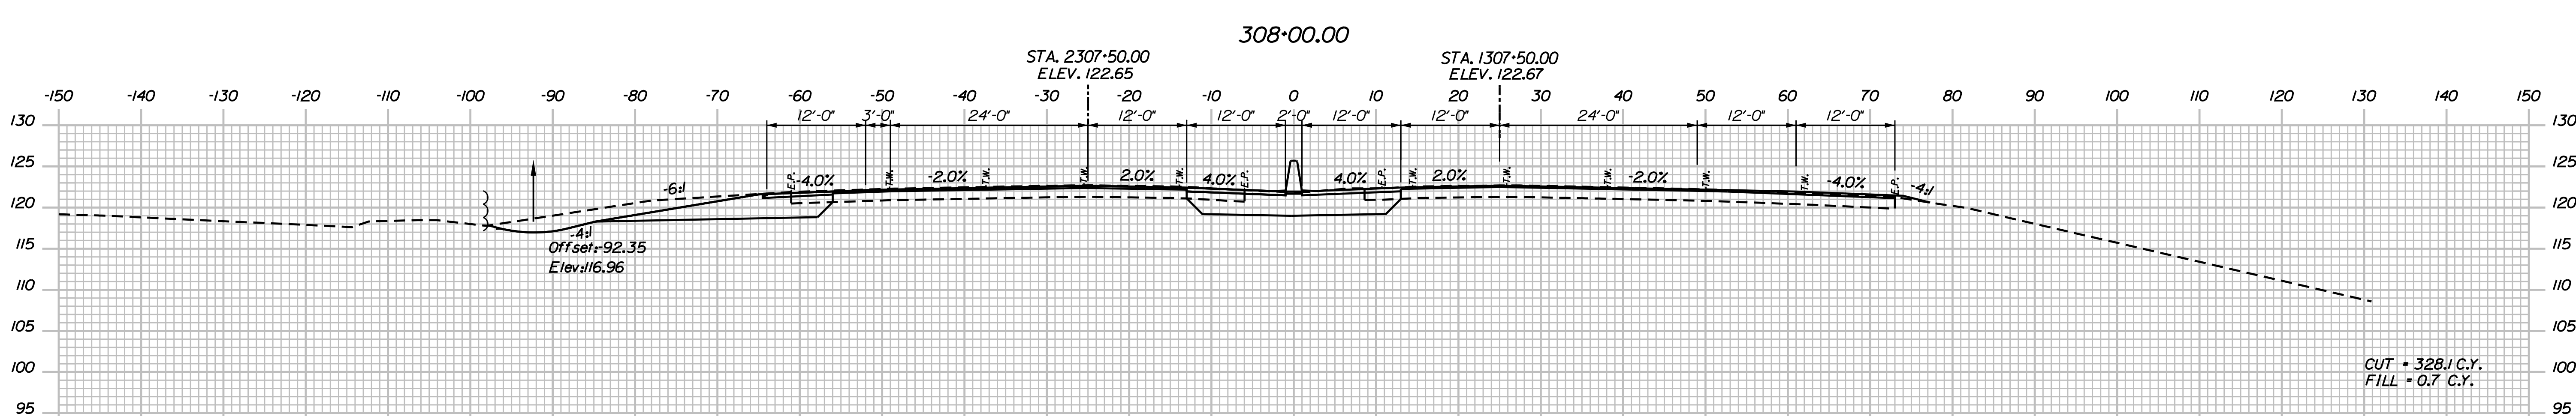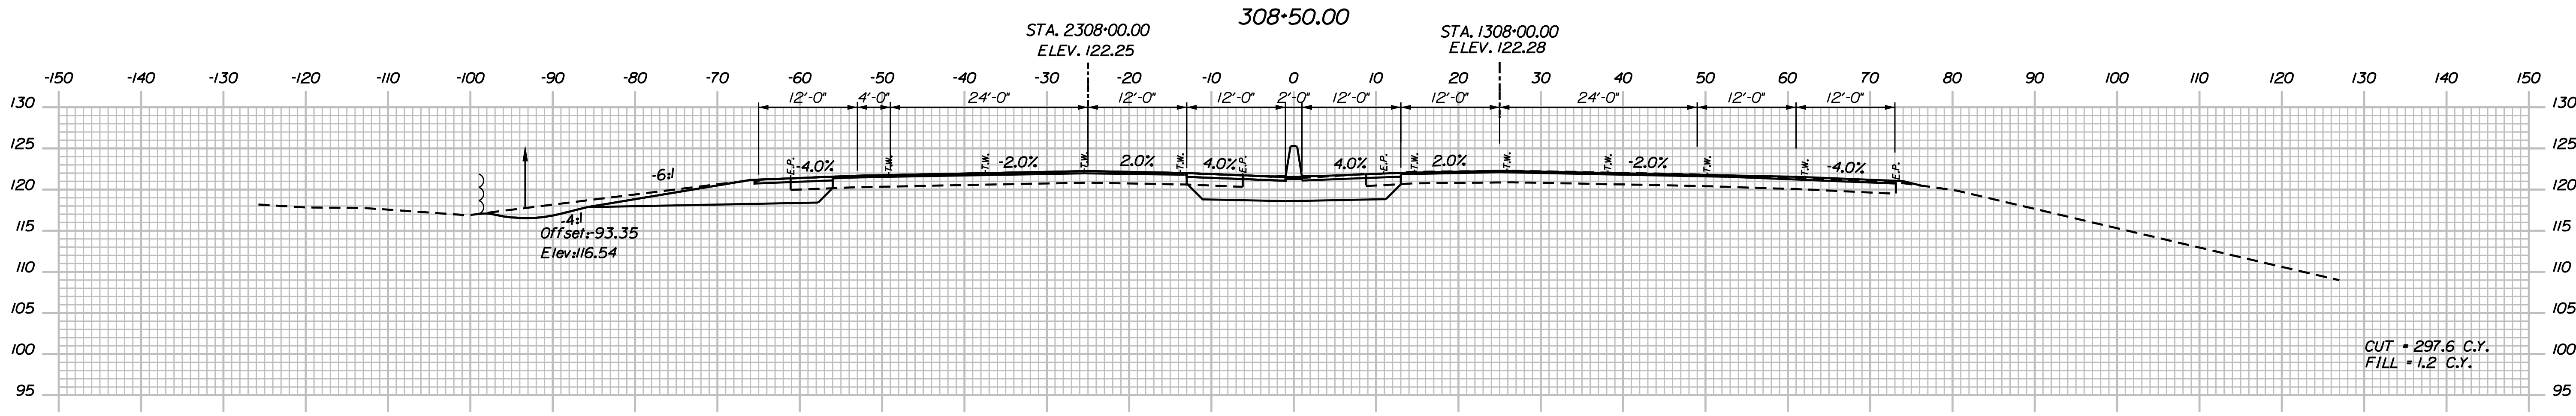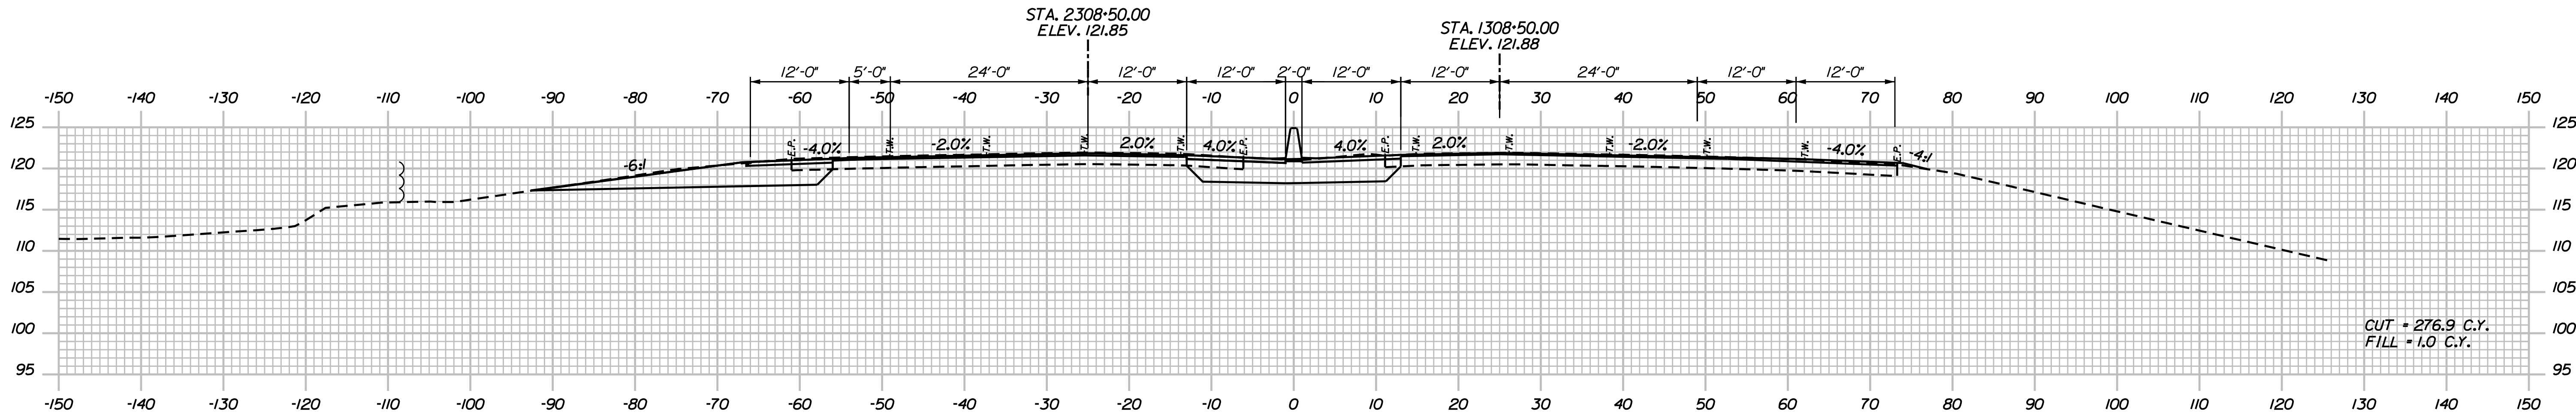

Scale: Scale of Feet

No.	Revision	By	Date

Designed by:

JACOBS

CONSULTANT PROJECT MANAGER: T. MORIN

	By	Date		By	Date
Designed	AMS	7-18	Checked	CSM	7-18
Drawn	SMG	7-18	In Charge of	TWM	7-18

JACOBS ENGINEERING GROUP
 120 ST. JAMES AVENUE
 BOSTON, MA 02116
 TEL (617) 242-9222
 FAX (617) 242-9824

THE GOLD STAR MEMORIAL HIGHWAY

MTA PROJECT MANAGER: R. NORWOOD

YORK TOLL PLAZA

I-95 CROSS SECTIONS
 STA. 307+50 TO STA. 308+50





SHEET NUMBER: XS-04

CONTRACT: 2018.20

202 OF 489

Date: 8/28/2018

Filename: ...0259637\Xsect12_195.dgn

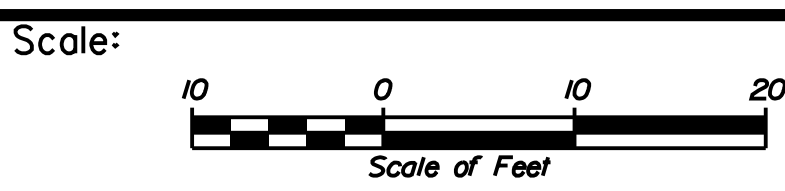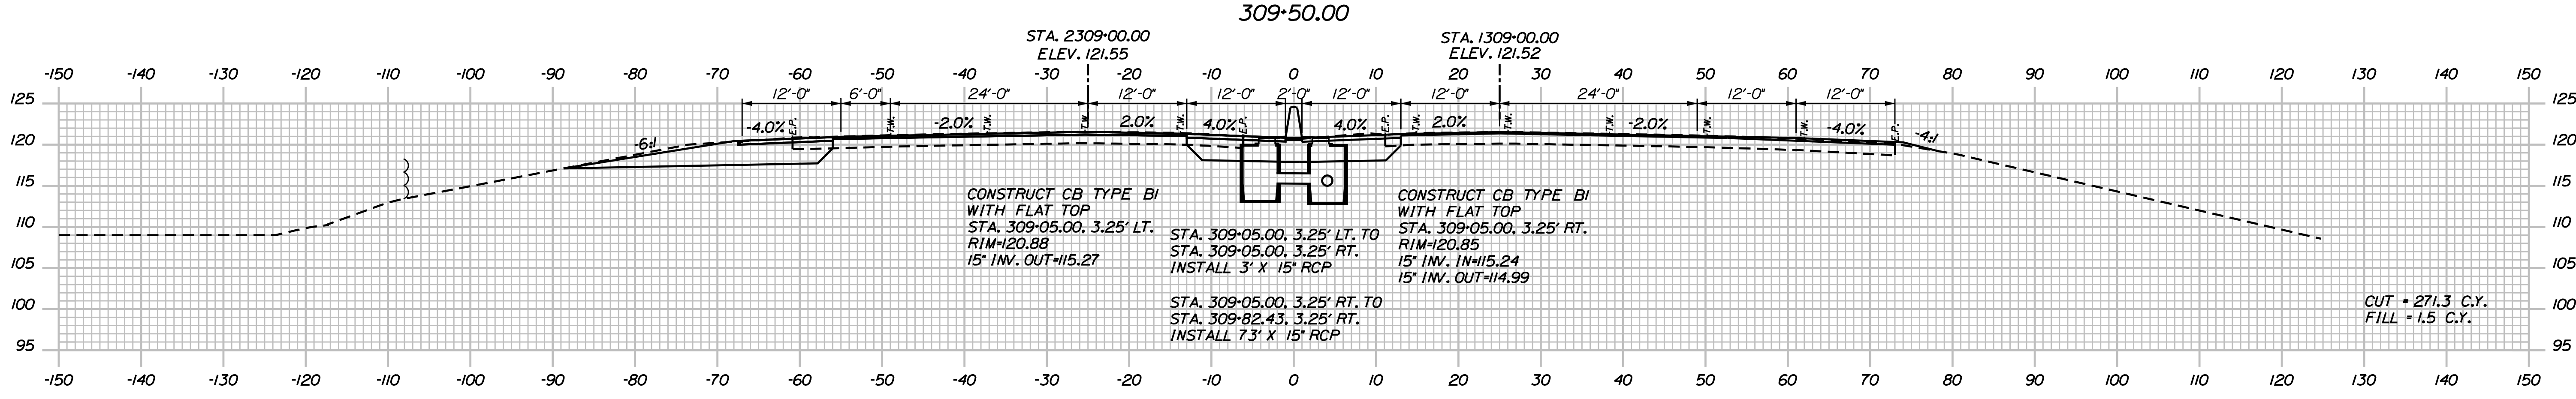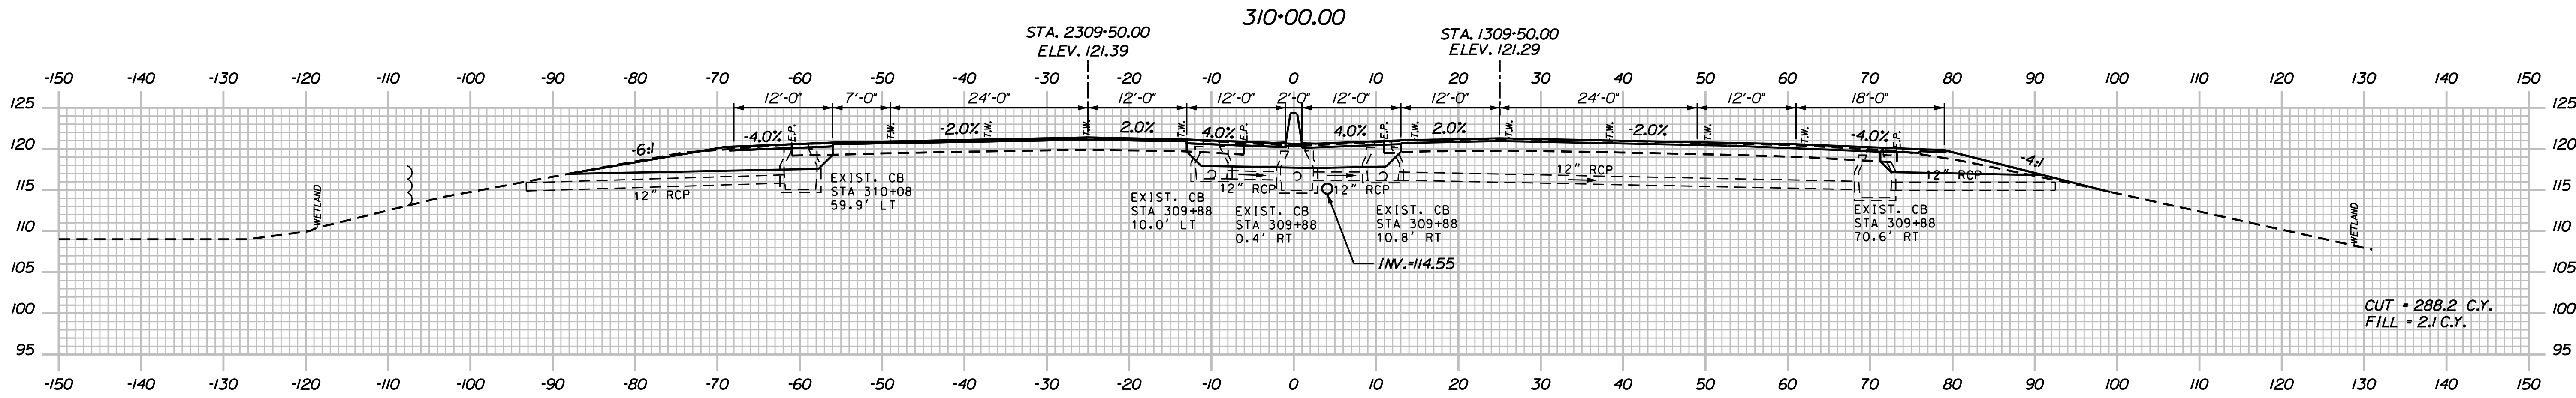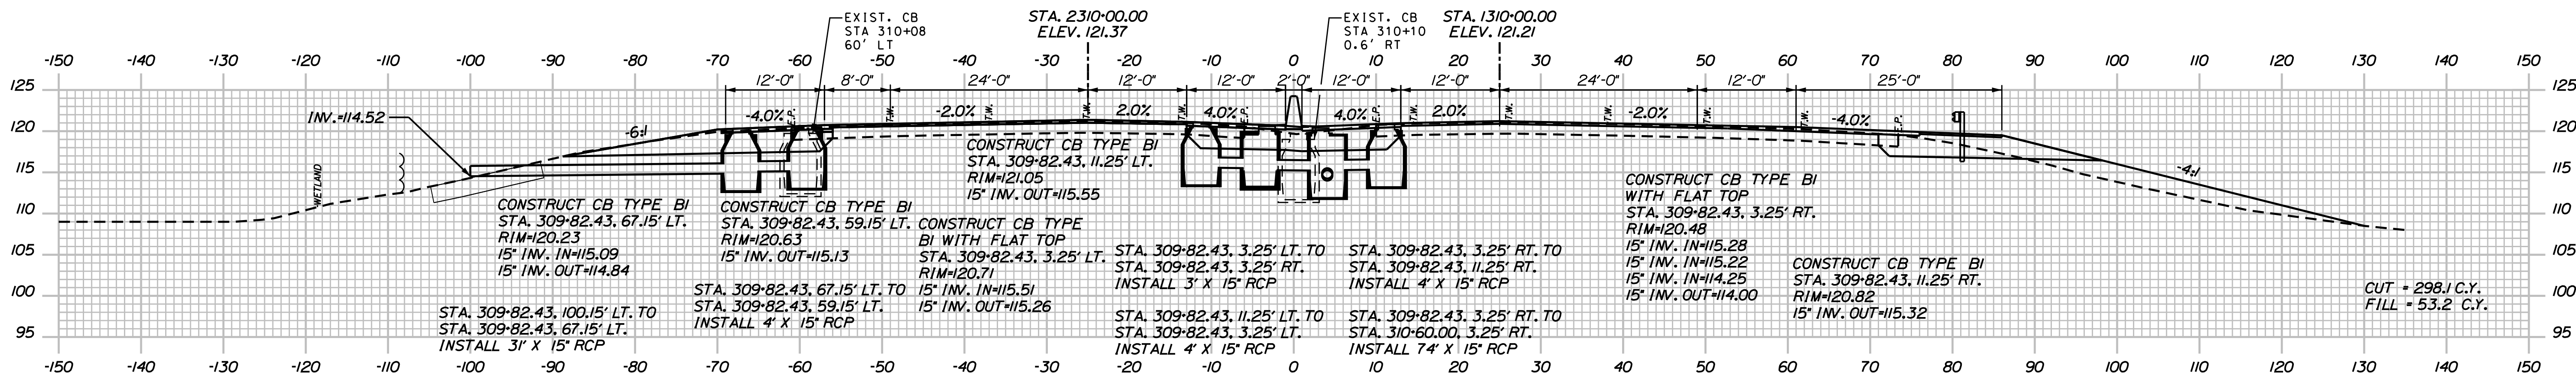

Designed by:



JACOBS ENGINEERING GROUP
120 ST. JAMES AVENUE
BOSTON, MA 02116
TEL (617) 242-9222
FAX (617) 242-9824



THE GOLD STAR
MEMORIAL HIGHWAY

YORK TOLL PLAZA
I-95 CROSS SECTIONS
STA. 309+00 TO STA. 310+00

CONSULTANT PROJECT MANAGER: T. MORIN

No.	Revision	By	Date

	By	Date		By	Date
Designed	AMS	7-18	Checked	CSM	7-18
Drawn	SMG	7-18	In Charge of	TWM	7-18

MTA PROJECT MANAGER: R. NORWOOD




CONTRACT: 2018.20

SHEET NUMBER: XS-05

203 OF 489

Date: 8/28/2018

Filename: ...02596371\sect12_195.dgn

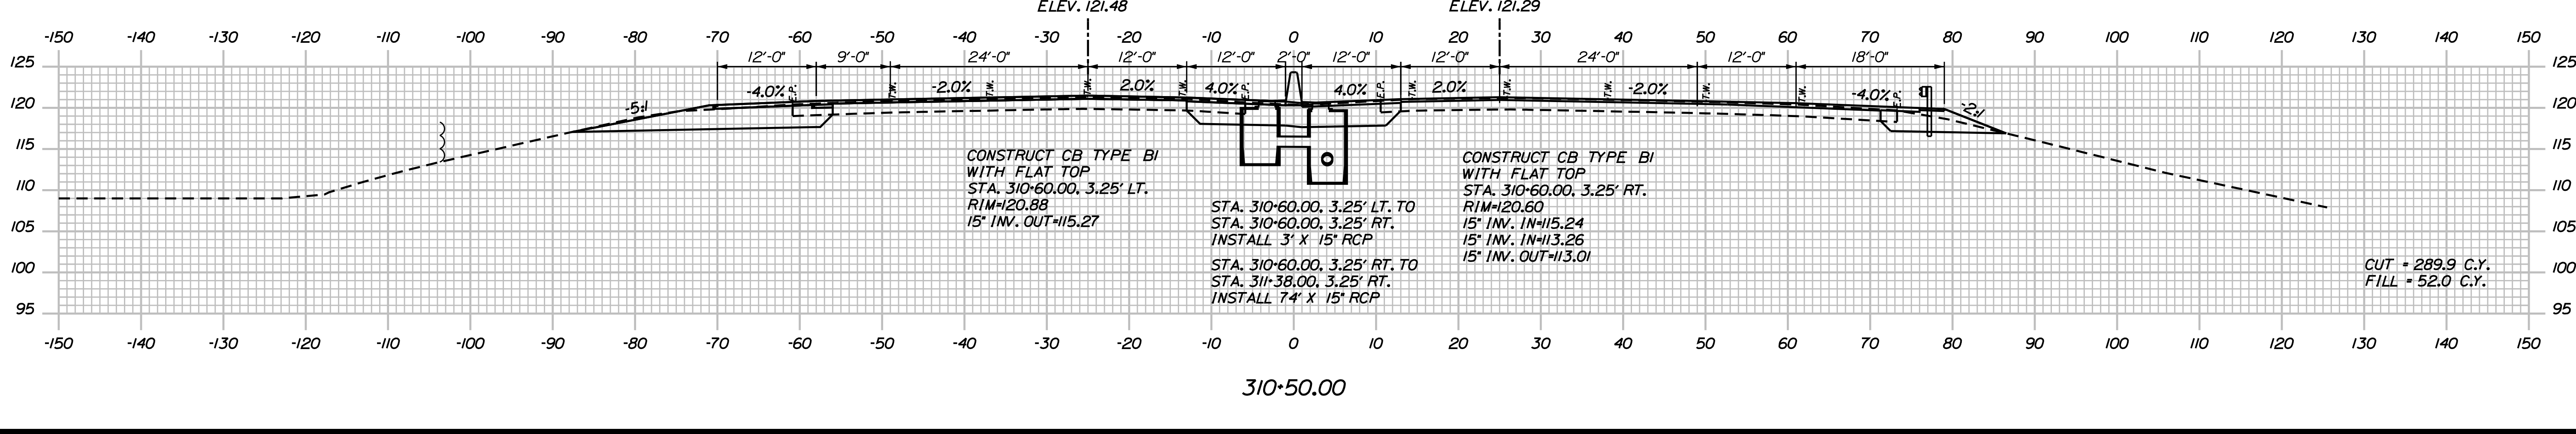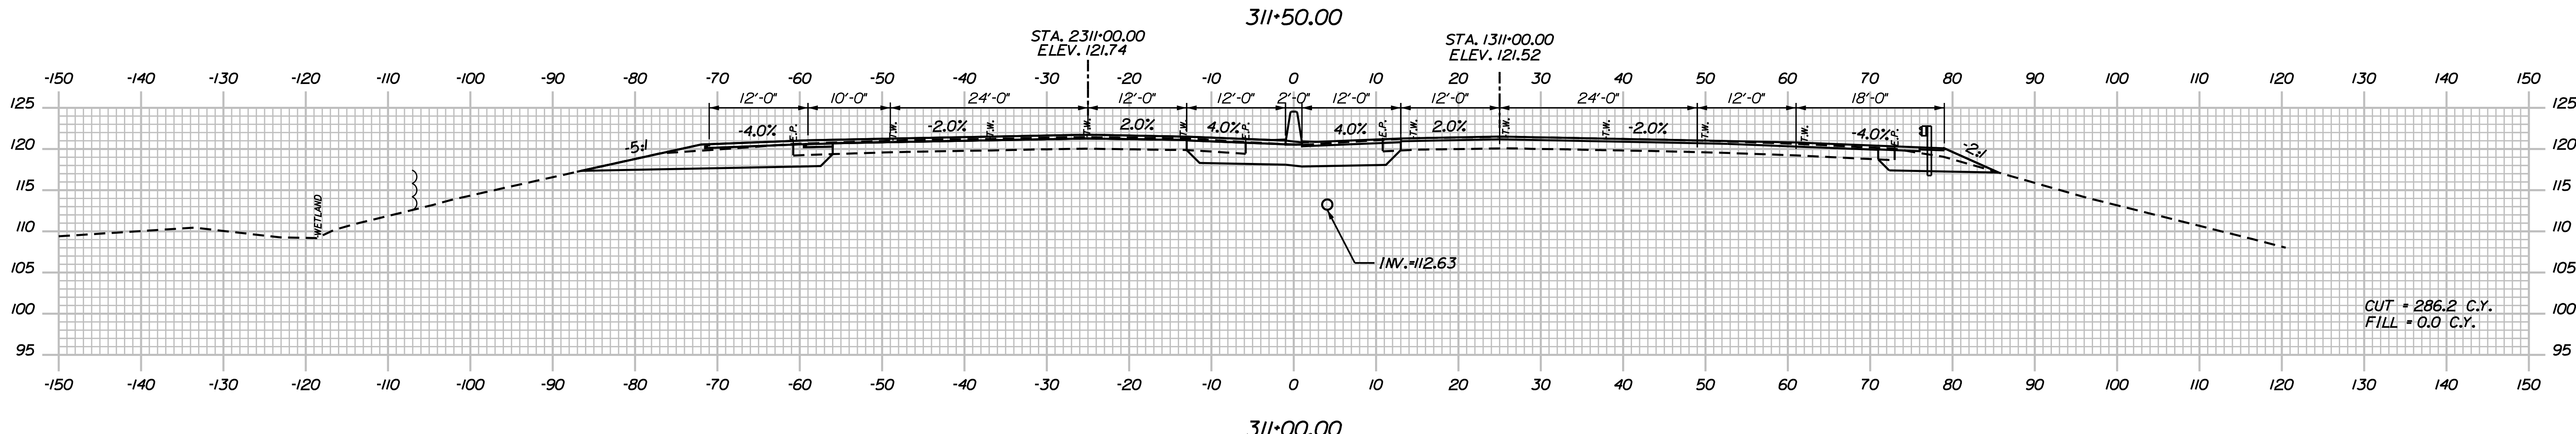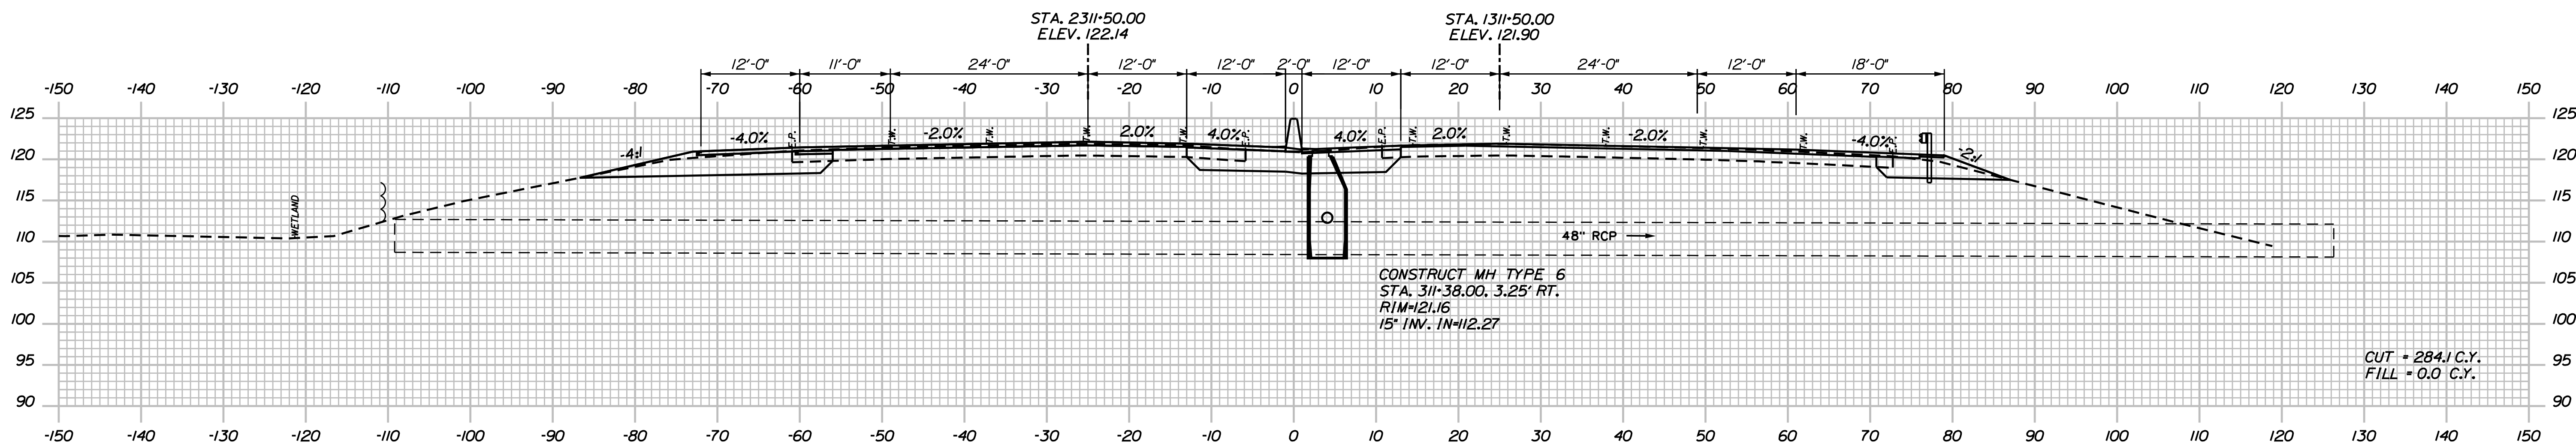

Scale:

No.	Revision	By	Date

Designed by:

JACOBS

CONSULTANT PROJECT MANAGER: T. MORIN

	By	Date		By	Date
Designed	AMS	7-18	Checked	CSM	7-18
Drawn	SMG	7-18	In Charge of	TWM	7-18

JACOBS ENGINEERING GROUP
 120 ST. JAMES AVENUE
 BOSTON, MA 02116
 TEL (617) 242-9222
 FAX (617) 242-9824

THE GOLD STAR MEMORIAL HIGHWAY

MTA PROJECT MANAGER: R. NORWOOD

YORK TOLL PLAZA

I-95 CROSS SECTIONS
 STA. 310+50 TO STA. 311+50


SHEET NUMBER: XS-06

CONTRACT: 2018.20

204 OF 489

Date: 8/28/2018

Filename: ...00259637\Xsect12_195.dgn

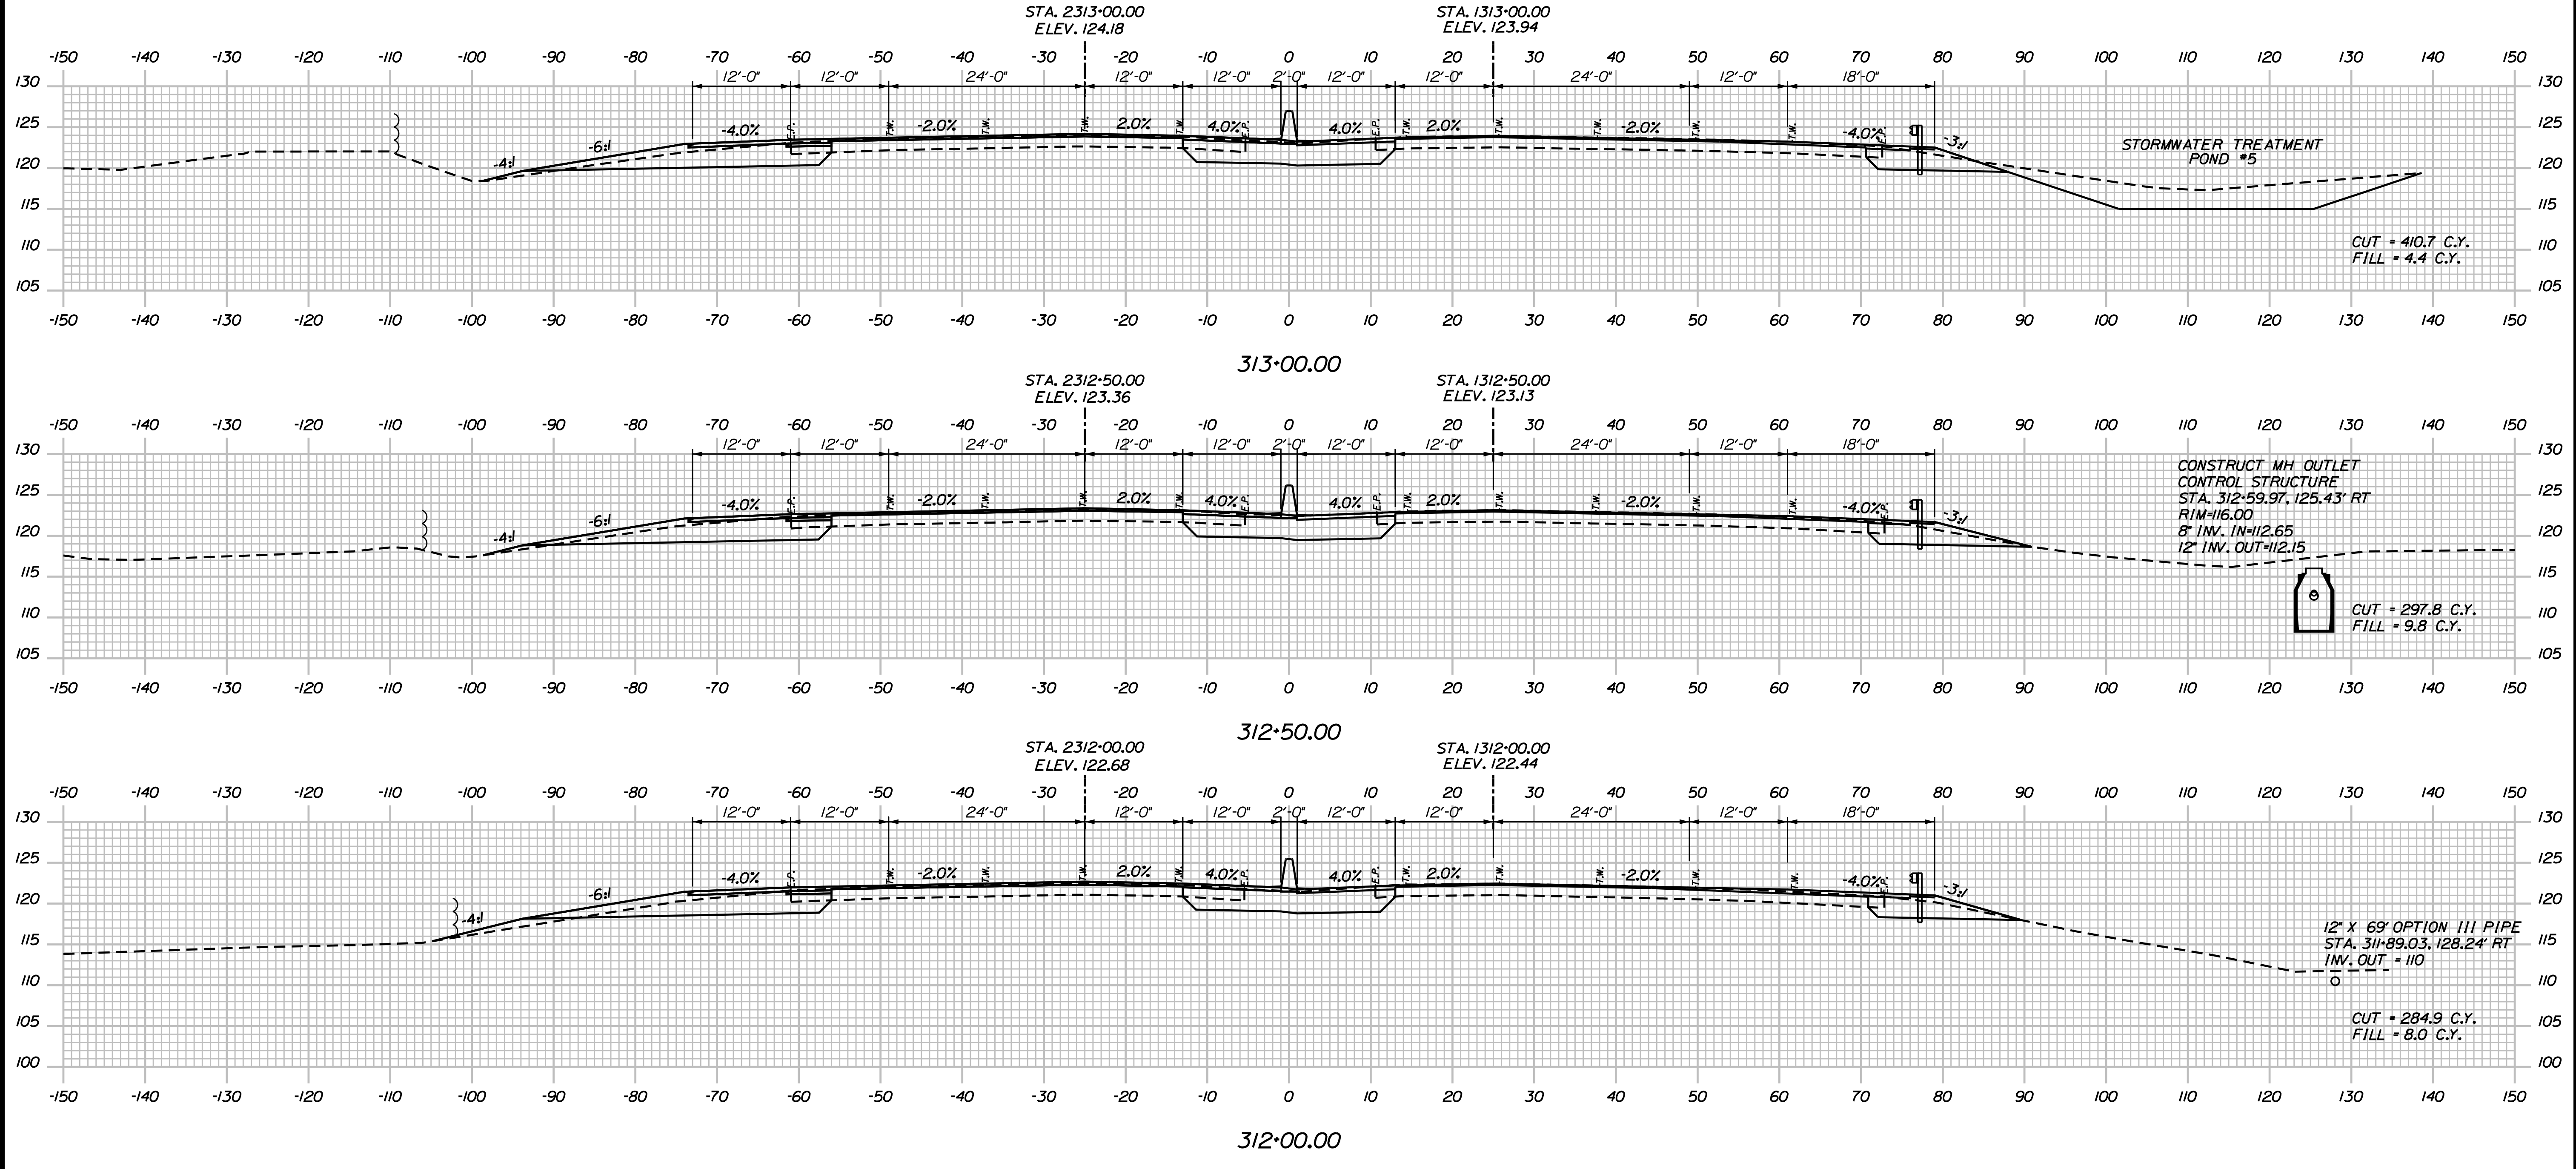

Scale:

No.	Revision	By	Date

Designed by:

JACOBS

CONSULTANT PROJECT MANAGER: T. MORIN

	By	Date		By	Date
Designed	AMS	7-18	Checked	CSM	7-18
Drawn	SMG	7-18	In Charge of	TWM	7-18

JACOBS ENGINEERING GROUP
 120 ST. JAMES AVENUE
 BOSTON, MA 02116
 TEL (617) 242-9222
 FAX (617) 242-9824

THE GOLD STAR MEMORIAL HIGHWAY

MTA PROJECT MANAGER: R. NORWOOD

YORK TOLL PLAZA

I-95 CROSS SECTIONS
 STA. 312+00 TO STA. 313+00


SHEET NUMBER: XS-07

CONTRACT: 2018.20

205 OF 489

Date: 8/28/2018

Filename: ...0259637\Xsect12_195.dgn

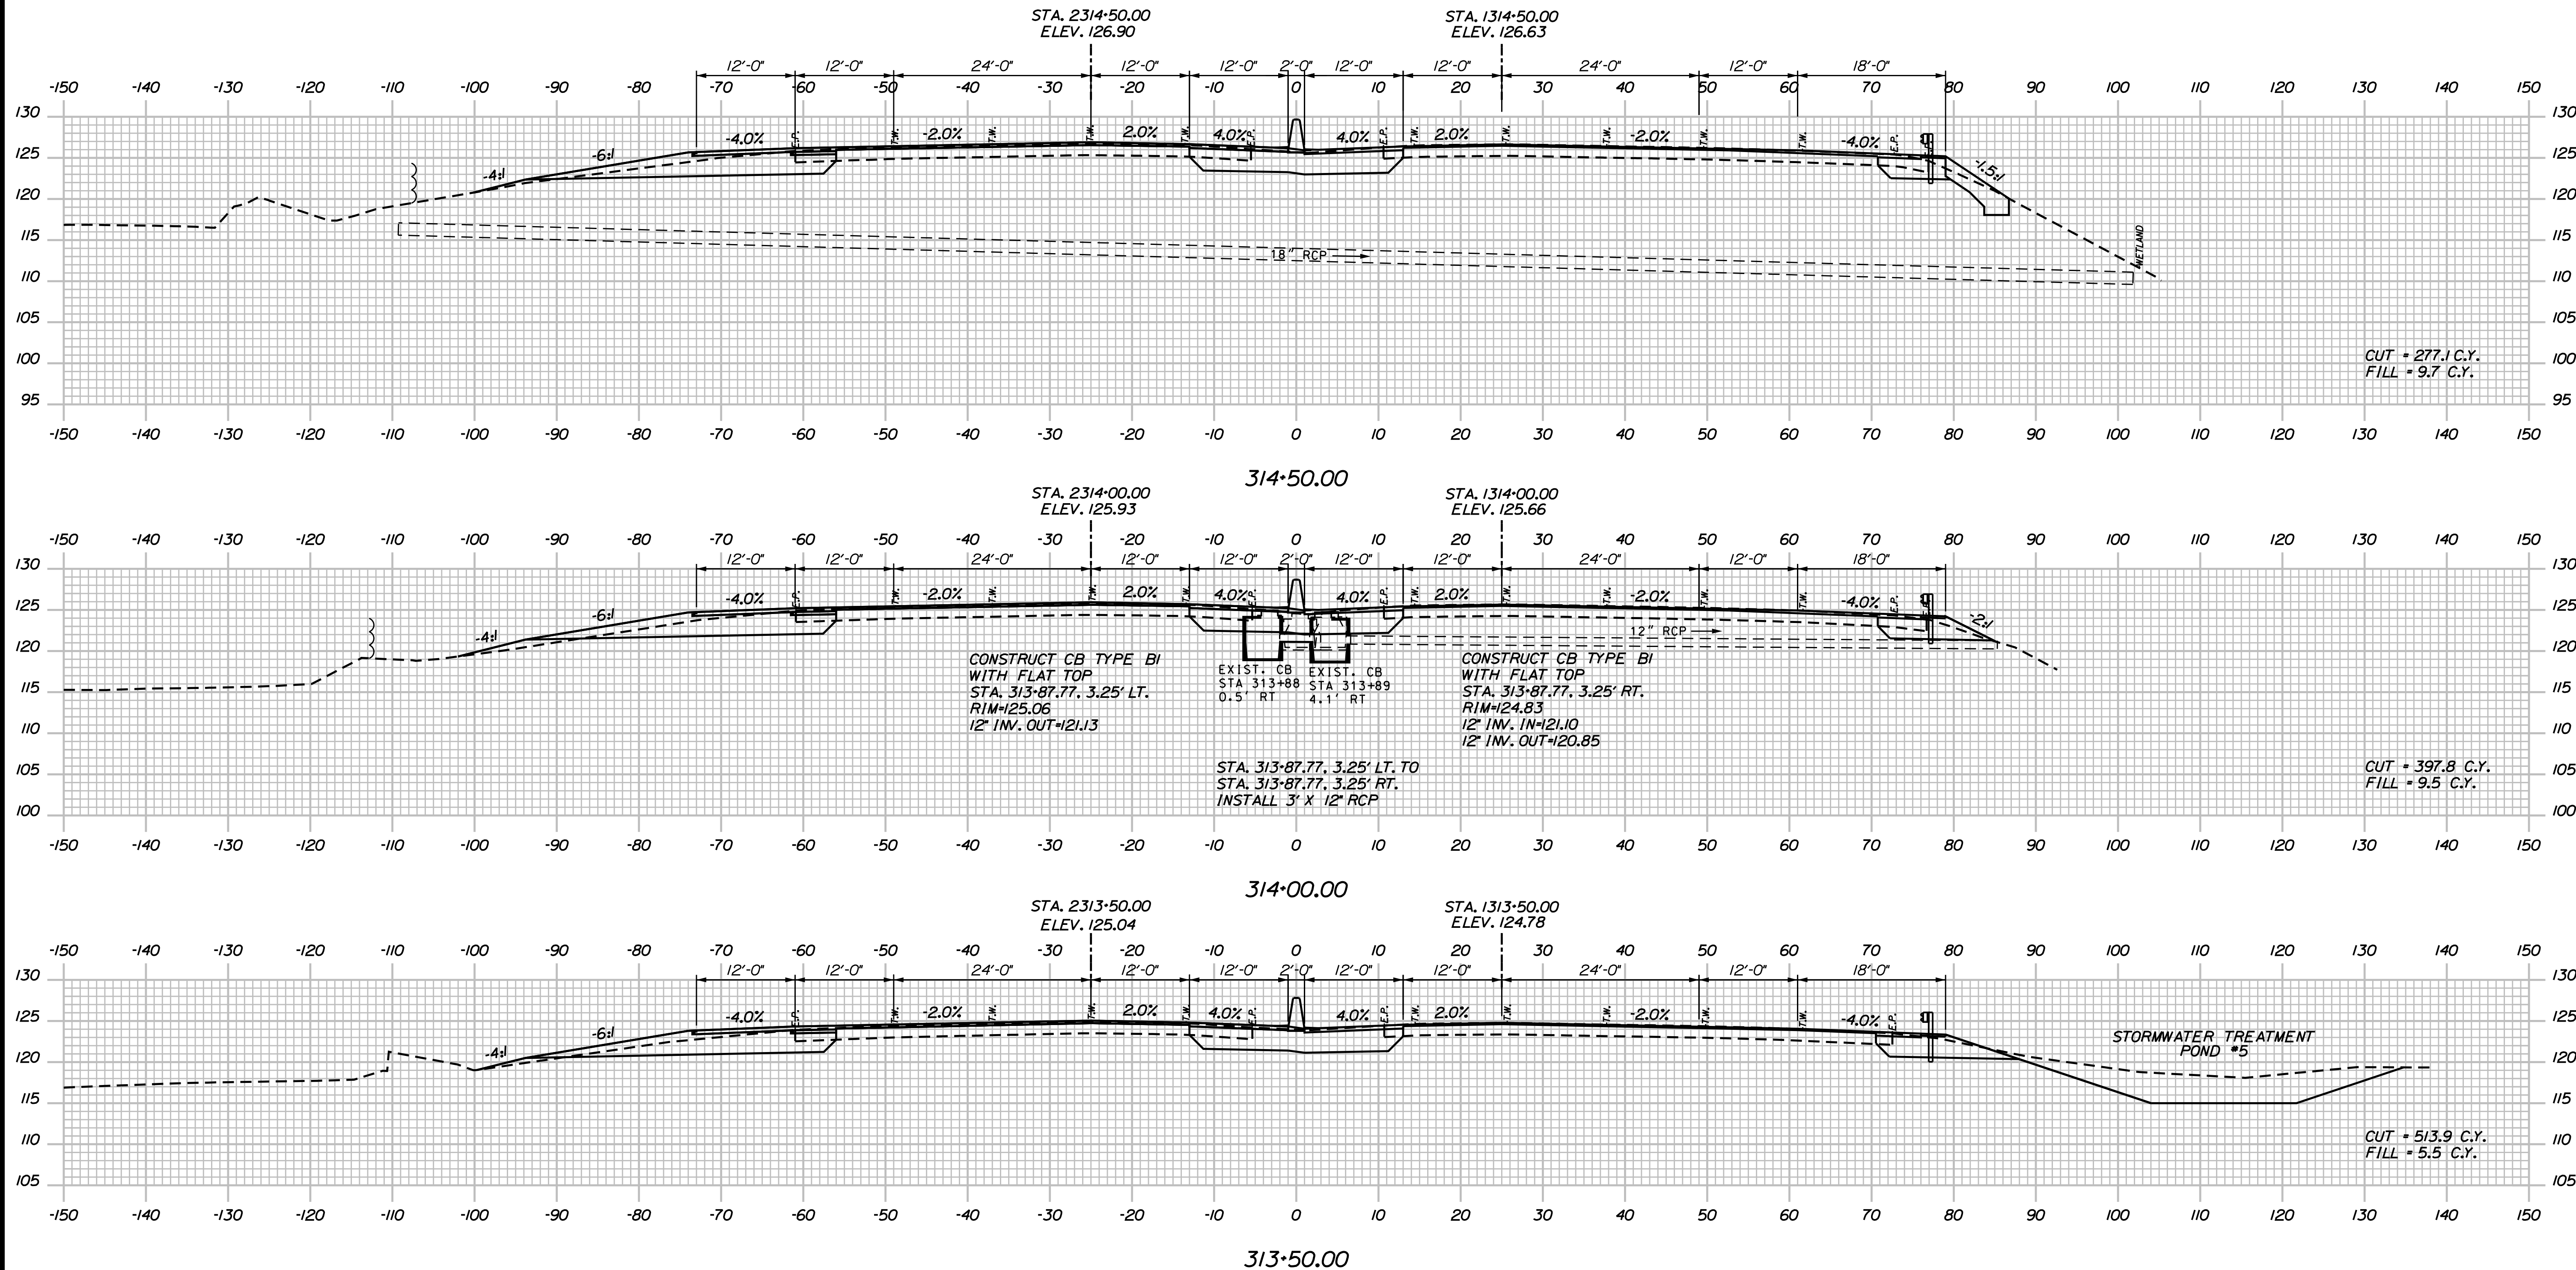

Scale:

No.	Revision	By	Date

Designed by:

JACOBS

CONSULTANT PROJECT MANAGER: T. MORIN

	By	Date		By	Date
Designed	AMS	7-18	Checked	CSM	7-18
Drawn	SMG	7-18	In Charge of	TWM	7-18

JACOBS ENGINEERING GROUP
 120 ST. JAMES AVENUE
 BOSTON, MA 02116
 TEL (617) 242-9222
 FAX (617) 242-9824

THE GOLD STAR MEMORIAL HIGHWAY

MTA PROJECT MANAGER: R. NORWOOD

YORK TOLL PLAZA

I-95 CROSS SECTIONS
 STA. 313+50 TO STA. 314+50





SHEET NUMBER: XS-08

CONTRACT: 2018.20

206 OF 489

Date: 8/28/2018

Filename: ...00259637\Xsect12_195.dgn

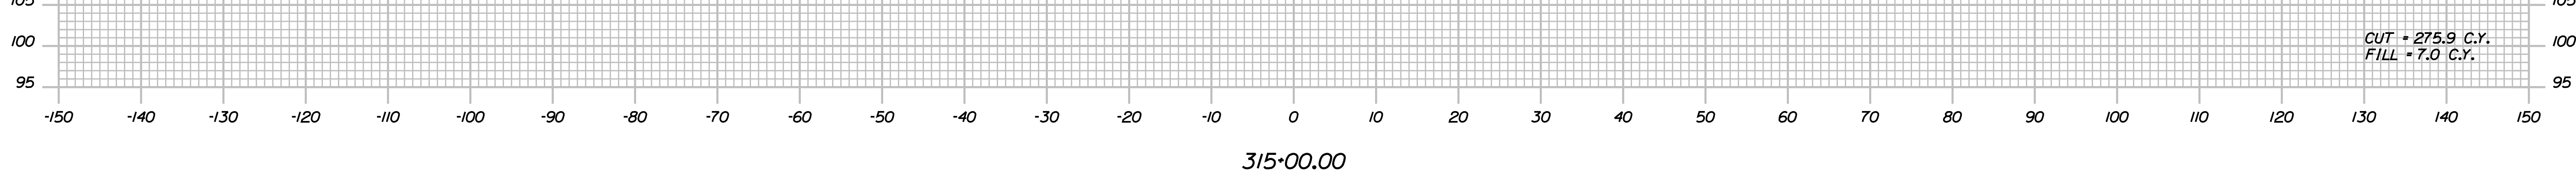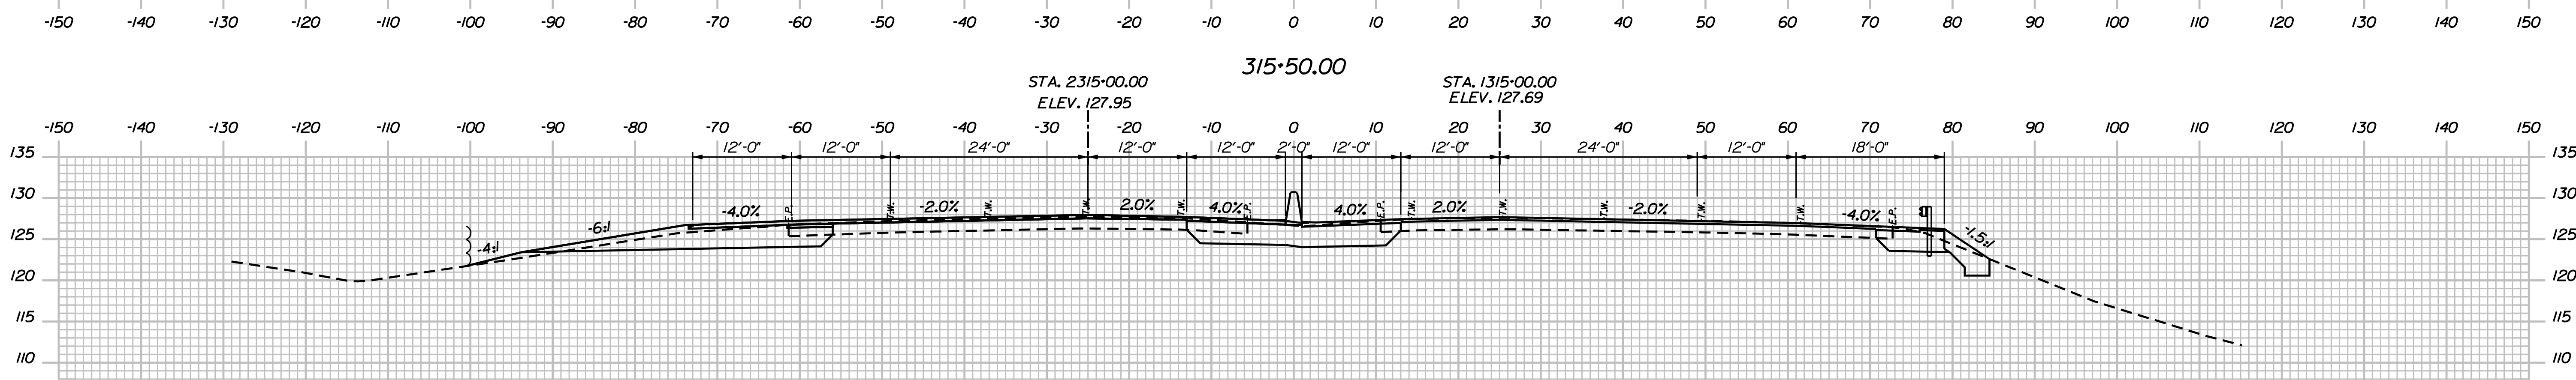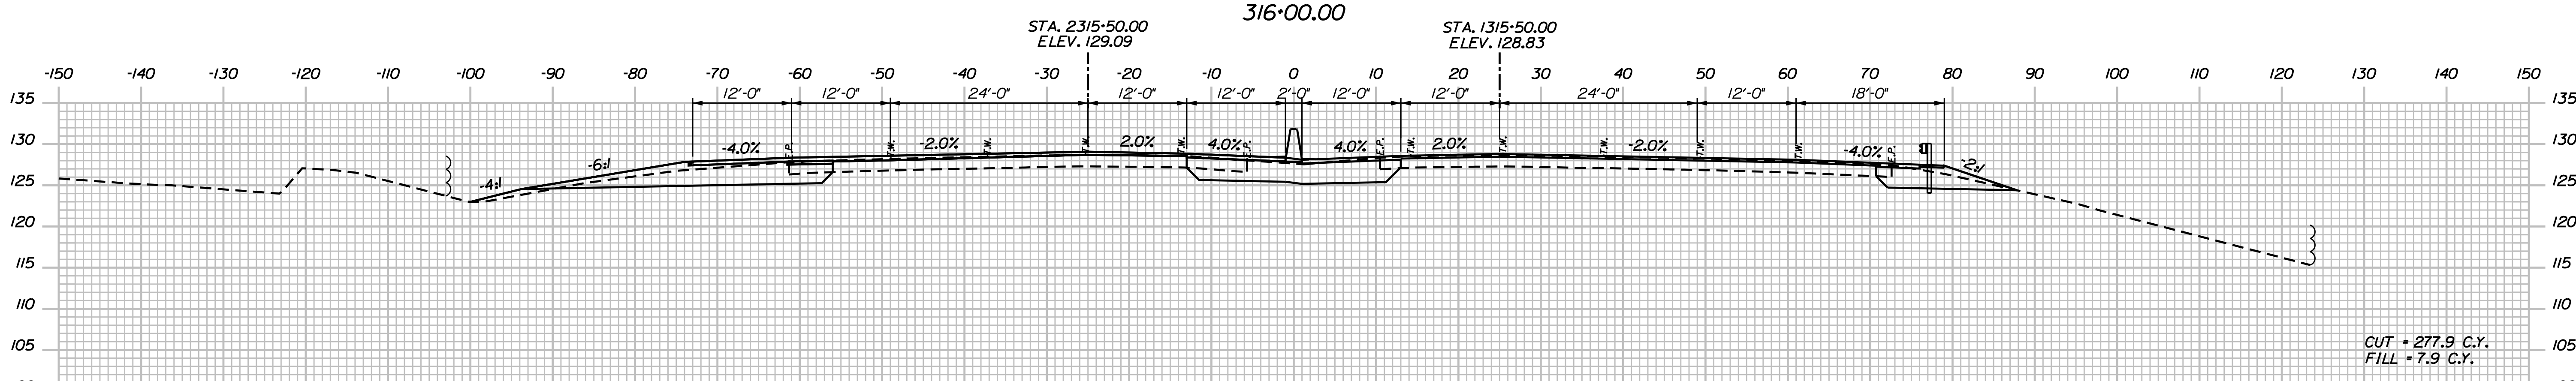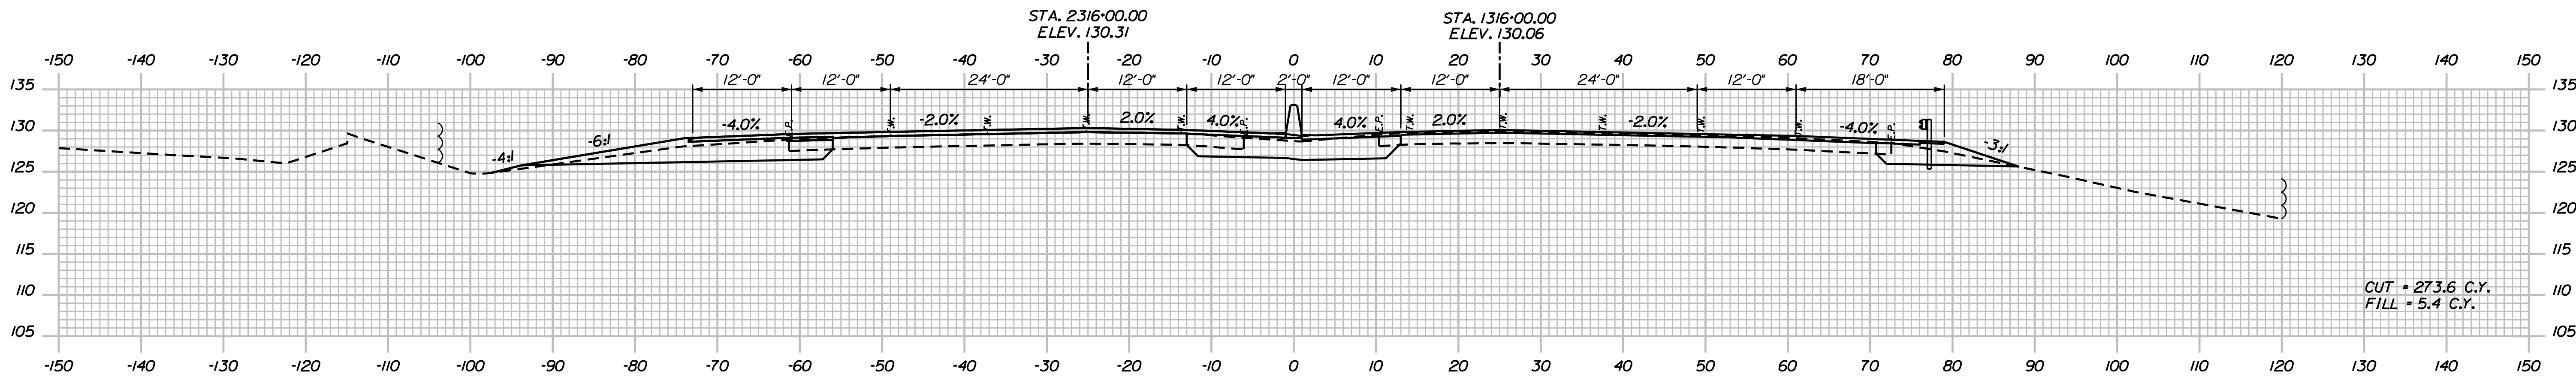

Scale: Scale of Feet

No.	Revision	By	Date

Designed by:

JACOBS

CONSULTANT PROJECT MANAGER: T. MORIN

	By	Date		By	Date
Designed	AMS	7-18	Checked	CSM	7-18
Drawn	SMG	7-18	In Charge of	TWM	7-18

JACOBS ENGINEERING GROUP
 120 ST. JAMES AVENUE
 BOSTON, MA 02116
 TEL (617) 242-9222
 FAX (617) 242-9824

THE GOLD STAR MEMORIAL HIGHWAY

MTA PROJECT MANAGER: R. NORWOOD

YORK TOLL PLAZA


I-95 CROSS SECTIONS
 STA. 315+00 TO STA. 316+00

SHEET NUMBER: XS-09

CONTRACT: 2018.20 207 OF 489

Date: 8/28/2018

Filename: ...0259637\Xsect12_195.dgn

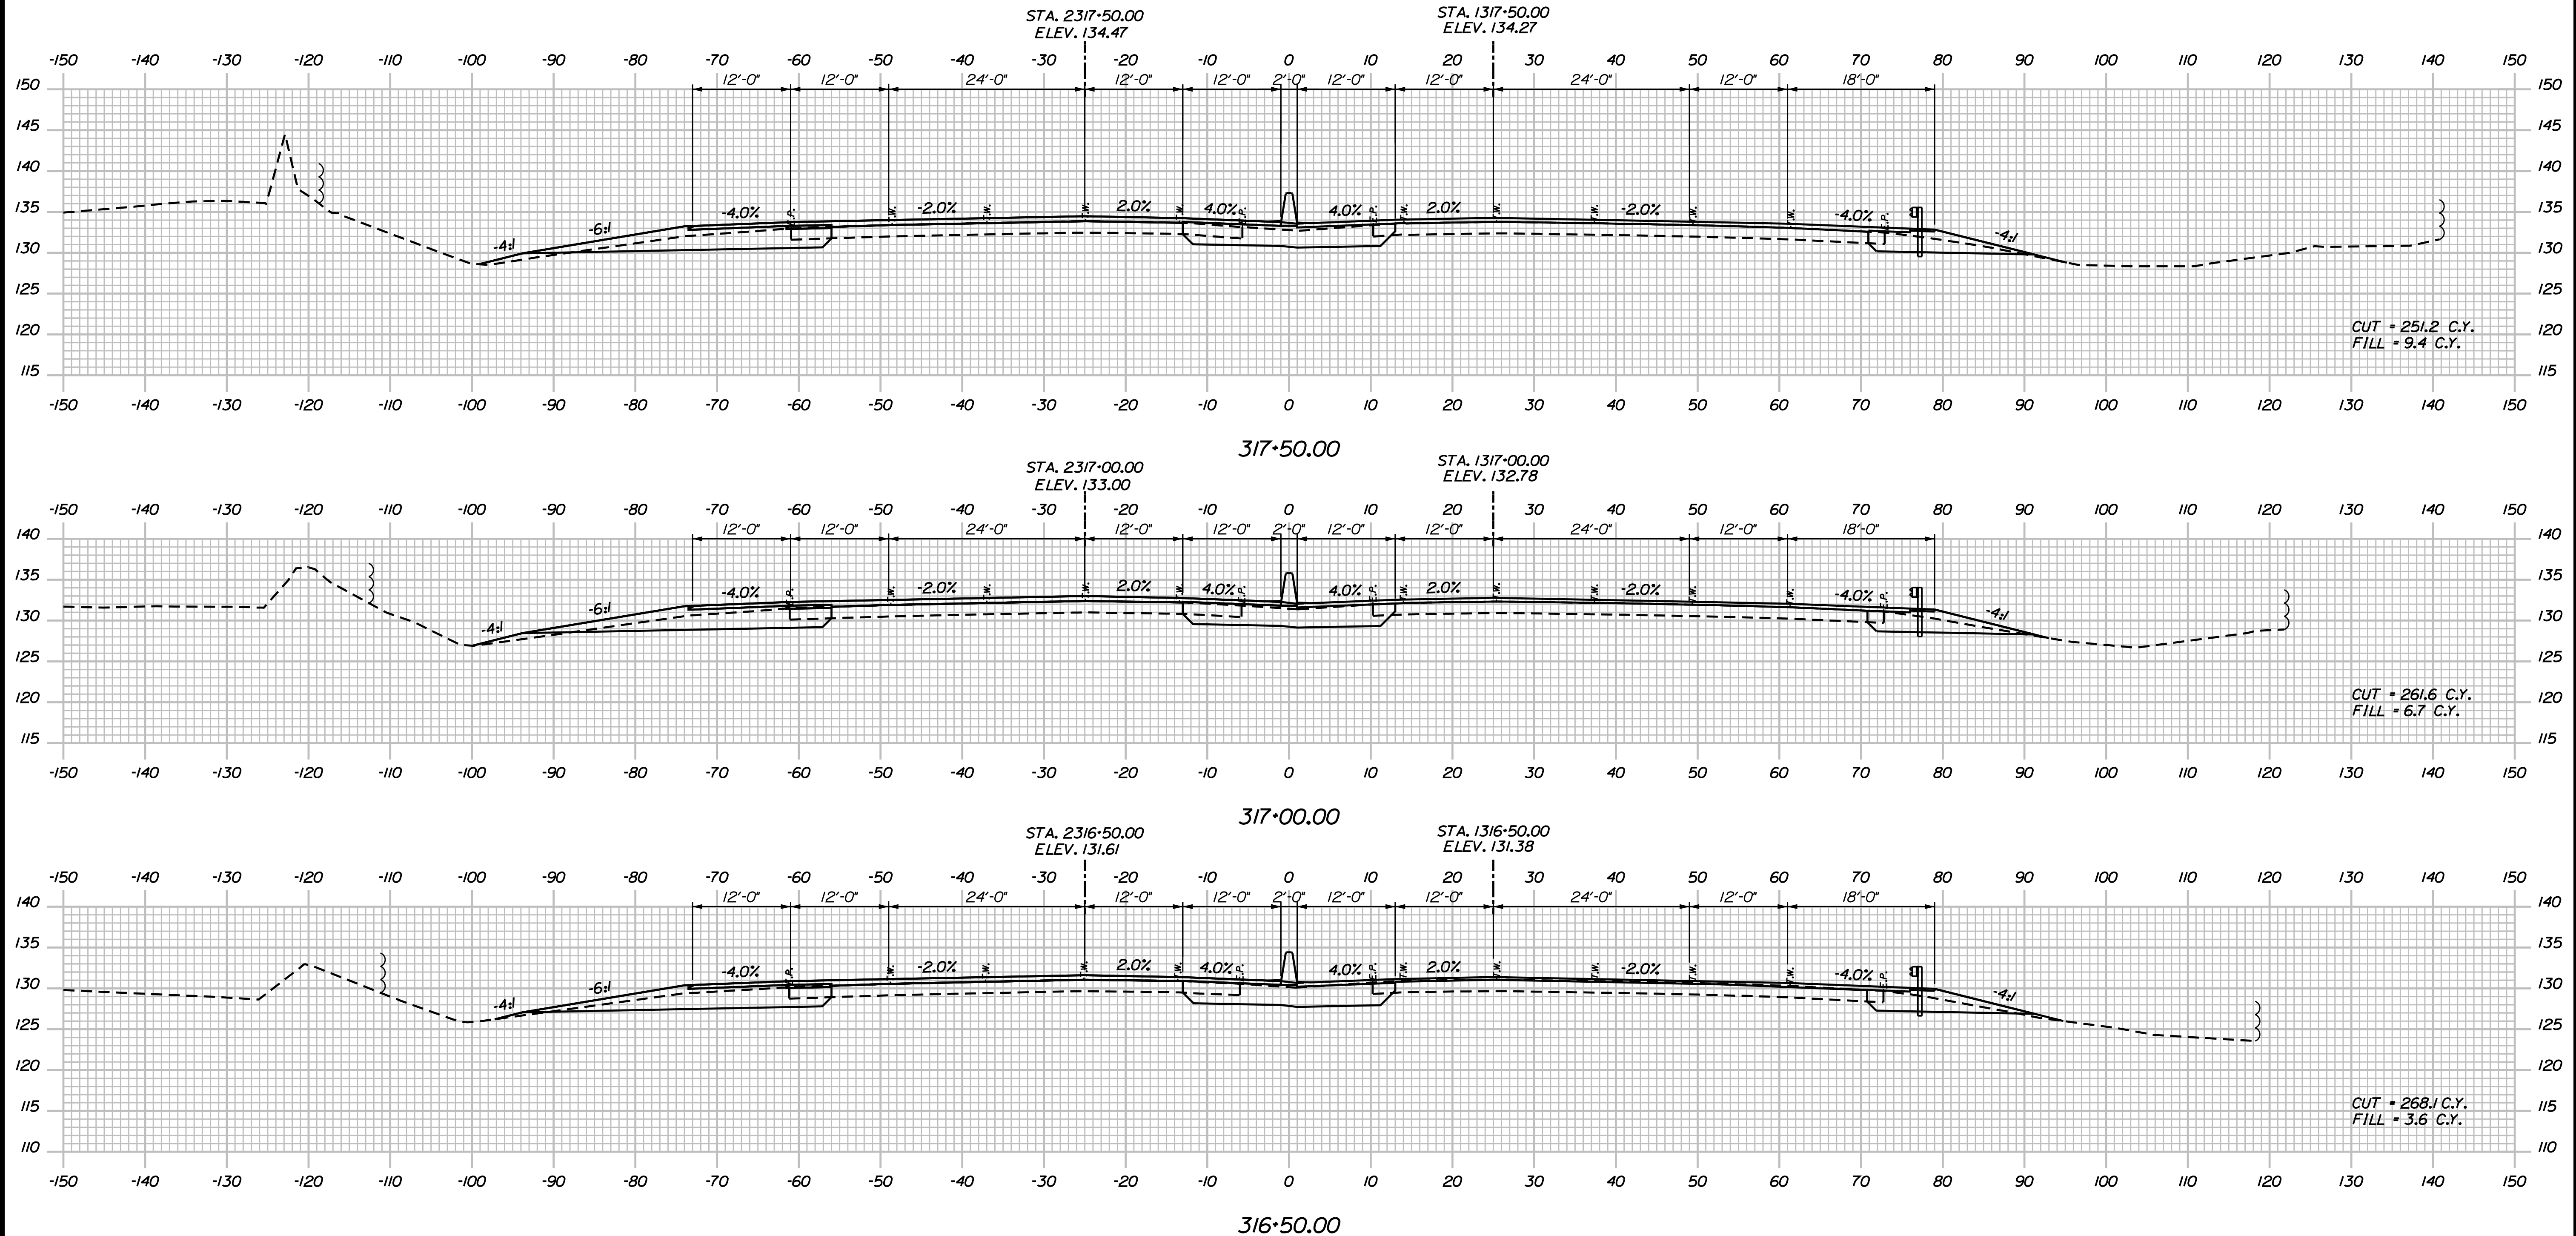

Scale:

No.	Revision	By	Date

Designed by:

JACOBS

CONSULTANT PROJECT MANAGER: T. MORIN

	By	Date		By	Date
Designed	AMS	7-18	Checked	CSM	7-18
Drawn	SMG	7-18	In Charge of	TWM	7-18

JACOBS ENGINEERING GROUP
 120 ST. JAMES AVENUE
 BOSTON, MA 02116
 TEL (617) 242-9222
 FAX (617) 242-9824

THE GOLD STAR MEMORIAL HIGHWAY

MTA PROJECT MANAGER: R. NORWOOD


YORK TOLL PLAZA

I-95 CROSS SECTIONS
 STA. 316+50 TO STA. 317+50

SHEET NUMBER: XS-10
 CONTRACT: 2018.20
 208 OF 489

Date: 8/28/2018

Filename: ...0259637\Xsect12_195.dgn

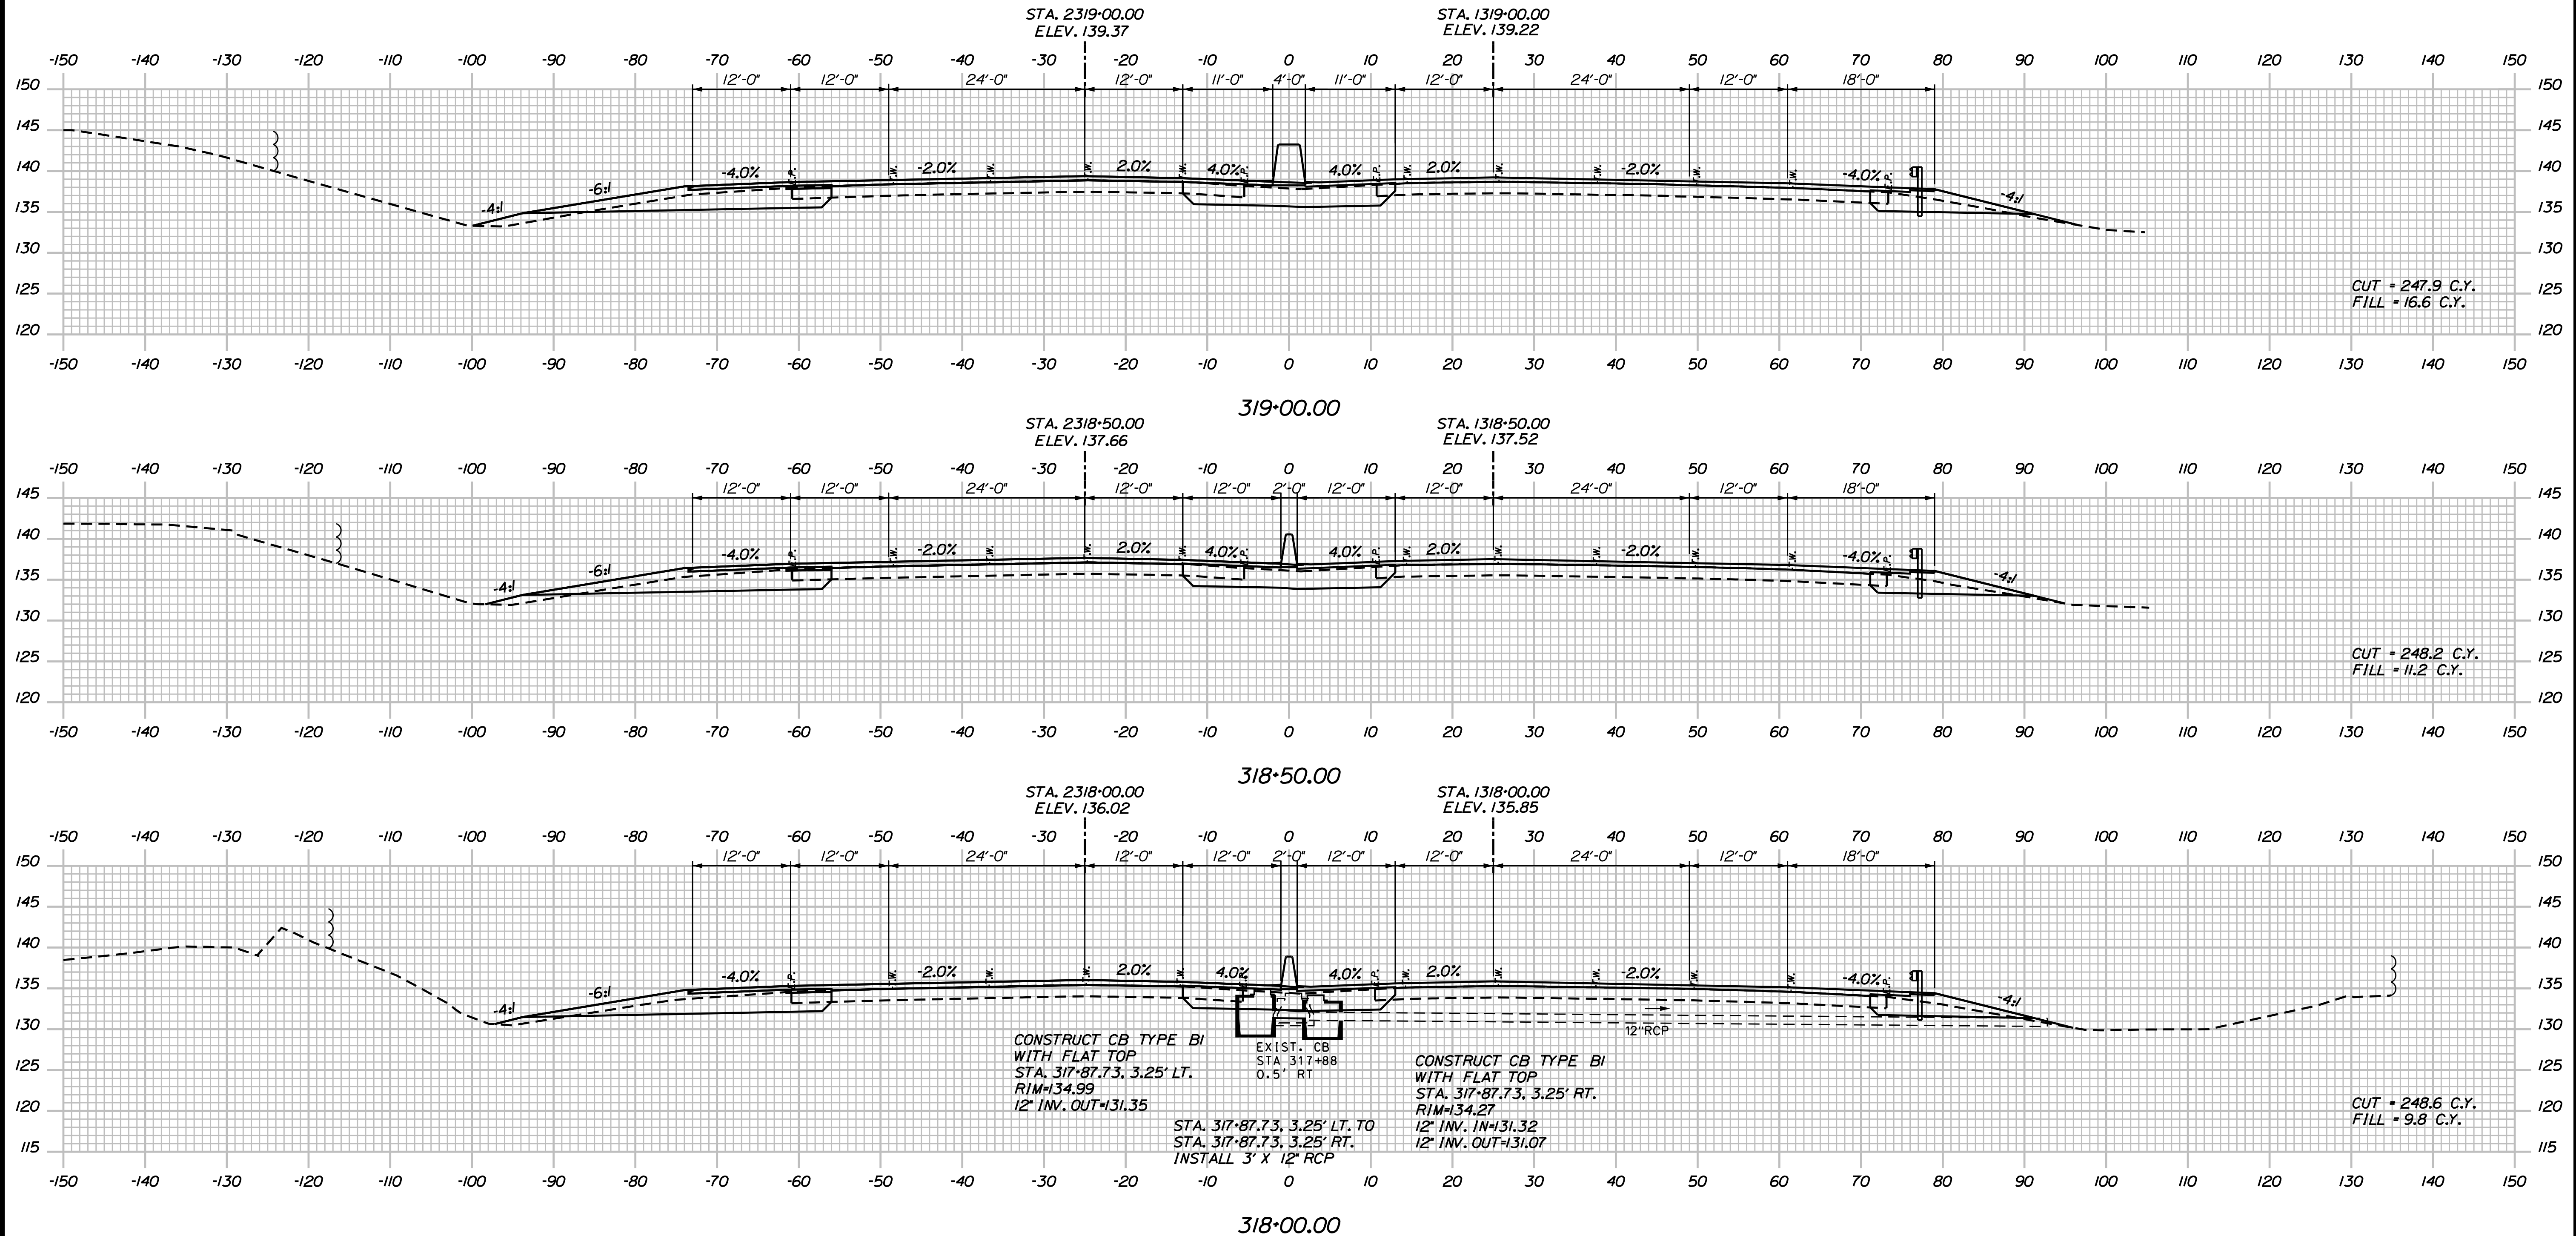

CUT = 247.9 C.Y.
FILL = 16.6 C.Y.

CUT = 248.2 C.Y.
FILL = 11.2 C.Y.

CUT = 248.6 C.Y.
FILL = 9.8 C.Y.

CONSTRUCT CB TYPE BI WITH FLAT TOP
STA. 317+87.73, 3.25' LT.
RIM=134.99
12" INV. OUT=131.35

EXIST. CB STA. 317+88
0.5' RT

CONSTRUCT CB TYPE BI WITH FLAT TOP
STA. 317+87.73, 3.25' RT.
RIM=134.27
12" INV. IN=131.32
12" INV. OUT=131.07

INSTALL 3' X 12" RCP

Scale:

No.	Revision	By	Date

Designed by:

JACOBS

CONSULTANT PROJECT MANAGER: T. MORIN

	By	Date		By	Date
Designed	AMS	7-18	Checked	CSM	7-18
Drawn	SMG	7-18	In Charge of	TWM	7-18

JACOBS ENGINEERING GROUP
120 ST. JAMES AVENUE
BOSTON, MA 02116
TEL (617) 242-9222
FAX (617) 242-9824

THE GOLD STAR MEMORIAL HIGHWAY

MTA PROJECT MANAGER: R. NORWOOD

YORK TOLL PLAZA

I-95 CROSS SECTIONS
STA. 318+00 TO STA. 319+00





SHEET NUMBER: XS-11

CONTRACT: 2018.20

209 OF 489

Date: 8/28/2018

Filename: ... \02596371\sect12_195.dgn

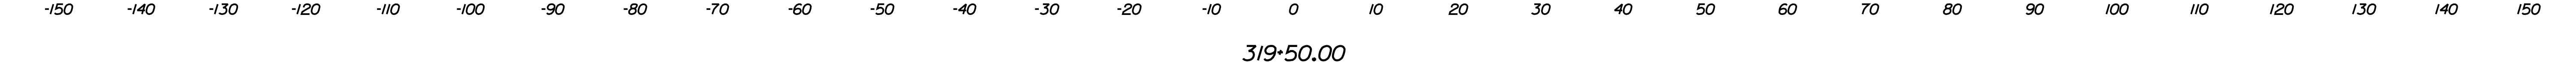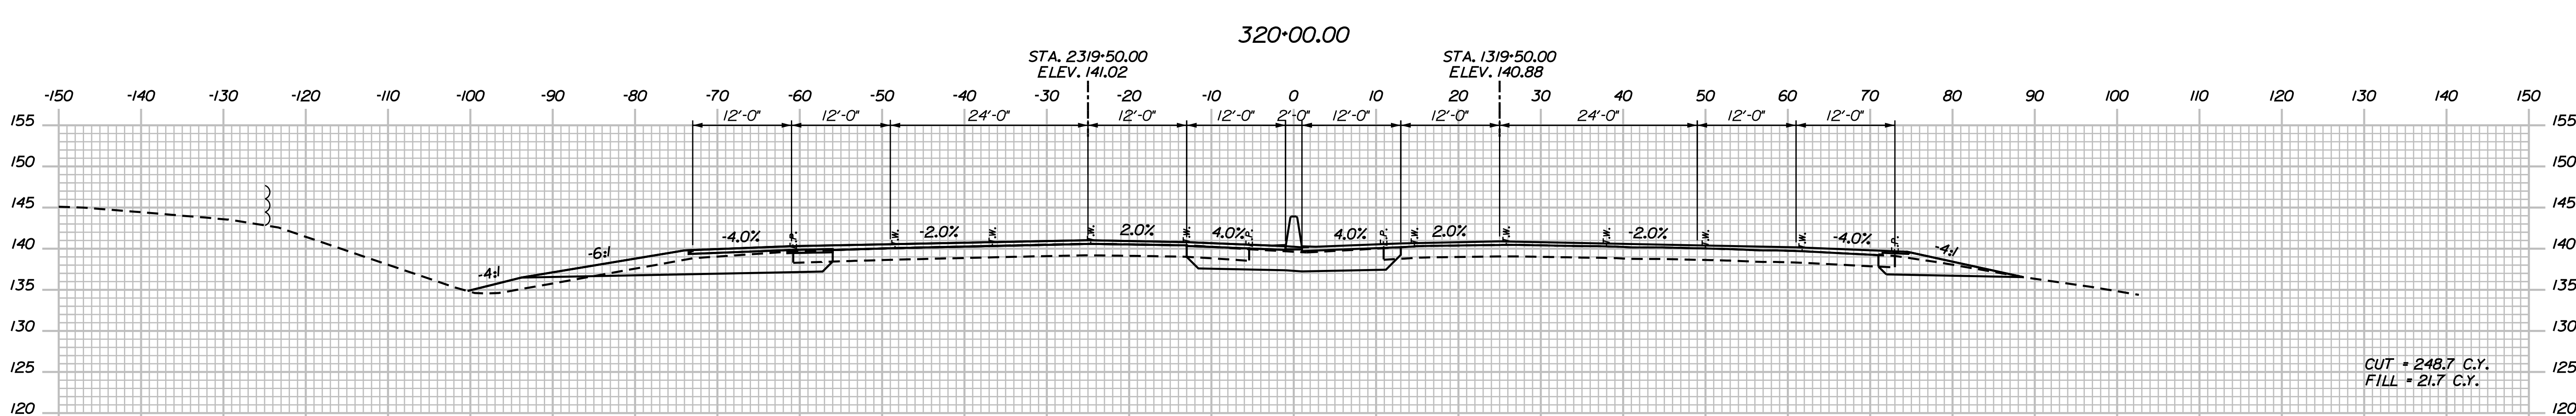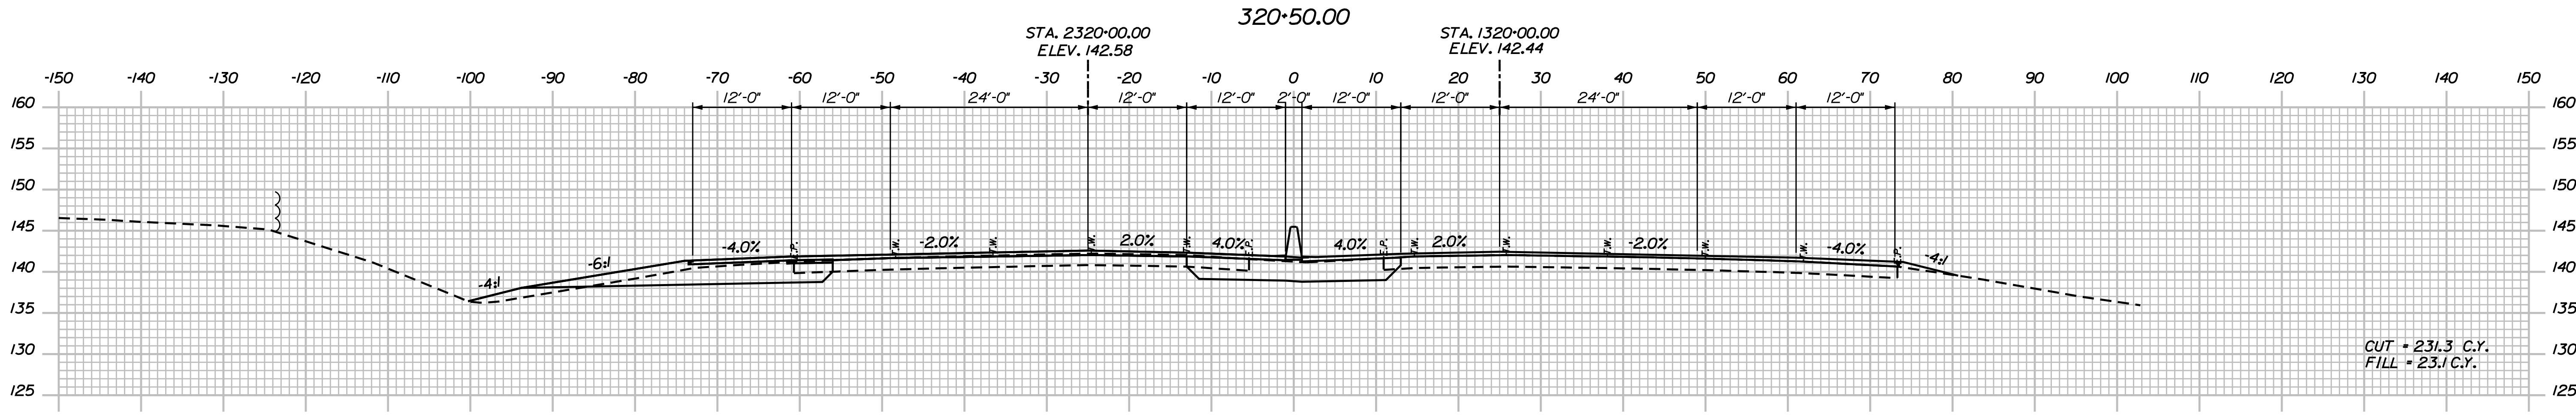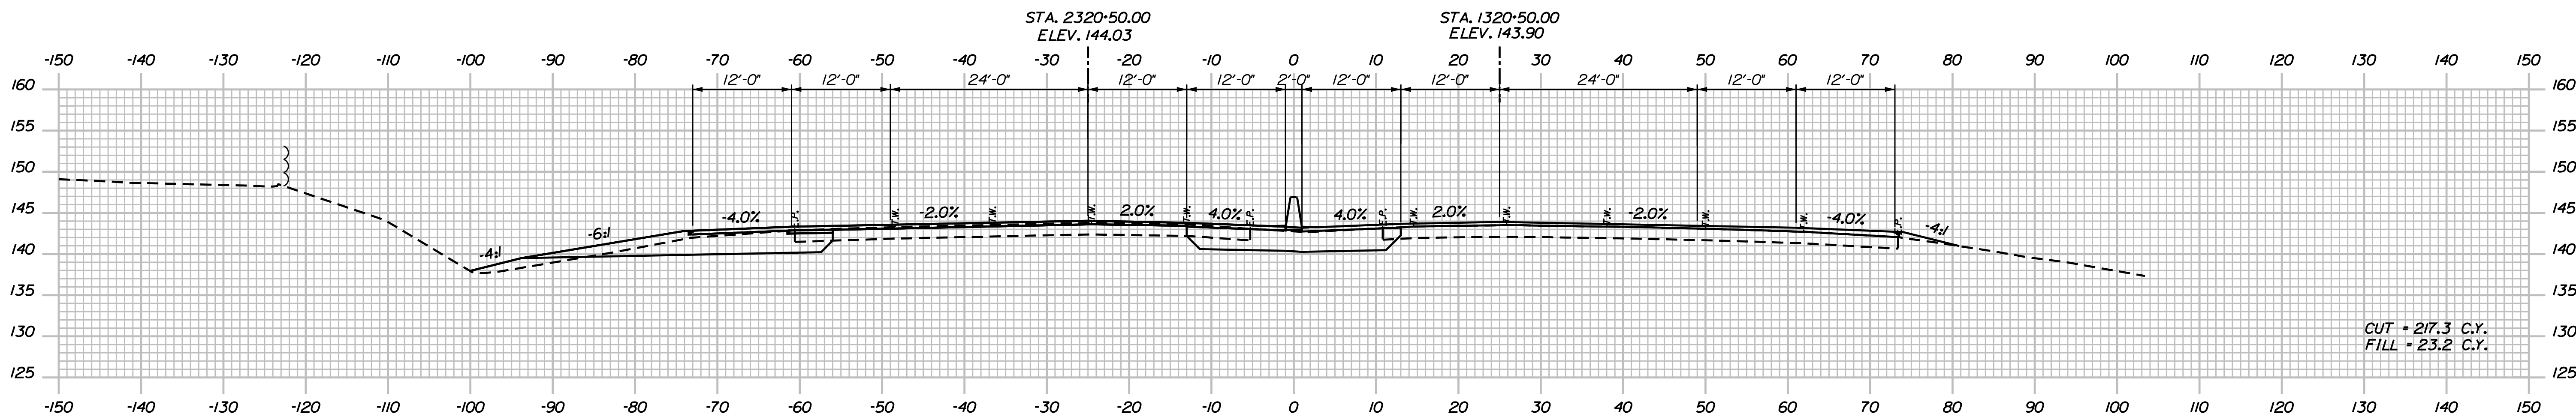

Scale: Scale of Feet

No.	Revision	By	Date

Designed by:

JACOBS

CONSULTANT PROJECT MANAGER: T. MORIN

	By	Date		By	Date
Designed	AMS	7-18	Checked	CSM	7-18
Drawn	SMG	7-18	In Charge of	TWM	7-18

JACOBS ENGINEERING GROUP
 120 ST. JAMES AVENUE
 BOSTON, MA 02116
 TEL (617) 242-9222
 FAX (617) 242-9824

THE GOLD STAR MEMORIAL HIGHWAY

MTA PROJECT MANAGER: R. NORWOOD

YORK TOLL PLAZA

I-95 CROSS SECTIONS
 STA. 319+50 TO STA. 320+50





SHEET NUMBER: XS-12

CONTRACT: 2018.20

210 OF 489

Date: 8/28/2018

Filename: ...00259637\Xsect12_195.dgn

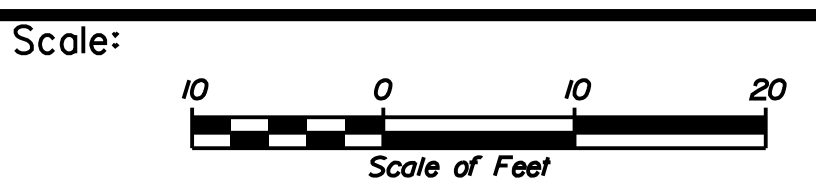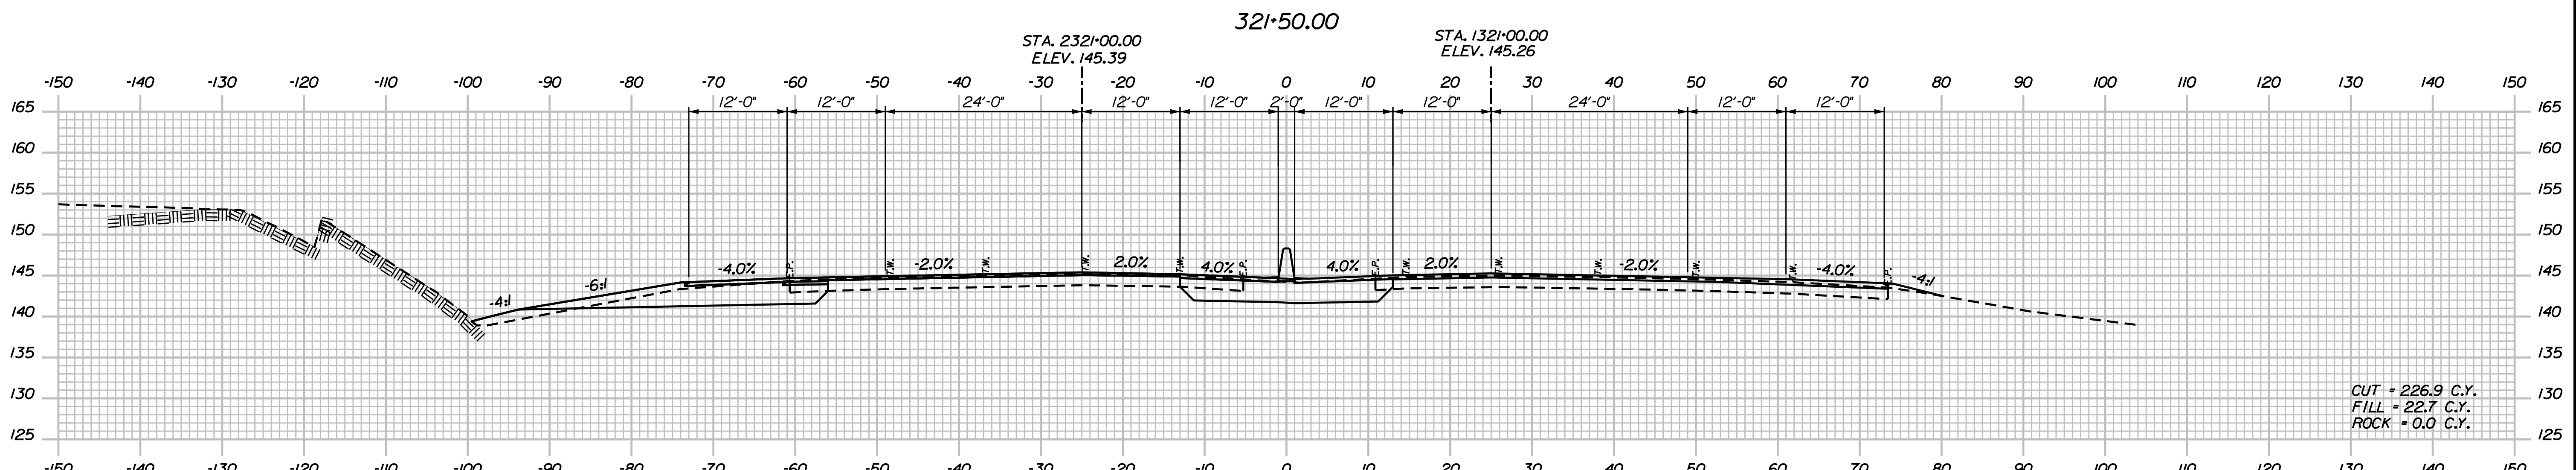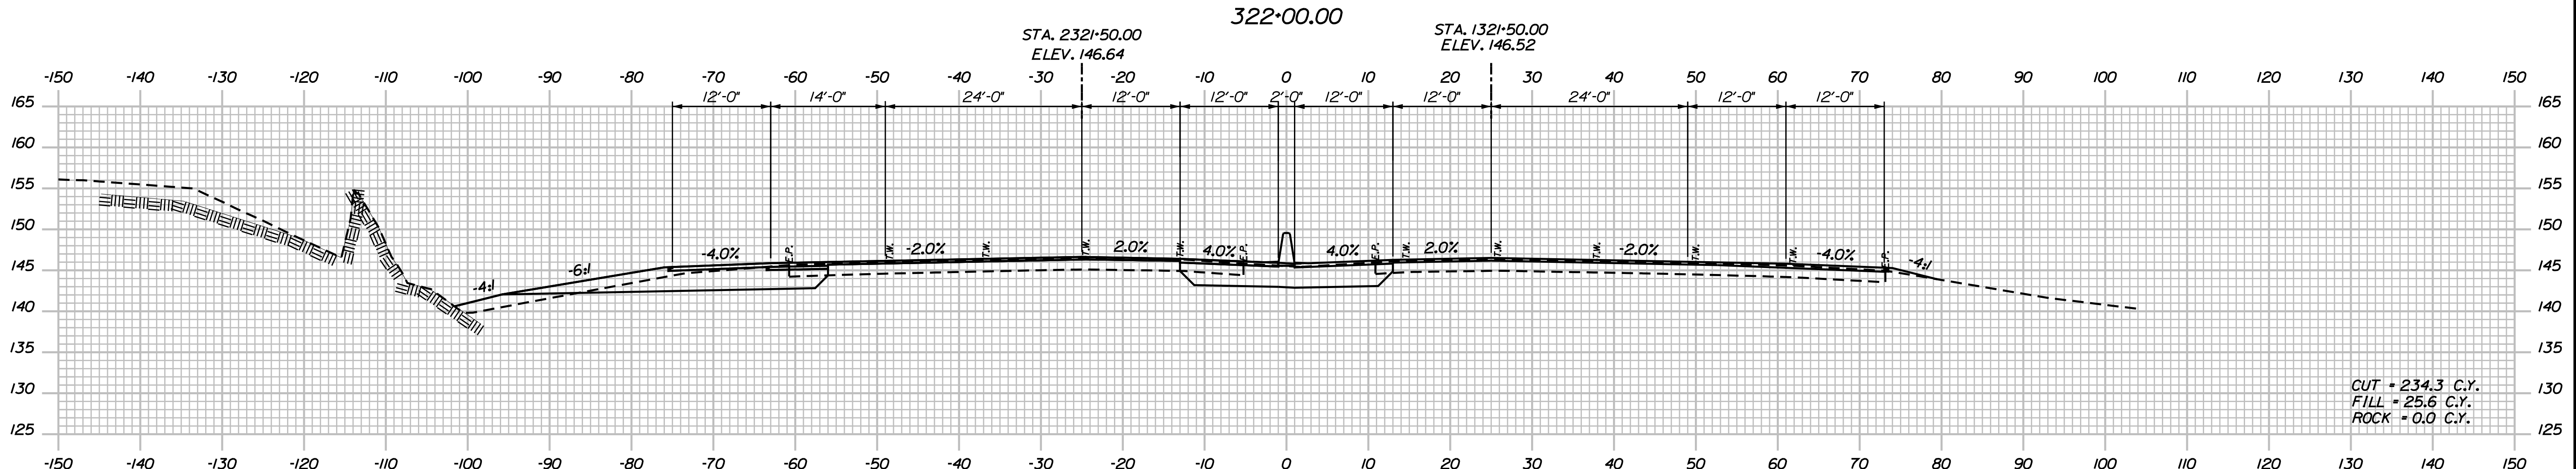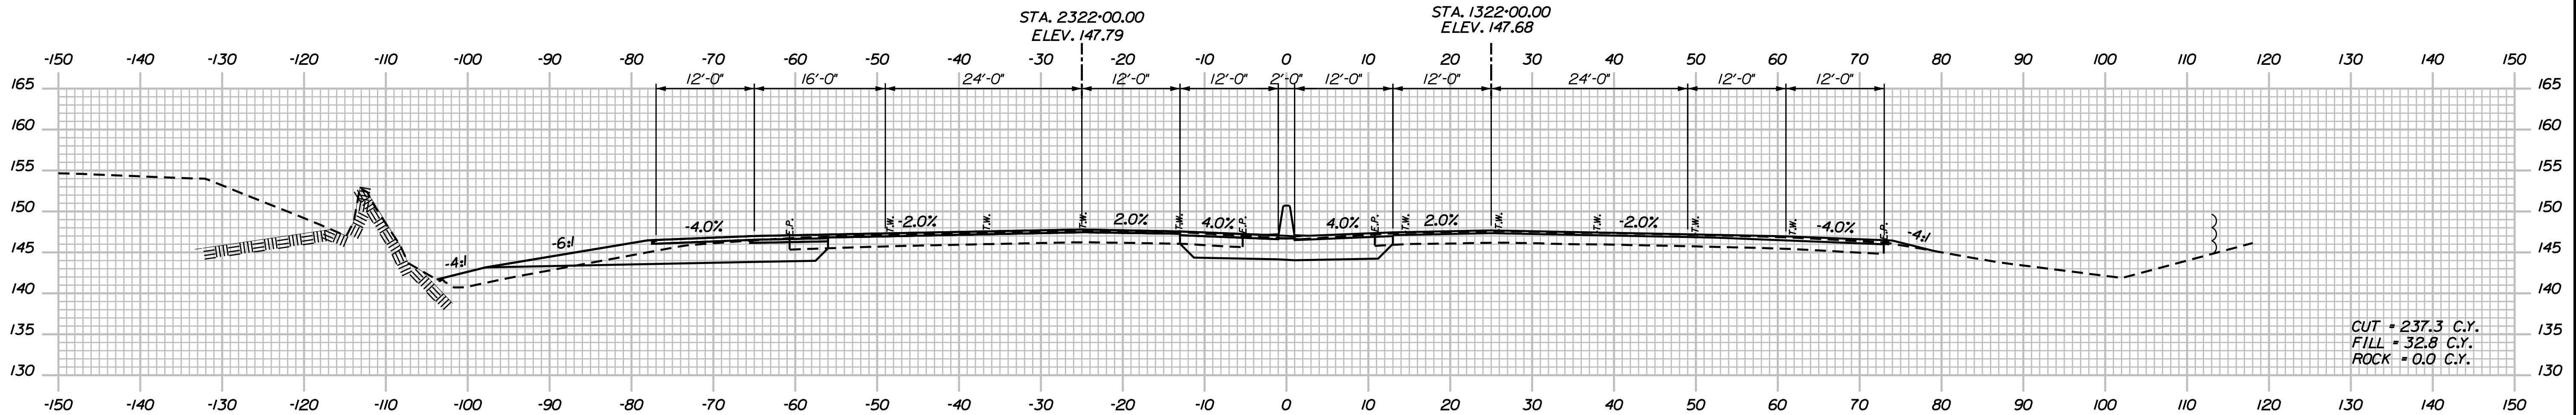

Designed by:

JACOBS

CONSULTANT PROJECT MANAGER: T. MORIN

No.	Revision	By	Date

	By	Date		By	Date
Designed	AMS	7-18	Checked	CSM	7-18
Drawn	SMG	7-18	In Charge of	TWM	7-18

JACOBS ENGINEERING GROUP
120 ST. JAMES AVENUE
BOSTON, MA 02116
TEL (617) 242-9222
FAX (617) 242-9824

THE GOLD STAR
MEMORIAL HIGHWAY

MTA PROJECT MANAGER: R. NORWOOD

YORK TOLL PLAZA

I-95 CROSS SECTIONS
STA. 321+00 TO STA. 322+00


SHEET NUMBER: XS-13

CONTRACT: 2018.20

211 OF 489

Date: 8/28/2018

Filename: ...0259637\Xsect12_195.dgn

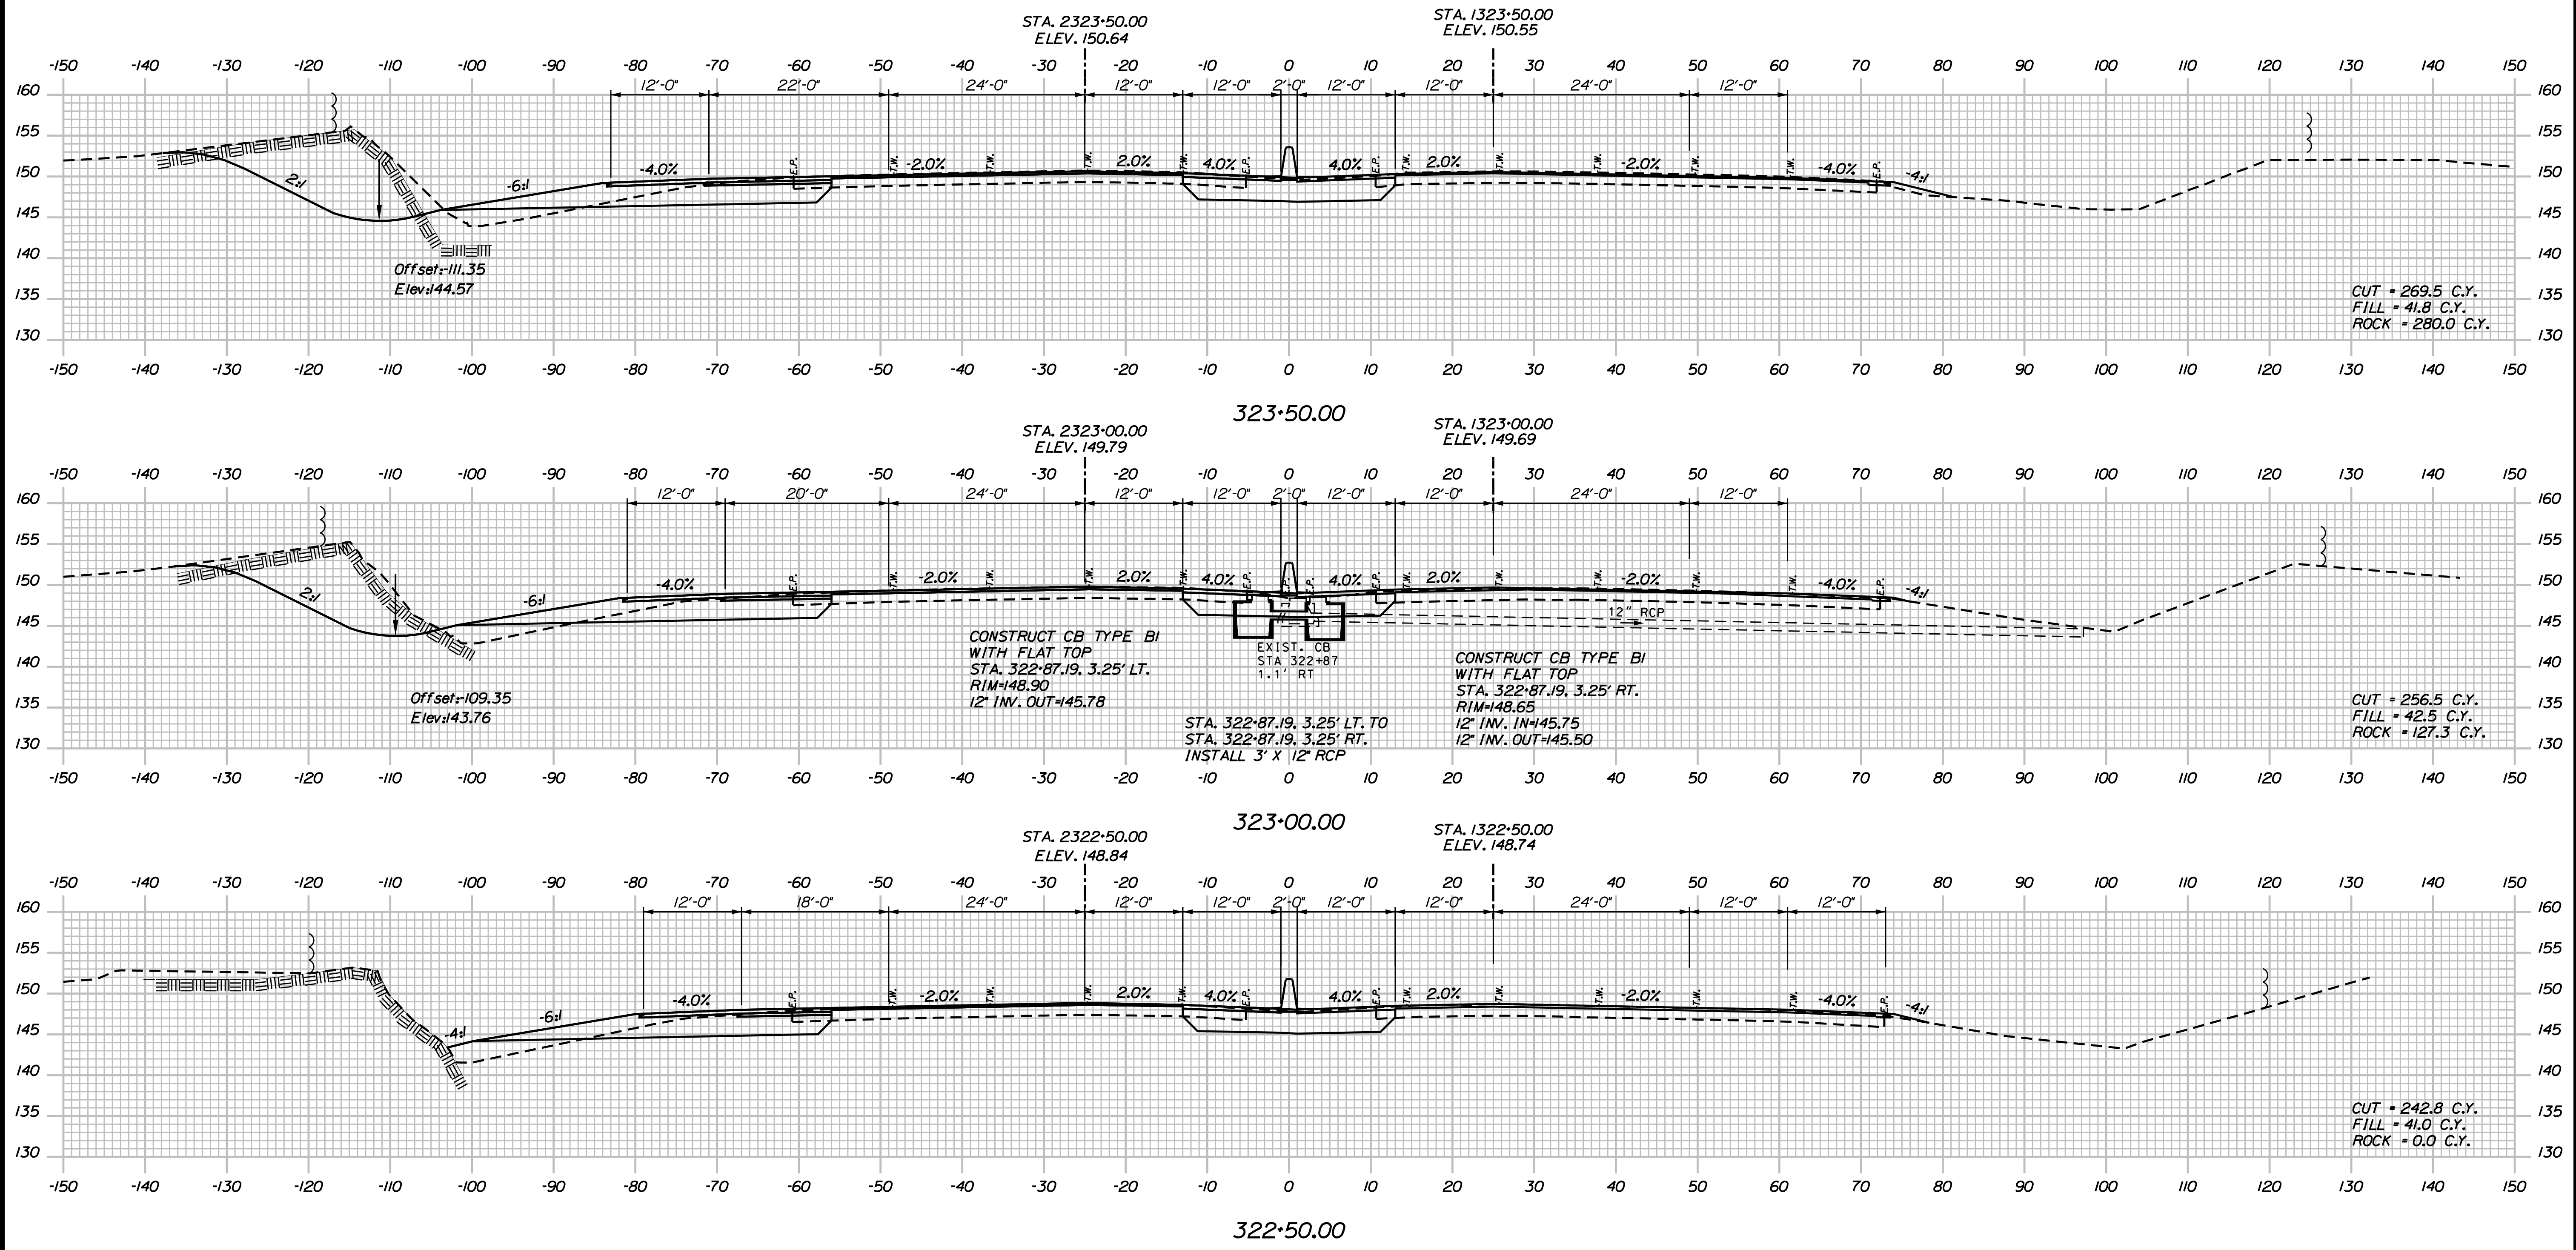

Scale:

No.	Revision	By	Date

Designed by:

JACOBS

CONSULTANT PROJECT MANAGER: T. MORIN

	By	Date		By	Date
Designed	AMS	7-18	Checked	CSM	7-18
Drawn	SMG	7-18	In Charge of	TWM	7-18

JACOBS ENGINEERING GROUP
 120 ST. JAMES AVENUE
 BOSTON, MA 02116
 TEL (617) 242-9222
 FAX (617) 242-9824

THE GOLD STAR MEMORIAL HIGHWAY

MTA PROJECT MANAGER: R. NORWOOD

YORK TOLL PLAZA

I-95 CROSS SECTIONS
 STA. 322+50 TO STA. 333+50


SHEET NUMBER: XS-14

CONTRACT: 2018.20

212 OF 489

Date: 8/28/2018

Filename: ...02596371\sect12_195.dgn

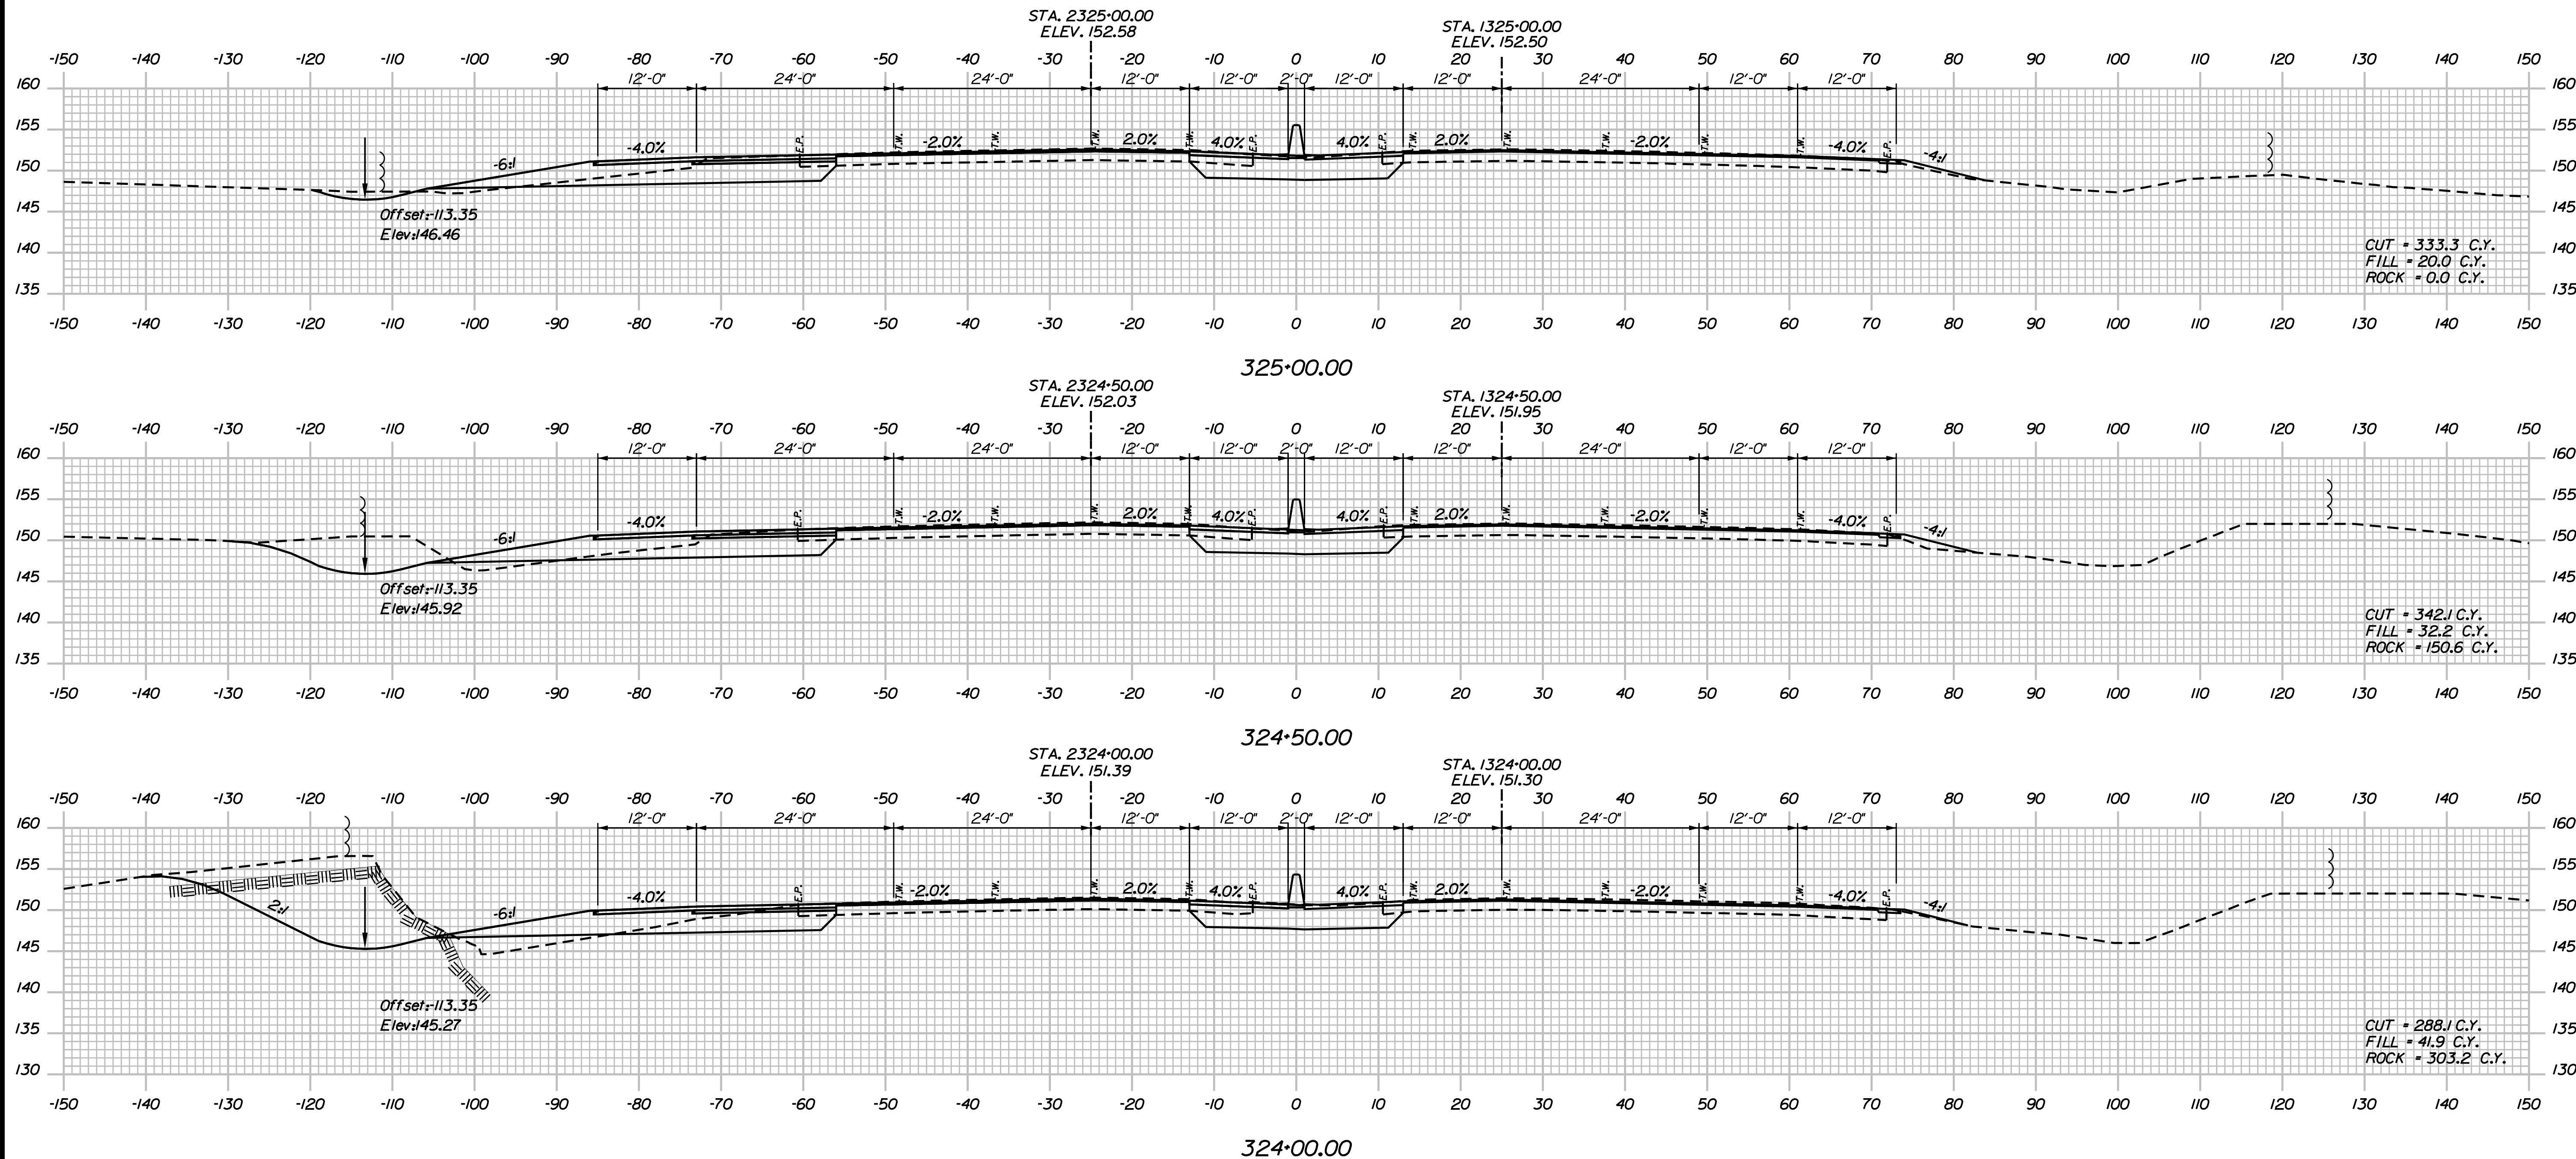

Scale: Scale of Feet

No.	Revision	By	Date

Designed by:

JACOBS

CONSULTANT PROJECT MANAGER: T. MORIN

	By	Date		By	Date
Designed	AMS	7-18	Checked	CSM	7-18
Drawn	SMG	7-18	In Charge of	TWM	7-18

JACOBS ENGINEERING GROUP
 120 ST. JAMES AVENUE
 BOSTON, MA 02116
 TEL (617) 242-9222
 FAX (617) 242-9824

MAINE TURNPIKE

THE GOLD STAR MEMORIAL HIGHWAY

MTA PROJECT MANAGER: R. NORWOOD

YORK TOLL PLAZA

I-95 CROSS SECTIONS
 STA. 324+00 TO STA. 325+00


SHEET NUMBER: XS-15

CONTRACT: 2018.20

213 OF 489

Date: 8/28/2018

Filename: ...02596371\Xsect12_195.dgn

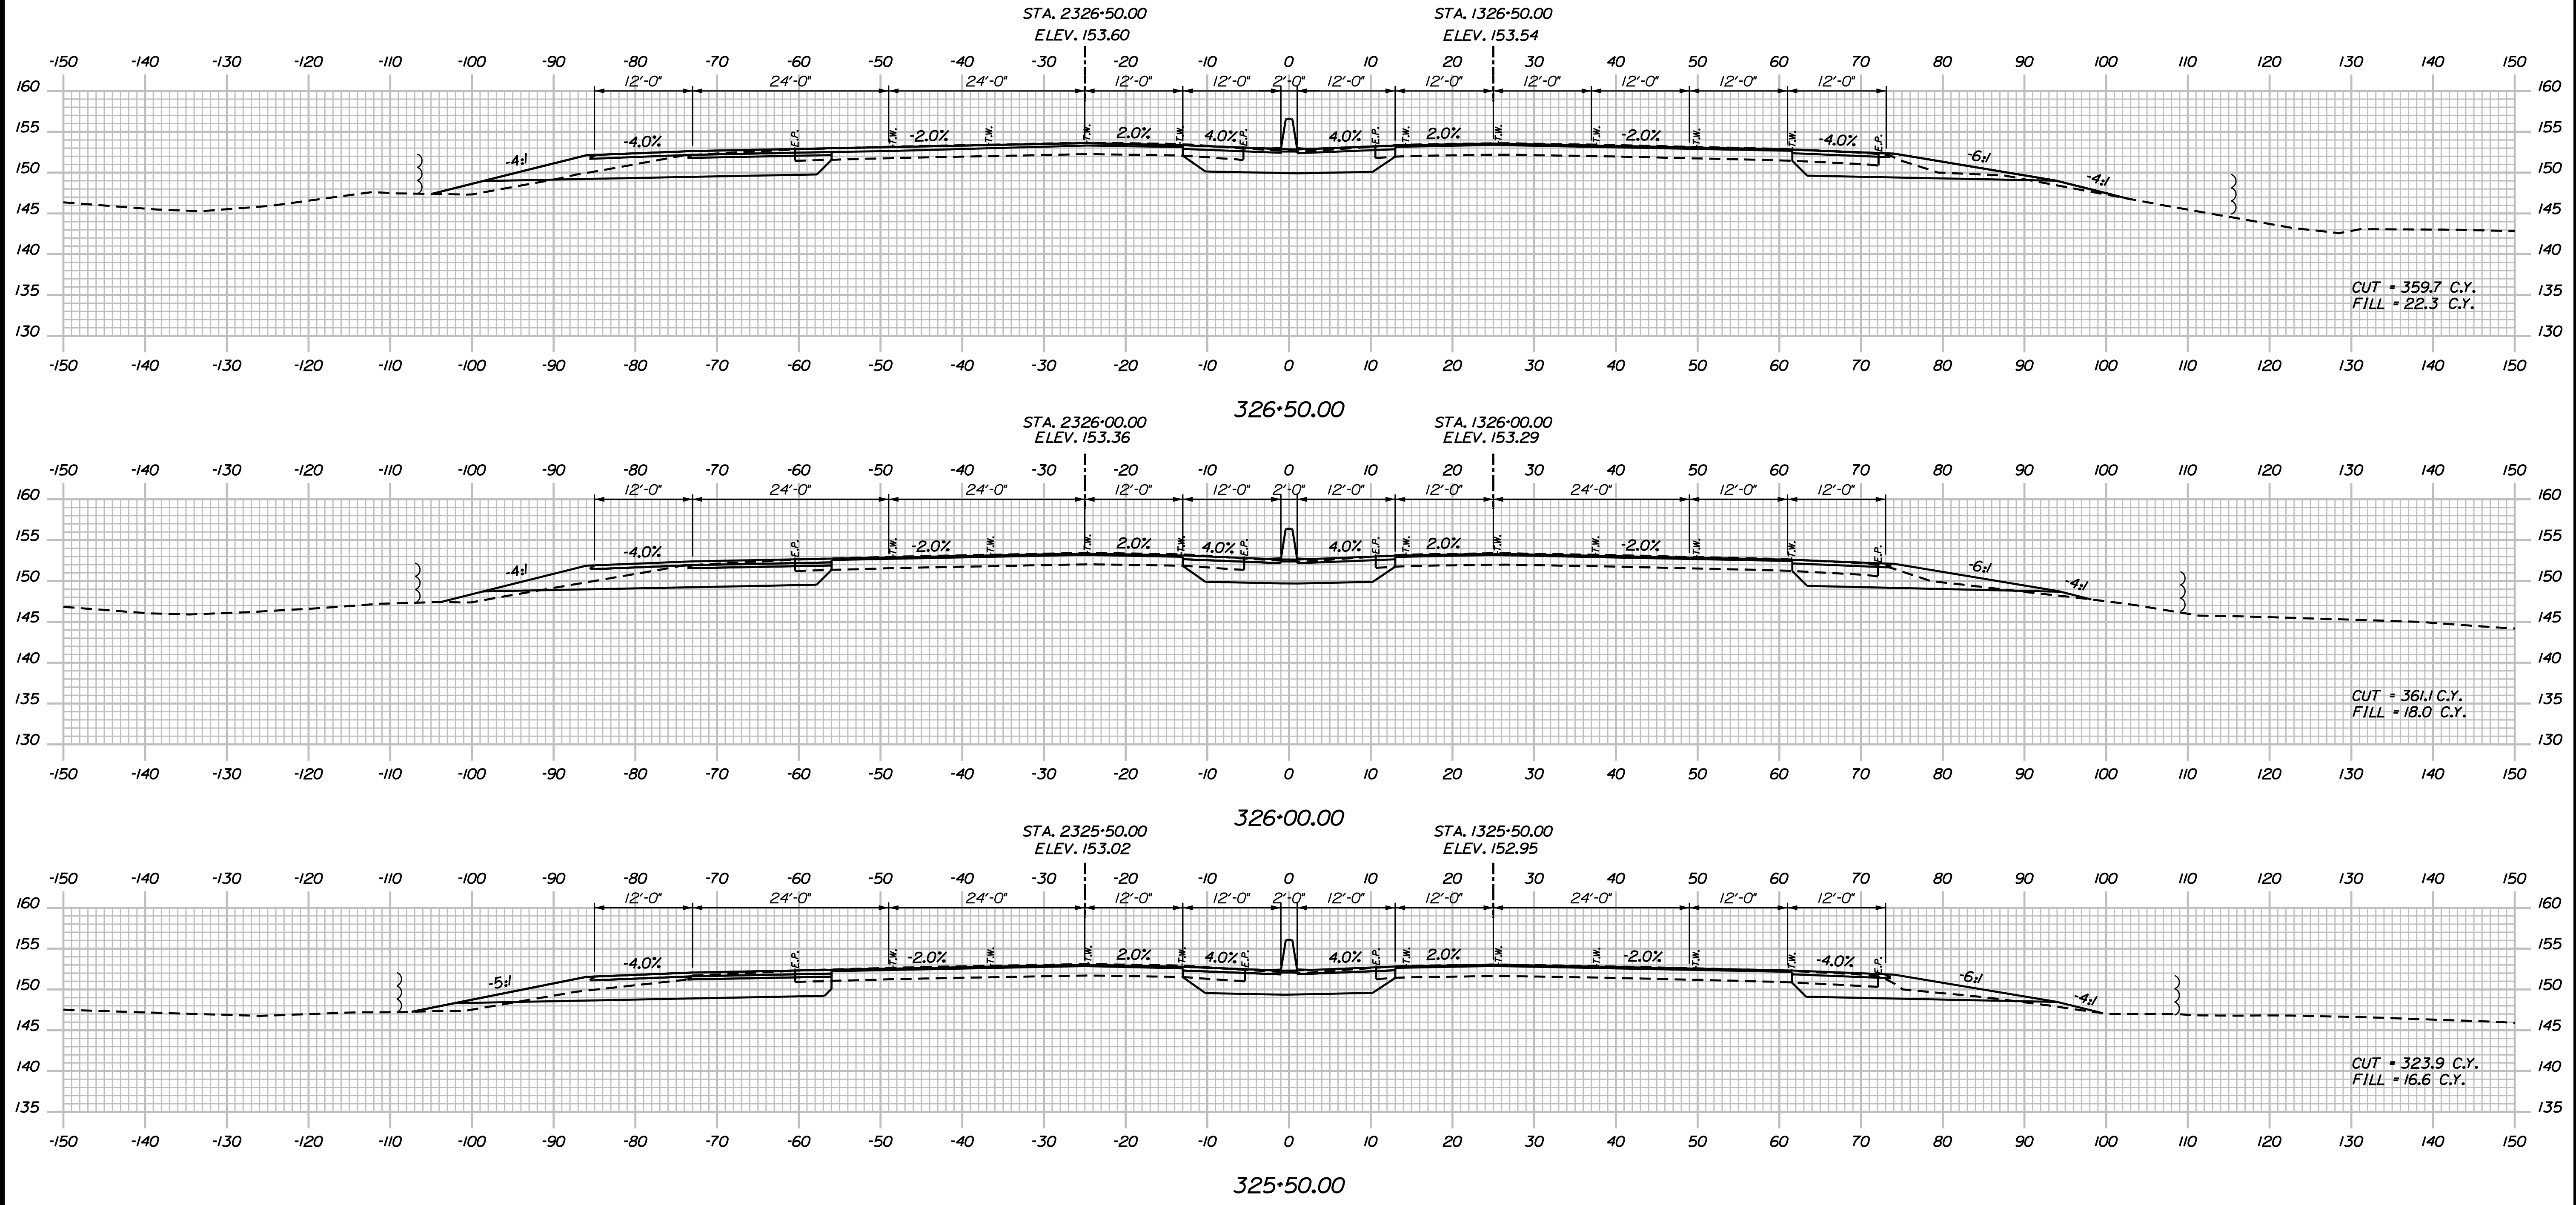

Scale: Scale of Feet

No.	Revision	By	Date

Designed by:

JACOBS

CONSULTANT PROJECT MANAGER: T. MORIN

	By	Date		By	Date
Designed	AMS	7-18	Checked	CSM	7-18
Drawn	SMG	7-18	In Charge of	TWM	7-18

JACOBS ENGINEERING GROUP
 120 ST. JAMES AVENUE
 BOSTON, MA 02116
 TEL (617) 242-9222
 FAX (617) 242-9824

MAINE TURNPIKE

THE GOLD STAR MEMORIAL HIGHWAY

MTA PROJECT MANAGER: R. NORWOOD

YORK TOLL PLAZA

I-95 CROSS SECTIONS
 STA. 325+50 TO STA. 326+50




SHEET NUMBER: XS-16

CONTRACT: 2018.20

214 OF 489

Date: 8/28/2018

Filename: ...02596371\Xsect12_195.dgn

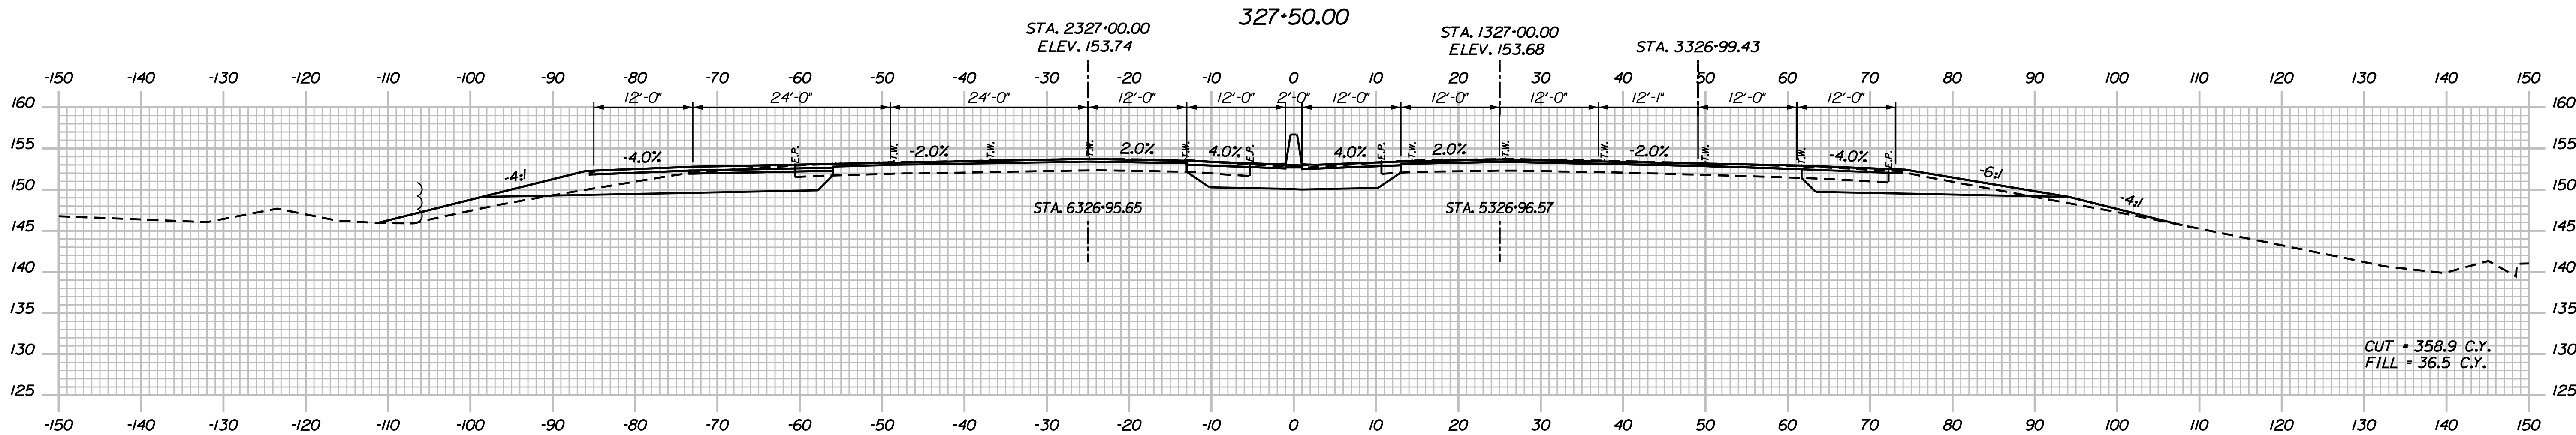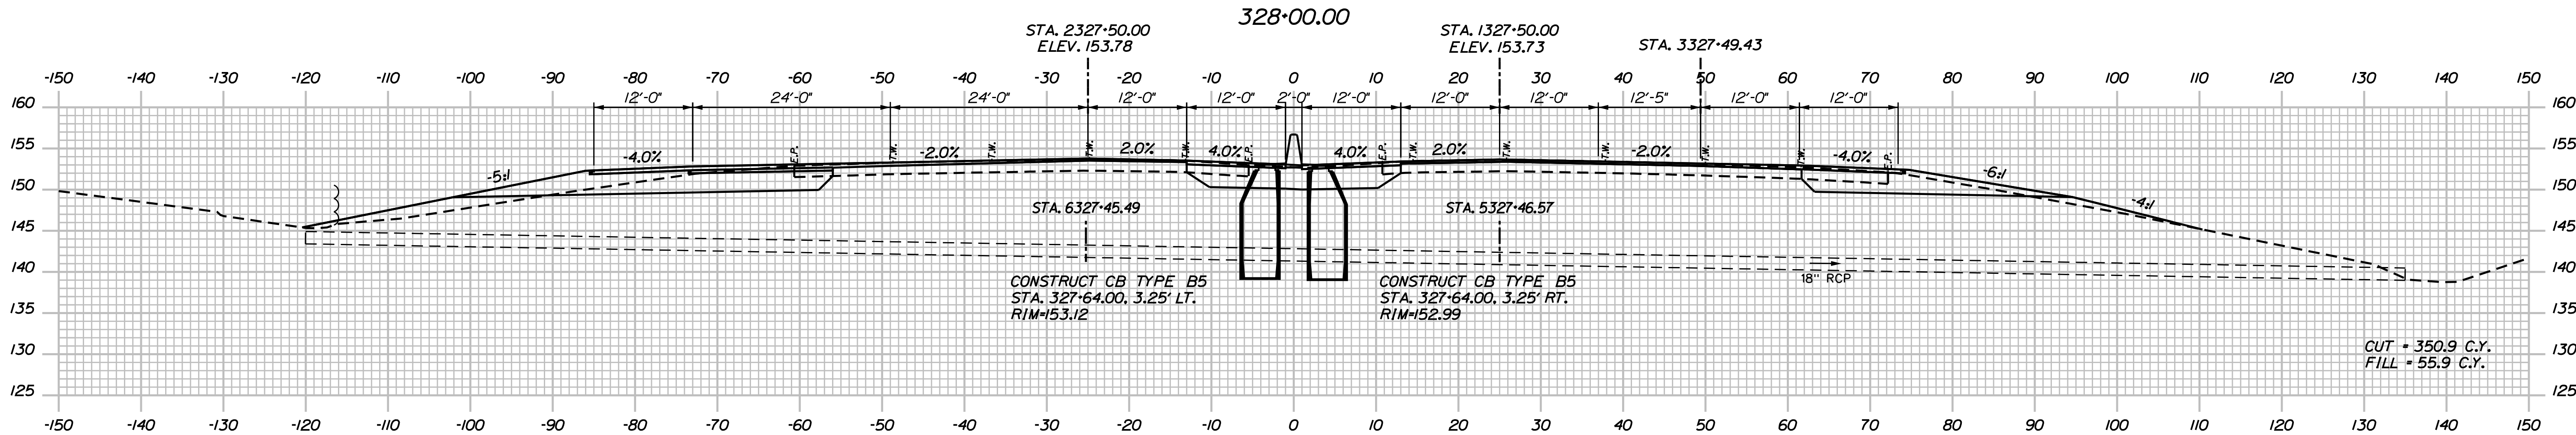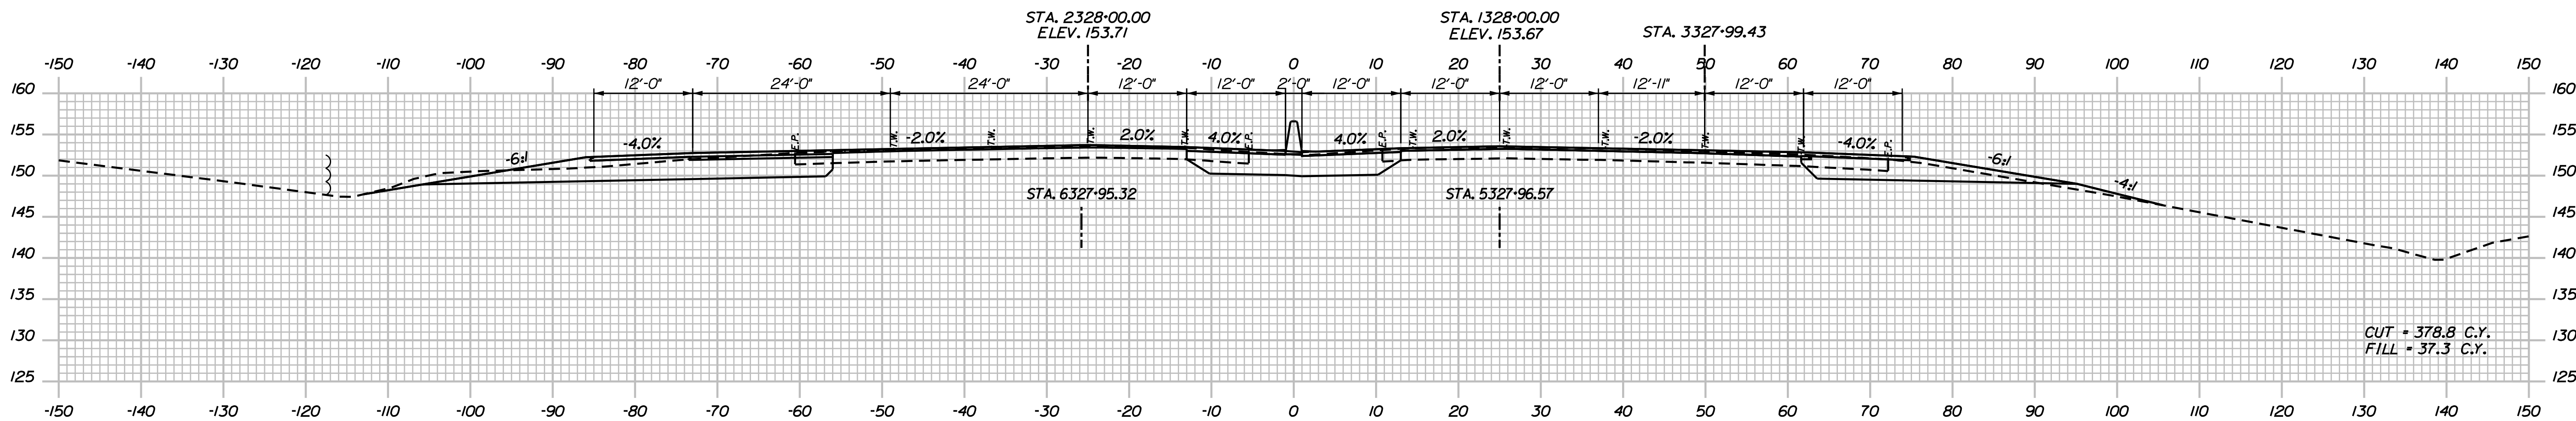

Scale: Scale of Feet

No.	Revision	By	Date

Designed by:

JACOBS

CONSULTANT PROJECT MANAGER: T. MORIN

	By	Date		By	Date
Designed	AMS	7-18	Checked	CSM	7-18
Drawn	SMG	7-18	In Charge of	TWM	7-18

JACOBS ENGINEERING GROUP
 120 ST. JAMES AVENUE
 BOSTON, MA 02116
 TEL (617) 242-9222
 FAX (617) 242-9824

THE GOLD STAR MEMORIAL HIGHWAY

MTA PROJECT MANAGER: R. NORWOOD

YORK TOLL PLAZA

I-95 CROSS SECTIONS
 STA. 327+00 TO STA. 328+00


SHEET NUMBER: XS-17

CONTRACT: 2018.20

215 OF 489

Date: 8/28/2018

Filename: ...0259637\Xsect12_195.dgn

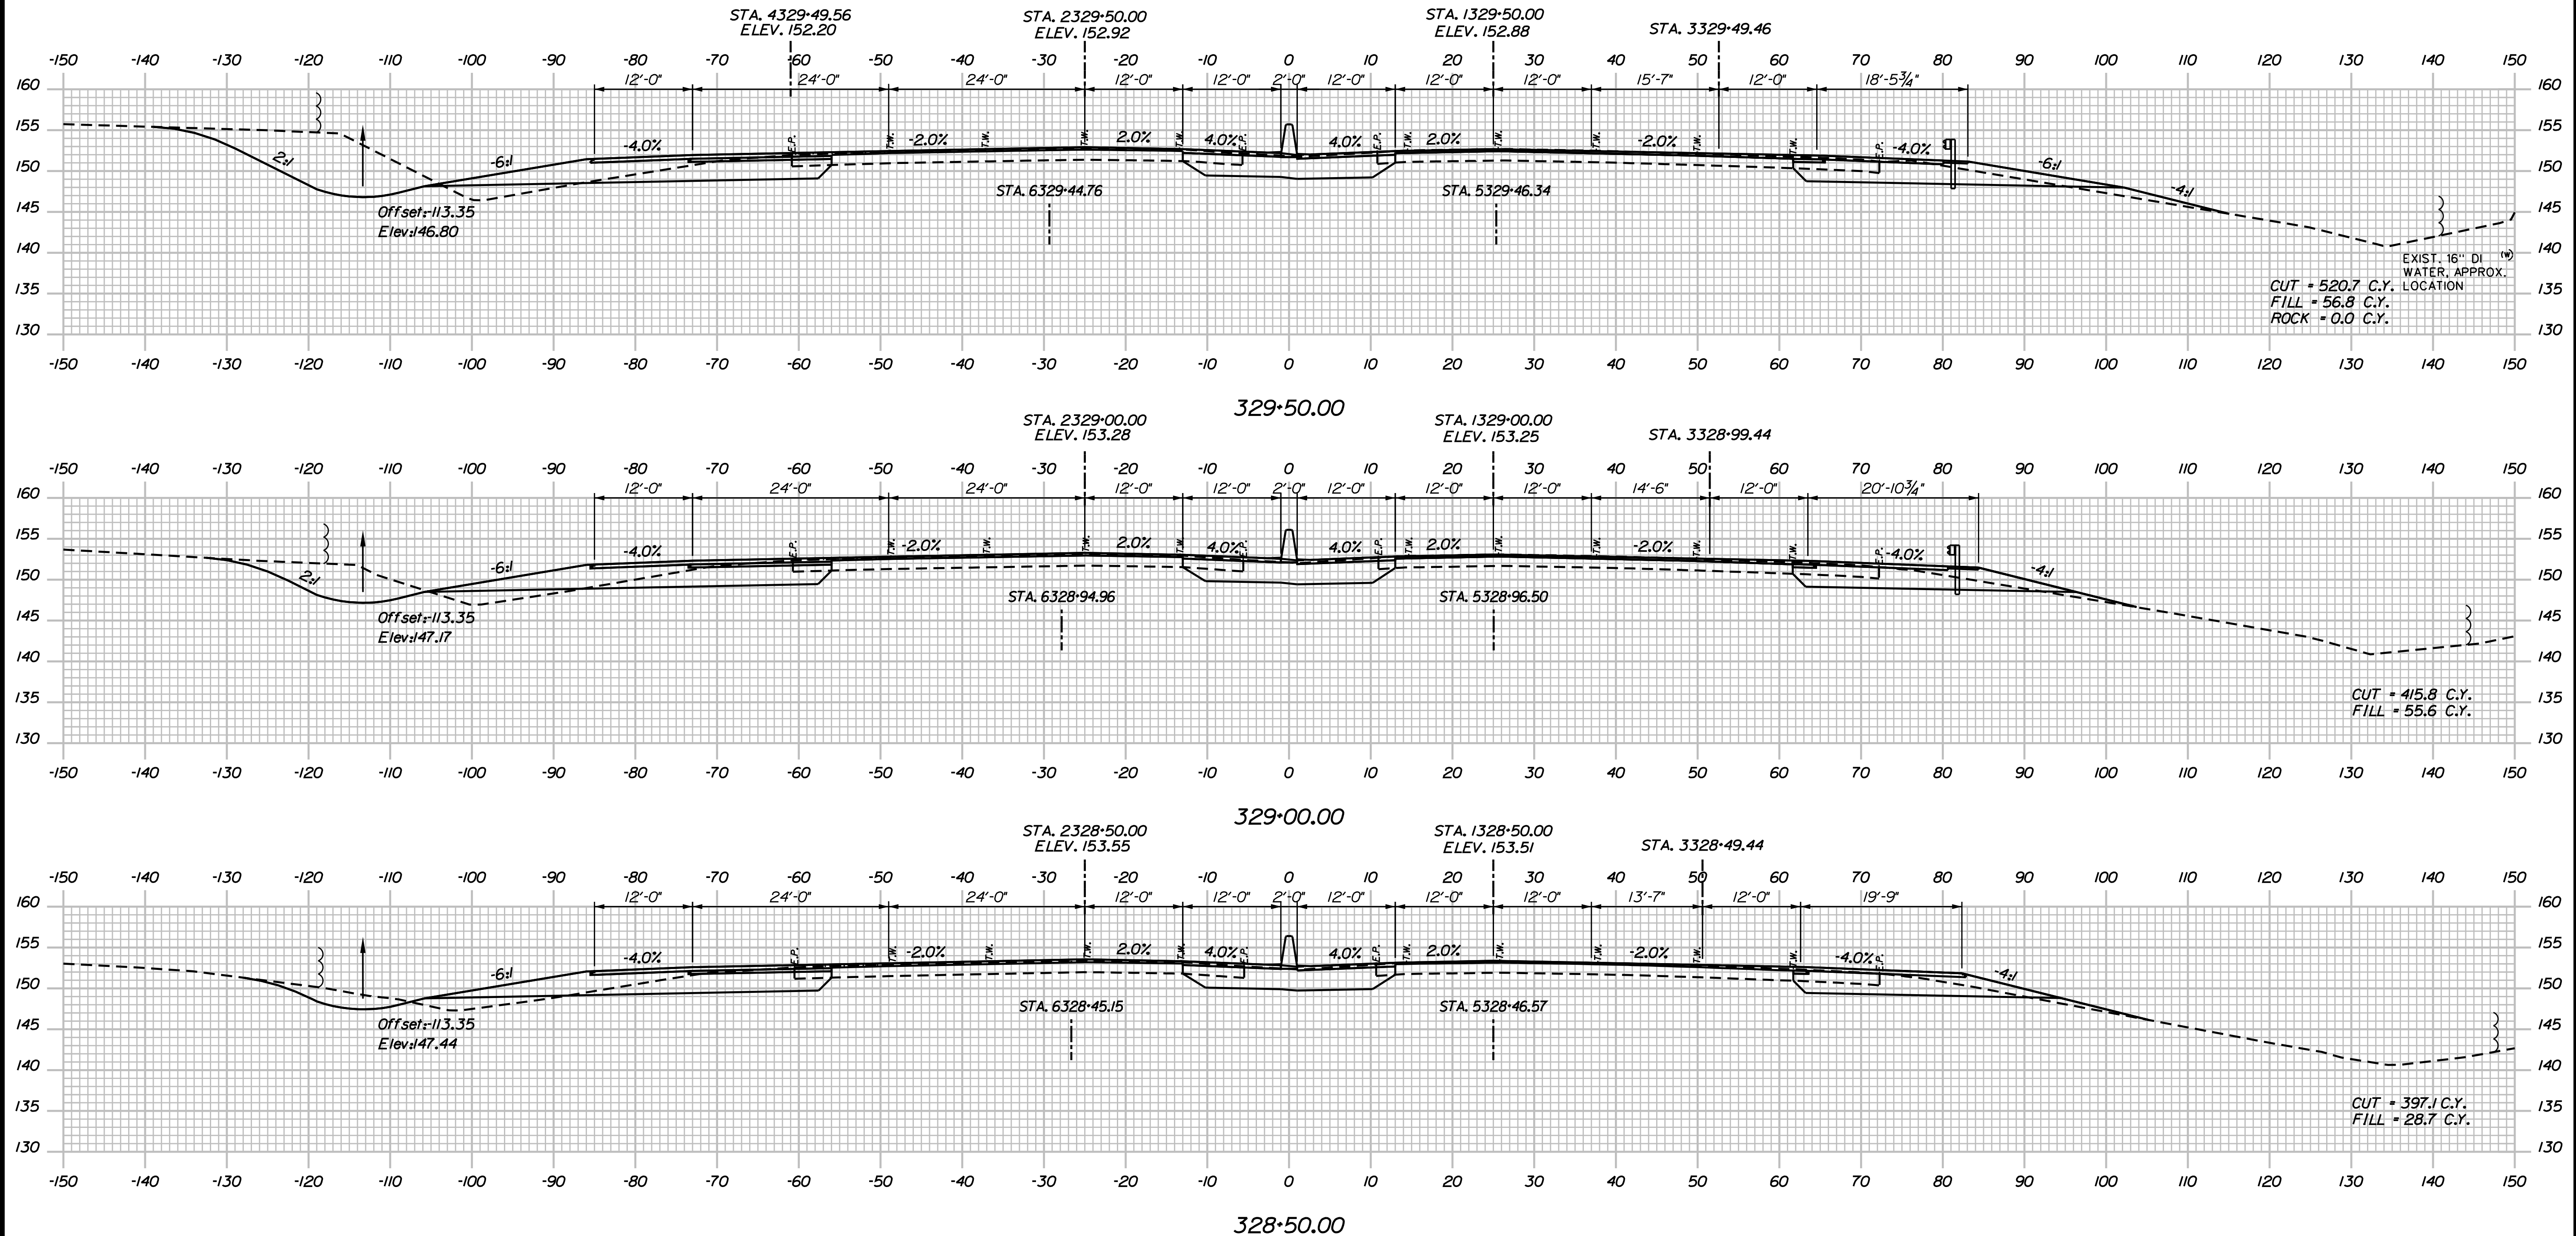

Scale:

No.	Revision	By	Date

Designed by:

JACOBS

CONSULTANT PROJECT MANAGER: T. MORIN

	By	Date		By	Date
Designed	AMS	7-18	Checked	CSM	7-18
Drawn	SMG	7-18	In Charge of	TWM	7-18

JACOBS ENGINEERING GROUP
 120 ST. JAMES AVENUE
 BOSTON, MA 02116
 TEL (617) 242-9222
 FAX (617) 242-9824

THE GOLD STAR MEMORIAL HIGHWAY

MTA PROJECT MANAGER: R. NORWOOD


YORK TOLL PLAZA

I-95 CROSS SECTIONS
 STA. 328+50 TO STA. 329+50

SHEET NUMBER: XS-18
 CONTRACT: 2018.20
 216 OF 489

Date: 8/28/2018

Filename: ...0259637\Xsect12_195.dgn

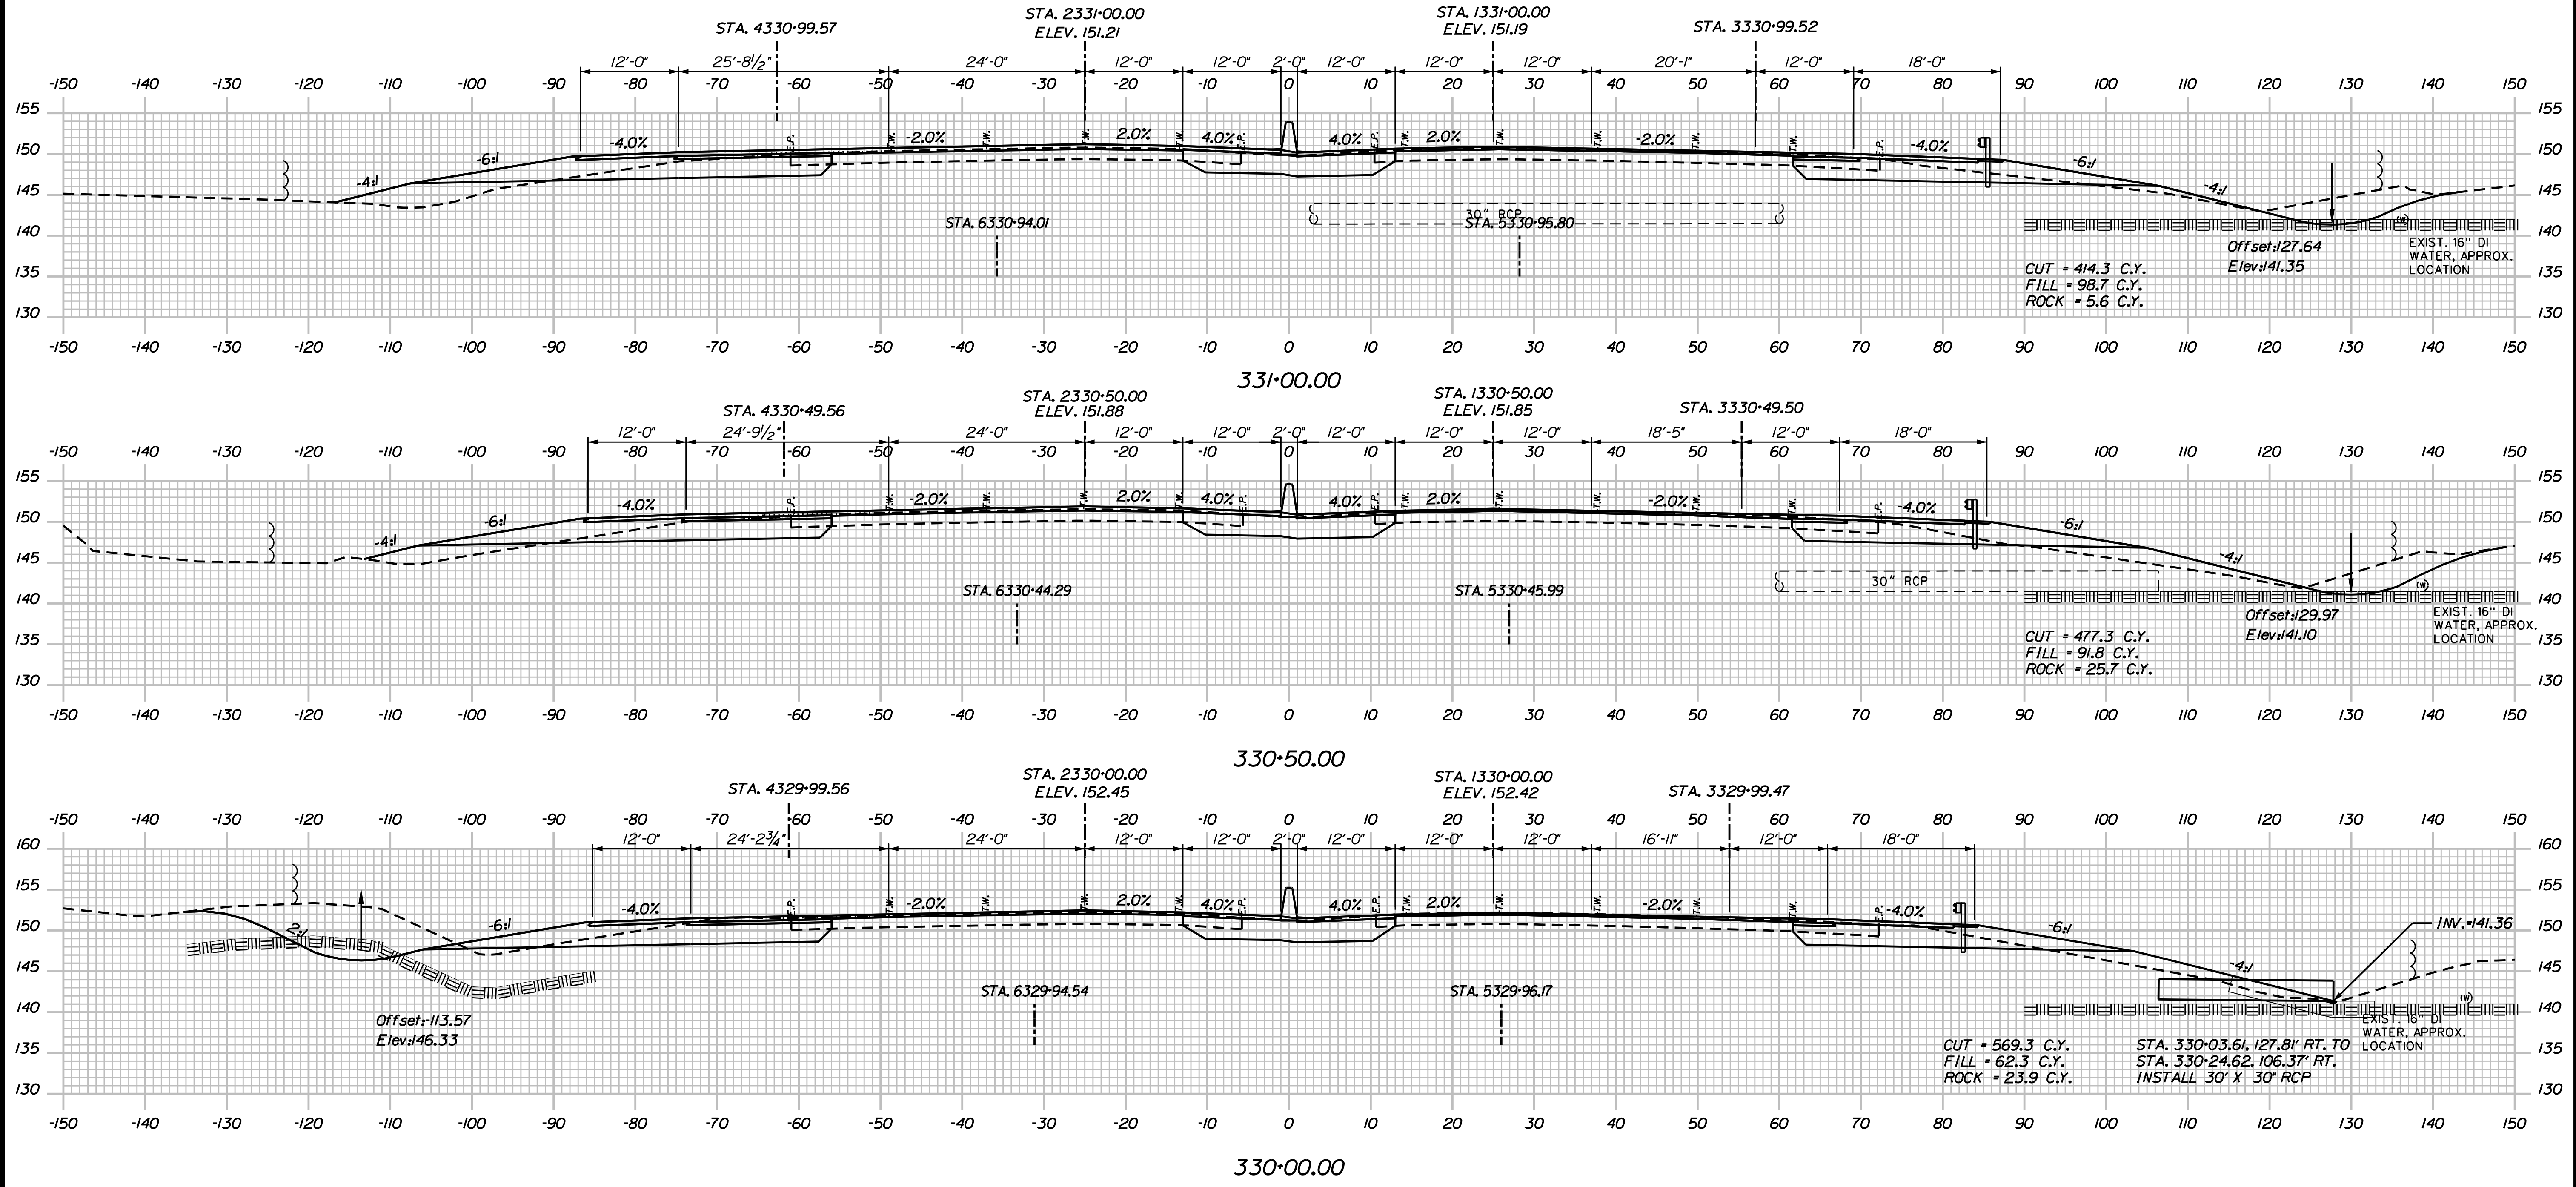

Scale:

No.	Revision	By	Date

Designed by:

JACOBS

CONSULTANT PROJECT MANAGER: T. MORIN

	By	Date		By	Date
Designed	AMS	7-18	Checked	CSM	7-18
Drawn	SMG	7-18	In Charge of	TWM	7-18

JACOBS ENGINEERING GROUP
 120 ST. JAMES AVENUE
 BOSTON, MA 02116
 TEL (617) 242-9222
 FAX (617) 242-9824

THE GOLD STAR
MEMORIAL HIGHWAY

MTA PROJECT MANAGER: R. NORWOOD

YORK TOLL PLAZA

I-95 CROSS SECTIONS
 STA. 330+00 TO STA. 331+00


SHEET NUMBER: XS-19

CONTRACT: 2018.20

217 OF 489

Date: 8/28/2018

Filename: ...0259637\Xsect12_195.dgn

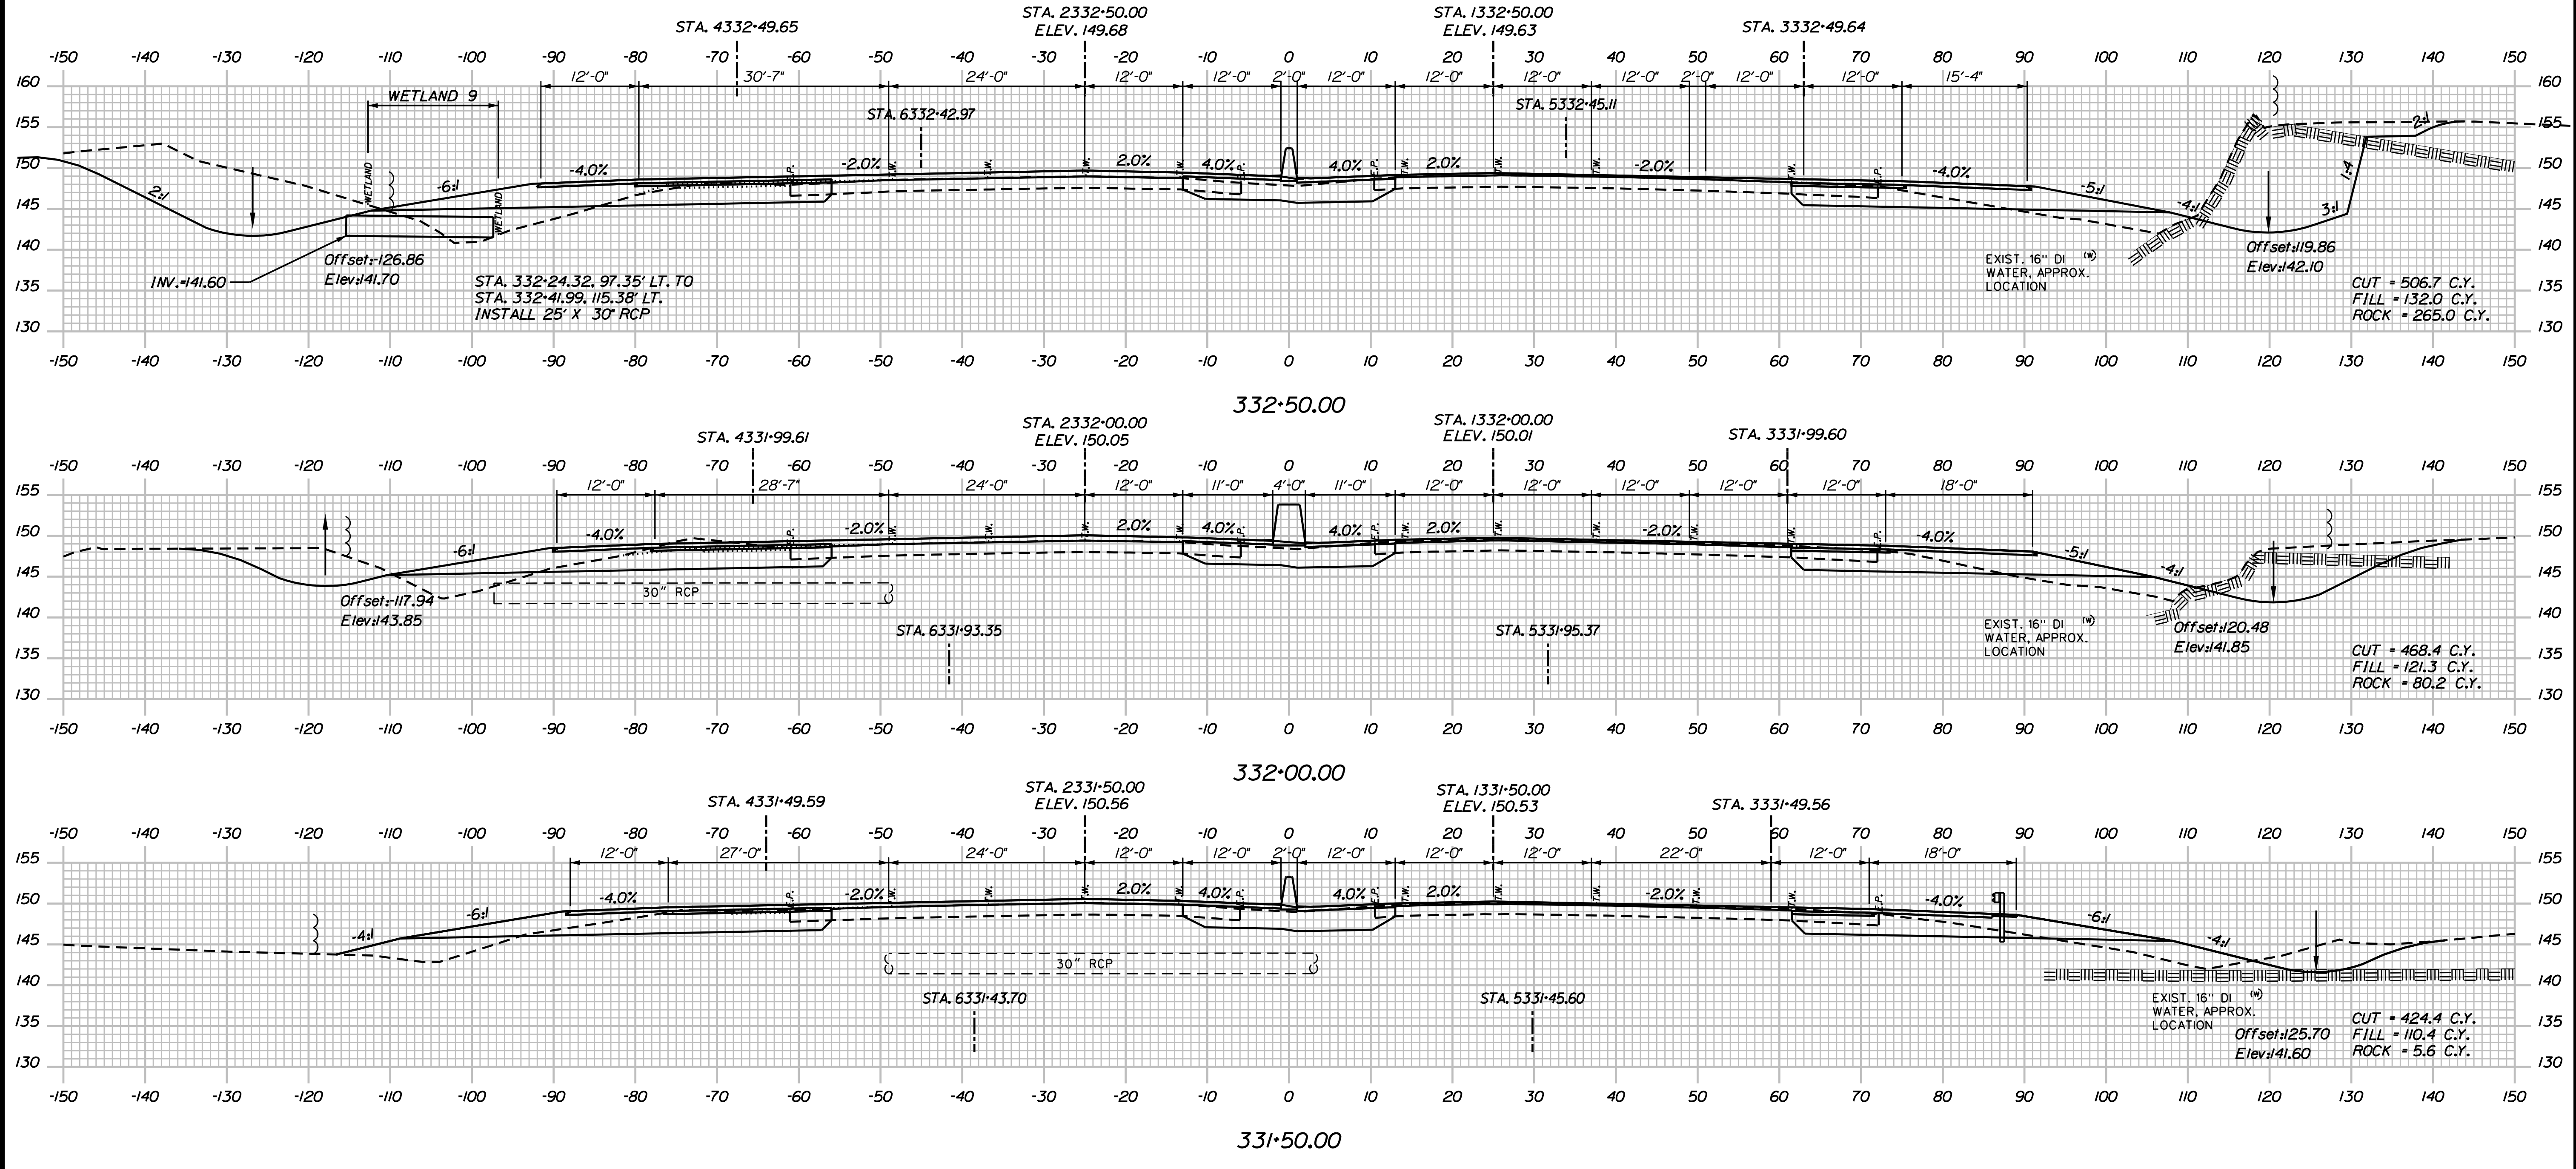

Scale:

No.	Revision	By	Date

Designed by:

JACOBS

CONSULTANT PROJECT MANAGER: T. MORIN

	By	Date		By	Date
Designed	AMS	7-18	Checked	CSM	7-18
Drawn	SMG	7-18	In Charge of	TWM	7-18

JACOBS ENGINEERING GROUP
 120 ST. JAMES AVENUE
 BOSTON, MA 02116
 TEL (617) 242-9222
 FAX (617) 242-9824

THE GOLD STAR MEMORIAL HIGHWAY

MTA PROJECT MANAGER: R. NORWOOD


YORK TOLL PLAZA

I-95 CROSS SECTIONS
 STA. 331+50 TO STA. 332+50

SHEET NUMBER: XS-20
 CONTRACT: 2018.20
 218 OF 489

Date: 8/28/2018

Filename: ...00259637\Xsect\2a_195.dgn

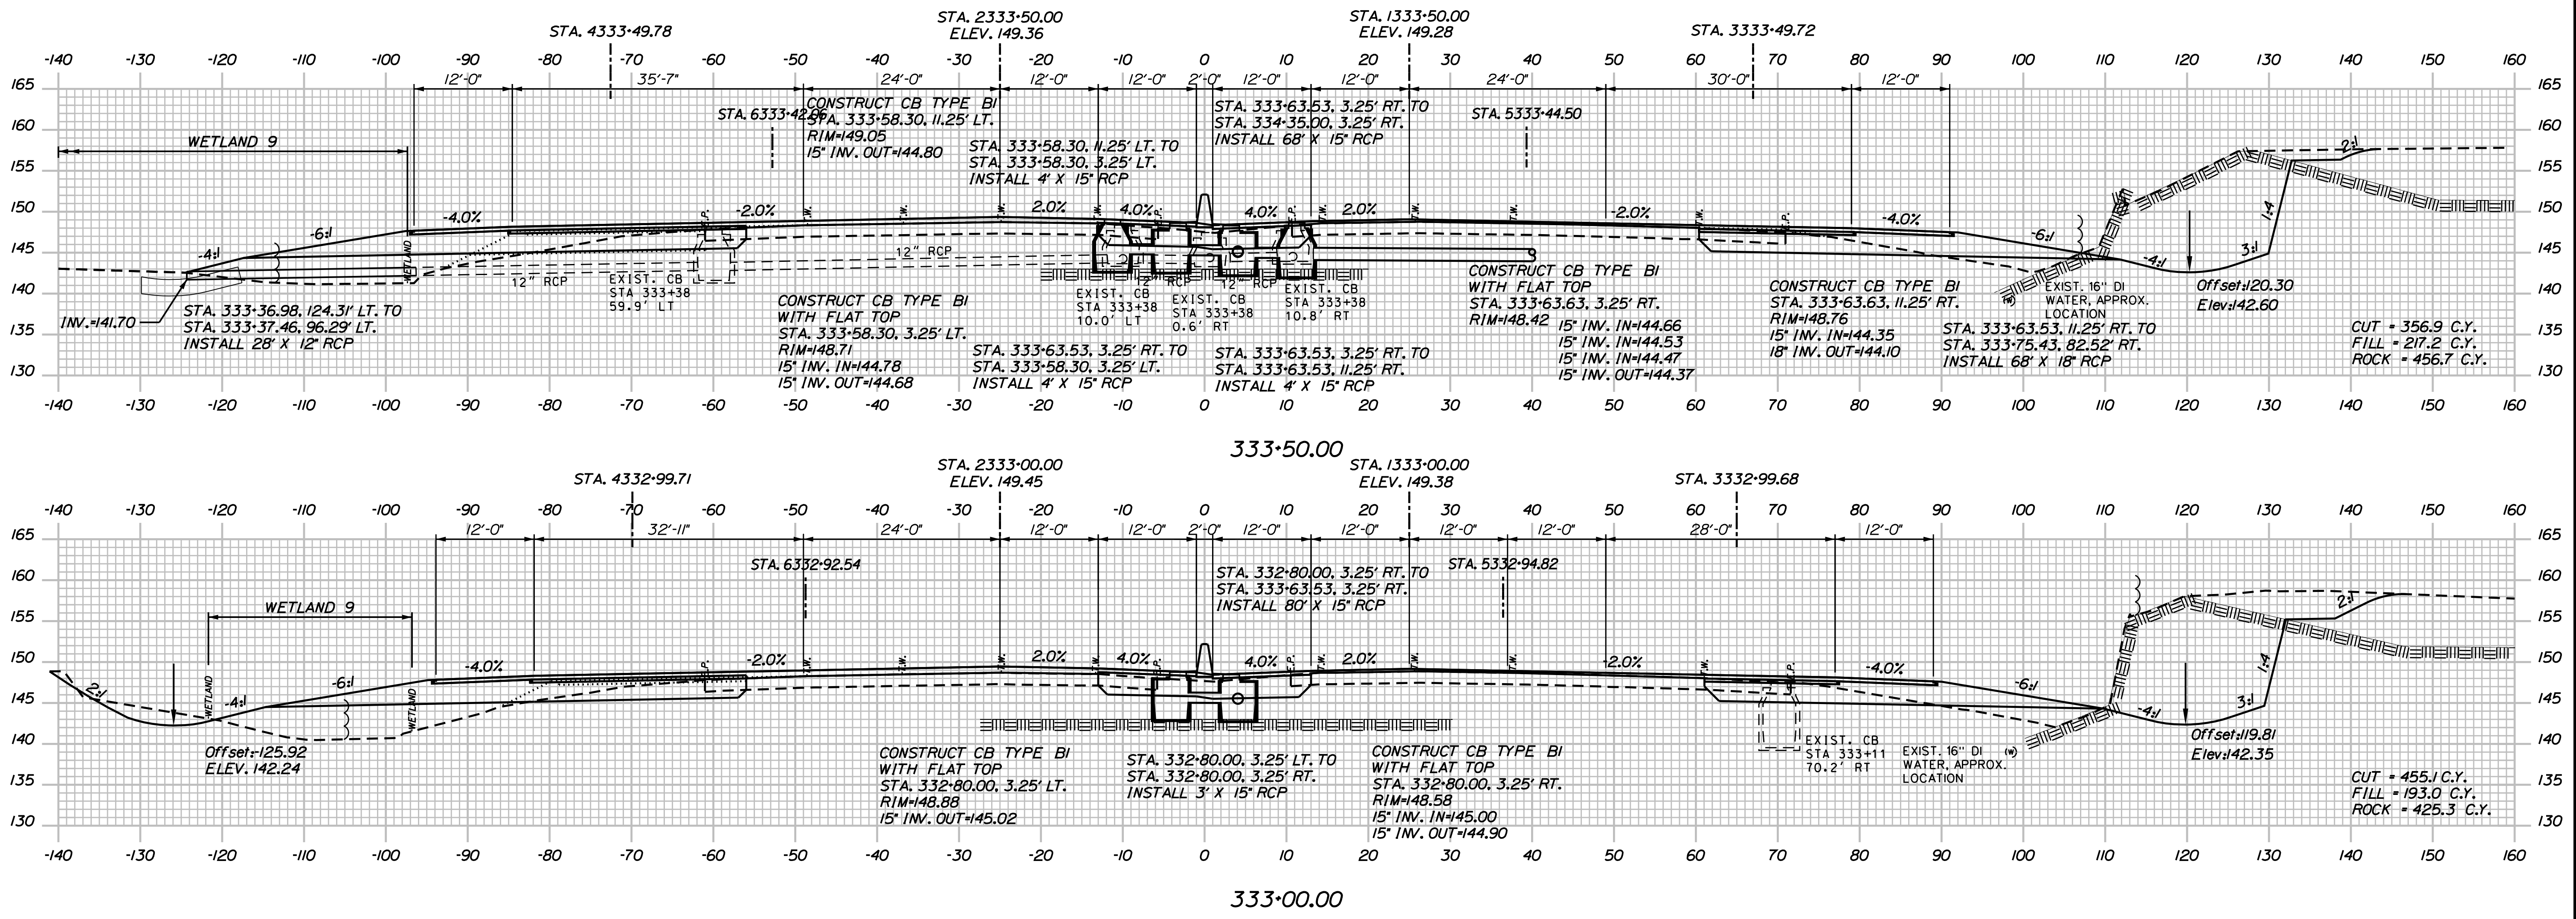

Scale:

No.	Revision	By	Date

Designed by:

JACOBS

CONSULTANT PROJECT MANAGER: T. MORIN

	By	Date		By	Date
Designed	AMS	7-18	Checked	CSM	7-18
Drawn	SMG	7-18	In Charge of	TWM	7-18

JACOBS ENGINEERING GROUP
 120 ST. JAMES AVENUE
 BOSTON, MA 02116
 TEL (617) 242-9222
 FAX (617) 242-9824

**THE GOLD STAR
 MEMORIAL HIGHWAY**

MTA PROJECT MANAGER: R. NORWOOD

YORK TOLL PLAZA



I-95 CROSS SECTIONS
 STA. 333+00 TO STA. 333+50

SHEET NUMBER: XS-21

CONTRACT: 2018.20 219 OF 489

Date: 8/28/2018

Filename: ...0259637\Xsect\2a_195.dgn

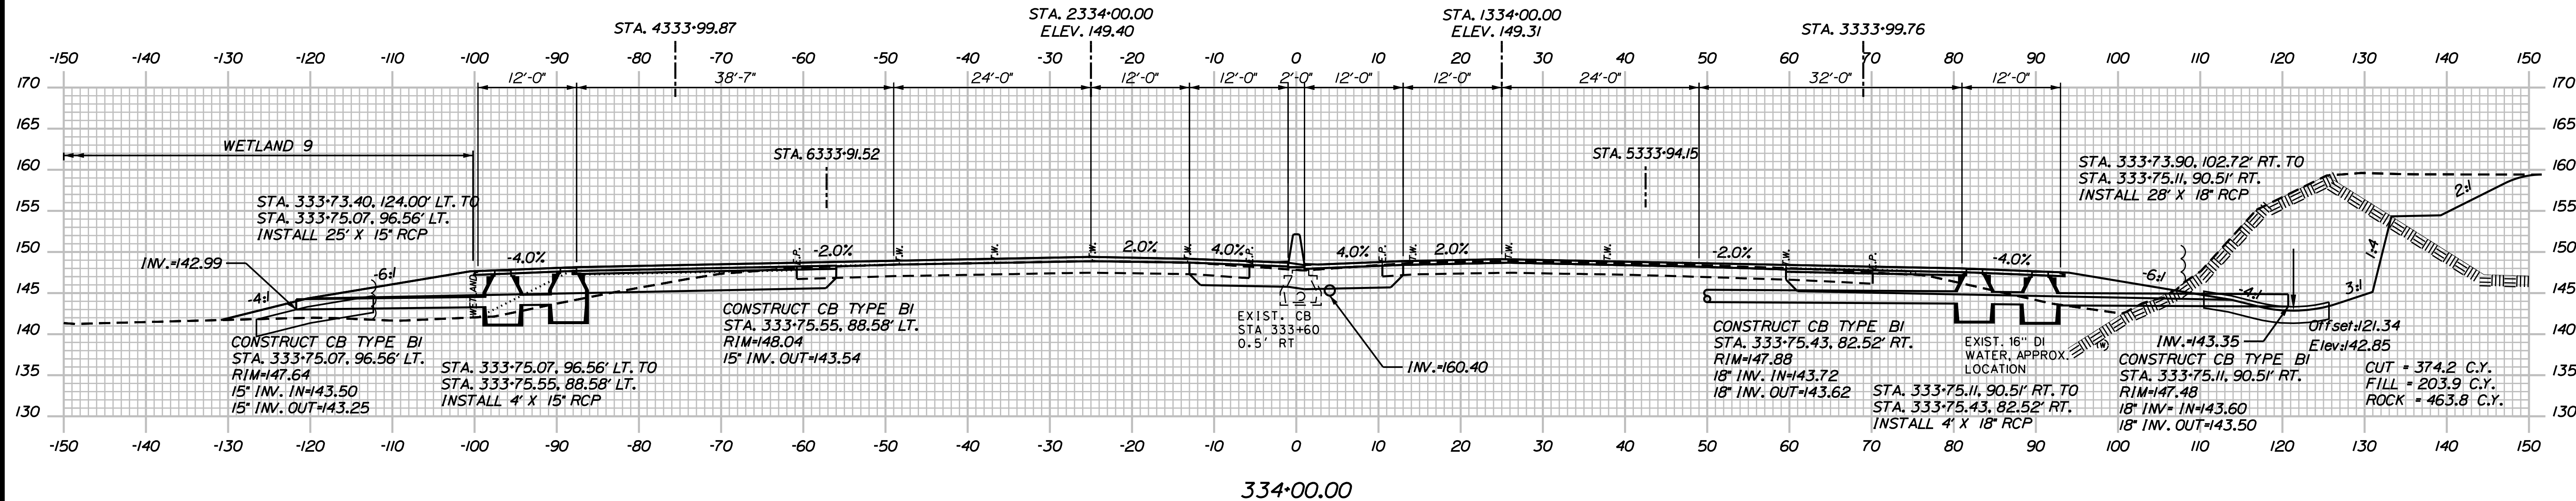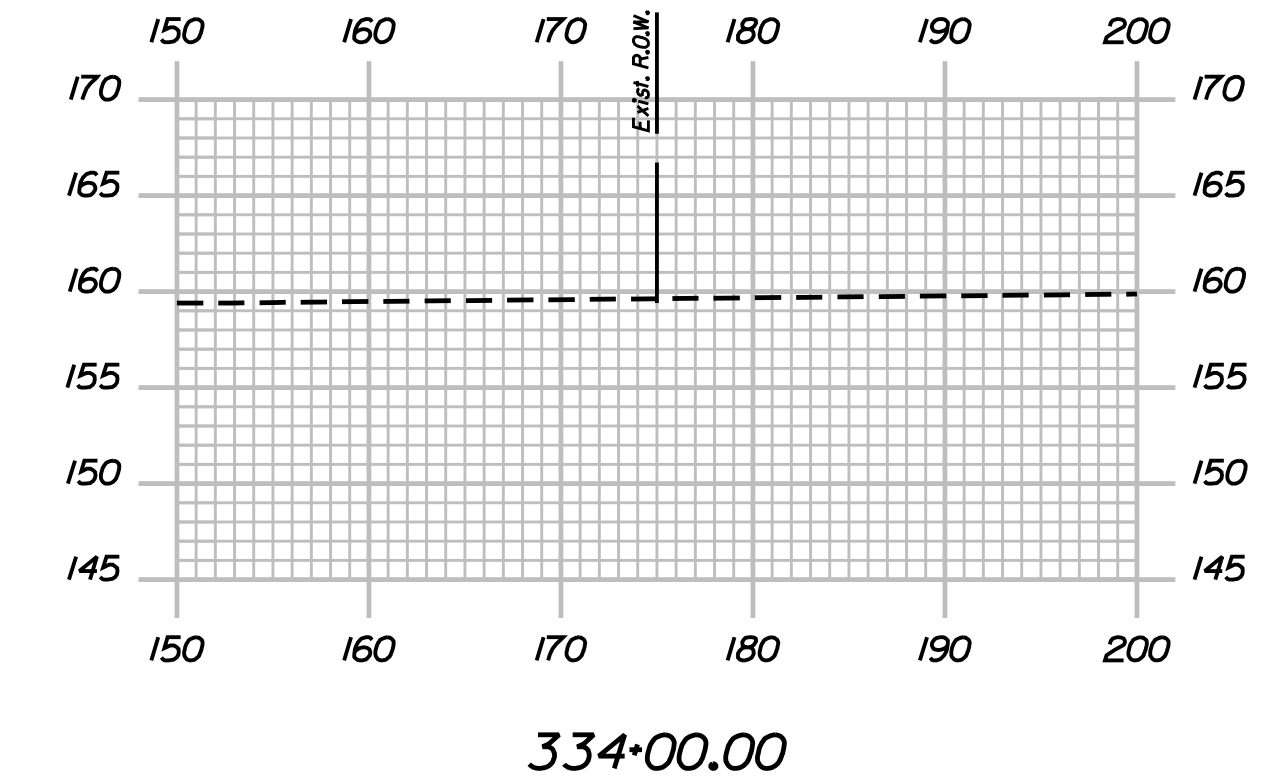

Scale:

No.	Revision	By	Date

Designed by:

JACOBS

CONSULTANT PROJECT MANAGER: T. MORIN

	By	Date		By	Date
Designed	AMS	7-18	Checked	CSM	7-18
Drawn	SMG	7-18	In Charge of	TWM	7-18

JACOBS ENGINEERING GROUP
 120 ST. JAMES AVENUE
 BOSTON, MA 02116
 TEL (617) 242-9222
 FAX (617) 242-9824

THE GOLD STAR MEMORIAL HIGHWAY

MTA PROJECT MANAGER: R. NORWOOD

YORK TOLL PLAZA


I-95 CROSS SECTIONS
STA. 334+00

SHEET NUMBER: XS-22
220 OF 489


CONTRACT: 2018.20

Date: 8/28/2018

Filename: ...00259637\Xsect\2a_195.dgn

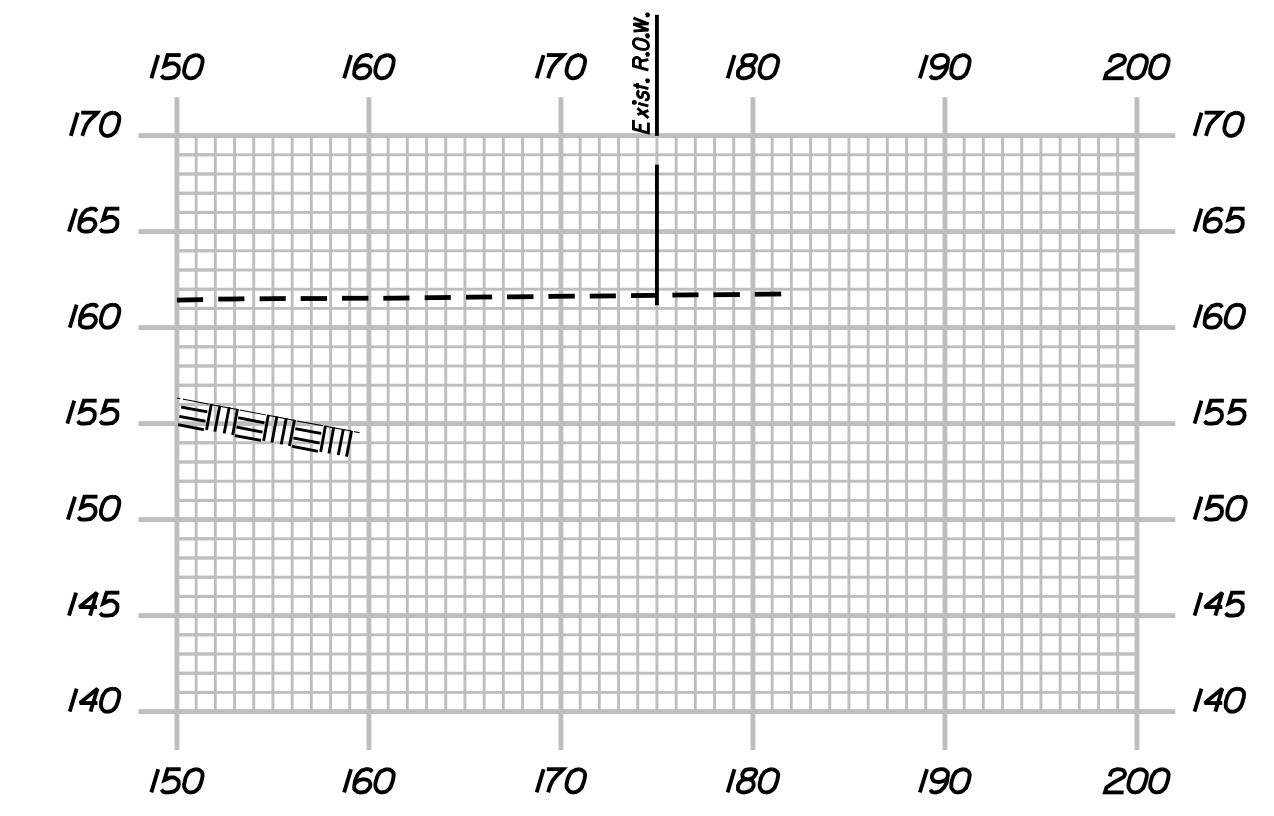

334+50.00

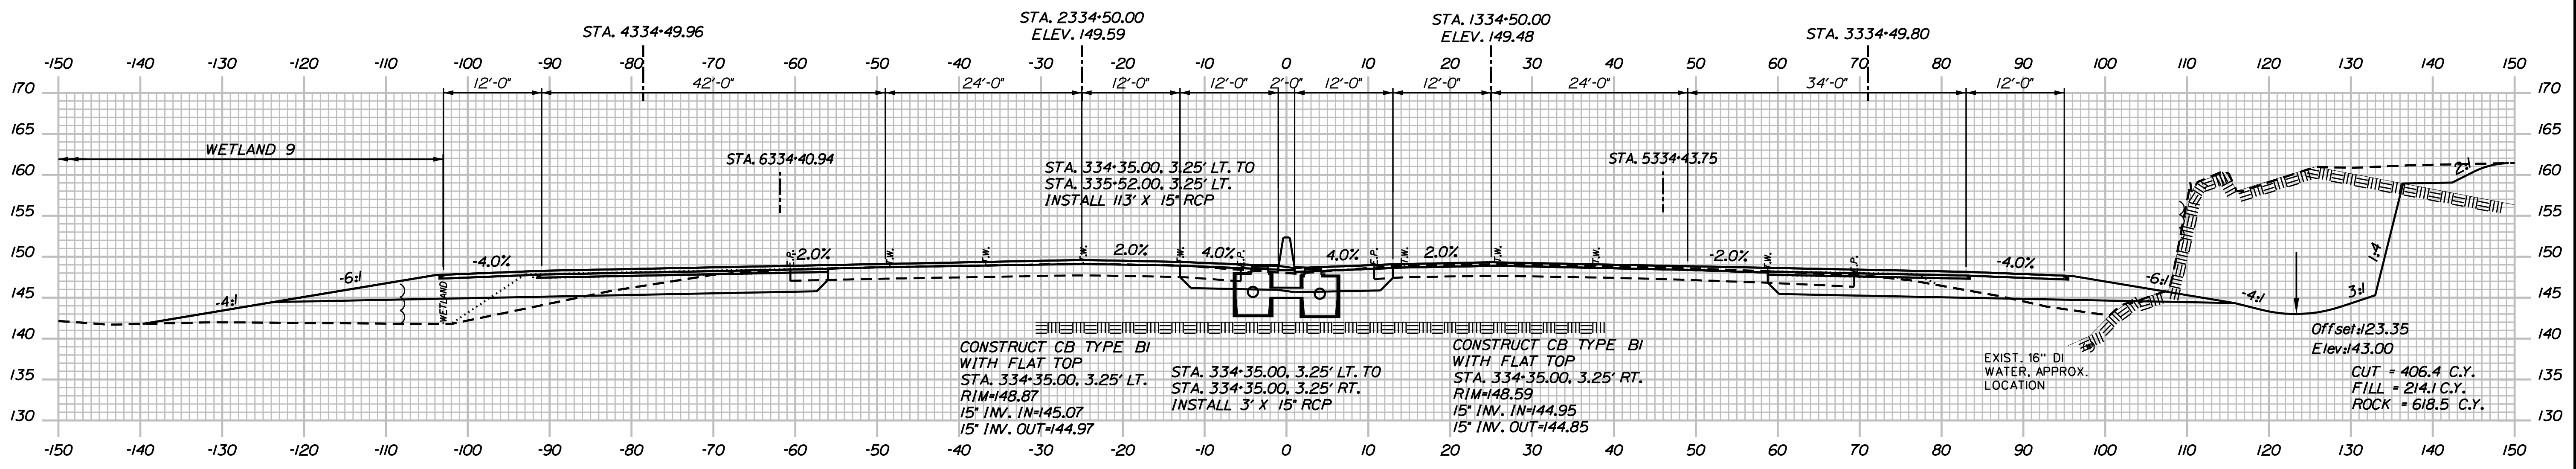

334+50.00

Scale:

No.	Revision	By	Date

Designed by:

JACOBS

CONSULTANT PROJECT MANAGER: T. MORIN

	By	Date		By	Date
Designed	AMS	7-18	Checked	CSM	7-18
Drawn	SMG	7-18	In Charge of	TWM	7-18

JACOBS ENGINEERING GROUP
 120 ST. JAMES AVENUE
 BOSTON, MA 02116
 TEL (617) 242-9222
 FAX (617) 242-9824

**THE GOLD STAR
 MEMORIAL HIGHWAY**

MTA PROJECT MANAGER: R. NORWOOD



YORK TOLL PLAZA
 I-95 CROSS SECTIONS
 STA. 334+50

SHEET NUMBER: XS-23
 221 OF 489

CONTRACT: 2018.20

Date: 8/28/2018

Filename: ... \02596371\Xsect\2a_195.dgn

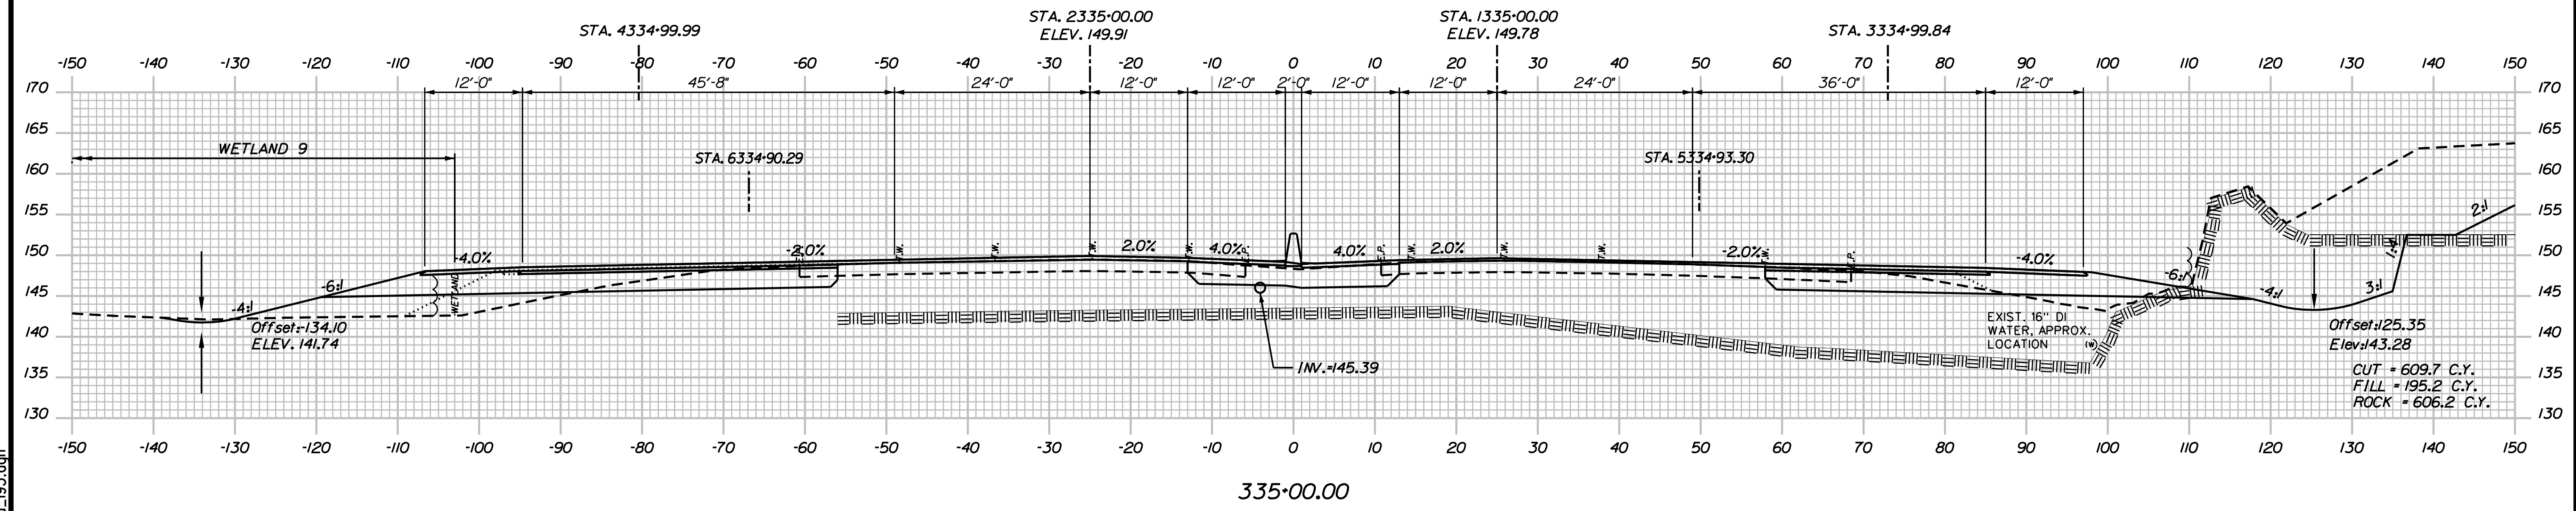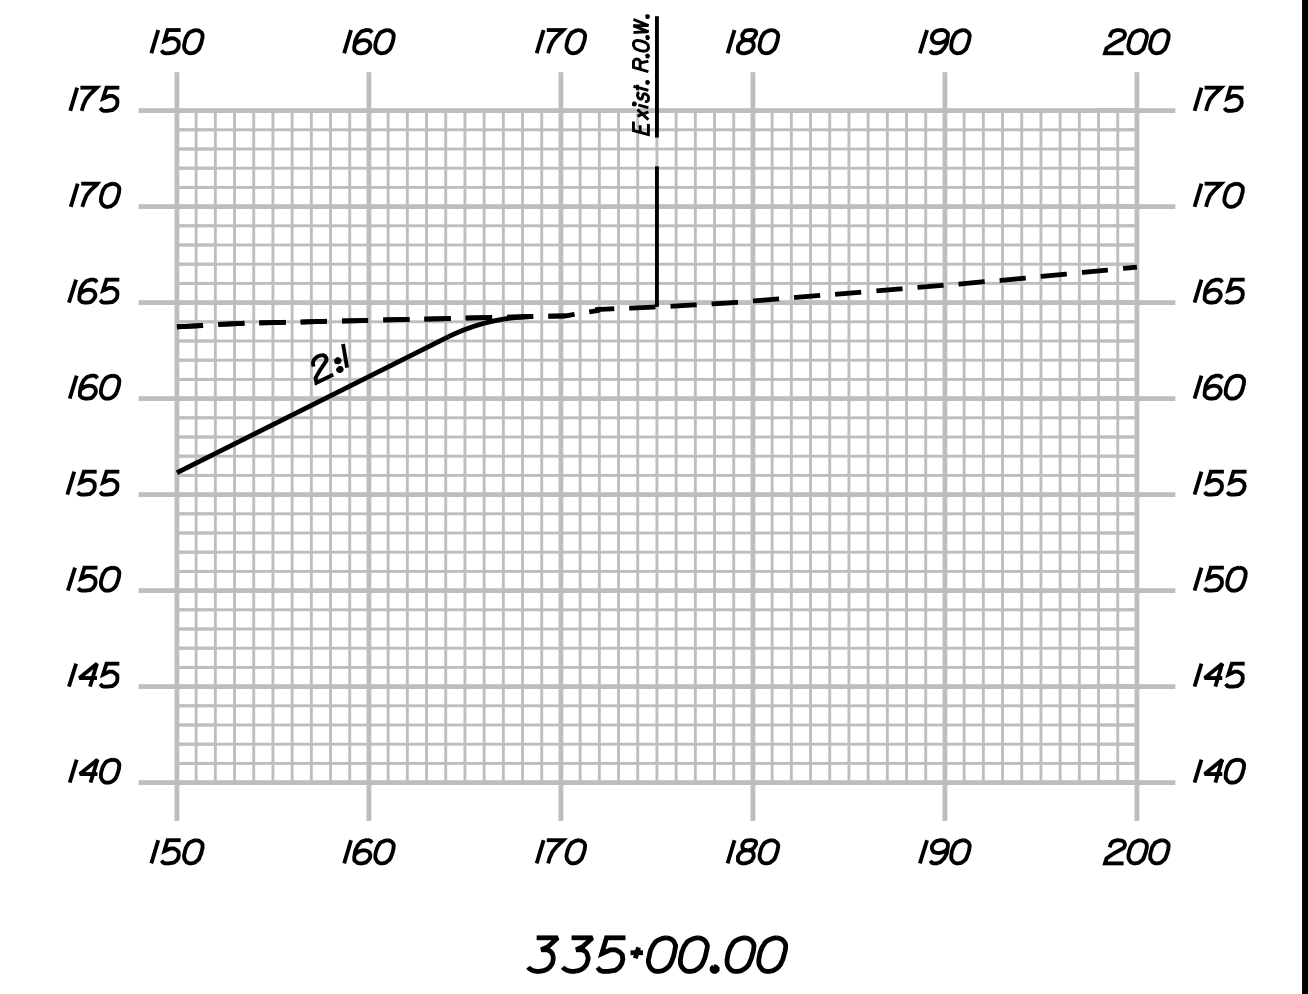

Scale:

No.	Revision	By	Date

Designed by:

JACOBS®

CONSULTANT PROJECT MANAGER: T. MORIN

	By	Date		By	Date
Designed	AMS	7-18	Checked	CSM	7-18
Drawn	SMG	7-18	In Charge of	TWM	7-18

JACOBS ENGINEERING GROUP
 120 ST. JAMES AVENUE
 BOSTON, MA 02116
 TEL (617) 242-9222
 FAX (617) 242-9824

THE GOLD STAR MEMORIAL HIGHWAY

MTA PROJECT MANAGER: R. NORWOOD



YORK TOLL PLAZA
 I-95 CROSS SECTIONS
 STA. 335+00

SHEET NUMBER: XS-24
 222 OF 489

CONTRACT: 2018.20

Date: 8/28/2018

Filename: ...00259637\Xsect\2a_195.dgn

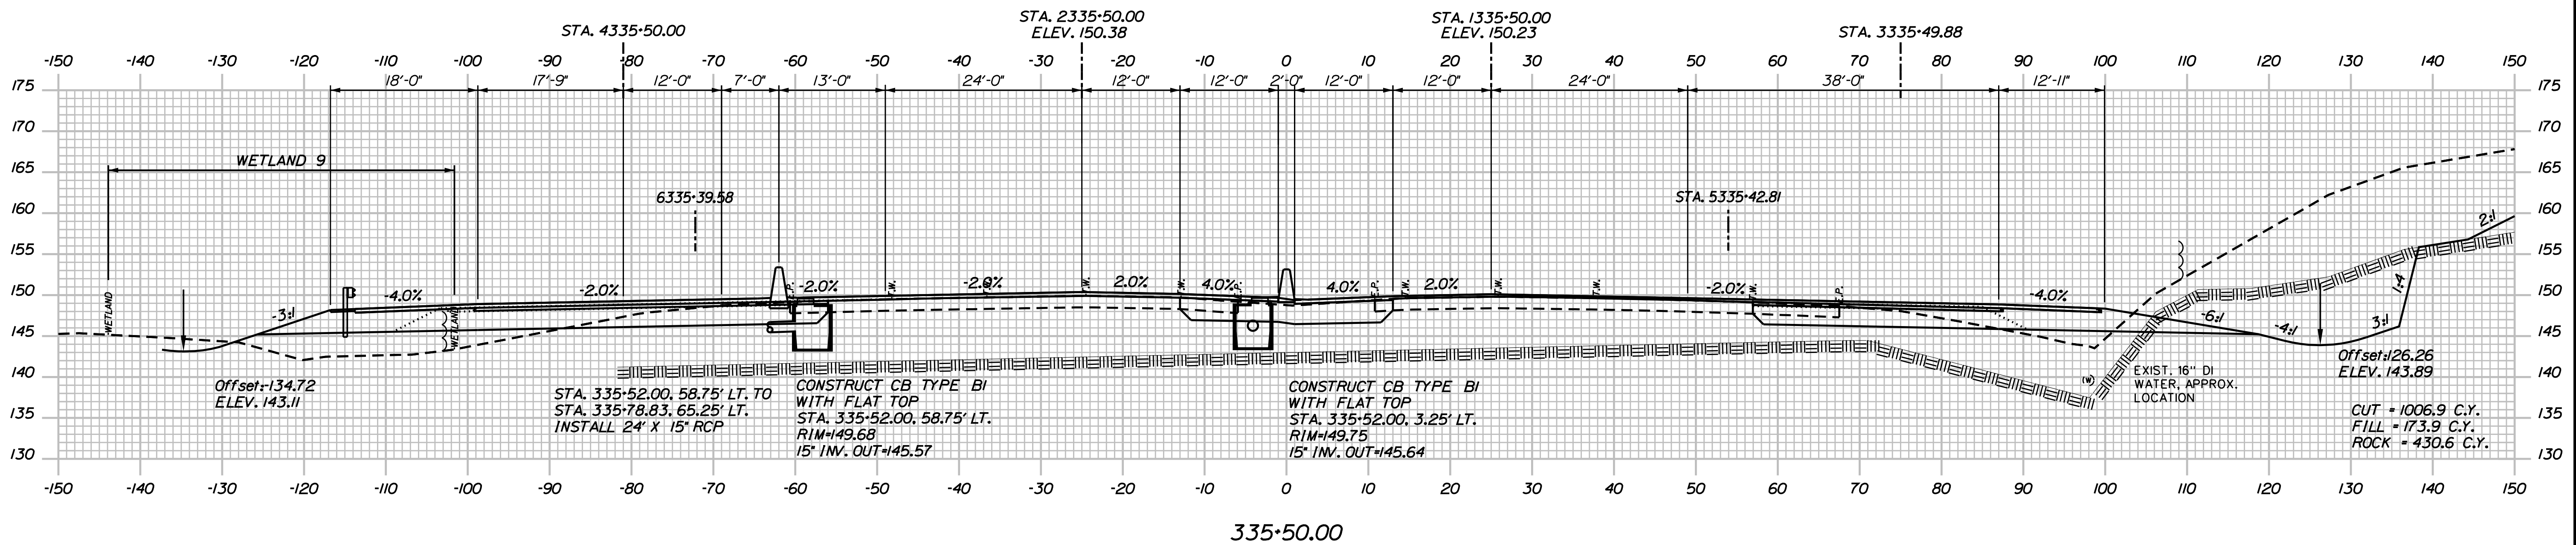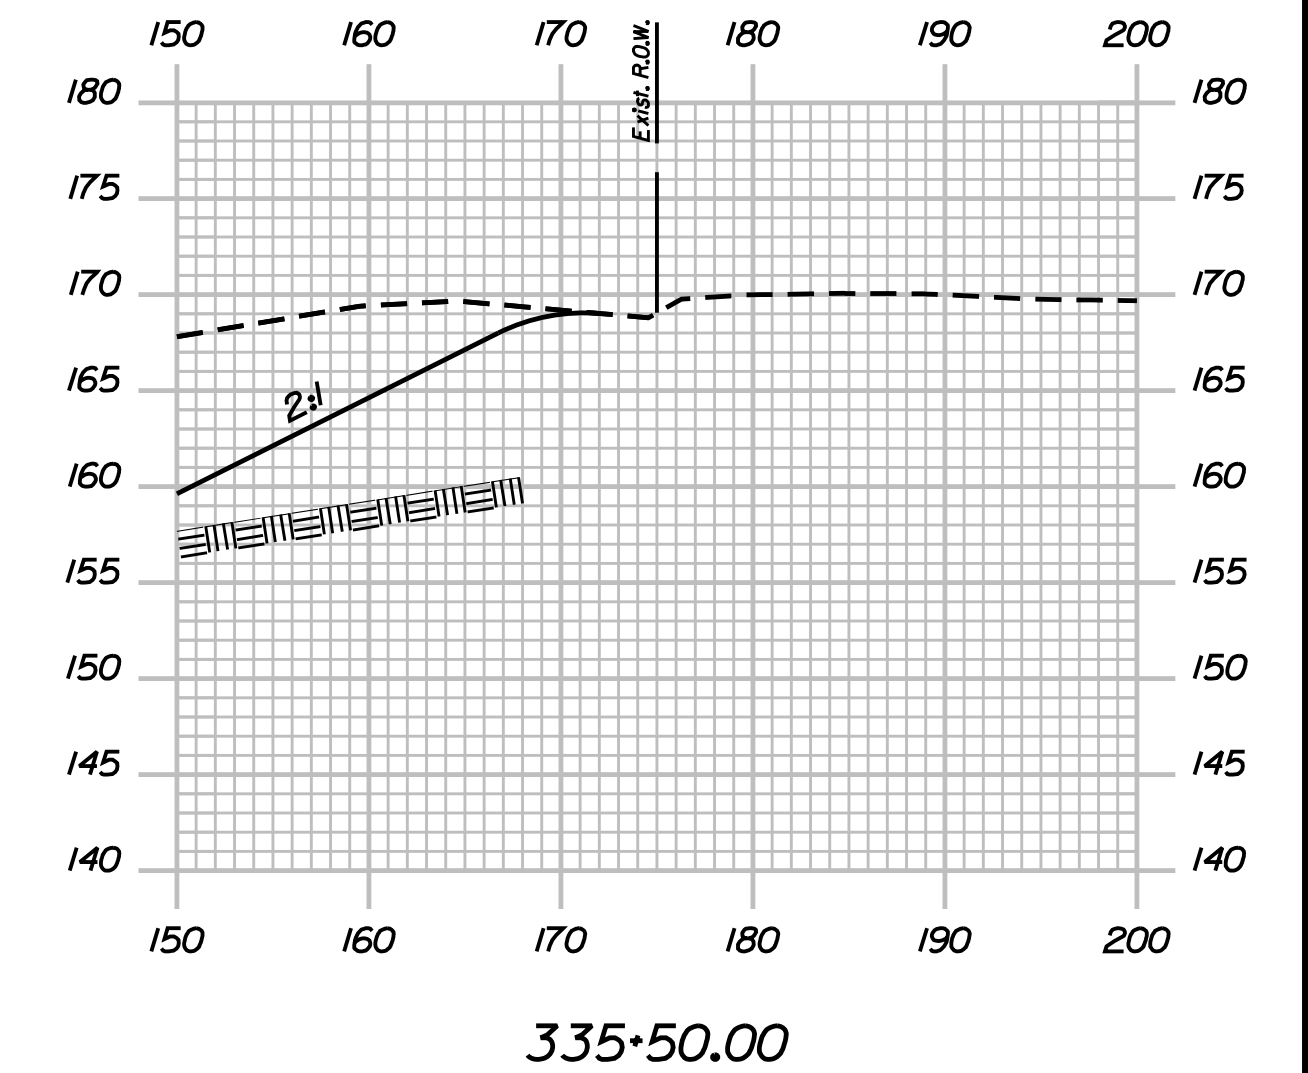

Scale: Scale of Feet

No.	Revision	By	Date

Designed by:

JACOBS

CONSULTANT PROJECT MANAGER: T. MORIN

	By	Date		By	Date
Designed	AMS	7-18	Checked	CSM	7-18
Drawn	SMG	7-18	In Charge of	TWM	7-18

JACOBS ENGINEERING GROUP
 120 ST. JAMES AVENUE
 BOSTON, MA 02116
 TEL (617) 242-9222
 FAX (617) 242-9824



THE GOLD STAR MEMORIAL HIGHWAY

MTA PROJECT MANAGER: R. NORWOOD

YORK TOLL PLAZA
 I-95 CROSS SECTIONS
 STA. 335+50

SHEET NUMBER: XS-25
 CONTRACT: 2018.20
 223 OF 489

Date: 8/28/2018

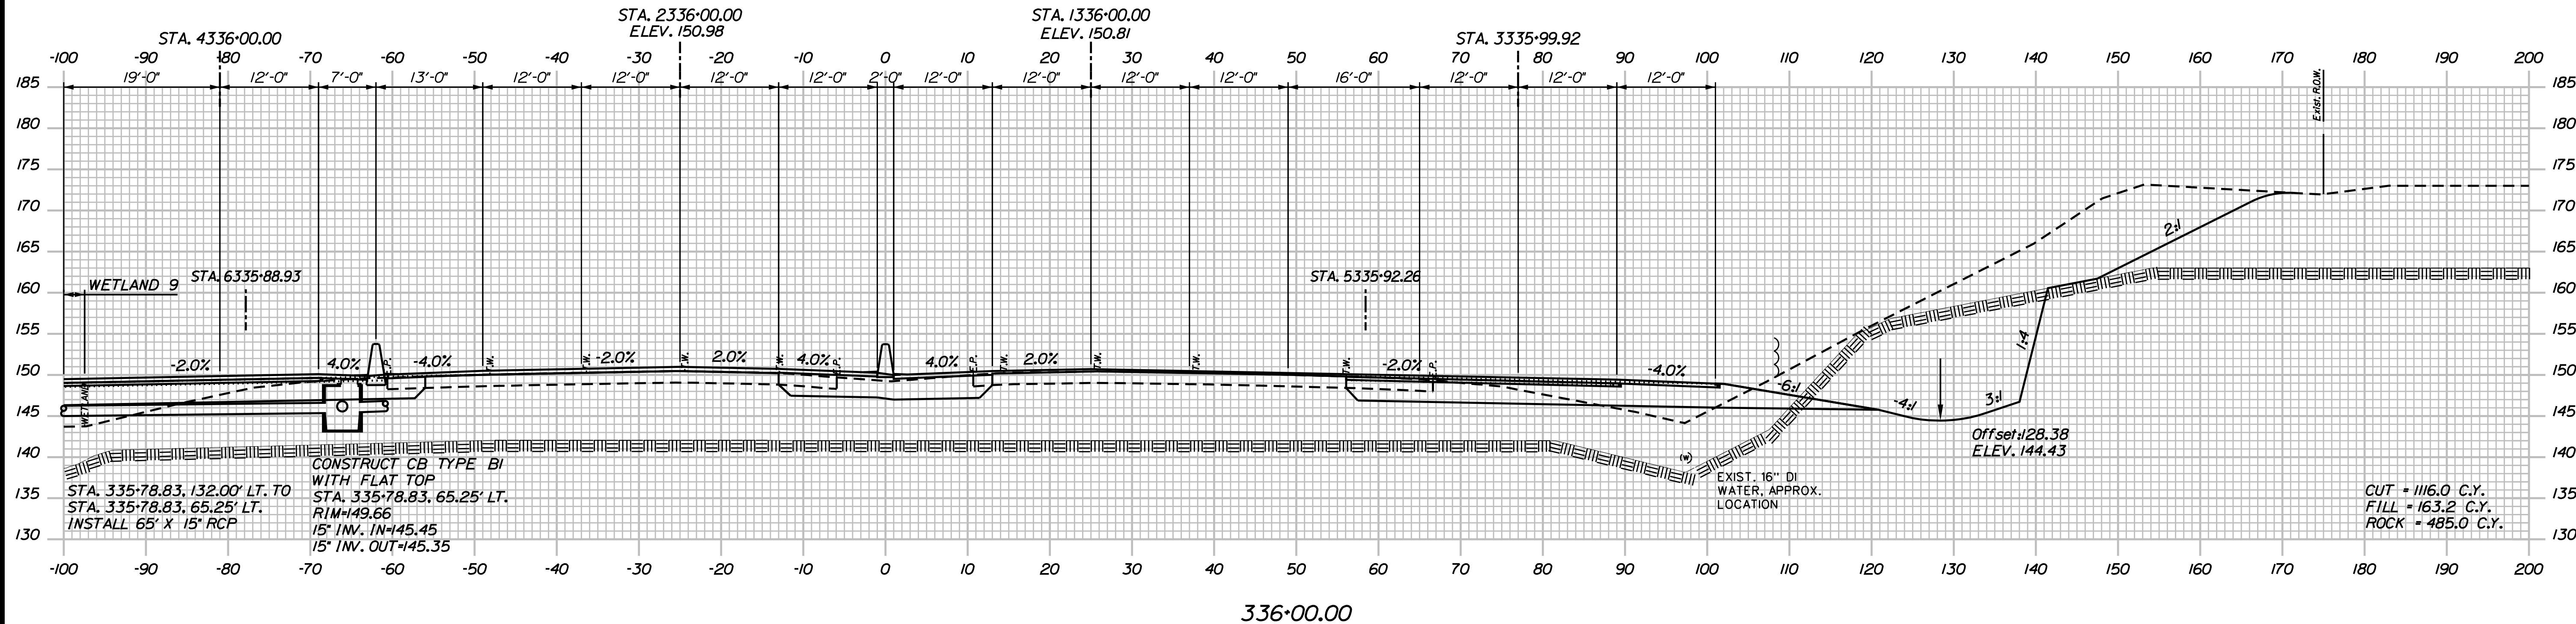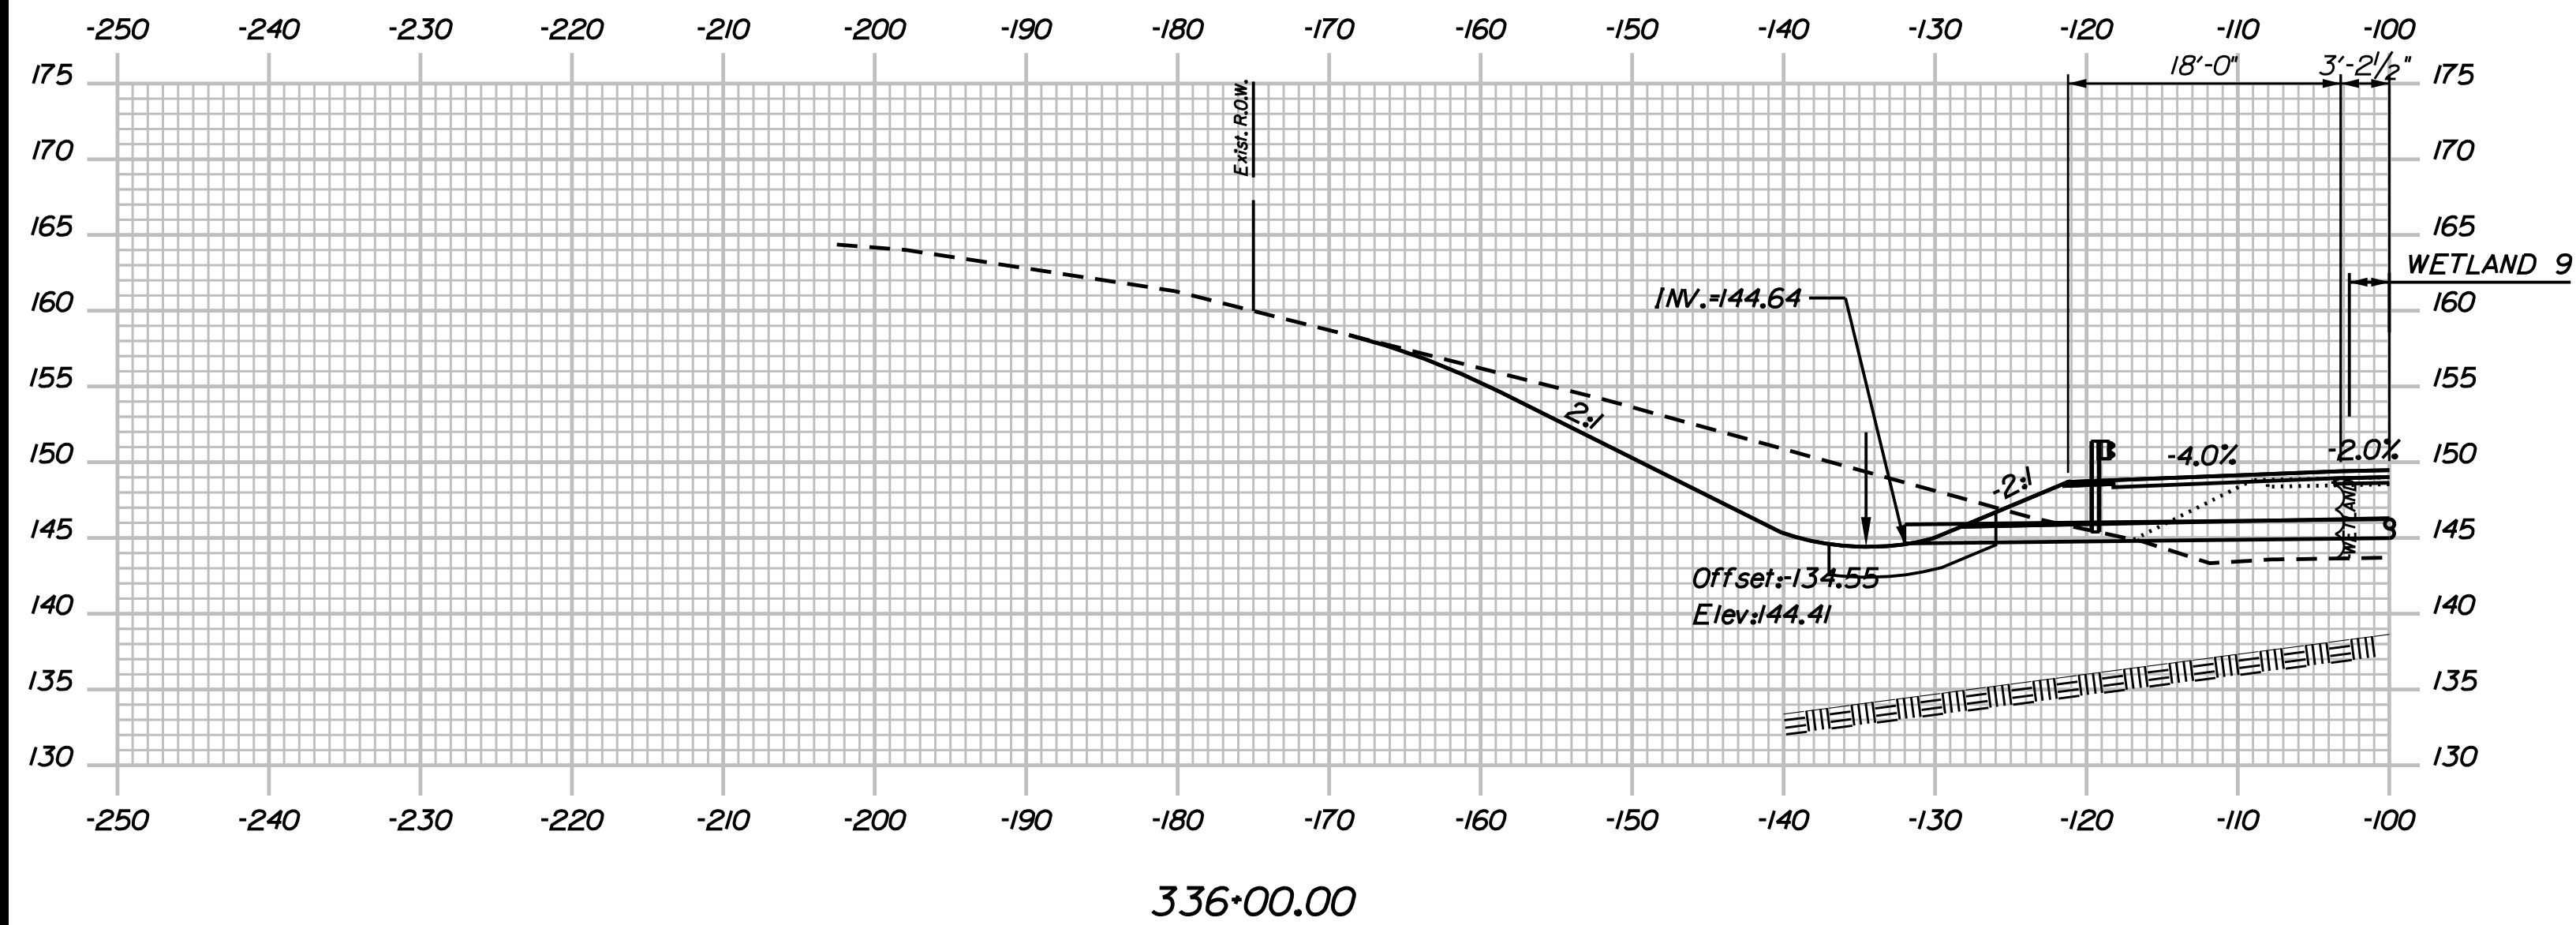

Filename: ...0259637\Xsect13_195.dgn

Scale:

No.	Revision	By	Date

Designed by:

JACOBS

CONSULTANT PROJECT MANAGER: T. MORIN

	By	Date		By	Date
Designed	AMS	7-18	Checked	CSM	7-18
Drawn	SMG	7-18	In Charge of	TWM	7-18

JACOBS ENGINEERING GROUP
 120 ST. JAMES AVENUE
 BOSTON, MA 02216
 TEL (617) 242-9222
 FAX (617) 242-9824


THE GOLD STAR MEMORIAL HIGHWAY

MTA PROJECT MANAGER: R. NORWOOD


YORK TOLL PLAZA
 I-95 CROSS SECTIONS
 STA. 336+00

SHEET NUMBER: XS-26
 CONTRACT: 2018.20
 224 OF 489

Date: 8/28/2018

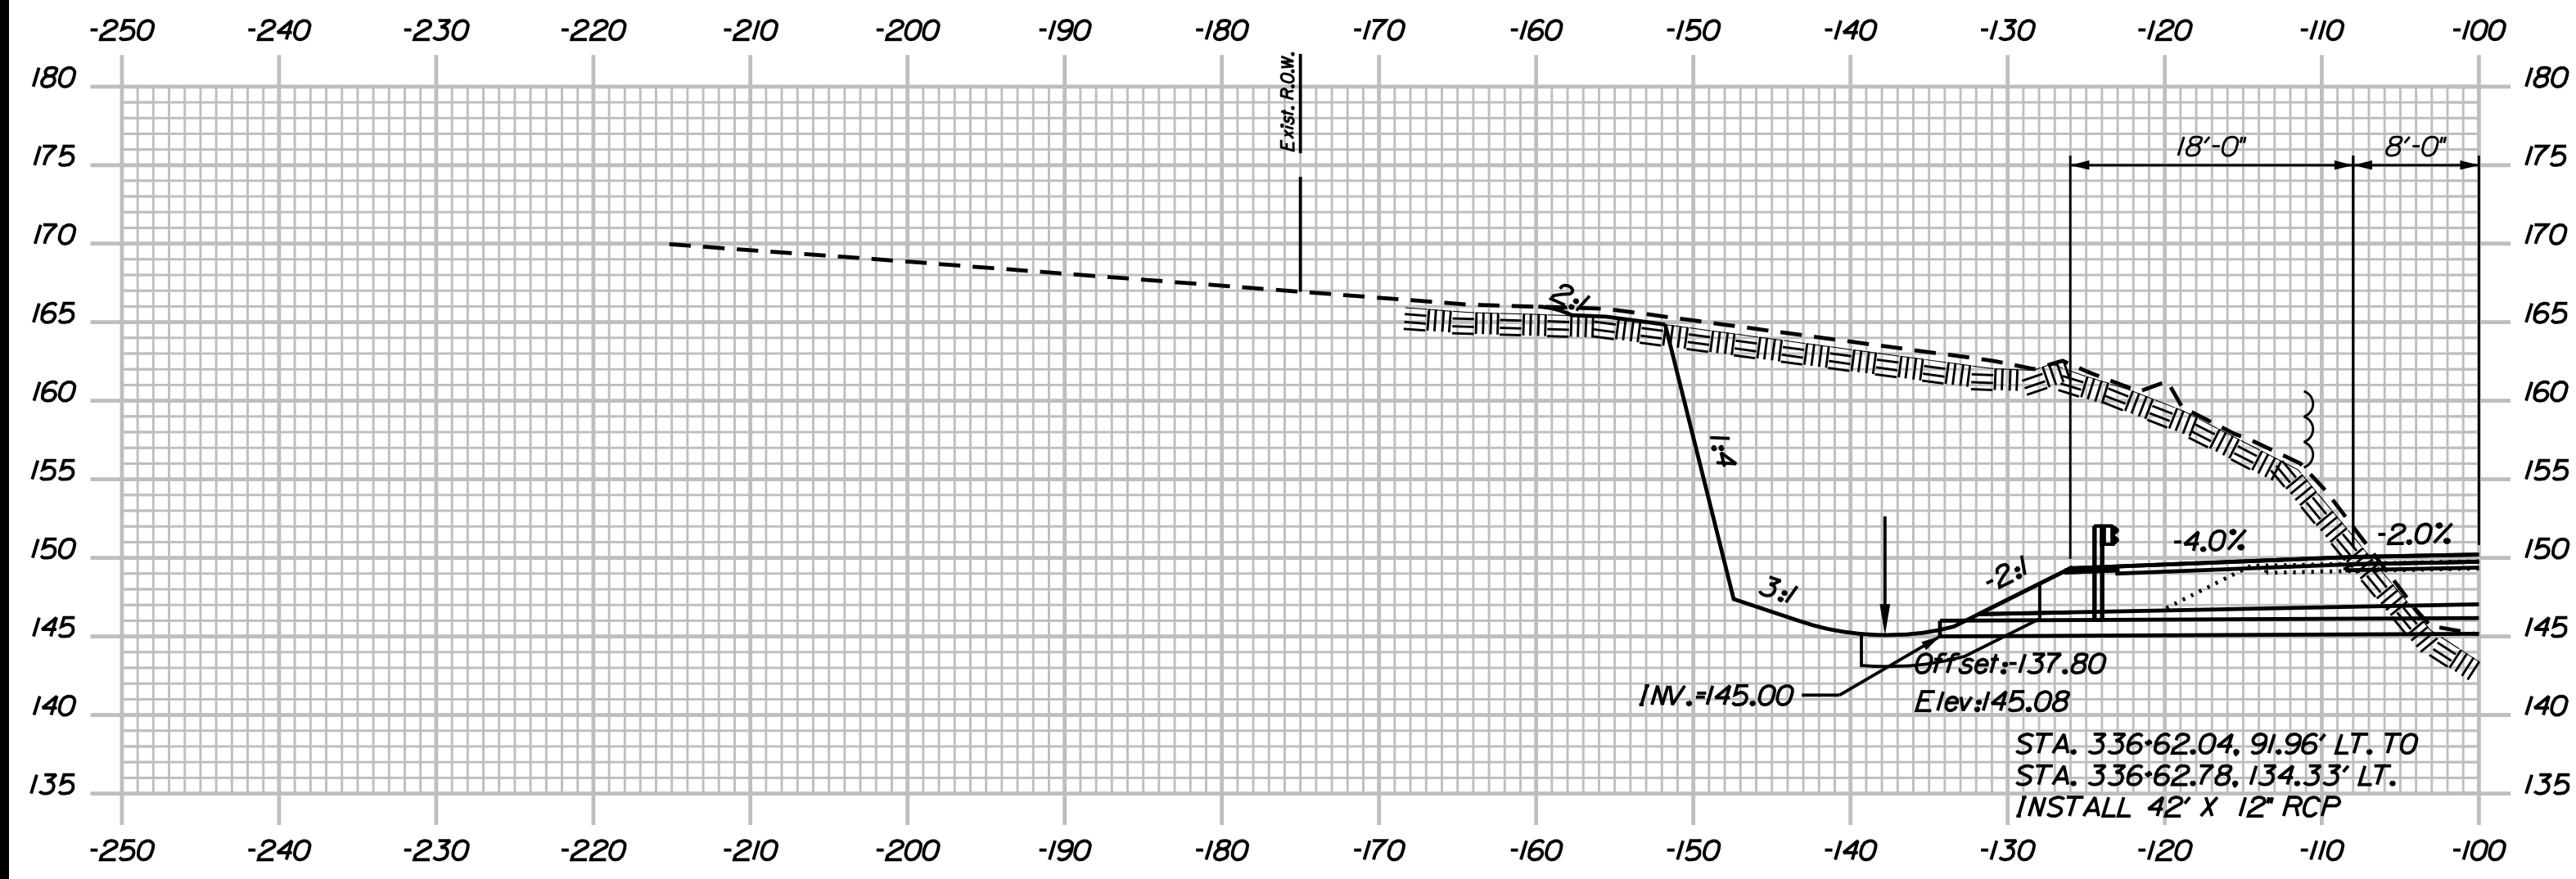

336+50.00

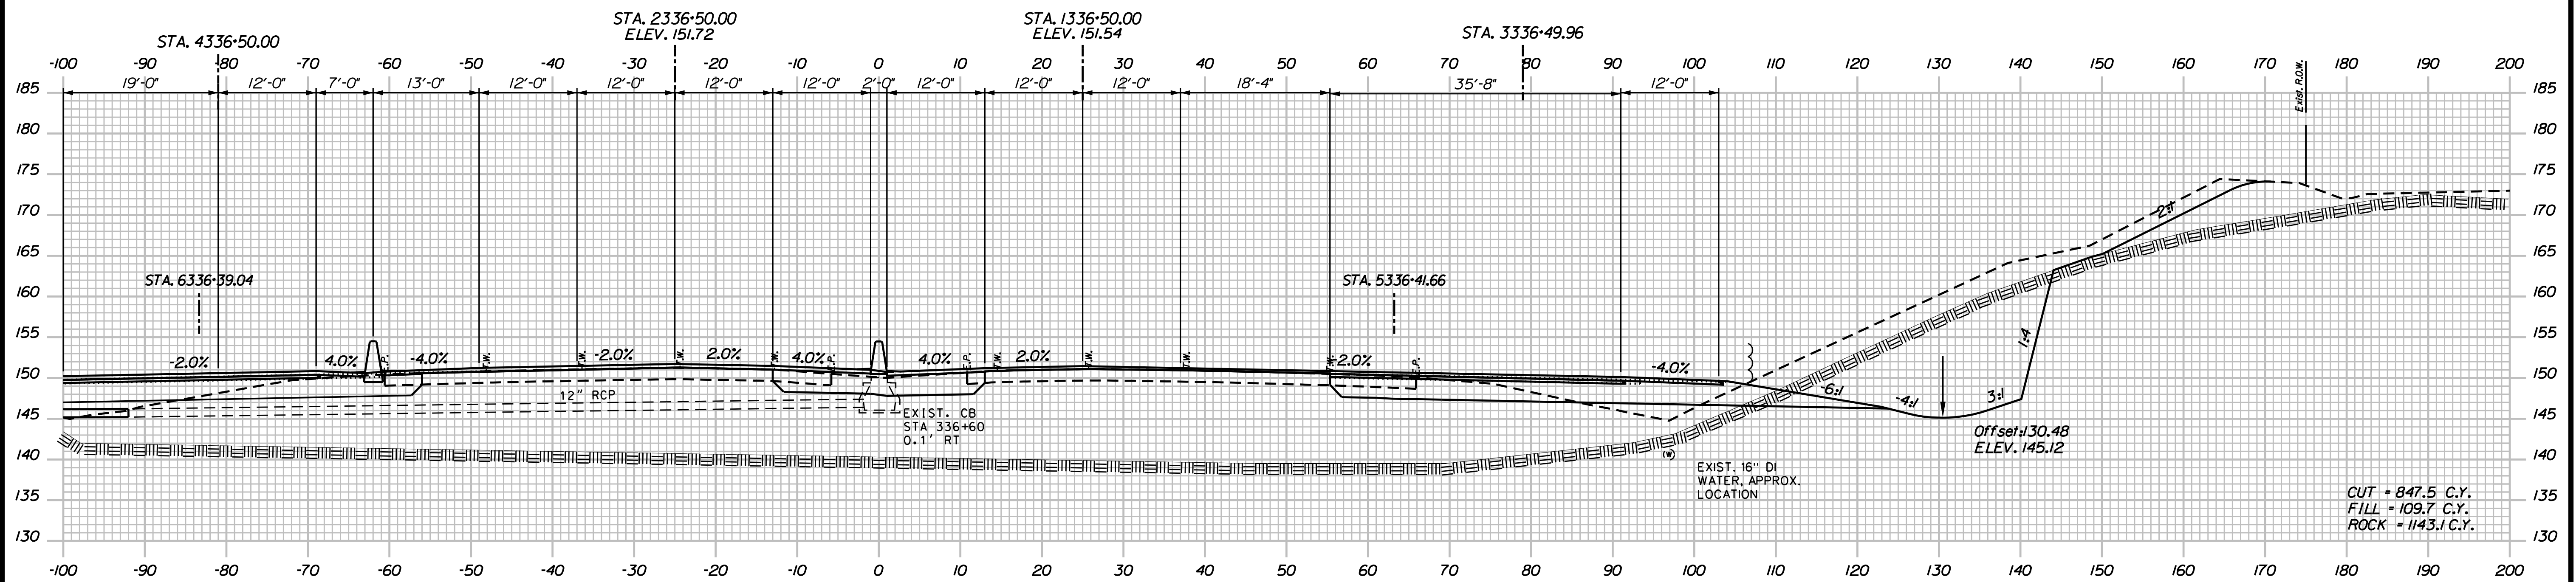

336+50.00

Filename: ...02596371\sect13_195.dgn

Scale:

No.	Revision	By	Date

Designed by:

JACOBS

CONSULTANT PROJECT MANAGER: T. MORIN

	By	Date		By	Date
Designed	AMS	7-18	Checked	CSM	7-18
Drawn	SMG	7-18	In Charge of	TWM	7-18

JACOBS ENGINEERING GROUP
 120 ST. JAMES AVENUE
 BOSTON, MA 02216
 TEL (617) 242-9222
 FAX (617) 242-9824


THE GOLD STAR MEMORIAL HIGHWAY

MTA PROJECT MANAGER: R. NORWOOD


YORK TOLL PLAZA
 I-95 CROSS SECTIONS
 STA. 336+50

SHEET NUMBER: XS-27
 CONTRACT: 2018.20
 225 OF 489


Date: 8/28/2018

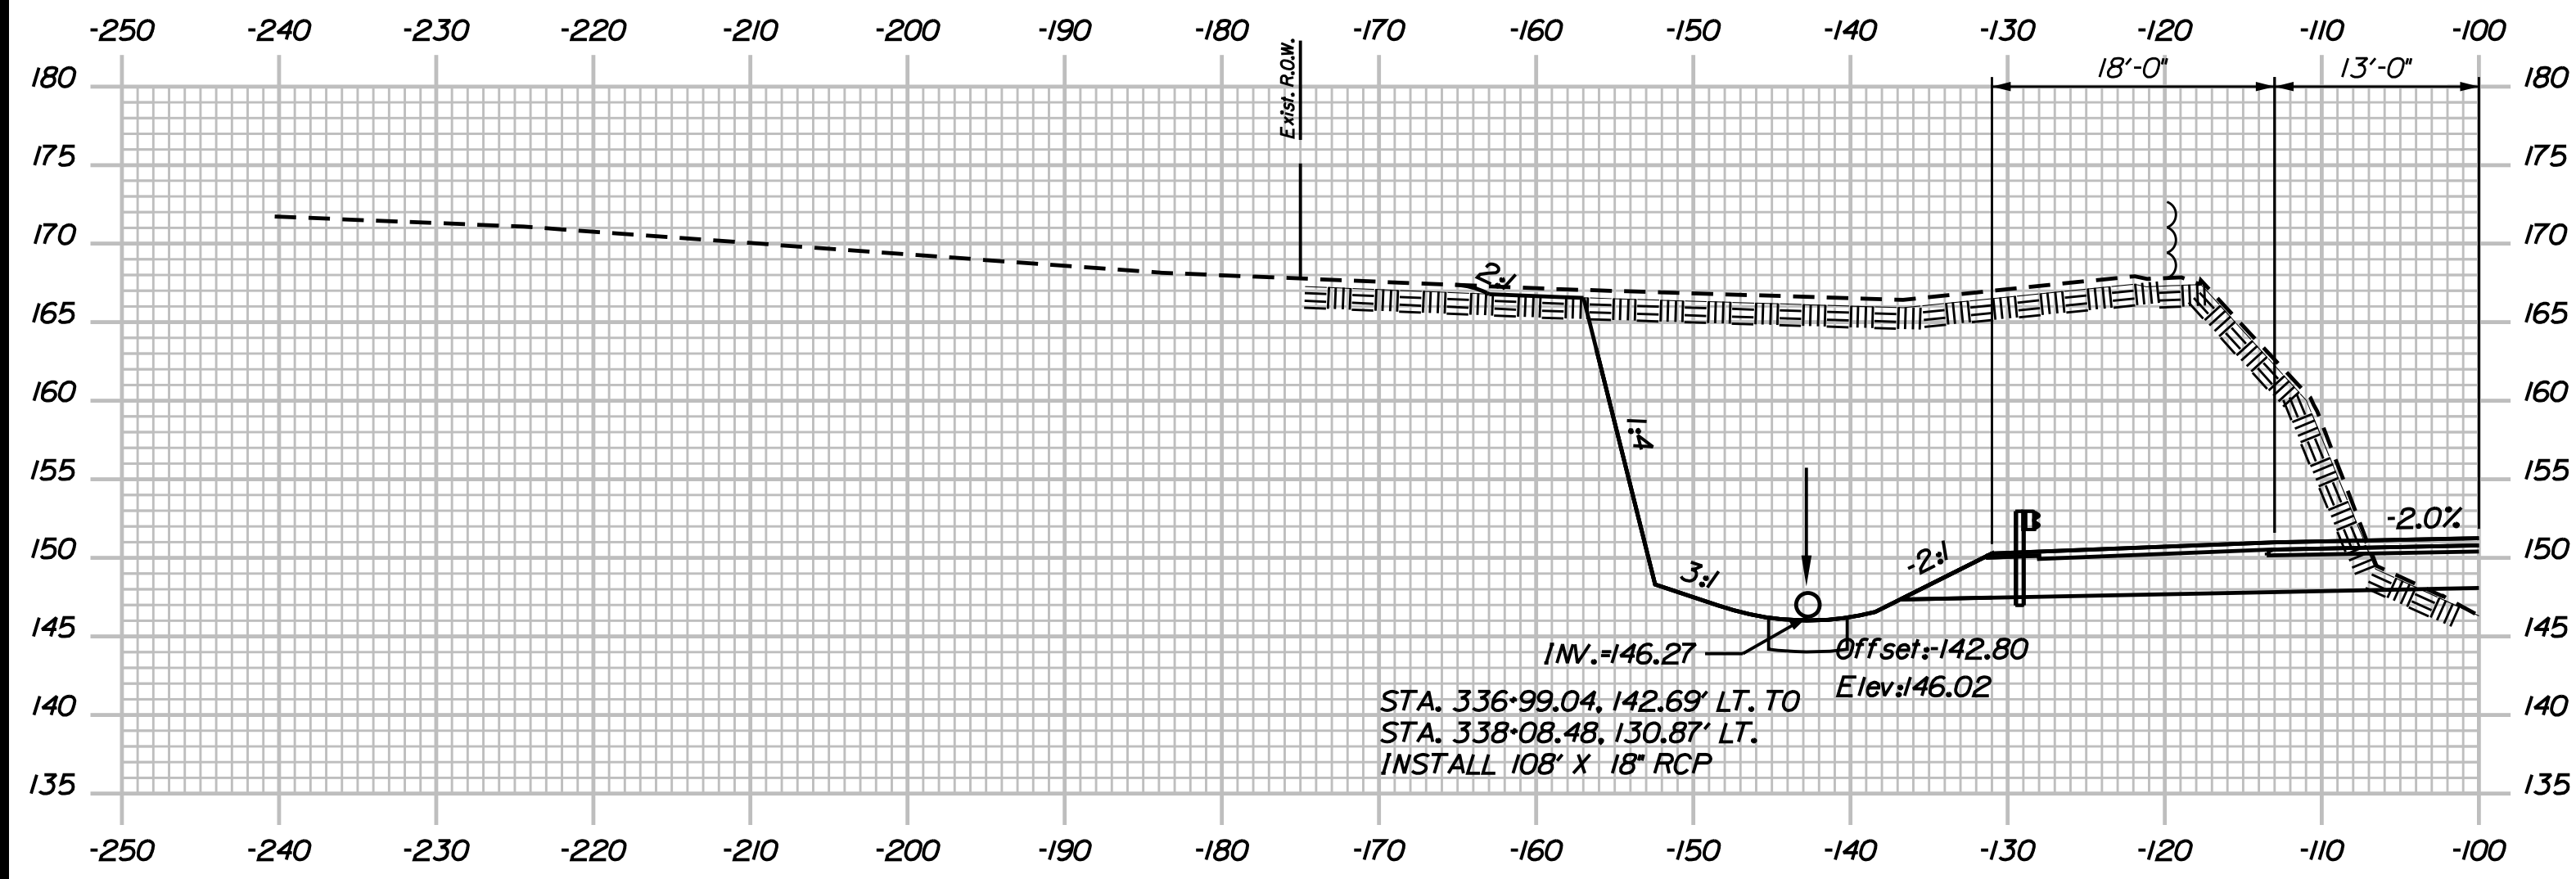

337+00.00

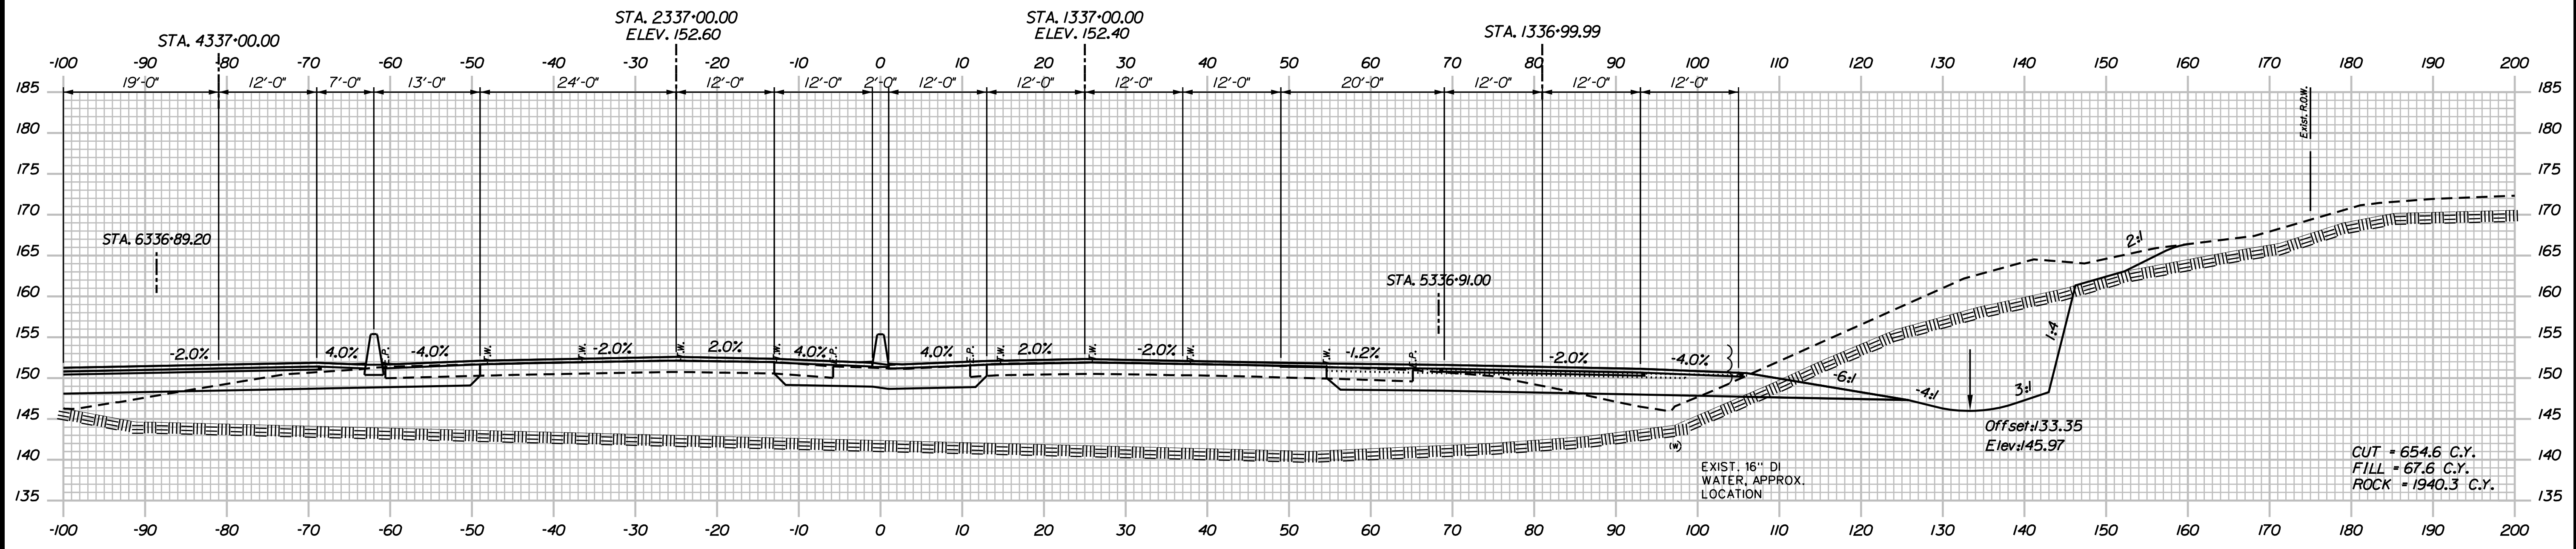

337+00.00

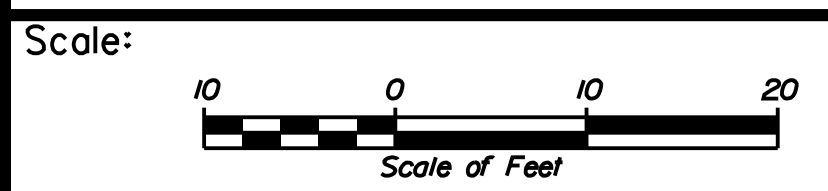

No.	Revision	By	Date

Designed by:

JACOBS

CONSULTANT PROJECT MANAGER: T. MORIN

	By	Date		By	Date
Designed	AMS	7-18	Checked	CSM	7-18
Drawn	SMG	7-18	In Charge of	TWM	7-18

JACOBS ENGINEERING GROUP
 120 ST. JAMES AVENUE
 BOSTON, MA 02216
 TEL (617) 242-9222
 FAX (617) 242-9824

**THE GOLD STAR
 MEMORIAL HIGHWAY**

MTA PROJECT MANAGER: R. NORWOOD


YORK TOLL PLAZA
 I-95 CROSS SECTIONS
 STA. 337+00

SHEET NUMBER: XS-28
 226 OF 489


CONTRACT: 2018.20

Filename: ...00259637\Xsect13_195.dgn

Date: 8/28/2018

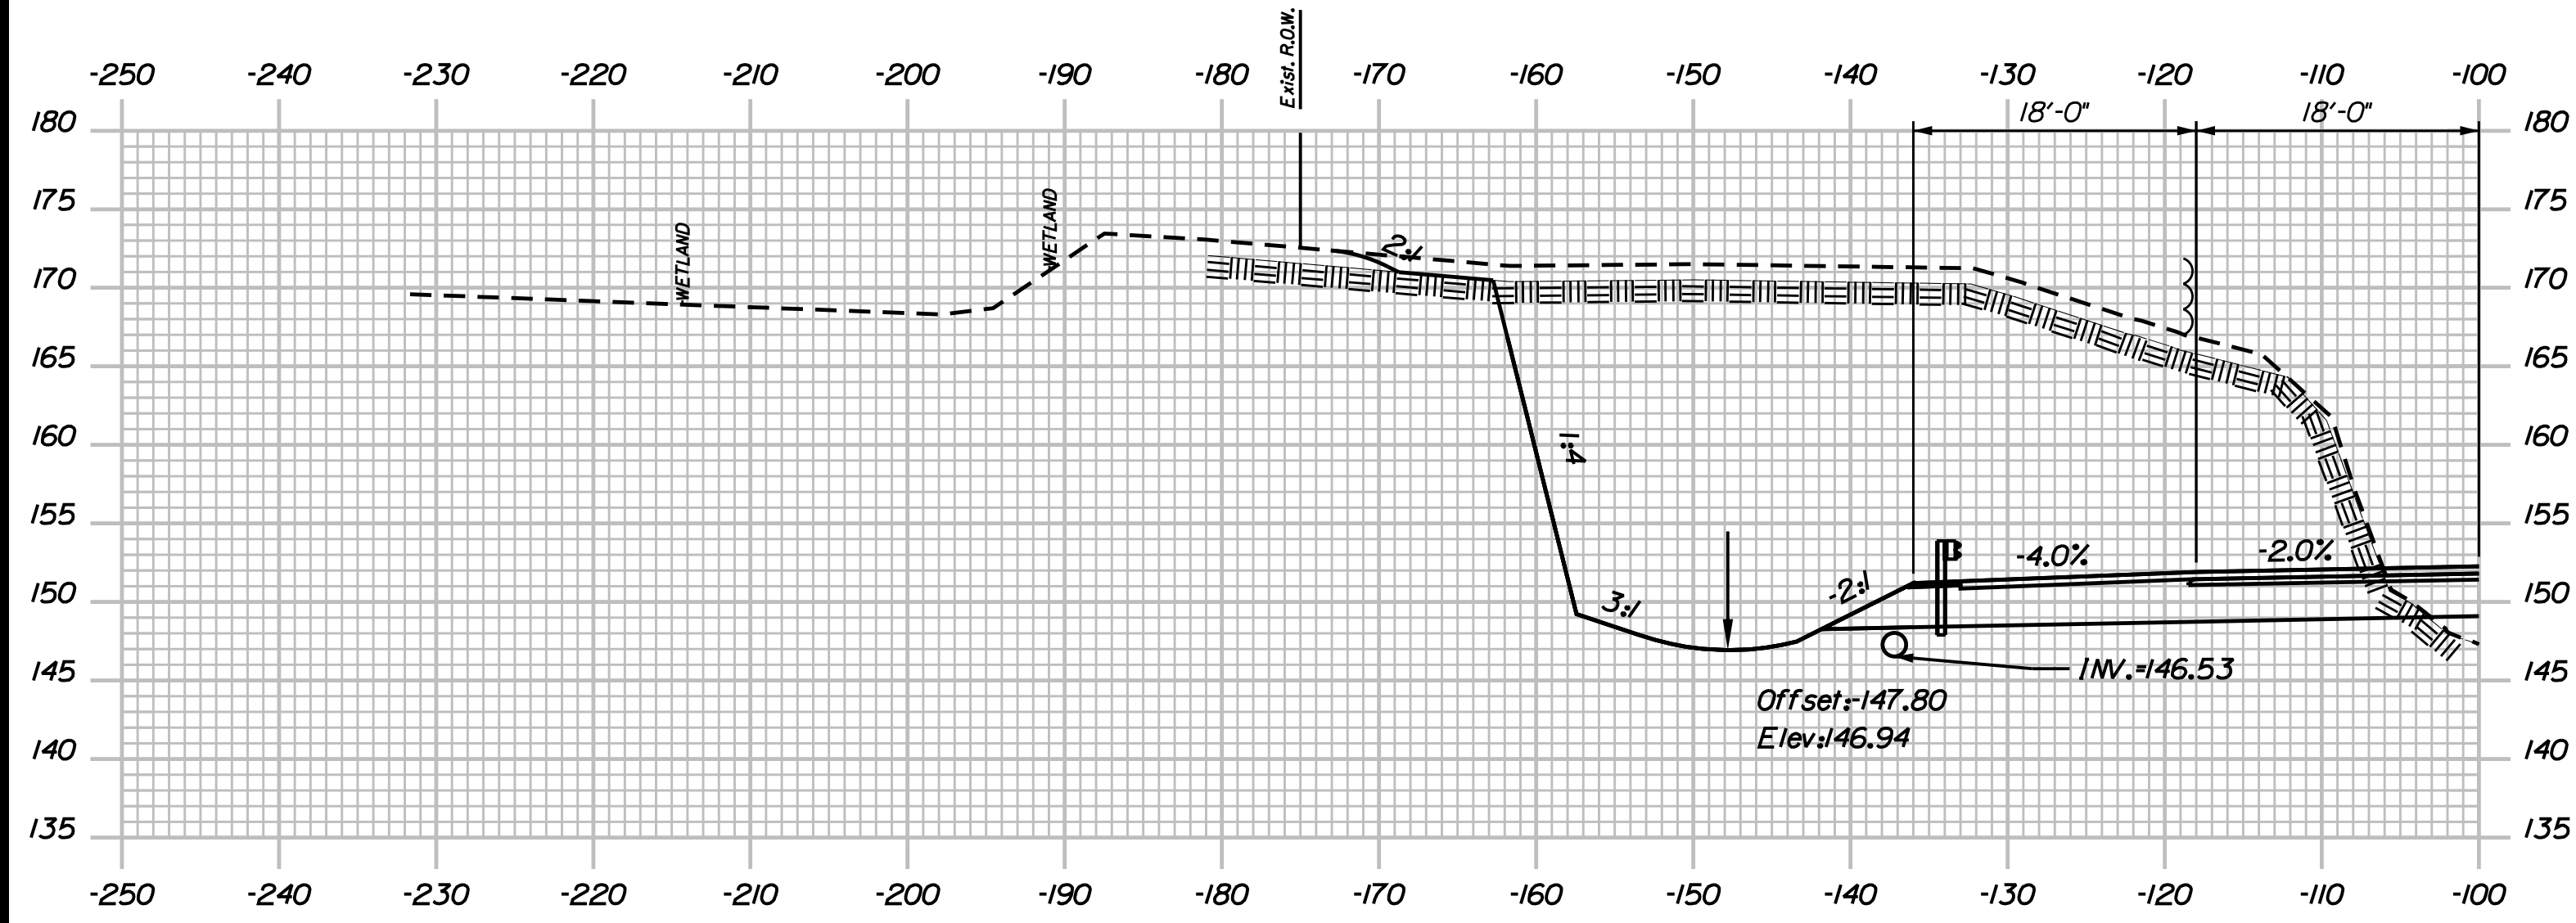

337+50.00

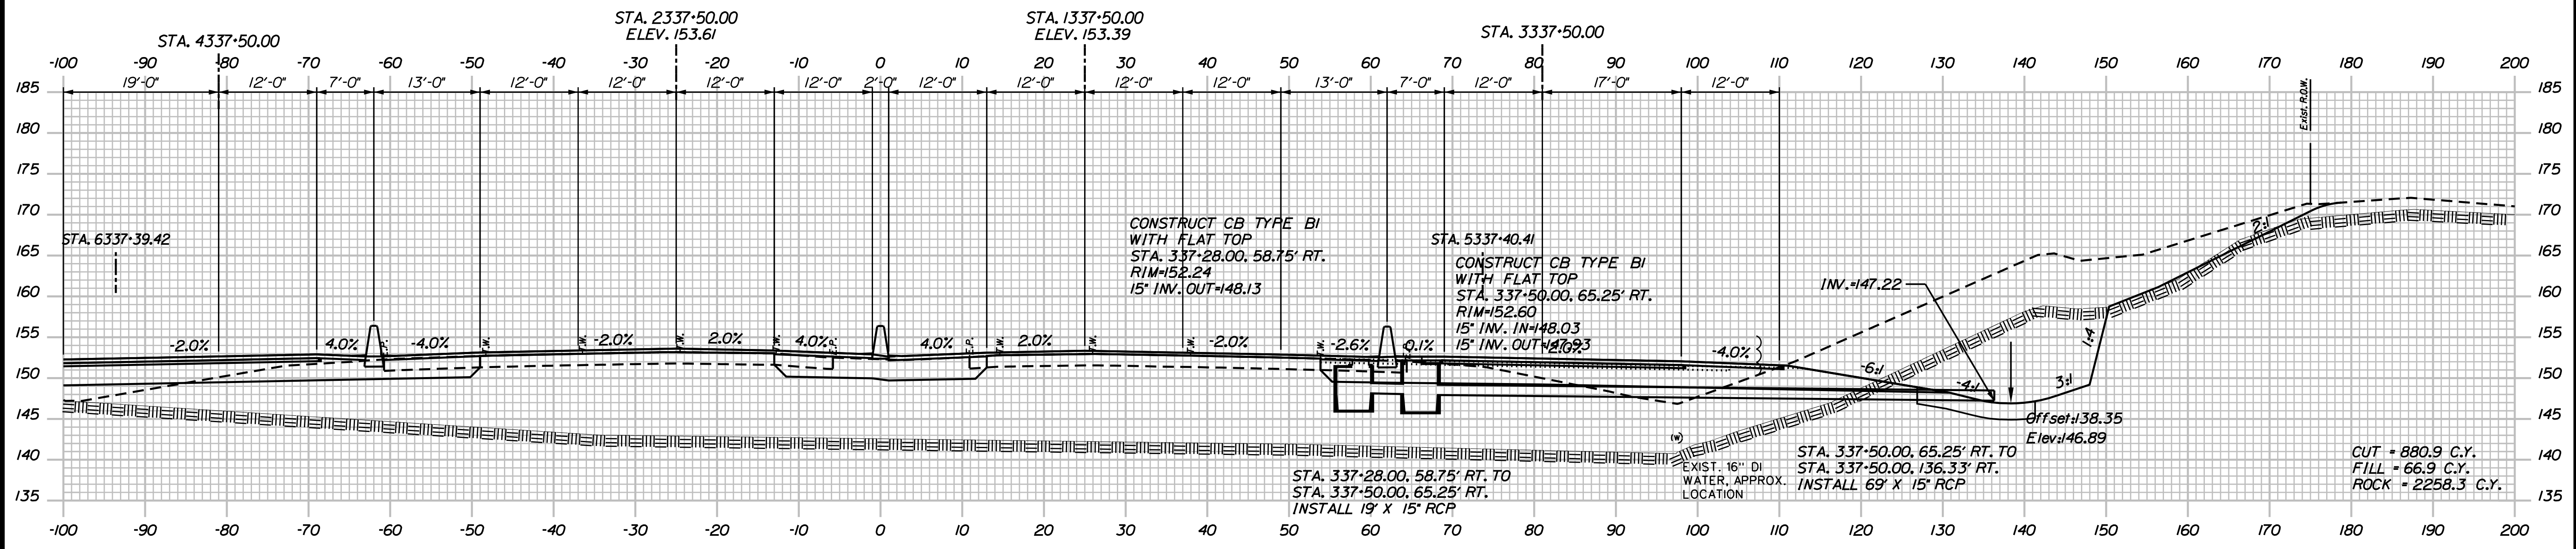

337+50.00

Filename: ...0259637\Xsect13_195.dgn

Scale:

No.	Revision	By	Date

Designed by:

JACOBS

CONSULTANT PROJECT MANAGER: T. MORIN

	By	Date		By	Date
Designed	AMS	7-18	Checked	CSM	7-18
Drawn	SMG	7-18	In Charge of	TWM	7-18

JACOBS ENGINEERING GROUP
 120 ST. JAMES AVENUE
 BOSTON, MA 02216
 TEL (617) 242-9222
 FAX (617) 242-9824


THE GOLD STAR
 MEMORIAL HIGHWAY

MTA PROJECT MANAGER: R. NORWOOD


YORK TOLL PLAZA
 I-95 CROSS SECTIONS
 STA. 337+50

SHEET NUMBER: XS-29
 CONTRACT: 2018.20
 227 OF 489

Date: 8/28/2018

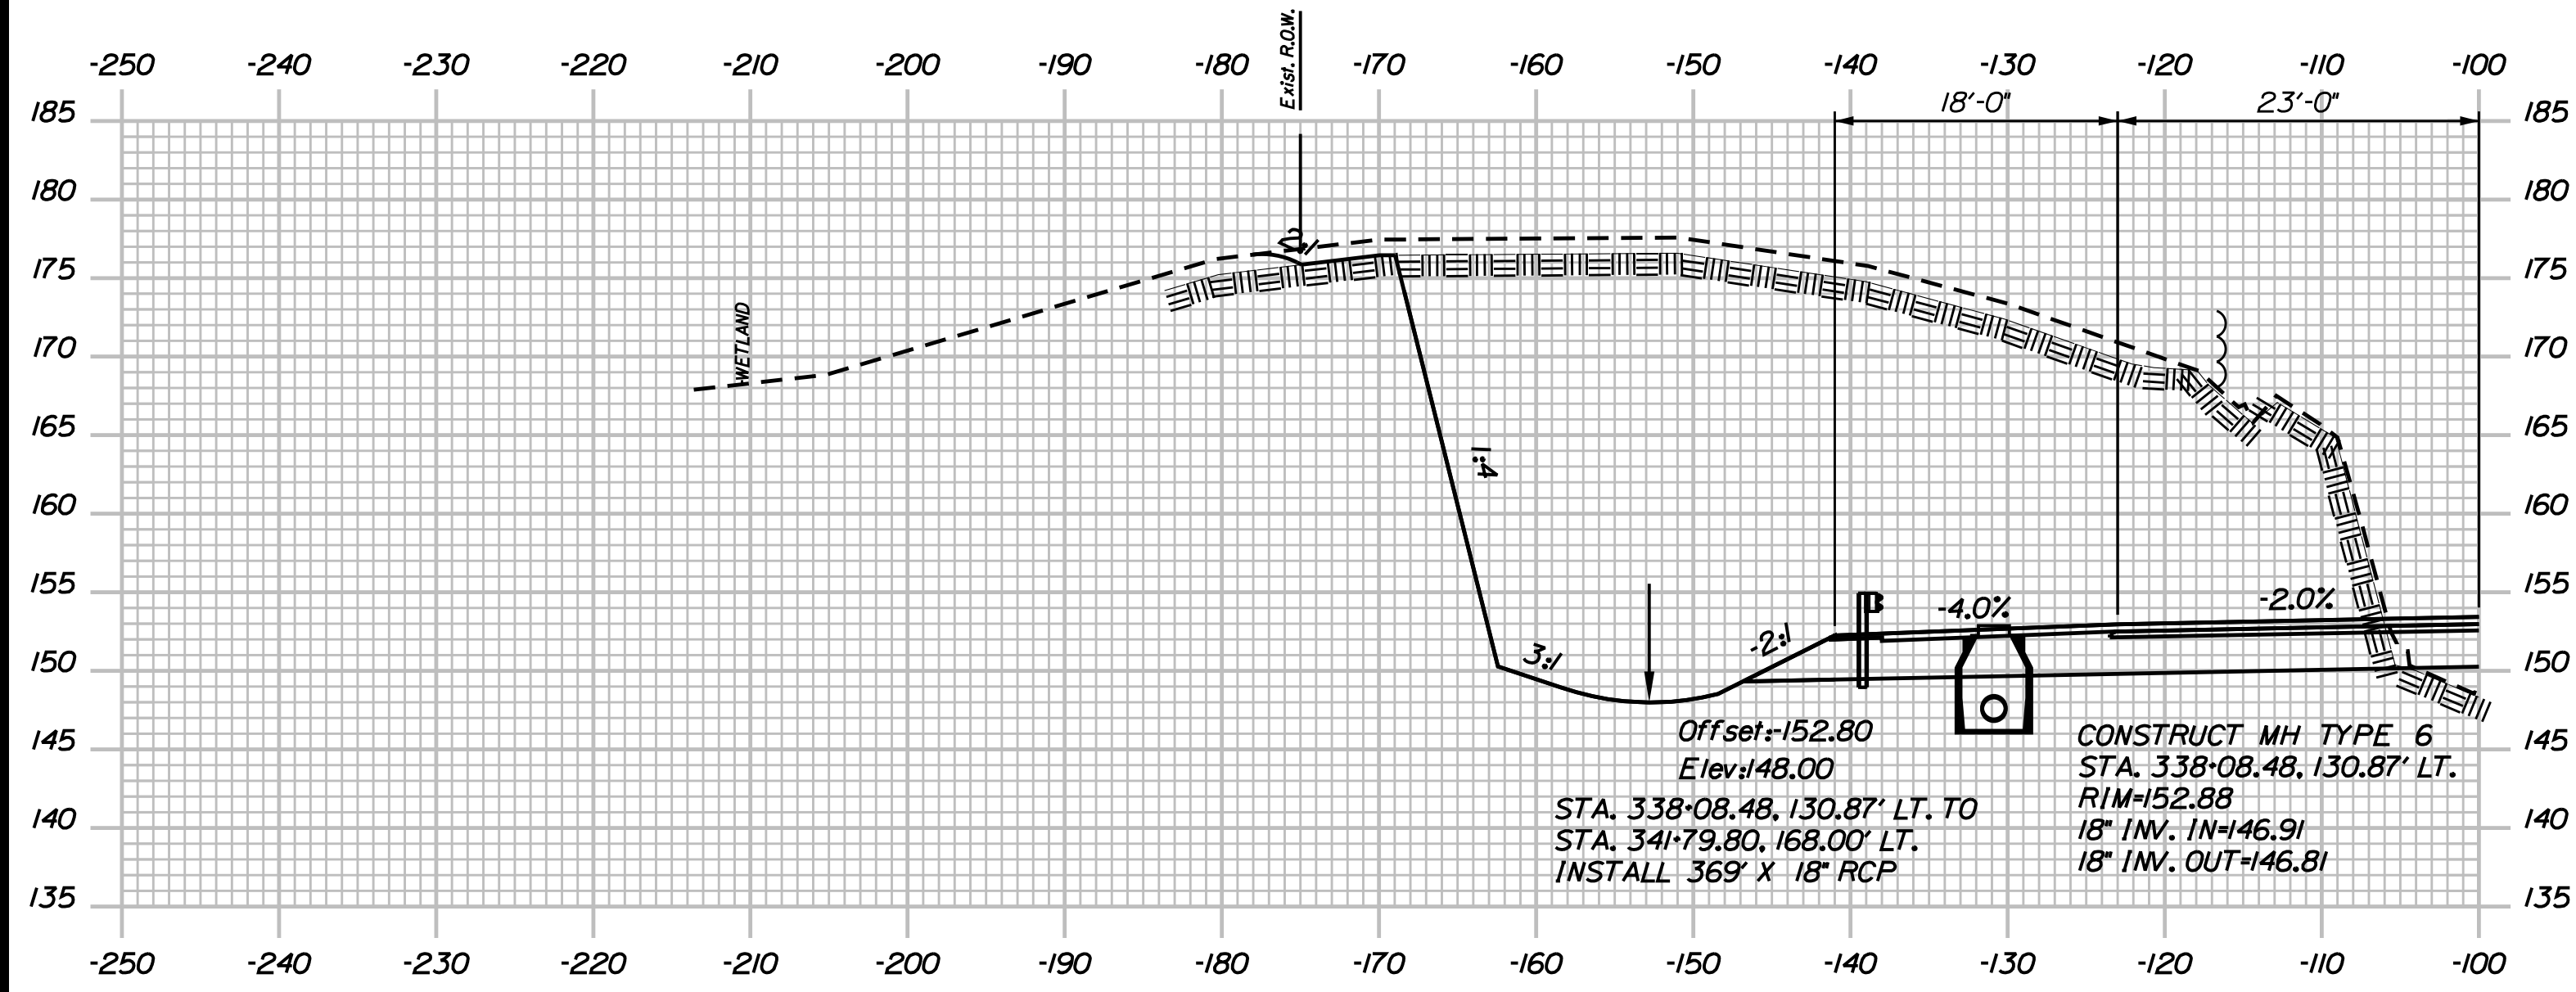

338+00.00

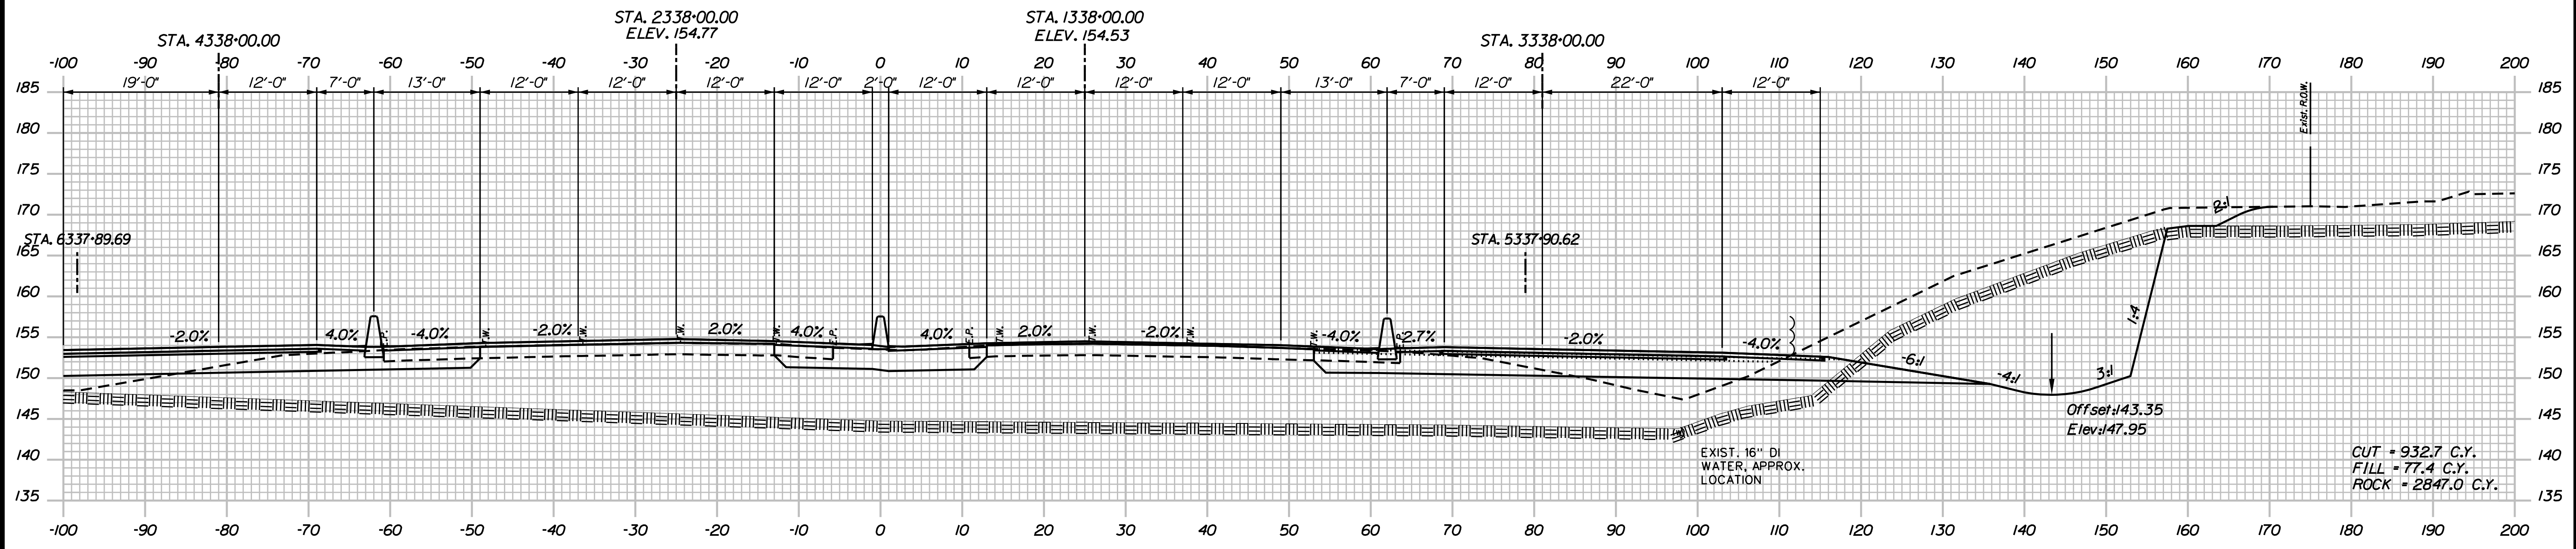

338+00.00

Scale:

No.	Revision	By	Date

Designed by:

JACOBS

CONSULTANT PROJECT MANAGER: T. MORIN

	By	Date		By	Date
Designed	AMS	7-18	Checked	CSM	7-18
Drawn	SMG	7-18	In Charge of	TWM	7-18

JACOBS ENGINEERING GROUP
 120 ST. JAMES AVENUE
 BOSTON, MA 02216
 TEL (617) 242-9222
 FAX (617) 242-9824

**THE GOLD STAR
 MEMORIAL HIGHWAY**

MTA PROJECT MANAGER: R. NORWOOD



YORK TOLL PLAZA
 I-95 CROSS SECTIONS
 STA. 338+00

SHEET NUMBER: XS-30
 228 OF 489

CONTRACT: 2018.20

Filename: ...0259637\Xsect13_195.dgn

Date: 8/28/2018

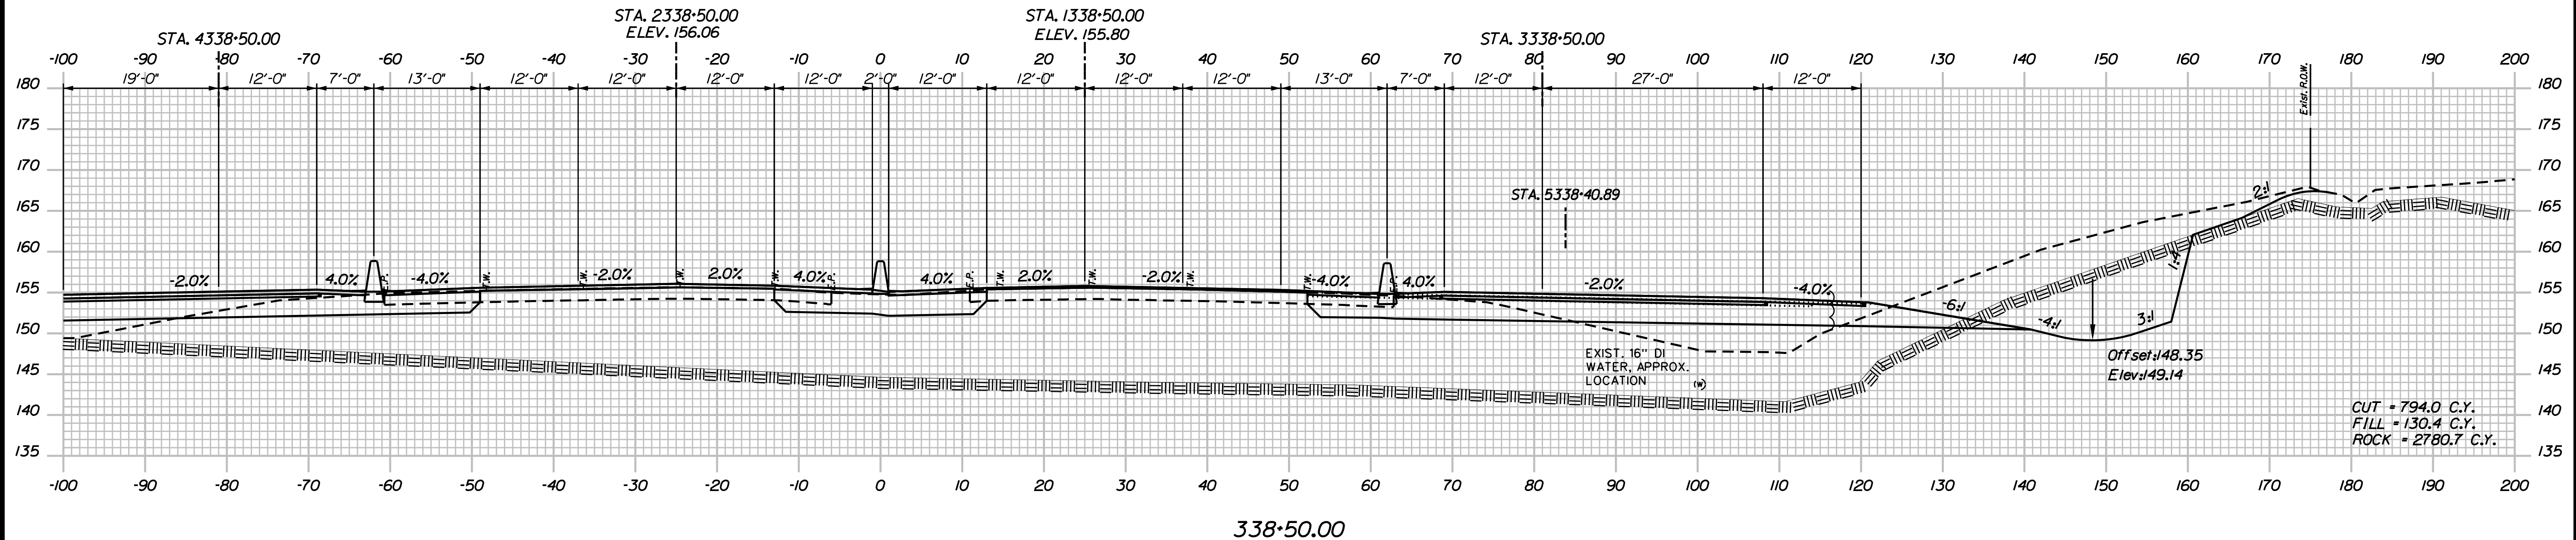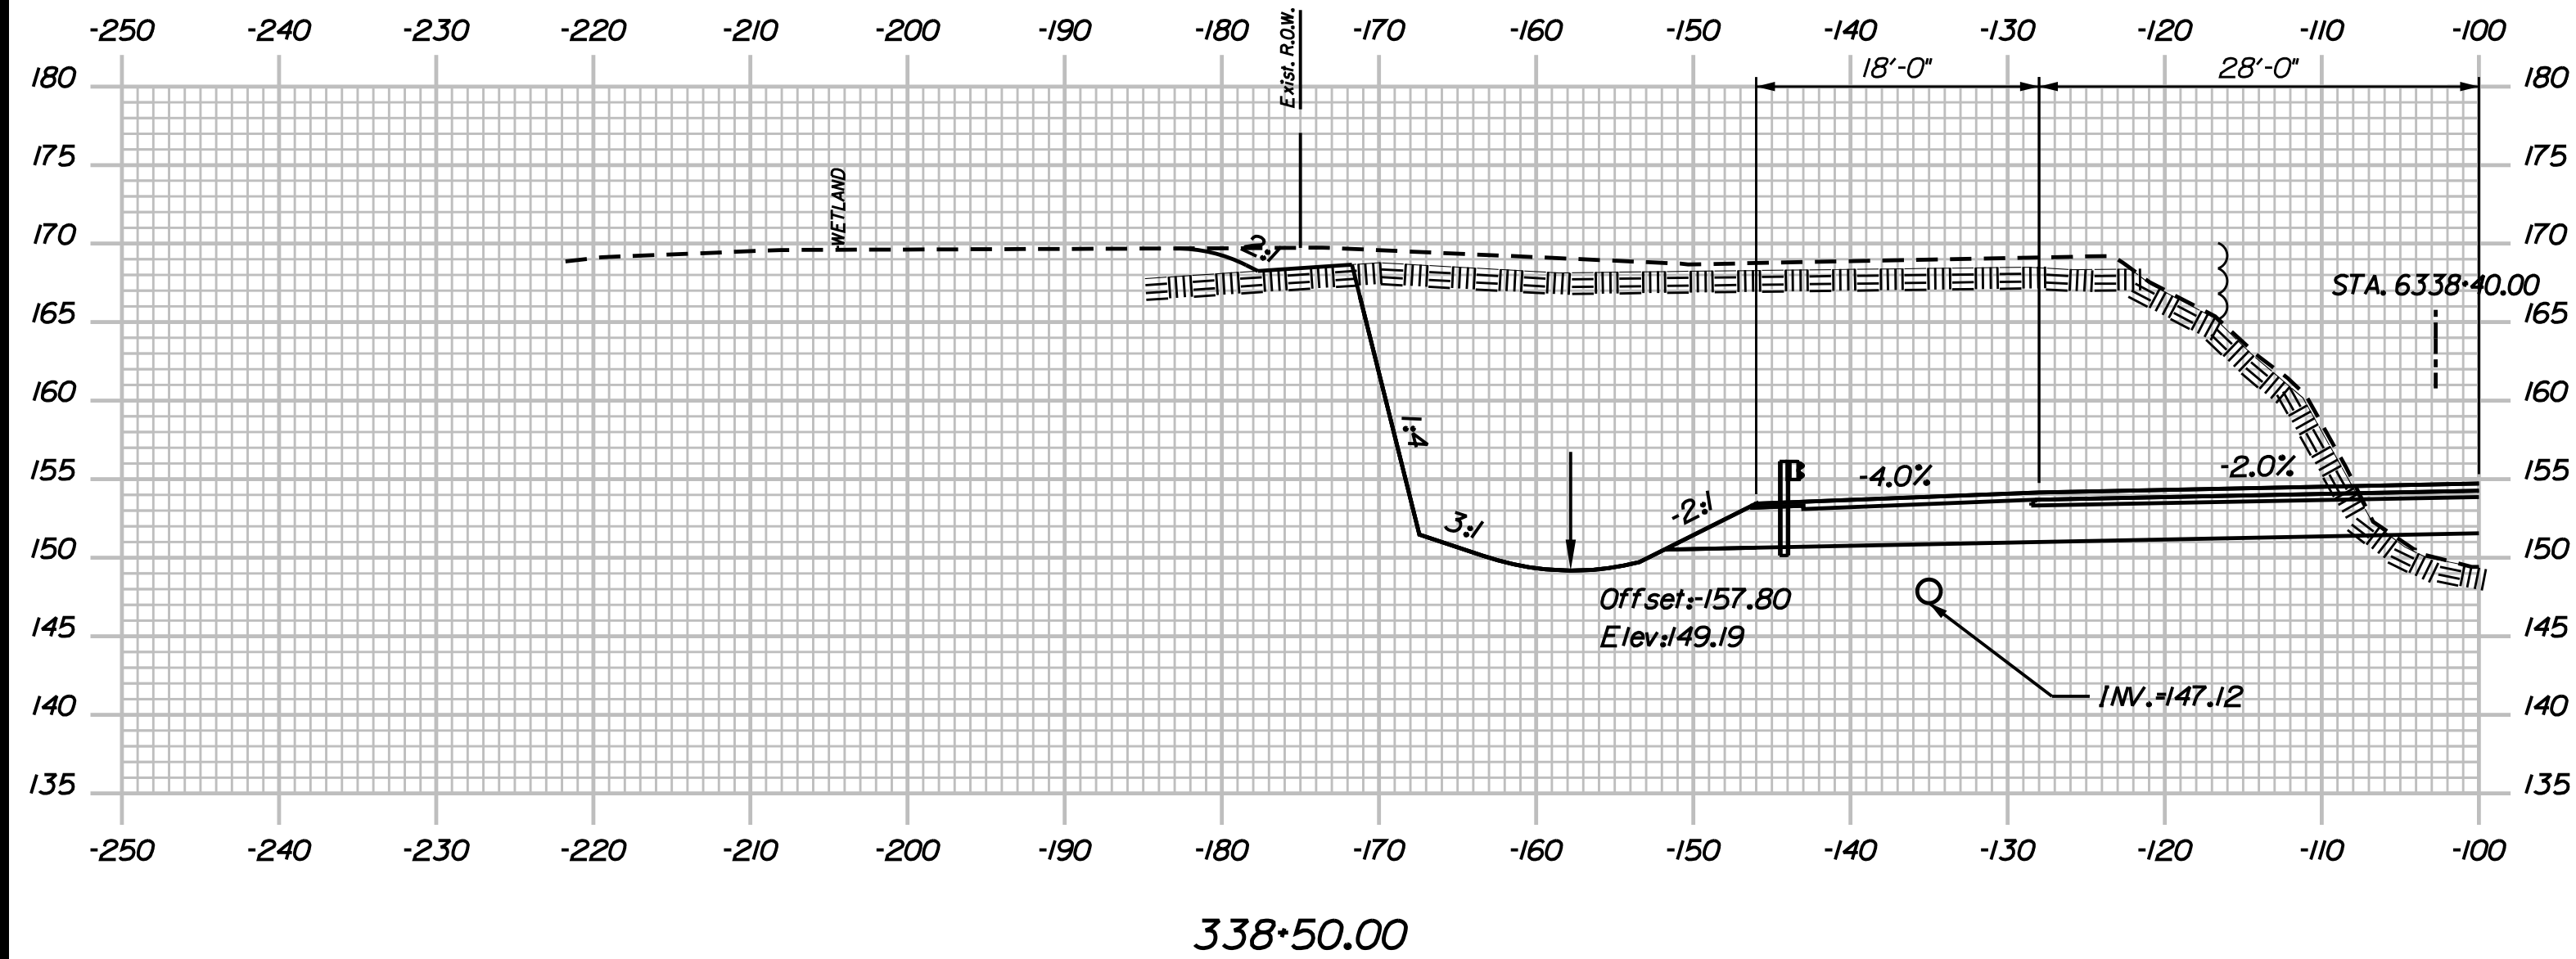

Filename: ...00259637\Xsect\3_195.dgn

Scale: Scale of Feet

No.	Revision	By	Date

Designed by:

JACOBS

CONSULTANT PROJECT MANAGER: T. MORIN

	By	Date		By	Date
Designed	AMS	7-18	Checked	CSM	7-18
Drawn	SMG	7-18	In Charge of	TWM	7-18

JACOBS ENGINEERING GROUP
 120 ST. JAMES AVENUE
 BOSTON, MA 02216
 TEL (617) 242-9222
 FAX (617) 242-9824

THE GOLD STAR MEMORIAL HIGHWAY

MTA PROJECT MANAGER: R. NORWOOD



YORK TOLL PLAZA

I-95 CROSS SECTIONS

STA. 338+50

SHEET NUMBER: XS-31
 CONTRACT: 2018.20
 229 OF 489

Date: 8/28/2018

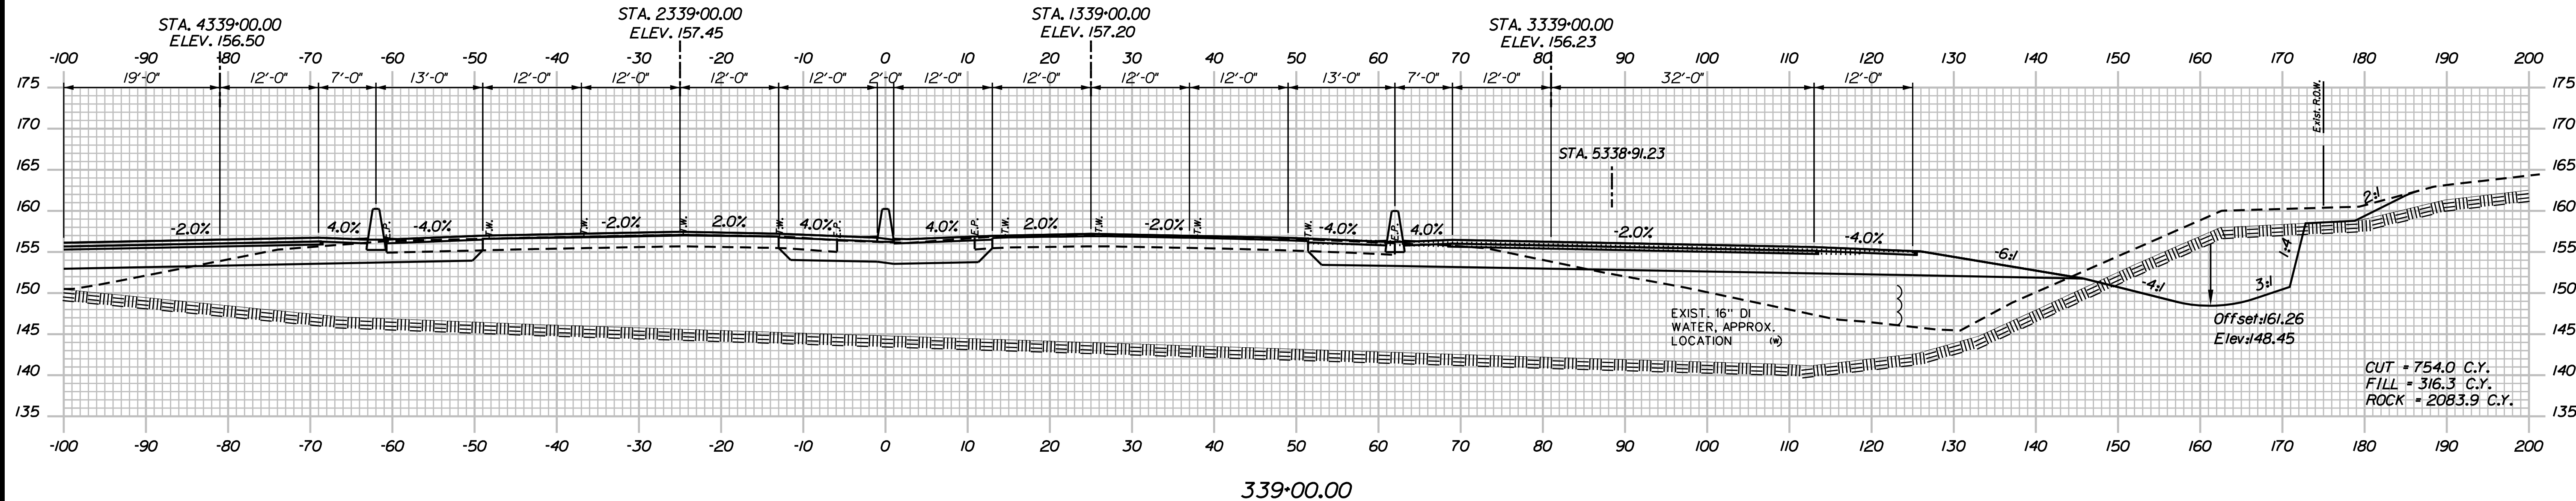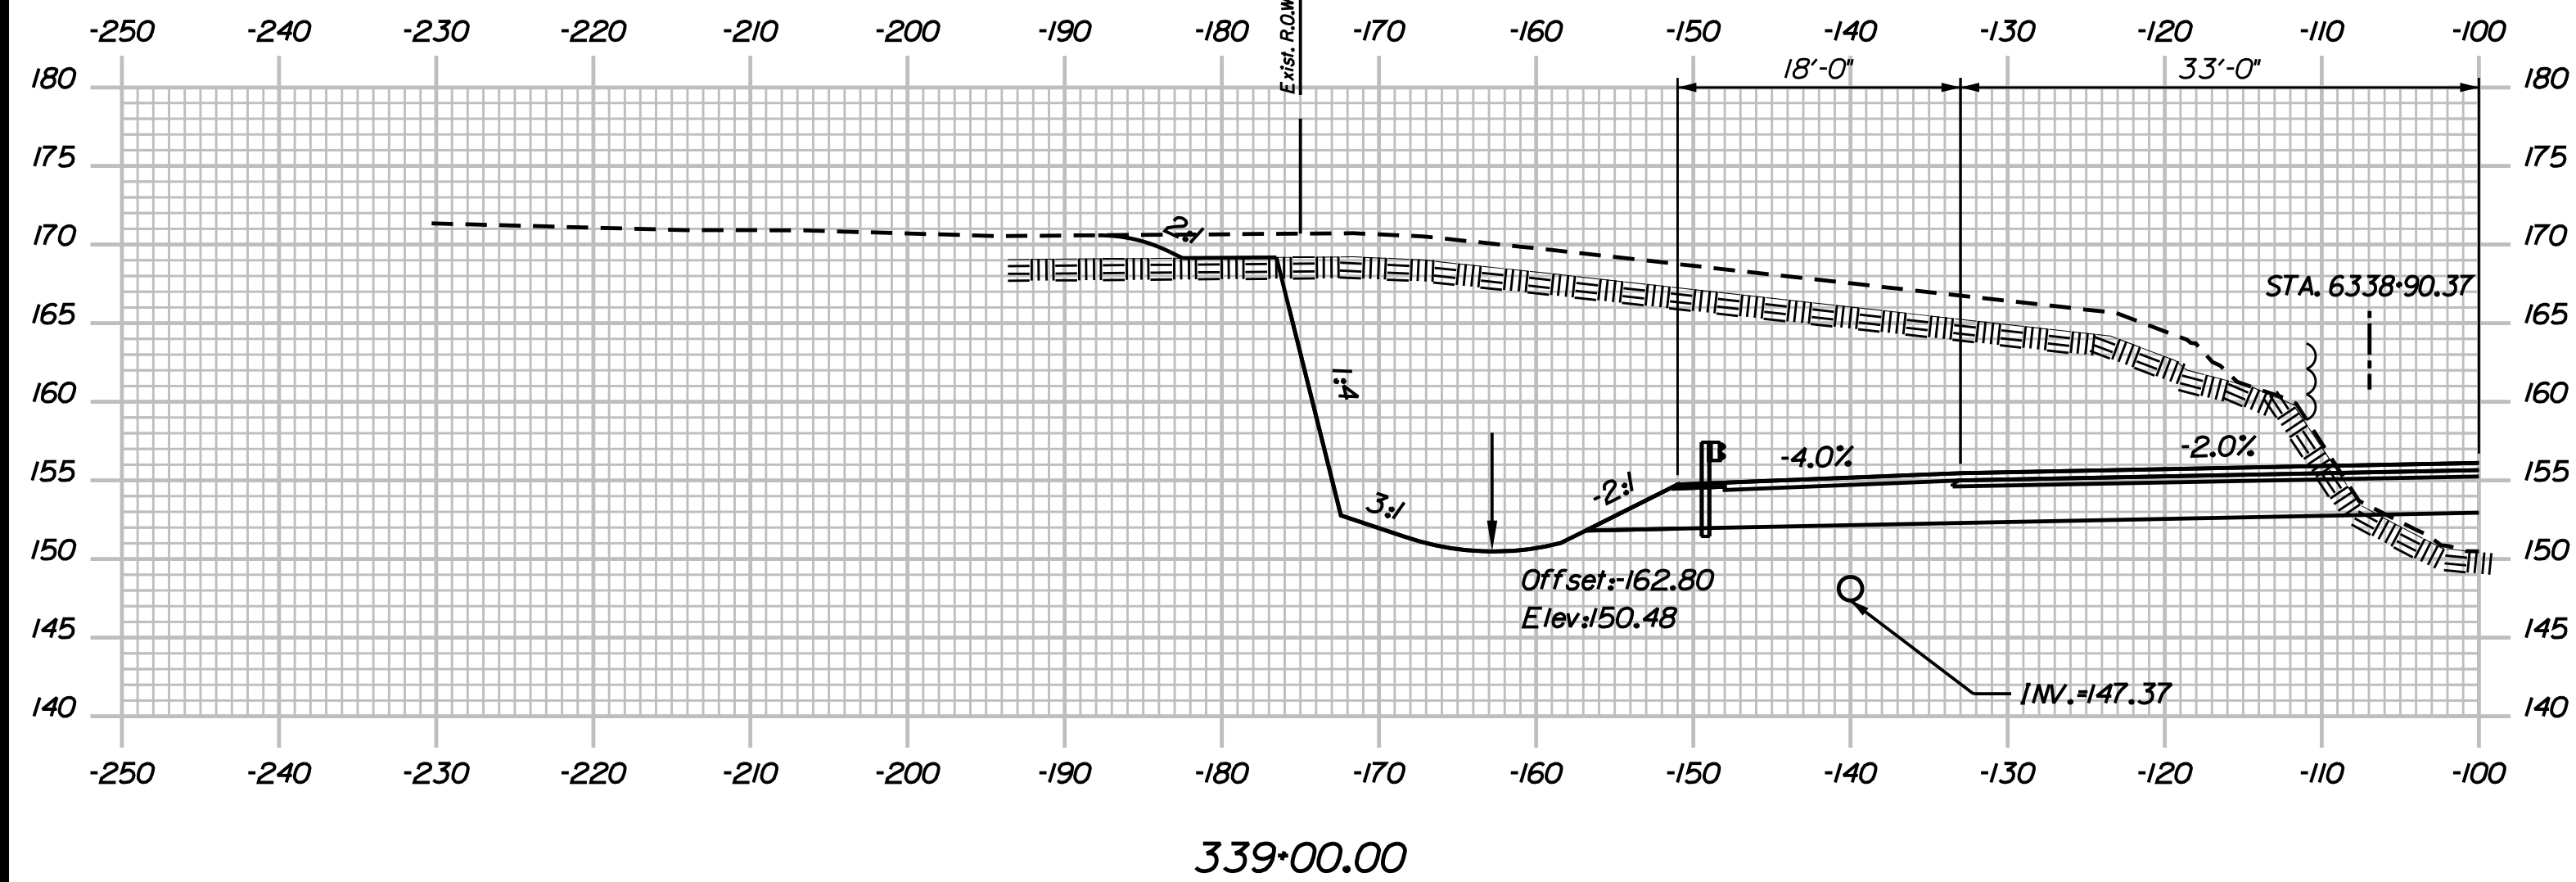

Scale:

No.	Revision	By	Date

Designed by:

JACOBS

CONSULTANT PROJECT MANAGER: T. MORIN

	By	Date		By	Date
Designed	AMS	7-18	Checked	CSM	7-18
Drawn	SMG	7-18	In Charge of	TWM	7-18

JACOBS ENGINEERING GROUP
 120 ST. JAMES AVENUE
 BOSTON, MA 02216
 TEL (617) 242-9222
 FAX (617) 242-9824

**THE GOLD STAR
 MEMORIAL HIGHWAY**

MTA PROJECT MANAGER: R. NORWOOD



YORK TOLL PLAZA
 I-95 CROSS SECTIONS
 STA. 339+00

SHEET NUMBER: XS-32
 230 OF 489

CONTRACT: 2018.20

Filename: ...00259637\Xsect13_195.dgn

Date: 8/28/2018

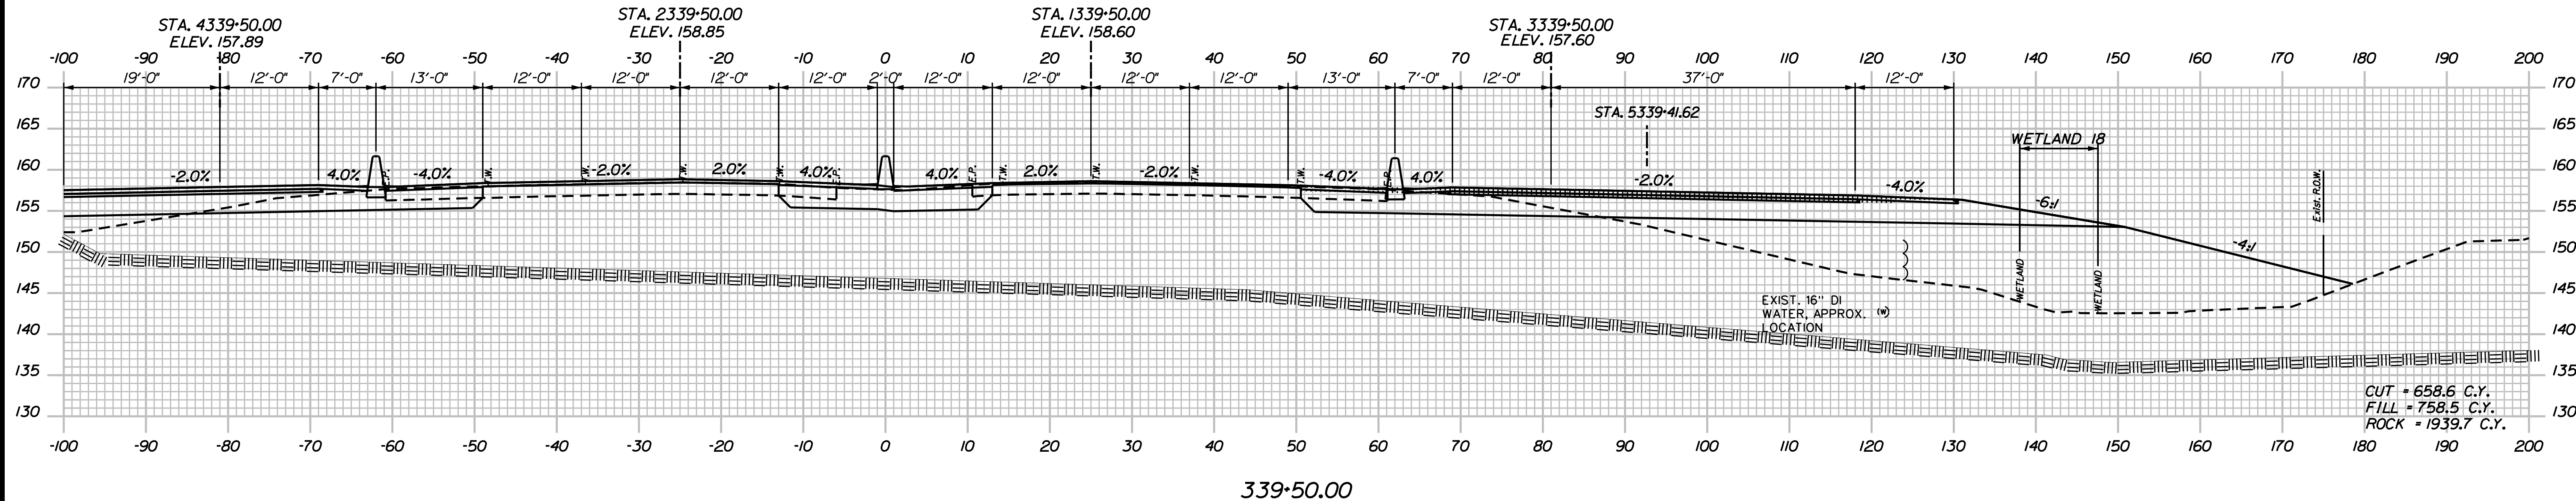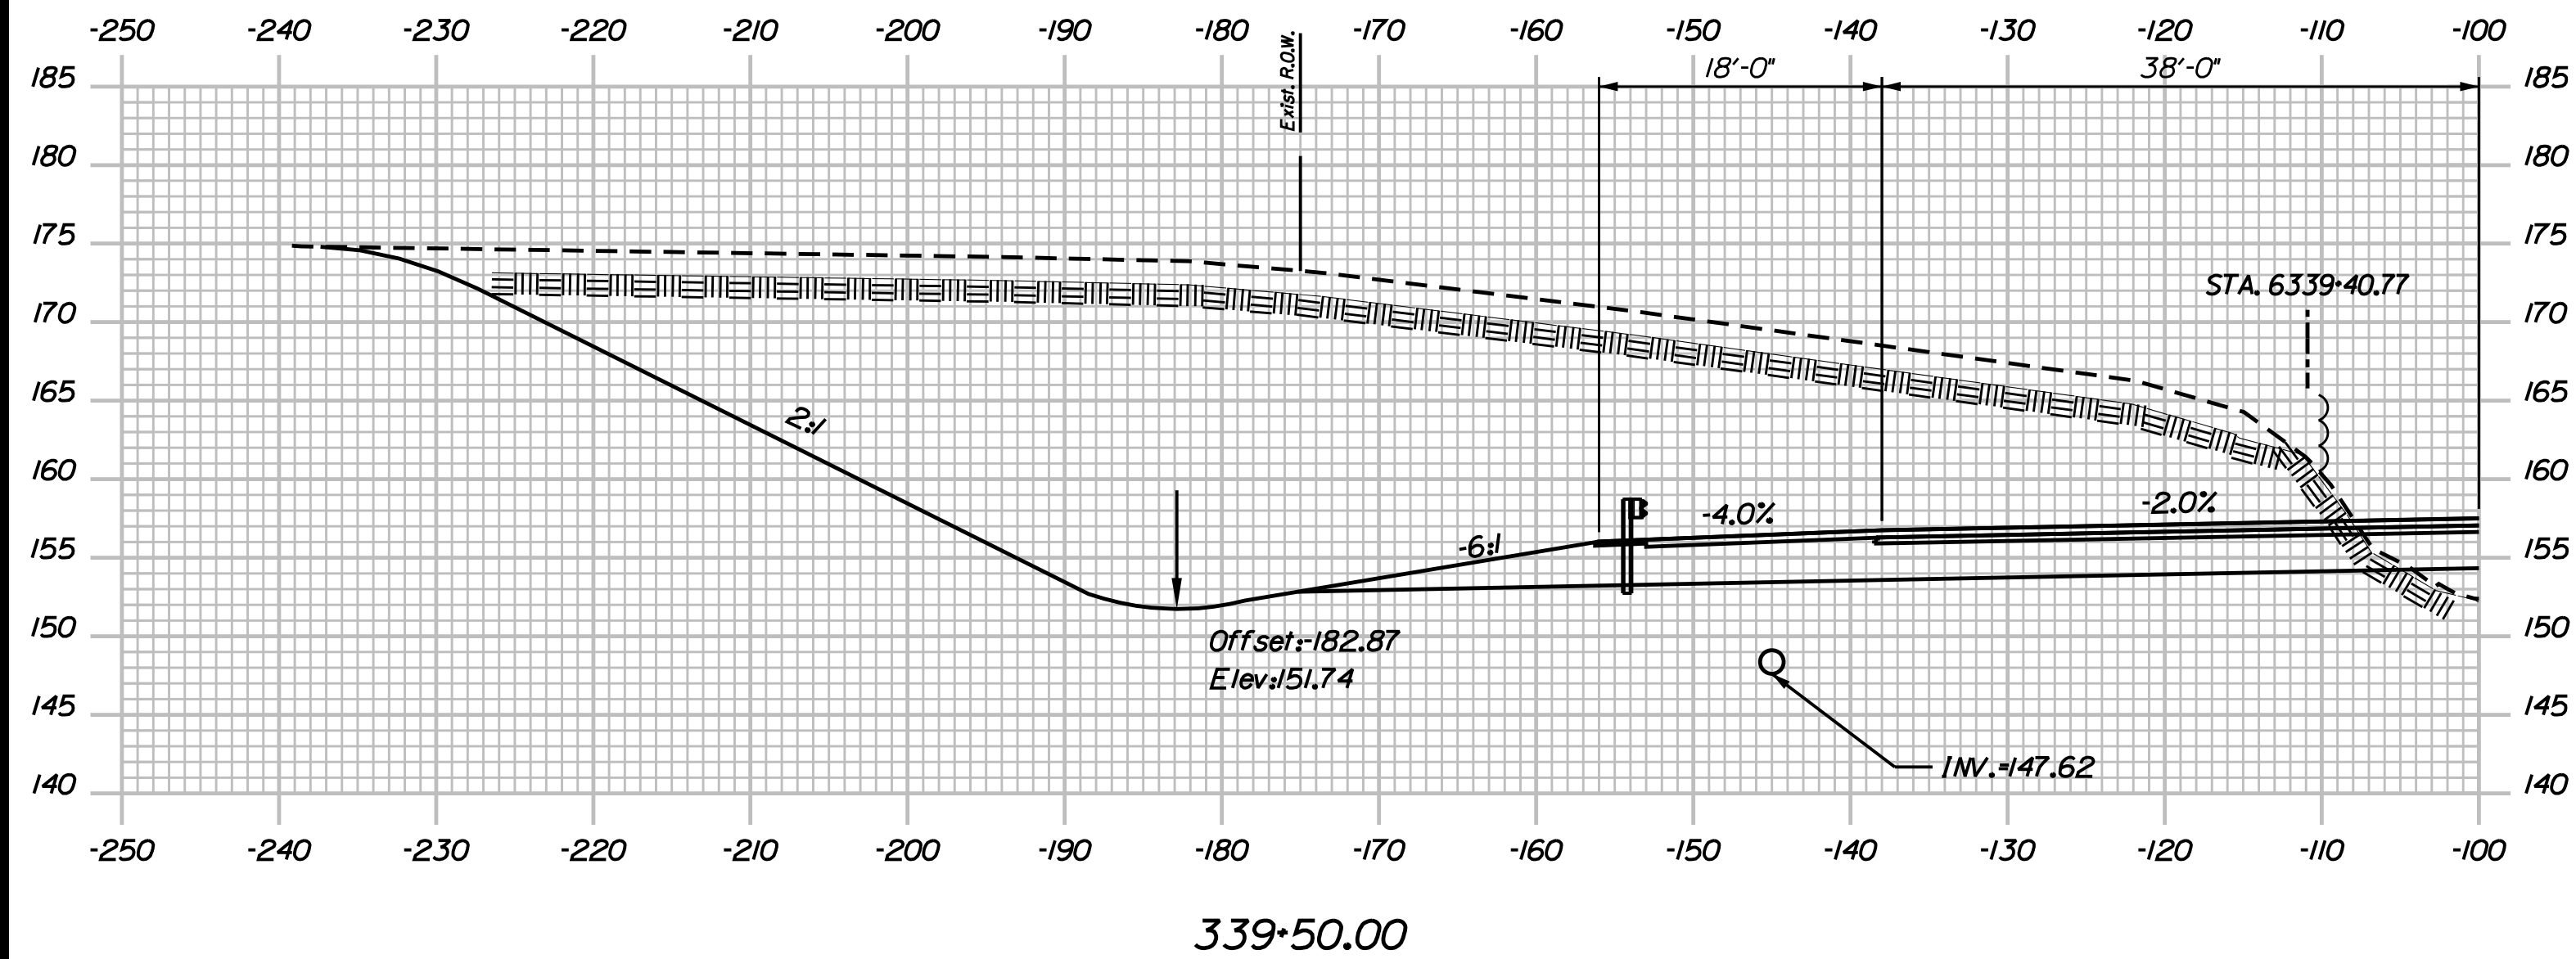

Filename: ...00259637\Xsect13_195.dgn

Scale:

No.	Revision	By	Date

Designed by:

JACOBS

CONSULTANT PROJECT MANAGER: T. MORIN

	By	Date		By	Date
Designed	AMS	7-18	Checked	CSM	7-18
Drawn	SMG	7-18	In Charge of	TWM	7-18

JACOBS ENGINEERING GROUP
 120 ST. JAMES AVENUE
 BOSTON, MA 02216
 TEL (617) 242-9222
 FAX (617) 242-9824

THE GOLD STAR MEMORIAL HIGHWAY

MTA PROJECT MANAGER: R. NORWOOD

YORK TOLL PLAZA



I-95 CROSS SECTIONS STA. 339+50

SHEET NUMBER: XS-33
 231 OF 489

CONTRACT: 2018.20

CUT = 658.6 C.Y.
 FILL = 758.5 C.Y.
 ROCK = 1939.7 C.Y.

Date: 8/28/2018

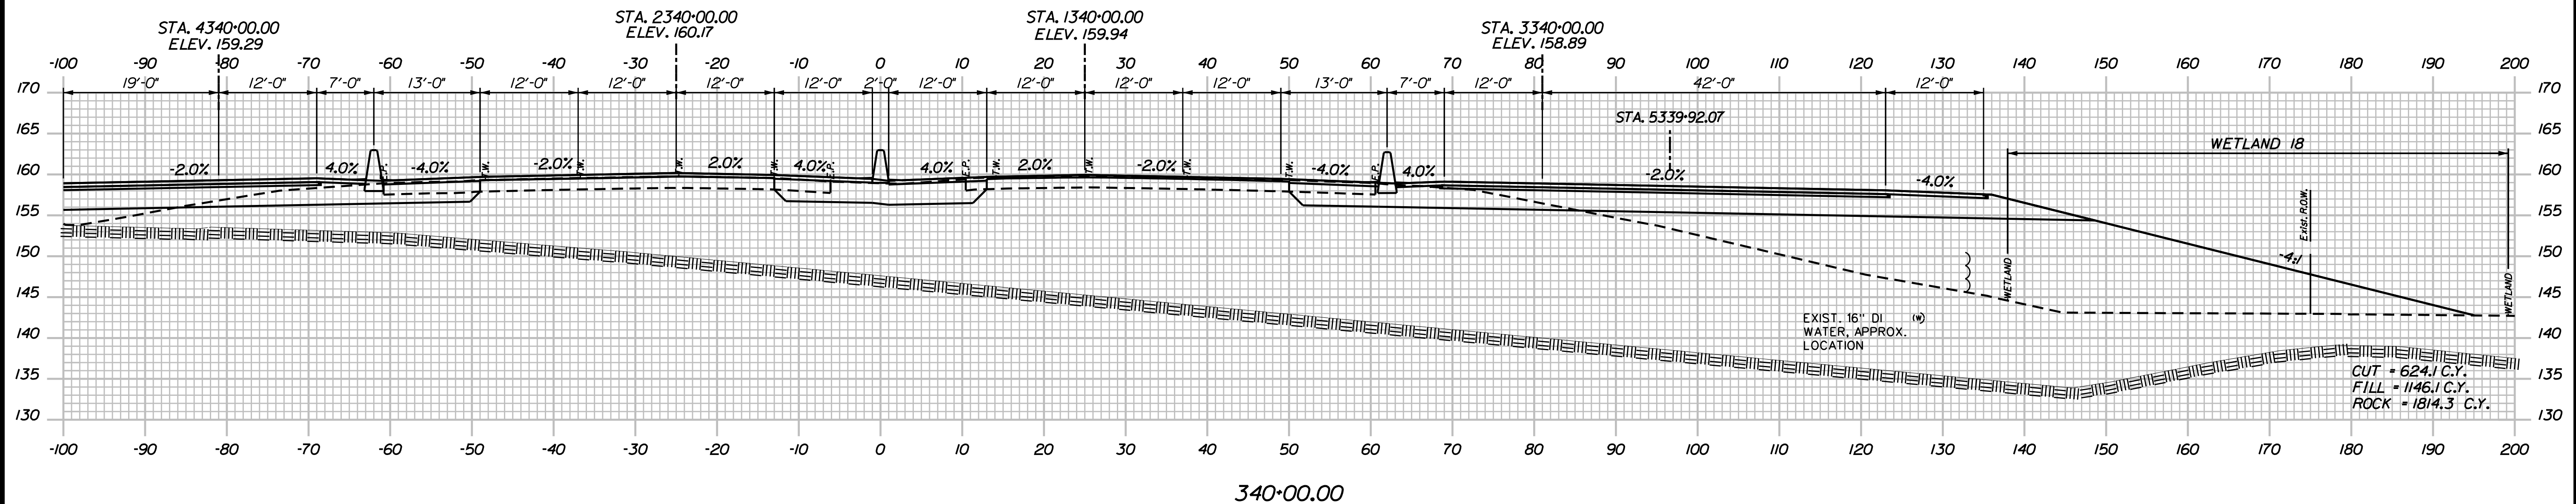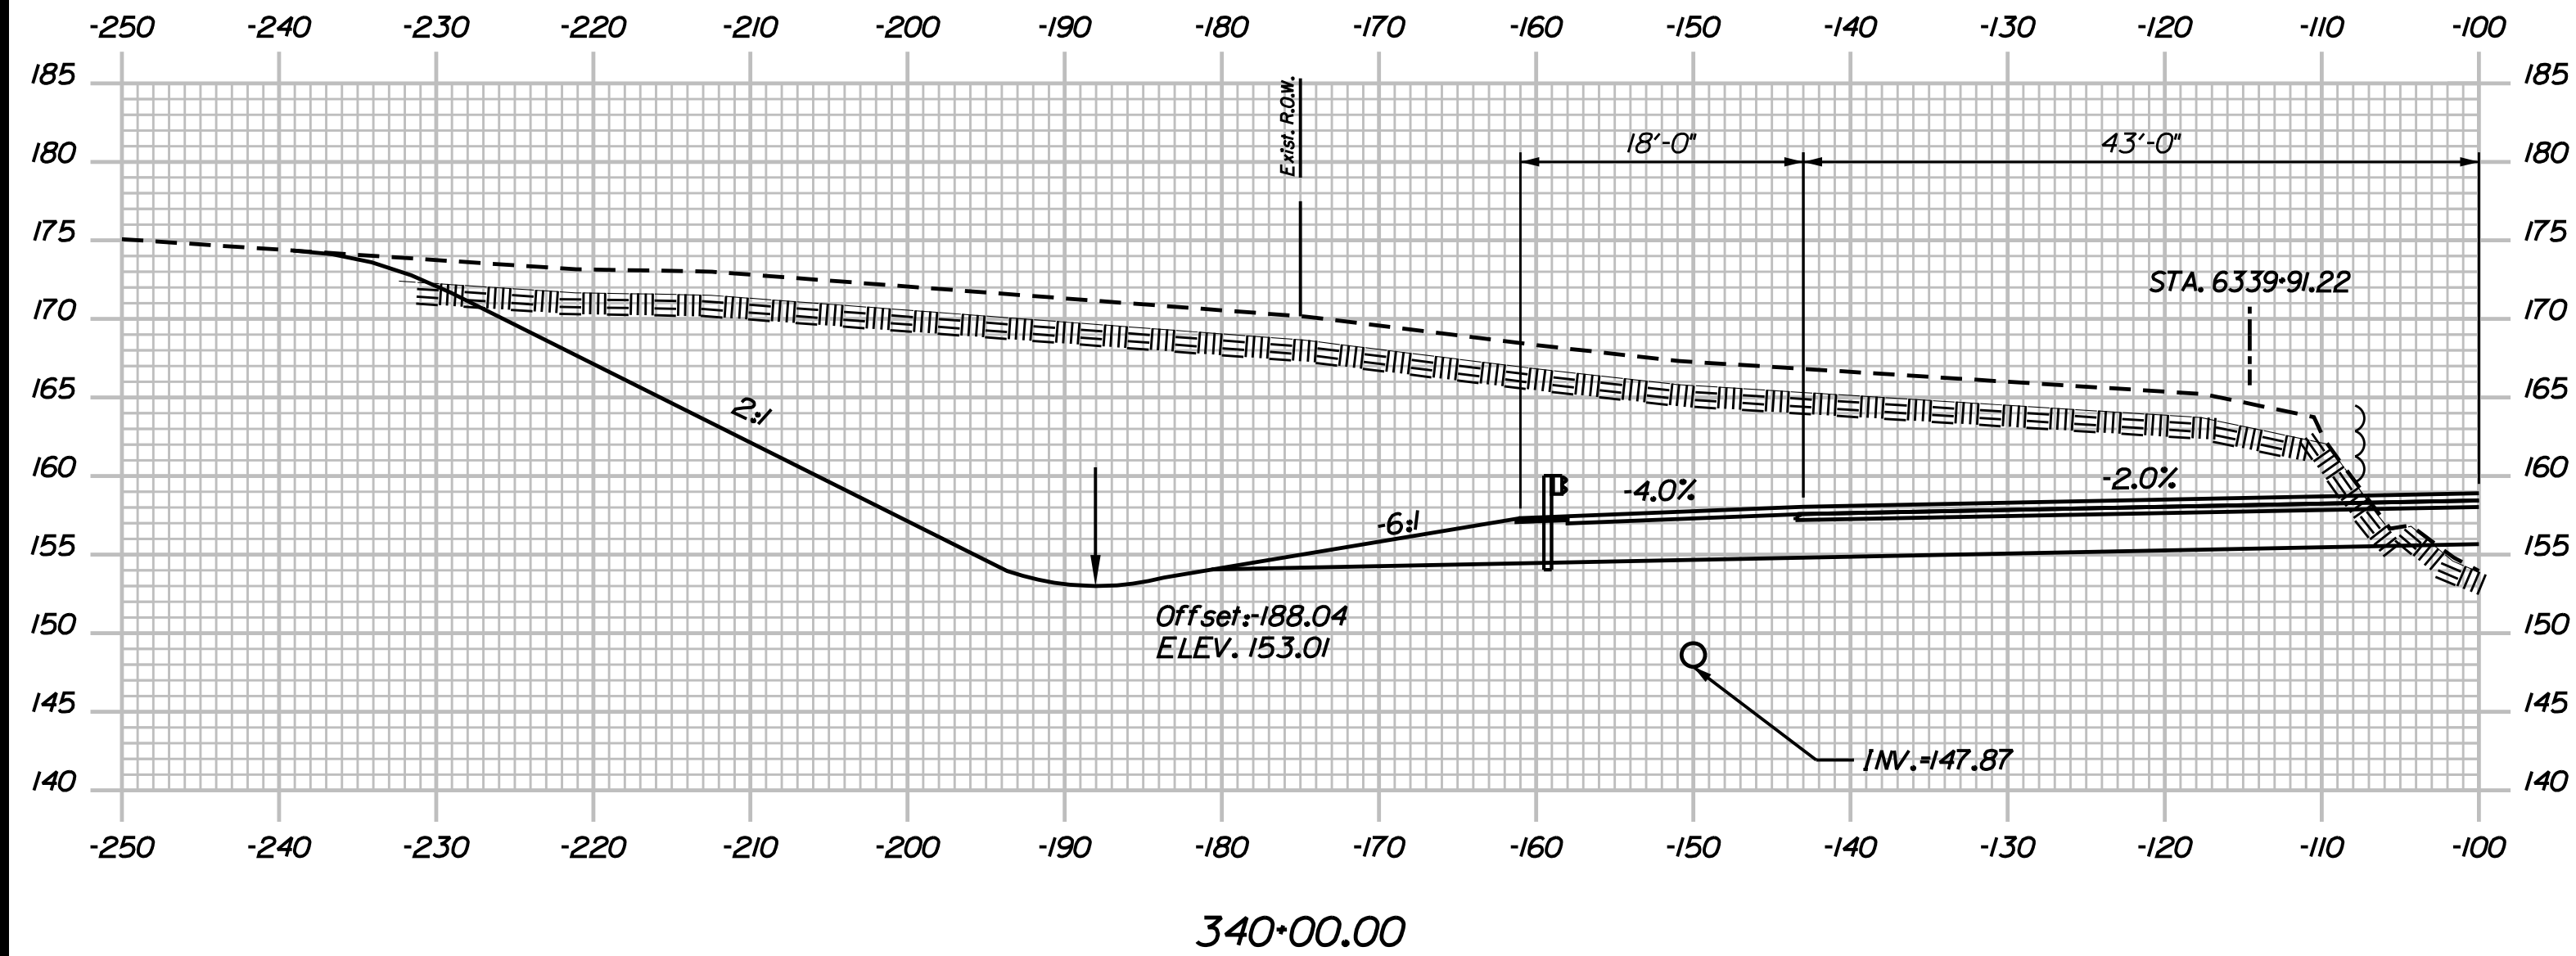

Filename: ...00259637\Xsect13_195.dgn

Scale:

No.	Revision	By	Date

Designed by:

JACOBS

CONSULTANT PROJECT MANAGER: T. MORIN

	By	Date		By	Date
Designed	AMS	7-18	Checked	CSM	7-18
Drawn	SMG	7-18	In Charge of	TWM	7-18

JACOBS ENGINEERING GROUP
 120 ST. JAMES AVENUE
 BOSTON, MA 02216
 TEL (617) 242-9222
 FAX (617) 242-9824




THE GOLD STAR
 MEMORIAL HIGHWAY

MTA PROJECT MANAGER: R. NORWOOD

YORK TOLL PLAZA
 I-95 CROSS SECTIONS
 STA. 340+00

SHEET NUMBER: XS-34
 CONTRACT: 2018.20
 232 OF 489

Date: 8/28/2018

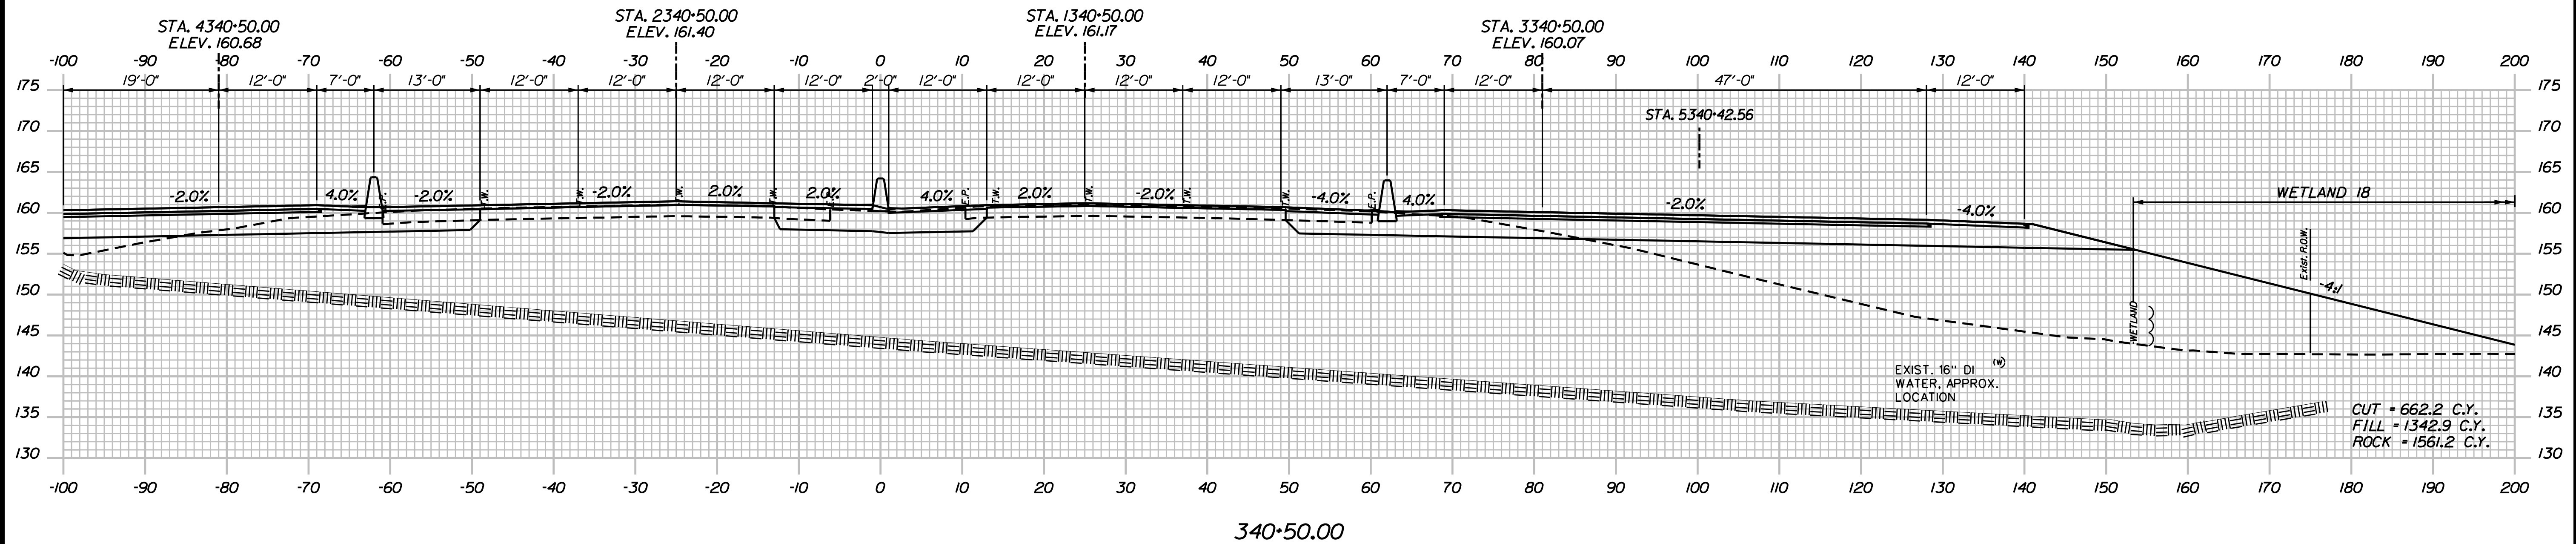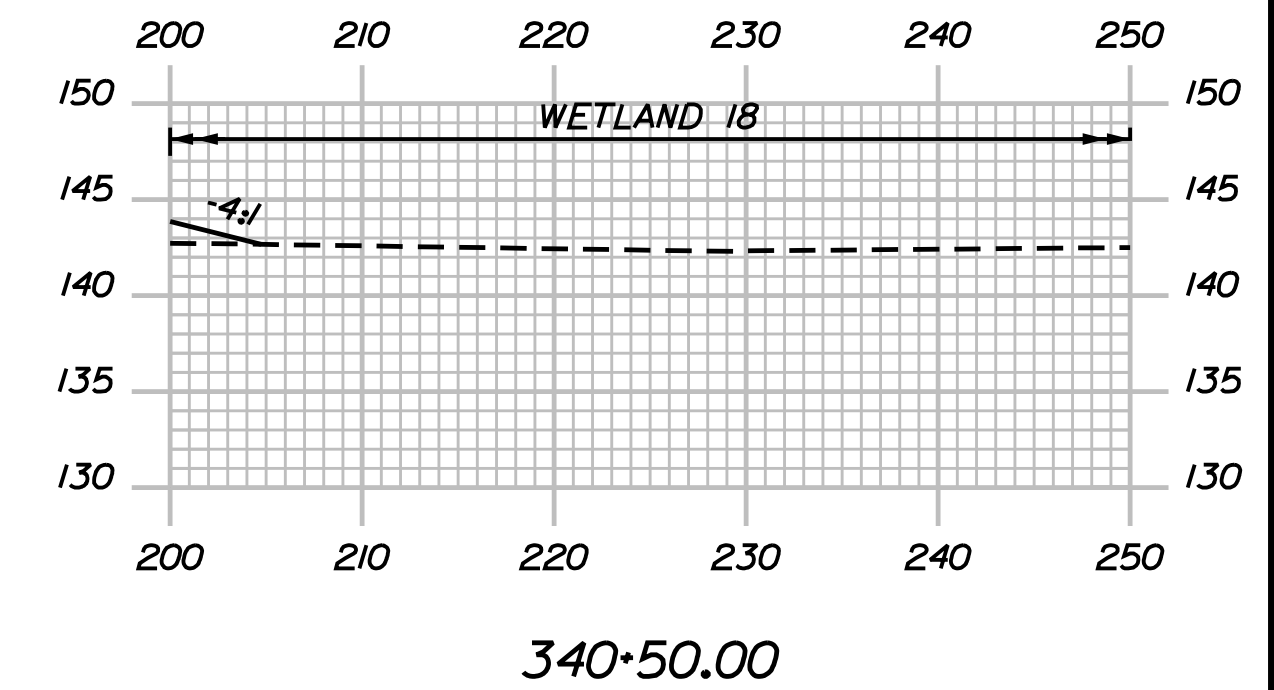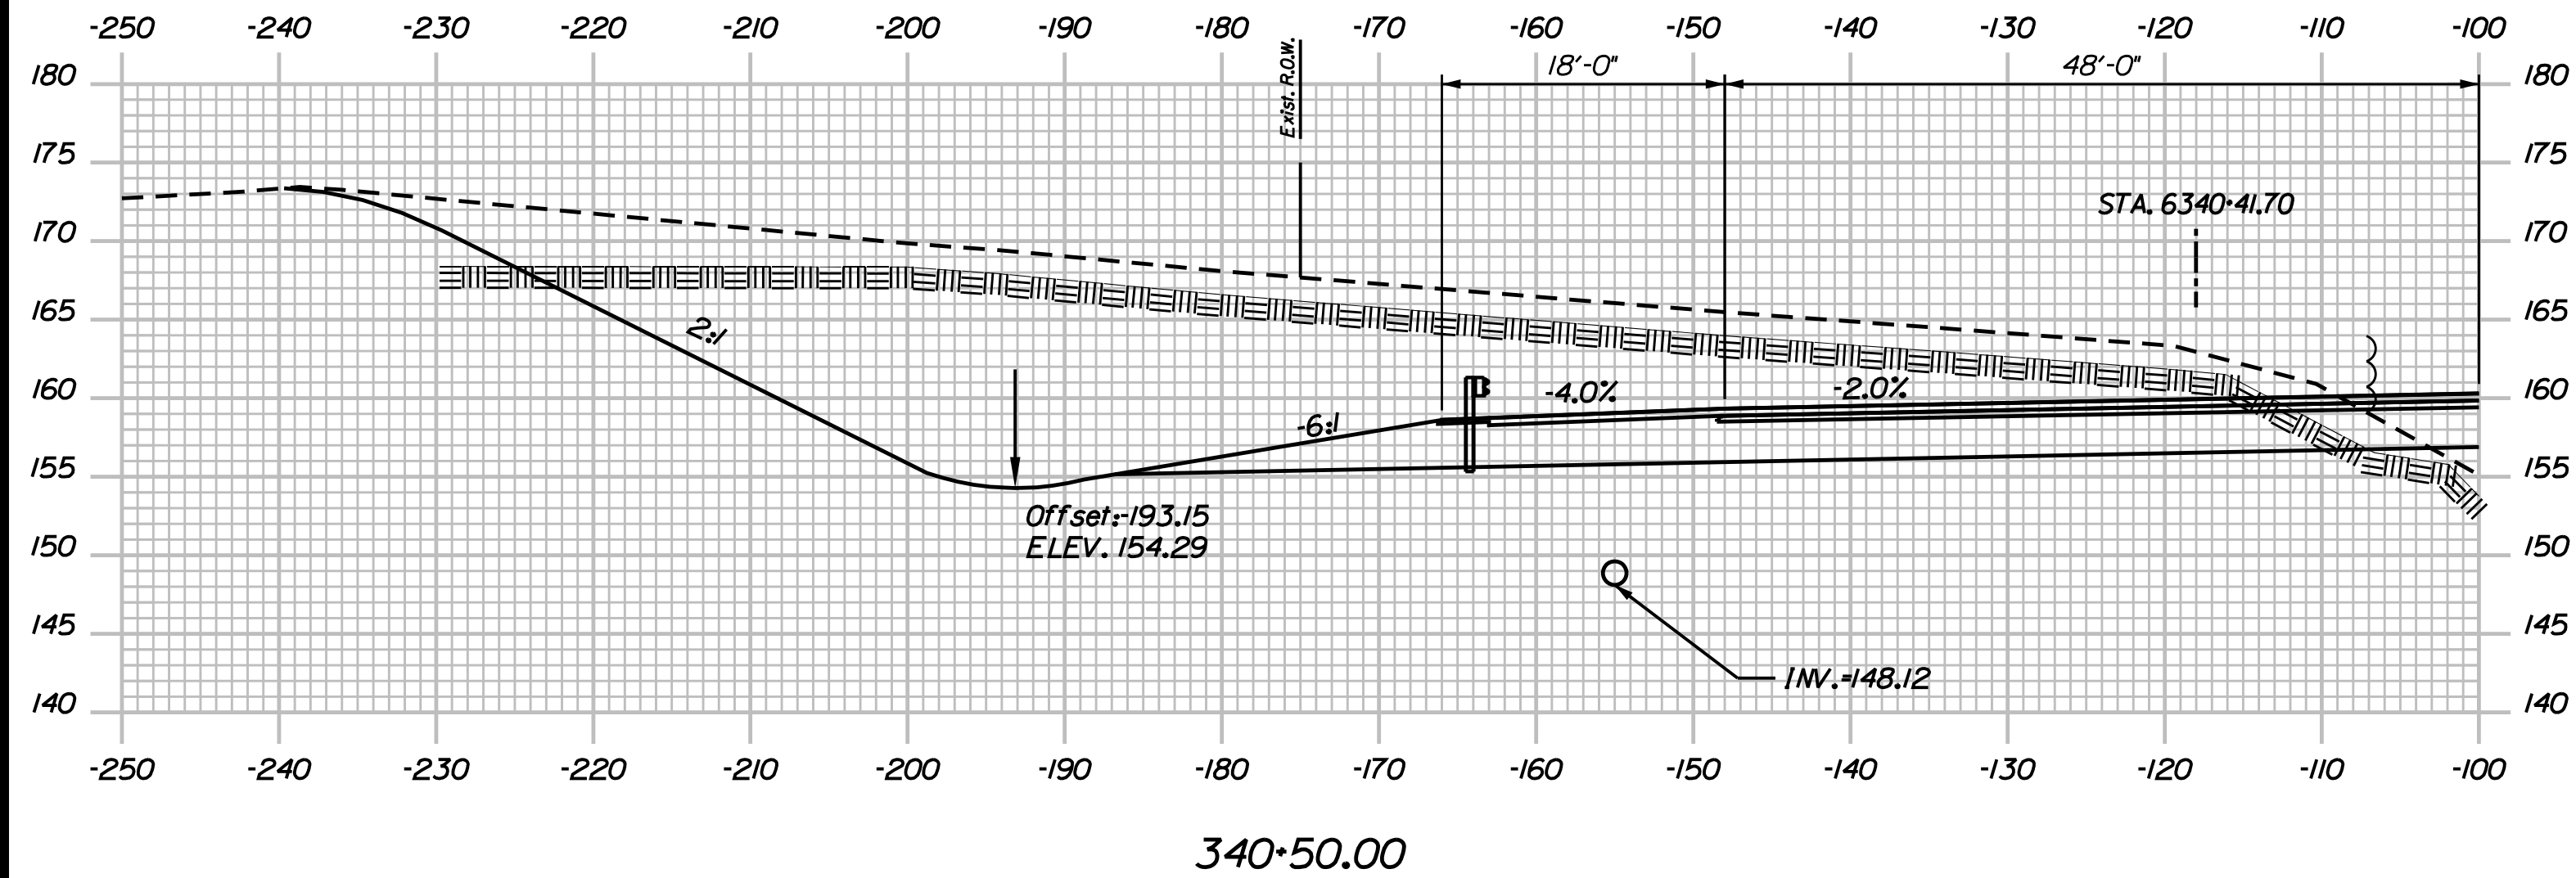

Filename: ...00259637\Xsect13_195.dgn

Scale:

No.	Revision	By	Date

Designed by:

JACOBS

CONSULTANT PROJECT MANAGER: T. MORIN

	By	Date		By	Date
Designed	AMS	7-18	Checked	CSM	7-18
Drawn	SMG	7-18	In Charge of	TWM	7-18

JACOBS ENGINEERING GROUP
 120 ST. JAMES AVENUE
 BOSTON, MA 02216
 TEL (617) 242-9222
 FAX (617) 242-9824

THE GOLD STAR MEMORIAL HIGHWAY




MTA PROJECT MANAGER: R. NORWOOD

YORK TOLL PLAZA
 I-95 CROSS SECTIONS
 STA. 340+50


SHEET NUMBER: XS-35
 233 OF 489

CONTRACT: 2018.20

Date: 8/28/2018

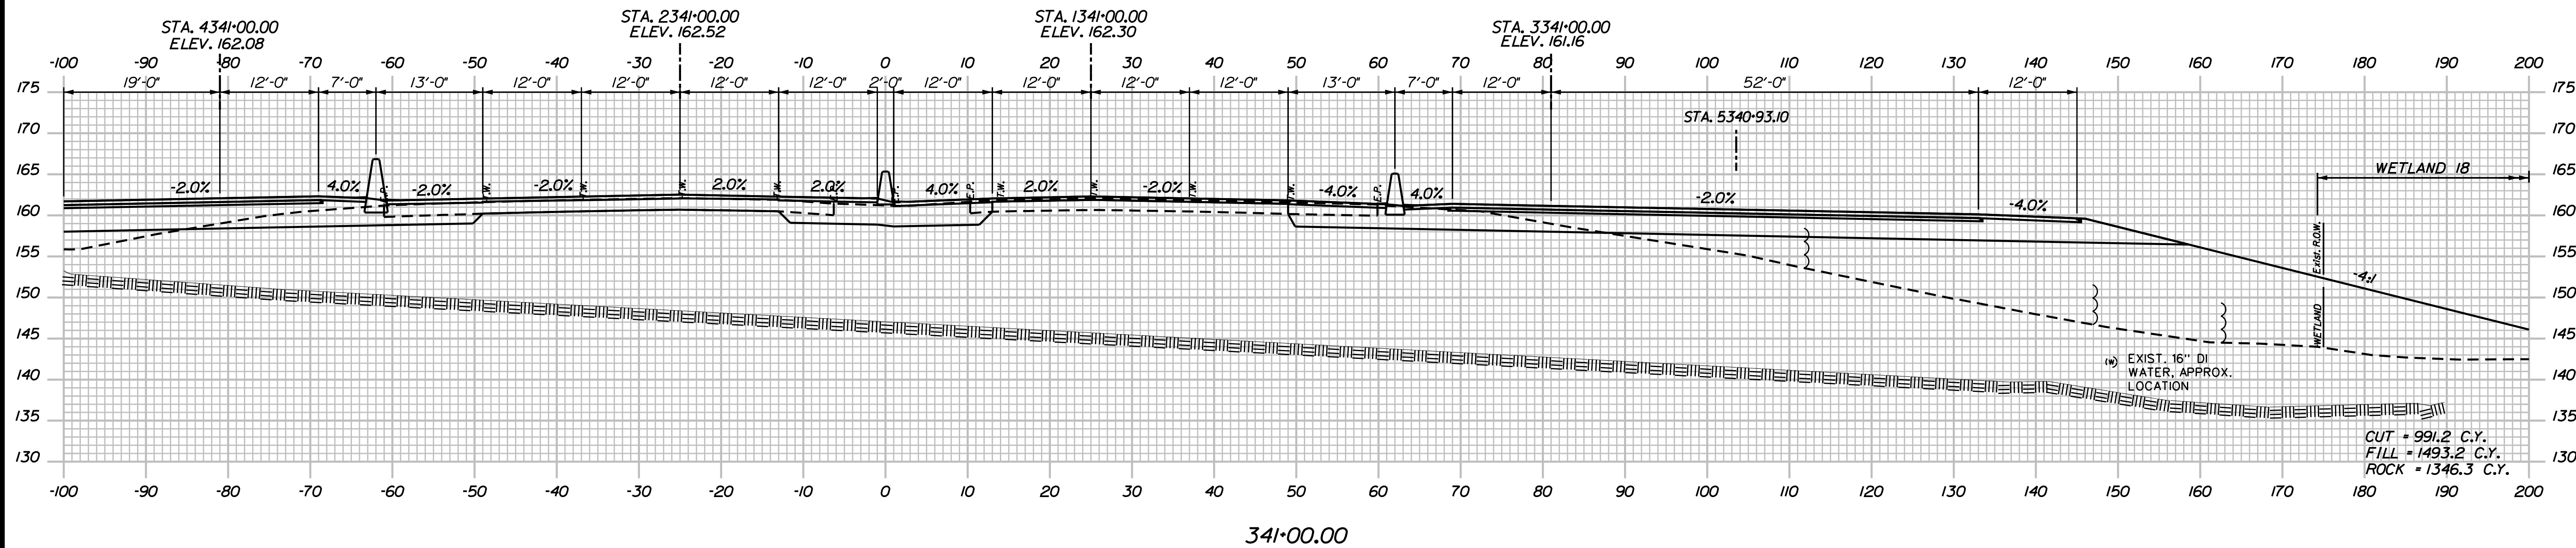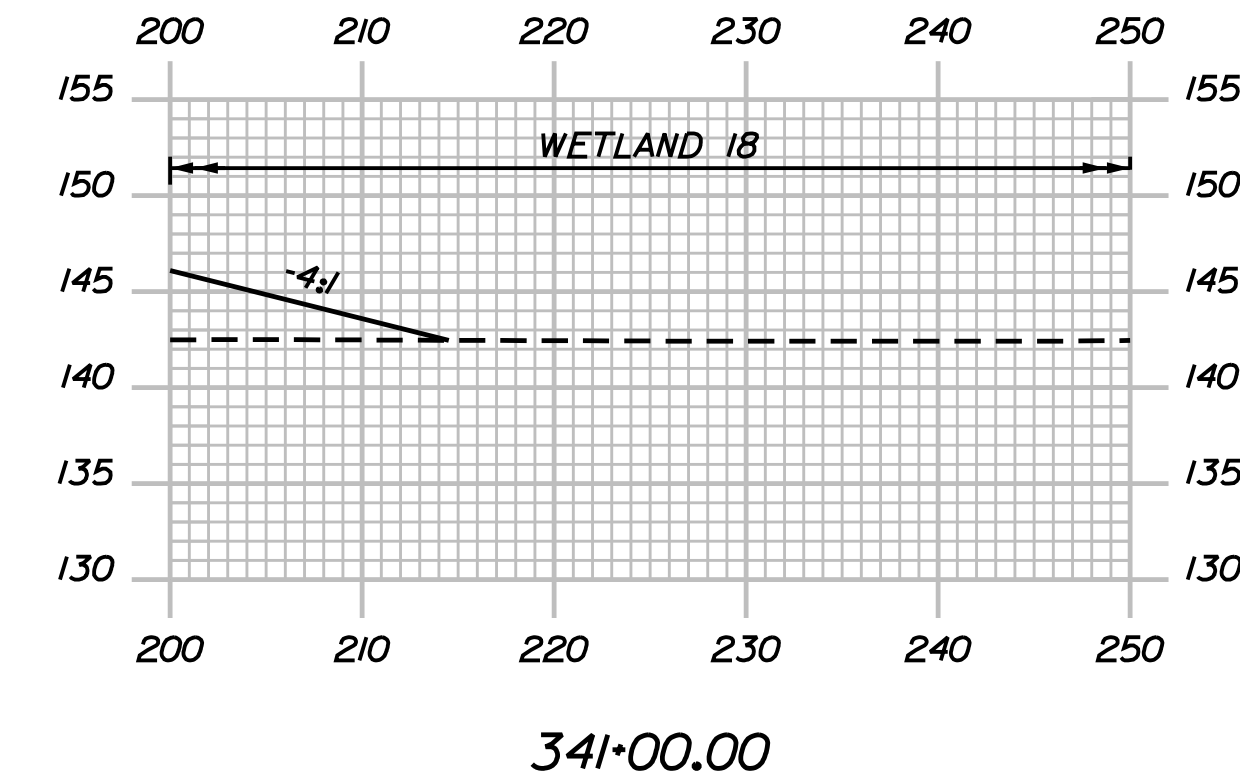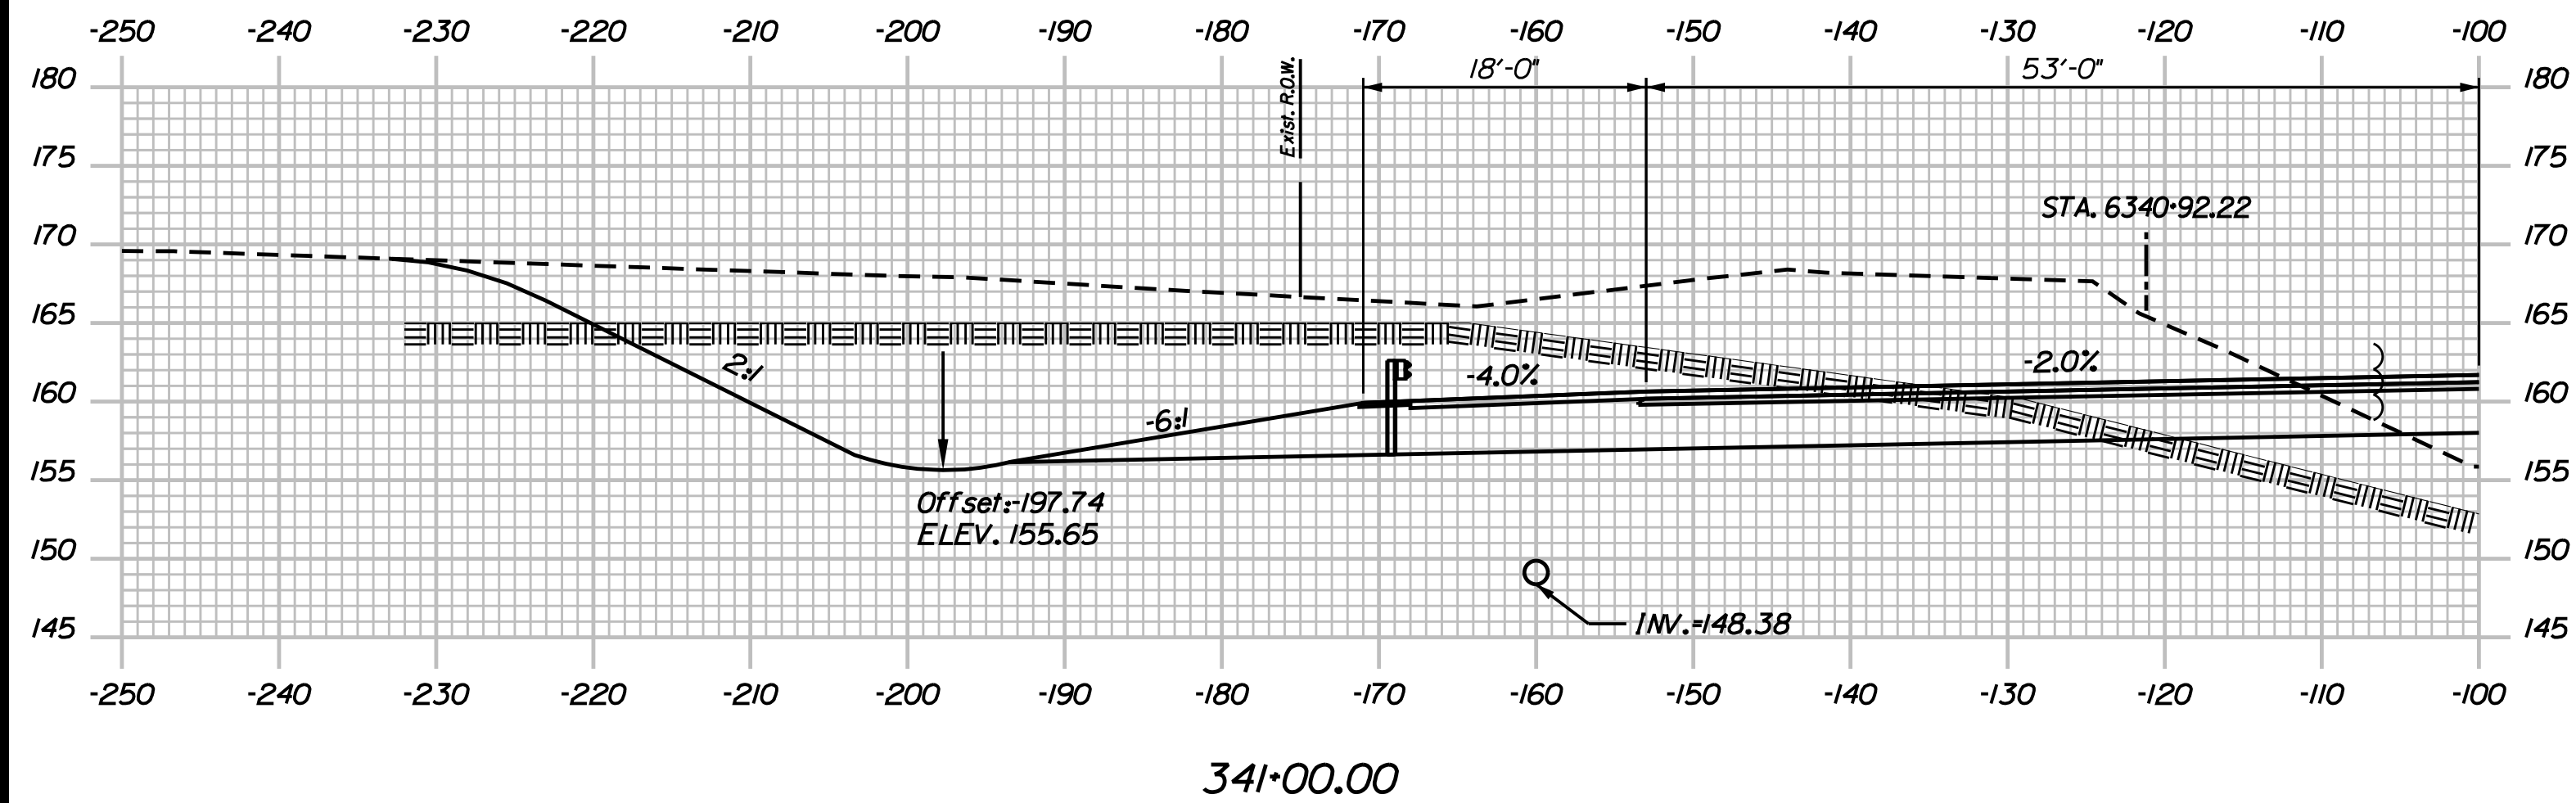

Filename: ...00259637\Xsect13_195.dgn

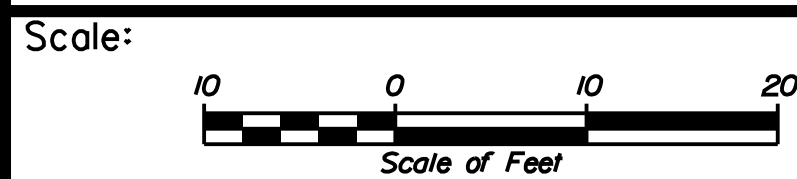

No.	Revision	By	Date

Designed by:

JACOBS

CONSULTANT PROJECT MANAGER: T. MORIN

	By	Date		By	Date
Designed	AMS	7-18	Checked	CSM	7-18
Drawn	SMG	7-18	In Charge of	TWM	7-18

JACOBS ENGINEERING GROUP
 120 ST. JAMES AVENUE
 BOSTON, MA 02216
 TEL (617) 242-9222
 FAX (617) 242-9824

THE GOLD STAR MEMORIAL HIGHWAY

MTA PROJECT MANAGER: R. NORWOOD

YORK TOLL PLAZA

I-95 CROSS SECTIONS




STA. 341+00

SHEET NUMBER: XS-36

CONTRACT: 2018.20

234 OF 489

Date: 8/28/2018

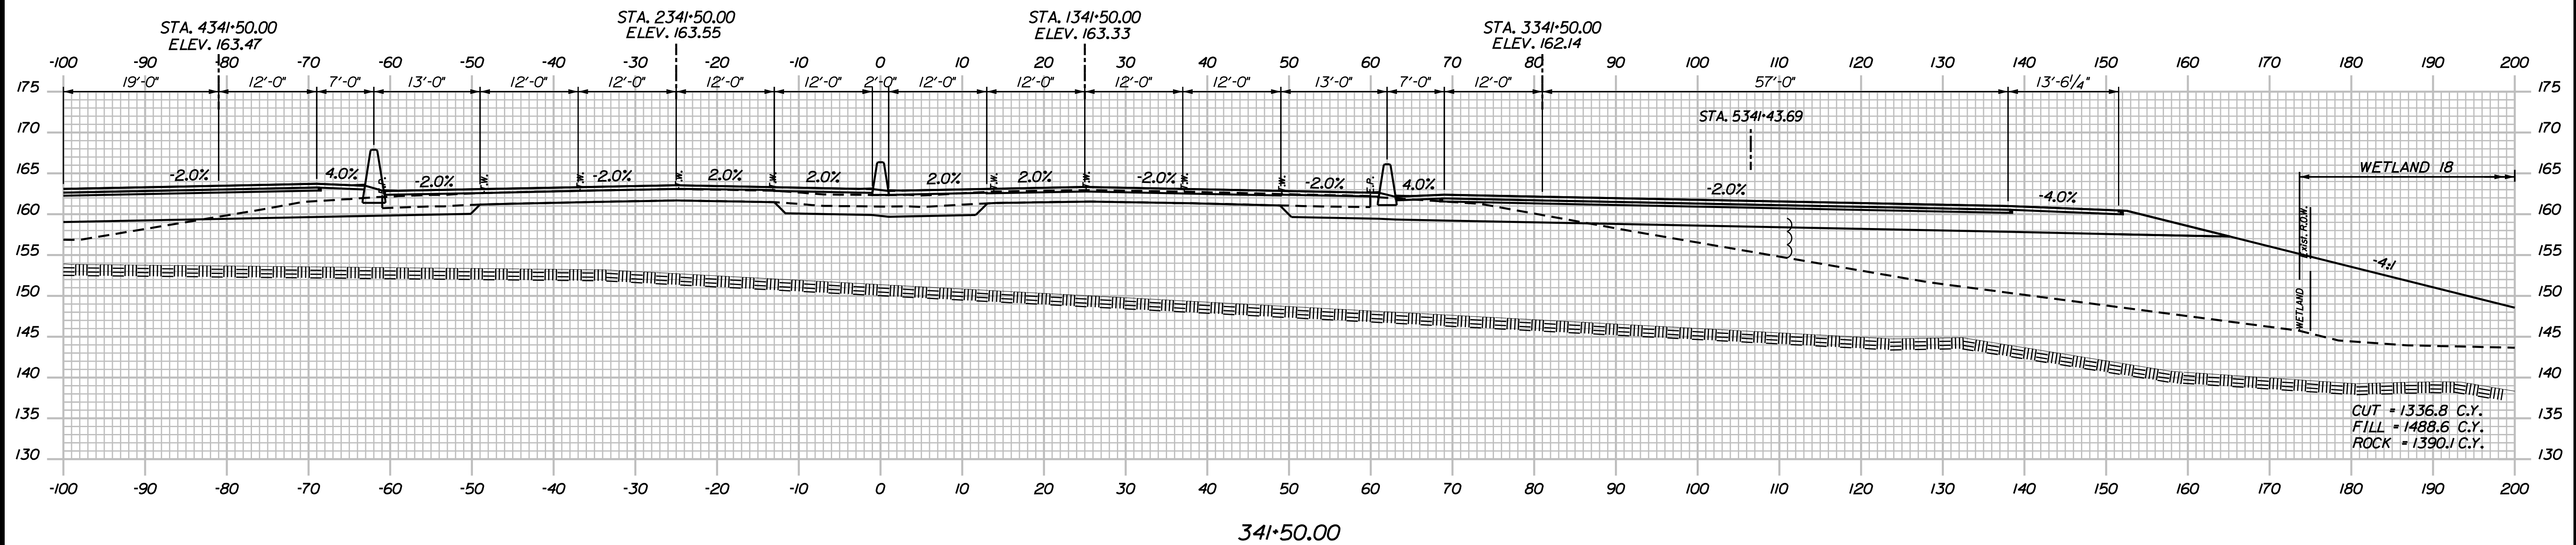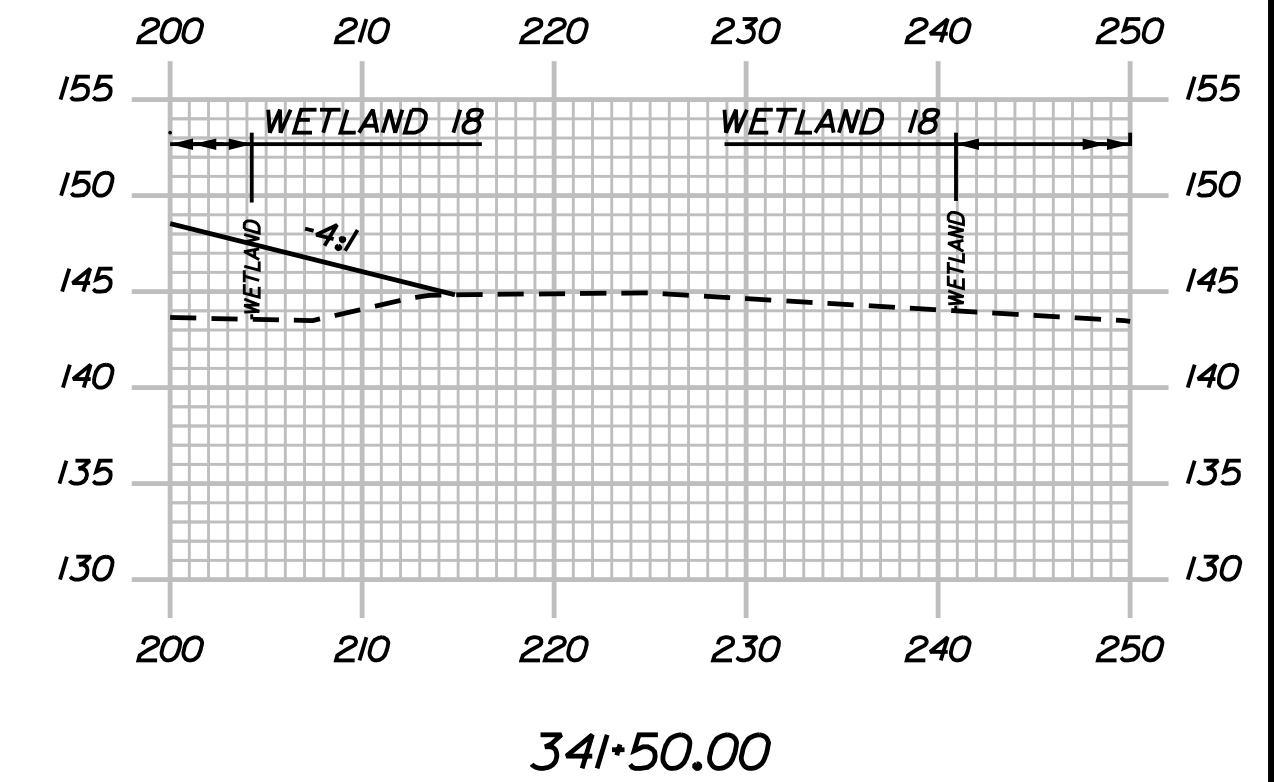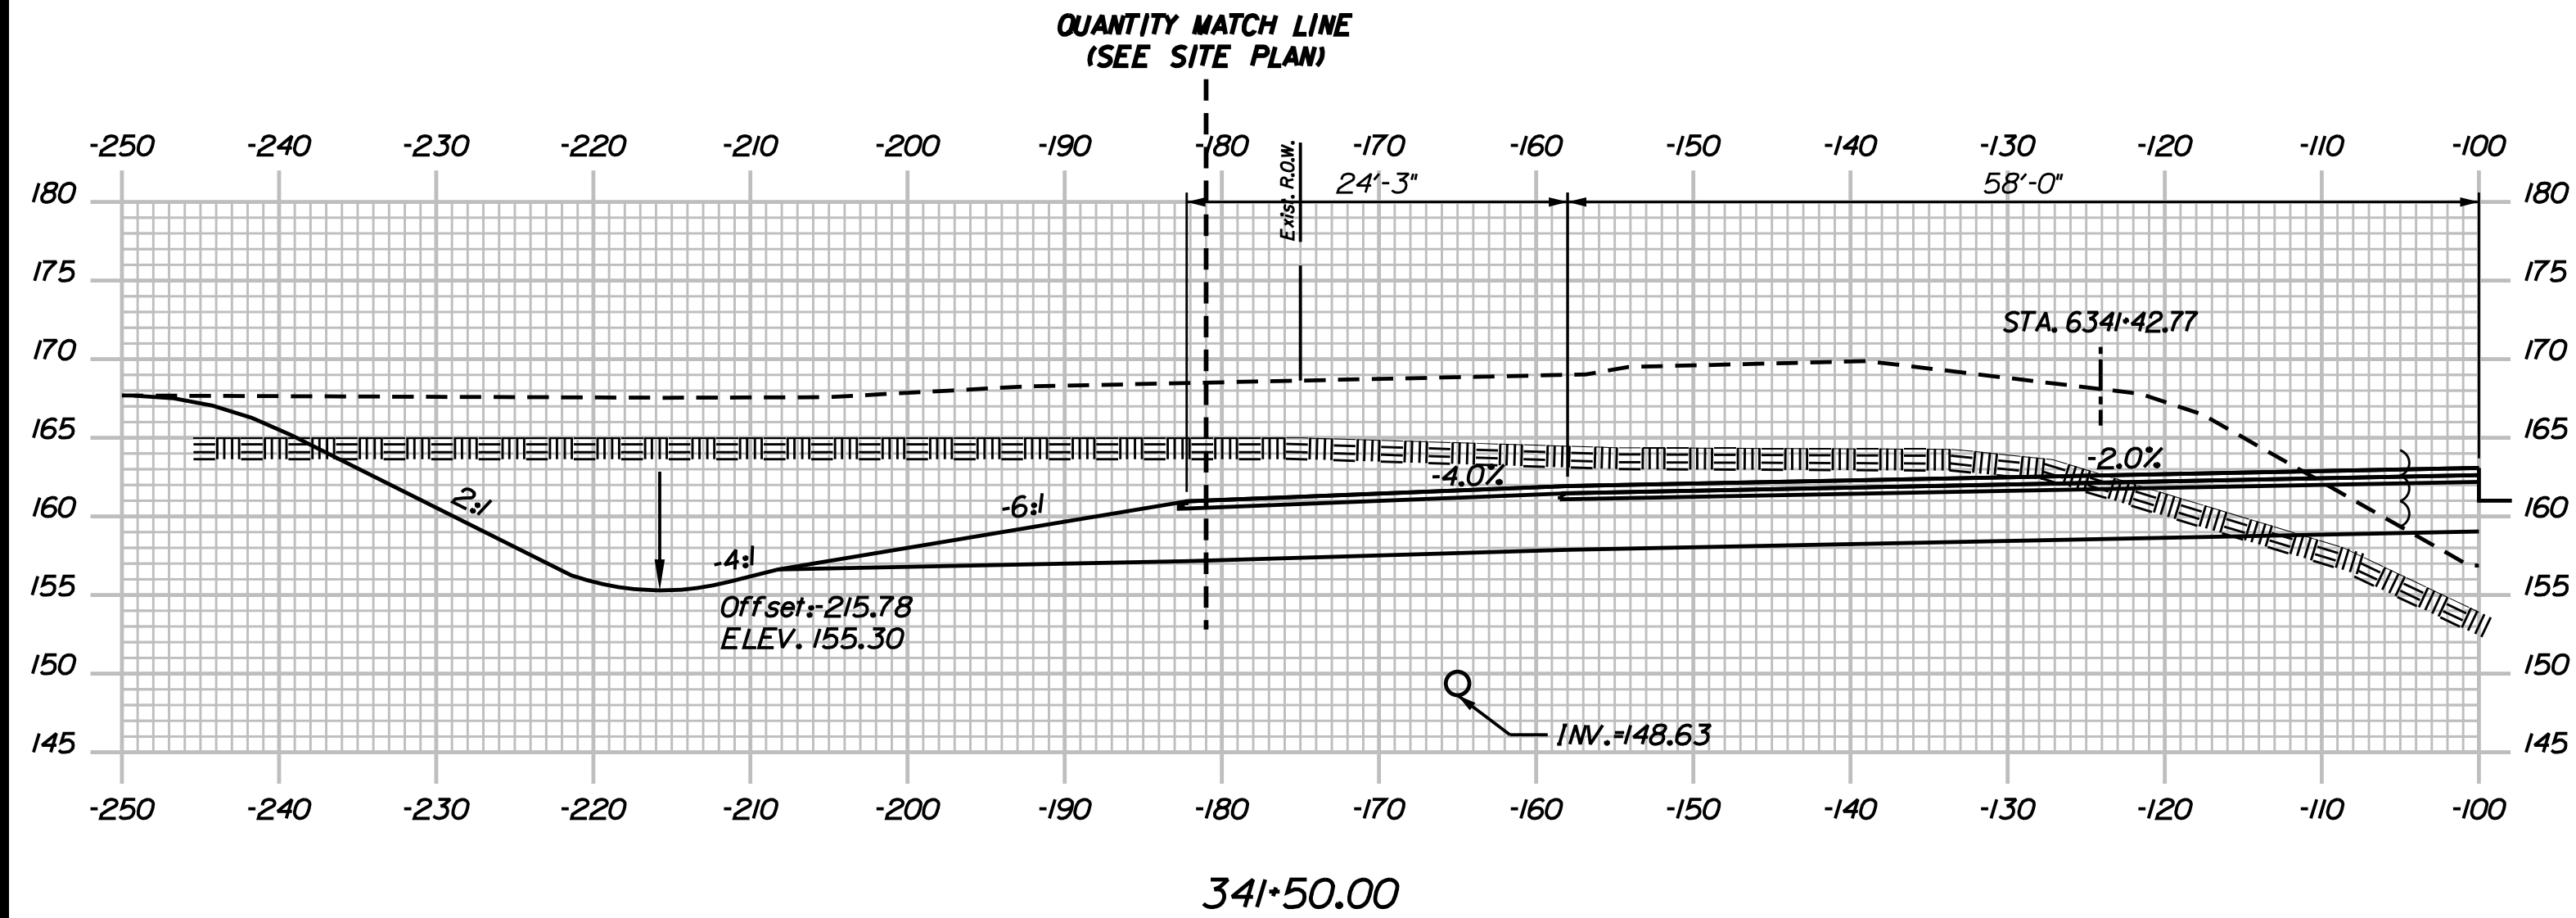

Filename: ...00259637\Xsect13_195.dgn

Scale:

No.	Revision	By	Date

Designed by:

JACOBS

CONSULTANT PROJECT MANAGER: T. MORIN

	By	Date		By	Date
Designed	AMS	7-18	Checked	CSM	7-18
Drawn	SMG	7-18	In Charge of	TWM	7-18

JACOBS ENGINEERING GROUP
 120 ST. JAMES AVENUE
 BOSTON, MA 02216
 TEL (617) 242-9222
 FAX (617) 242-9824




THE GOLD STAR MEMORIAL HIGHWAY

MTA PROJECT MANAGER: R. NORWOOD

YORK TOLL PLAZA
 I-95 CROSS SECTIONS
 STA. 341+50

SHEET NUMBER: XS-37
 CONTRACT: 2018.20
 235 OF 489

Date: 8/28/2018

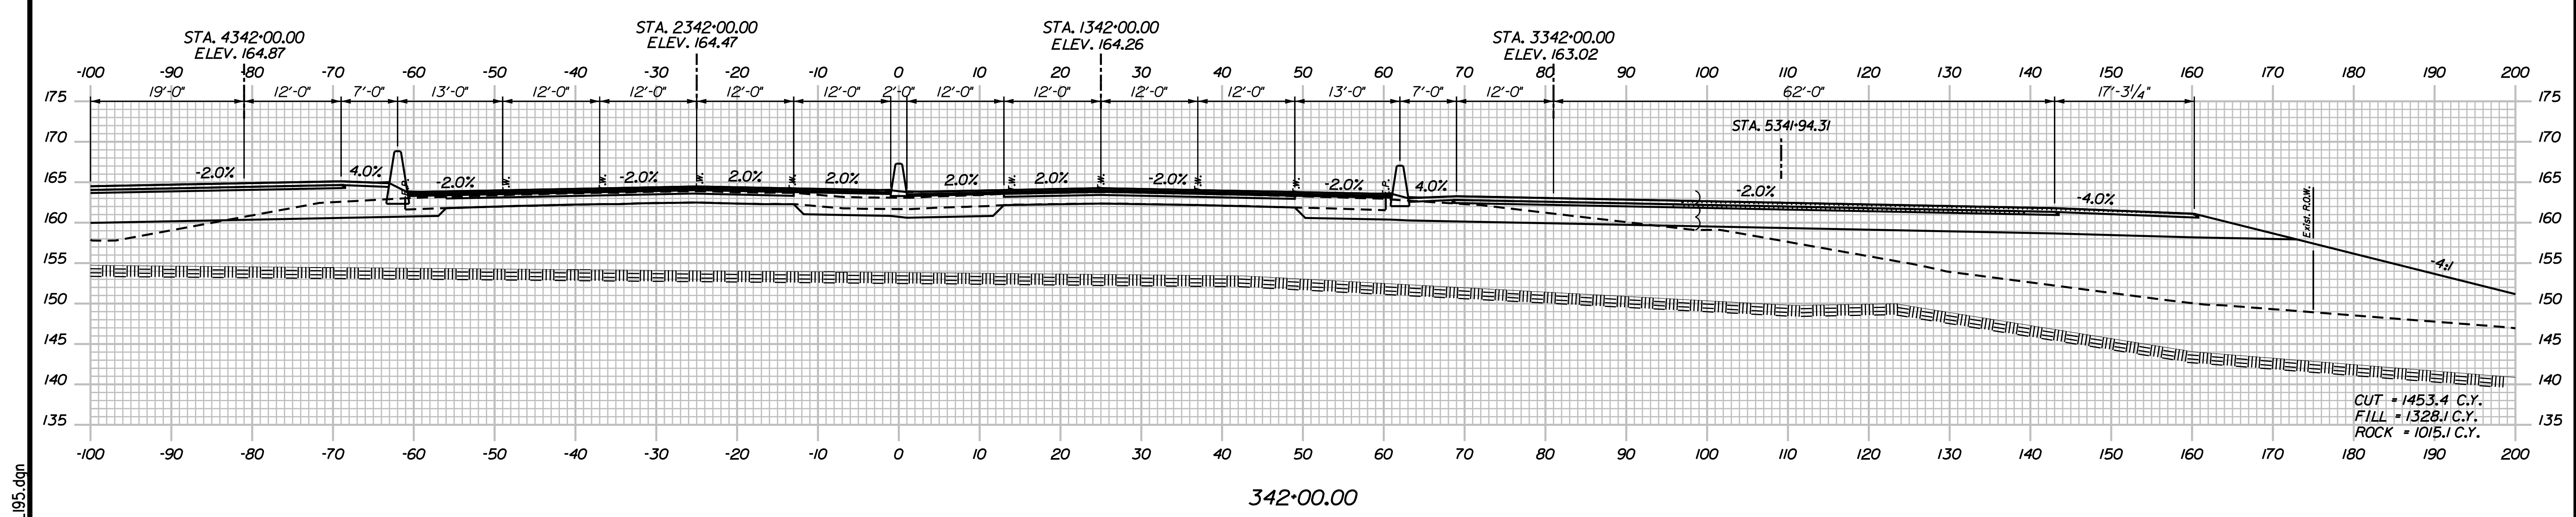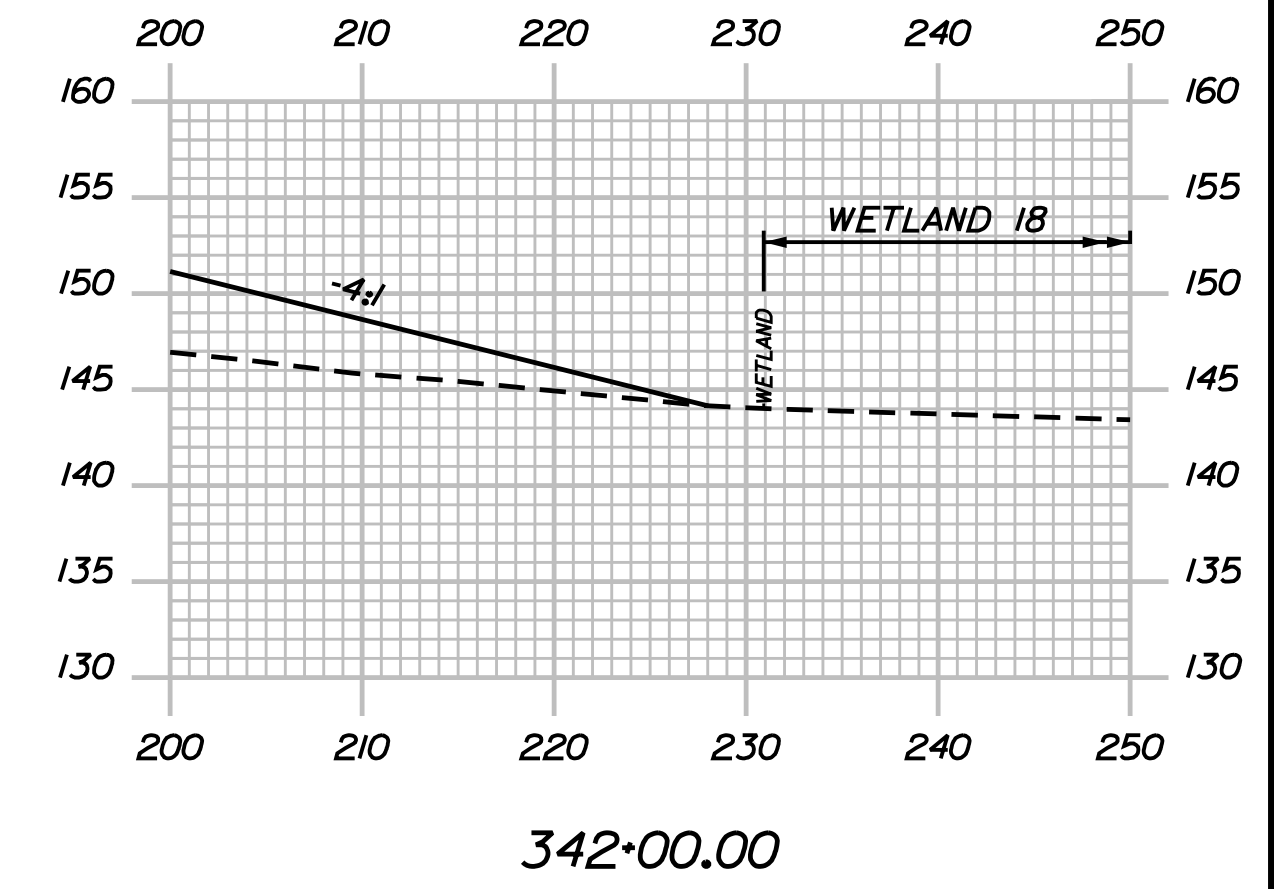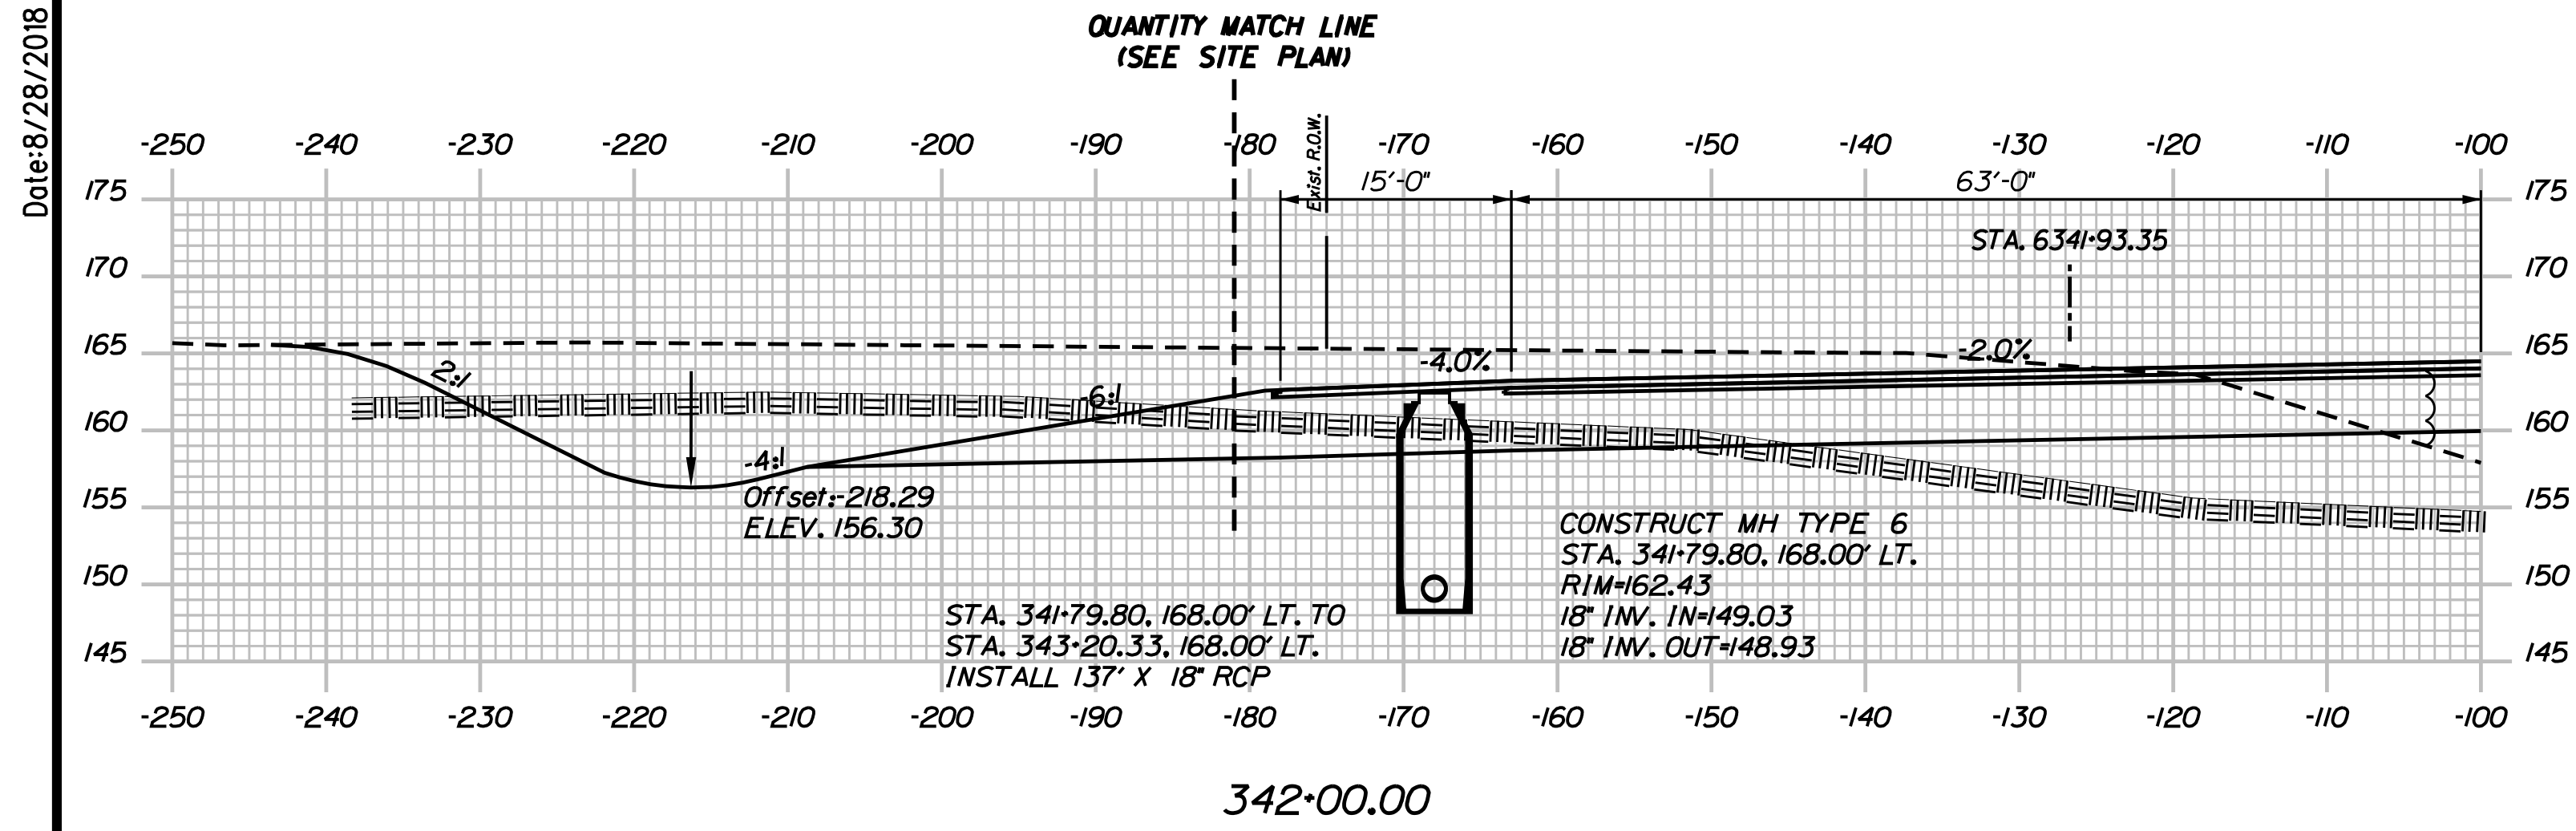

Filename: ...002596371\Xsect13_195.dgn

Scale: 1" = 20'

No.	Revision	By	Date

Designed by:

JACOBS

CONSULTANT PROJECT MANAGER: T. MORIN

	By	Date		By	Date
Designed	AMS	7-18	Checked	CSM	7-18
Drawn	SMG	7-18	In Charge of	TWM	7-18

JACOBS ENGINEERING GROUP
120 ST. JAMES AVENUE
BOSTON, MA 02216
TEL (617) 242-9222
FAX (617) 242-9824



THE GOLD STAR
MEMORIAL HIGHWAY

MTA PROJECT MANAGER: R. NORWOOD

YORK TOLL PLAZA
I-95 CROSS SECTIONS
STA. 342+00

SHEET NUMBER: XS-38
CONTRACT: 2018.20
236 OF 489

Date: 8/28/2018

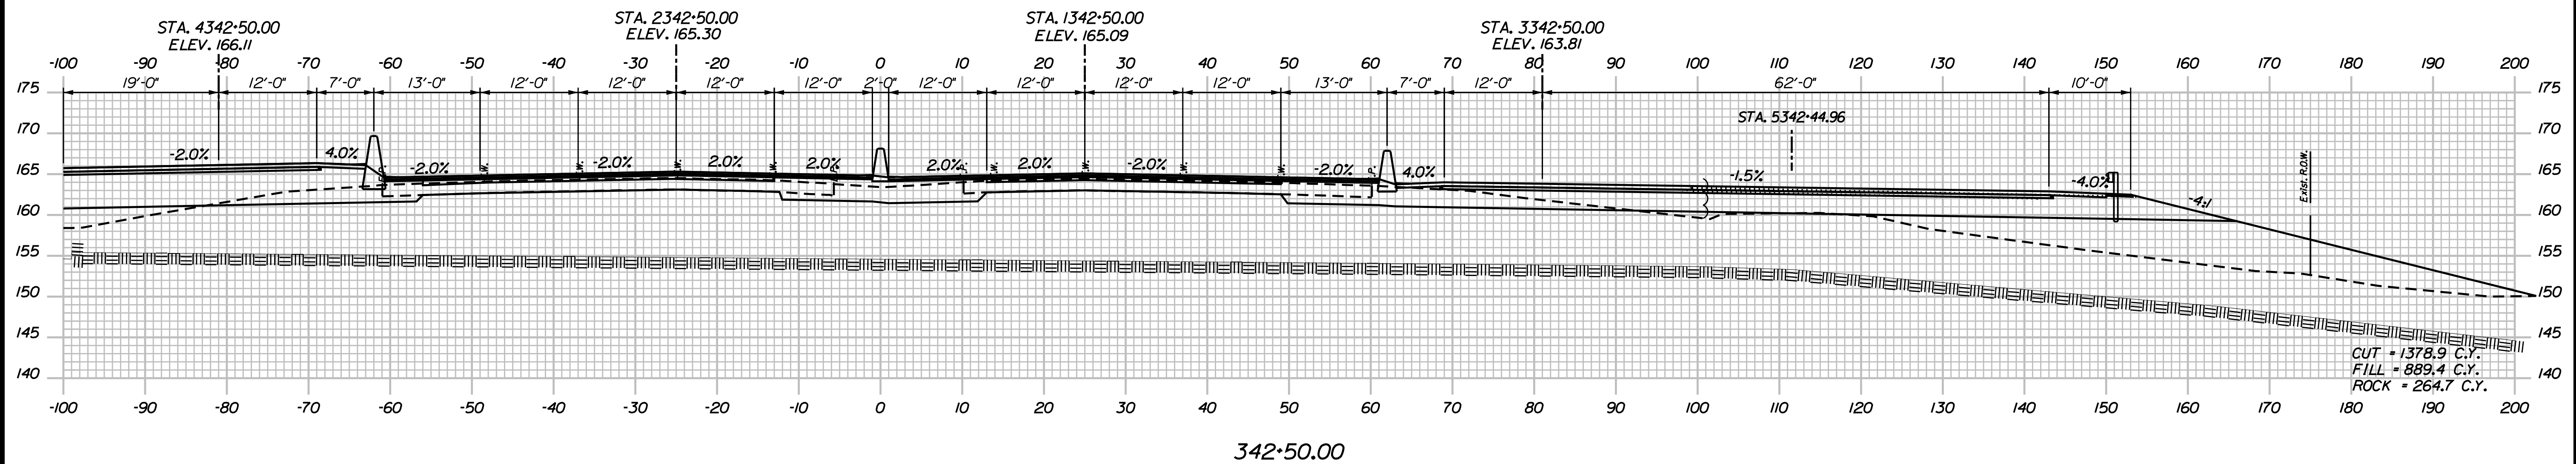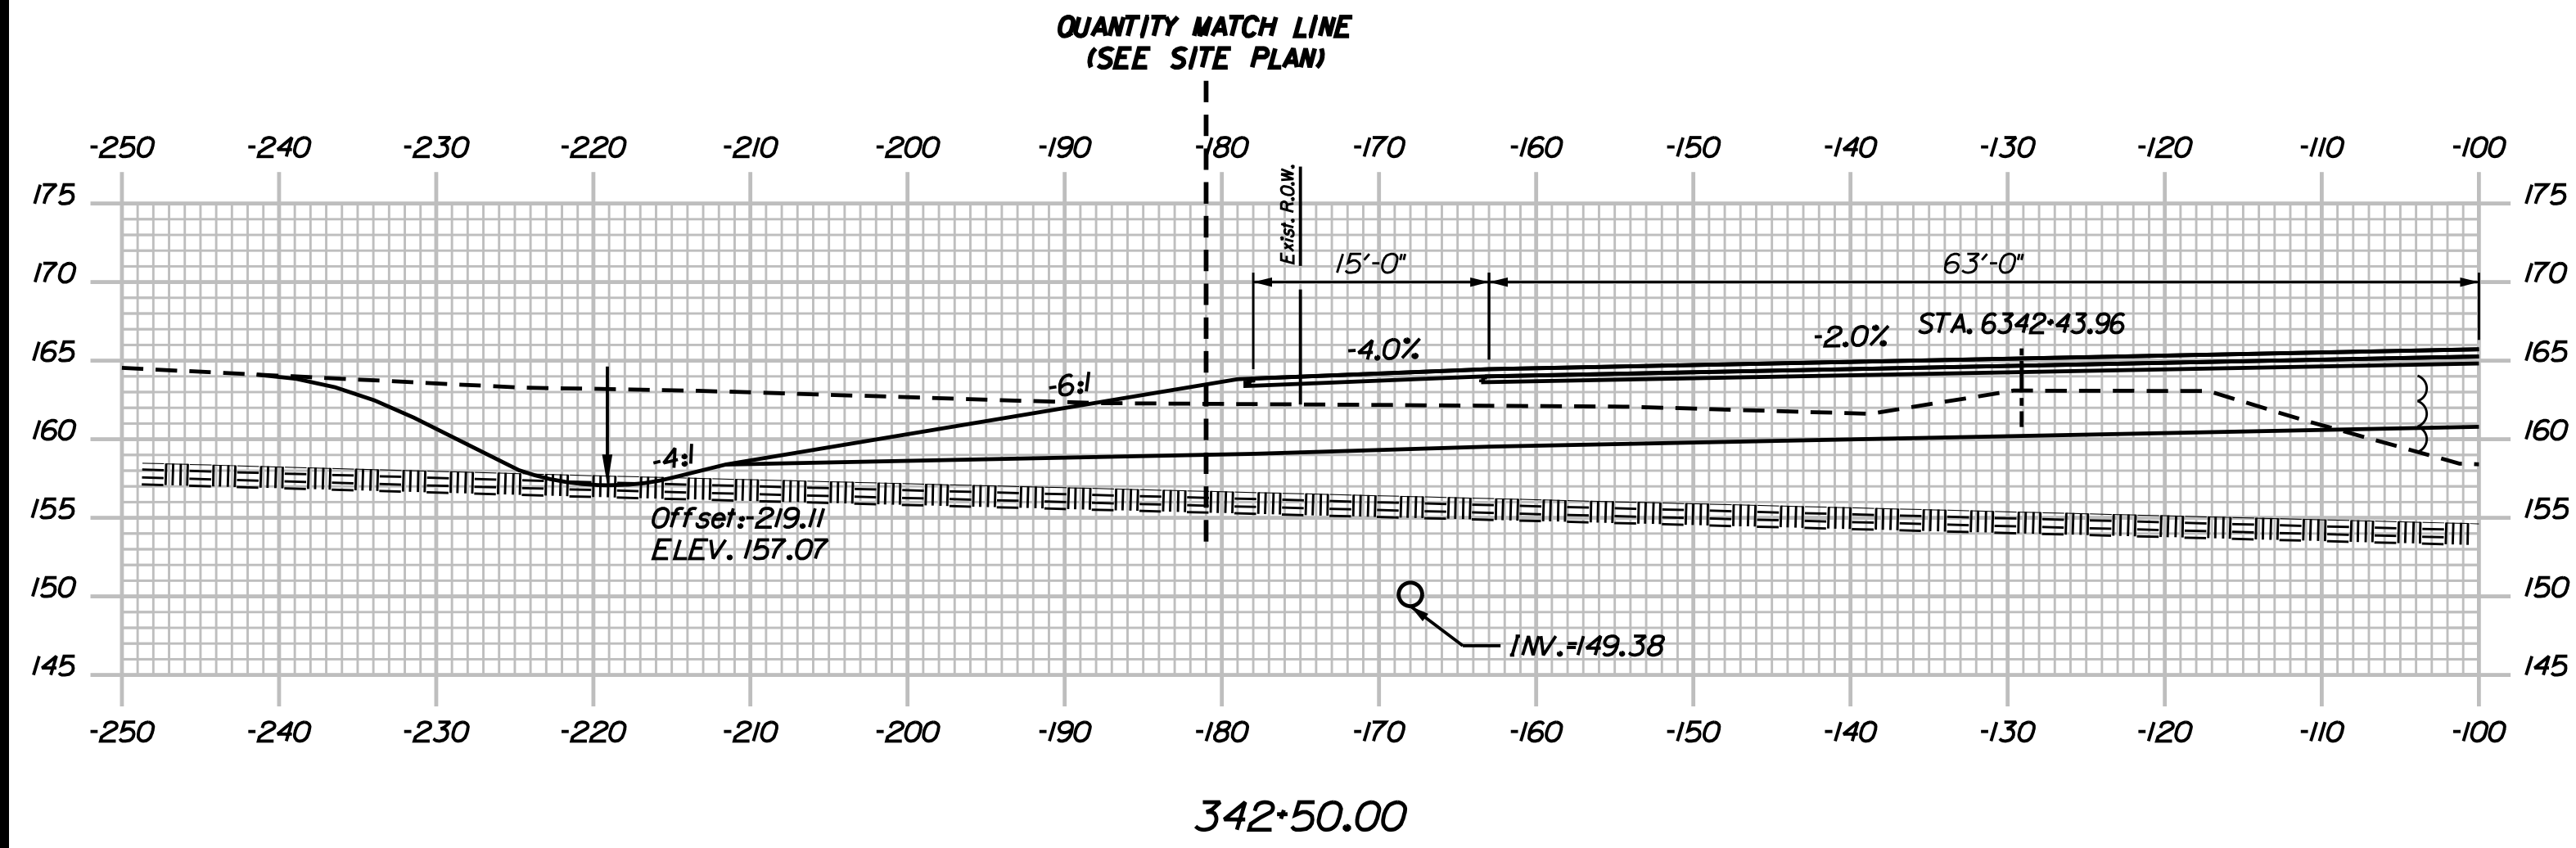

Filename: ...002596371\Xsect13_195.dgn

Scale:

No.	Revision	By	Date

Designed by:

JACOBS

CONSULTANT PROJECT MANAGER: T. MORIN

	By	Date		By	Date
Designed	AMS	7-18	Checked	CSM	7-18
Drawn	SMG	7-18	In Charge of	TWM	7-18

JACOBS ENGINEERING GROUP
120 ST. JAMES AVENUE
BOSTON, MA 02216
TEL (617) 242-9222
FAX (617) 242-9824



THE GOLD STAR MEMORIAL HIGHWAY

MTA PROJECT MANAGER: R. NORWOOD

YORK TOLL PLAZA
I-95 CROSS SECTIONS
STA. 342+50

SHEET NUMBER: XS-39
CONTRACT: 2018.20
237 OF 489

Date: 8/28/2018

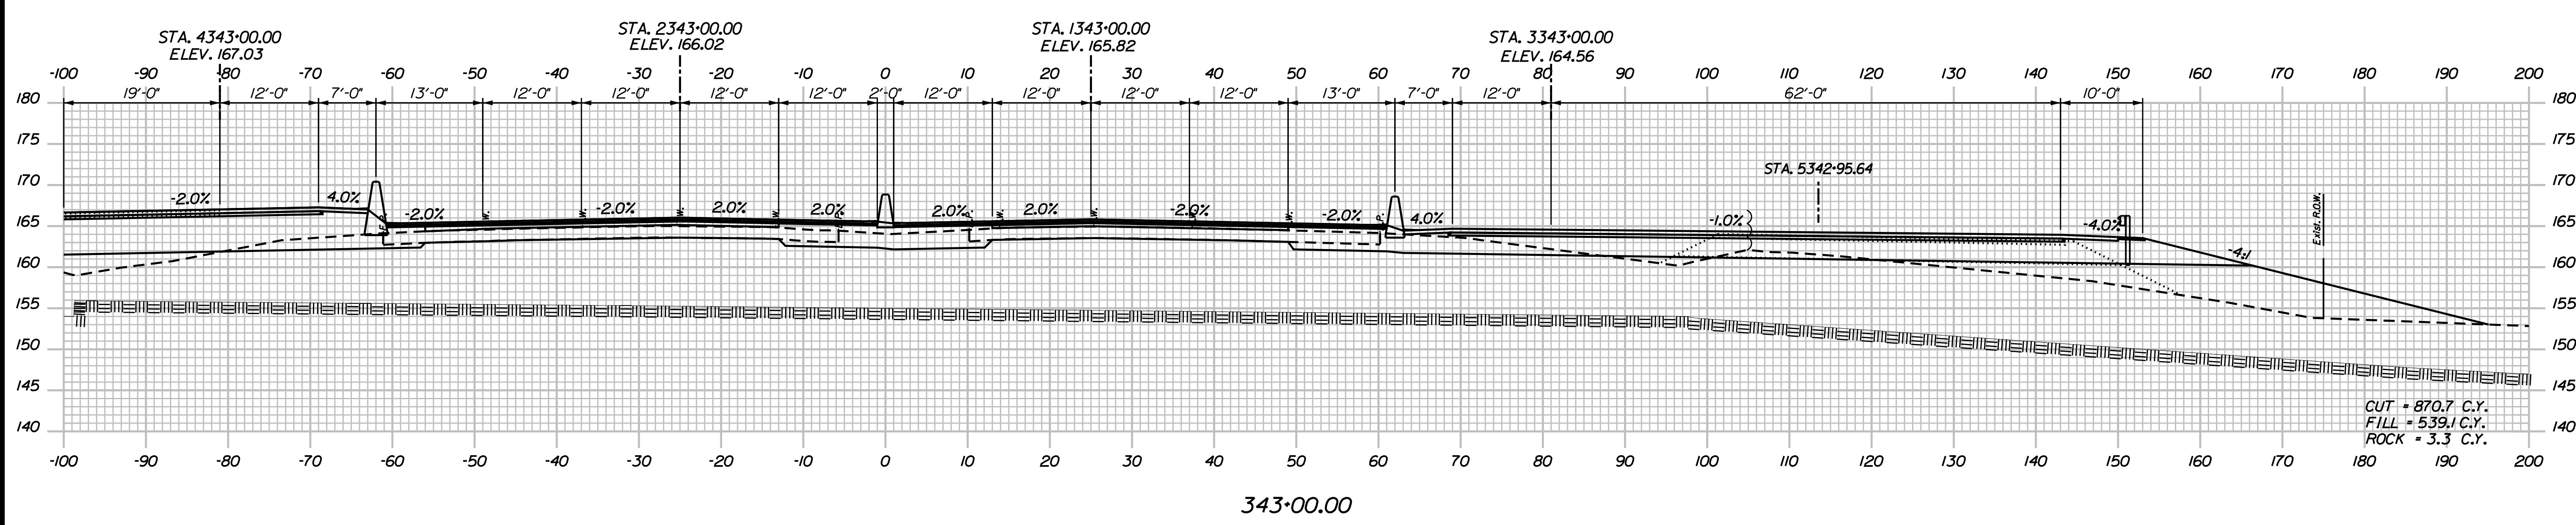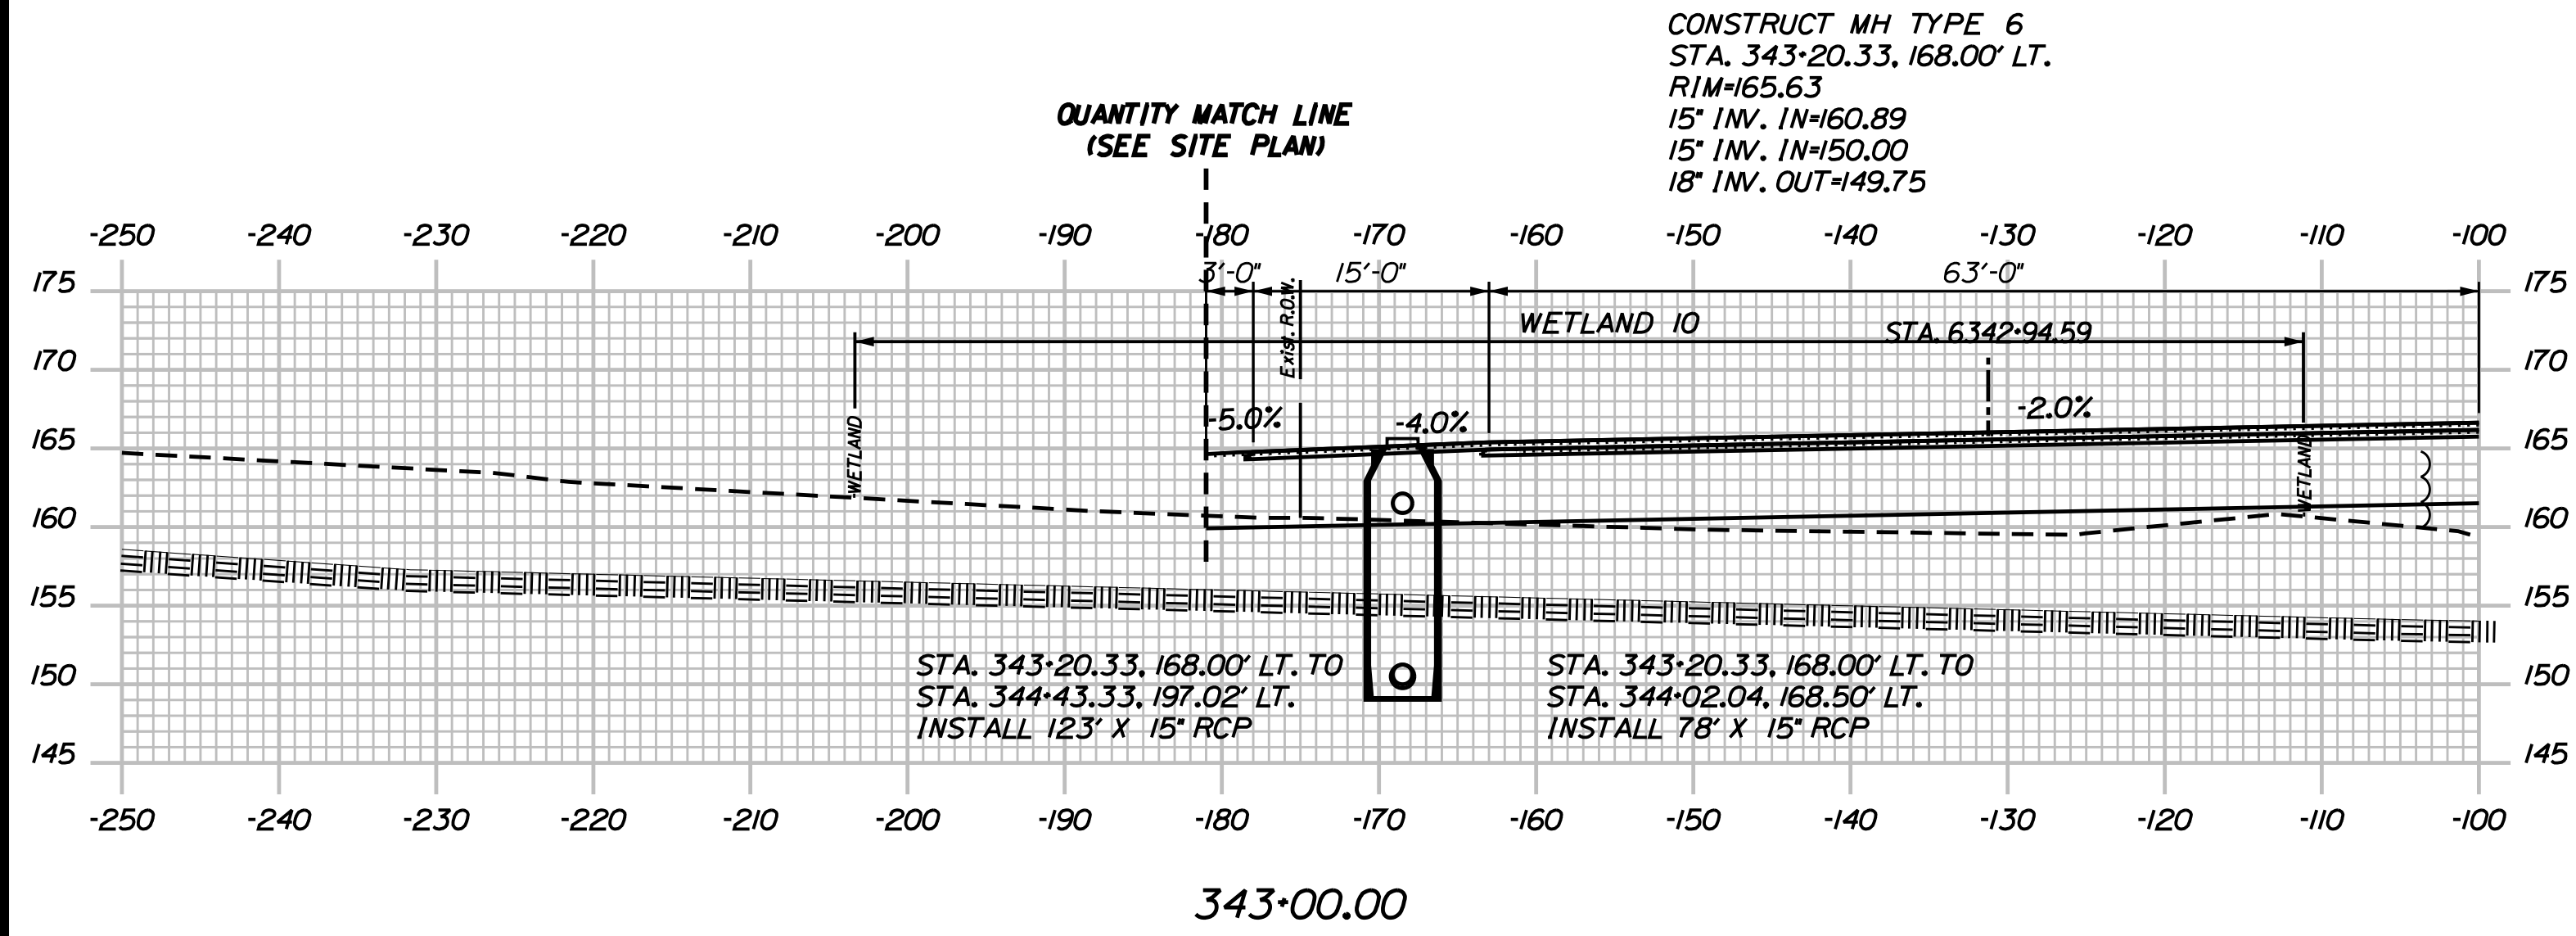

Filename: ...00259637\Xsect13_195.dgn

Scale:

No.	Revision	By	Date

Designed by:

JACOBS

CONSULTANT PROJECT MANAGER: T. MORIN

	By	Date		By	Date
Designed	AMS	7-18	Checked	CSM	7-18
Drawn	SMG	7-18	In Charge of	TWM	7-18

JACOBS ENGINEERING GROUP
 120 ST. JAMES AVENUE
 BOSTON, MA 02216
 TEL (617) 242-9222
 FAX (617) 242-9824



THE GOLD STAR
 MEMORIAL HIGHWAY

MTA PROJECT MANAGER: R. NORWOOD

YORK TOLL PLAZA
 I-95 CROSS SECTIONS
 STA. 343+00

SHEET NUMBER: XS-40
 CONTRACT: 2018.20
 238 OF 489

Date: 8/28/2018

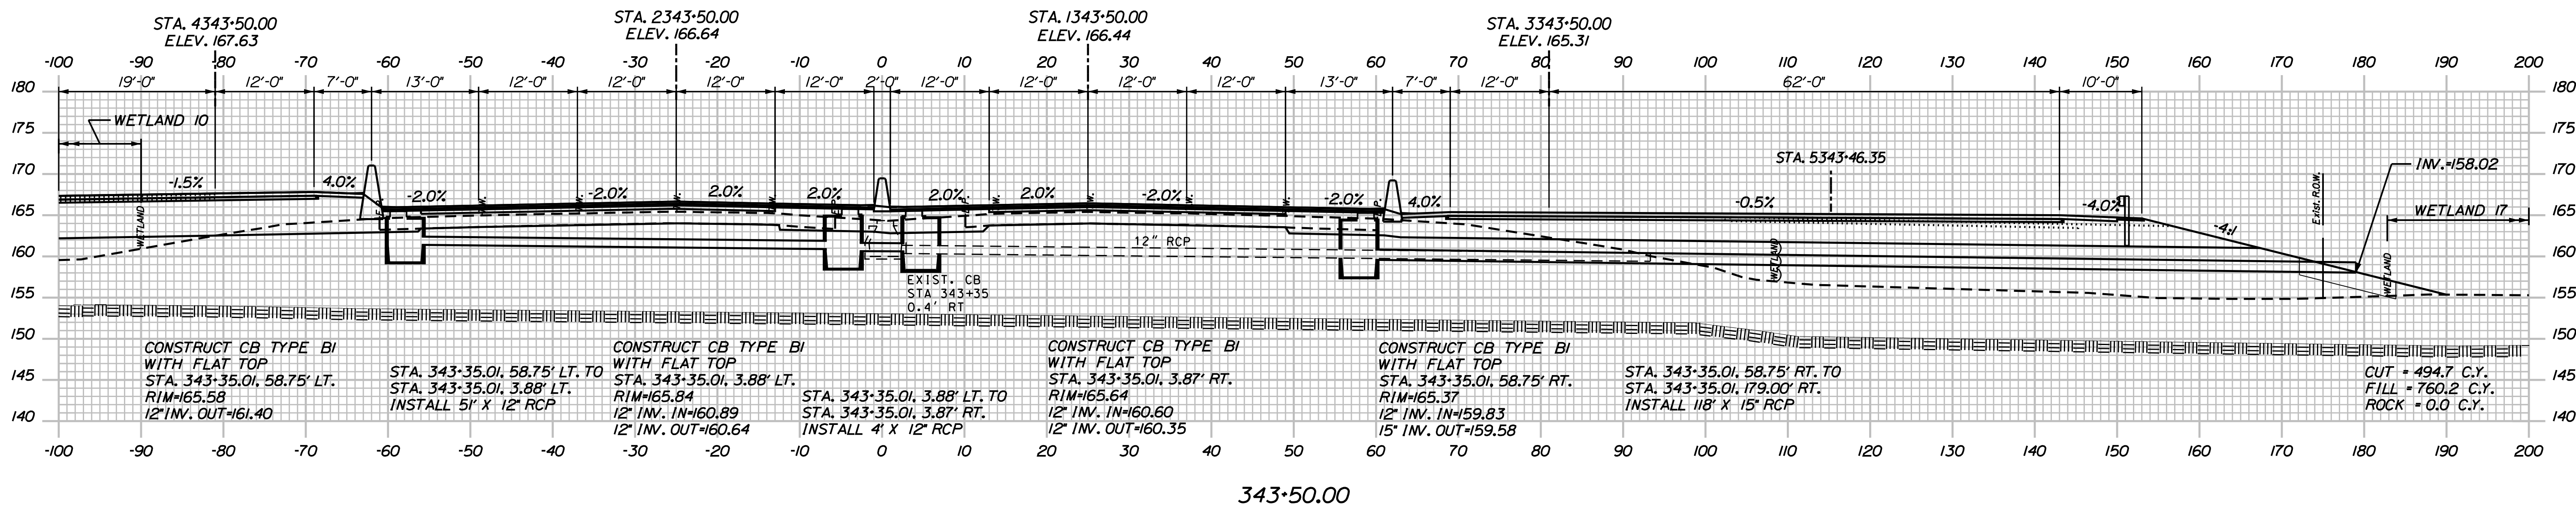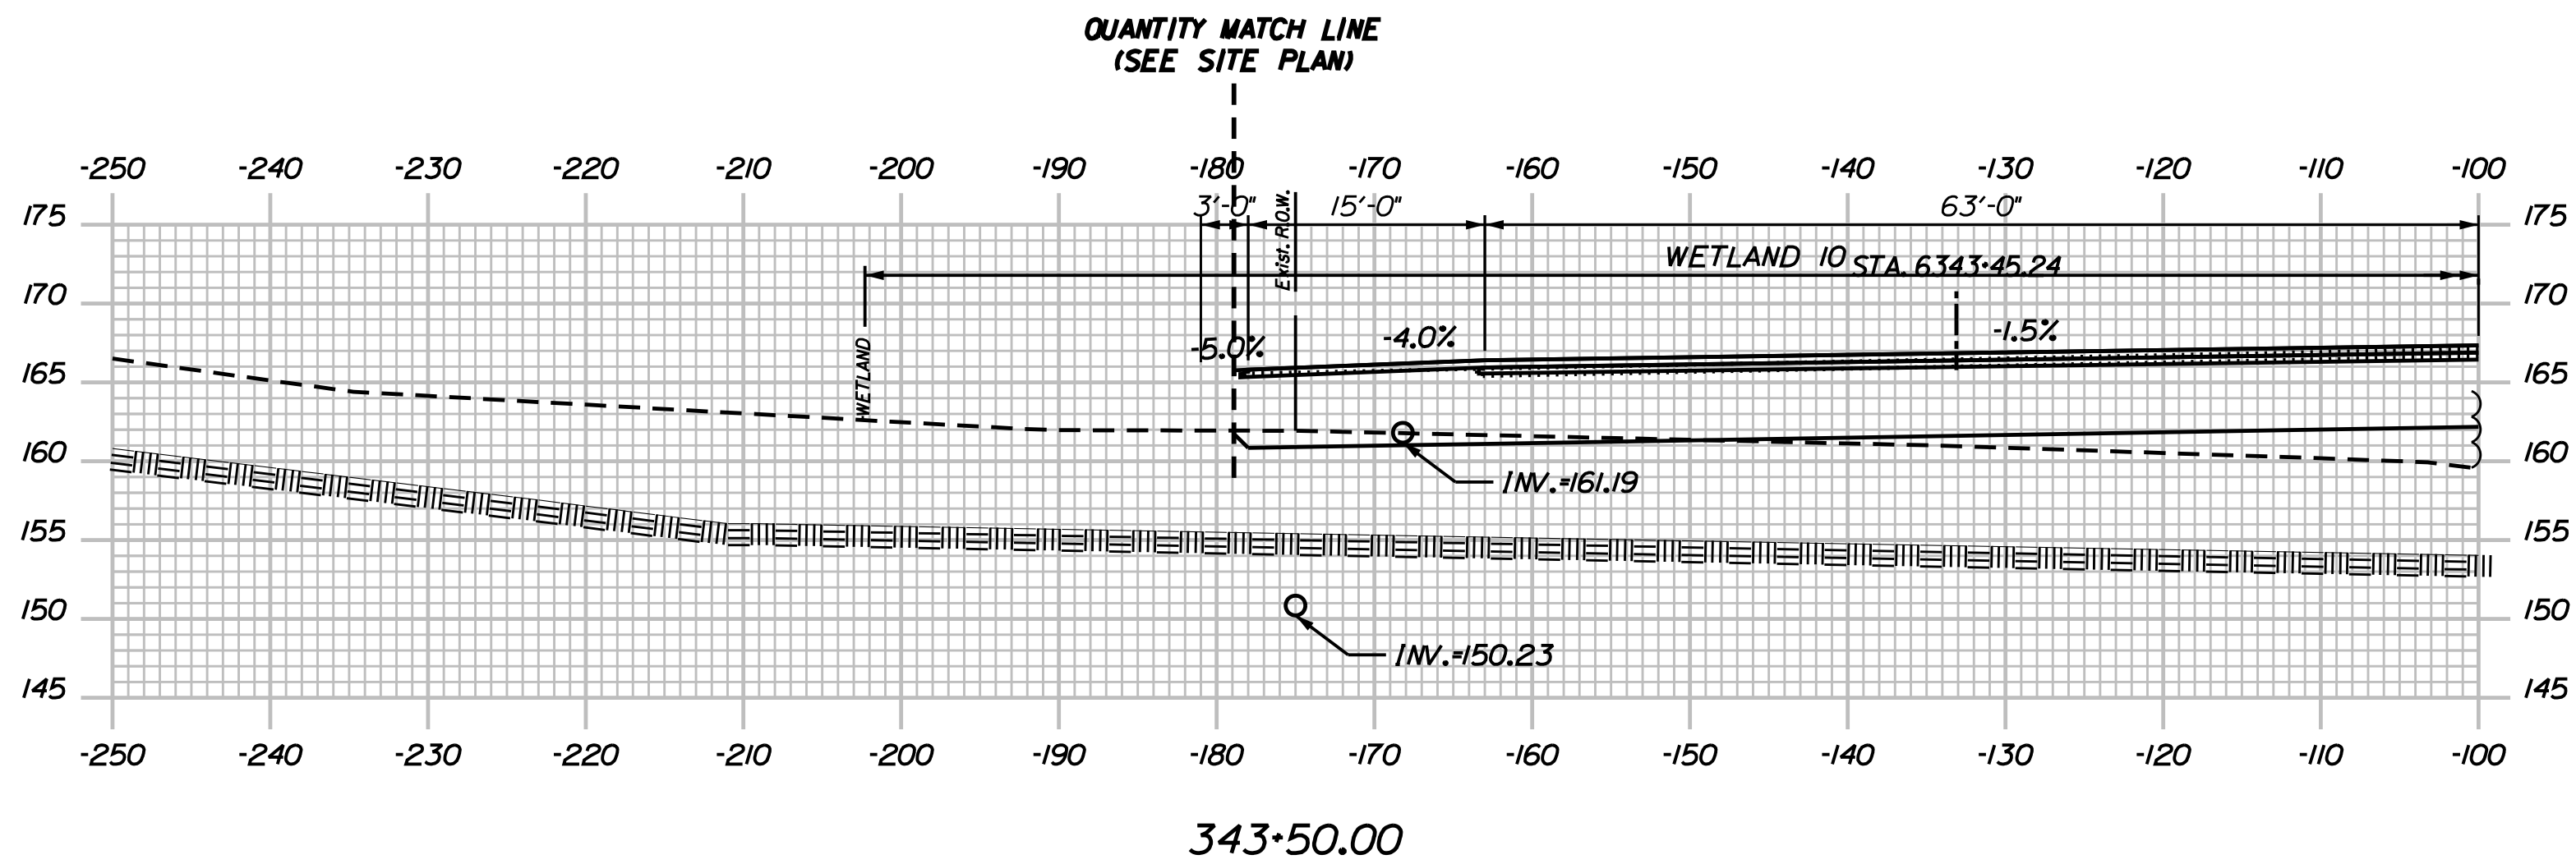

Filename: ...00259637\Xsect13_195.dgn

Scale:

No.	Revision	By	Date

Designed by:

JACOBS

CONSULTANT PROJECT MANAGER: T. MORIN

	By	Date		By	Date
Designed	AMS	7-18	Checked	CSM	7-18
Drawn	SMG	7-18	In Charge of	TWM	7-18

JACOBS ENGINEERING GROUP
 120 ST. JAMES AVENUE
 BOSTON, MA 02216
 TEL (617) 242-9222
 FAX (617) 242-9824



THE GOLD STAR MEMORIAL HIGHWAY

MTA PROJECT MANAGER: R. NORWOOD

YORK TOLL PLAZA
 I-95 CROSS SECTIONS
 STA. 343+50

SHEET NUMBER: XS-41
 CONTRACT: 2018.20
 239 OF 489

Date: 8/28/2018

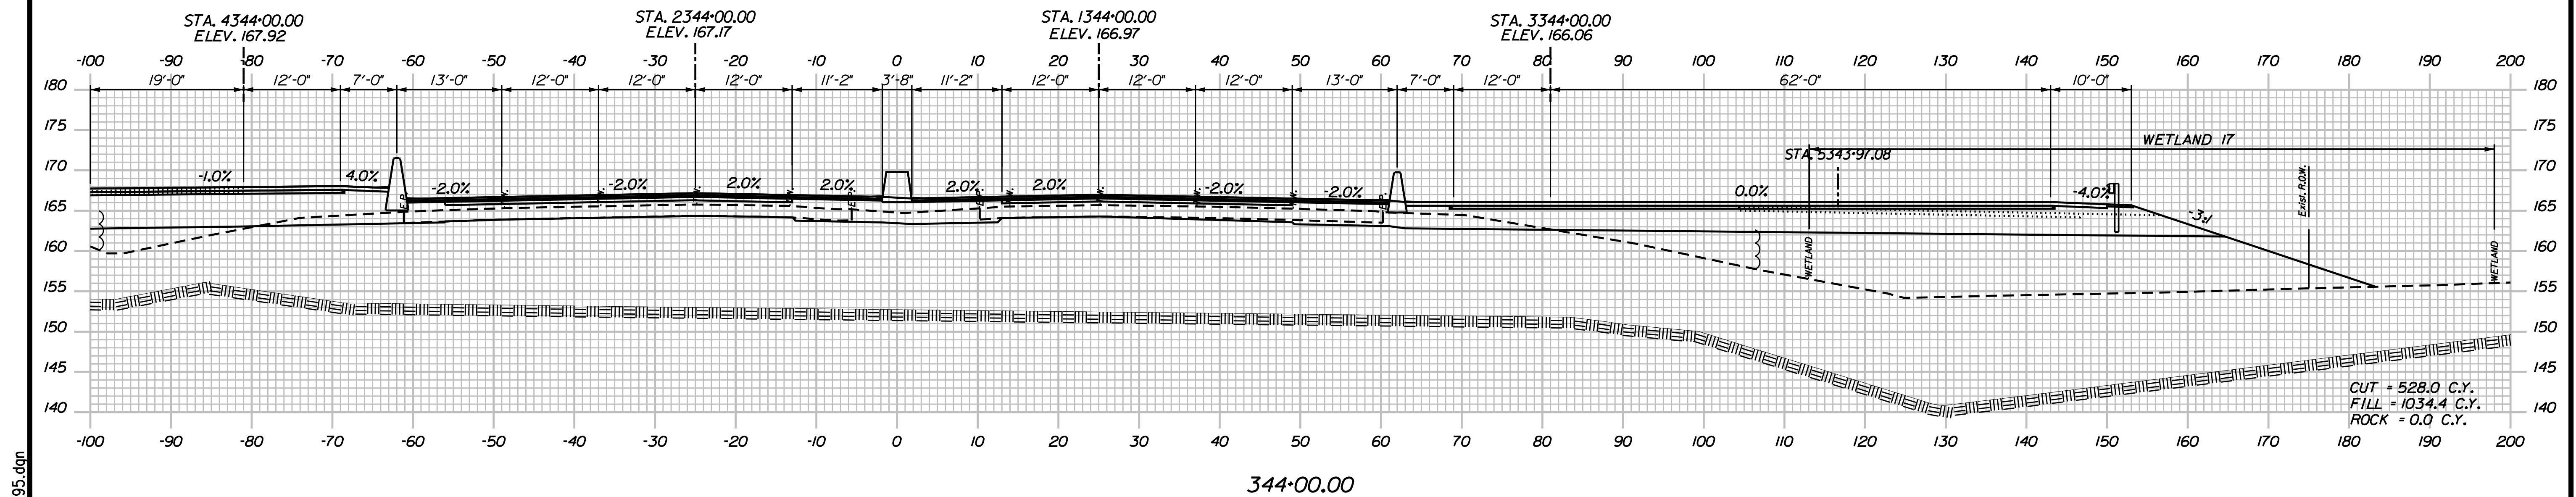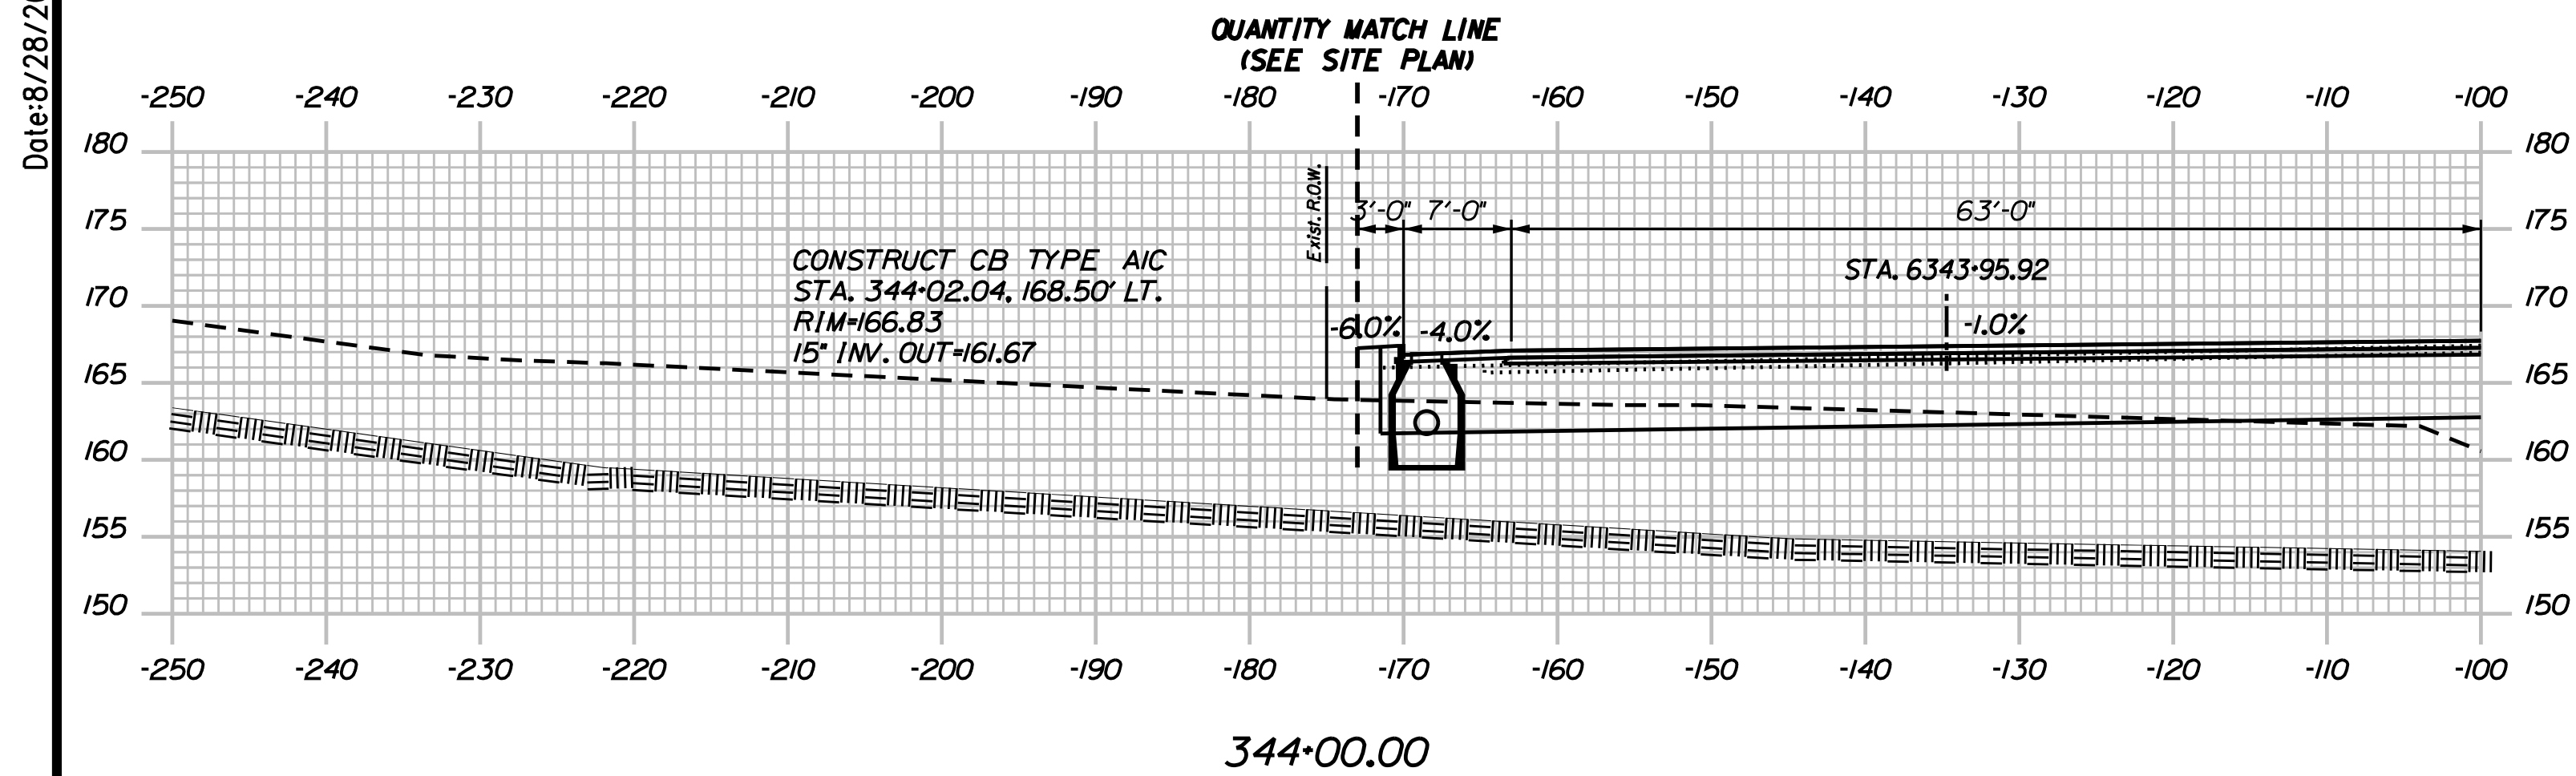

Filename: ...00259637\Xsect13_195.dgn

Scale:

No.	Revision	By	Date

Designed by:

JACOBS

CONSULTANT PROJECT MANAGER: T. MORIN

	By	Date		By	Date
Designed	AMS	7-18	Checked	CSM	7-18
Drawn	SMG	7-18	In Charge of	TWM	7-18

JACOBS ENGINEERING GROUP
 120 ST. JAMES AVENUE
 BOSTON, MA 02216
 TEL (617) 242-9222
 FAX (617) 242-9824

THE GOLD STAR
 MEMORIAL HIGHWAY

MTA PROJECT MANAGER: R. NORWOOD



YORK TOLL PLAZA
 I-95 CROSS SECTIONS
 STA. 344+00

SHEET NUMBER: XS-42
 240 OF 489

CONTRACT: 2018.20

NOTE:
TOLL PLAZA NOT SHOWN FOR CLARITY.
SEE STRUCTURAL PLANS FOR DETAILS.

Date: 8/28/2018

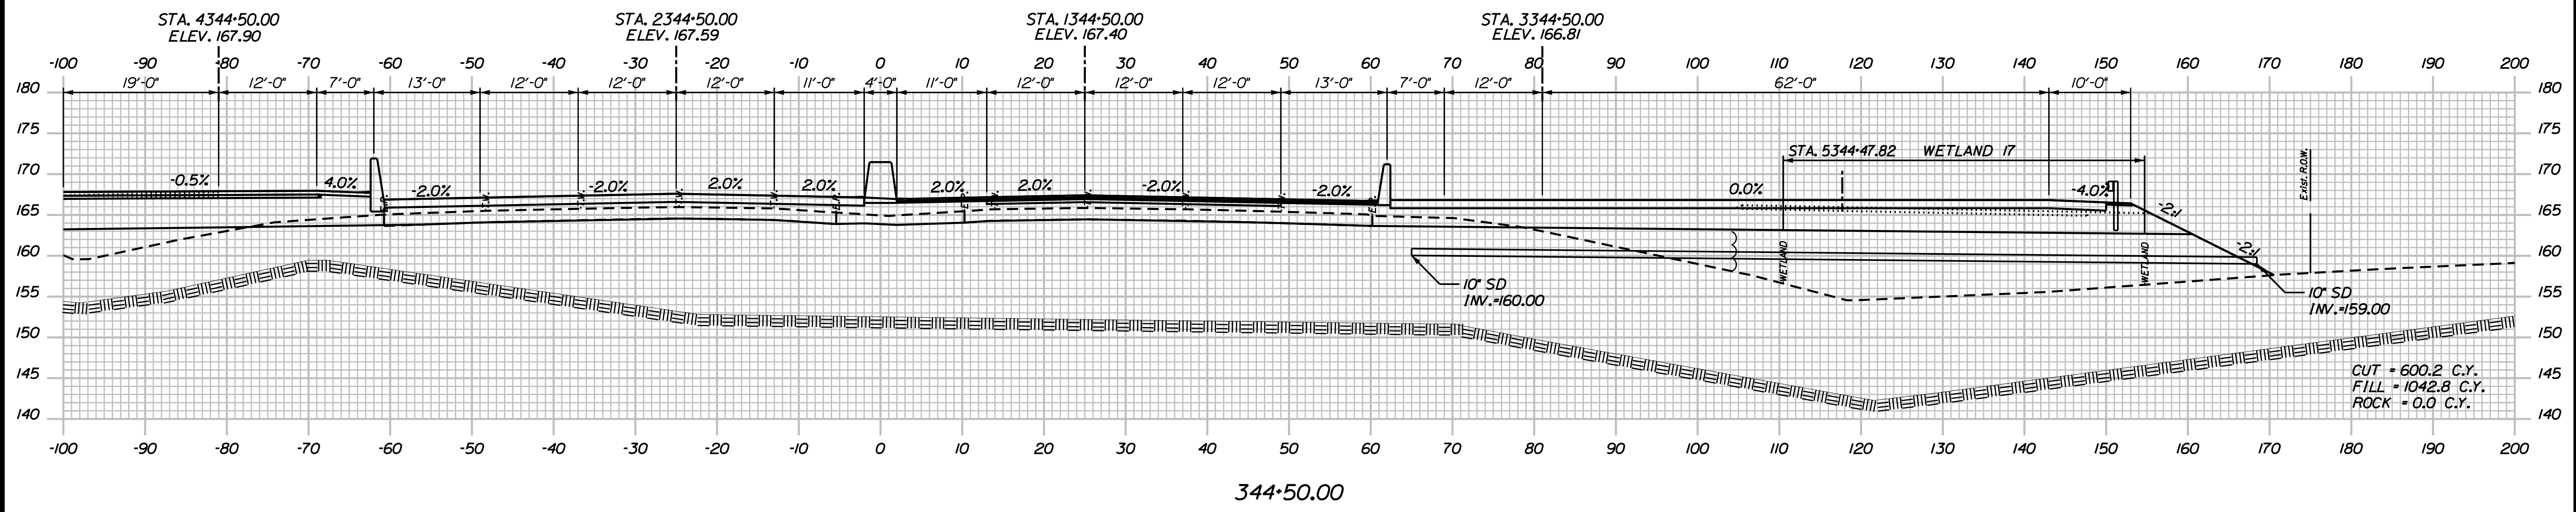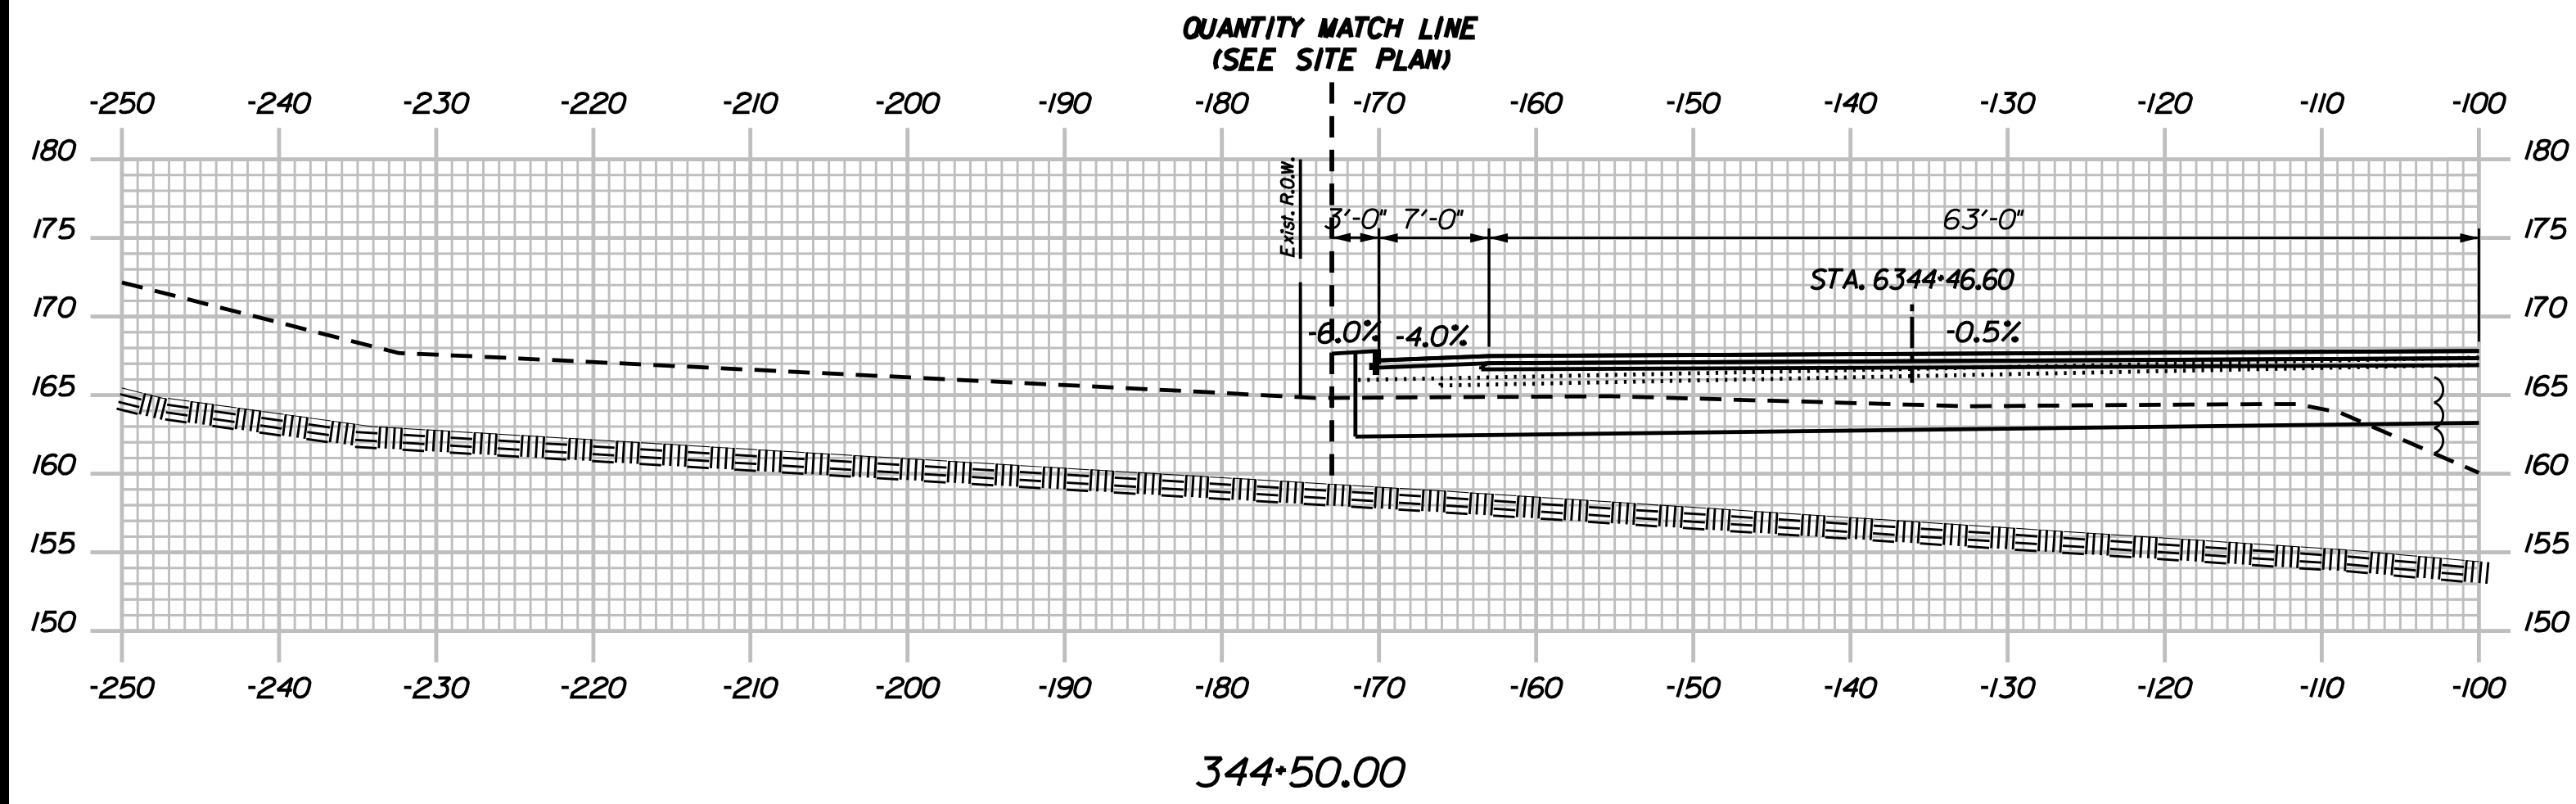

Filename: ...002596371\Xsect13_195.dgn

Scale:

No.	Revision	By	Date

Designed by:

JACOBS

CONSULTANT PROJECT MANAGER: T. MORIN

	By	Date		By	Date
Designed	AMS	7-18	Checked	CSM	7-18
Drawn	SMG	7-18	In Charge of	TWM	7-18

JACOBS ENGINEERING GROUP
120 ST. JAMES AVENUE
BOSTON, MA 02216
TEL (617) 242-9222
FAX (617) 242-9824

**THE GOLD STAR
MEMORIAL HIGHWAY**

MTA PROJECT MANAGER: R. NORWOOD

YORK TOLL PLAZA

I-95 CROSS SECTIONS
STA. 344+50



SHEET NUMBER: XS-43

CONTRACT: 2018.20

241 OF 489

NOTE:
TOLL PLAZA NOT SHOWN FOR CLARITY.
SEE STRUCTURAL PLANS FOR DETAILS.

Date: 8/28/2018

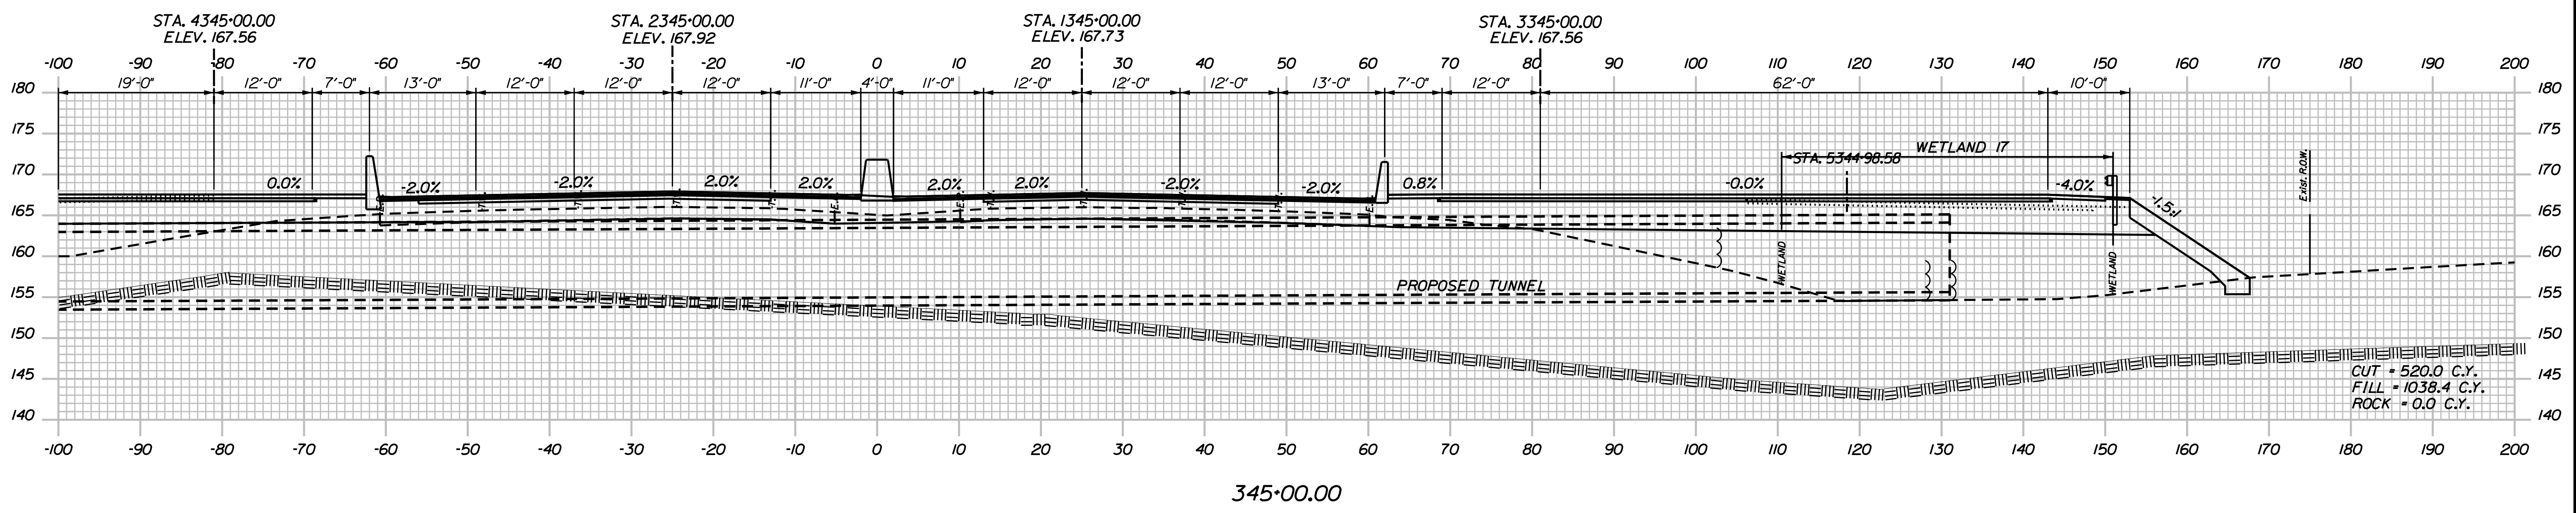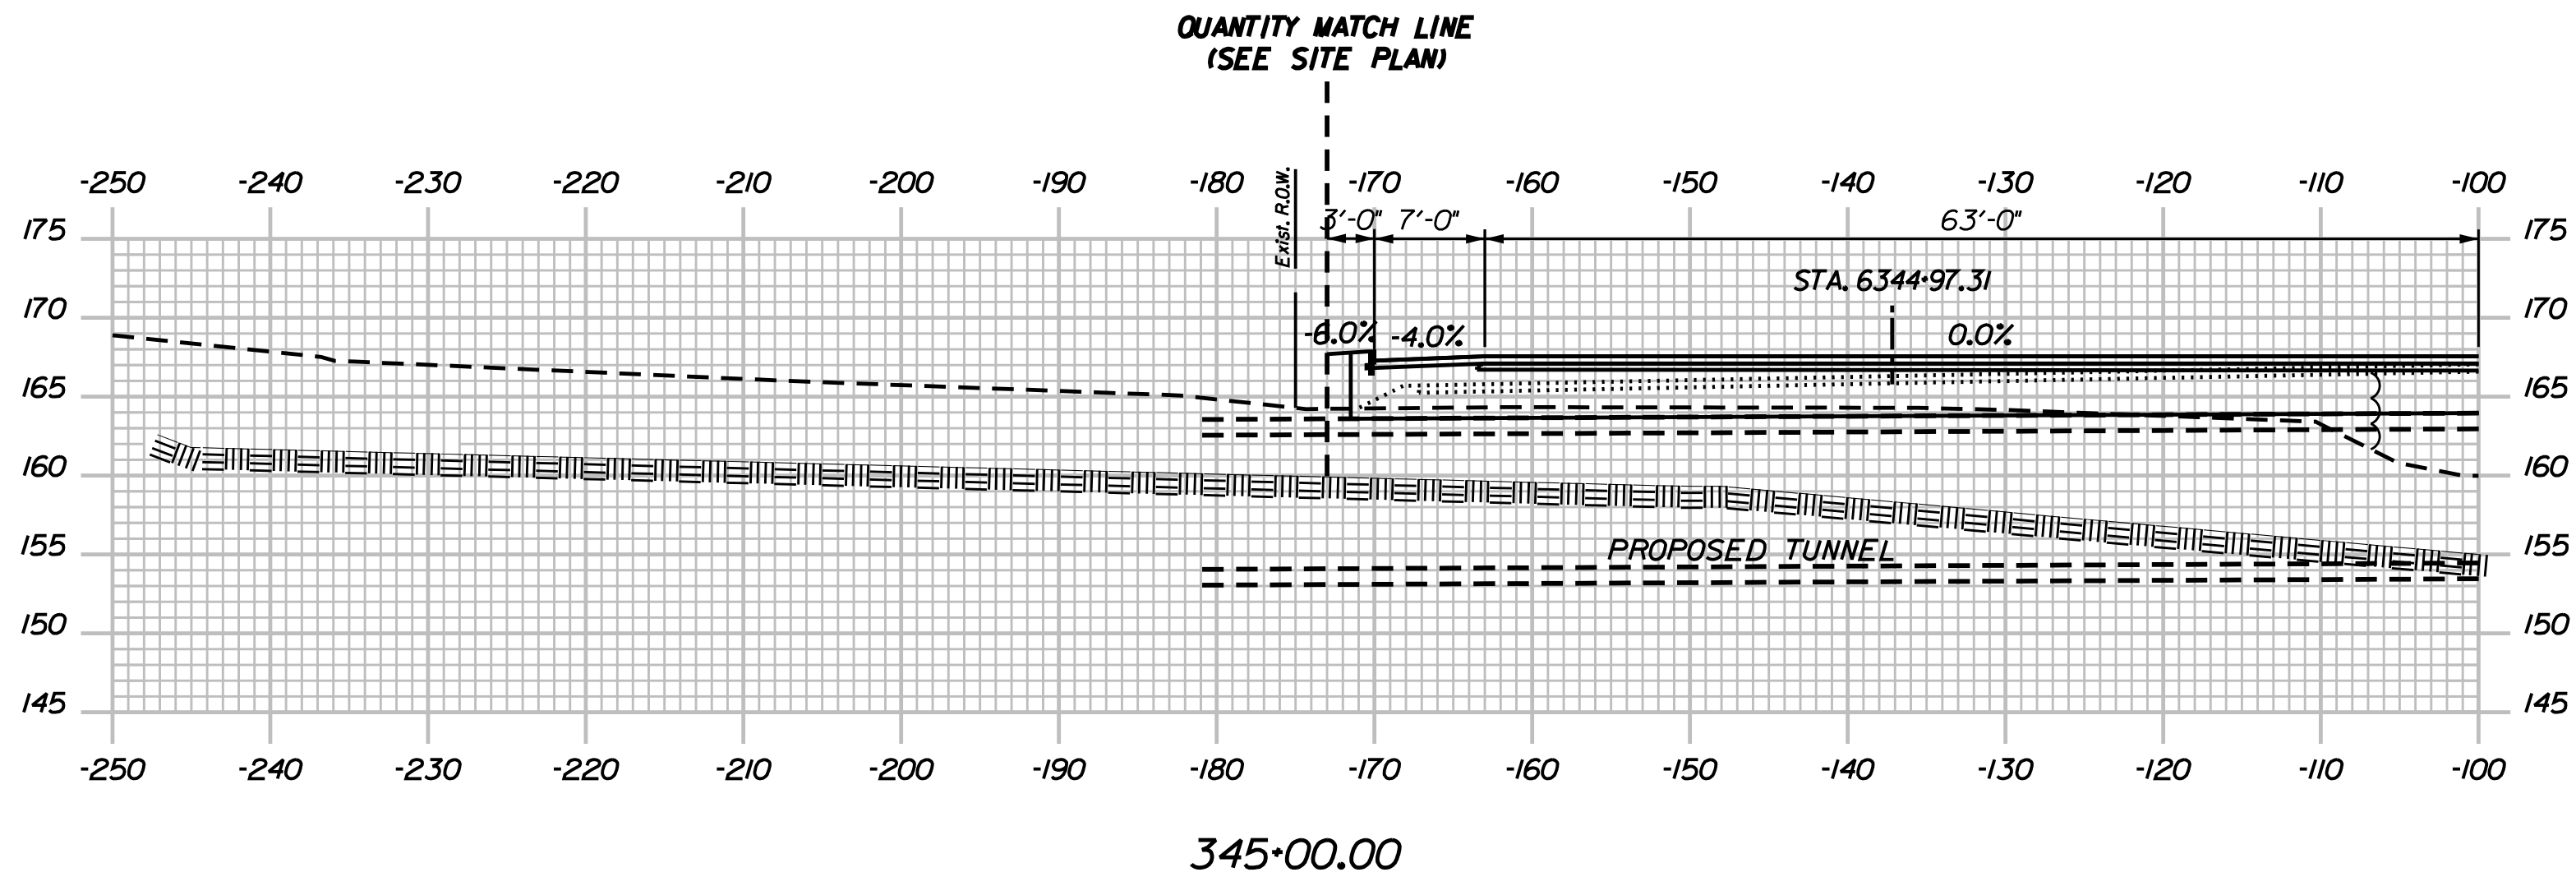

Filename: ...002596371\Xsect13_195.dgn

Scale: Scale of Feet

No.	Revision	By	Date

Designed by:

JACOBS

CONSULTANT PROJECT MANAGER: T. MORIN

	By	Date		By	Date
Designed	AMS	7-18	Checked	CSM	7-18
Drawn	SMG	7-18	In Charge of	TWM	7-18

JACOBS ENGINEERING GROUP
120 ST. JAMES AVENUE
BOSTON, MA 02216
TEL (617) 242-9222
FAX (617) 242-9824

**THE GOLD STAR
MEMORIAL HIGHWAY**



MTA PROJECT MANAGER: R. NORWOOD

YORK TOLL PLAZA
I-95 CROSS SECTIONS
STA. 345+00

SHEET NUMBER: XS-44
CONTRACT: 2018.20
242 OF 489

NOTE:
TOLL PLAZA NOT SHOWN FOR CLARITY.
SEE STRUCTURAL PLANS FOR DETAILS.

Date: 8/28/2018

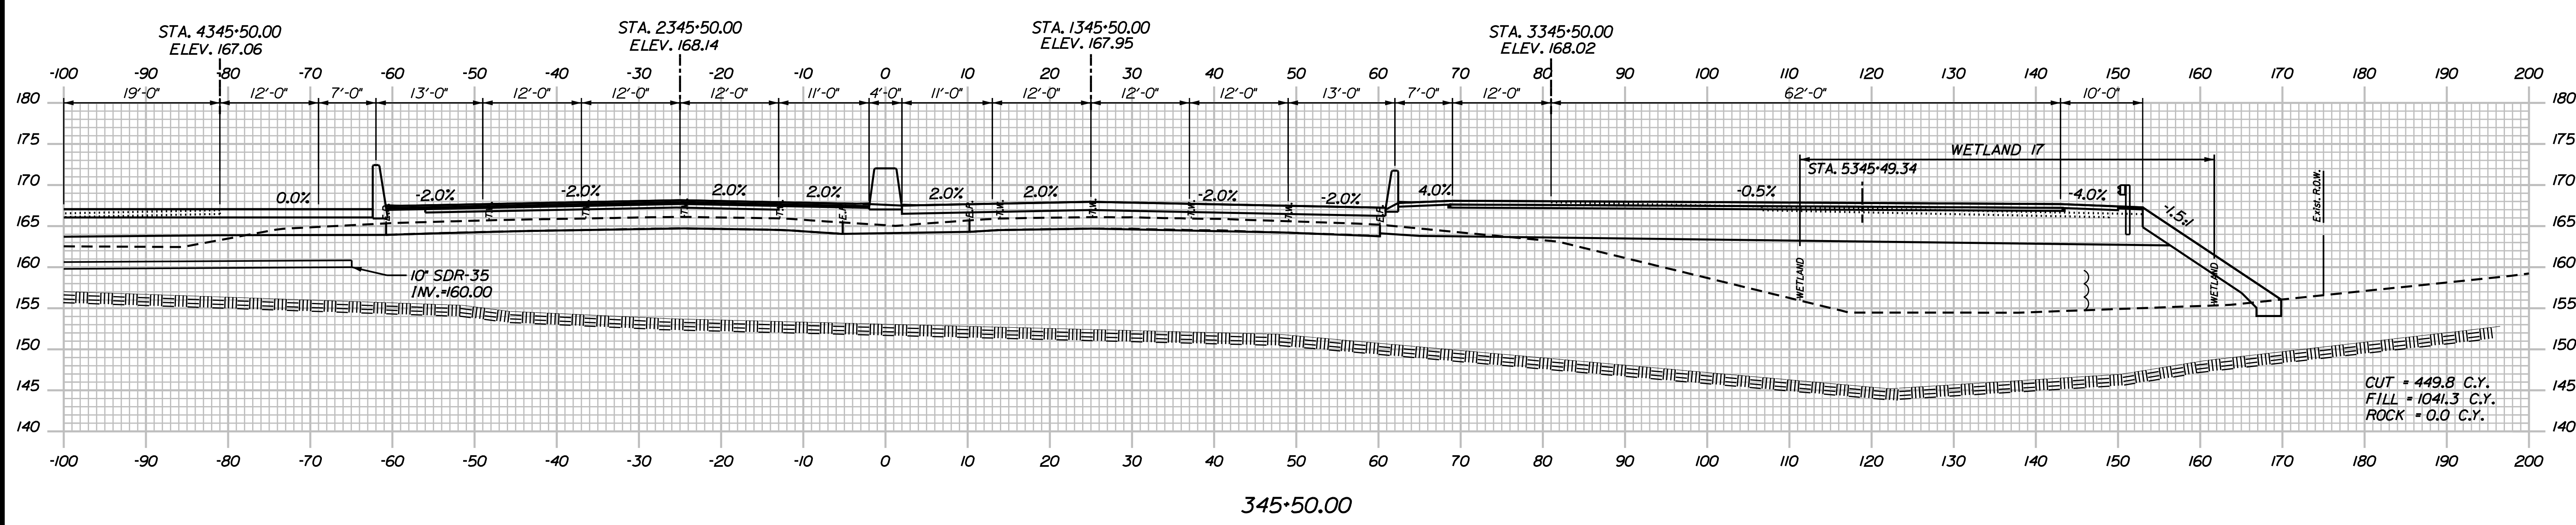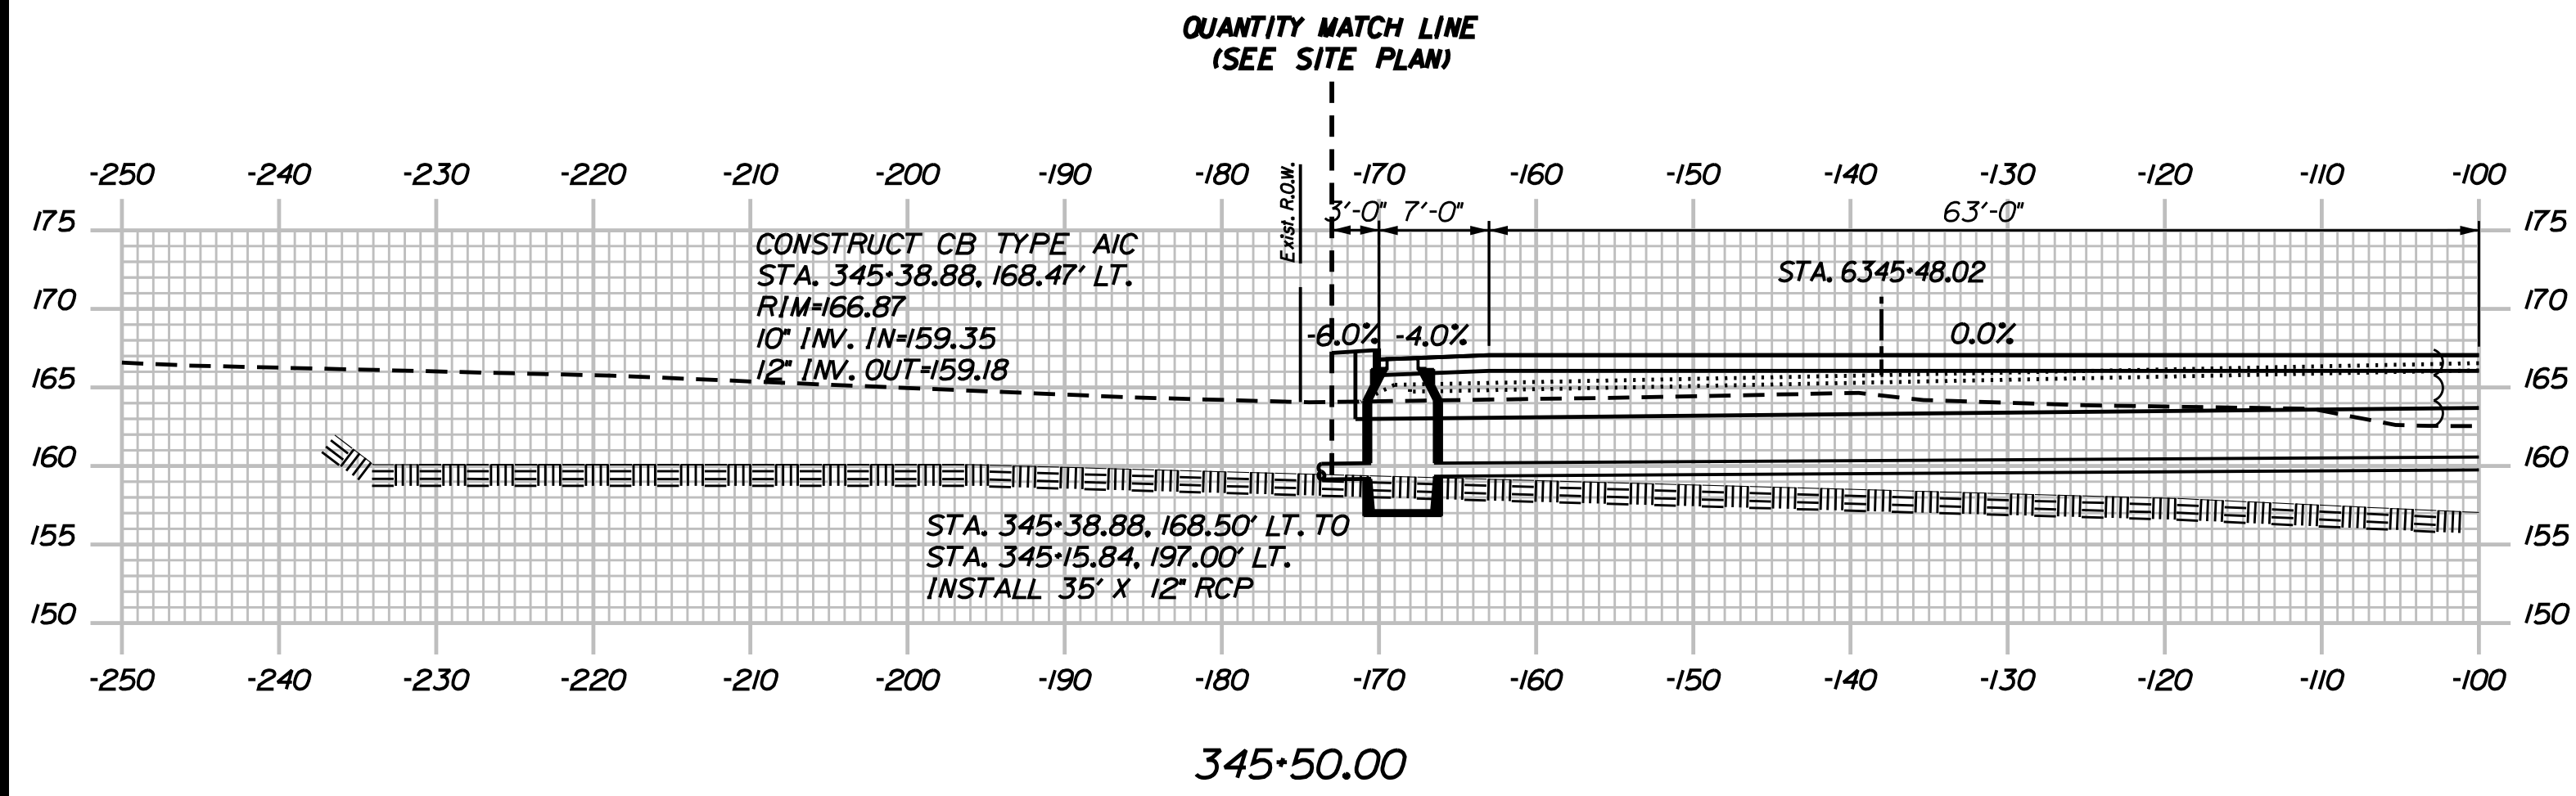

Filename: ...00259637\Xsect13_195.dgn

Scale: 1" = 20'

No.	Revision	By	Date

Designed by:

JACOBS

CONSULTANT PROJECT MANAGER: T. MORIN

	By	Date		By	Date
Designed	AMS	7-18	Checked	CSM	7-18
Drawn	SMG	7-18	In Charge of	TWM	7-18

JACOBS ENGINEERING GROUP
120 ST. JAMES AVENUE
BOSTON, MA 02216
TEL (617) 242-9222
FAX (617) 242-9824

MAINE TURNPIKE

THE GOLD STAR MEMORIAL HIGHWAY

MTA PROJECT MANAGER: R. NORWOOD

YORK TOLL PLAZA



I-95 CROSS SECTIONS
STA. 345+50

SHEET NUMBER: XS-45

CONTRACT: 2018.20

243 OF 489

Date: 8/28/2018

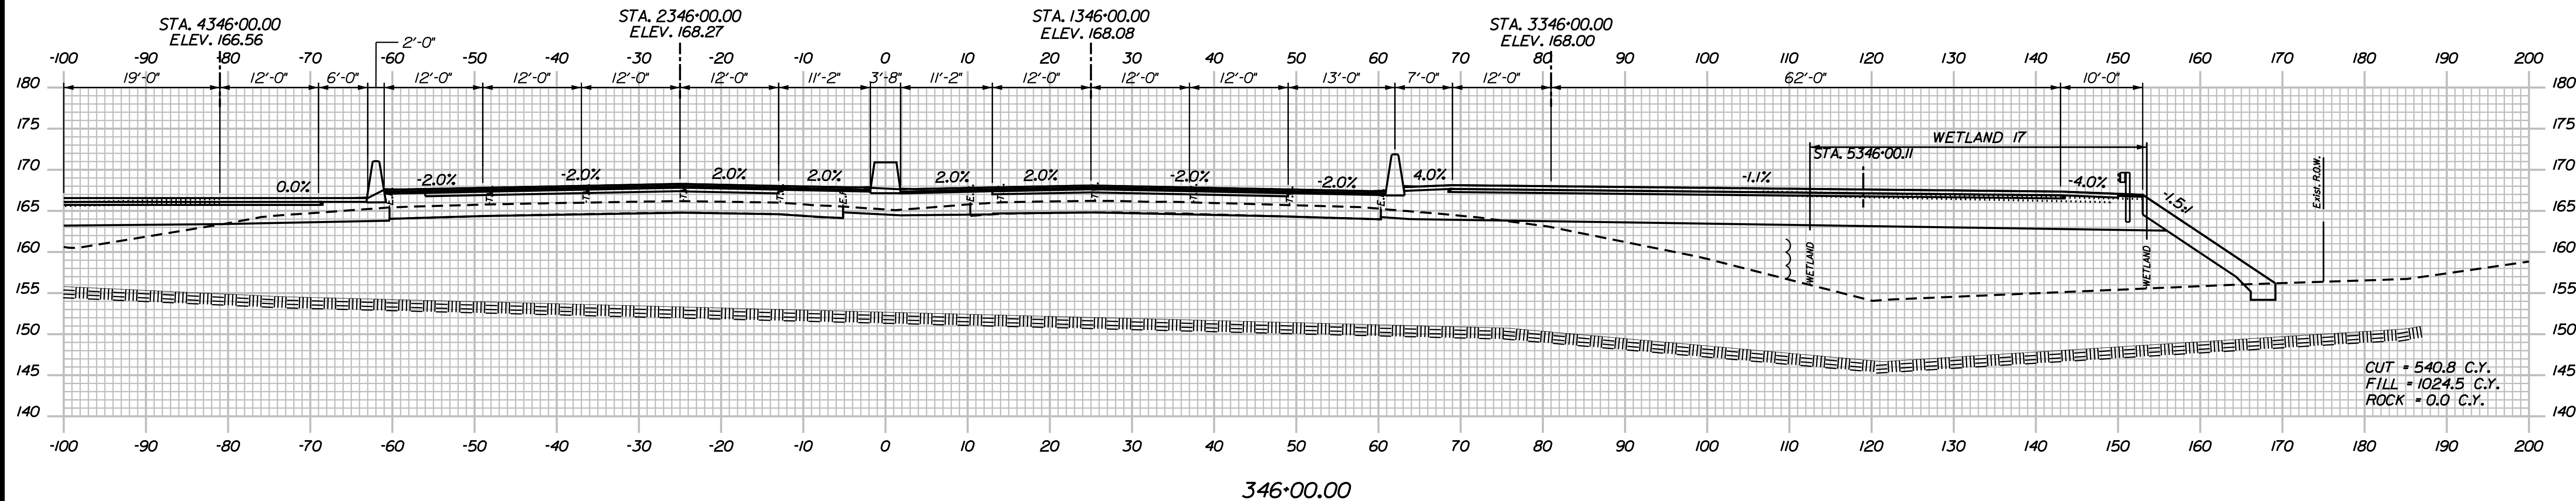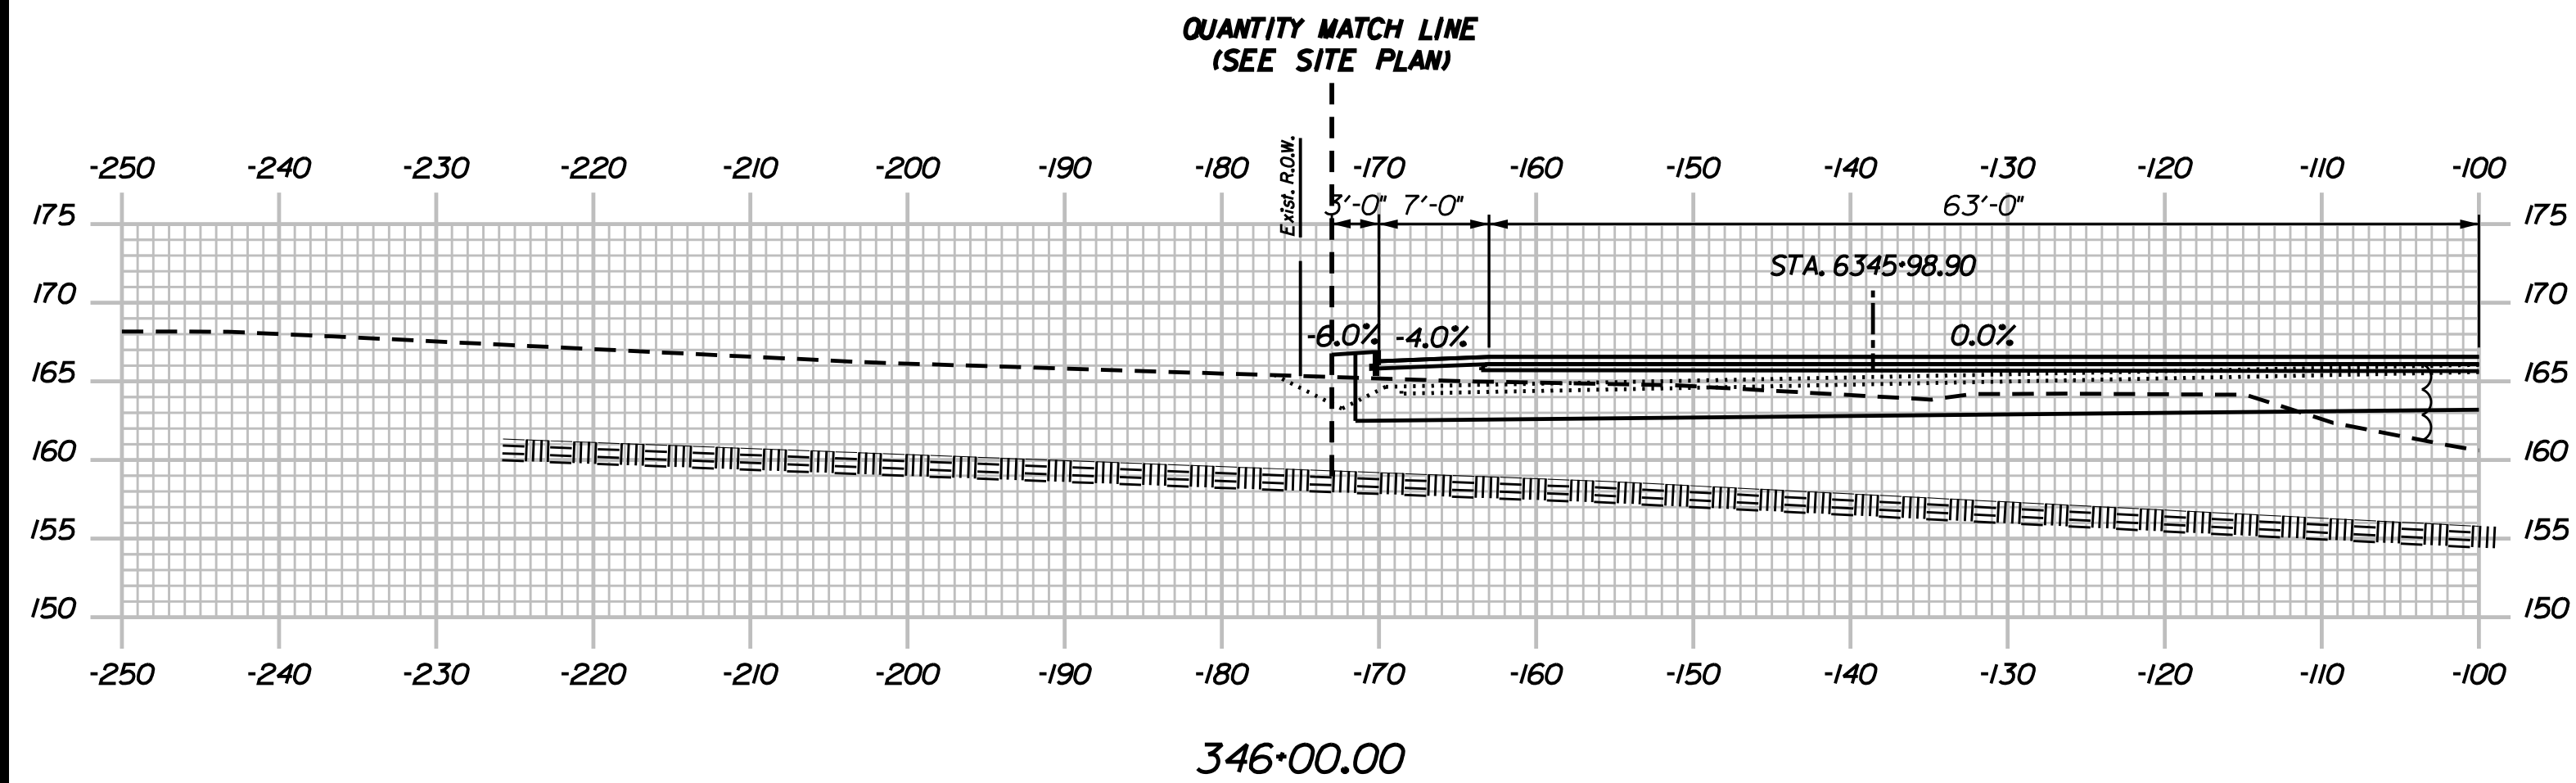

Filename: ...002596371\Xsect13_195.dgn

Scale: Scale of Feet

No.	Revision	By	Date

Designed by:

JACOBS

CONSULTANT PROJECT MANAGER: T. MORIN

	By	Date		By	Date
Designed	AMS	7-18	Checked	CSM	7-18
Drawn	SMG	7-18	In Charge of	TWM	7-18

JACOBS ENGINEERING GROUP
 120 ST. JAMES AVENUE
 BOSTON, MA 02216
 TEL (617) 242-9222
 FAX (617) 242-9824



**THE GOLD STAR
 MEMORIAL HIGHWAY**

MTA PROJECT MANAGER: R. NORWOOD

YORK TOLL PLAZA
 I-95 CROSS SECTIONS
 STA. 346+00

SHEET NUMBER: XS-46
 CONTRACT: 2018.20
 244 OF 489

Date: 8/28/2018

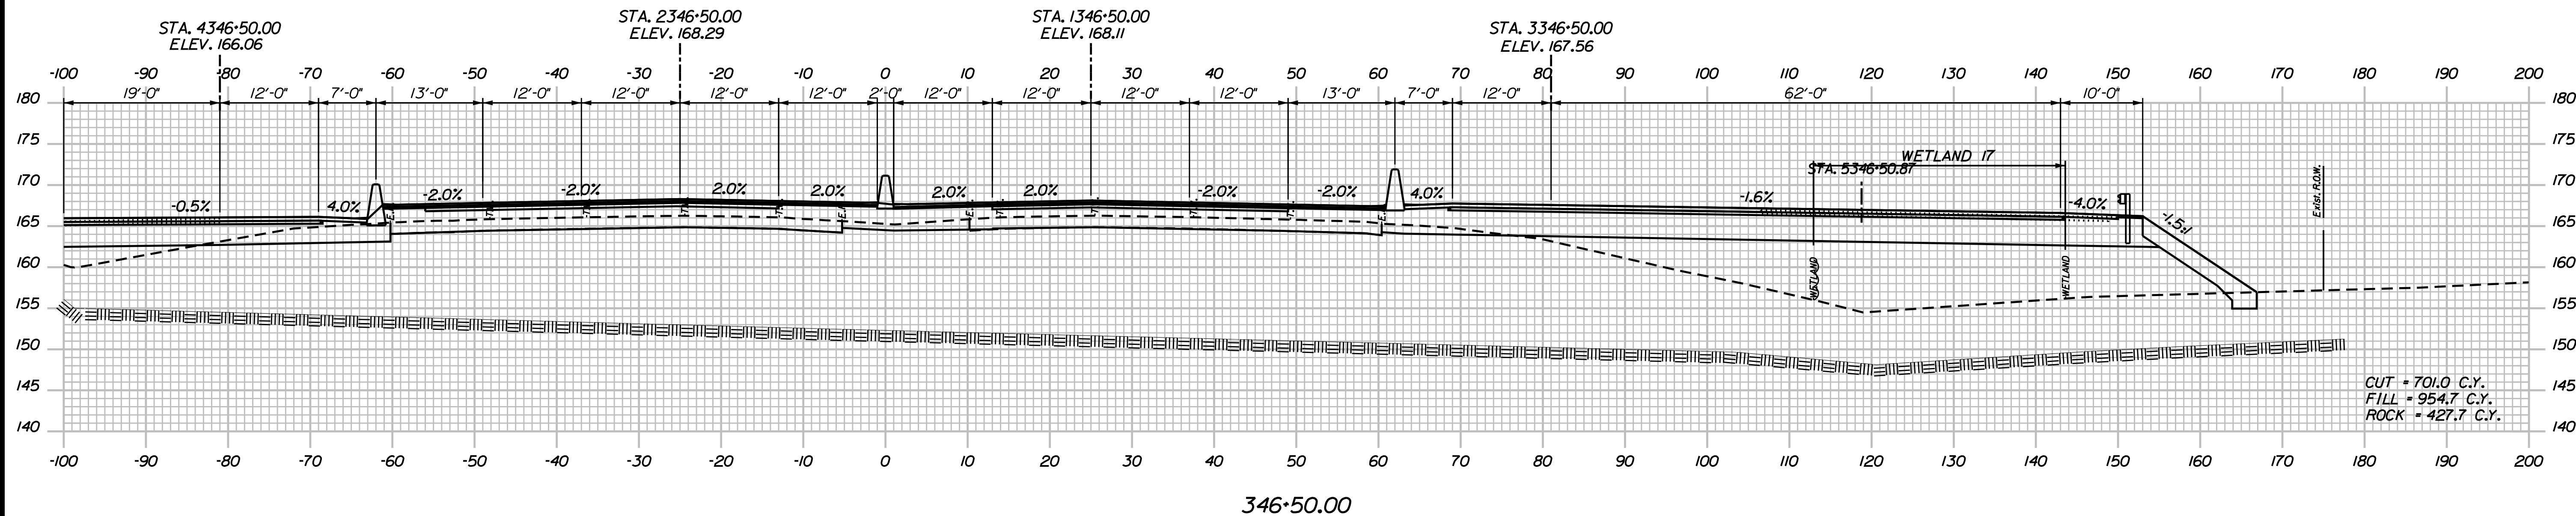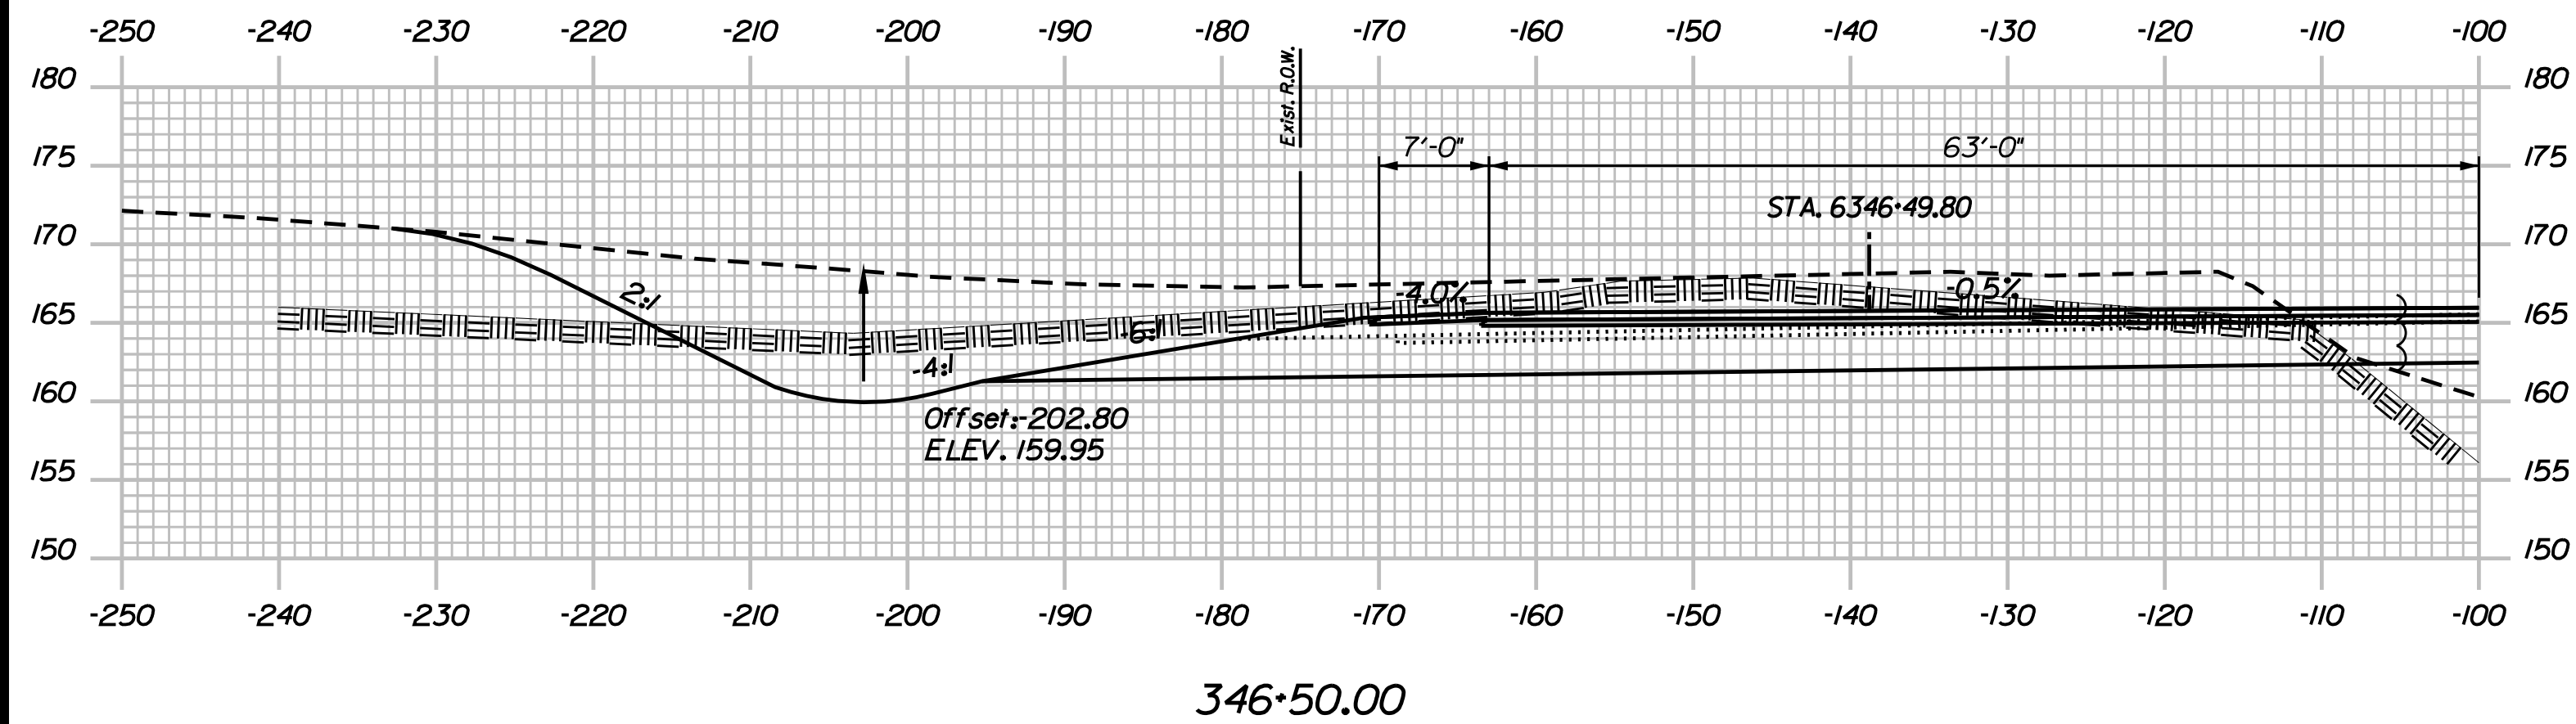

Filename: ...00259637\Xsect13_195.dgn

Scale:

No.	Revision	By	Date

Designed by:

JACOBS

CONSULTANT PROJECT MANAGER: T. MORIN

	By	Date		By	Date
Designed	AMS	7-18	Checked	CSM	7-18
Drawn	SMG	7-18	In Charge of	TWM	7-18

JACOBS ENGINEERING GROUP
 120 ST. JAMES AVENUE
 BOSTON, MA 02216
 TEL (617) 242-9222
 FAX (617) 242-9824


THE GOLD STAR
MEMORIAL HIGHWAY

MTA PROJECT MANAGER: R. NORWOOD


YORK TOLL PLAZA
 I-95 CROSS SECTIONS
 STA. 346+50

SHEET NUMBER: XS-47
 CONTRACT: 2018.20
 245 OF 489

Date: 8/28/2018

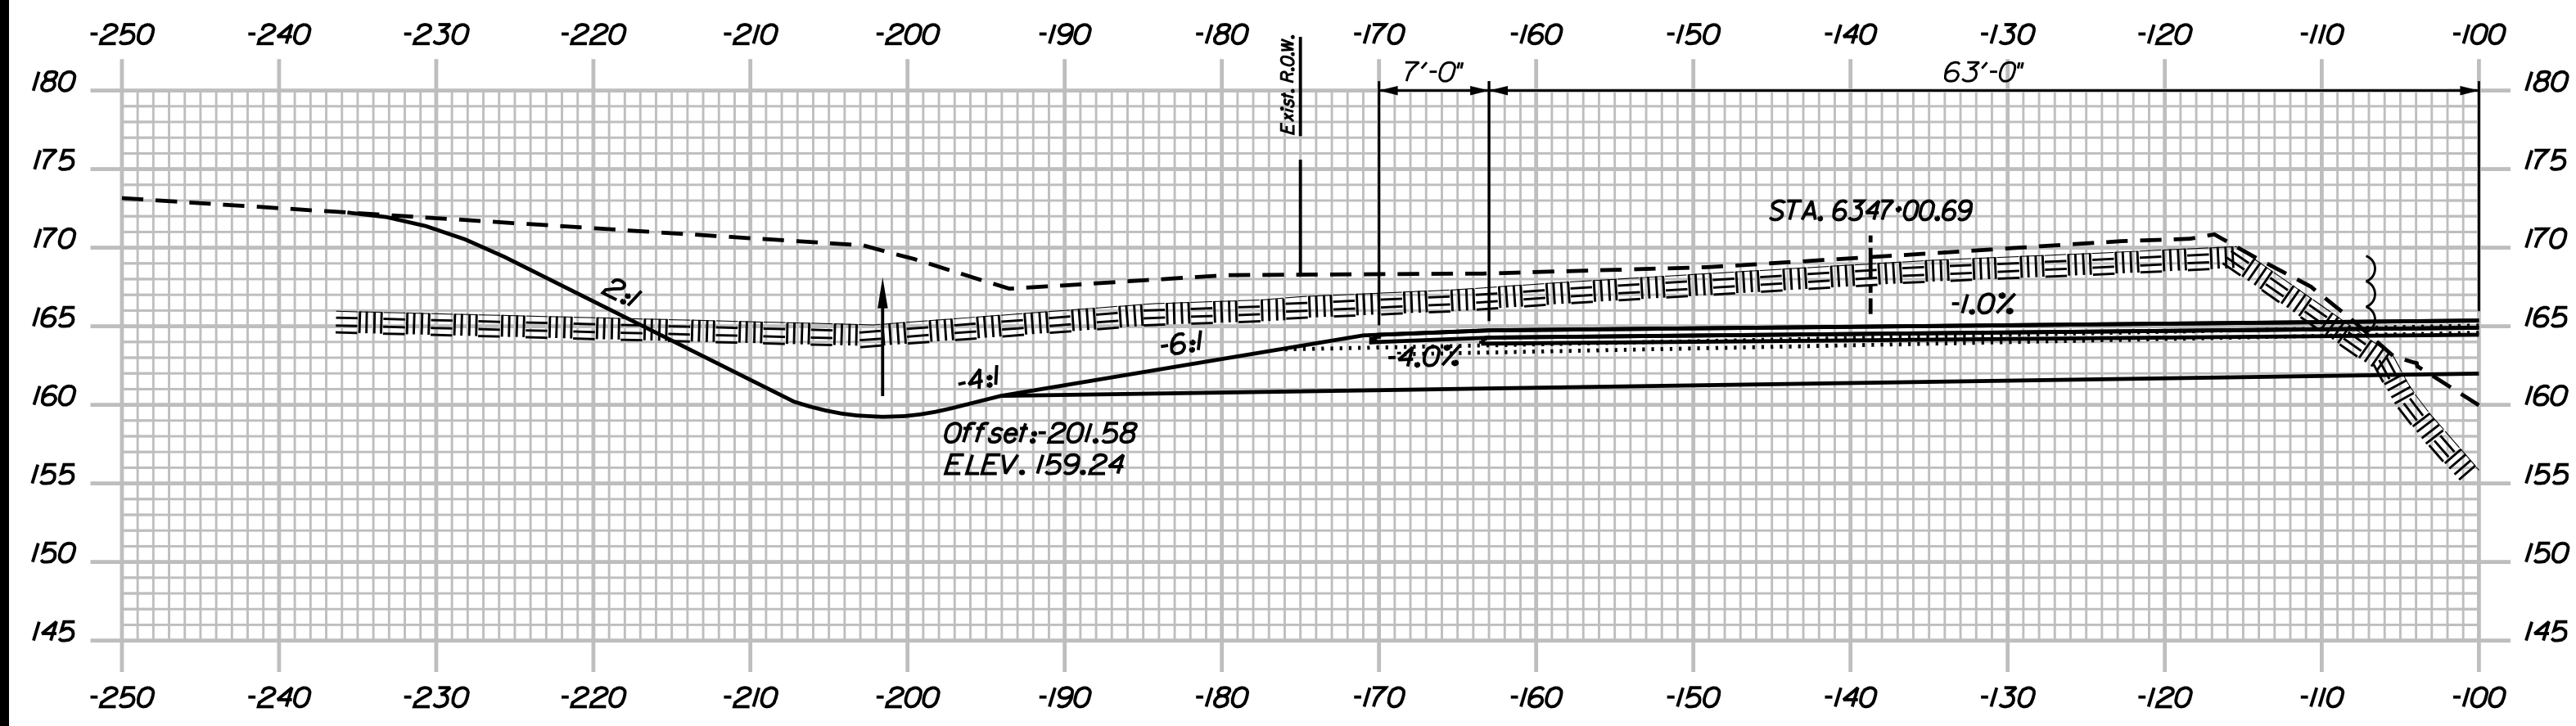

347+00.00

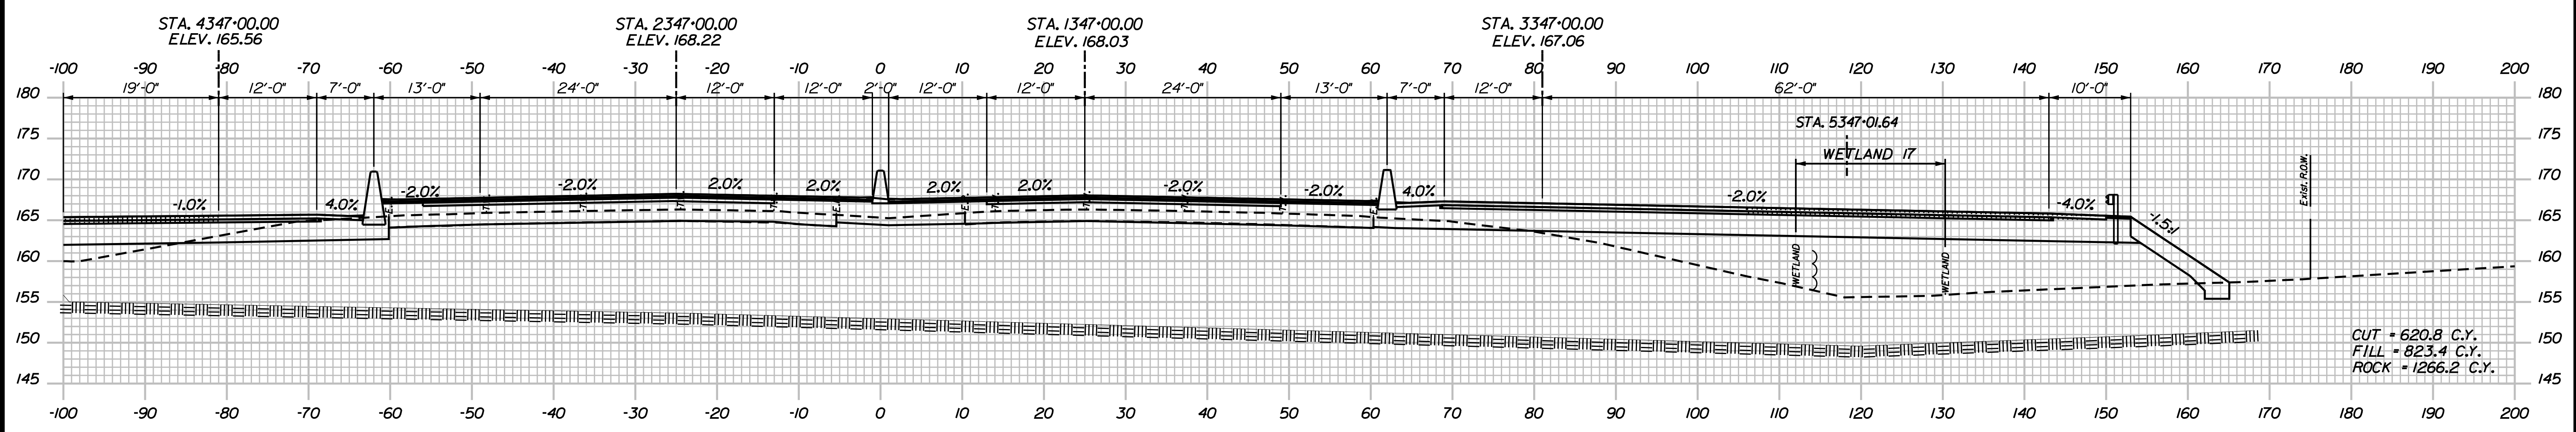

347+00.00

Filename: ...002596371\Xsect13_195.dgn

Scale: Scale of Feet

No.	Revision	By	Date

Designed by:

JACOBS

CONSULTANT PROJECT MANAGER: T. MORIN

	By	Date		By	Date
Designed	AMS	7-18	Checked	CSM	7-18
Drawn	SMG	7-18	In Charge of	TWM	7-18

JACOBS ENGINEERING GROUP
 120 ST. JAMES AVENUE
 BOSTON, MA 02216
 TEL (617) 242-9222
 FAX (617) 242-9824



THE GOLD STAR
 MEMORIAL HIGHWAY

MTA PROJECT MANAGER: R. NORWOOD

YORK TOLL PLAZA
 I-95 CROSS SECTIONS
 STA. 347+00

SHEET NUMBER: XS-48
 CONTRACT: 2018.20
 246 OF 489

Date: 8/28/2018

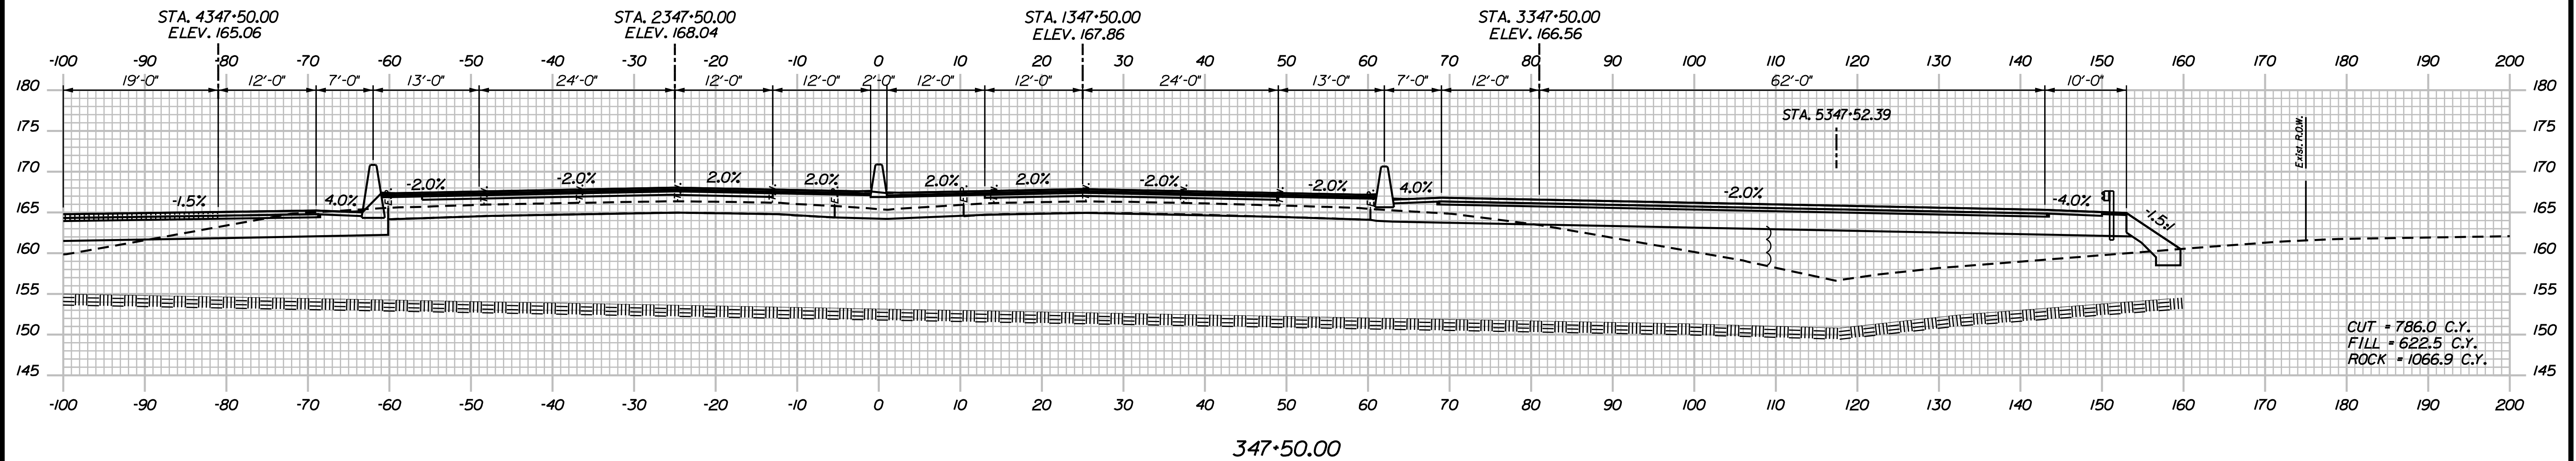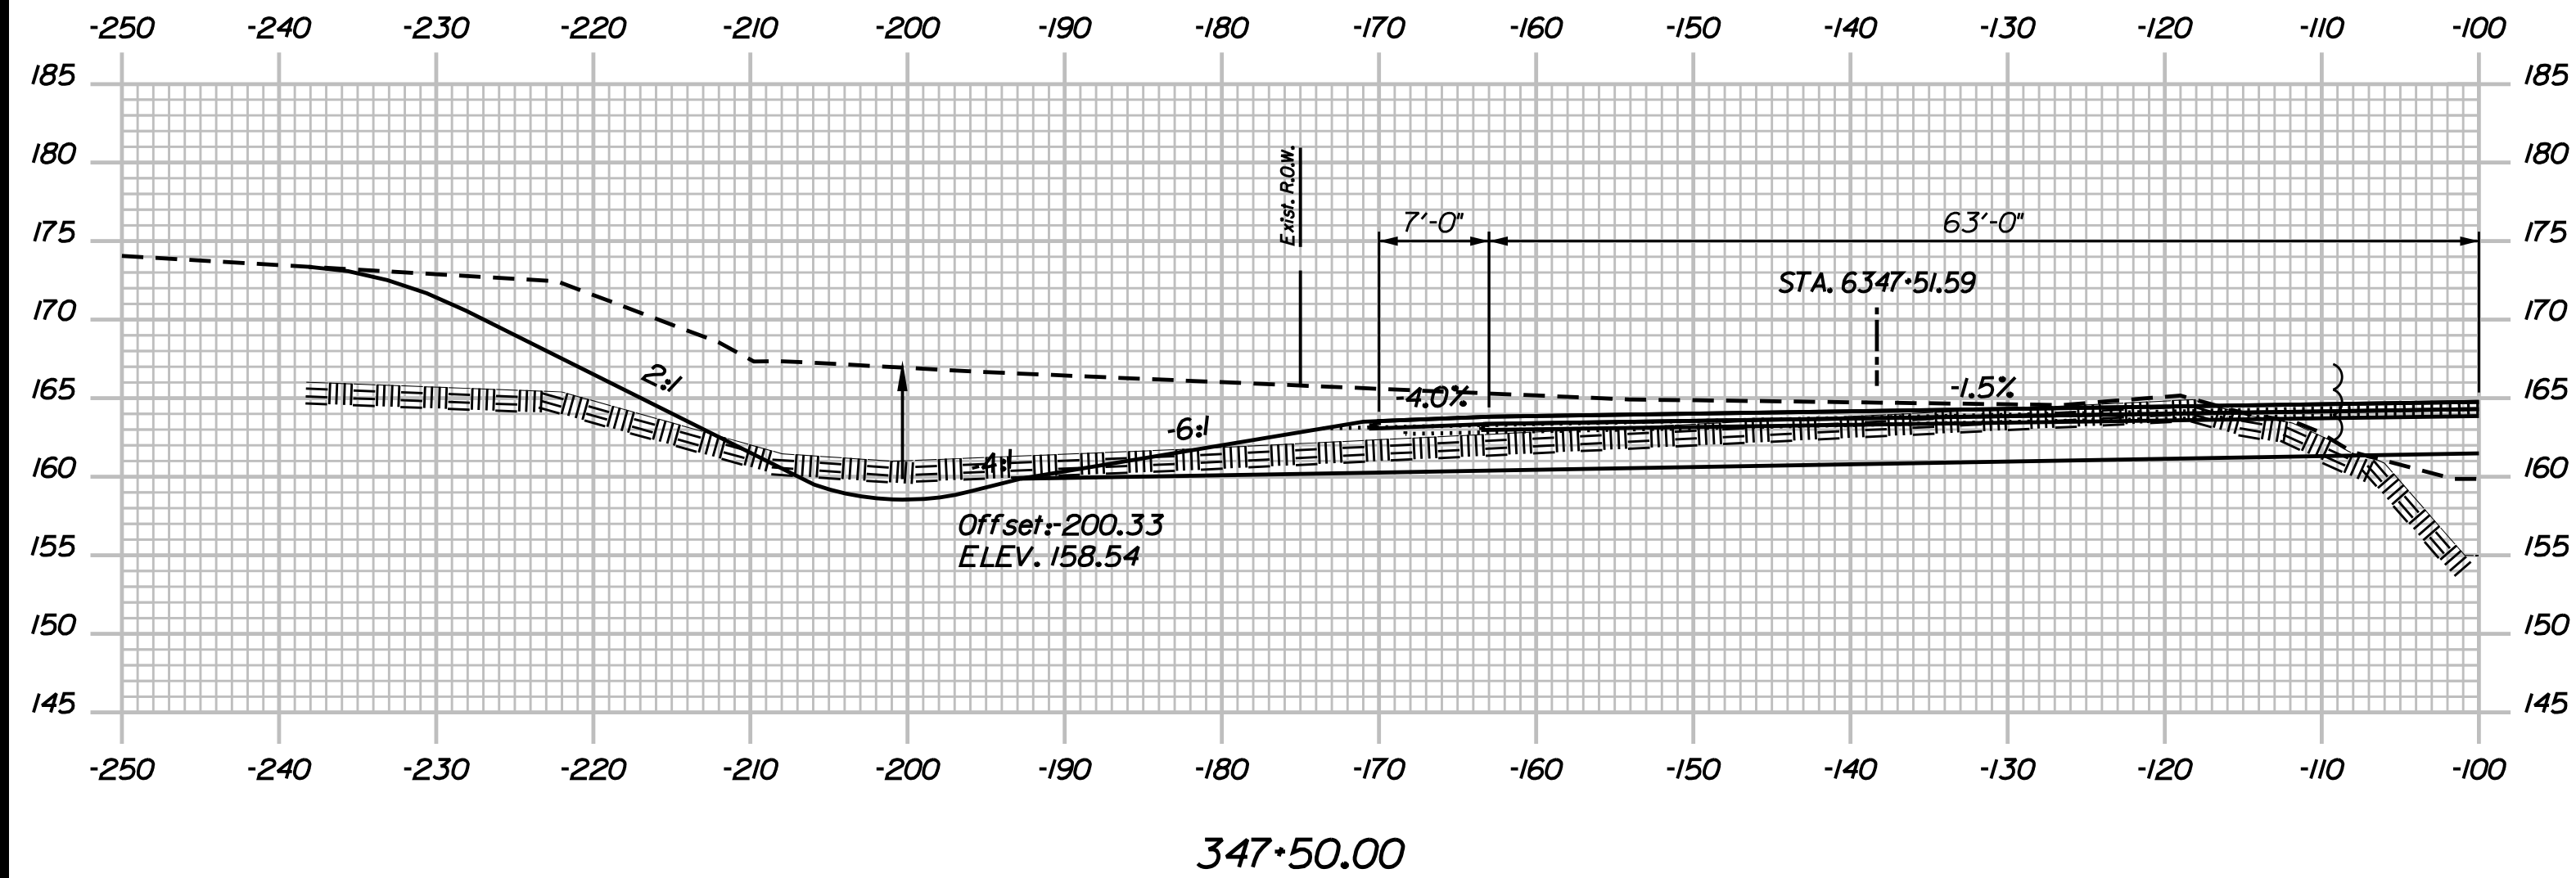

Filename: ...002596371\Xsect13_195.dgn

Scale:

No.	Revision	By	Date

Designed by:

JACOBS

CONSULTANT PROJECT MANAGER: T. MORIN

	By	Date		By	Date
Designed	AMS	7-18	Checked	CSM	7-18
Drawn	SMG	7-18	In Charge of	TWM	7-18

JACOBS ENGINEERING GROUP
 120 ST. JAMES AVENUE
 BOSTON, MA 02216
 TEL (617) 242-9222
 FAX (617) 242-9824



THE GOLD STAR MEMORIAL HIGHWAY

MTA PROJECT MANAGER: R. NORWOOD

YORK TOLL PLAZA
 I-95 CROSS SECTIONS
 STA. 347+50

SHEET NUMBER: XS-49
 CONTRACT: 2018.20
 247 OF 489

Date: 8/28/2018

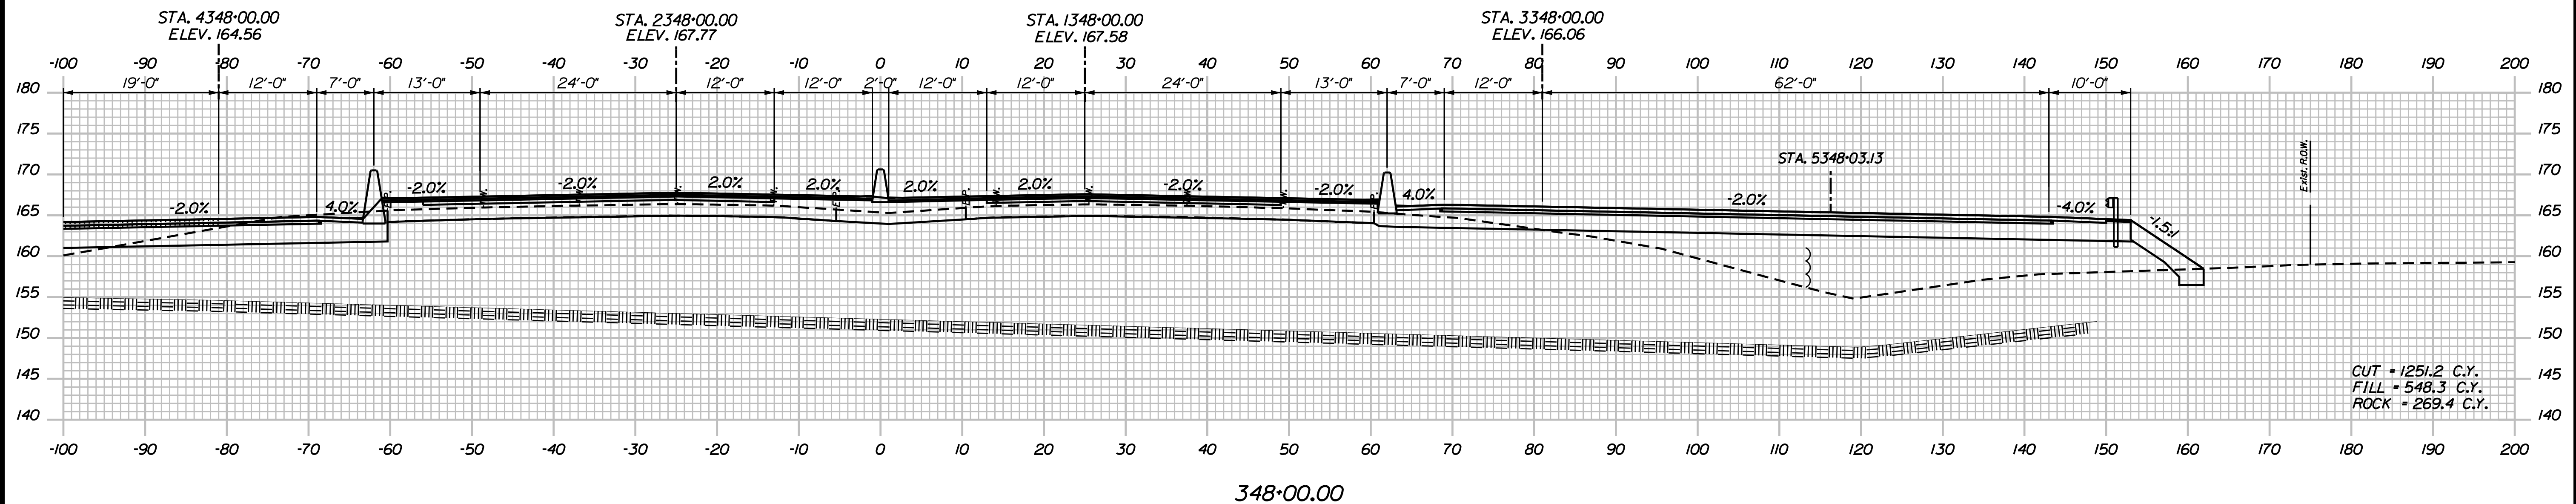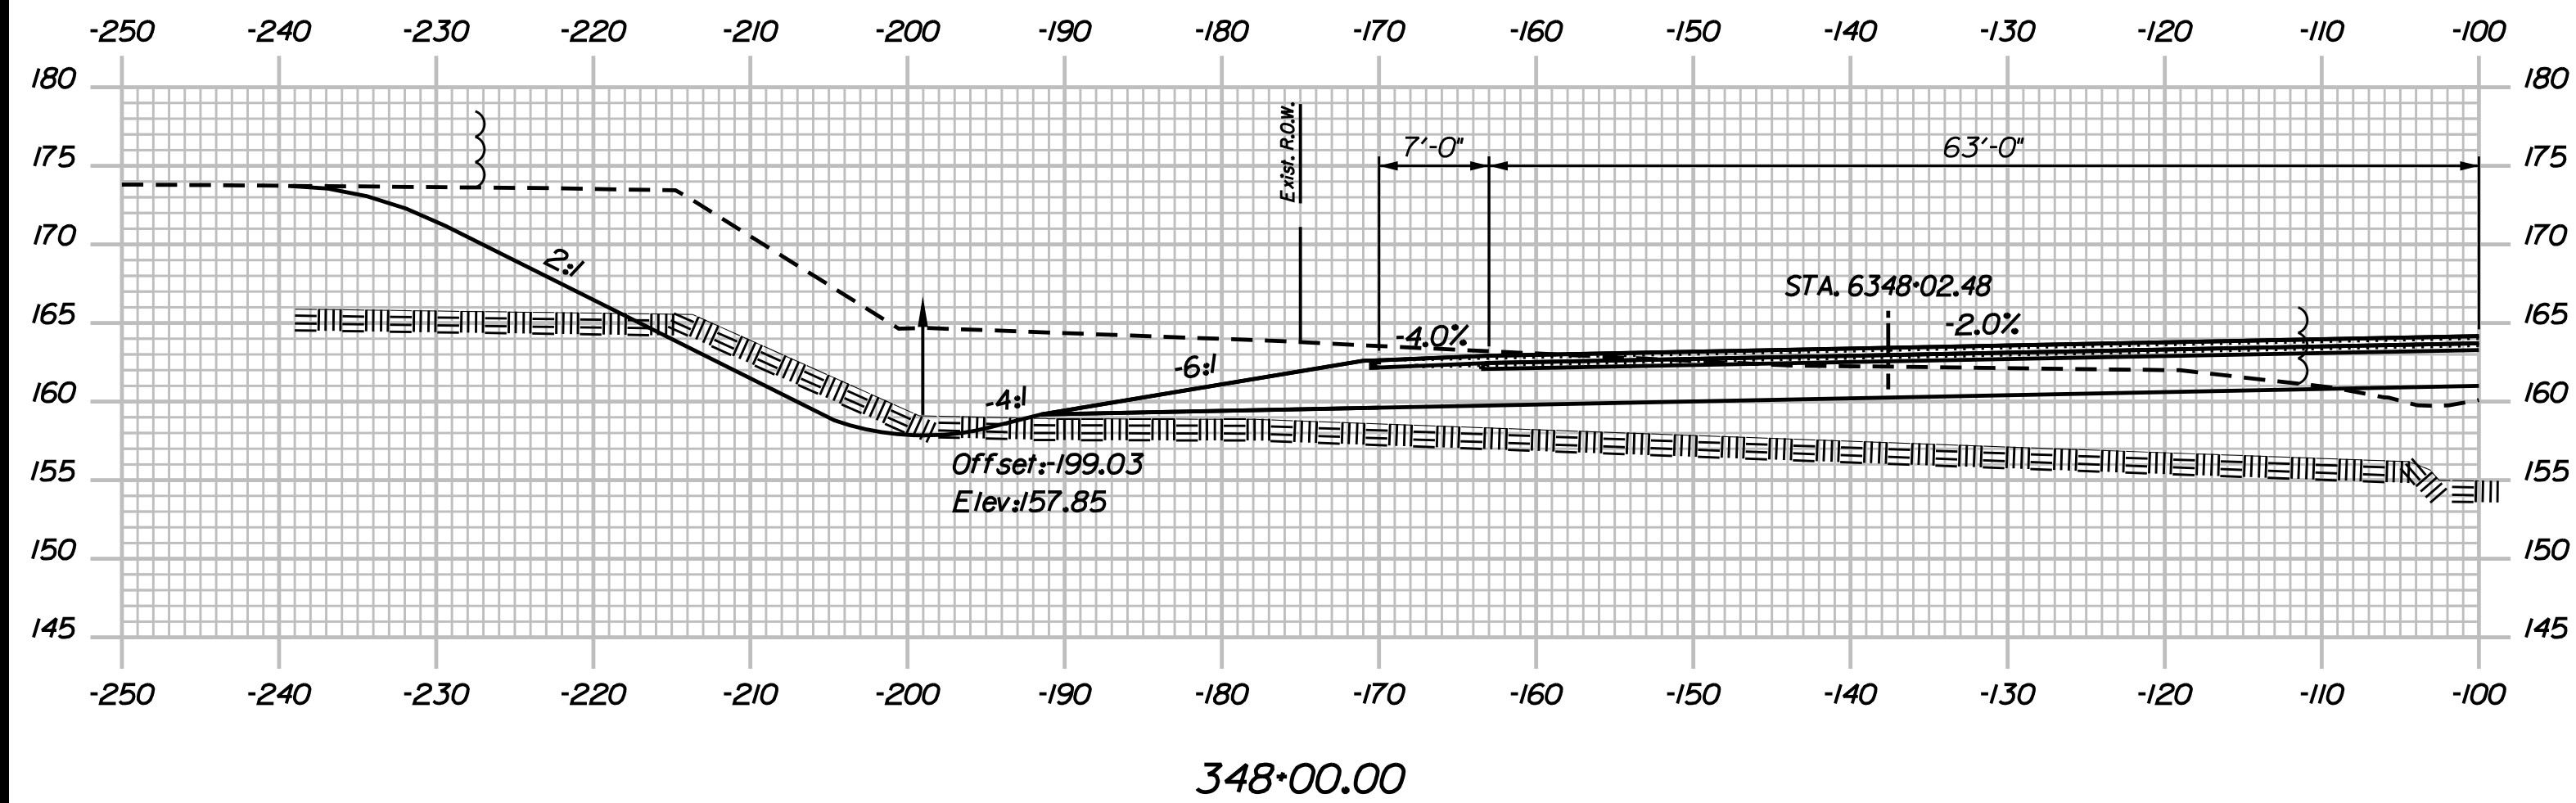

Filename: ...00259637\Xsect13_195.dgn

Scale: Scale of Feet

No.	Revision	By	Date

Designed by:

JACOBS

CONSULTANT PROJECT MANAGER: T. MORIN

	By	Date		By	Date
Designed	AMS	7-18	Checked	CSM	7-18
Drawn	SMG	7-18	In Charge of	TWM	7-18

JACOBS ENGINEERING GROUP
 120 ST. JAMES AVENUE
 BOSTON, MA 02216
 TEL (617) 242-9222
 FAX (617) 242-9824

THE GOLD STAR
 MEMORIAL HIGHWAY



MTA PROJECT MANAGER: R. NORWOOD

YORK TOLL PLAZA
 I-95 CROSS SECTIONS
 STA. 348+00

SHEET NUMBER: XS-50
 248 OF 489

CONTRACT: 2018.20

Date: 8/28/2018

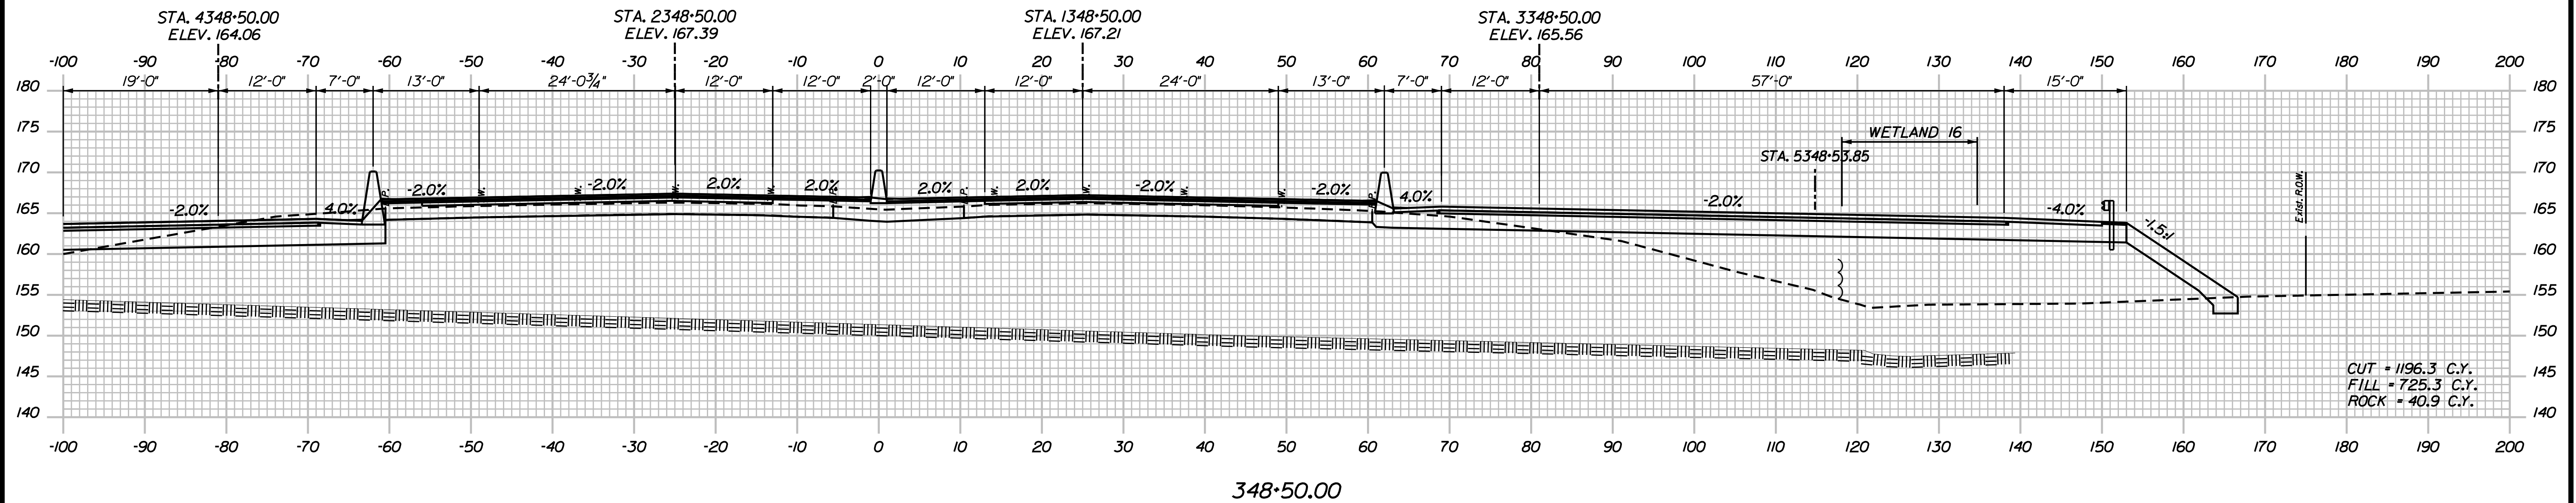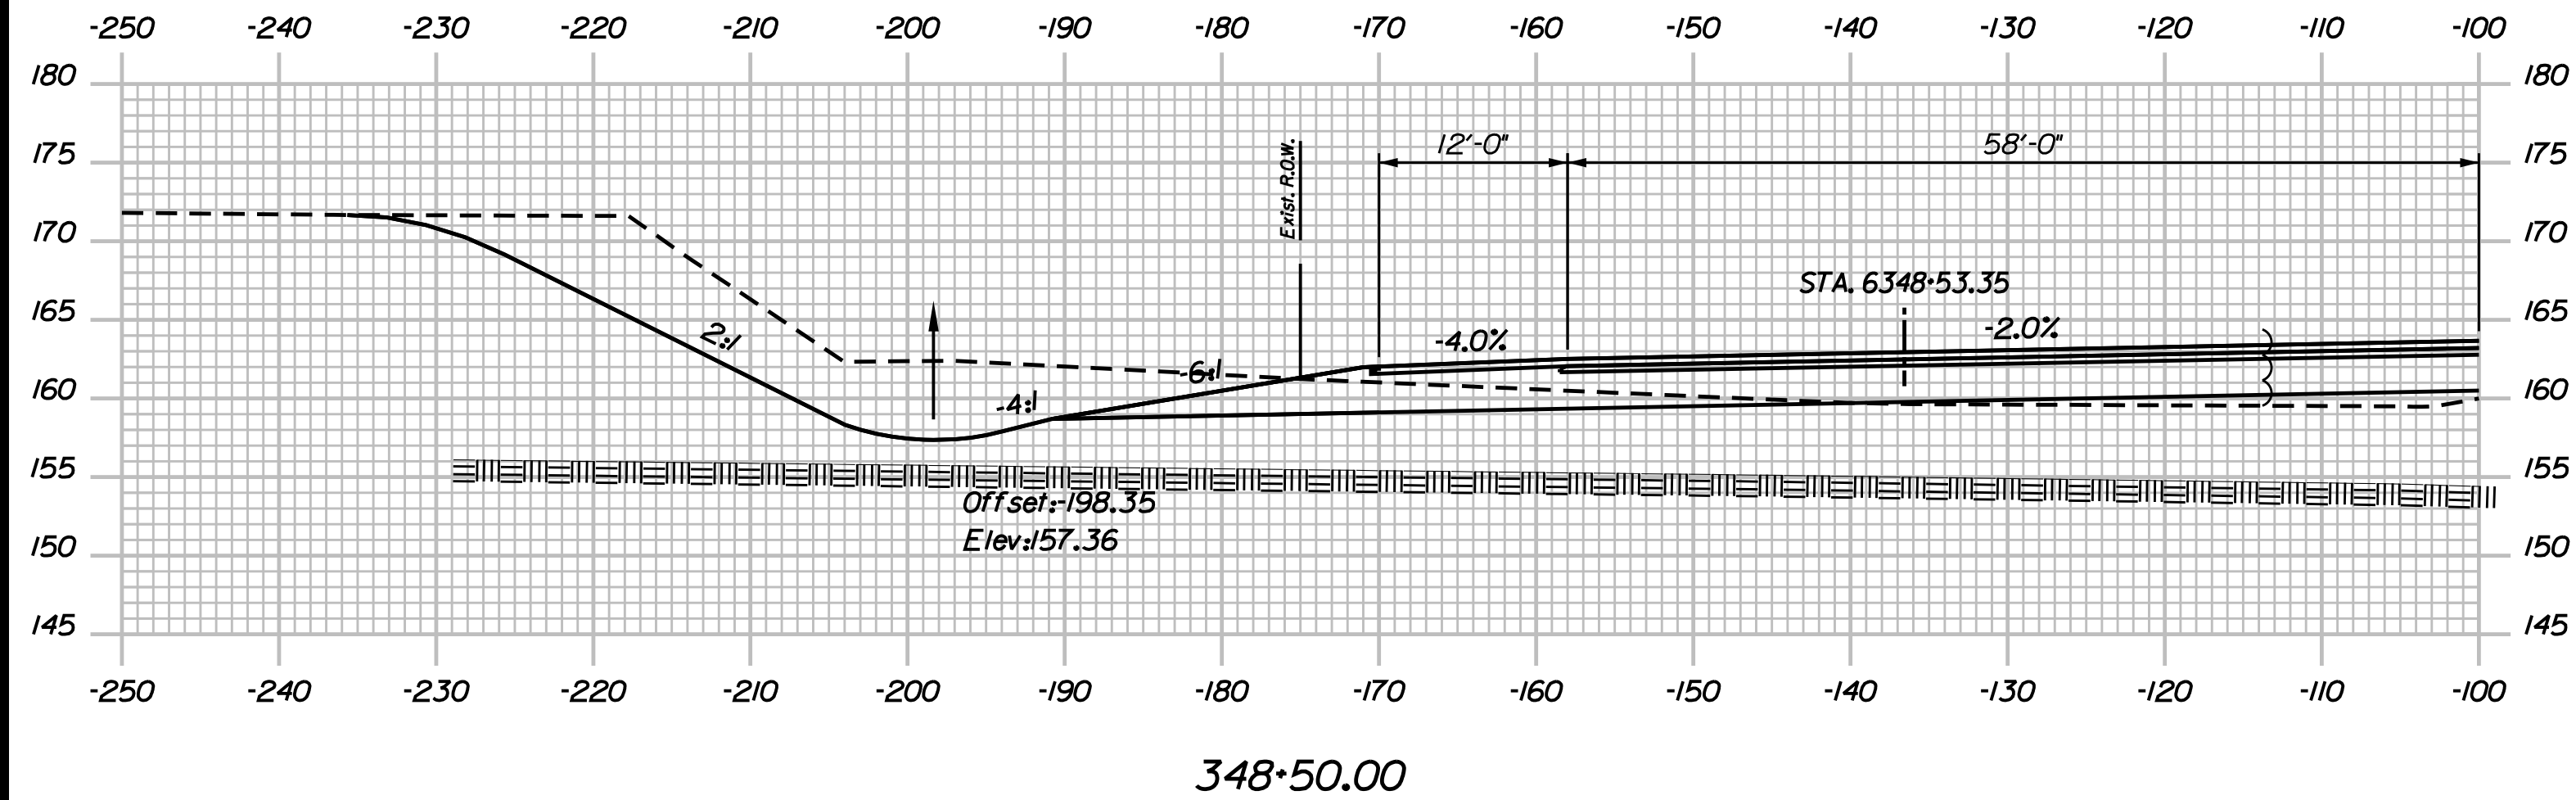

Filename: ...00259637\Xsect13_195.dgn

Scale: Scale of Feet

No.	Revision	By	Date

Designed by:

JACOBS

CONSULTANT PROJECT MANAGER: T. MORIN

	By	Date		By	Date
Designed	AMS	7-18	Checked	CSM	7-18
Drawn	SMG	7-18	In Charge of	TWM	7-18

JACOBS ENGINEERING GROUP
 120 ST. JAMES AVENUE
 BOSTON, MA 02216
 TEL (617) 242-9222
 FAX (617) 242-9824

THE GOLD STAR MEMORIAL HIGHWAY



MTA PROJECT MANAGER: R. NORWOOD

YORK TOLL PLAZA
 I-95 CROSS SECTIONS
 STA. 348+50

SHEET NUMBER: XS-51
 249 OF 489

CONTRACT: 2018.20

Date: 8/28/2018

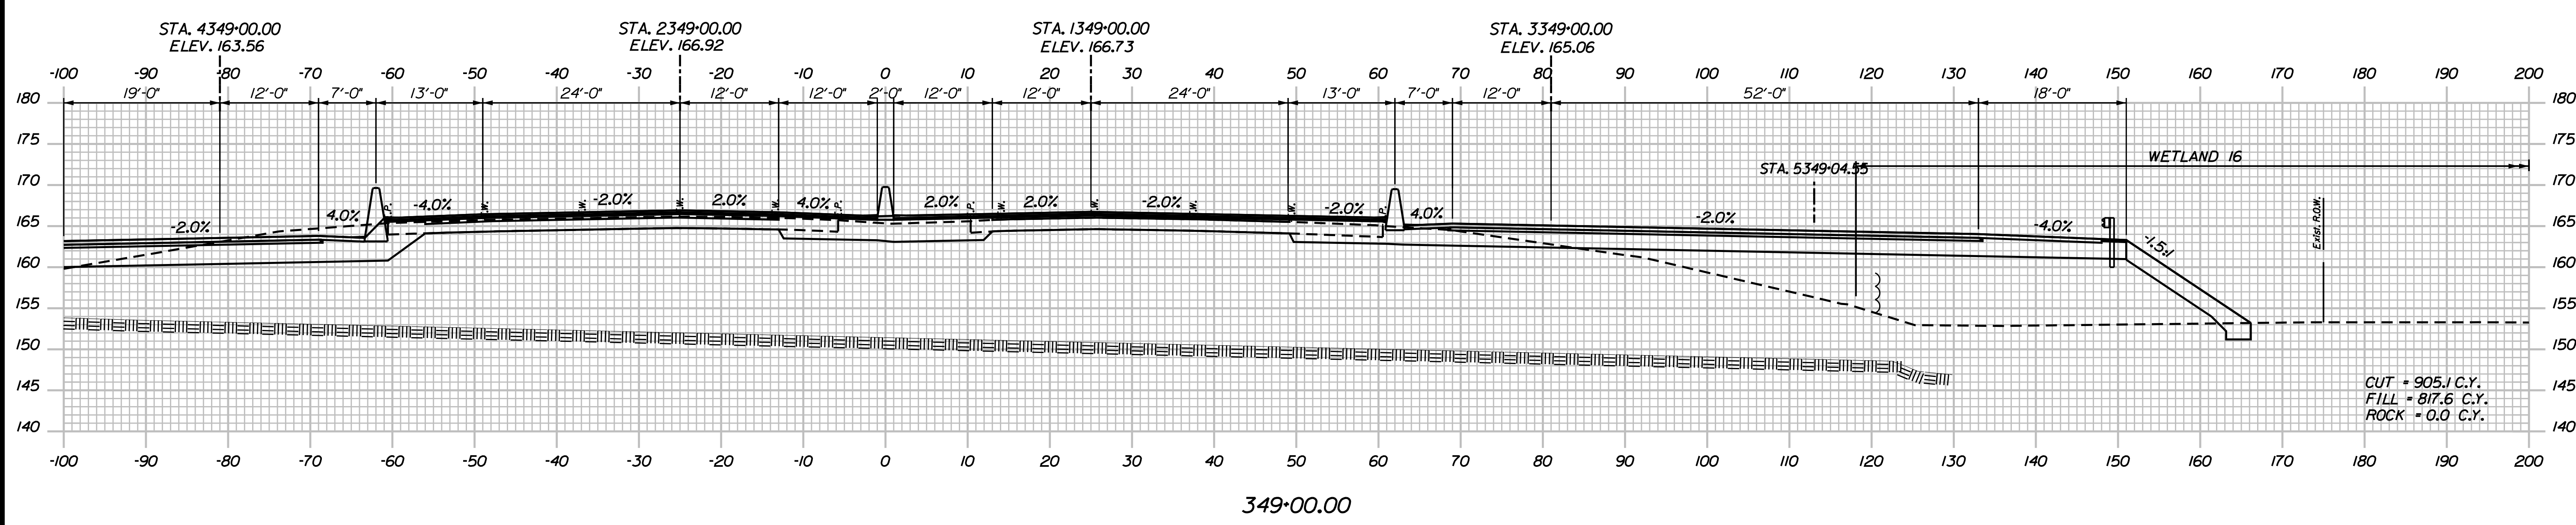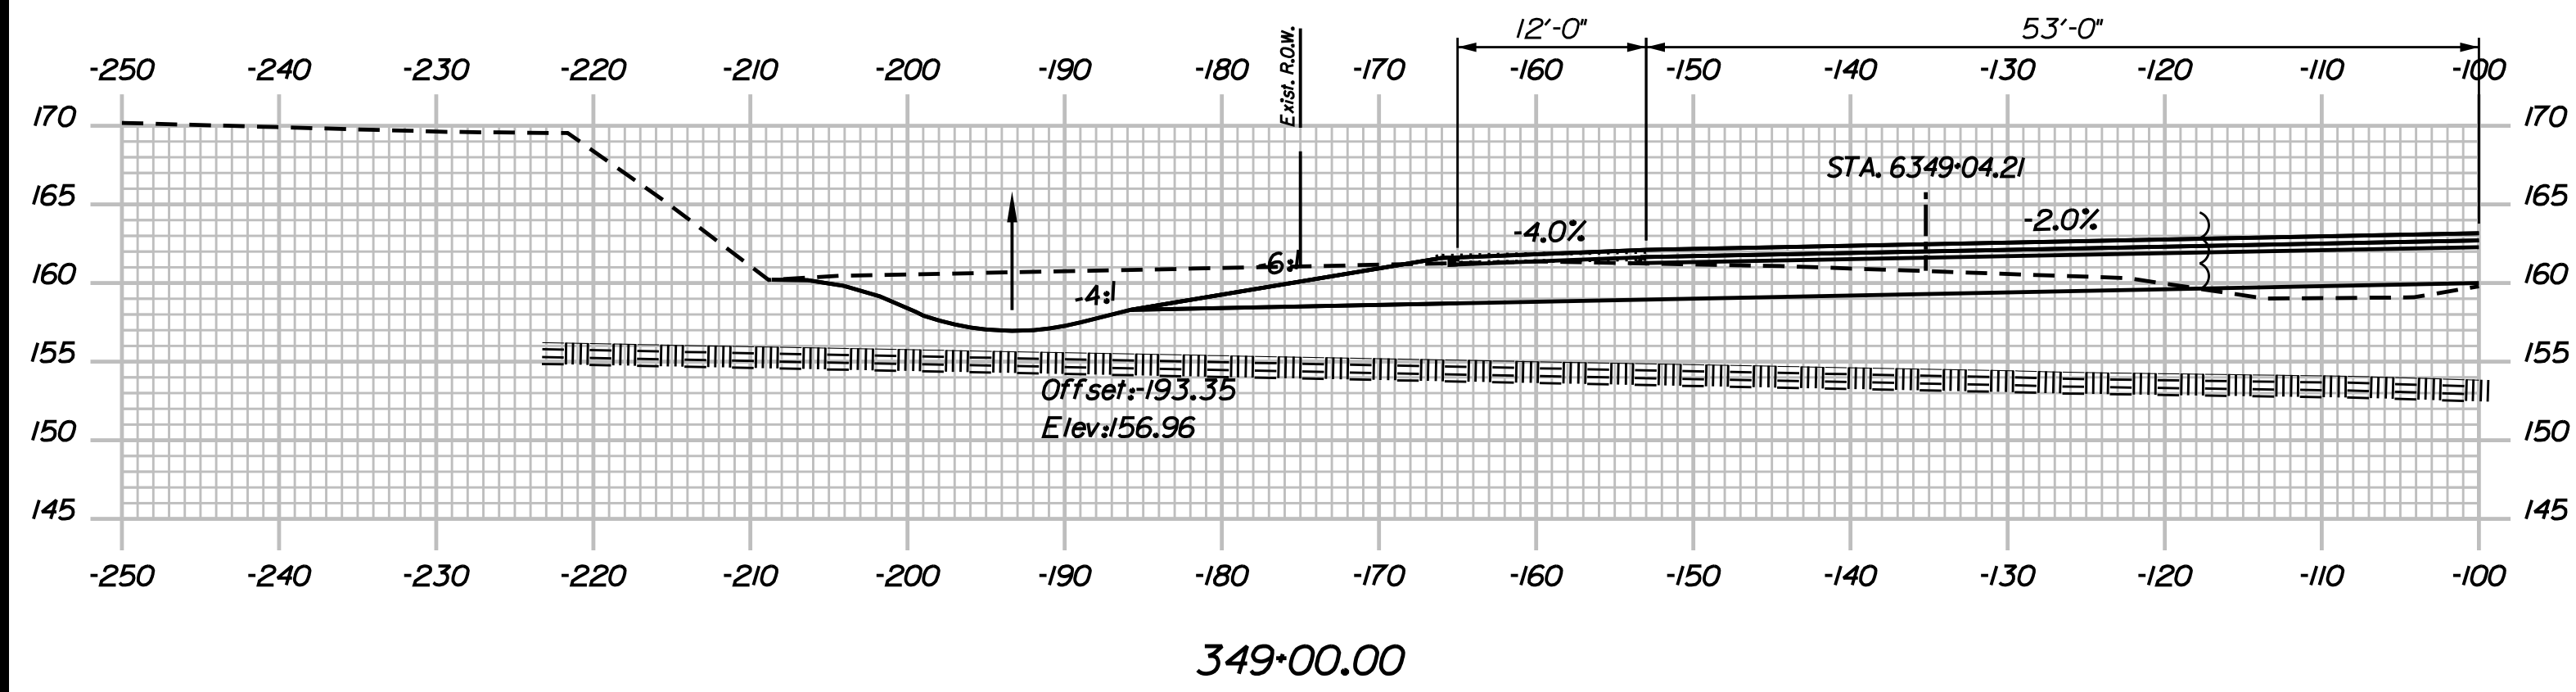

Filename: ...00259637\Xsect13_195.dgn

Scale: Scale of Feet

No.	Revision	By	Date

Designed by:

JACOBS

CONSULTANT PROJECT MANAGER: T. MORIN

	By	Date		By	Date
Designed	AMS	7-18	Checked	CSM	7-18
Drawn	SMG	7-18	In Charge of	TWM	7-18

JACOBS ENGINEERING GROUP
 120 ST. JAMES AVENUE
 BOSTON, MA 02216
 TEL (617) 242-9222
 FAX (617) 242-9824

THE GOLD STAR
MEMORIAL HIGHWAY

MTA PROJECT MANAGER: R. NORWOOD



YORK TOLL PLAZA
 I-95 CROSS SECTIONS
 STA. 349+00

SHEET NUMBER: XS-52
 250 OF 489

CONTRACT: 2018.20

CUT = 905.1 C.Y.
 FILL = 817.6 C.Y.
 ROCK = 0.0 C.Y.

Date: 8/28/2018

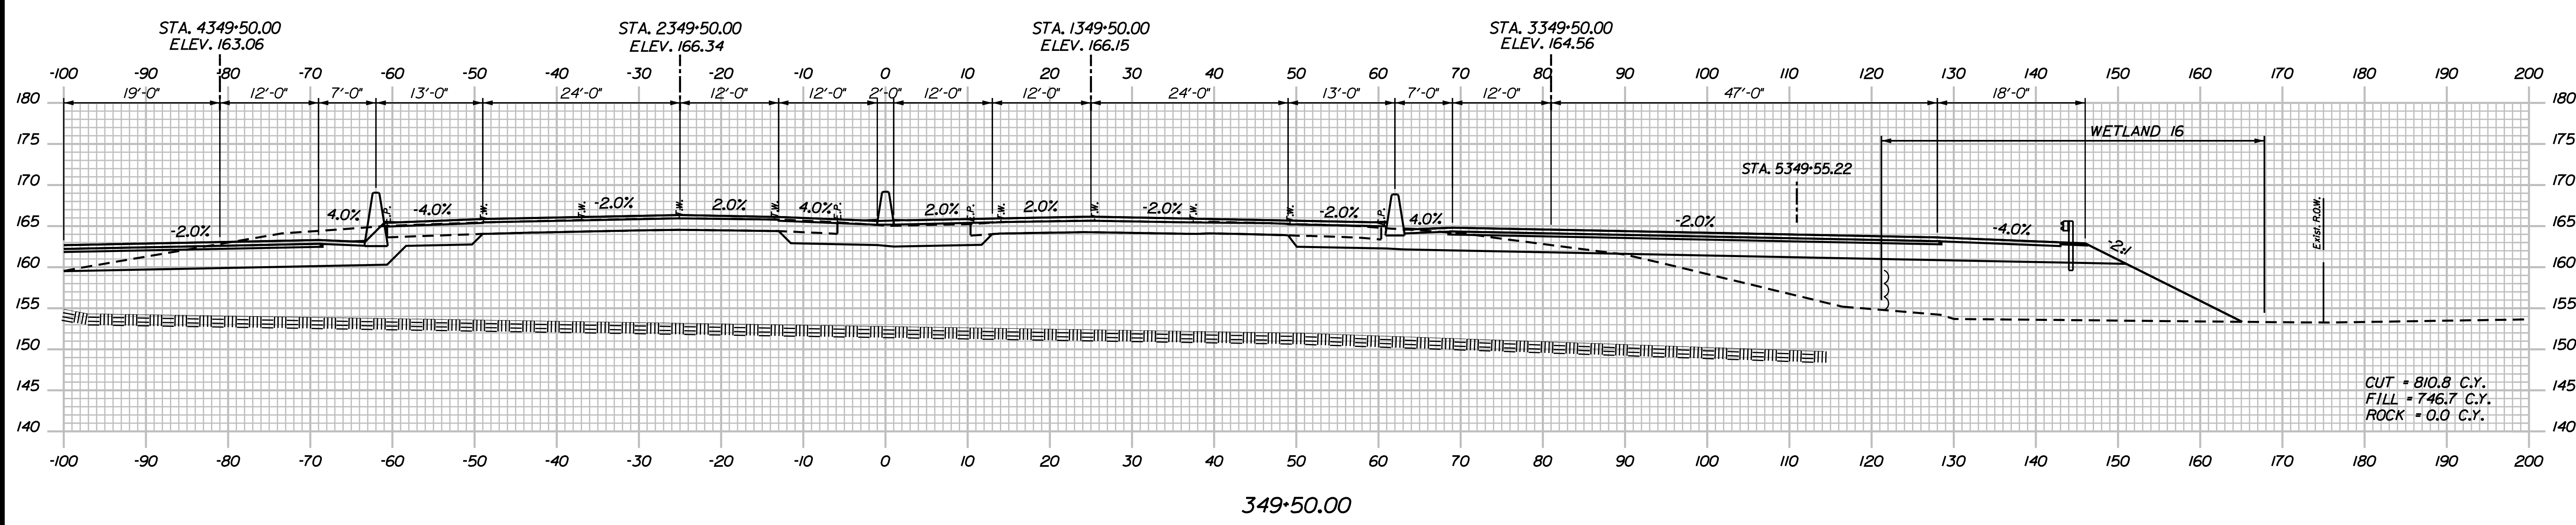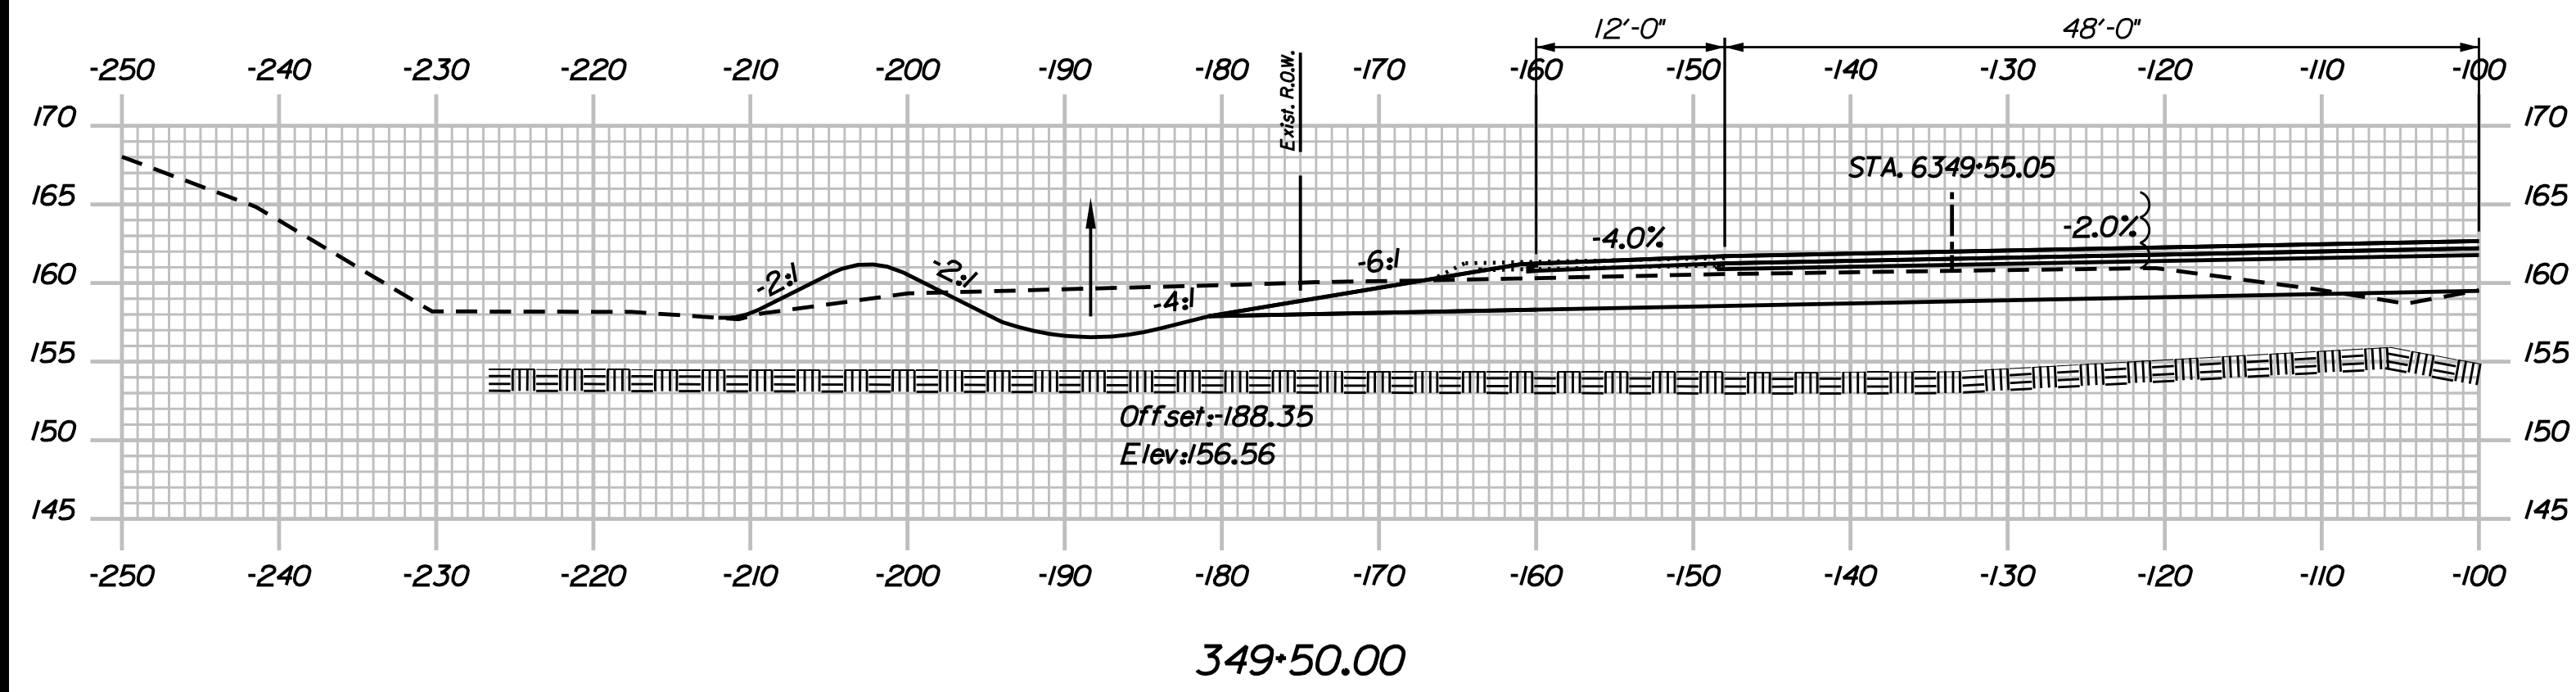

Filename: ...00259637\Xsect13_195.dgn

Scale: Scale of Feet

No.	Revision	By	Date

Designed by:

JACOBS

CONSULTANT PROJECT MANAGER: T. MORIN

	By	Date		By	Date
Designed	AMS	7-18	Checked	CSM	7-18
Drawn	SMG	7-18	In Charge of	TWM	7-18

JACOBS ENGINEERING GROUP
 120 ST. JAMES AVENUE
 BOSTON, MA 02216
 TEL (617) 242-9222
 FAX (617) 242-9824



THE GOLD STAR
 MEMORIAL HIGHWAY

MTA PROJECT MANAGER: R. NORWOOD

YORK TOLL PLAZA
 I-95 CROSS SECTIONS
 STA. 349+50

SHEET NUMBER: XS-53
 CONTRACT: 2018.20
 251 OF 489

Date: 8/28/2018

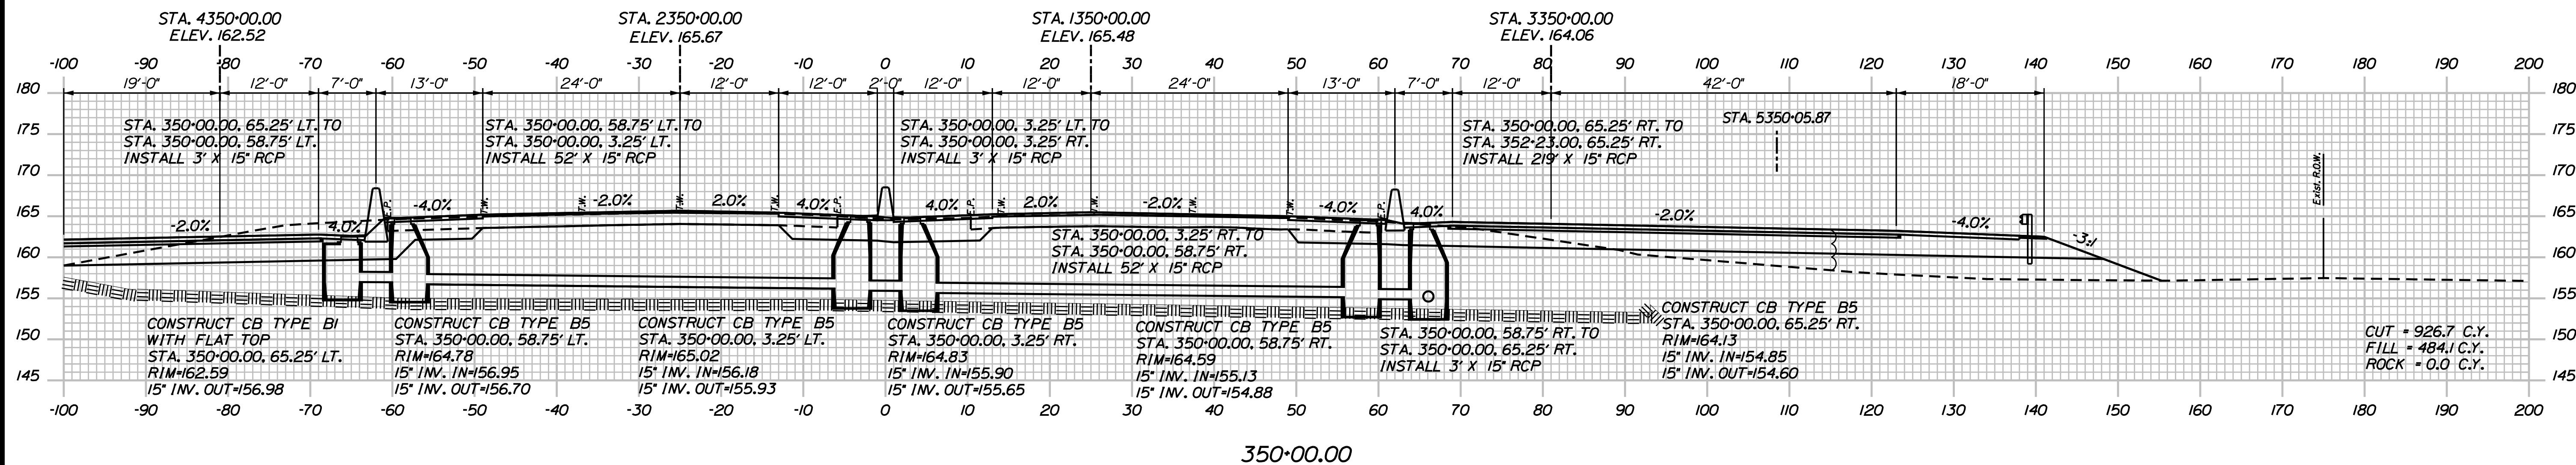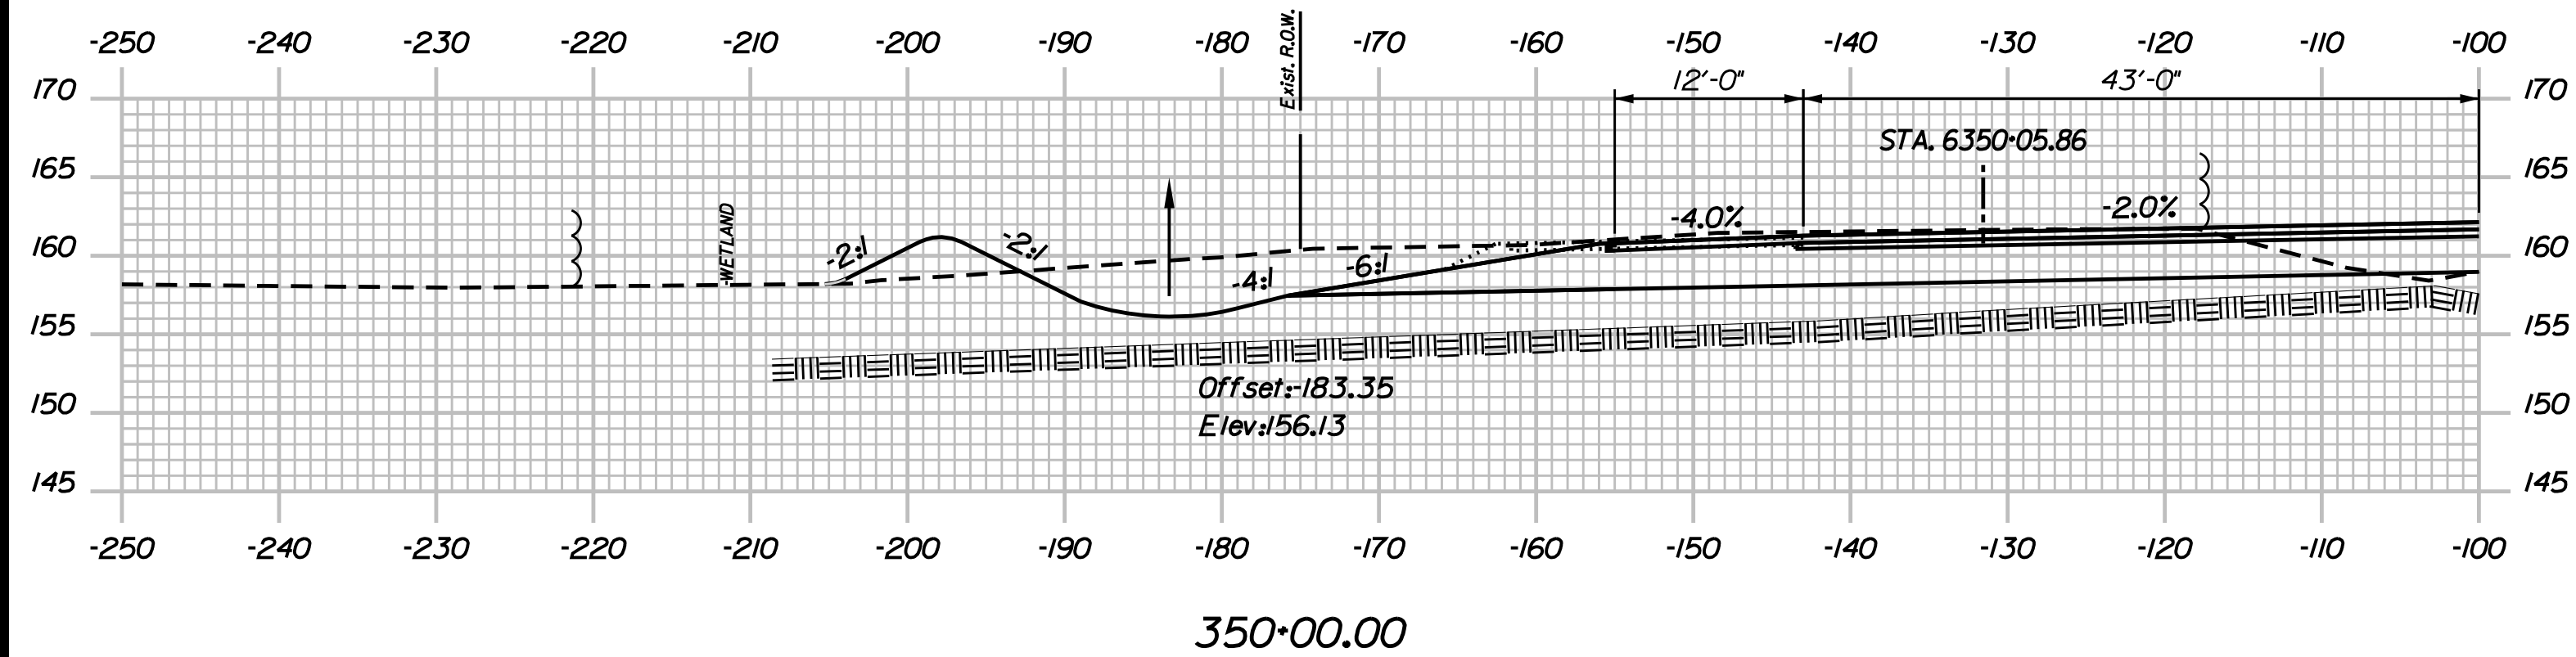

Filename: ...0259637\Xsect13_195.dgn

Scale: Scale of Feet

No.	Revision	By	Date

Designed by:

JACOBS

CONSULTANT PROJECT MANAGER: T. MORIN

	By	Date		By	Date
Designed	AMS	7-18	Checked	CSM	7-18
Drawn	SMG	7-18	In Charge of	TWM	7-18

JACOBS ENGINEERING GROUP
 120 ST. JAMES AVENUE
 BOSTON, MA 02216
 TEL (617) 242-9222
 FAX (617) 242-9824



THE GOLD STAR
 MEMORIAL HIGHWAY

MTA PROJECT MANAGER: R. NORWOOD

YORK TOLL PLAZA
 I-95 CROSS SECTIONS
 STA. 350+00

SHEET NUMBER: XS-54
 CONTRACT: 2018.20
 252 OF 489

Date: 8/28/2018

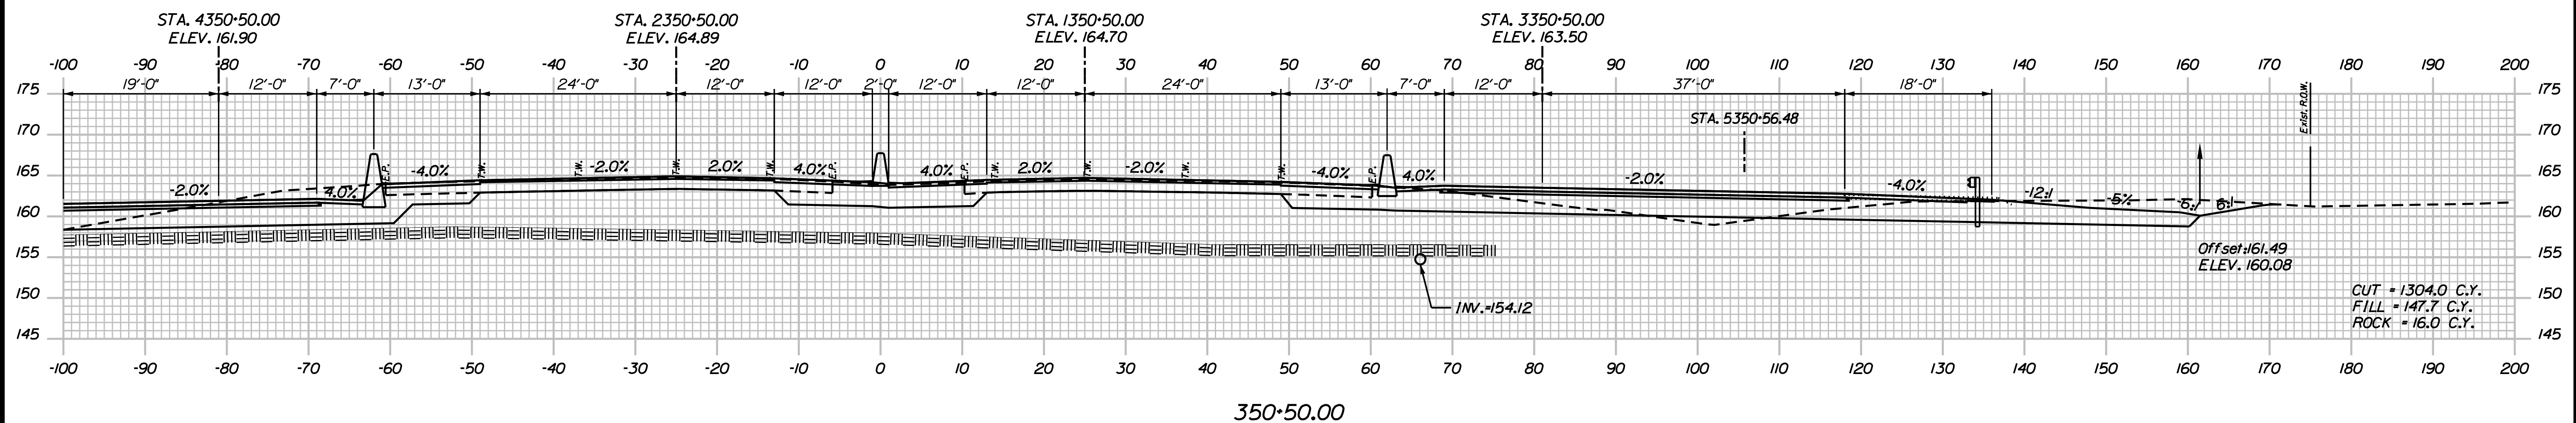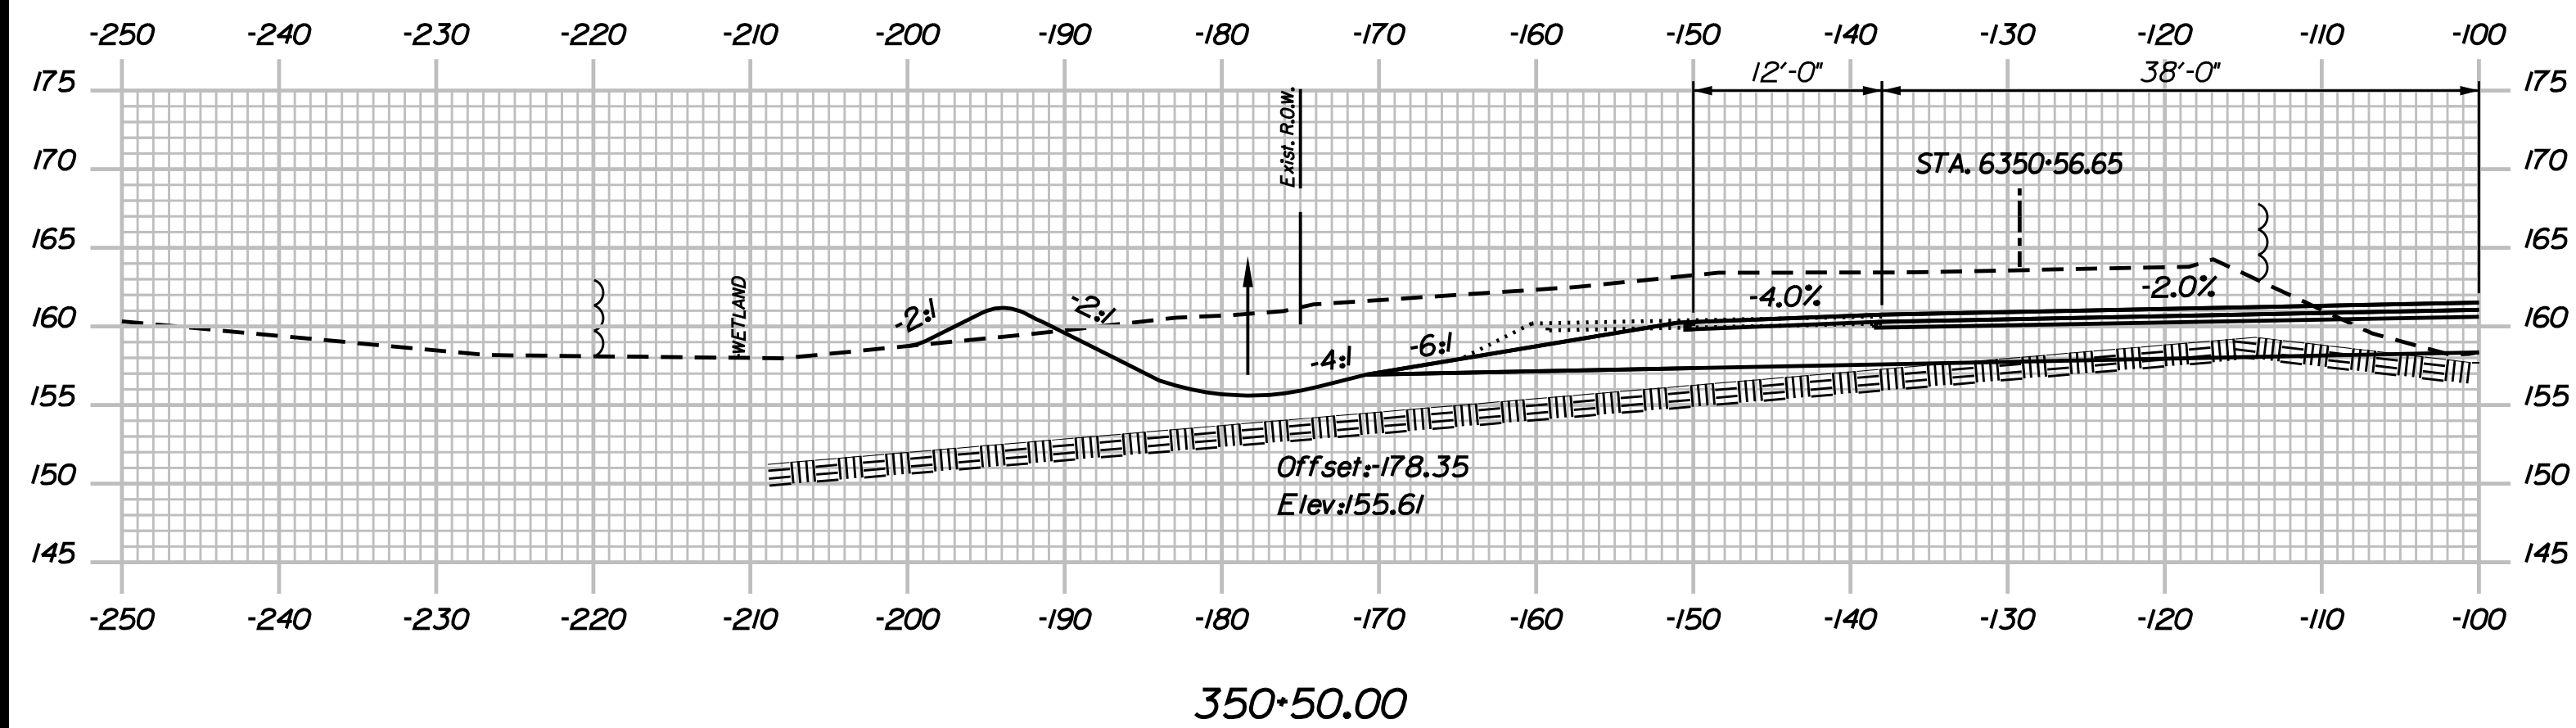

Filename: ...002596371\sect13_195.dgn

Scale:

No.	Revision	By	Date

Designed by:

JACOBS

CONSULTANT PROJECT MANAGER: T. MORIN

	By	Date	Checked	By	Date
Designed	AMS	7-18	Checked	CSM	7-18
Drawn	SMG	7-18	In Charge of	TWM	7-18

JACOBS ENGINEERING GROUP
120 ST. JAMES AVENUE
BOSTON, MA 02216
TEL (617) 242-9222
FAX (617) 242-9824



**THE GOLD STAR
MEMORIAL HIGHWAY**

MTA PROJECT MANAGER: R. NORWOOD

YORK TOLL PLAZA
I-95 CROSS SECTIONS
STA. 350+50

SHEET NUMBER: XS-55
CONTRACT: 2018.20
253 OF 489

Date: 8/28/2018

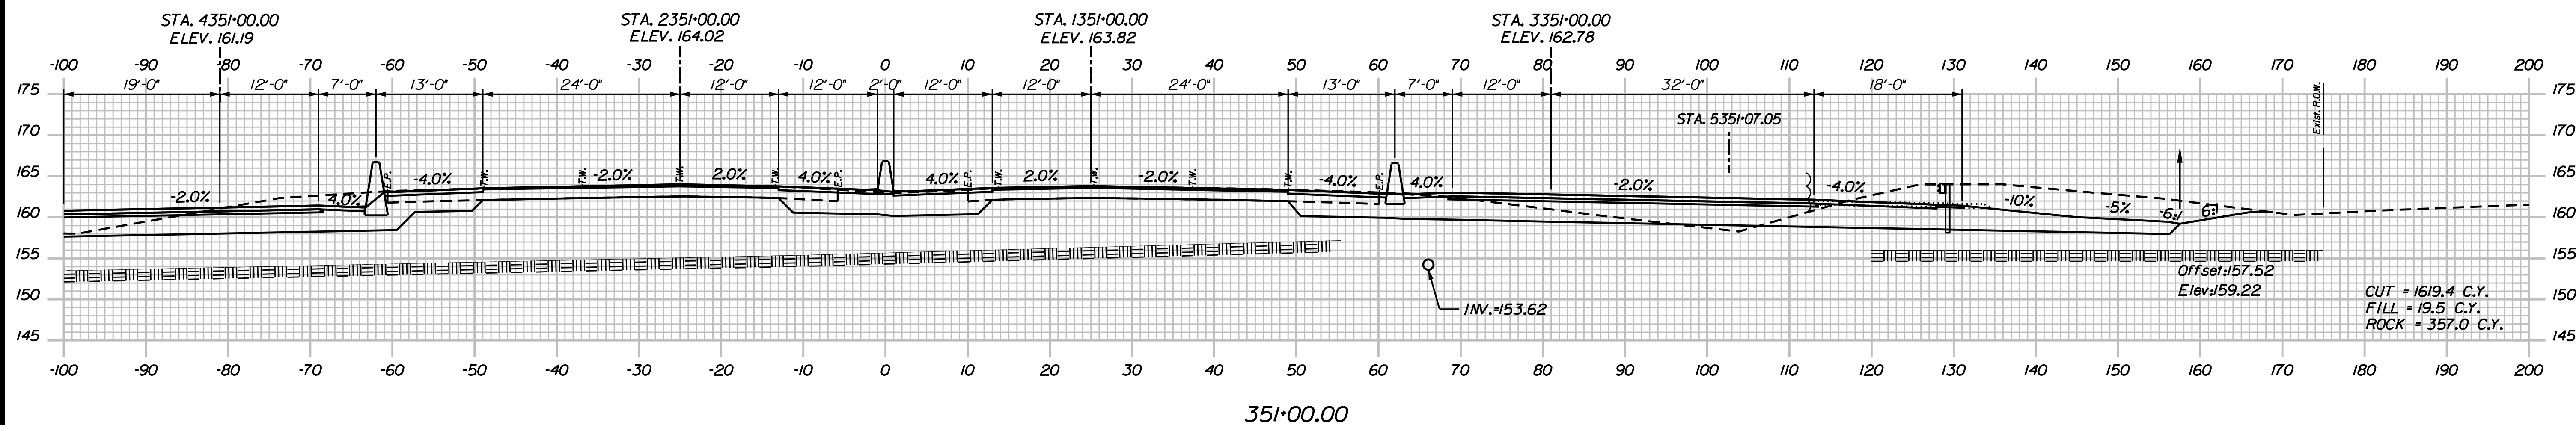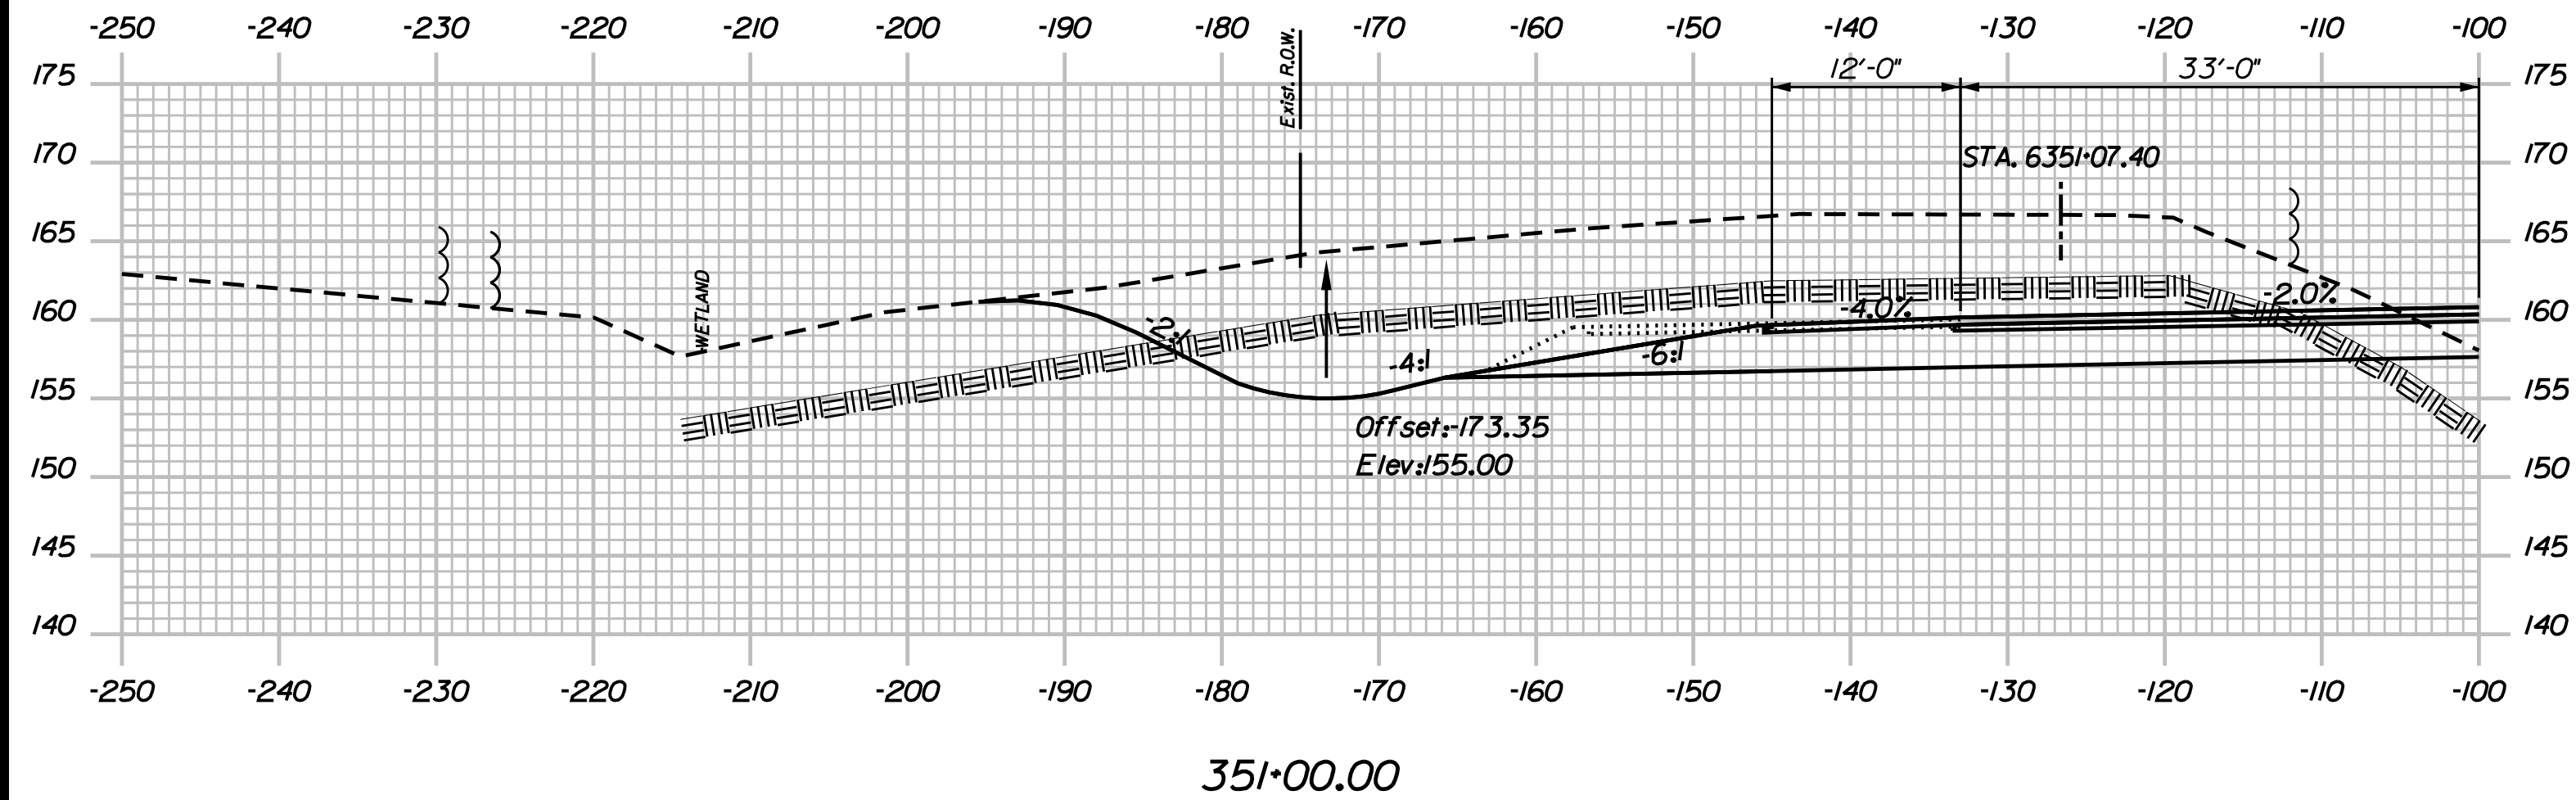

Filename: ...00259637\Xsect13_195.dgn

Scale: Scale of Feet

No.	Revision	By	Date

Designed by:

JACOBS

CONSULTANT PROJECT MANAGER: T. MORIN

	By	Date		By	Date
Designed	AMS	7-18	Checked	CSM	7-18
Drawn	SMG	7-18	In Charge of	TWM	7-18

JACOBS ENGINEERING GROUP
 120 ST. JAMES AVENUE
 BOSTON, MA 02216
 TEL (617) 242-9222
 FAX (617) 242-9824



THE GOLD STAR MEMORIAL HIGHWAY

MTA PROJECT MANAGER: R. NORWOOD

YORK TOLL PLAZA
 I-95 CROSS SECTIONS
 STA. 351+00

SHEET NUMBER: XS-56
 CONTRACT: 2018.20
 254 OF 489

Date: 8/28/2018

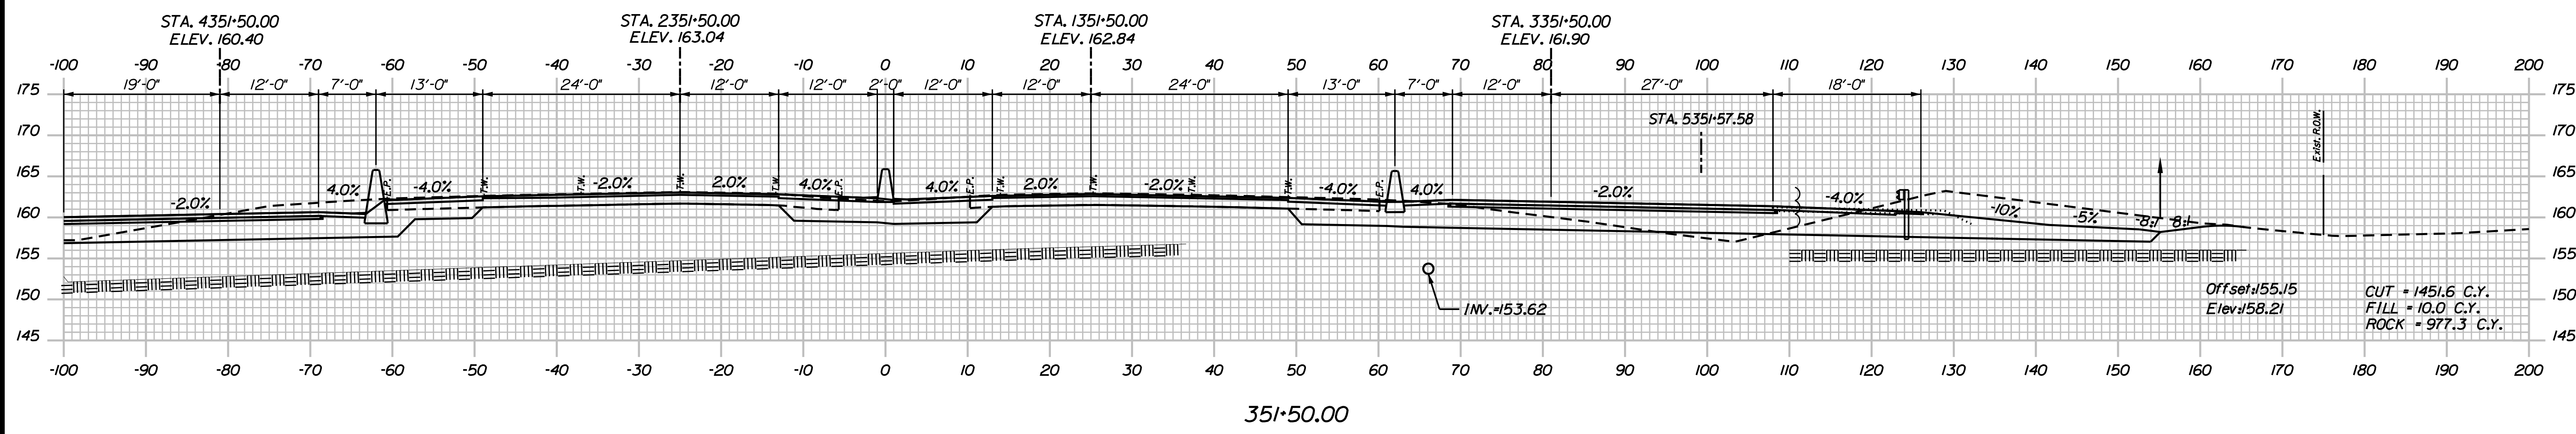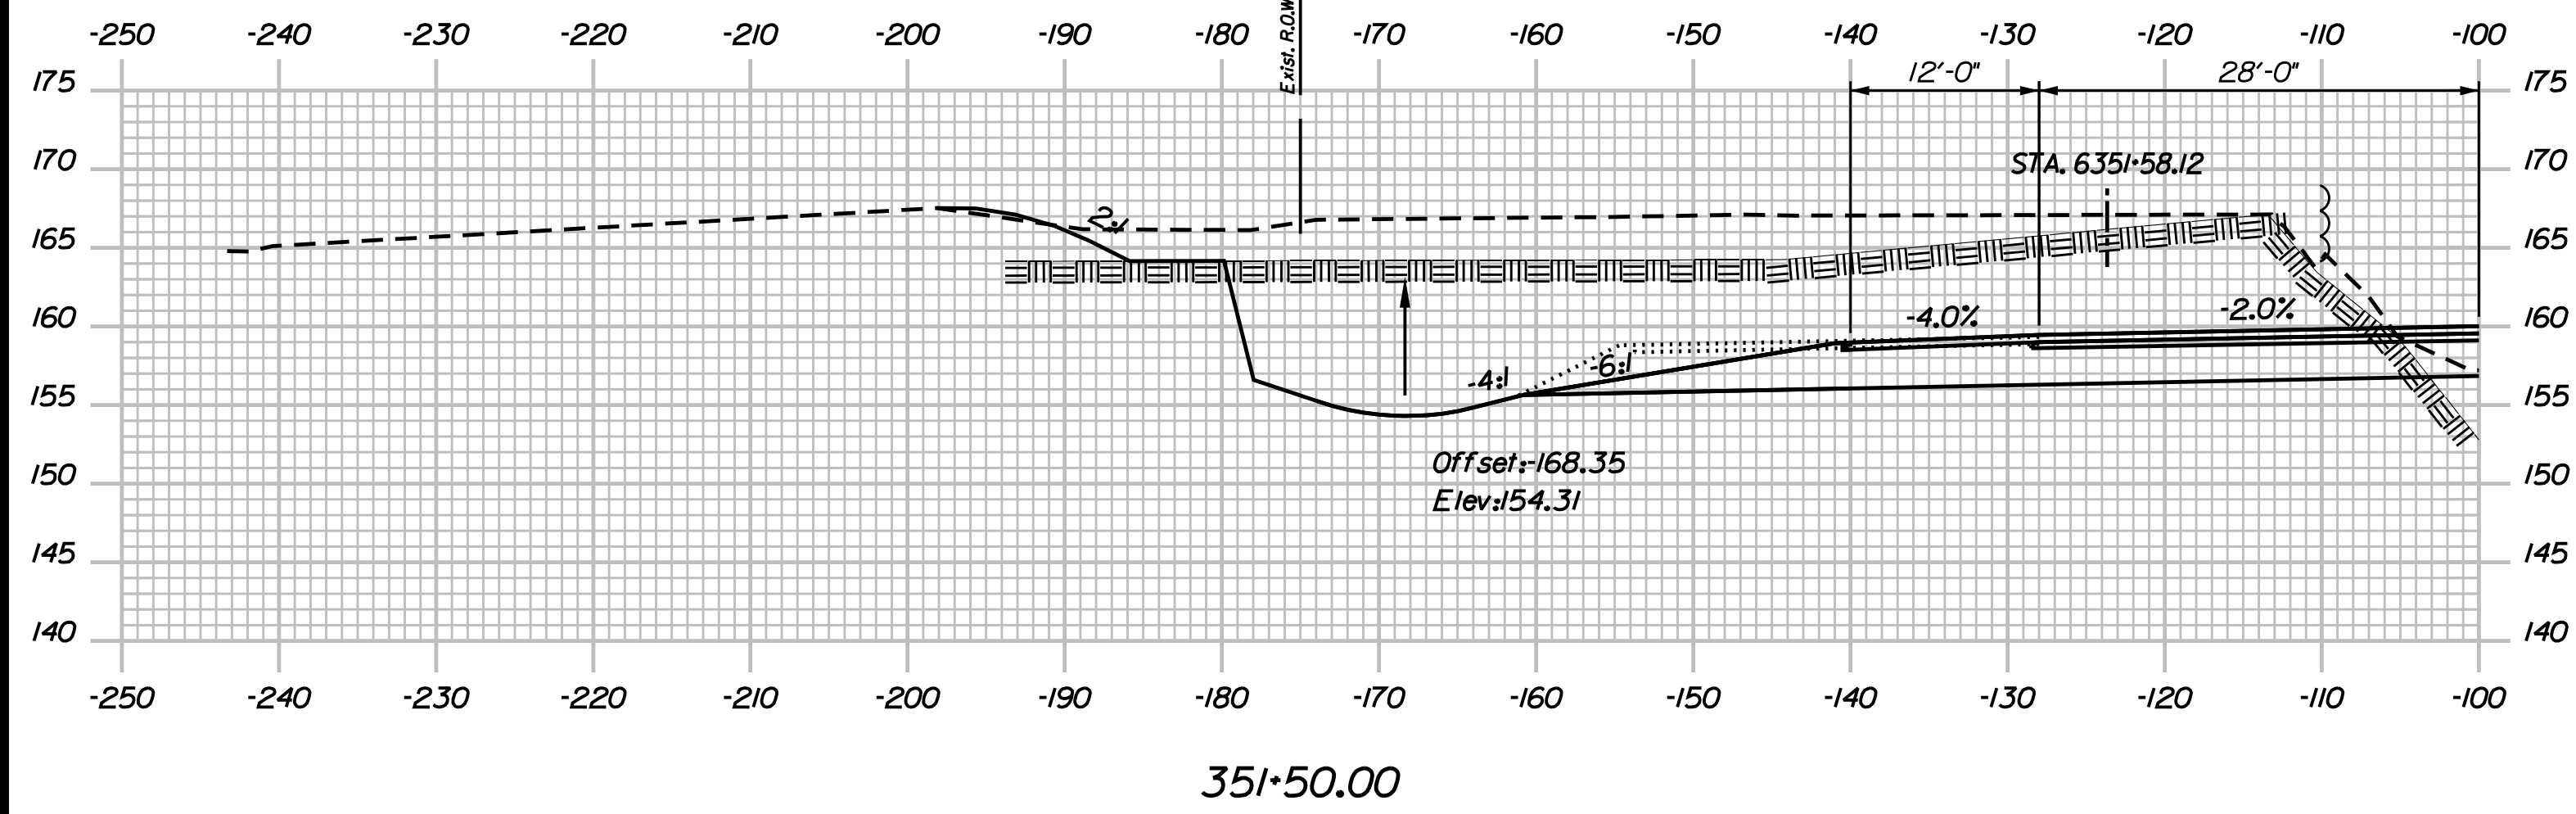

Filename: ...00259637\Xsect13_195.dgn

Scale: Scale of Feet

No.	Revision	By	Date

Designed by:

JACOBS

CONSULTANT PROJECT MANAGER: T. MORIN

	By	Date		By	Date
Designed	AMS	7-18	Checked	CSM	7-18
Drawn	SMG	7-18	In Charge of	TWM	7-18

JACOBS ENGINEERING GROUP
 120 ST. JAMES AVENUE
 BOSTON, MA 02216
 TEL (617) 242-9222
 FAX (617) 242-9824



**THE GOLD STAR
 MEMORIAL HIGHWAY**

MTA PROJECT MANAGER: R. NORWOOD

YORK TOLL PLAZA
 I-95 CROSS SECTIONS
 STA. 351+50

SHEET NUMBER: XS-57
 CONTRACT: 2018.20
 255 OF 489

Date: 8/28/2018

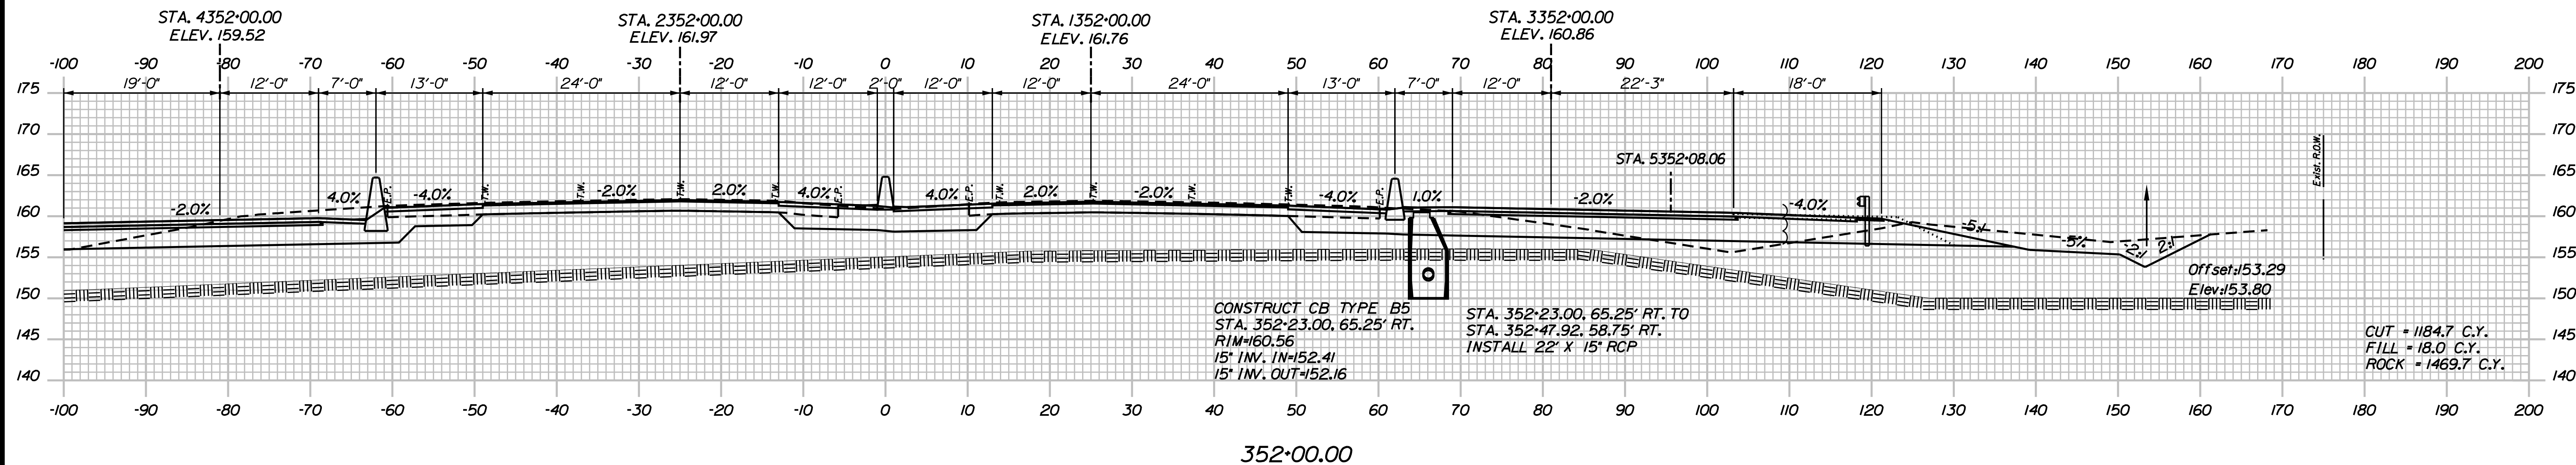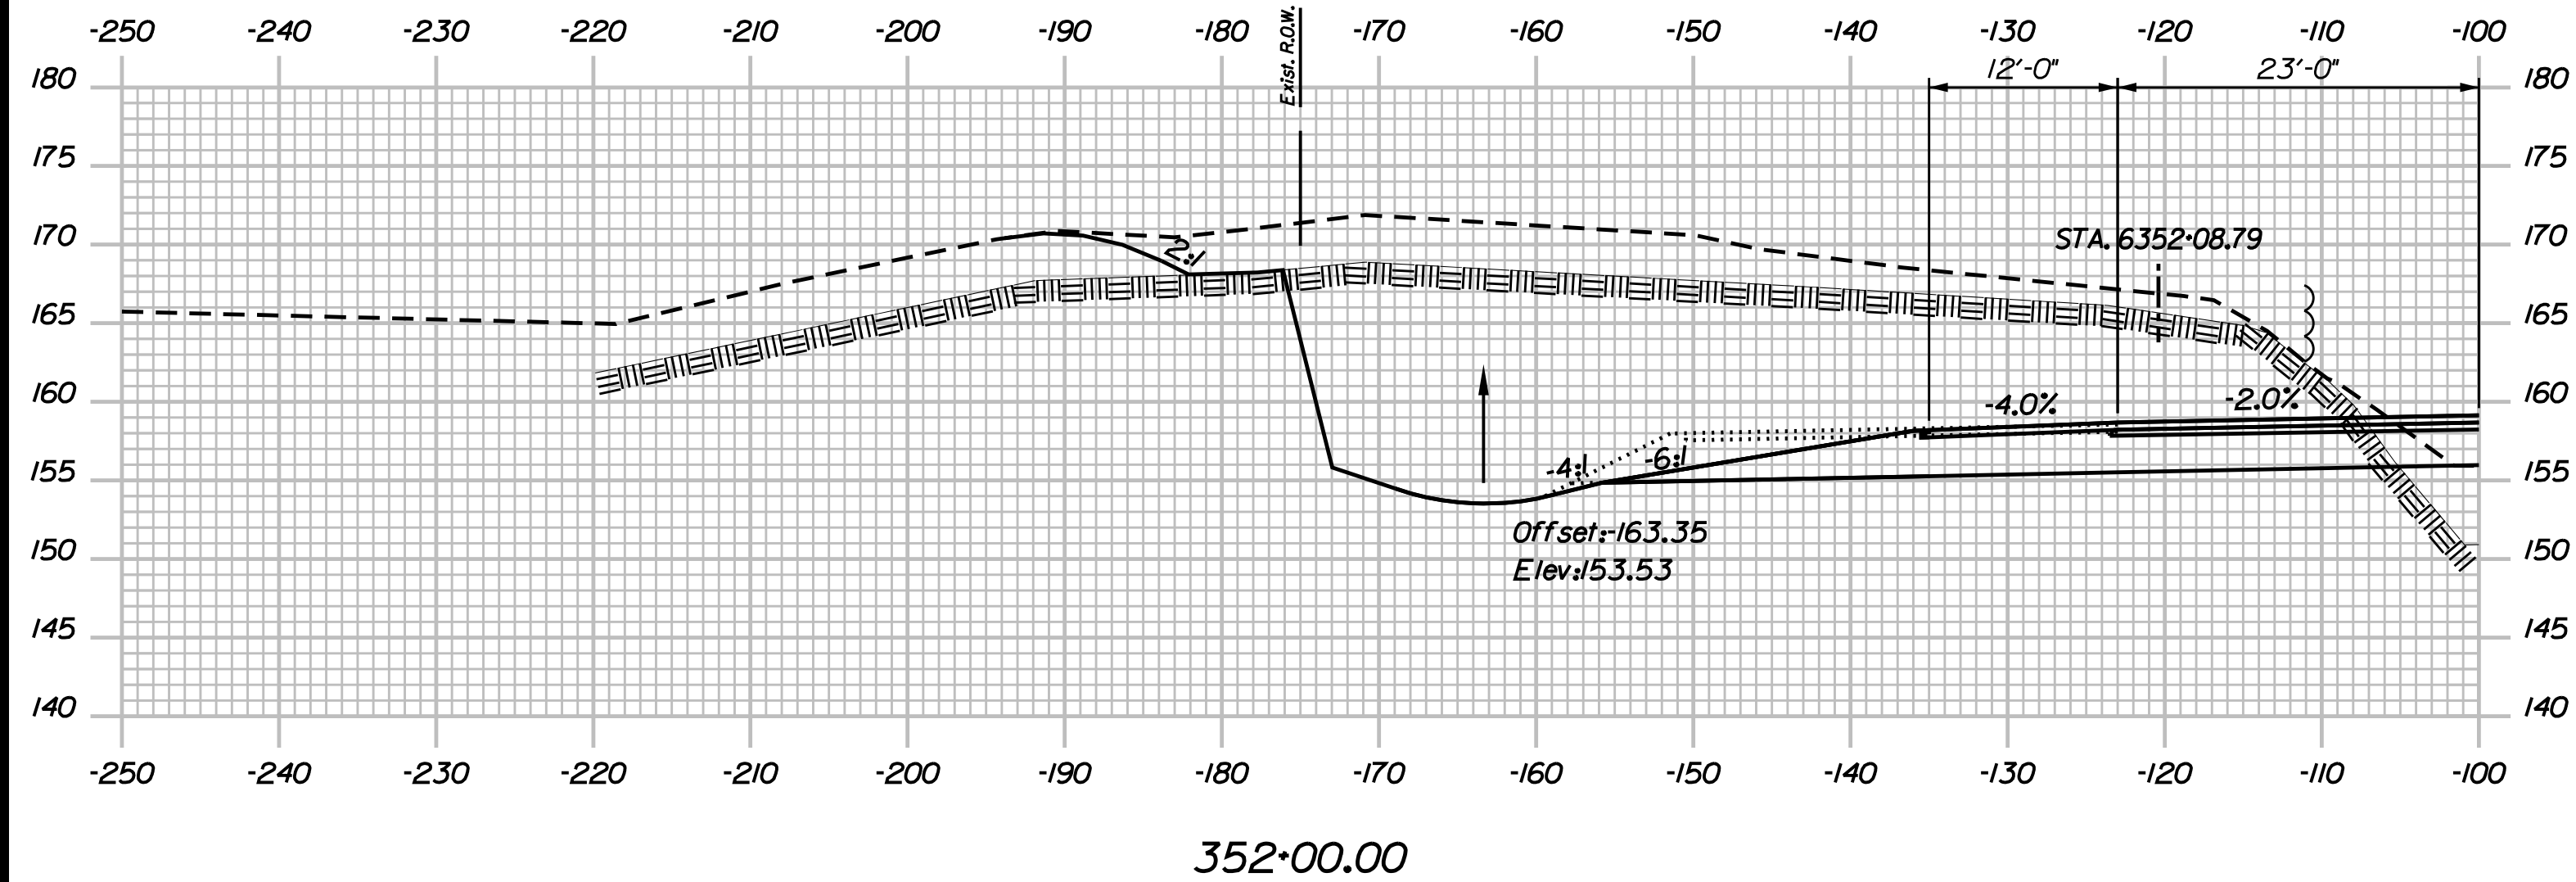

Filename: ...00259637\Xsect13_195.dgn

Scale: Scale of Feet

No.	Revision	By	Date

Designed by:

JACOBS

CONSULTANT PROJECT MANAGER: T. MORIN

	By	Date		By	Date
Designed	AMS	7-18	Checked	CSM	7-18
Drawn	SMG	7-18	In Charge of	TWM	7-18

JACOBS ENGINEERING GROUP
 120 ST. JAMES AVENUE
 BOSTON, MA 02216
 TEL (617) 242-9222
 FAX (617) 242-9824



THE GOLD STAR
 MEMORIAL HIGHWAY

MTA PROJECT MANAGER: R. NORWOOD

YORK TOLL PLAZA
 I-95 CROSS SECTIONS
 STA. 352+00

SHEET NUMBER: XS-58
 CONTRACT: 2018.20
 256 OF 489

Date: 8/28/2018

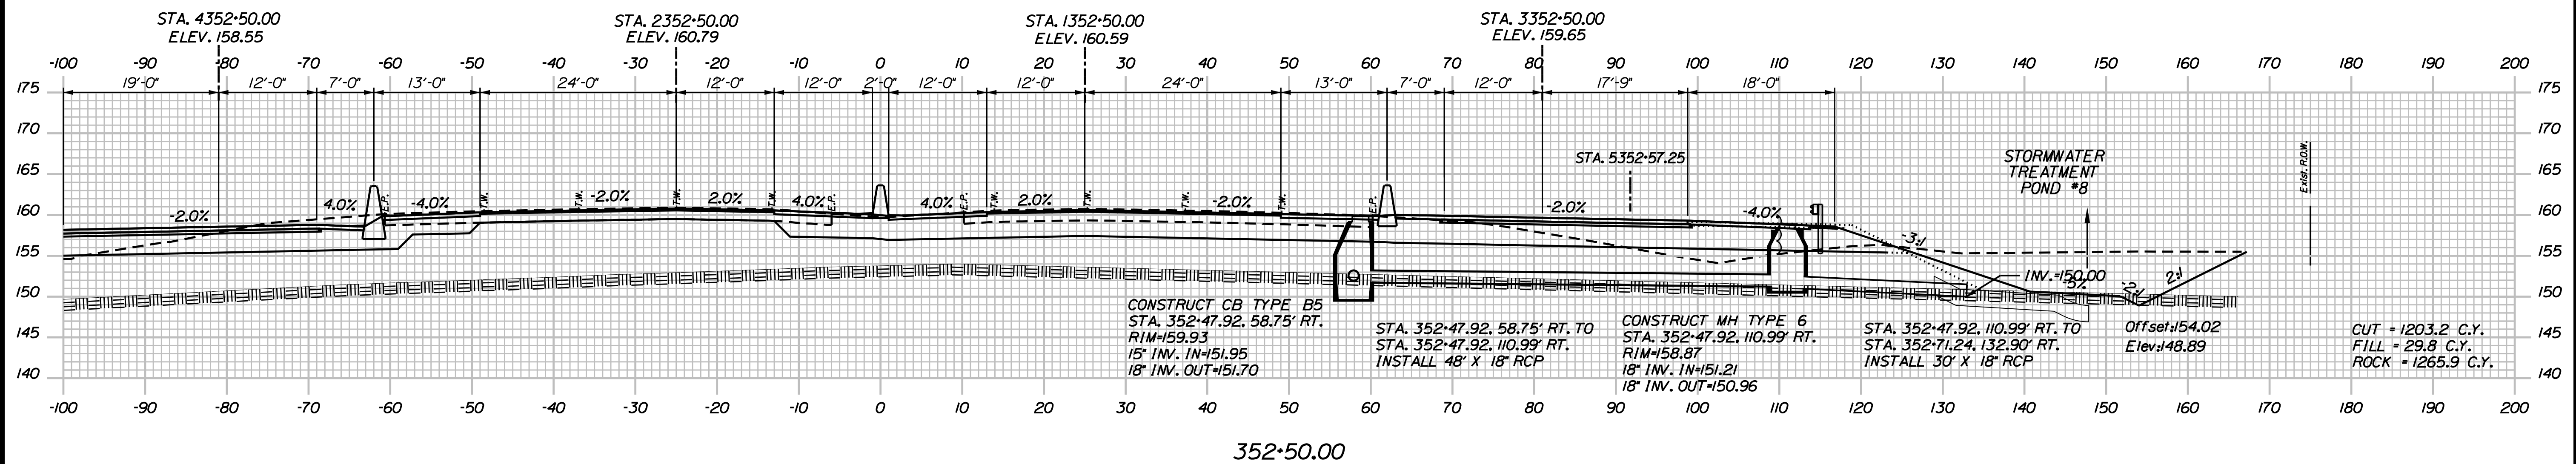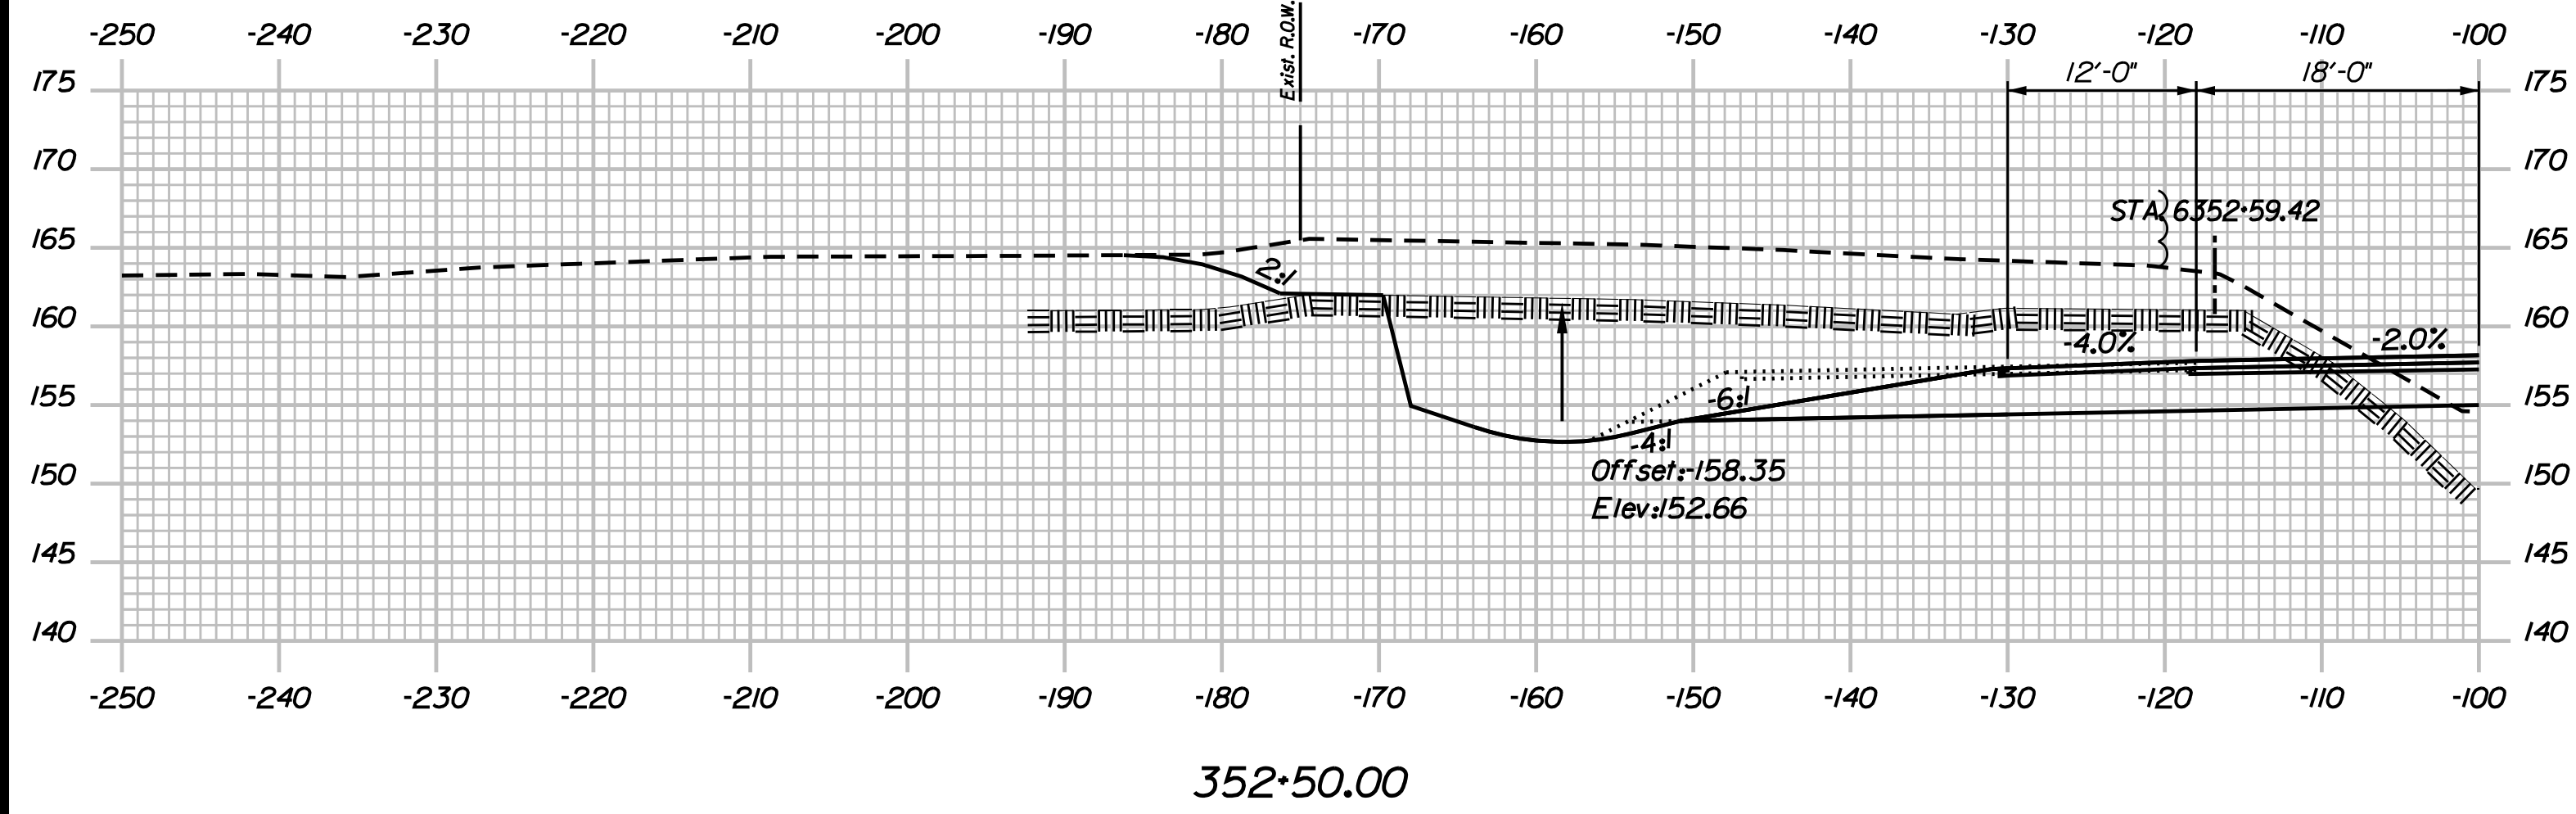

Filename: ...00259637\Xsect13_195.dgn

Scale:

No.	Revision	By	Date

Designed by:

JACOBS

CONSULTANT PROJECT MANAGER: T. MORIN

	By	Date		By	Date
Designed	AMS	7-18	Checked	CSM	7-18
Drawn	SMG	7-18	In Charge of	TWM	7-18

JACOBS ENGINEERING GROUP
 120 ST. JAMES AVENUE
 BOSTON, MA 02216
 TEL (617) 242-9222
 FAX (617) 242-9824



THE GOLD STAR MEMORIAL HIGHWAY

MTA PROJECT MANAGER: R. NORWOOD

YORK TOLL PLAZA
 I-95 CROSS SECTIONS
 STA. 352+50

SHEET NUMBER: XS-59
 CONTRACT: 2018.20
 257 OF 489

Date: 8/28/2018

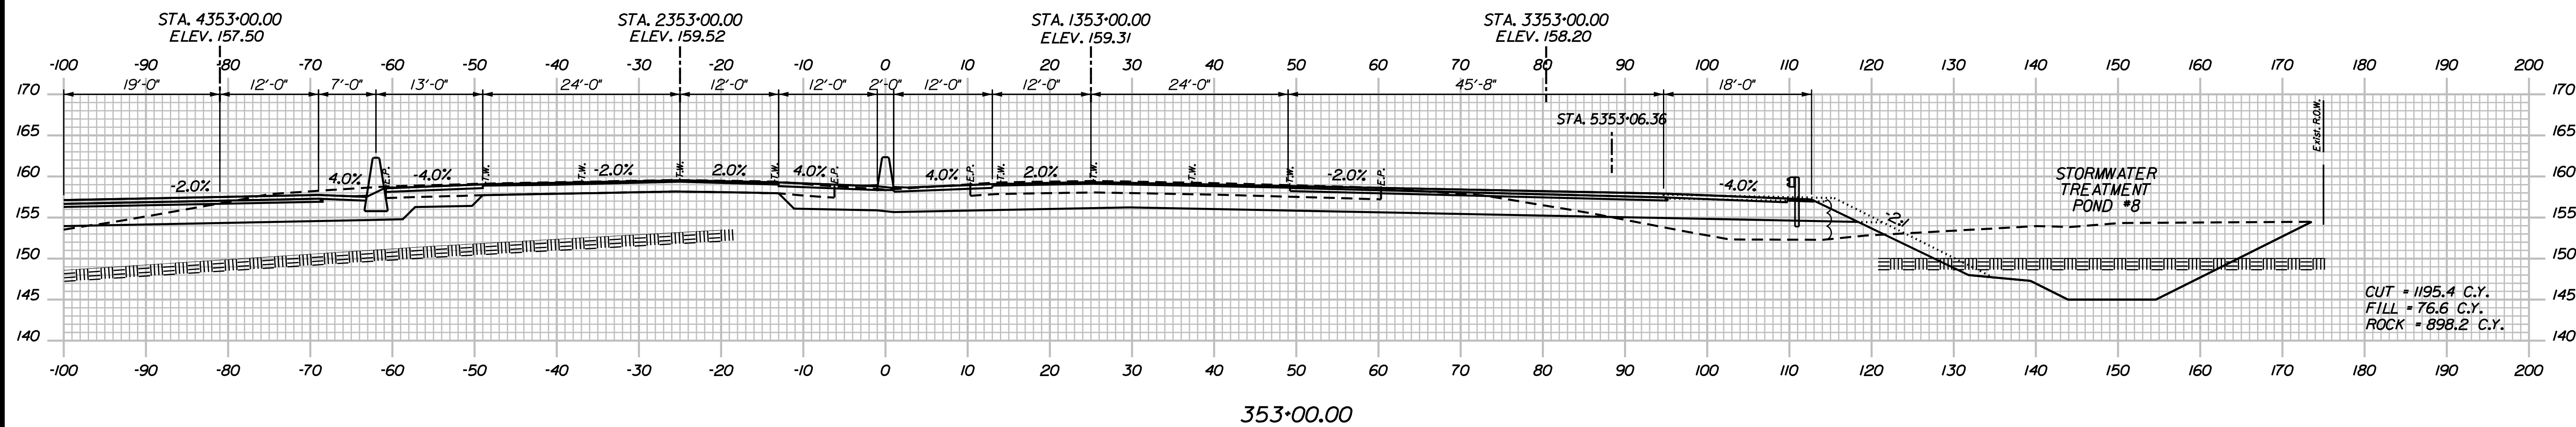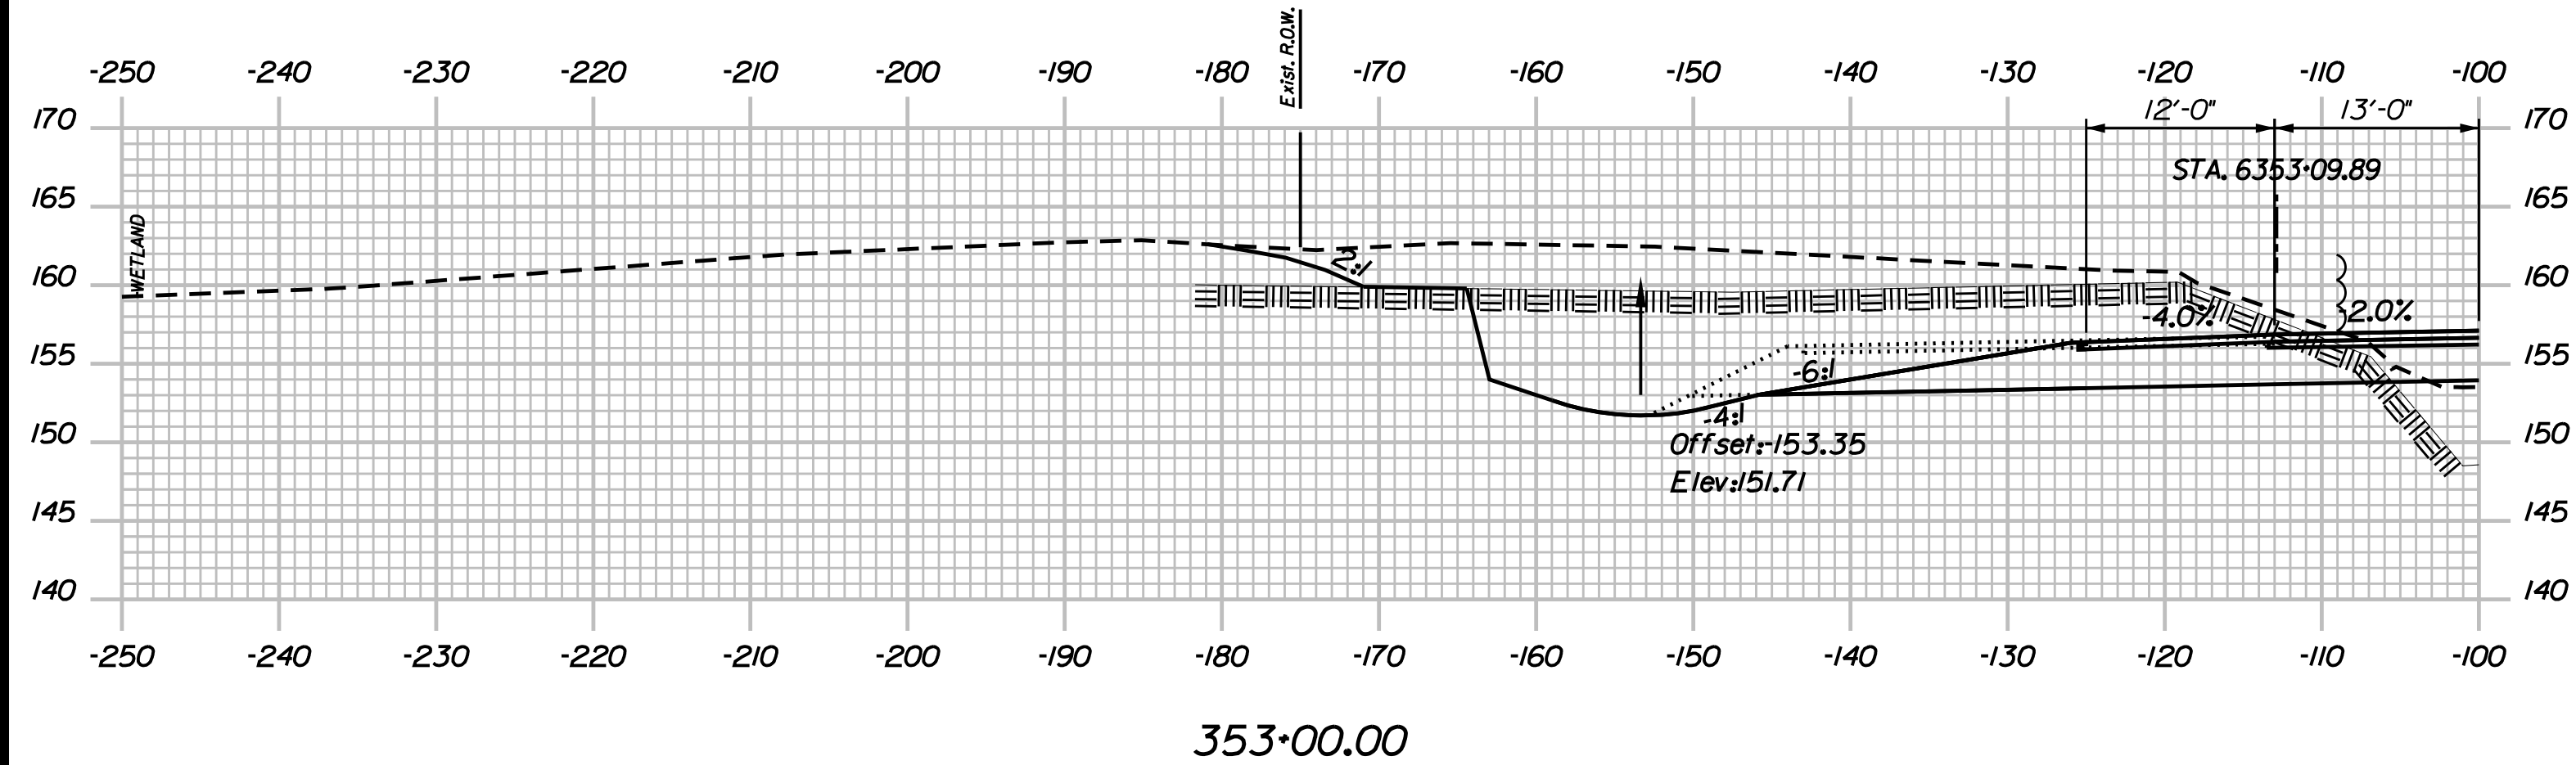

Filename: ...00259637\Xsect13_195.dgn

Scale: Scale of Feet

No.	Revision	By	Date

Designed by:

JACOBS

CONSULTANT PROJECT MANAGER: T. MORIN

	By	Date		By	Date
Designed	AMS	7-18	Checked	CSM	7-18
Drawn	SMG	7-18	In Charge of	TWM	7-18

JACOBS ENGINEERING GROUP
 120 ST. JAMES AVENUE
 BOSTON, MA 02216
 TEL (617) 242-9222
 FAX (617) 242-9824

THE GOLD STAR MEMORIAL HIGHWAY



MTA PROJECT MANAGER: R. NORWOOD

YORK TOLL PLAZA
 I-95 CROSS SECTIONS
 STA. 353+00

SHEET NUMBER: XS-60
 258 OF 489

CONTRACT: 2018.20

Date: 8/28/2018

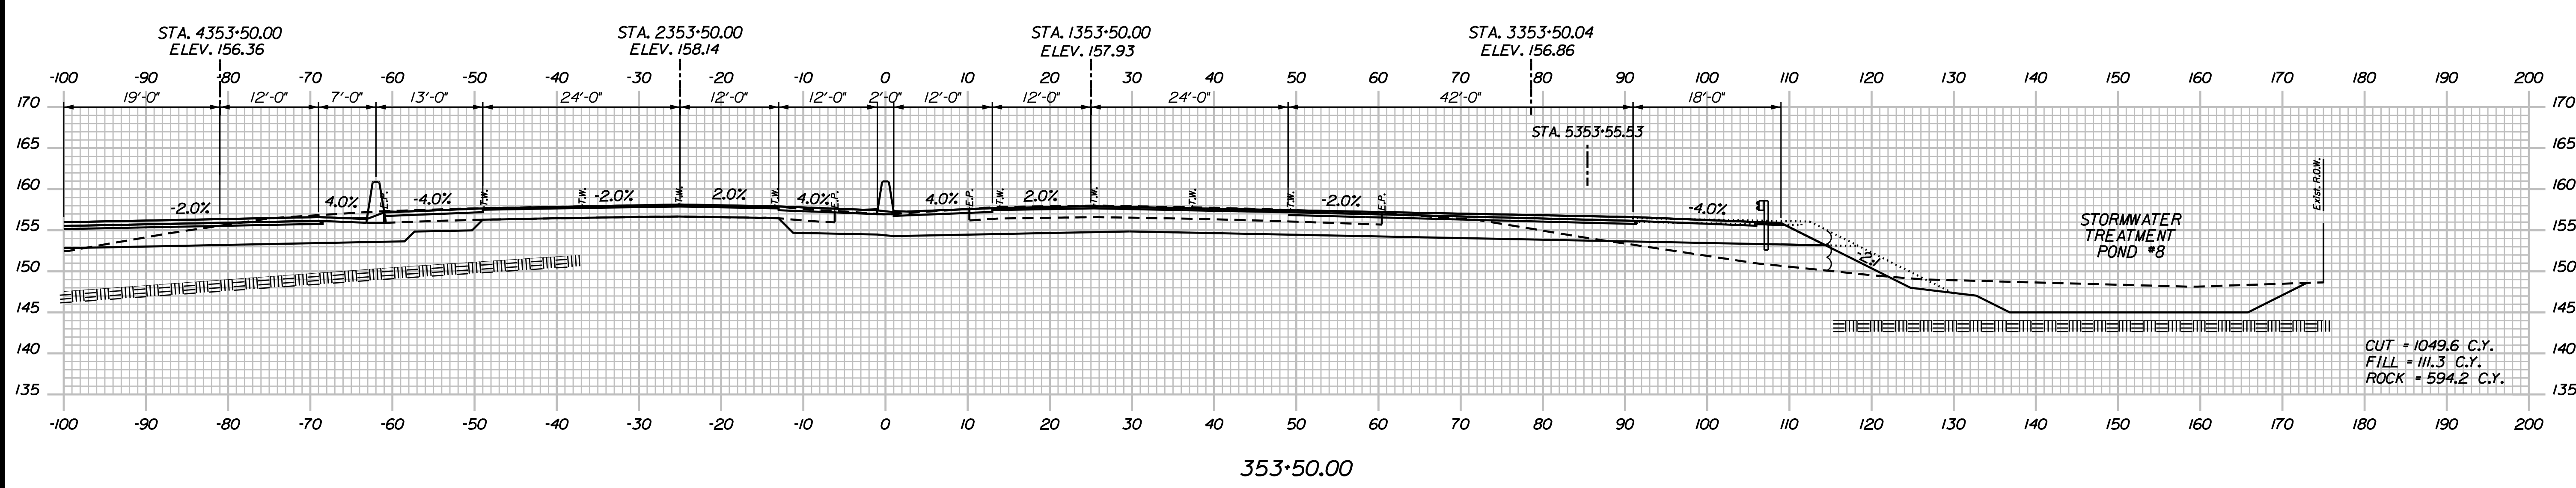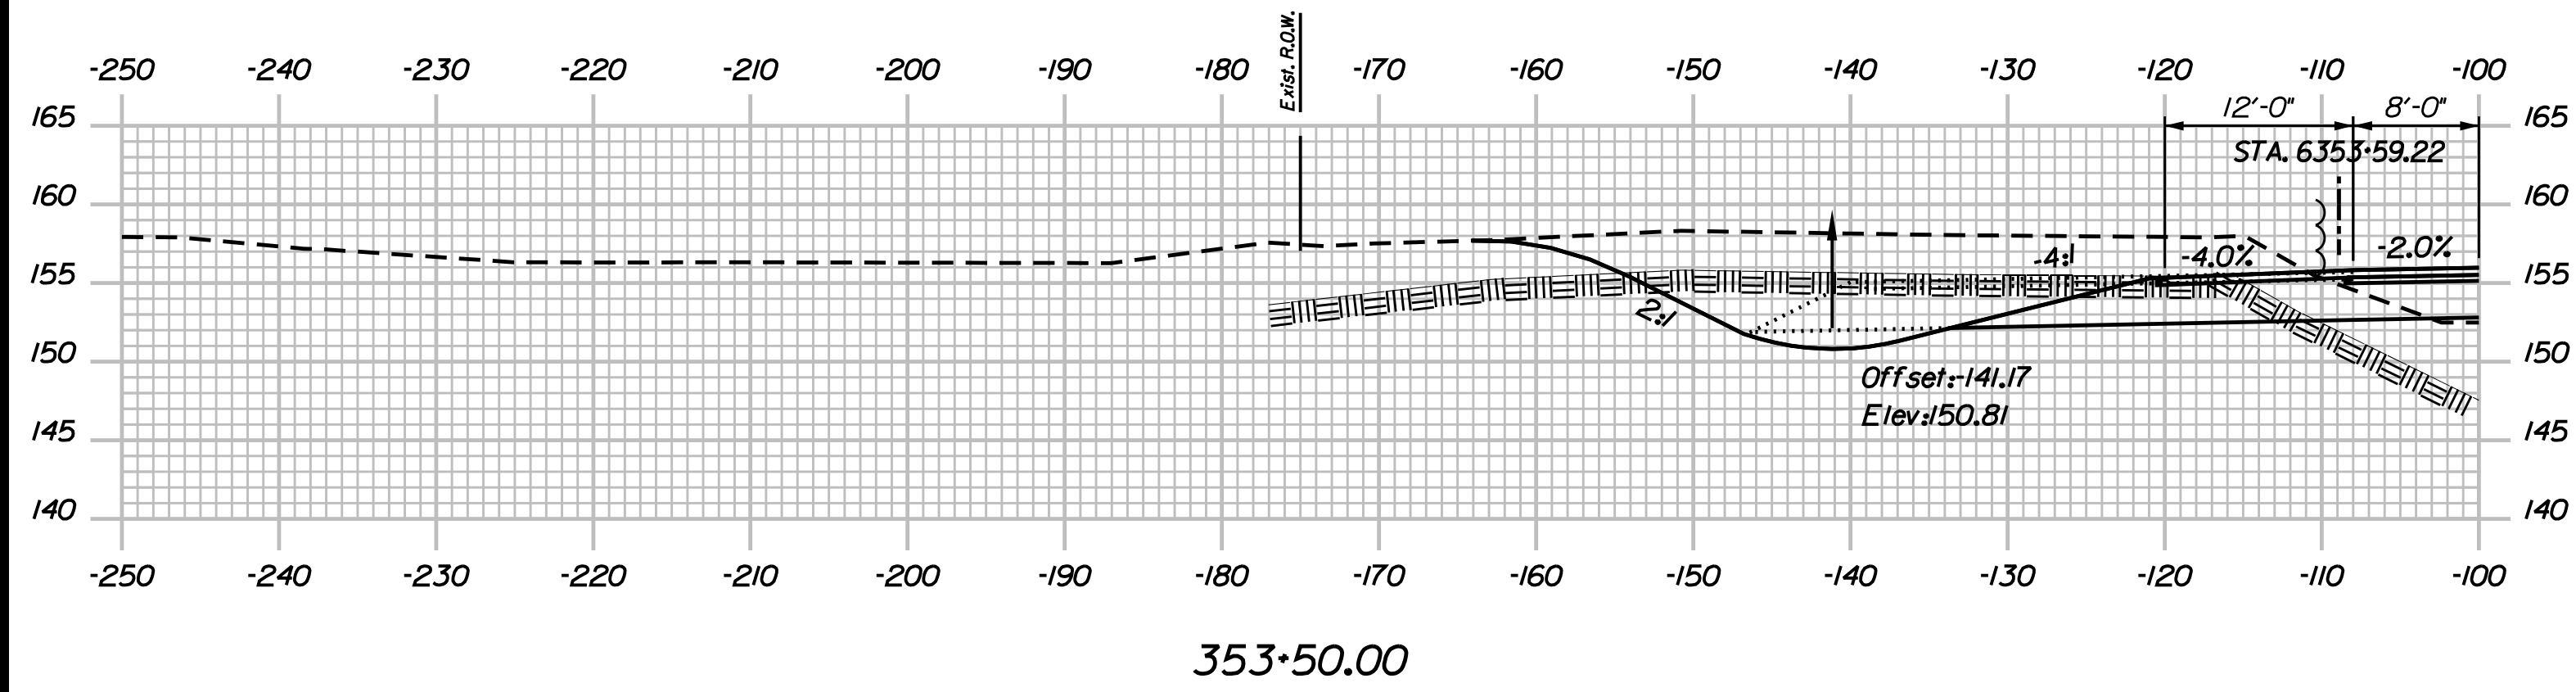

Filename: ...00259637\Xsect13_195.dgn

Scale:

No.	Revision	By	Date

Designed by:

JACOBS

CONSULTANT PROJECT MANAGER: T. MORIN

	By	Date		By	Date
Designed	AMS	7-18	Checked	CSM	7-18
Drawn	SMG	7-18	In Charge of	TWM	7-18

JACOBS ENGINEERING GROUP
 120 ST. JAMES AVENUE
 BOSTON, MA 02216
 TEL (617) 242-9222
 FAX (617) 242-9824



THE GOLD STAR MEMORIAL HIGHWAY

MTA PROJECT MANAGER: R. NORWOOD

YORK TOLL PLAZA
 I-95 CROSS SECTIONS
 STA. 353+50

SHEET NUMBER: XS-61
 CONTRACT: 2018.20
 259 OF 489

Date: 8/28/2018

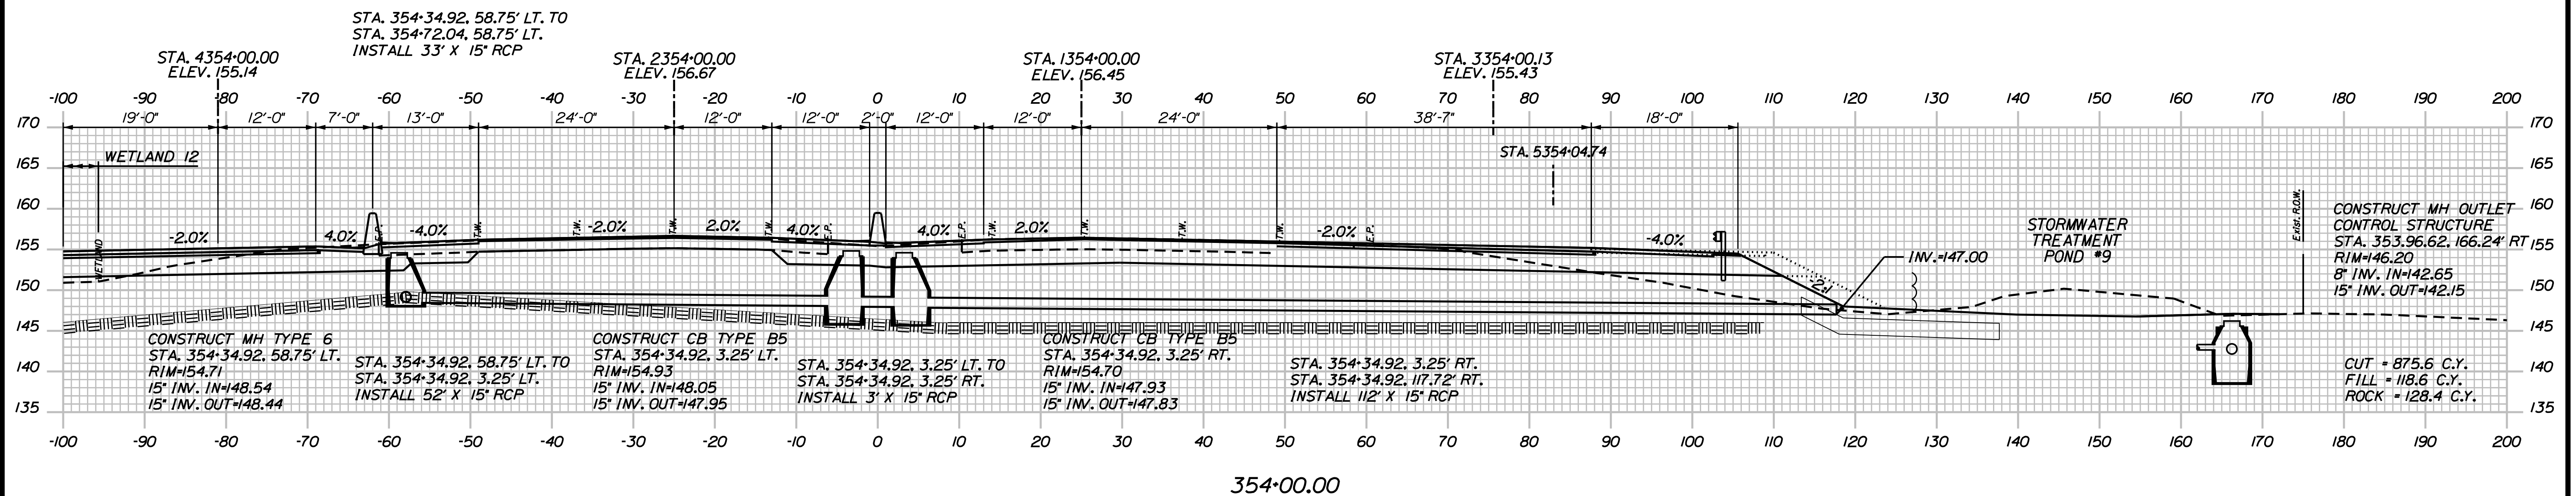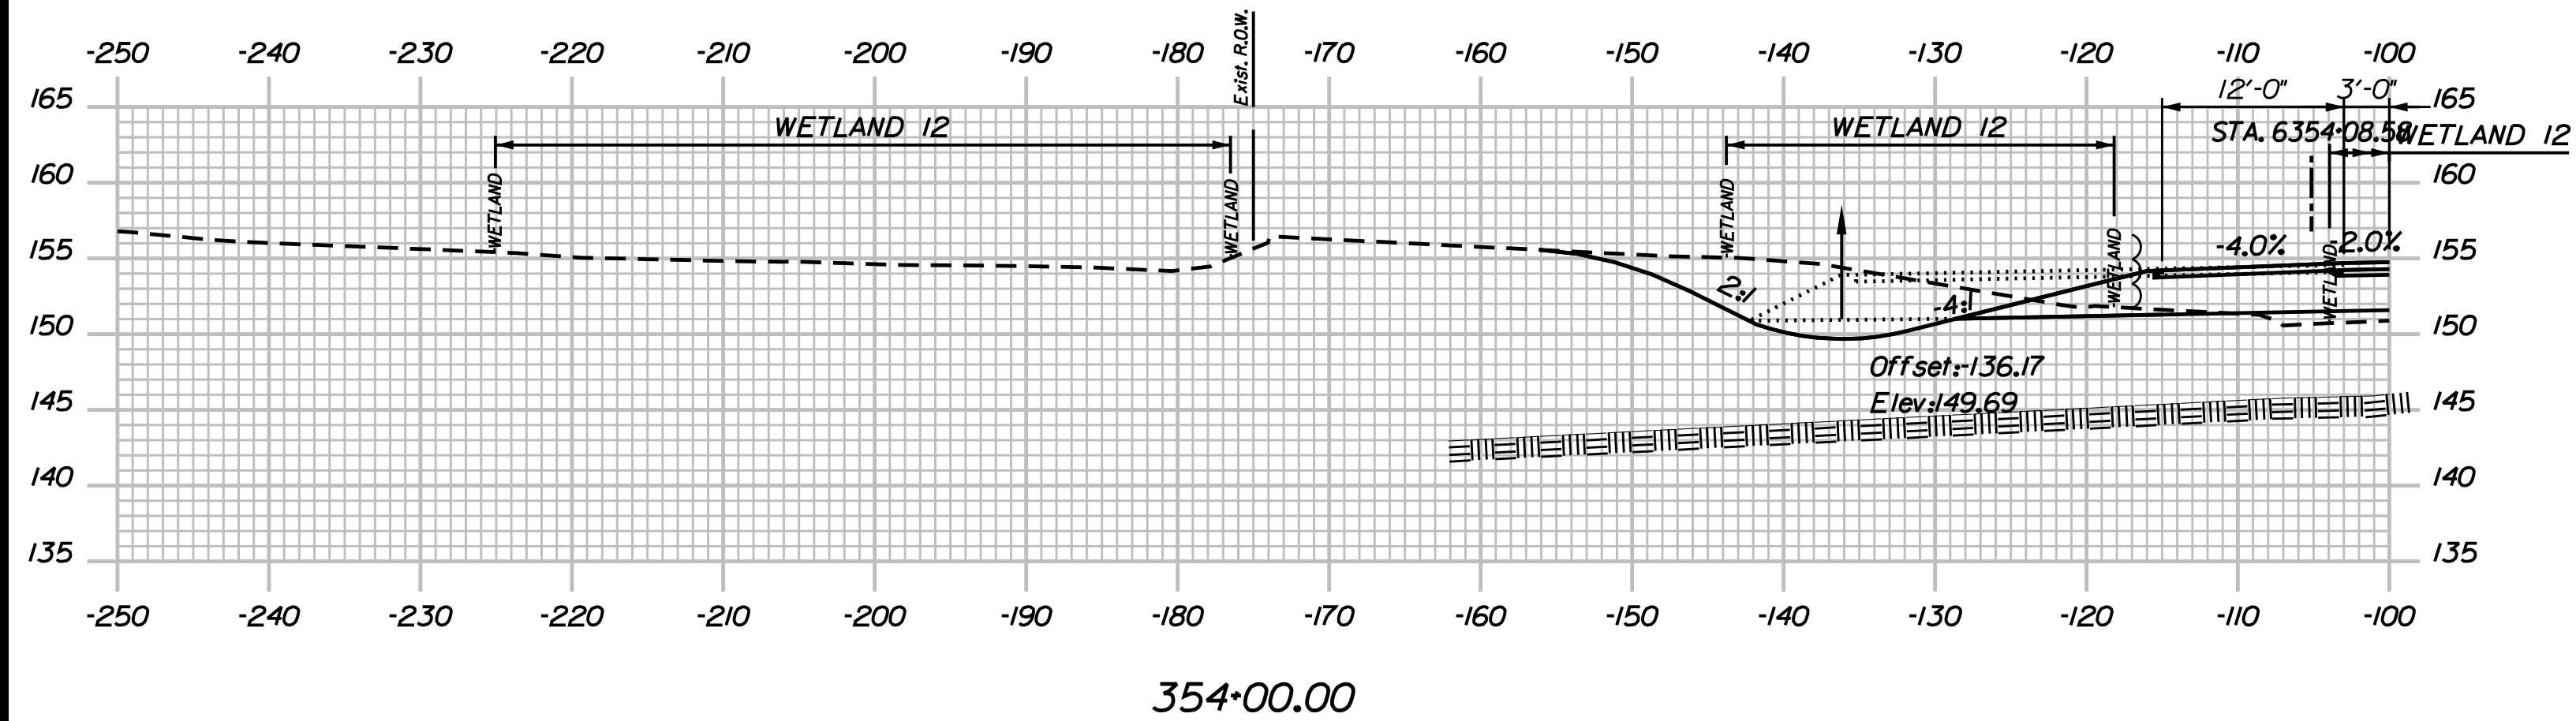

Filename: ...00259637\Xsect13_195.dgn

Scale:

No.	Revision	By	Date

Designed by:

JACOBS

CONSULTANT PROJECT MANAGER: T. MORIN

	By	Date		By	Date
Designed	AMS	7-18	Checked	CSM	7-18
Drawn	SMG	7-18	In Charge of	TWM	7-18

JACOBS ENGINEERING GROUP
 120 ST. JAMES AVENUE
 BOSTON, MA 02216
 TEL (617) 242-9222
 FAX (617) 242-9824


THE GOLD STAR MEMORIAL HIGHWAY

MTA PROJECT MANAGER: R. NORWOOD


YORK TOLL PLAZA
 I-95 CROSS SECTIONS
 STA. 354+00

SHEET NUMBER: XS-62
 CONTRACT: 2018.20
 260 OF 489

Date: 8/28/2018

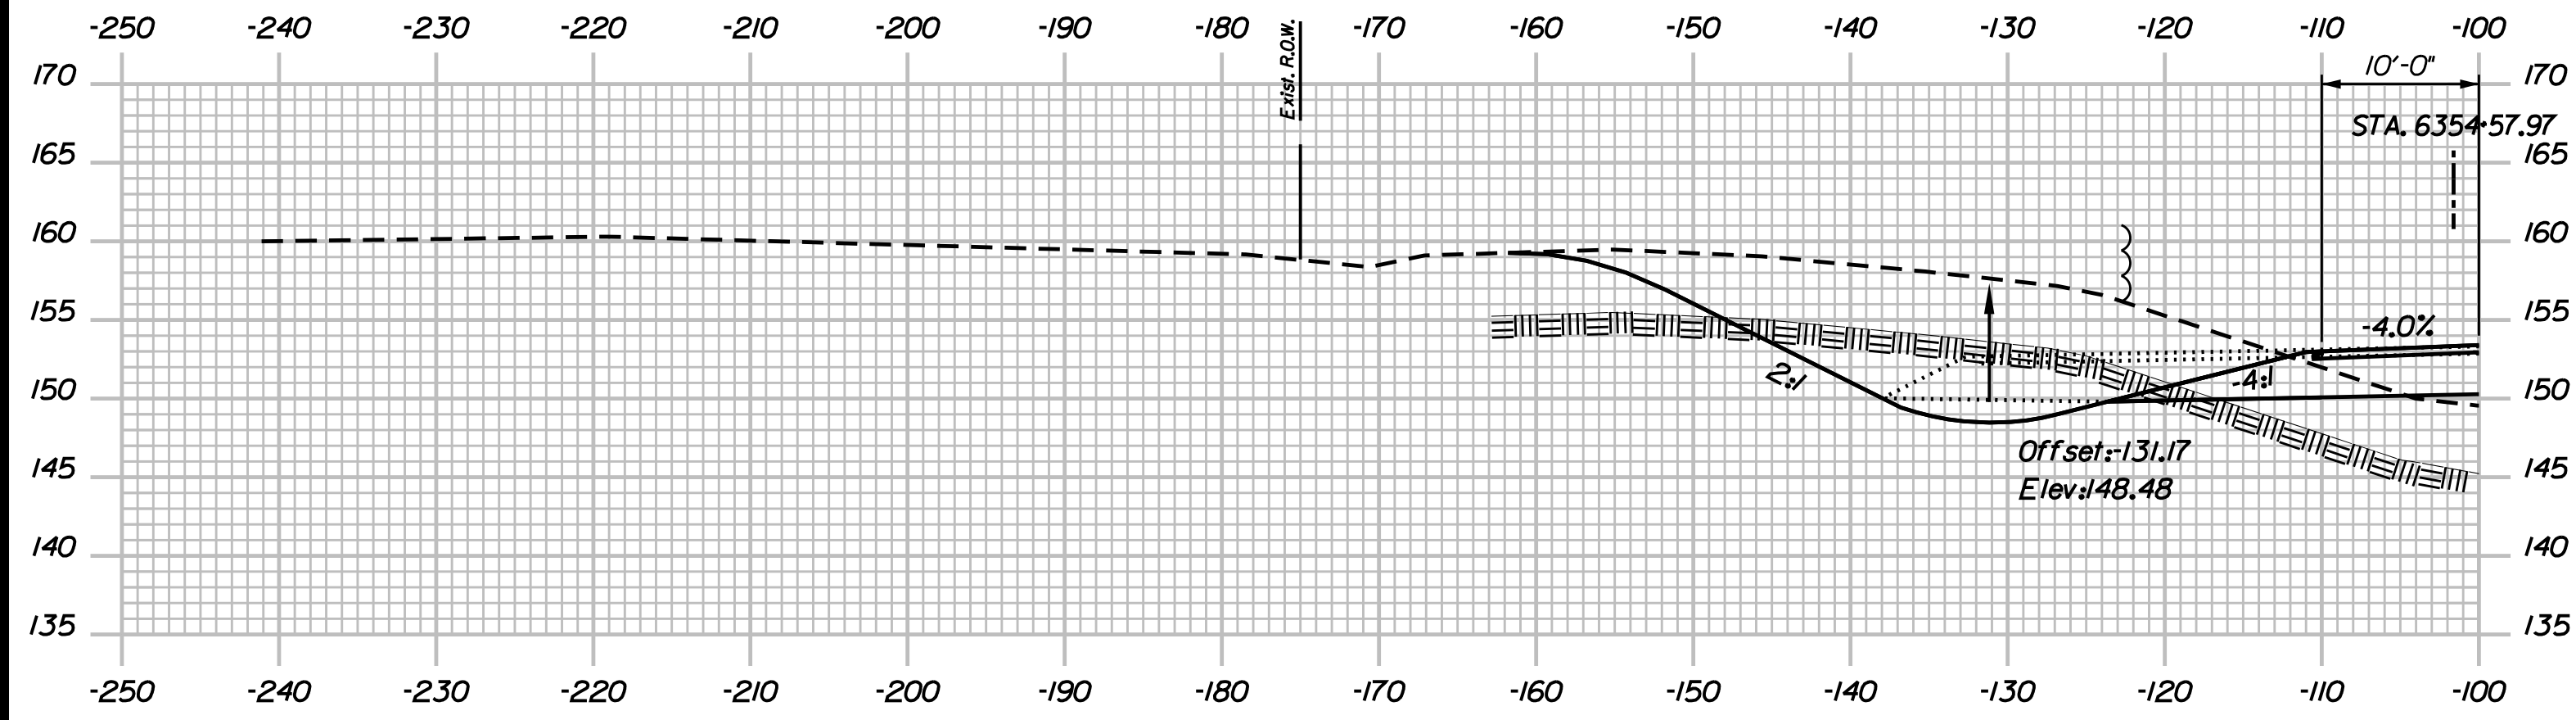

354+50.00

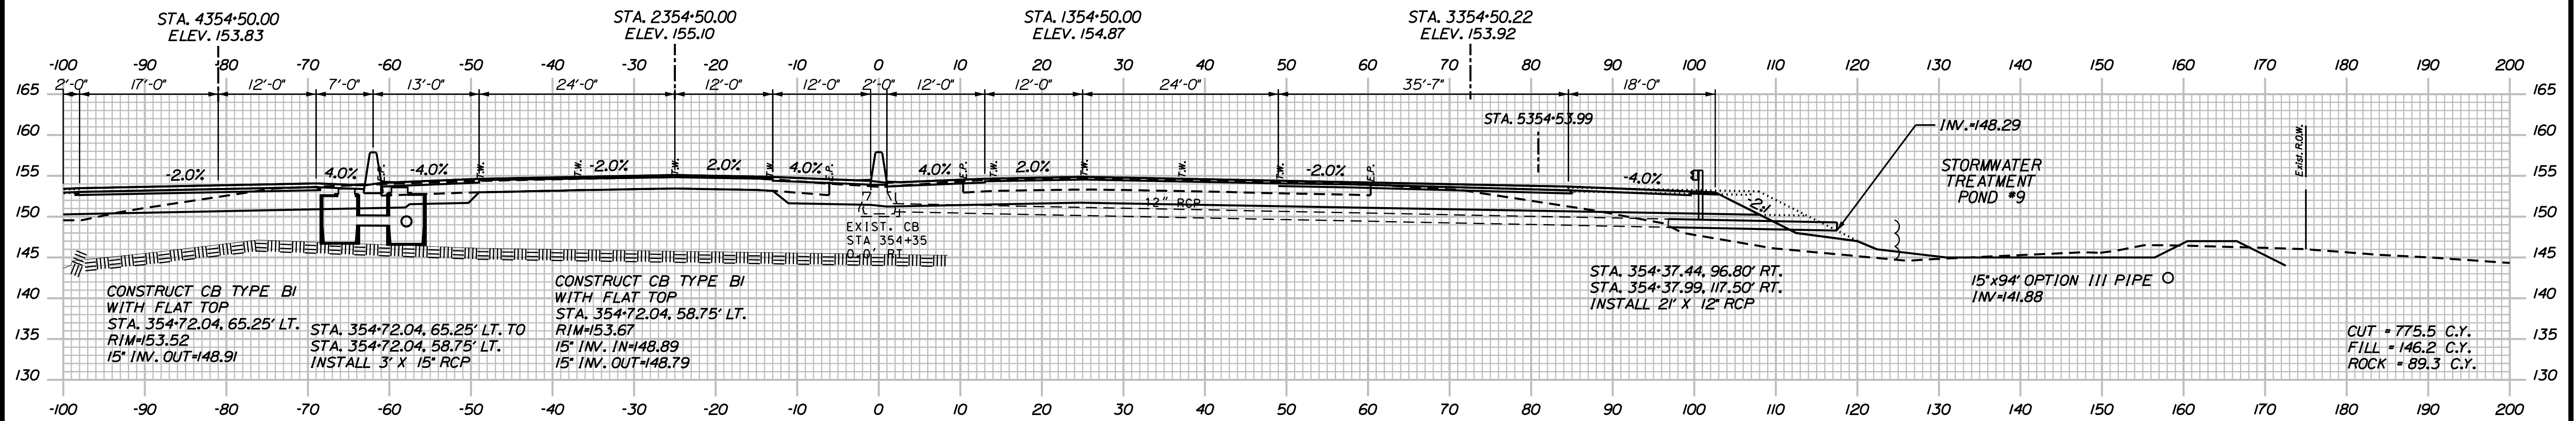

354+50.00

Filename: ...0259637\Xsect13_195.dgn

Scale:

No.	Revision	By	Date

Designed by:

JACOBS

CONSULTANT PROJECT MANAGER: T. MORIN

	By	Date		By	Date
Designed	AMS	7-18	Checked	CSM	7-18
Drawn	SMG	7-18	In Charge of	TWM	7-18

JACOBS ENGINEERING GROUP
 120 ST. JAMES AVENUE
 BOSTON, MA 02216
 TEL (617) 242-9222
 FAX (617) 242-9824



THE GOLD STAR MEMORIAL HIGHWAY

MTA PROJECT MANAGER: R. NORWOOD

YORK TOLL PLAZA
 I-95 CROSS SECTIONS
 STA. 354+50

SHEET NUMBER: XS-63
 CONTRACT: 2018.20
 261 OF 489

Date: 8/28/2018

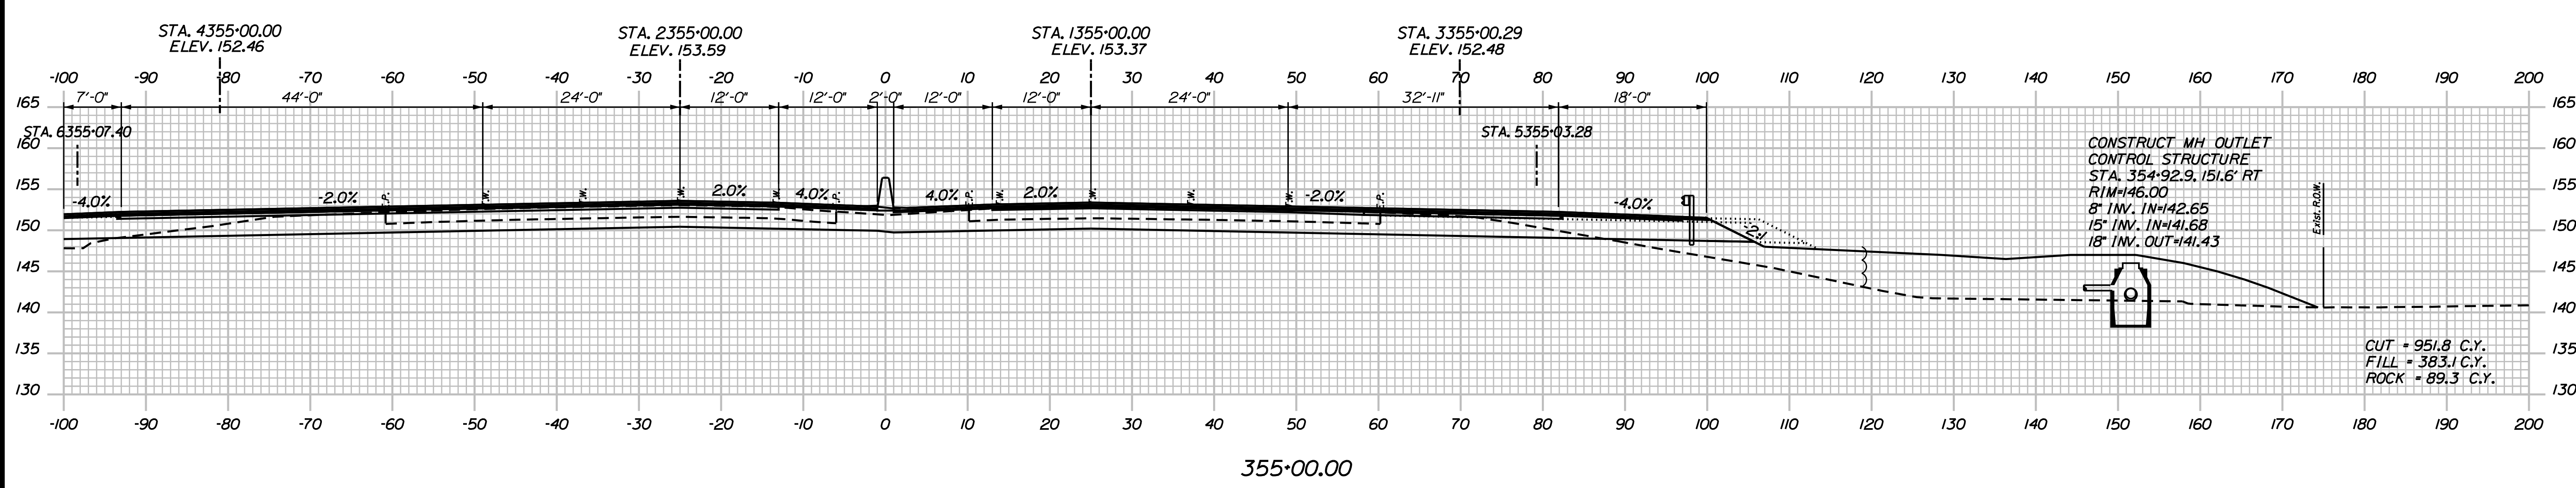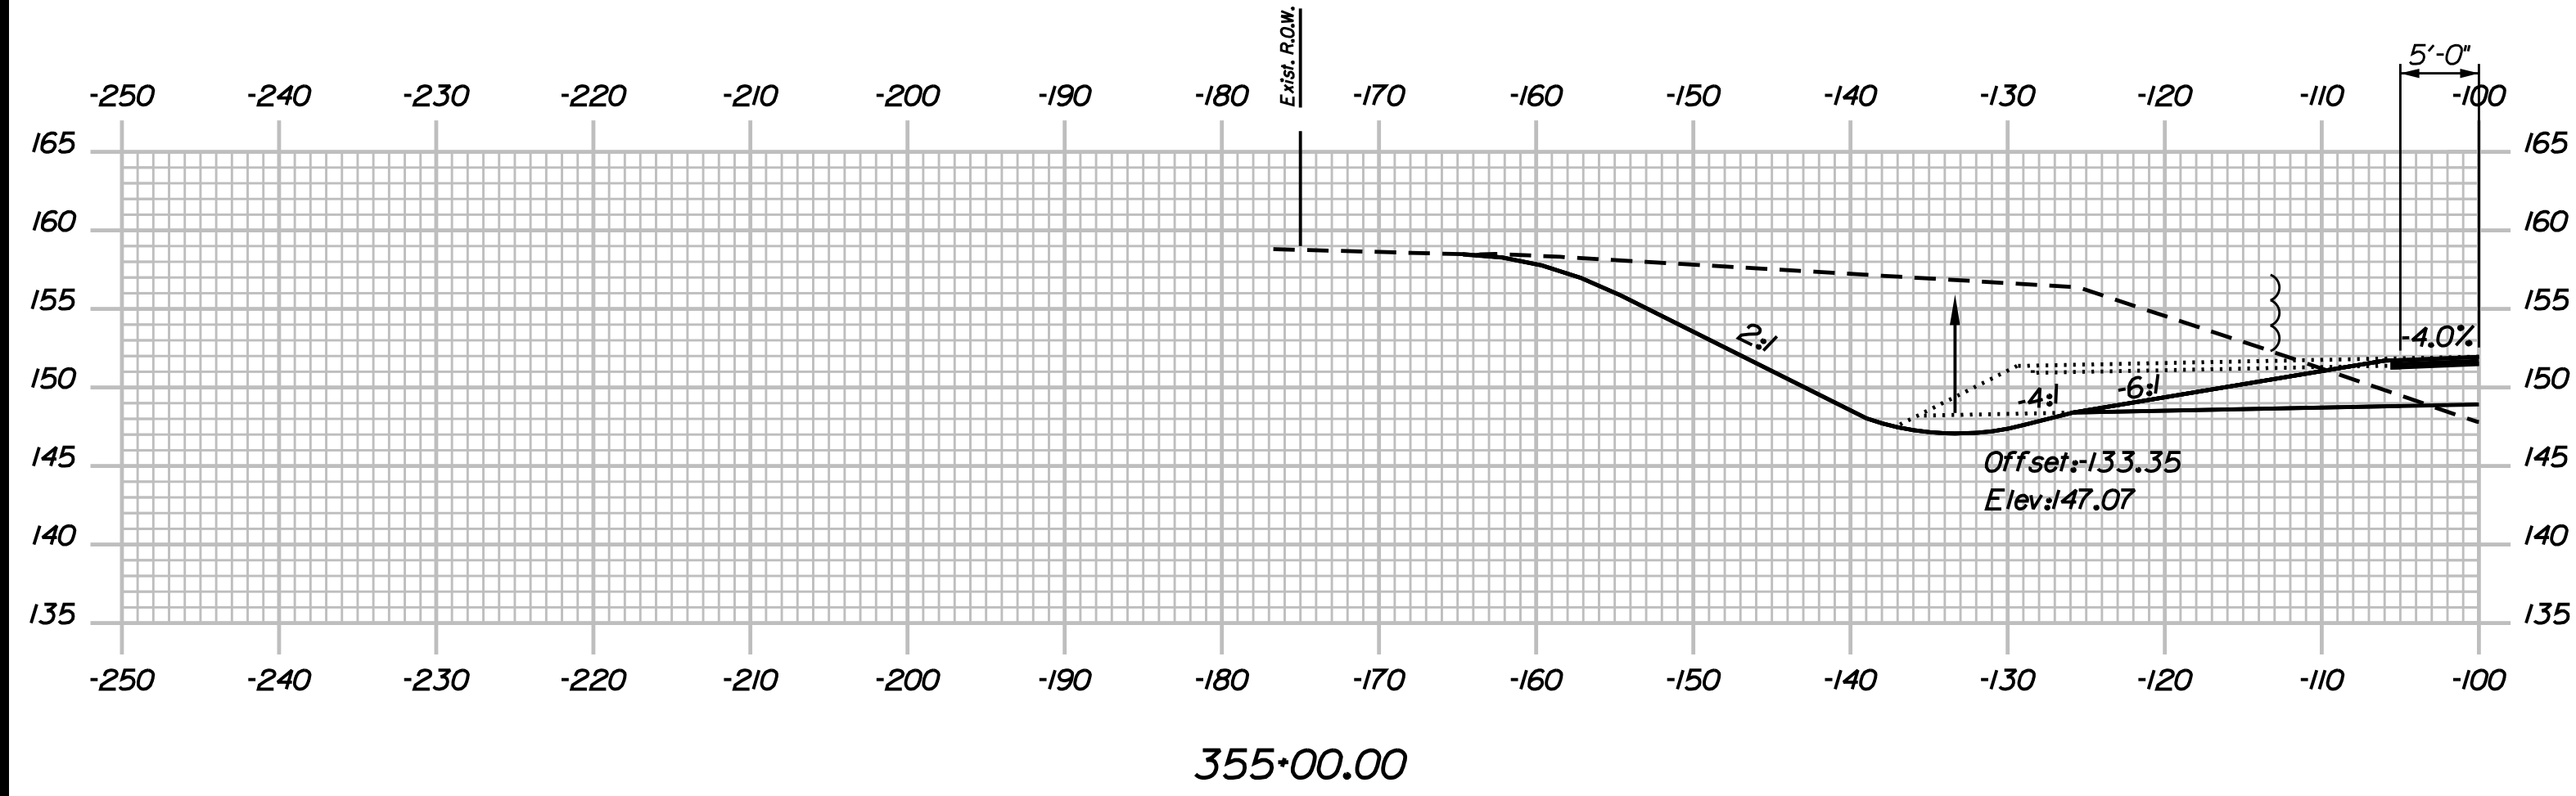

Filename: ... \02596371\Xsect13_195.dgn

Scale:

No.	Revision	By	Date

Designed by:

JACOBS

CONSULTANT PROJECT MANAGER: T. MORIN

	By	Date		By	Date
Designed	AMS	7-18	Checked	CSM	7-18
Drawn	SMG	7-18	In Charge of	TWM	7-18

JACOBS ENGINEERING GROUP
 120 ST. JAMES AVENUE
 BOSTON, MA 02216
 TEL (617) 242-9222
 FAX (617) 242-9824


THE GOLD STAR MEMORIAL HIGHWAY

MTA PROJECT MANAGER: R. NORWOOD


YORK TOLL PLAZA
 I-95 CROSS SECTIONS
 STA. 355+00

SHEET NUMBER: XS-64
 CONTRACT: 2018.20
 262 OF 489

Date: 8/28/2018

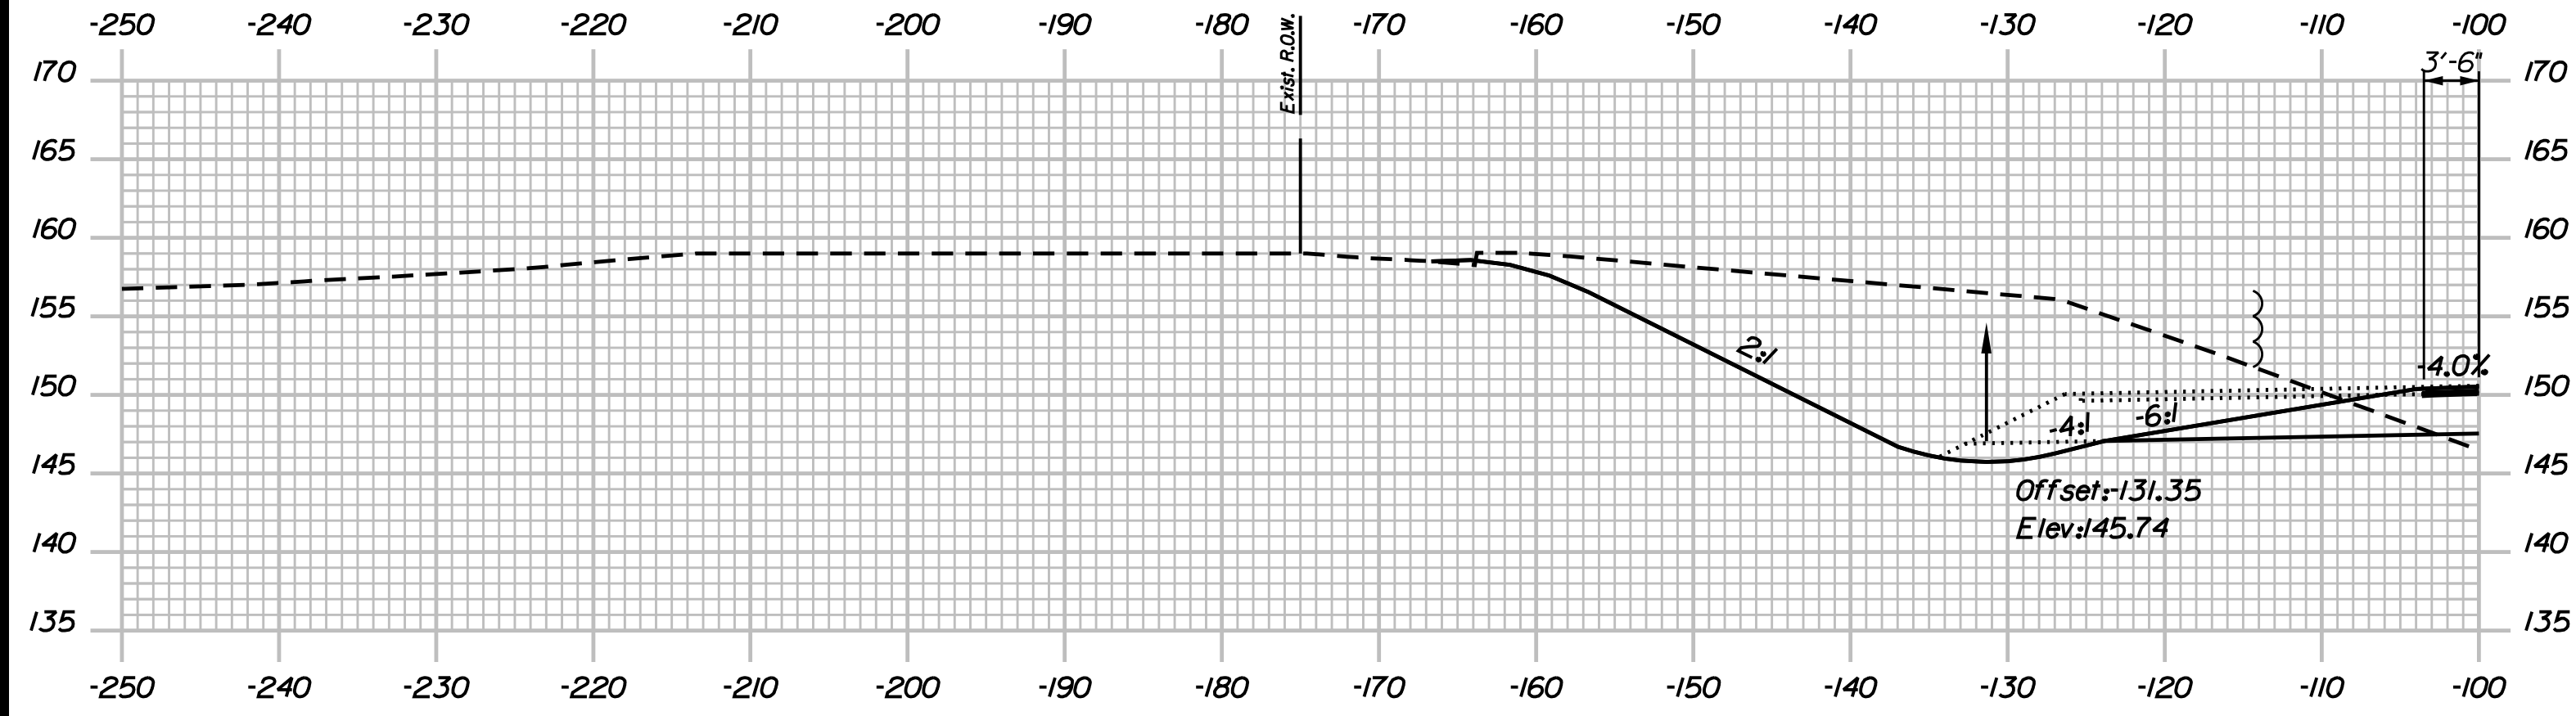

355+50.00

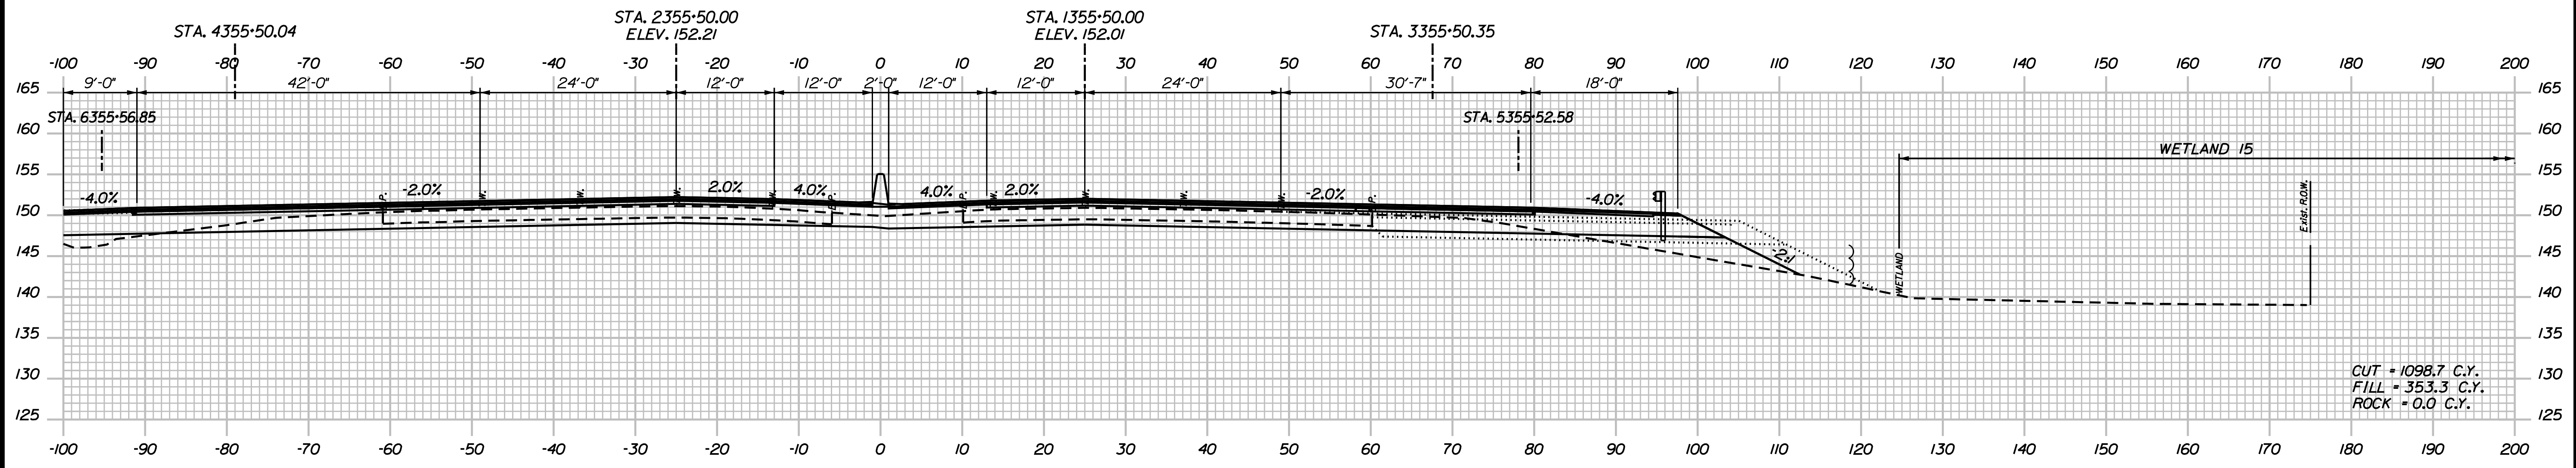

355+50.00

CUT = 1098.7 C.Y.
 FILL = 353.3 C.Y.
 ROCK = 0.0 C.Y.

Filename: ...00259637\Xsect13_195.dgn

Scale:

No.	Revision	By	Date

Designed by:

JACOBS

CONSULTANT PROJECT MANAGER: T. MORIN

	By	Date		By	Date
Designed	AMS	7-18	Checked	CSM	7-18
Drawn	SMG	7-18	In Charge of	TWM	7-18

JACOBS ENGINEERING GROUP
 120 ST. JAMES AVENUE
 BOSTON, MA 02216
 TEL (617) 242-9222
 FAX (617) 242-9824

THE GOLD STAR MEMORIAL HIGHWAY


MTA PROJECT MANAGER: R. NORWOOD

YORK TOLL PLAZA
 I-95 CROSS SECTIONS
 STA. 355+50

SHEET NUMBER: XS-65
 CONTRACT: 2018.20
 263 OF 489

Date: 8/28/2018

Filename: ...0259637\Xsect14_195.dgn

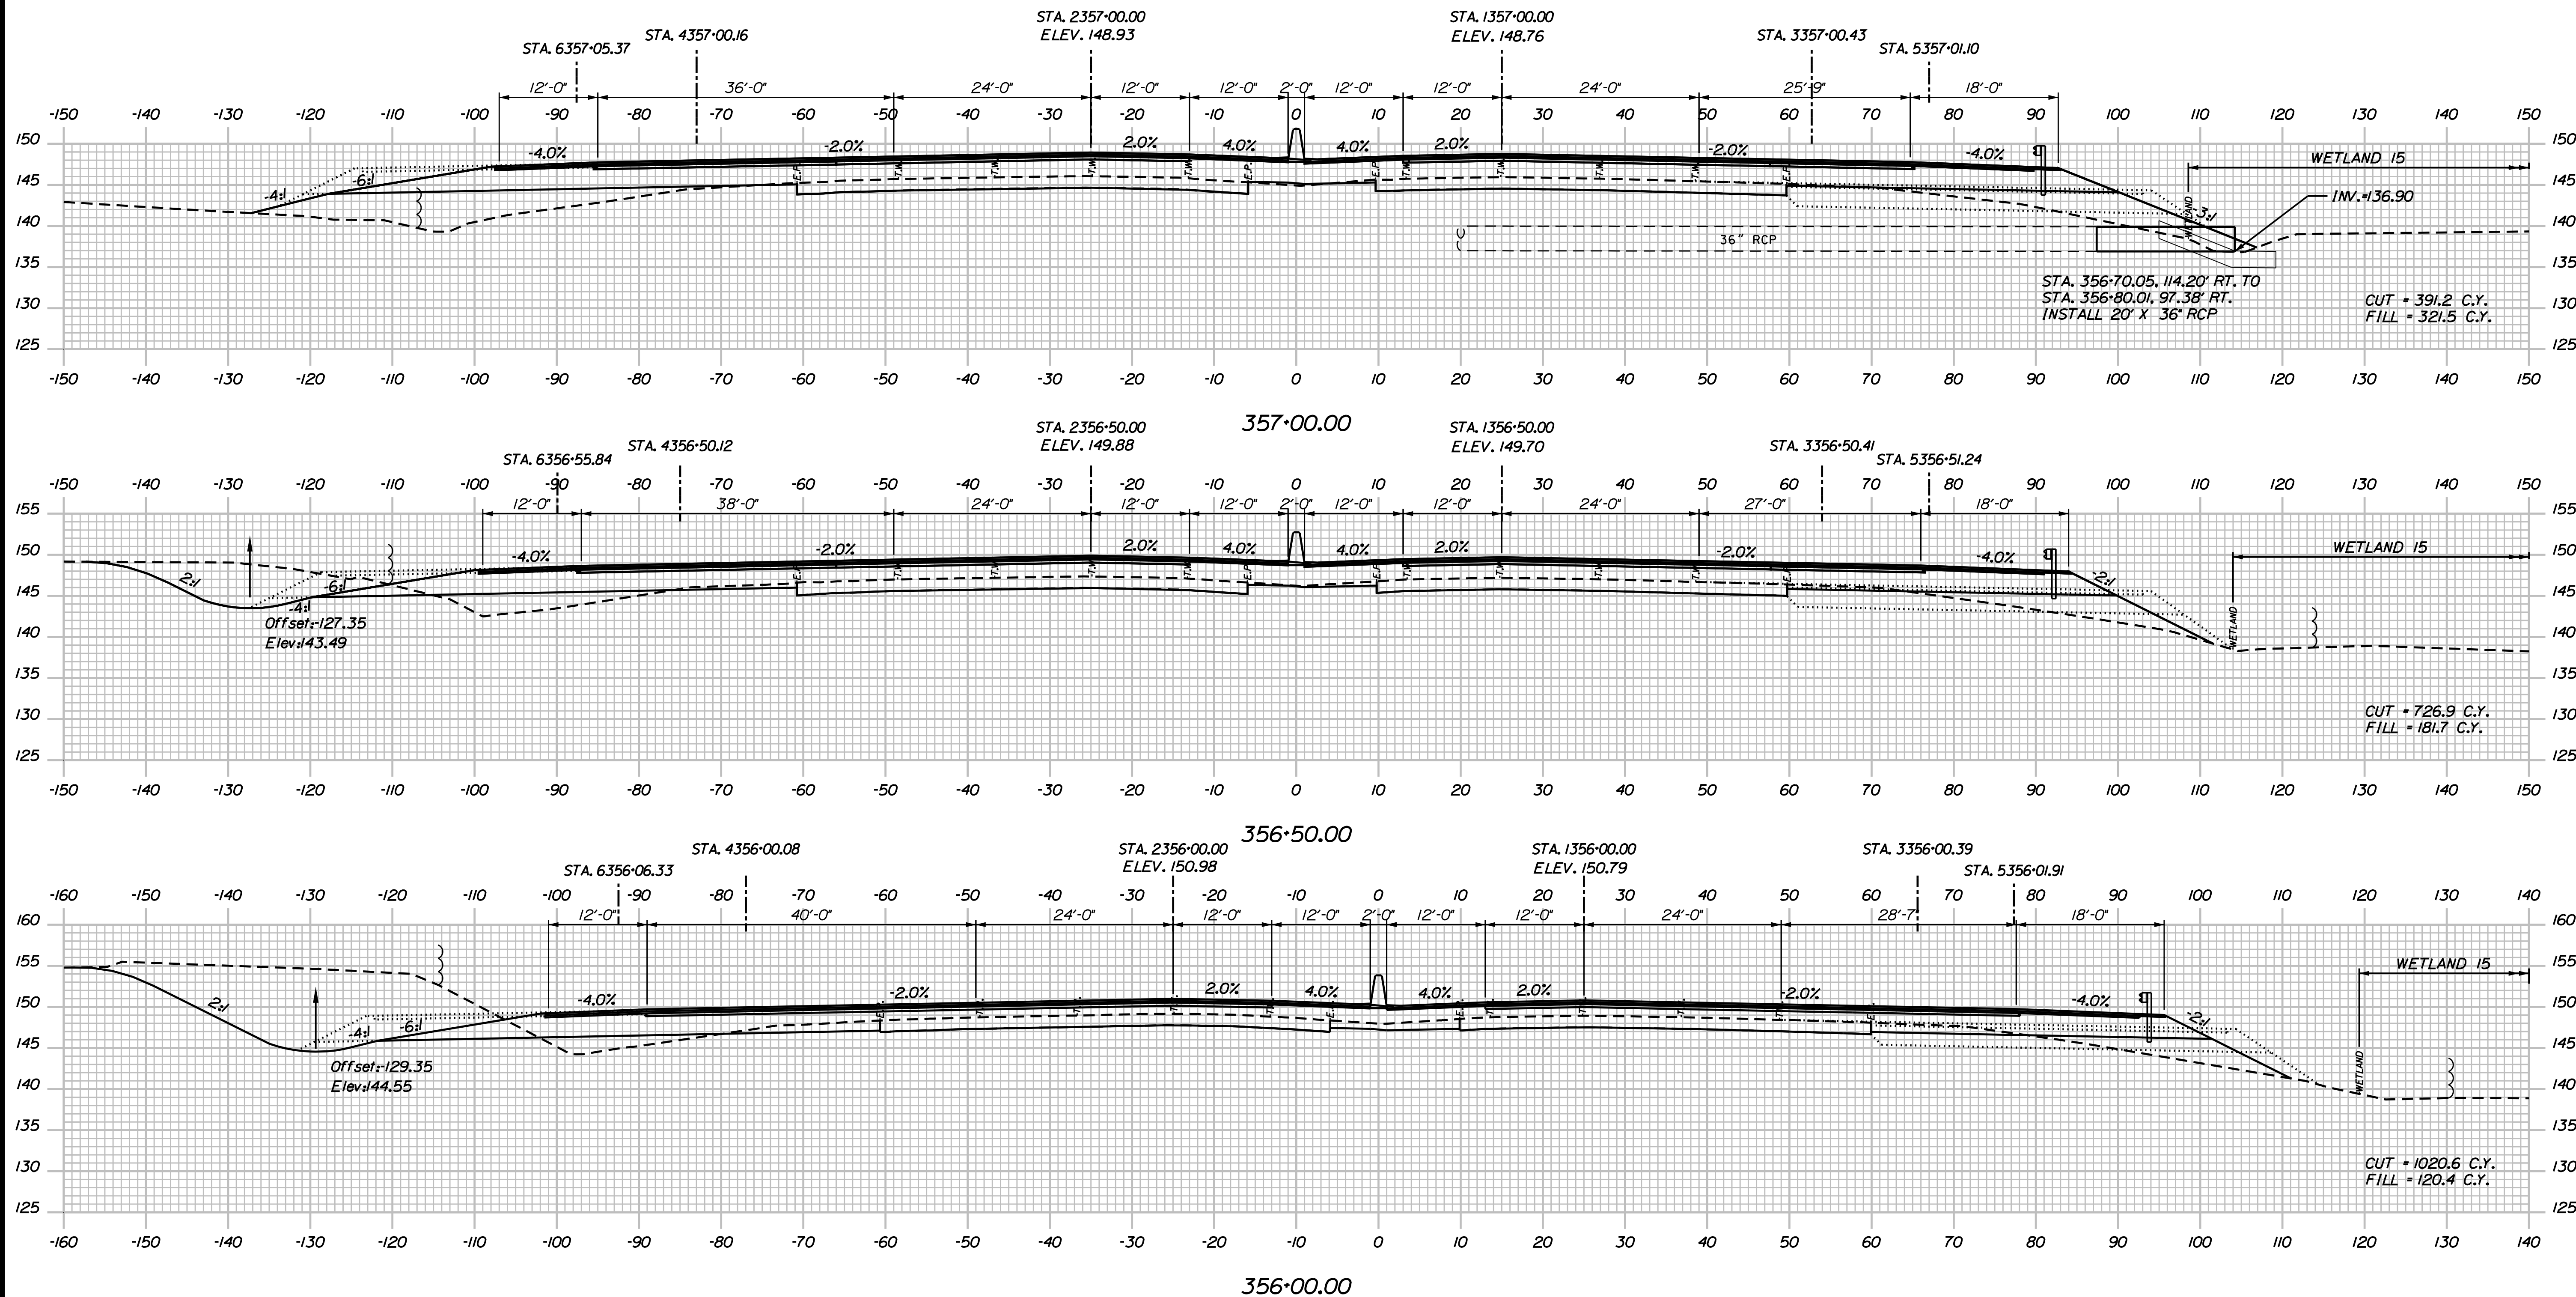

Scale:

No.	Revision	By	Date

Designed by:

JACOBS

CONSULTANT PROJECT MANAGER: T. MORIN

	By	Date		By	Date
Designed	AMS	7-18	Checked	CSM	7-18
Drawn	SMG	7-18	In Charge of	TWM	7-18

JACOBS ENGINEERING GROUP
 120 ST. JAMES AVENUE
 BOSTON, MA 02116
 TEL (617) 242-9222
 FAX (617) 242-9824

THE GOLD STAR MEMORIAL HIGHWAY

MTA PROJECT MANAGER: R. NORWOOD

YORK TOLL PLAZA

I-95 CROSS SECTIONS
 STA. 356+00 TO STA. 357+00


SHEET NUMBER: XS-66

CONTRACT: 2018.20

264 OF 489

Date: 6/28/2018

Filename: ...0259637\Xsect14_195.dgn

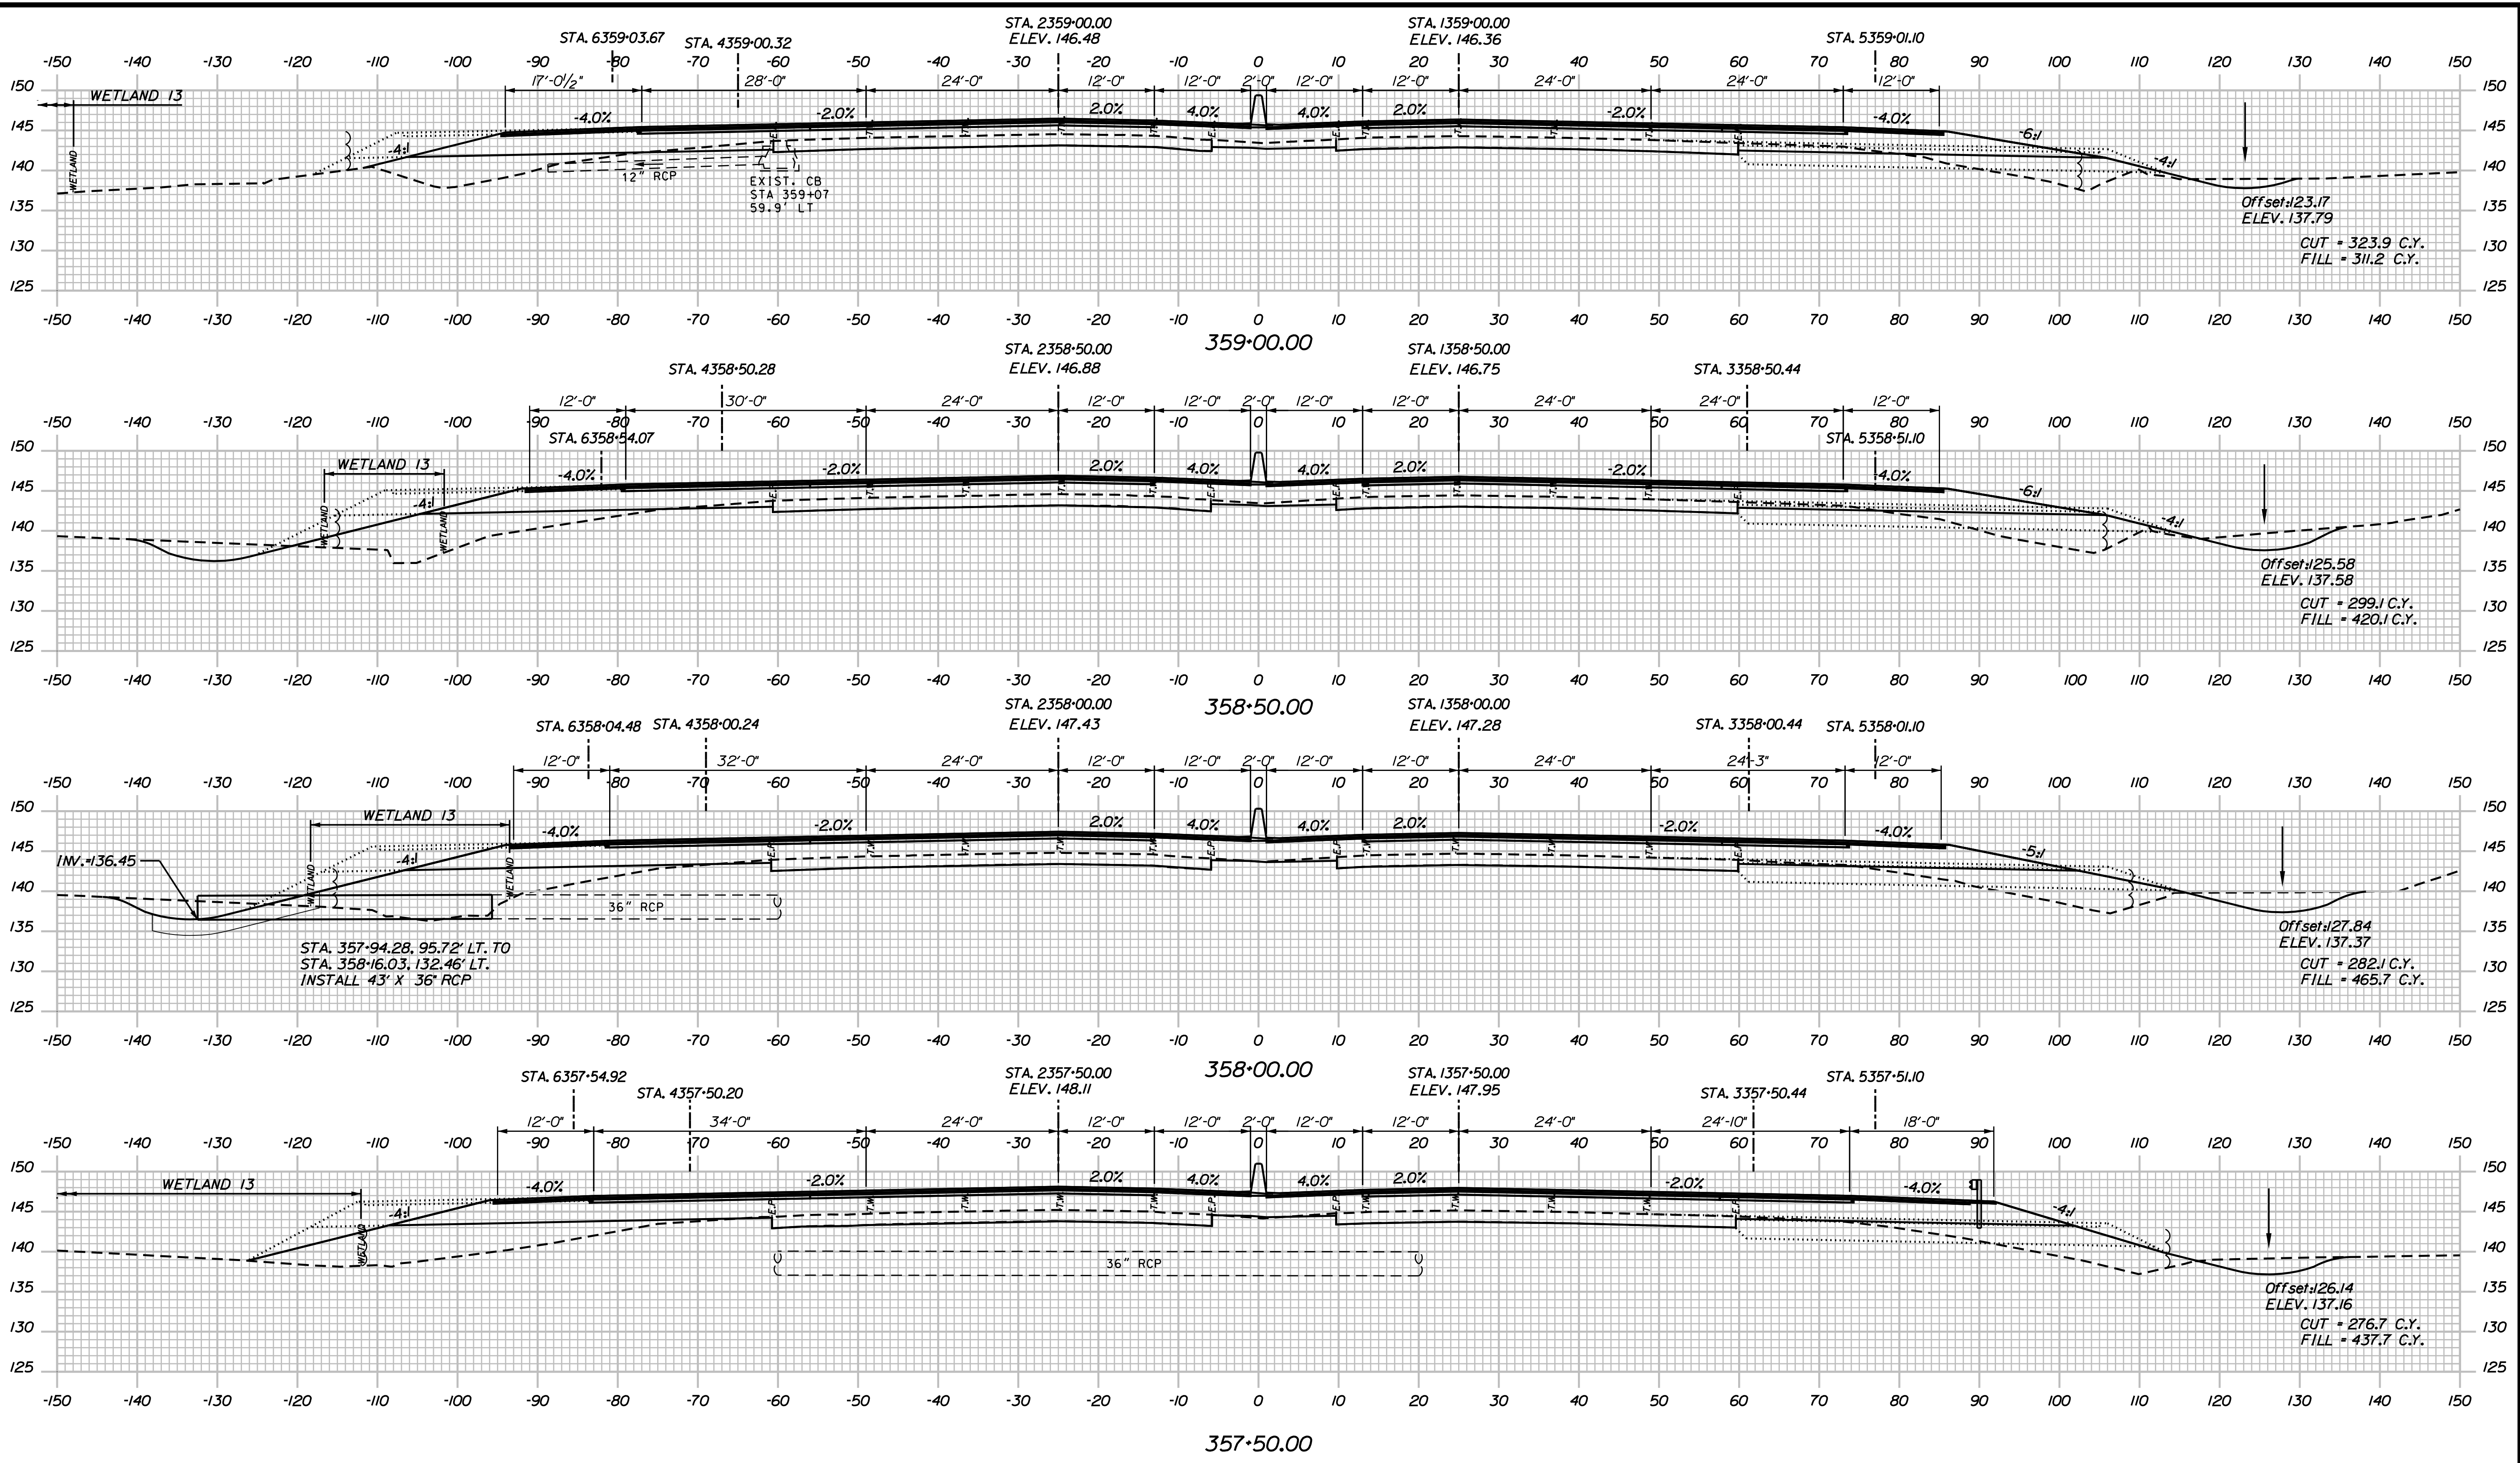

Scale:

No.	Revision	By	Date

Designed by:

JACOBS

CONSULTANT PROJECT MANAGER: T. MORIN

	By	Date		By	Date
Designed	AMS	7-18	Checked	CSM	7-18
Drawn	SMG	7-18	In Charge of	TWM	7-18

JACOBS ENGINEERING GROUP
 120 ST. JAMES AVENUE
 BOSTON, MA 02116
 TEL (617) 242-9222
 FAX (617) 242-9824

**THE GOLD STAR
 MEMORIAL HIGHWAY**

MTA PROJECT MANAGER: R. NORWOOD

YORK TOLL PLAZA

I-95 CROSS SECTIONS
 STA. 357+50 TO STA. 359+00


SHEET NUMBER: XS-67

CONTRACT: 2018.20

265 OF 489

Date: 8/28/2018

Filename: ...00259637\Xsect14_195.dgn

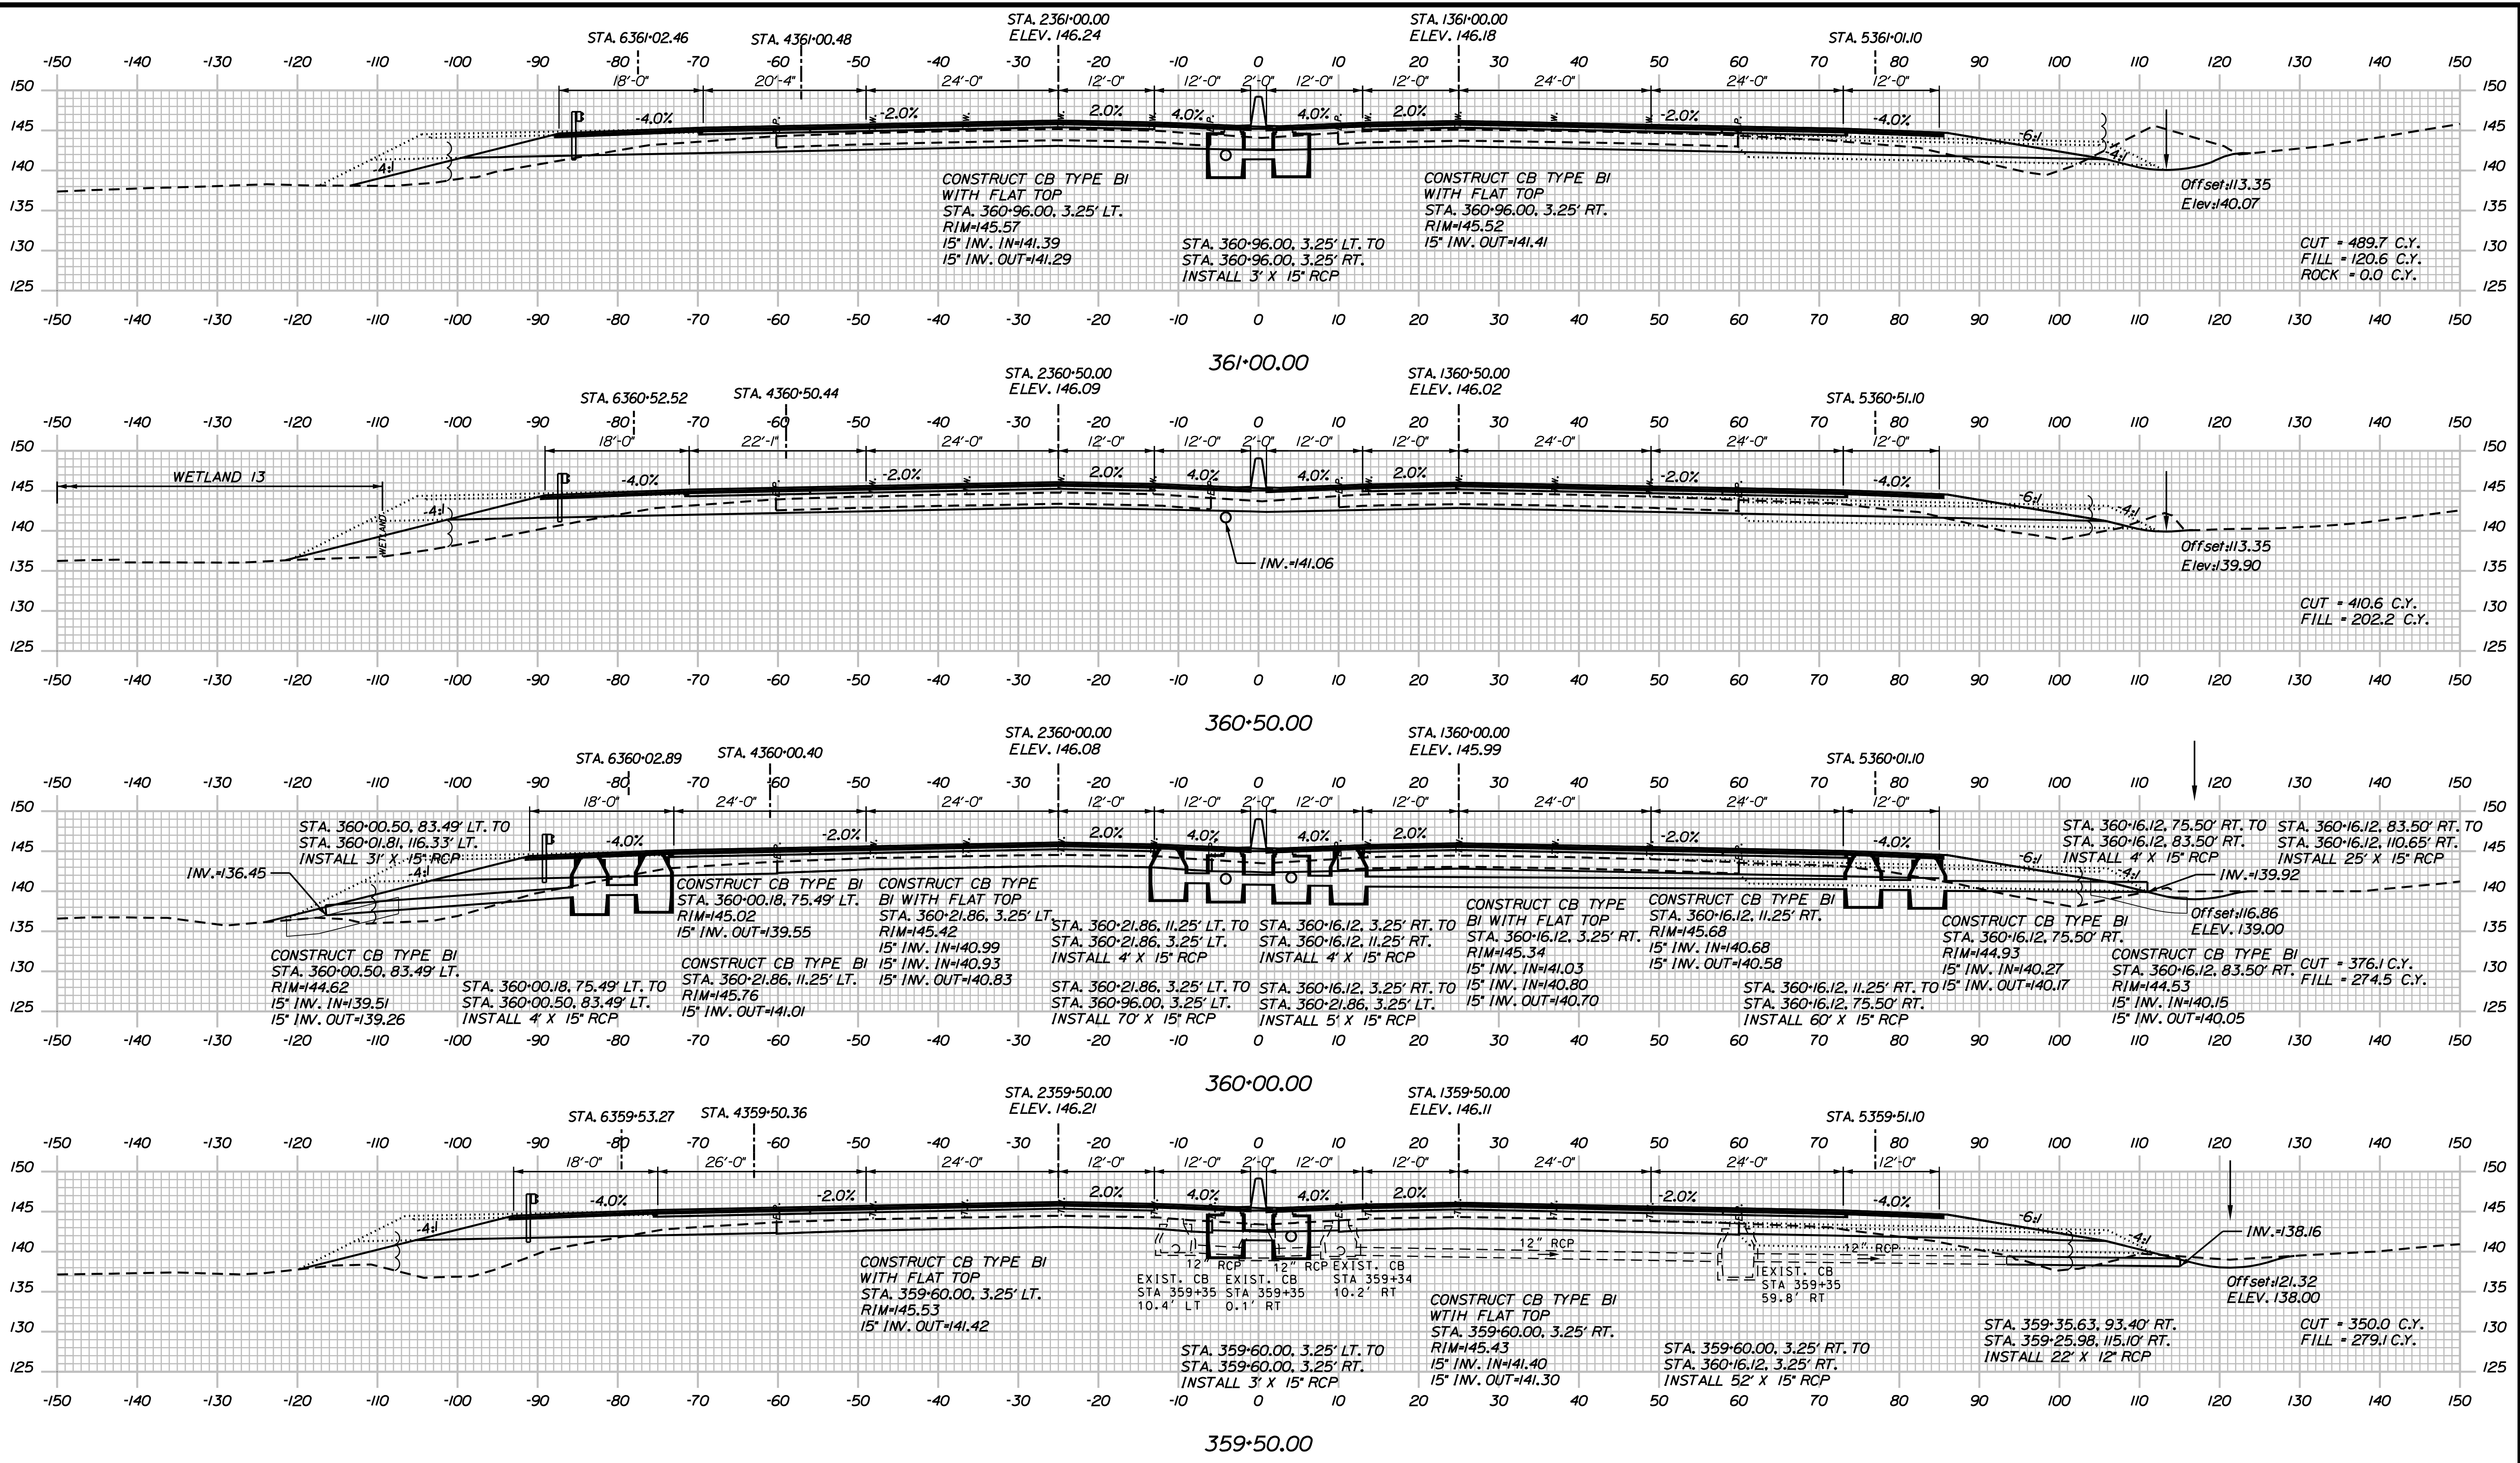

Scale: Scale of Feet

No.	Revision	By	Date

Designed by:

JACOBS

CONSULTANT PROJECT MANAGER: T. MORIN

	By	Date		By	Date
Designed	AMS	7-18	Checked	CSM	7-18
Drawn	SMG	7-18	In Charge of	TWM	7-18

JACOBS ENGINEERING GROUP
 120 ST. JAMES AVENUE
 BOSTON, MA 02116
 TEL (617) 242-9222
 FAX (617) 242-9824

THE GOLD STAR
 MEMORIAL HIGHWAY

MTA PROJECT MANAGER: R. NORWOOD

YORK TOLL PLAZA

I-95 CROSS SECTIONS
 STA. 359+50 TO STA. 361+00


SHEET NUMBER: XS-68

CONTRACT: 2018.20

266 OF 489

Date: 8/28/2018

Filename: ...0259637\Xsect14_195.dgn

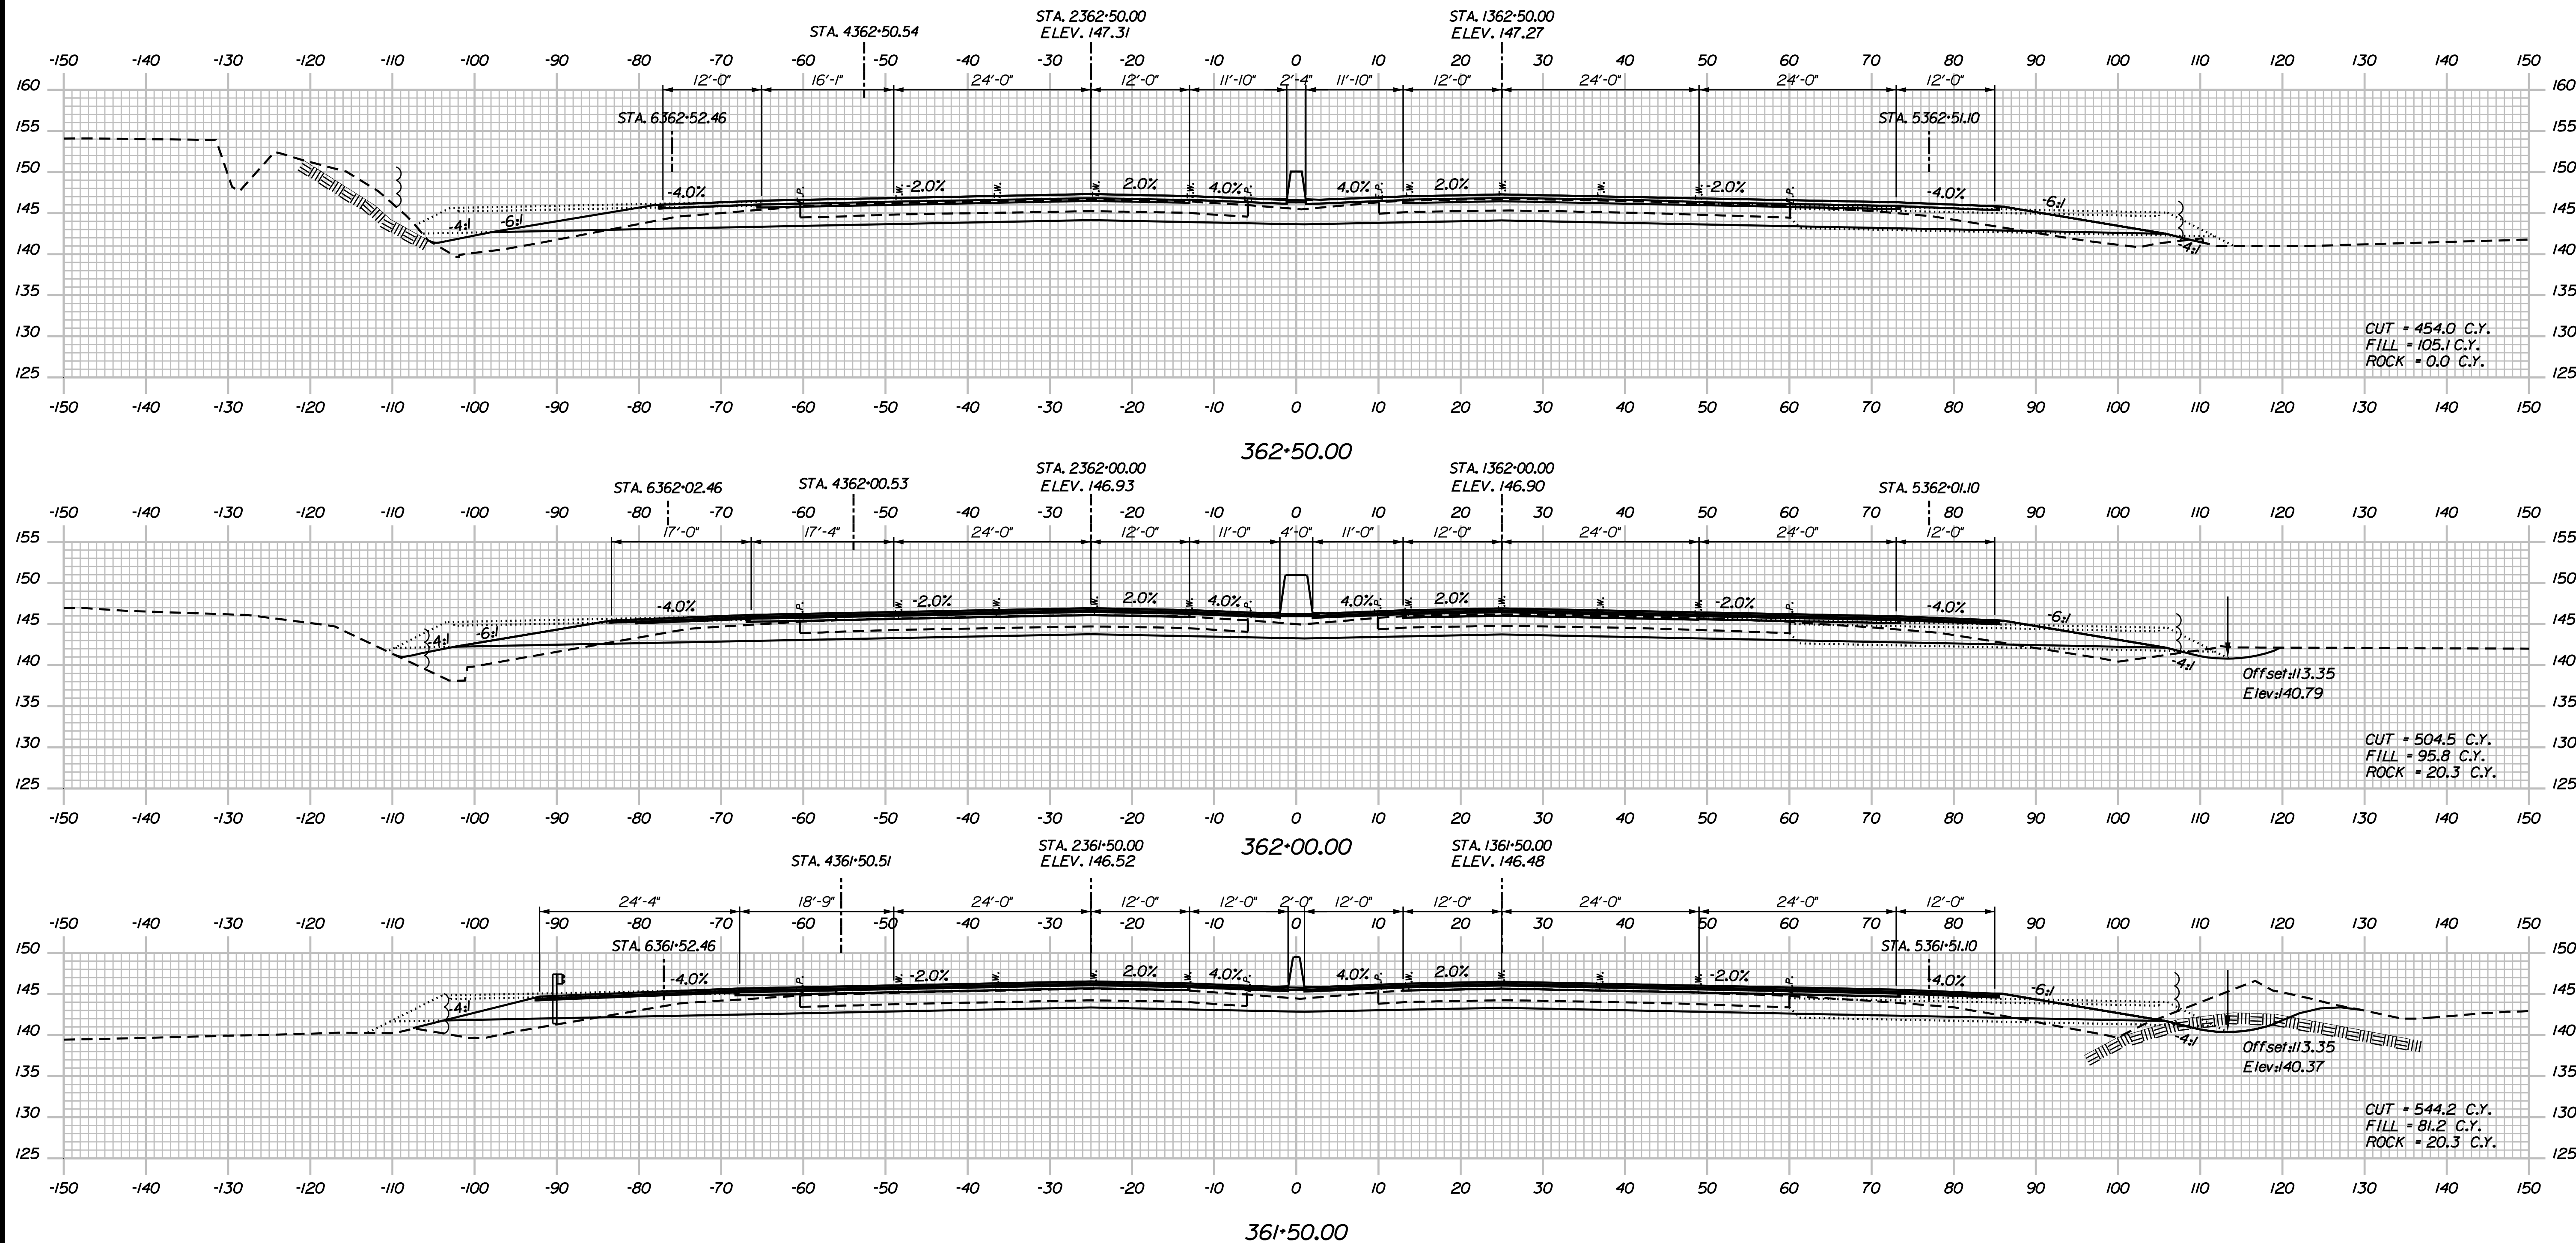

CUT = 454.0 C.Y.
 FILL = 105.1 C.Y.
 ROCK = 0.0 C.Y.

CUT = 504.5 C.Y.
 FILL = 95.8 C.Y.
 ROCK = 20.3 C.Y.

CUT = 544.2 C.Y.
 FILL = 81.2 C.Y.
 ROCK = 20.3 C.Y.

Scale:

No.	Revision	By	Date

Designed by:

JACOBS

CONSULTANT PROJECT MANAGER: T. MORIN

	By	Date		By	Date
Designed	AMS	7-18	Checked	CSM	7-18
Drawn	SMG	7-18	In Charge of	TWM	7-18

JACOBS ENGINEERING GROUP
 120 ST. JAMES AVENUE
 BOSTON, MA 02116
 TEL (617) 242-9222
 FAX (617) 242-9824

THE GOLD STAR MEMORIAL HIGHWAY

MTA PROJECT MANAGER: R. NORWOOD

YORK TOLL PLAZA

I-95 CROSS SECTIONS
 STA. 361+50 TO STA. 362+50





SHEET NUMBER: XS-69

CONTRACT: 2018.20

267 OF 489

Date: 8/28/2018

Filename: ...0259637\Xsect14_195.dgn

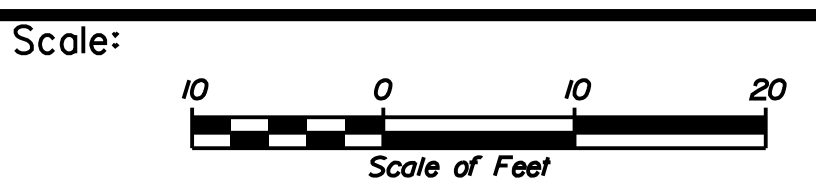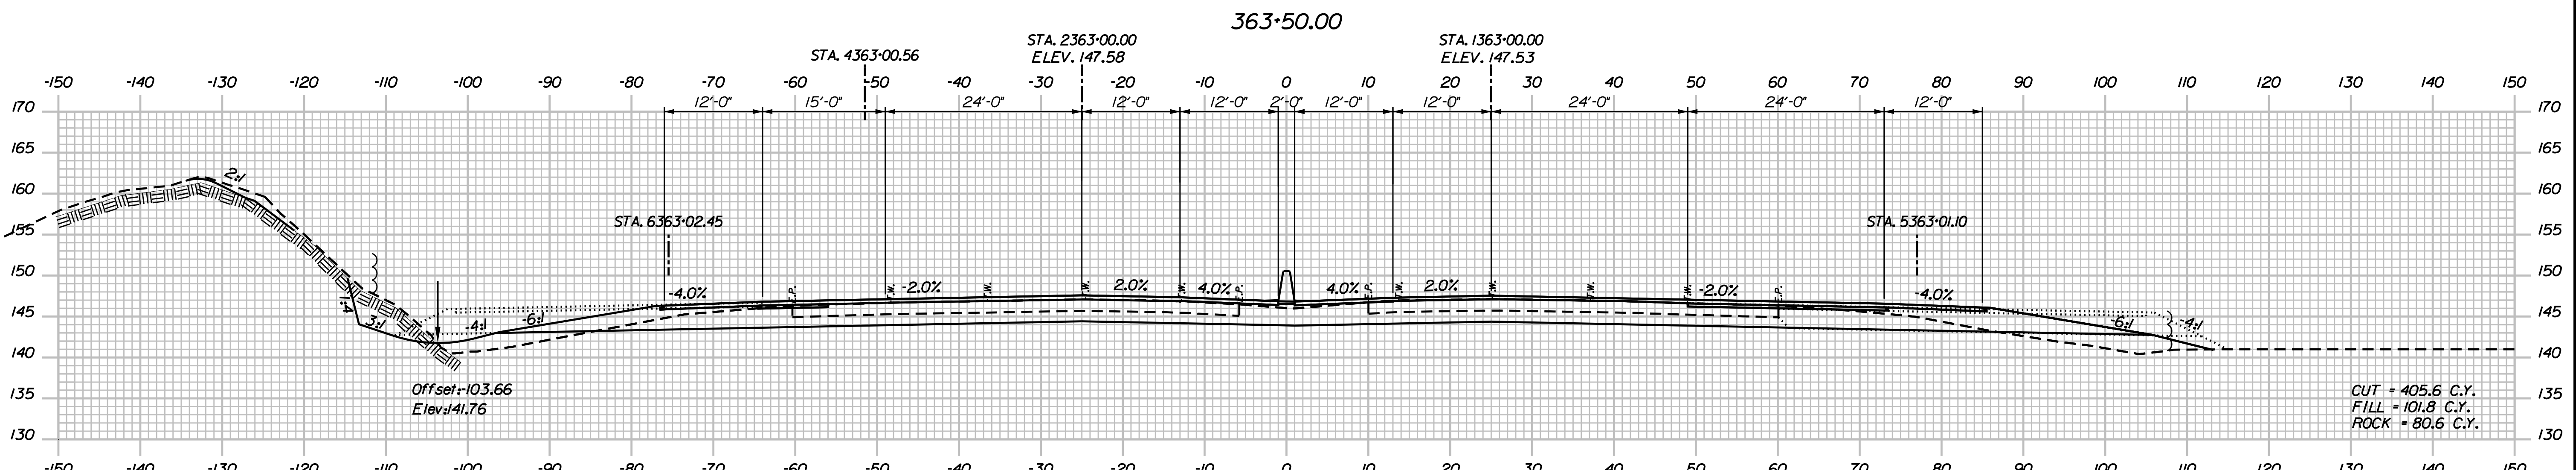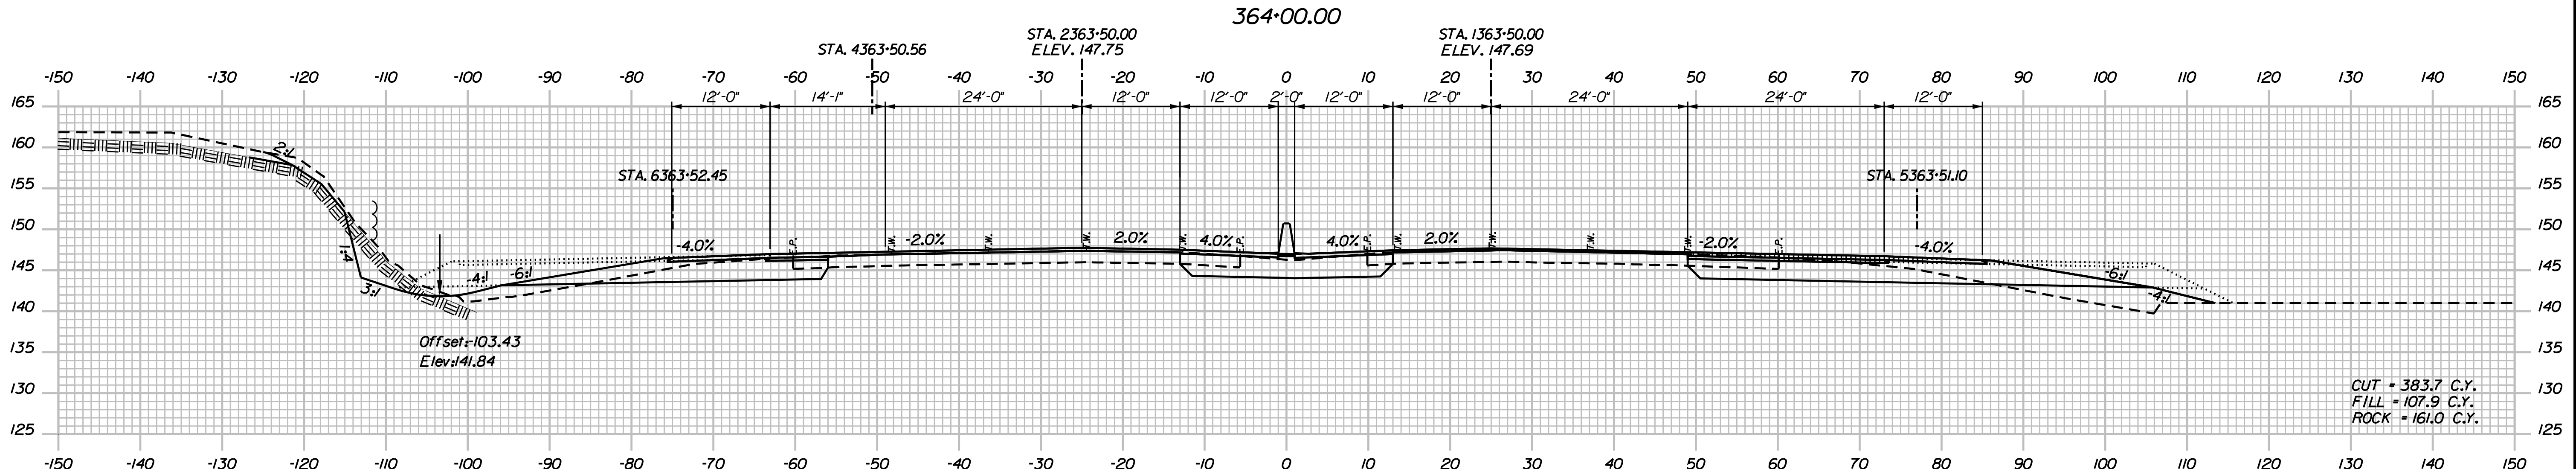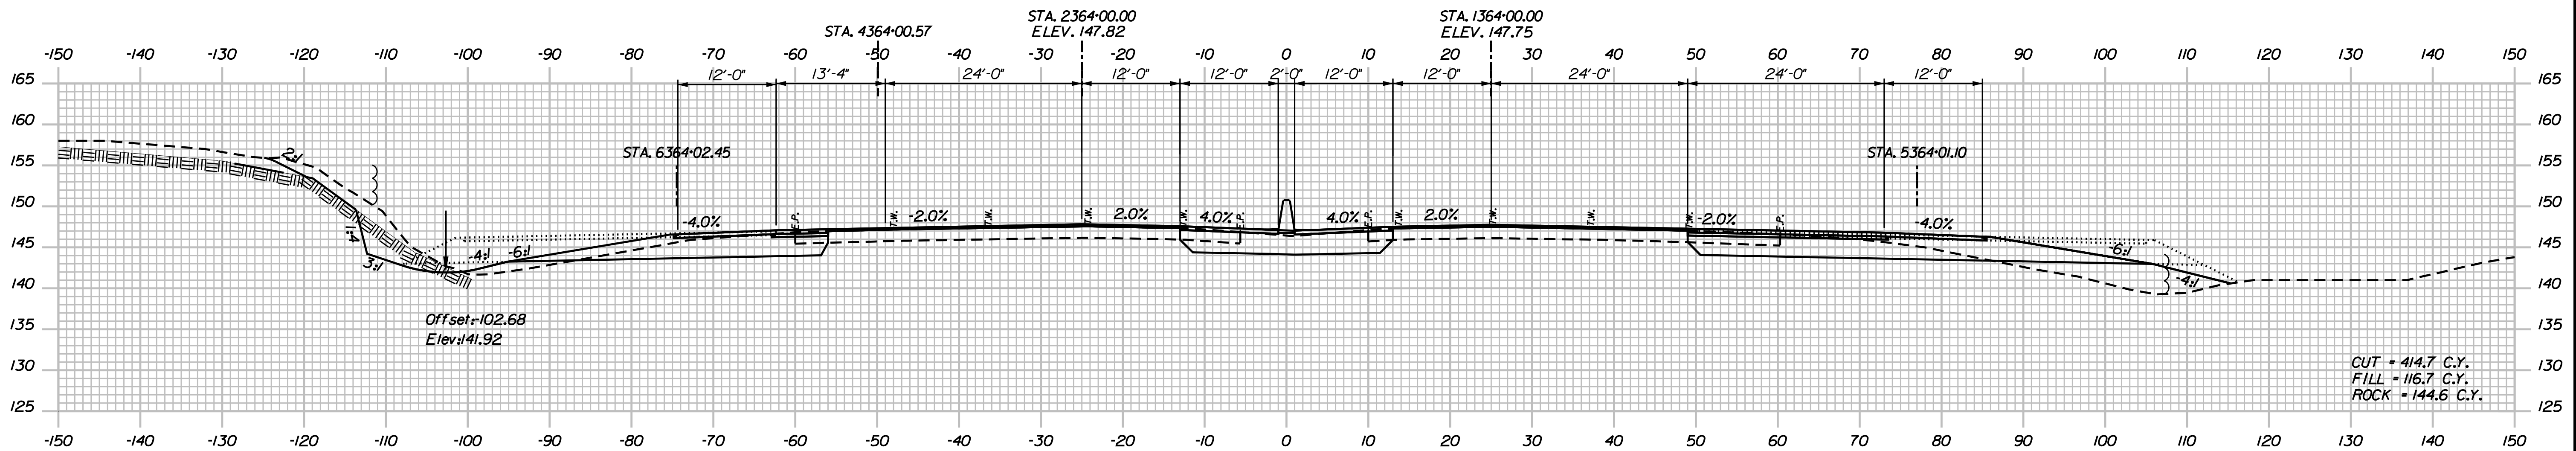

Designed by:

JACOBS

CONSULTANT PROJECT MANAGER: T. MORIN

No.	Revision	By	Date

	By	Date		By	Date
Designed	AMS	7-18	Checked	CSM	7-18
Drawn	SMG	7-18	In Charge of	TWM	7-18

JACOBS ENGINEERING GROUP
 120 ST. JAMES AVENUE
 BOSTON, MA 02116
 TEL (617) 242-9222
 FAX (617) 242-9824

THE GOLD STAR MEMORIAL HIGHWAY

MTA PROJECT MANAGER: R. NORWOOD

YORK TOLL PLAZA

I-95 CROSS SECTIONS
 STA. 363+00 TO STA. 364+00


SHEET NUMBER: XS-70

CONTRACT: 2018.20

268 OF 489

Date: 8/28/2018

Filename: ...00259637\Xsect14_195.dgn

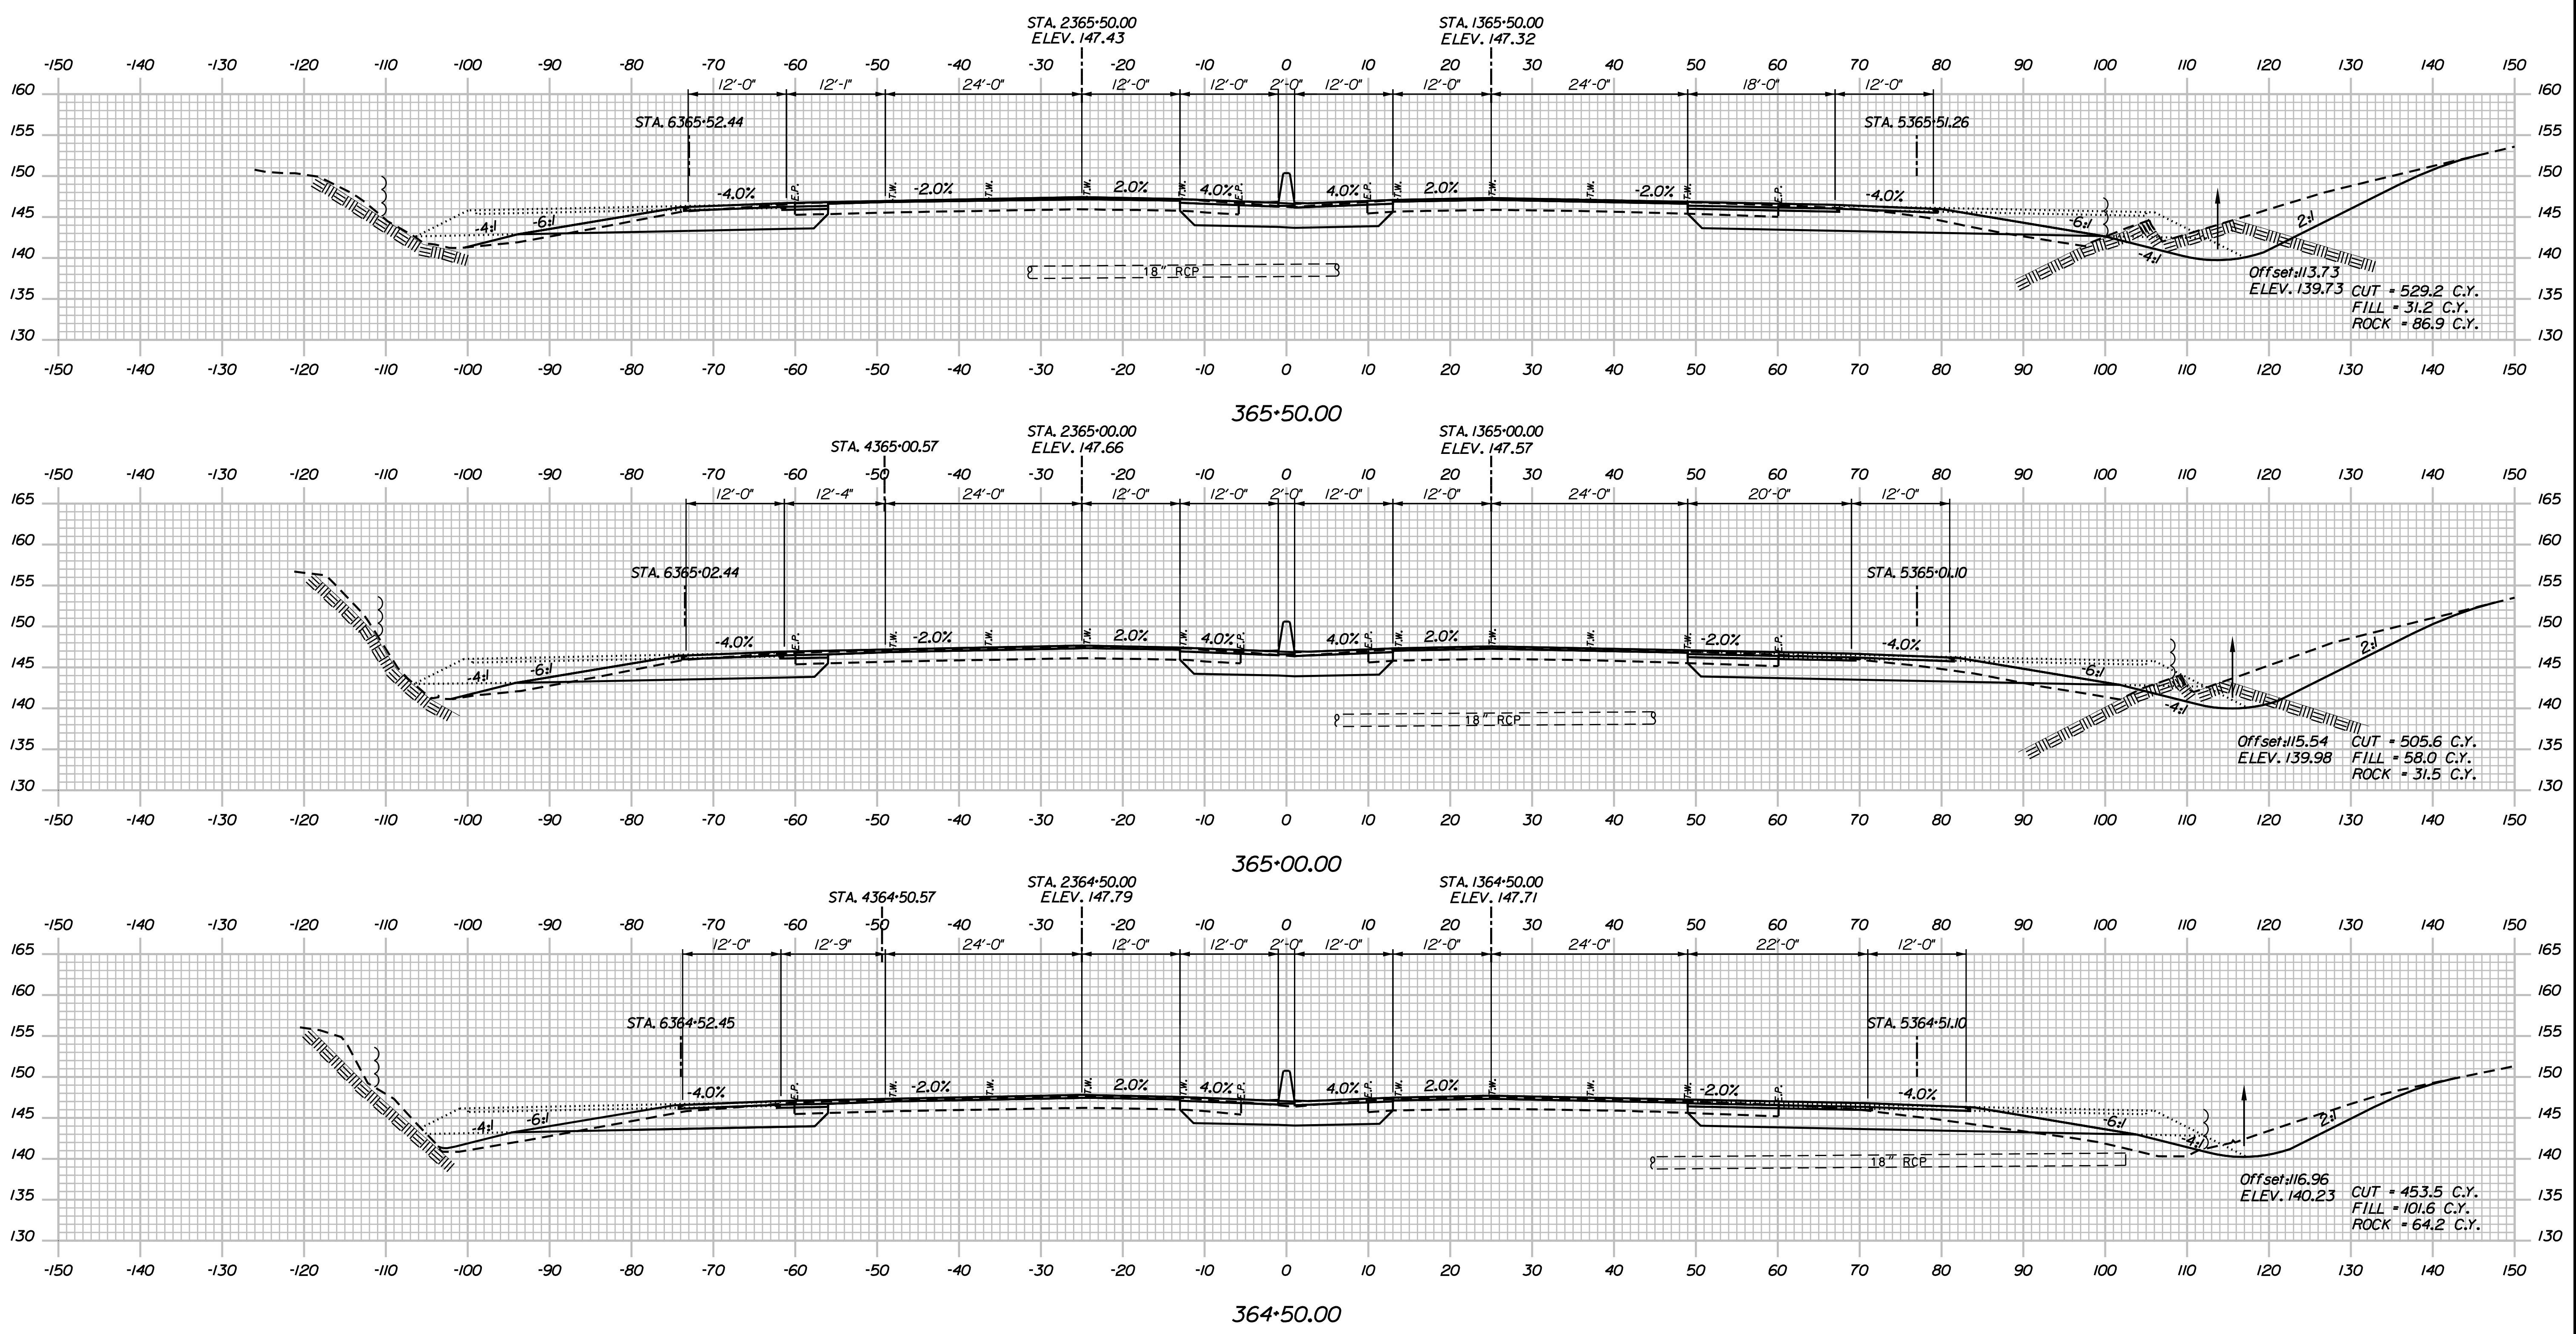

Scale:

No.	Revision	By	Date

Designed by:

JACOBS

CONSULTANT PROJECT MANAGER: T. MORIN

	By	Date		By	Date
Designed	AMS	7-18	Checked	CSM	7-18
Drawn	SMG	7-18	In Charge of	TWM	7-18

JACOBS ENGINEERING GROUP
 120 ST. JAMES AVENUE
 BOSTON, MA 02116
 TEL (617) 242-9222
 FAX (617) 242-9824

THE GOLD STAR MEMORIAL HIGHWAY

MTA PROJECT MANAGER: R. NORWOOD


YORK TOLL PLAZA

I-95 CROSS SECTIONS
 STA. 364+50 TO STA. 365+50

SHEET NUMBER: XS-71
 CONTRACT: 2018.20
 269 OF 489

Date: 8/28/2018

Filename: ... \02596371\Xsect14_195.dgn

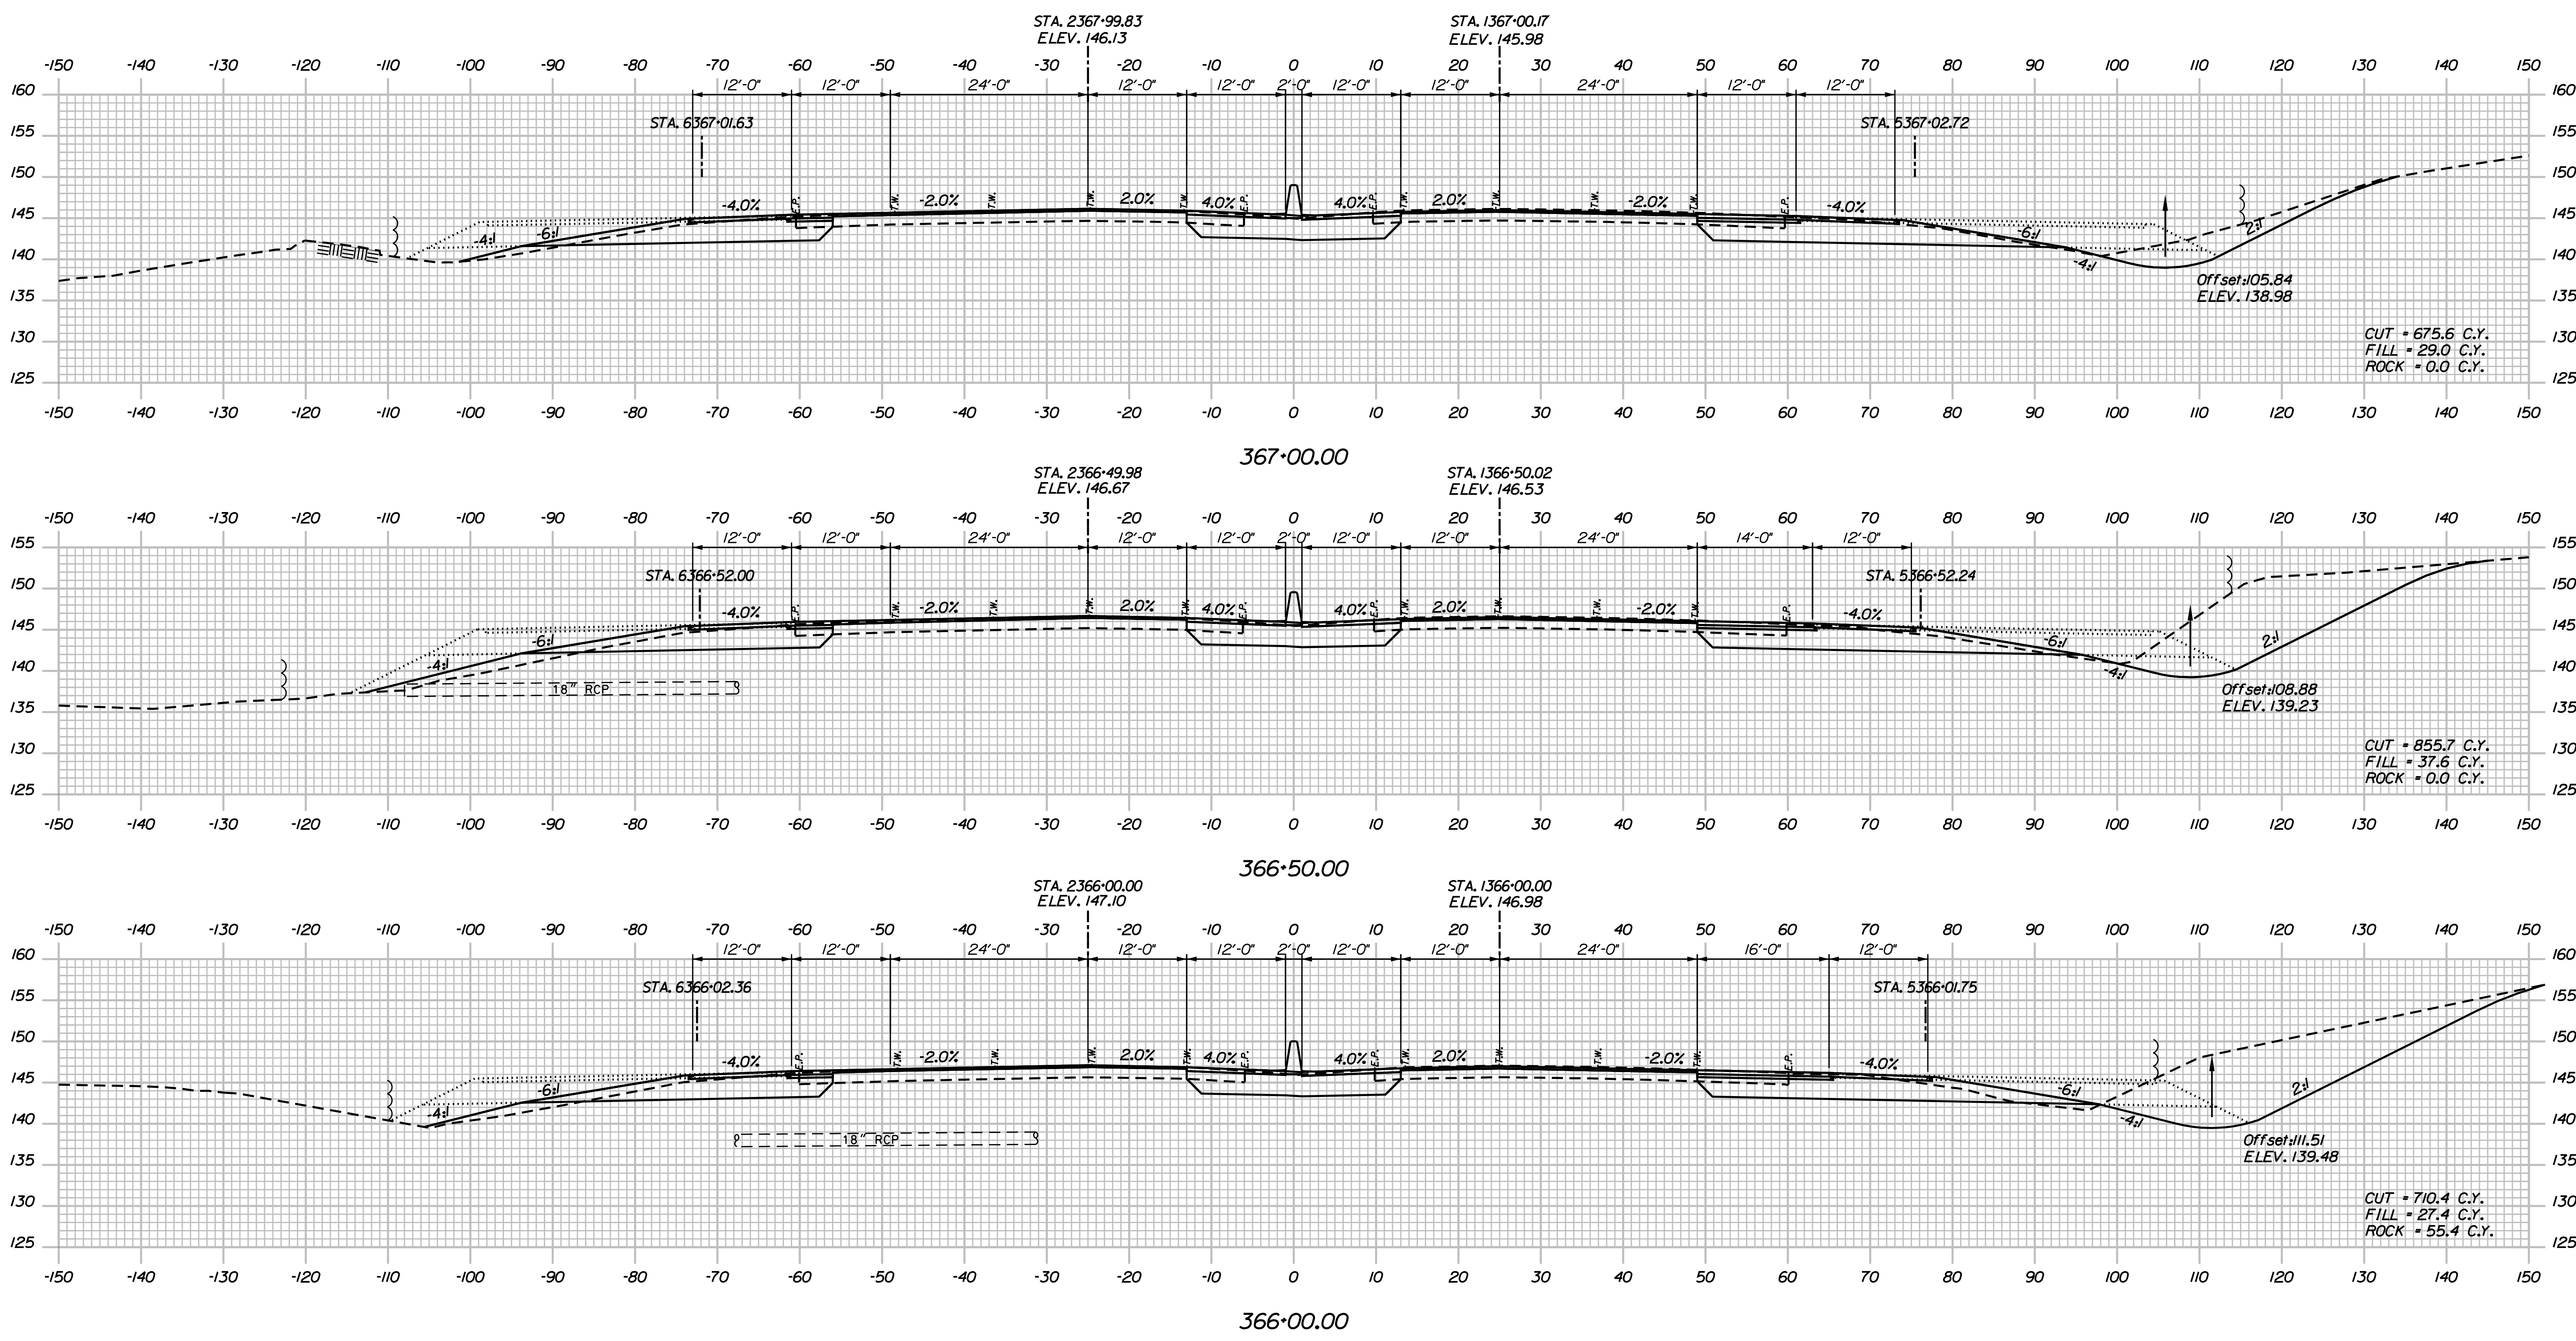

Scale:

No.	Revision	By	Date

Designed by:

JACOBS

CONSULTANT PROJECT MANAGER: T. MORIN

	By	Date		By	Date
Designed	AMS	7-18	Checked	CSM	7-18
Drawn	SMG	7-18	In Charge of	TWM	7-18

JACOBS ENGINEERING GROUP
 120 ST. JAMES AVENUE
 BOSTON, MA 02116
 TEL (617) 242-9222
 FAX (617) 242-9824

**THE GOLD STAR
 MEMORIAL HIGHWAY**

MTA PROJECT MANAGER: R. NORWOOD

YORK TOLL PLAZA

I-95 CROSS SECTIONS
 STA. 366+00 TO STA. 367+00





SHEET NUMBER: XS-72

CONTRACT: 2018.20

270 OF 489

Date: 8/28/2018

Filename: ... \02596371\sect14_195.dgn

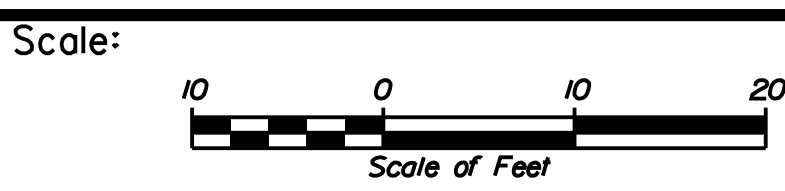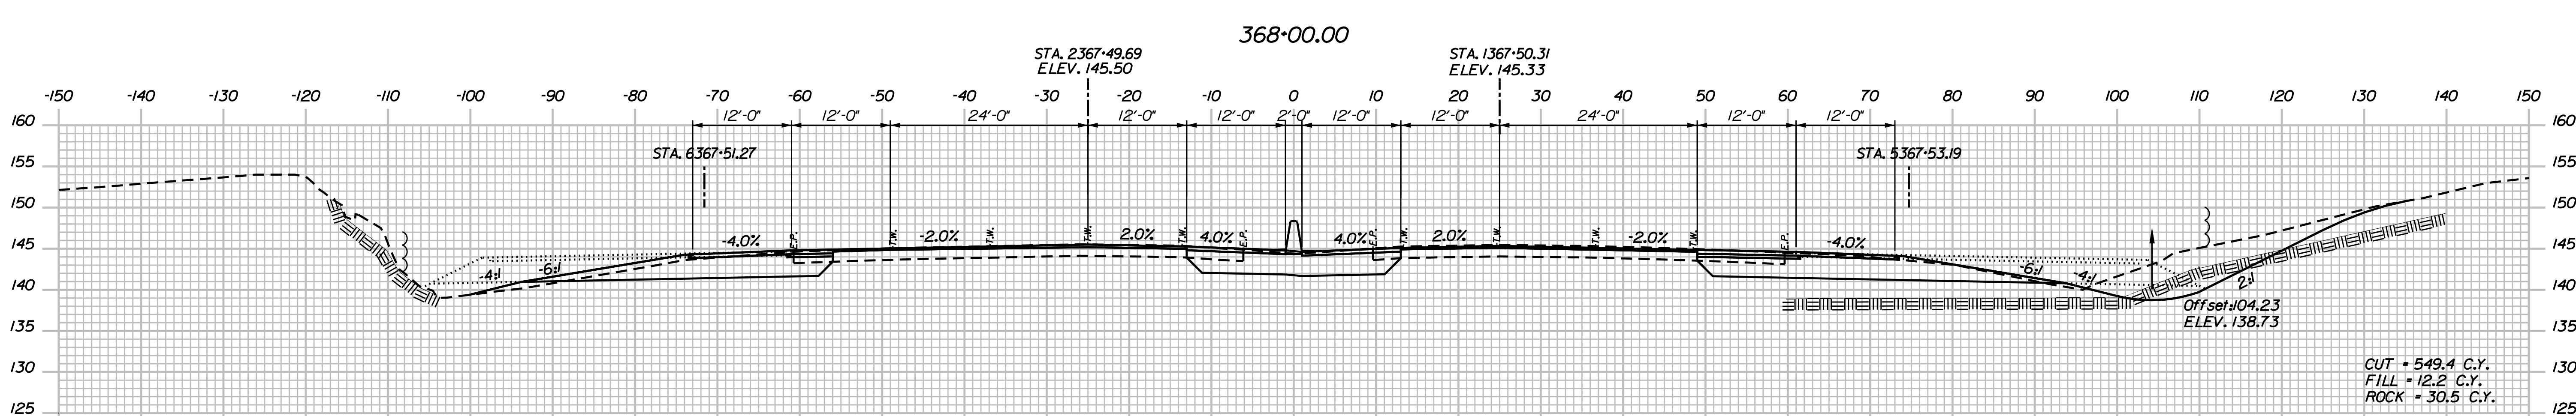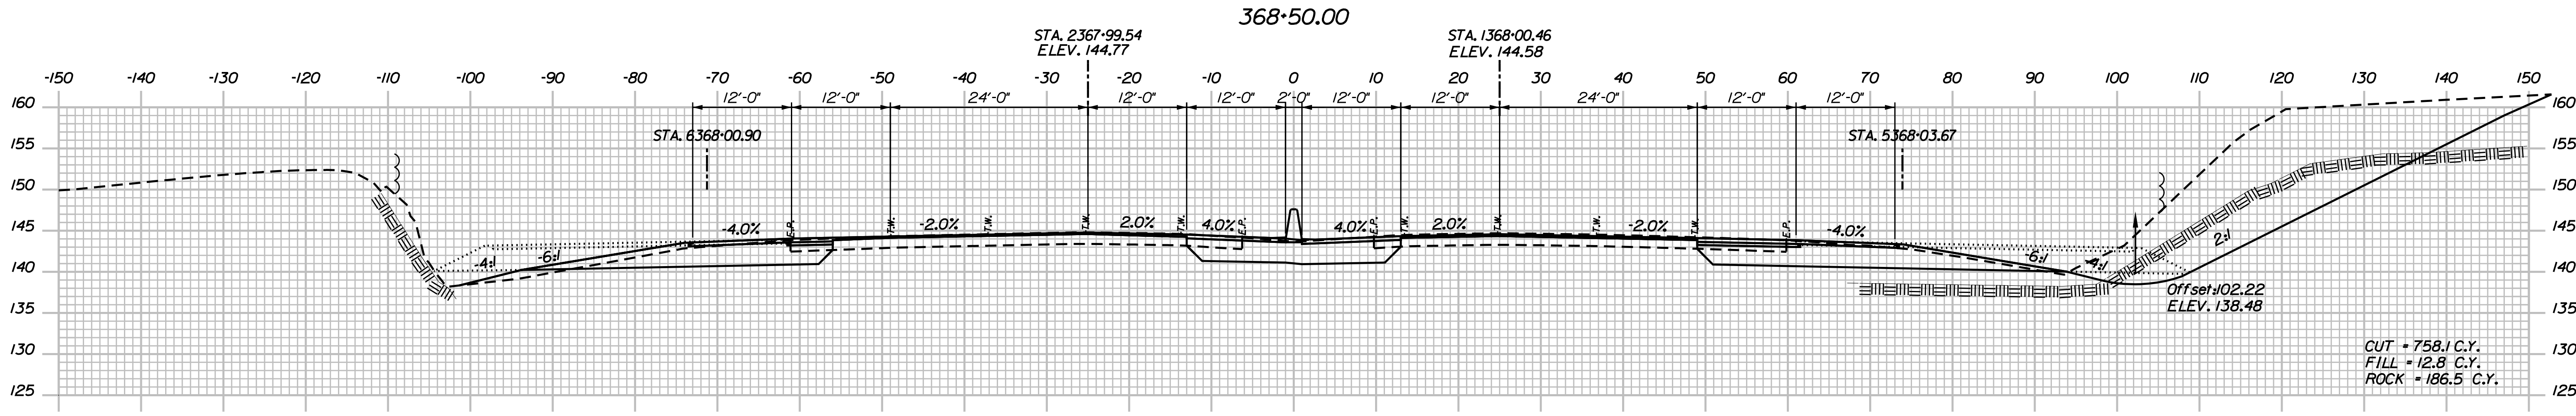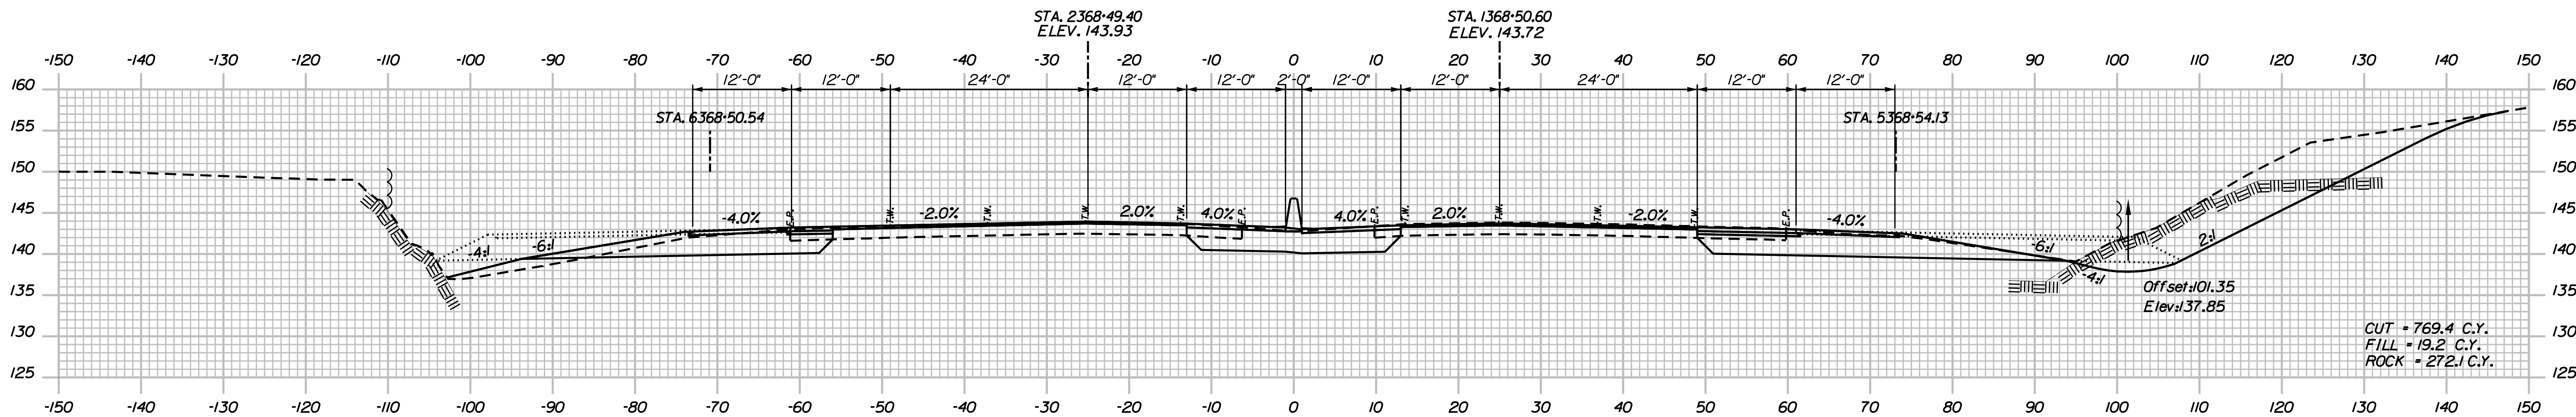

No.	Revision	By	Date

Designed by:

JACOBS

CONSULTANT PROJECT MANAGER: T. MORIN

	By	Date		By	Date
Designed	AMS	7-18	Checked	CSM	7-18
Drawn	SMG	7-18	In Charge of	TWM	7-18

JACOBS ENGINEERING GROUP
 120 ST. JAMES AVENUE
 BOSTON, MA 02116
 TEL (617) 242-9222
 FAX (617) 242-9824

**THE GOLD STAR
MEMORIAL HIGHWAY**

MTA PROJECT MANAGER: R. NORWOOD

YORK TOLL PLAZA

I-95 CROSS SECTIONS
 STA. 367+50 TO STA. 368+50




SHEET NUMBER: XS-73

CONTRACT: 2018.20

271 OF 489

Date: 8/28/2018

Filename: ...0259637\Xsect14_195.dgn

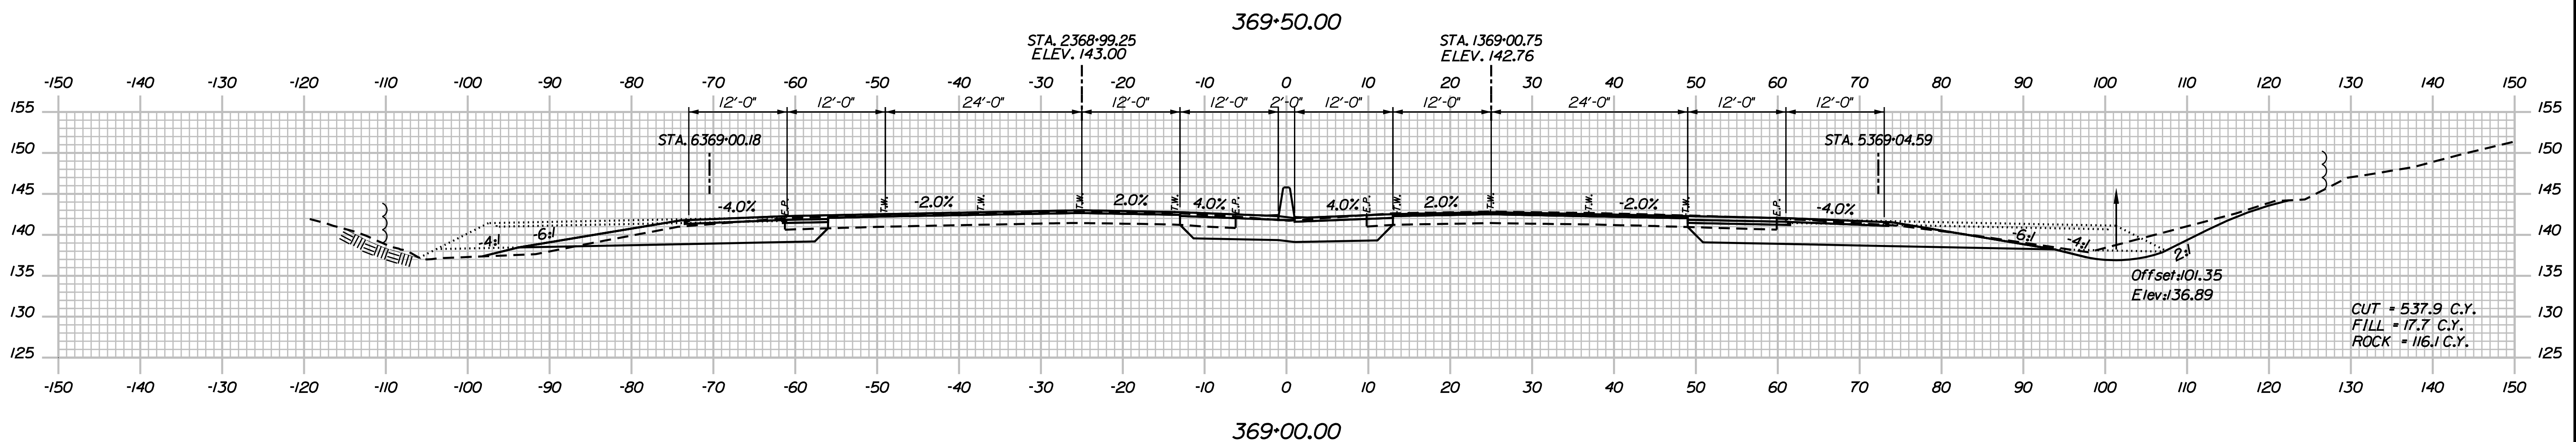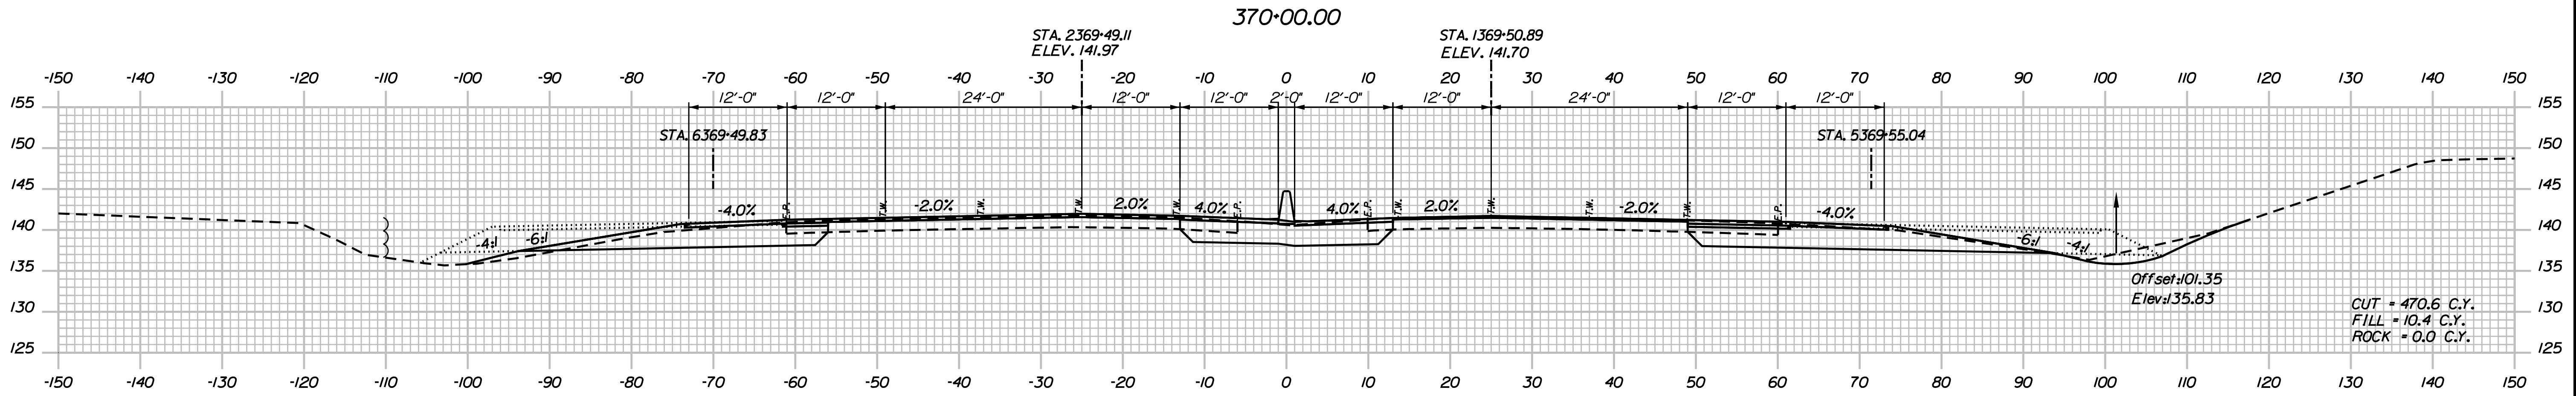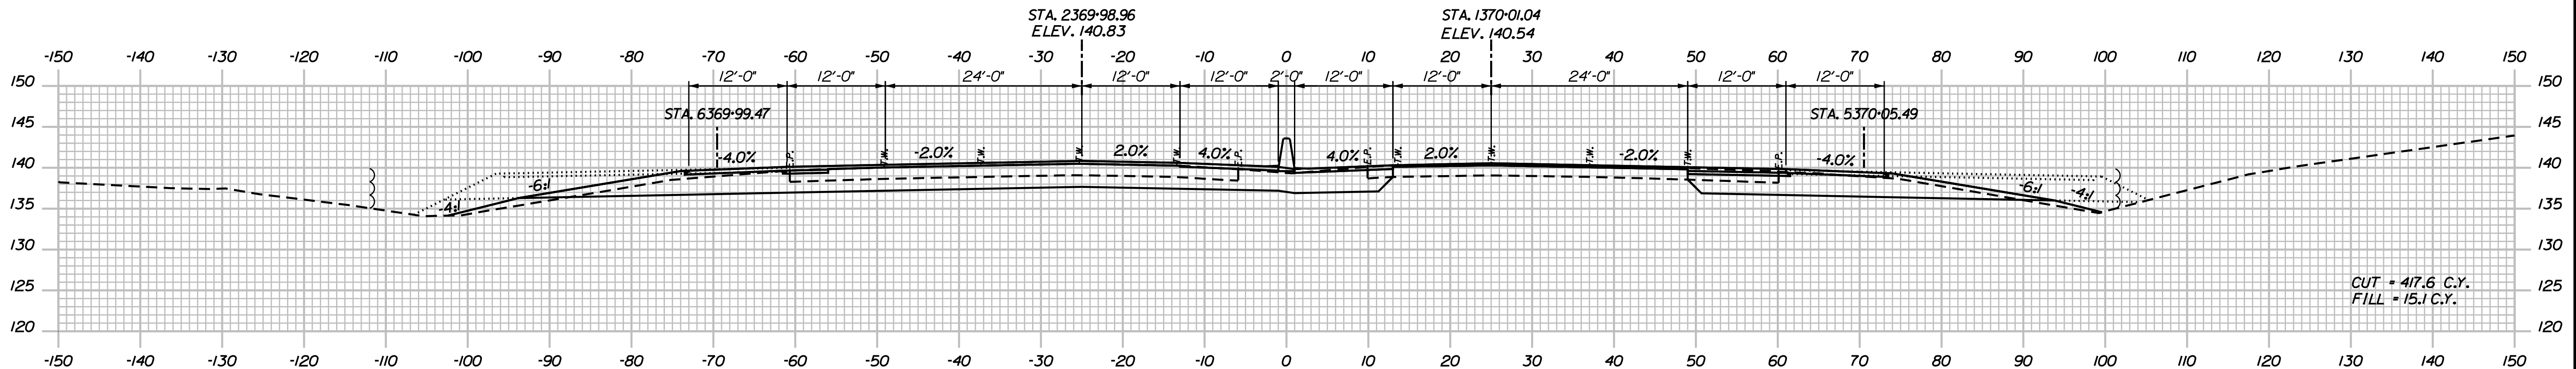

Scale:

No.	Revision	By	Date

Designed by:

JACOBS

CONSULTANT PROJECT MANAGER: T. MORIN

	By	Date		By	Date
Designed	AMS	7-18	Checked	CSM	7-18
Drawn	SMG	7-18	In Charge of	TWM	7-18

JACOBS ENGINEERING GROUP
 120 ST. JAMES AVENUE
 BOSTON, MA 02116
 TEL (617) 242-9222
 FAX (617) 242-9824

THE GOLD STAR MEMORIAL HIGHWAY

MTA PROJECT MANAGER: R. NORWOOD

YORK TOLL PLAZA

I-95 CROSS SECTIONS
 STA. 369+00 TO STA. 370+00



SHEET NUMBER: XS-74

CONTRACT: 2018.20

272 OF 489

Date: 8/28/2018

Filename: ...0259637\Xsect14_195.dgn

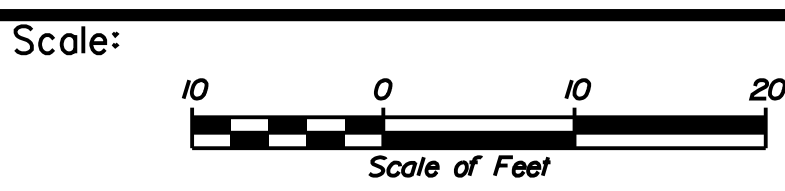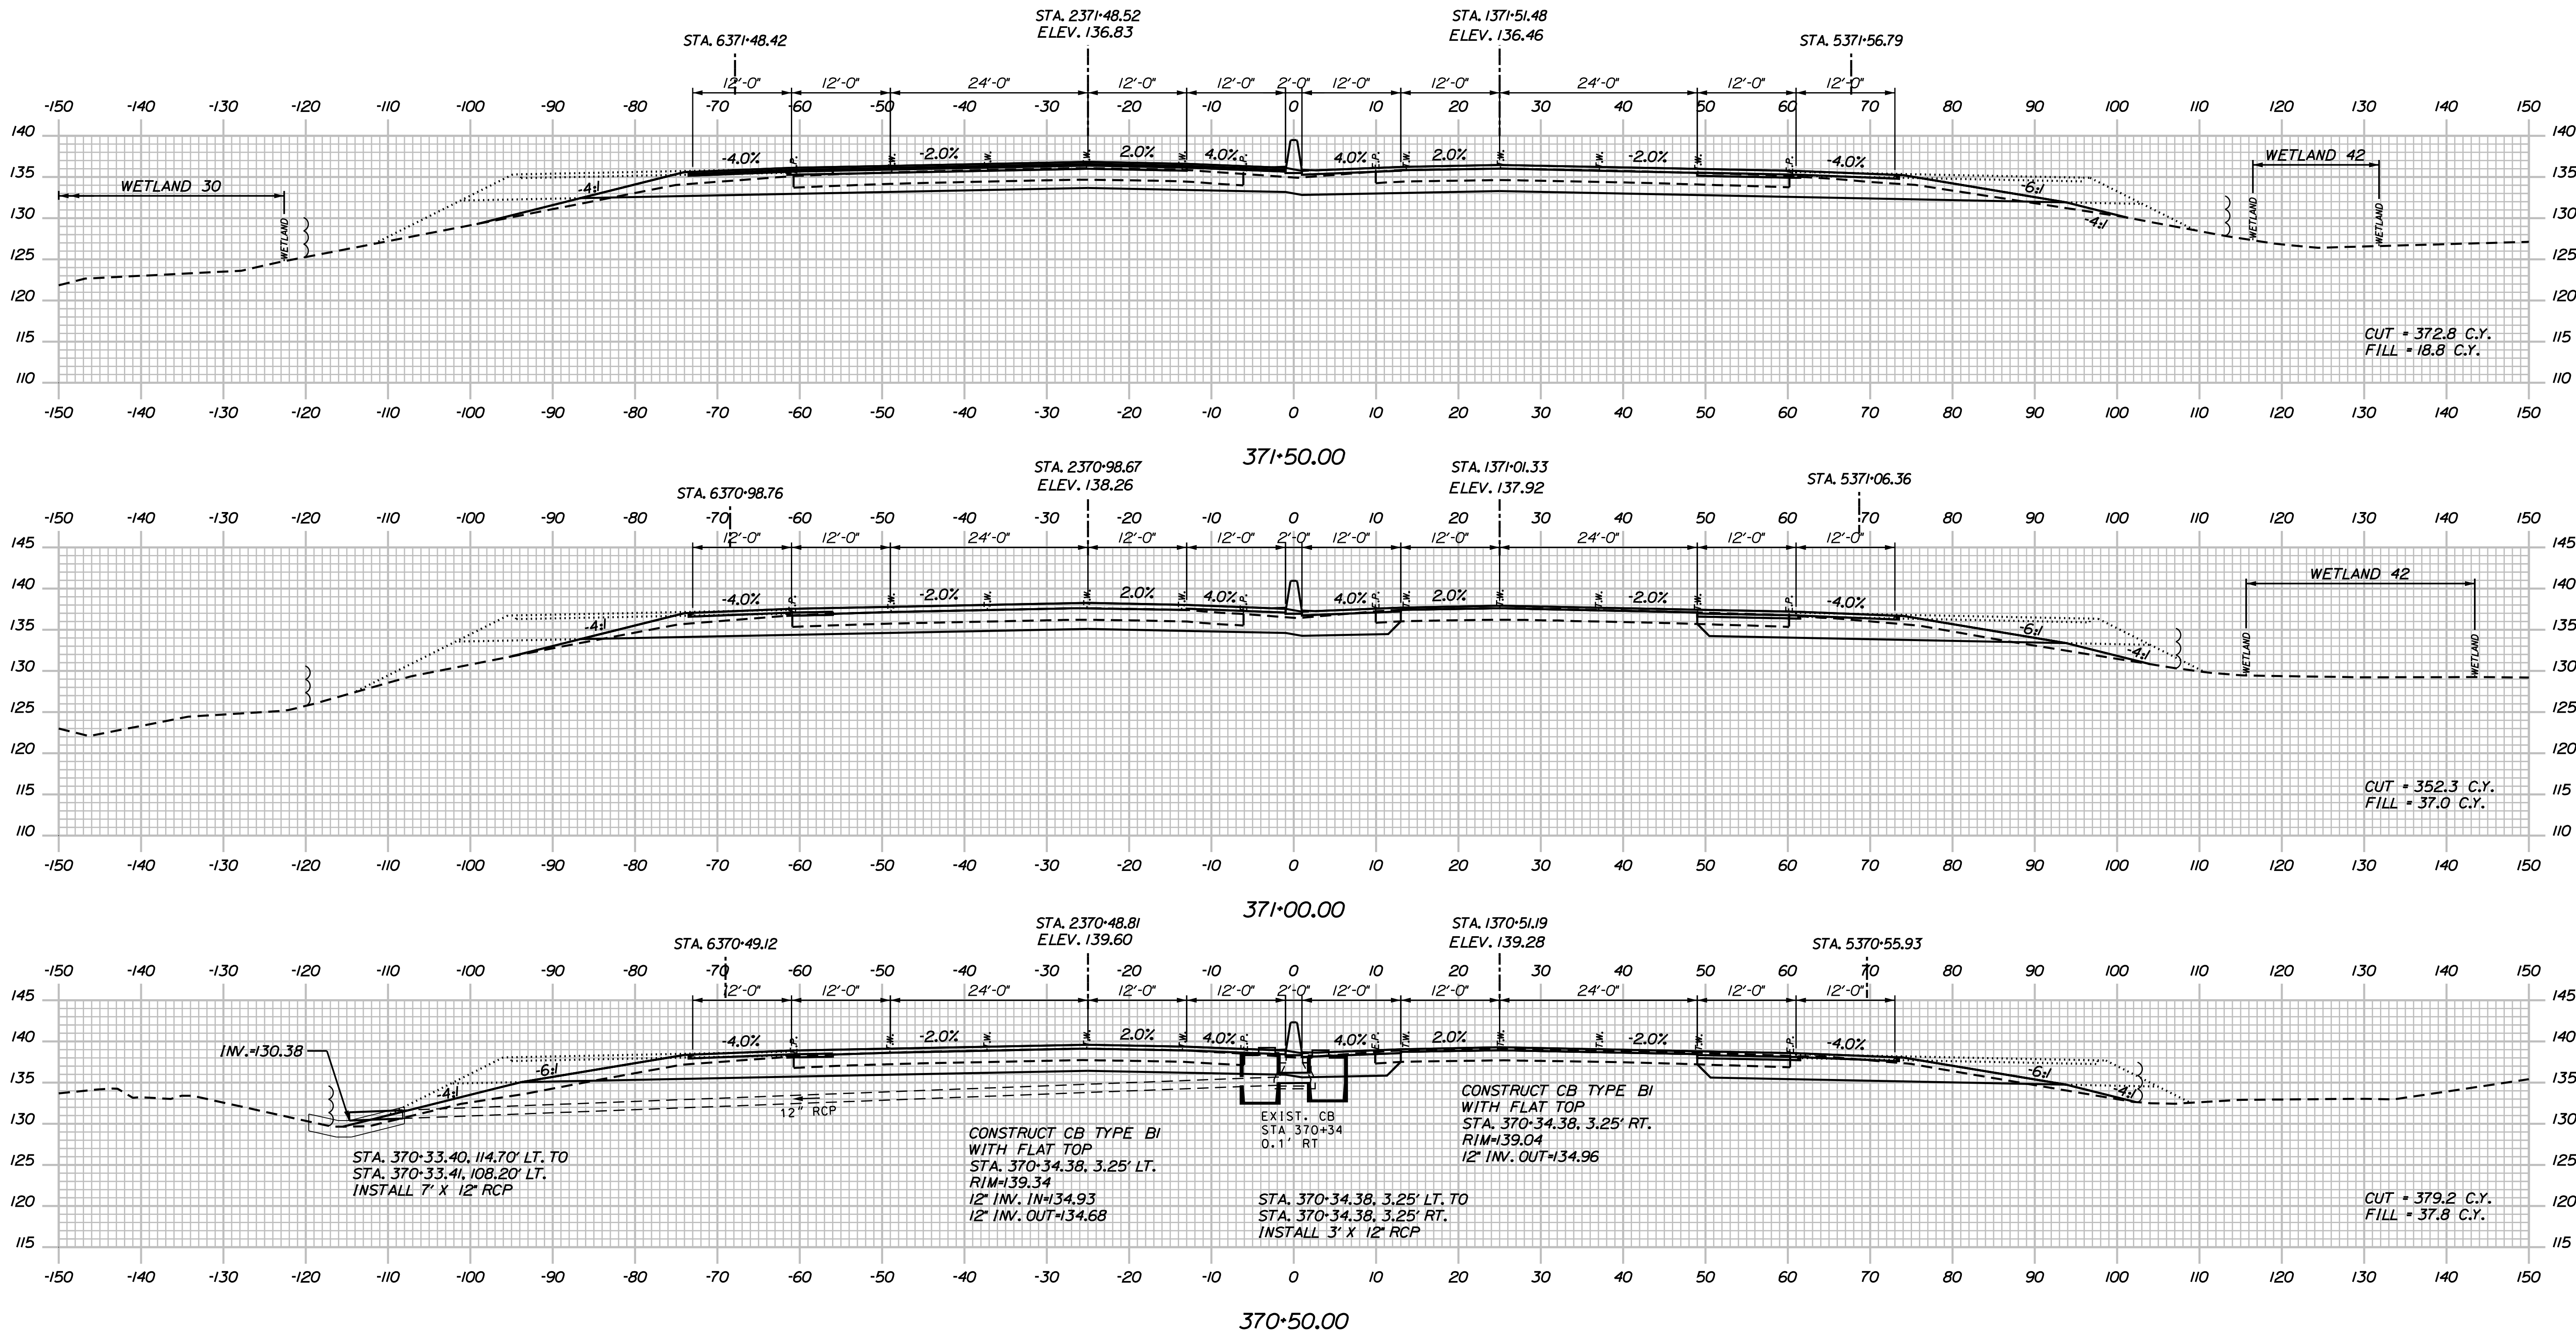

No.	Revision	By	Date

Designed by:

JACOBS

CONSULTANT PROJECT MANAGER: T. MORIN

	By	Date		By	Date
Designed	AMS	7-18	Checked	CSM	7-18
Drawn	SMG	7-18	In Charge of	TWM	7-18

JACOBS ENGINEERING GROUP
 120 ST. JAMES AVENUE
 BOSTON, MA 02116
 TEL (617) 242-9222
 FAX (617) 242-9824

THE GOLD STAR MEMORIAL HIGHWAY

MTA PROJECT MANAGER: R. NORWOOD

YORK TOLL PLAZA

I-95 CROSS SECTIONS
 STA. 370+50 TO STA. 371+50


SHEET NUMBER: XS-75

CONTRACT: 2018.20

273 OF 489

Date: 8/28/2018

Filename: ...0259637\Xsect14_195.dgn

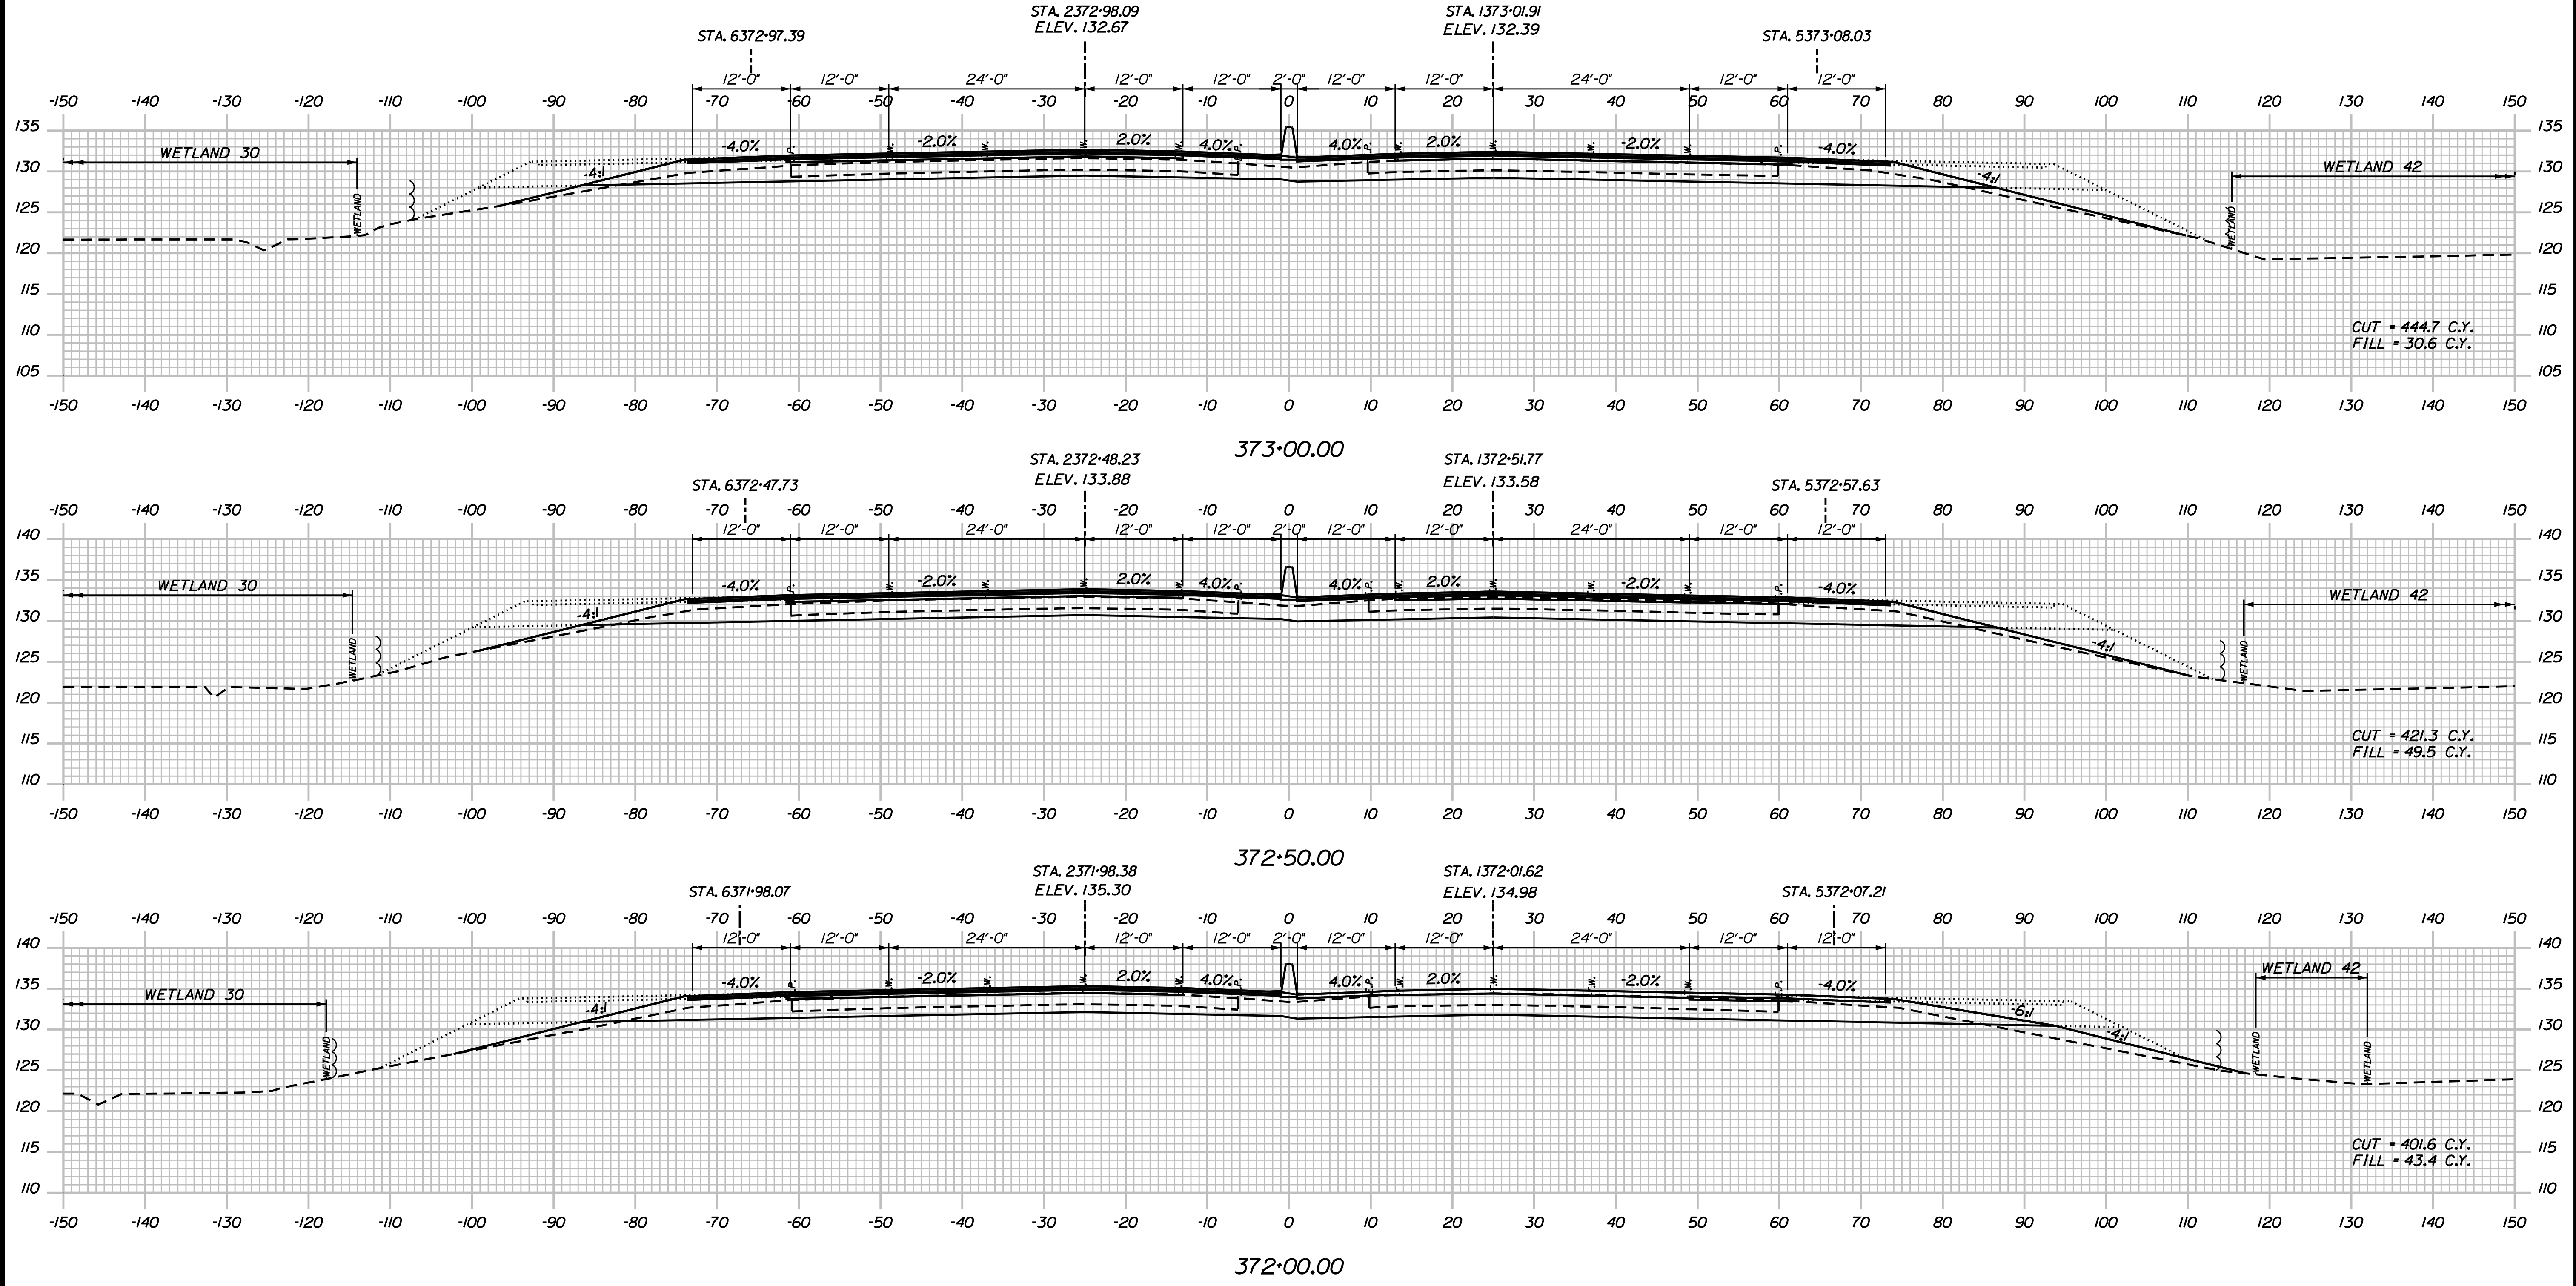

Scale: Scale of Feet

No.	Revision	By	Date

Designed by:

JACOBS

CONSULTANT PROJECT MANAGER: T. MORIN

	By	Date		By	Date
Designed	AMS	7-18	Checked	CSM	7-18
Drawn	SMG	7-18	In Charge of	TWM	7-18

JACOBS ENGINEERING GROUP
 120 ST. JAMES AVENUE
 BOSTON, MA 02116
 TEL (617) 242-9222
 FAX (617) 242-9824

MAINE TURNPIKE

THE GOLD STAR MEMORIAL HIGHWAY

MTA PROJECT MANAGER: R. NORWOOD

YORK TOLL PLAZA

I-95 CROSS SECTIONS
 STA. 372+00 TO STA. 373+00


SHEET NUMBER: XS-76

CONTRACT: 2018.20

274 OF 489

Date: 8/28/2018

Filename: ...0259637\Xsect14_195.dgn

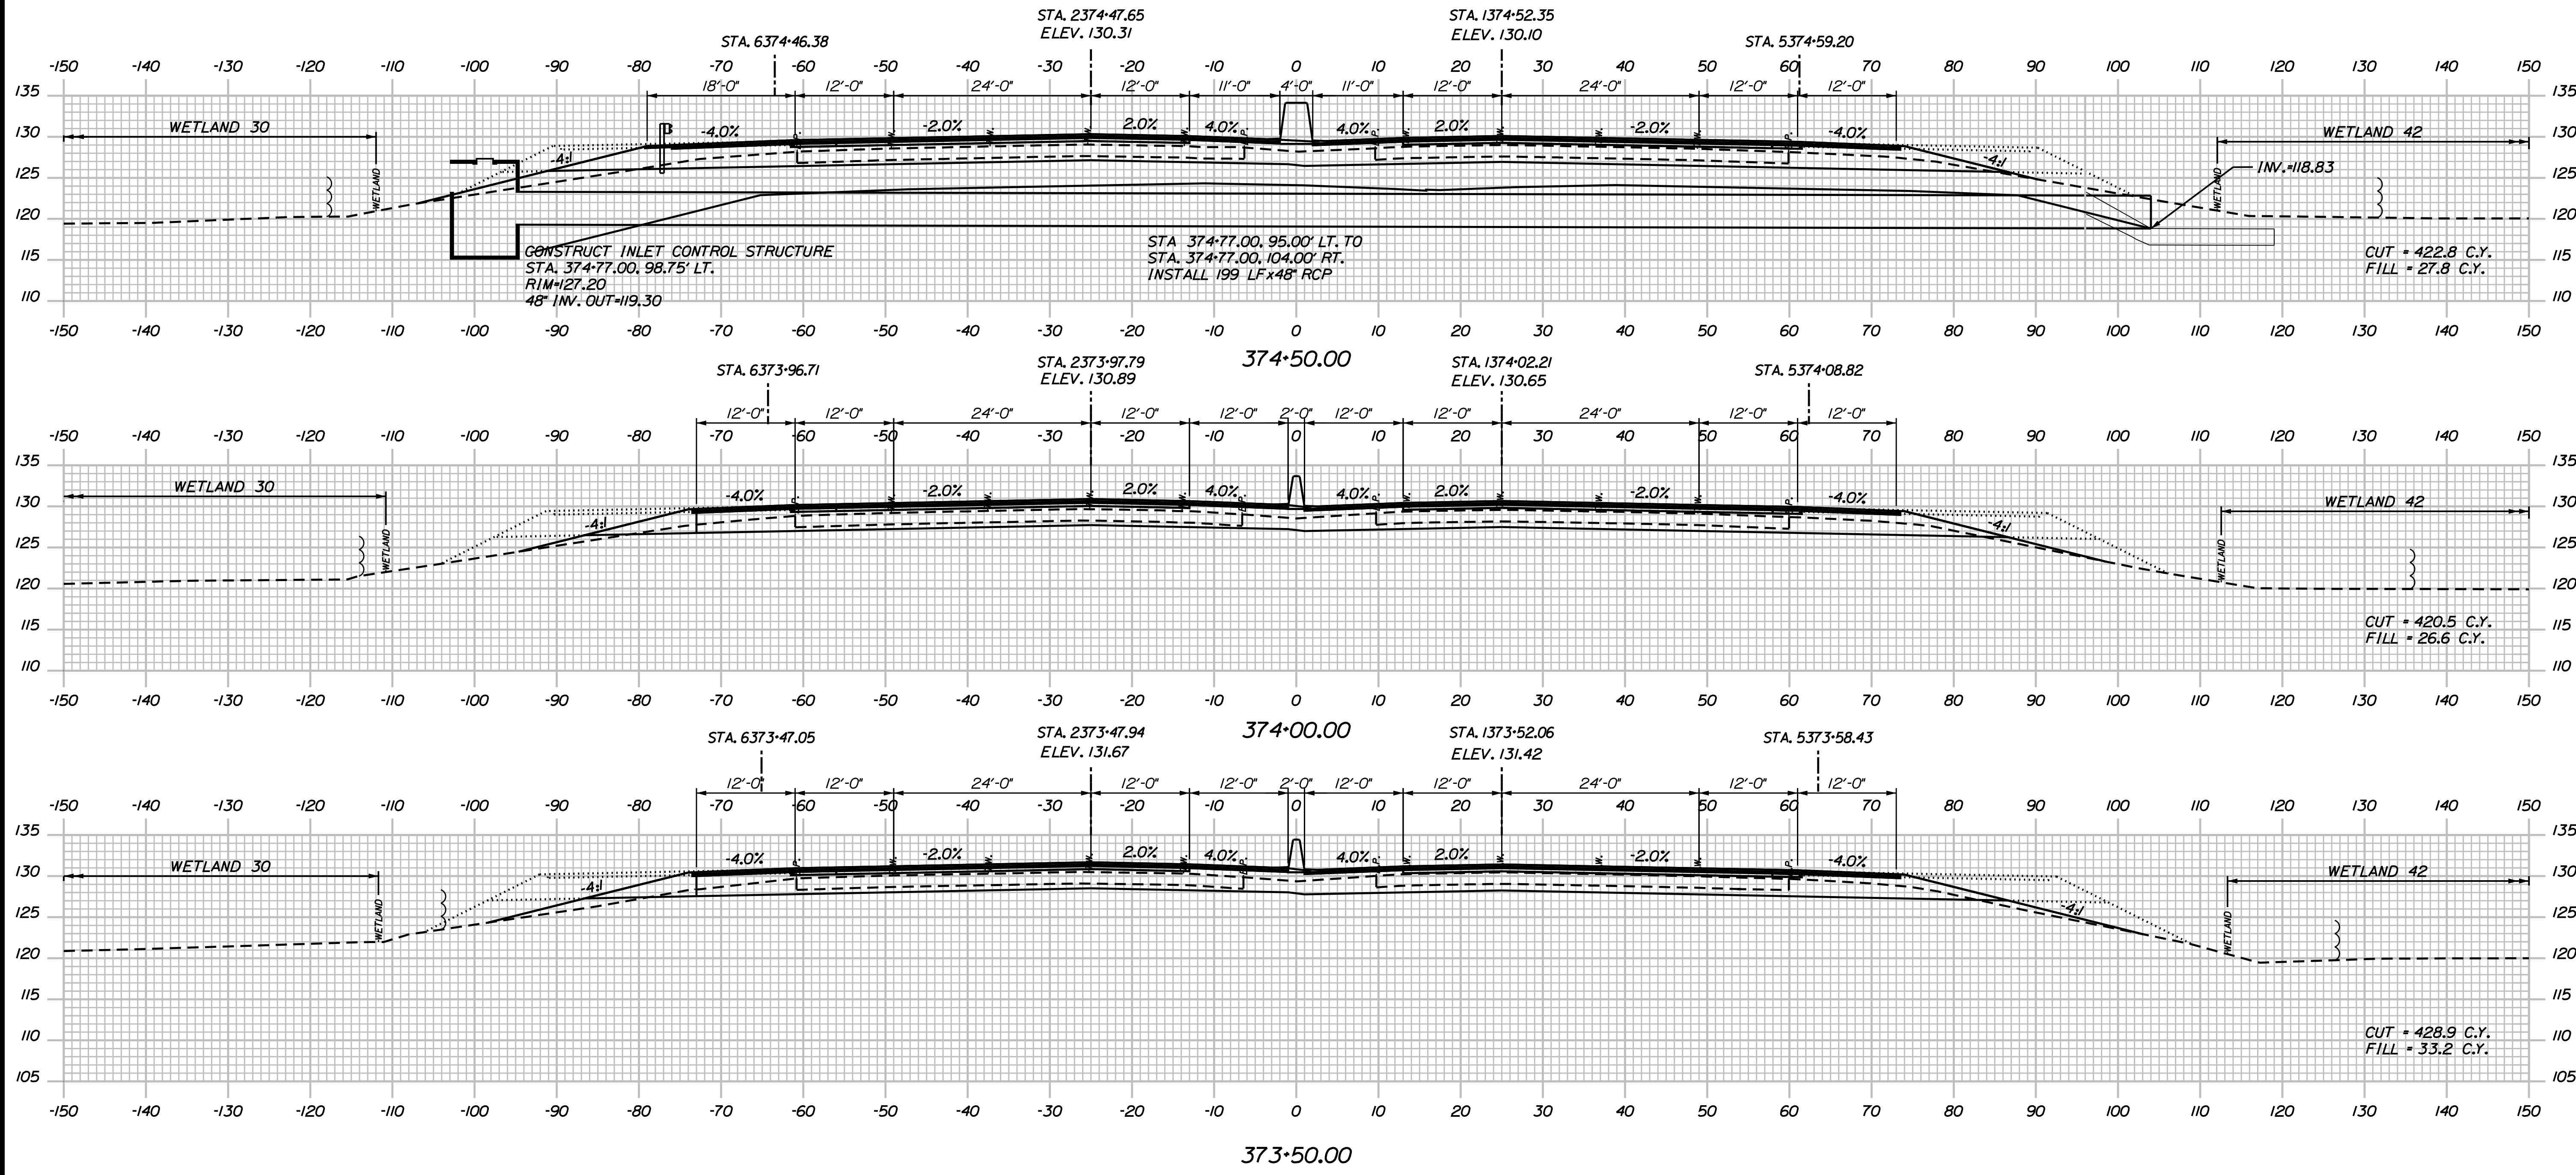

Scale:

No.	Revision	By	Date

Designed by:

JACOBS

CONSULTANT PROJECT MANAGER: T. MORIN

	By	Date		By	Date
Designed	AMS	7-18	Checked	CSM	7-18
Drawn	SMG	7-18	In Charge of	TWM	7-18

JACOBS ENGINEERING GROUP
 120 ST. JAMES AVENUE
 BOSTON, MA 02116
 TEL (617) 242-9222
 FAX (617) 242-9824

**THE GOLD STAR
 MEMORIAL HIGHWAY**

MTA PROJECT MANAGER: R. NORWOOD

YORK TOLL PLAZA

I-95 CROSS SECTIONS
 STA. 373+50 TO STA. 374+50


SHEET NUMBER: XS-77

CONTRACT: 2018.20

275 OF 489

Date: 8/28/2018

Filename: ...00259637\Xsect14_195.dgn

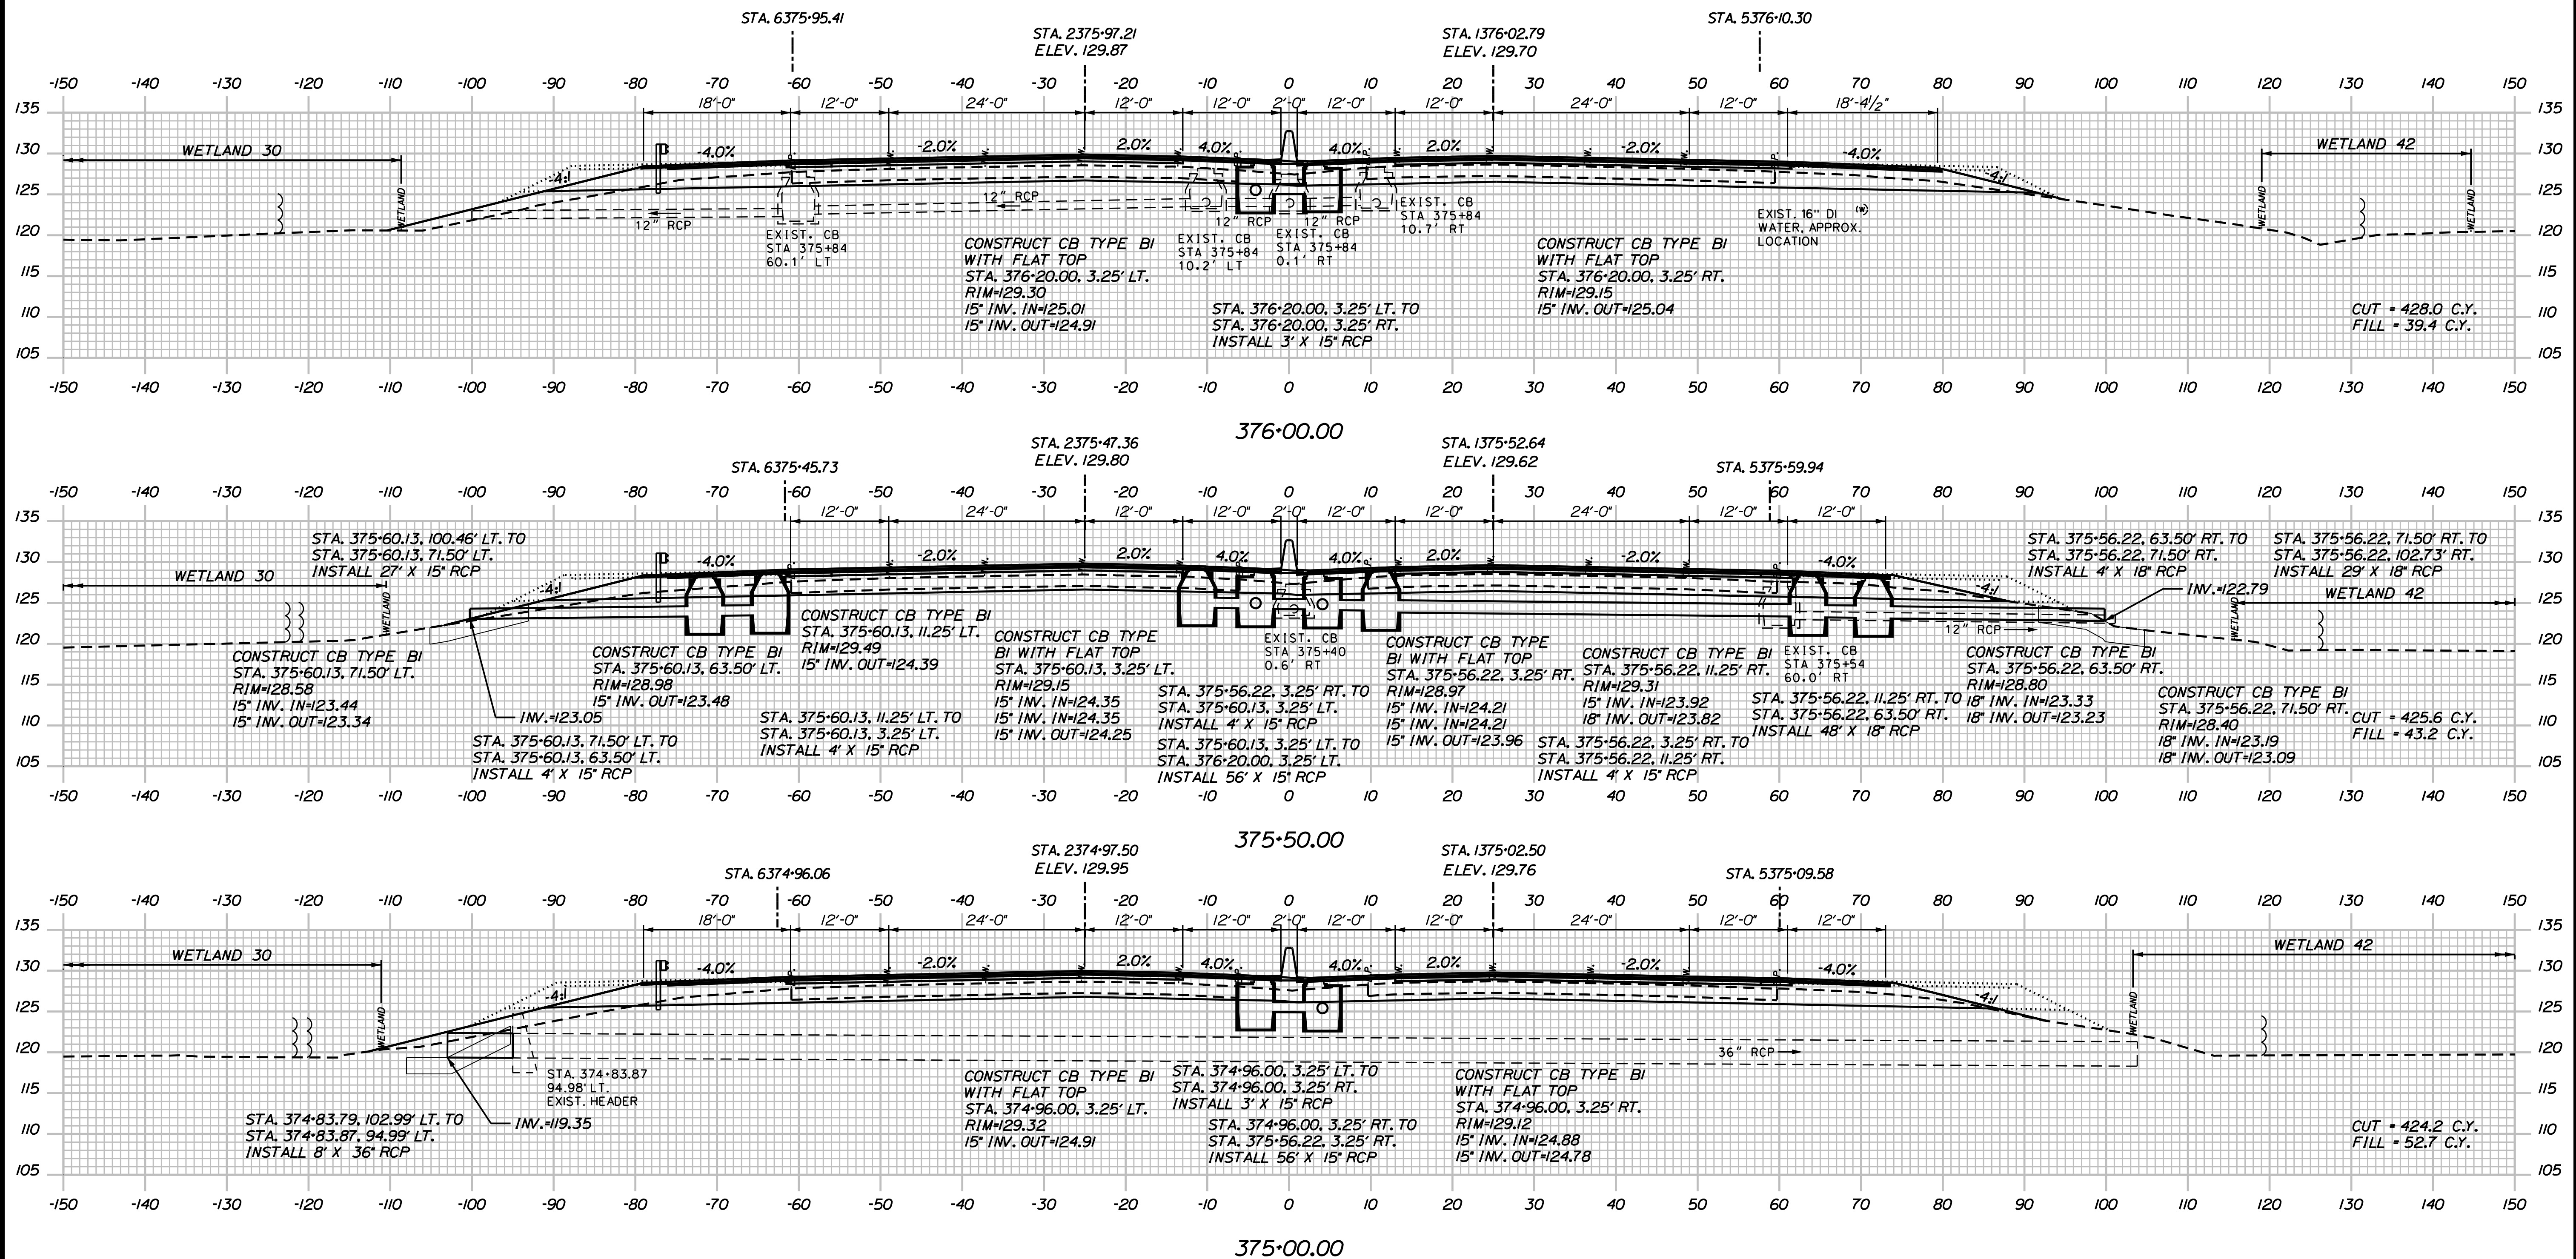

Scale:

No.	Revision	By	Date

Designed by:

JACOBS

CONSULTANT PROJECT MANAGER: T. MORIN

	By	Date		By	Date
Designed	AMS	7-18	Checked	CSM	7-18
Drawn	SMG	7-18	In Charge of	TWM	7-18

JACOBS ENGINEERING GROUP
 120 ST. JAMES AVENUE
 BOSTON, MA 02116
 TEL (617) 242-9222
 FAX (617) 242-9824

THE GOLD STAR MEMORIAL HIGHWAY

MTA PROJECT MANAGER: R. NORWOOD

YORK TOLL PLAZA

I-95 CROSS SECTIONS
 STA. 375+00 TO STA. 376+00


SHEET NUMBER: XS-78

CONTRACT: 2018.20

276 OF 489

Date: 8/28/2018

Filename: ...0259637\Xsect14_195.dgn

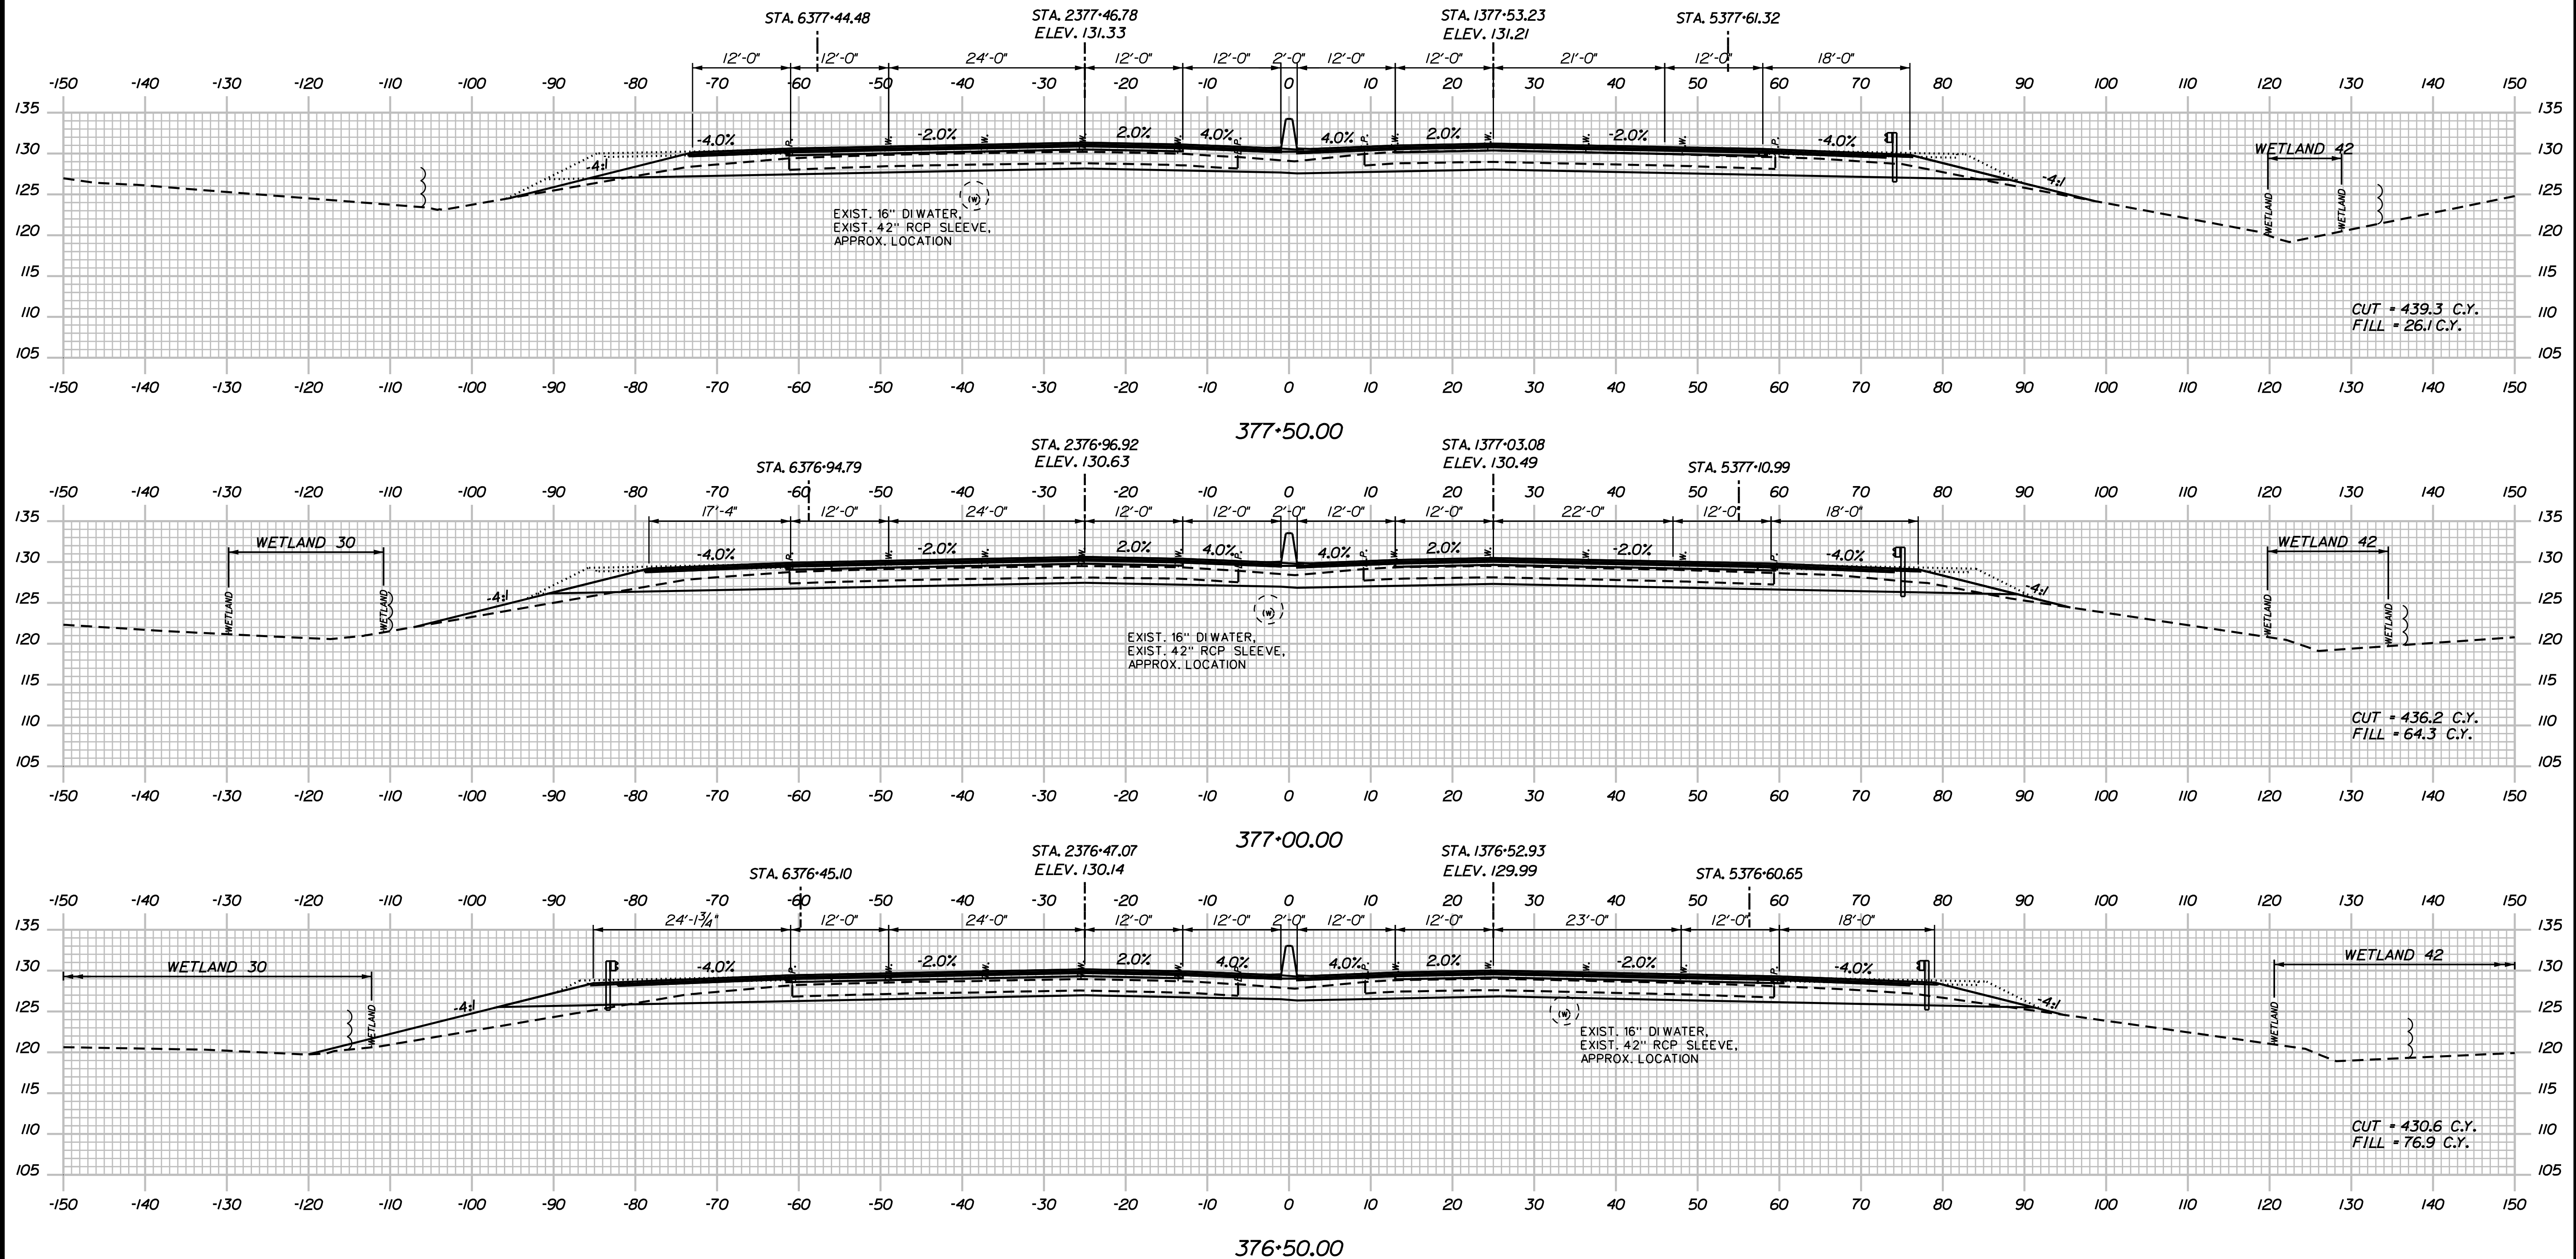

Scale:

No.	Revision	By	Date

Designed by:

JACOBS

CONSULTANT PROJECT MANAGER: T. MORIN

	By	Date		By	Date
Designed	AMS	7-18	Checked	CSM	7-18
Drawn	SMG	7-18	In Charge of	TWM	7-18

JACOBS ENGINEERING GROUP
 120 ST. JAMES AVENUE
 BOSTON, MA 02116
 TEL (617) 242-9222
 FAX (617) 242-9824

THE GOLD STAR MEMORIAL HIGHWAY

MTA PROJECT MANAGER: R. NORWOOD

YORK TOLL PLAZA

I-95 CROSS SECTIONS
 STA. 376+50 TO STA. 377+50




SHEET NUMBER: XS-79

CONTRACT: 2018.20

277 OF 489

Date: 8/28/2018

Filename: ...0259637\Xsect14_195.dgn

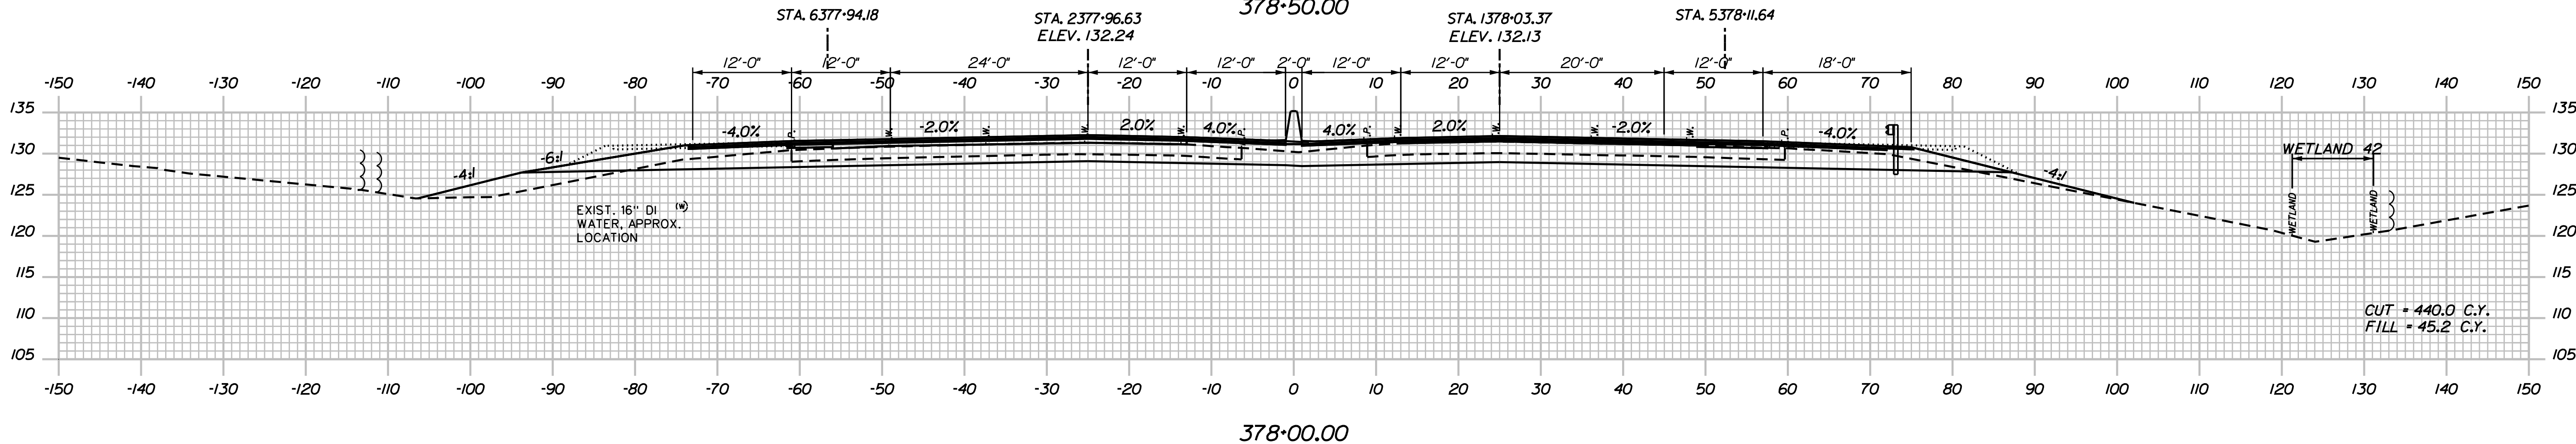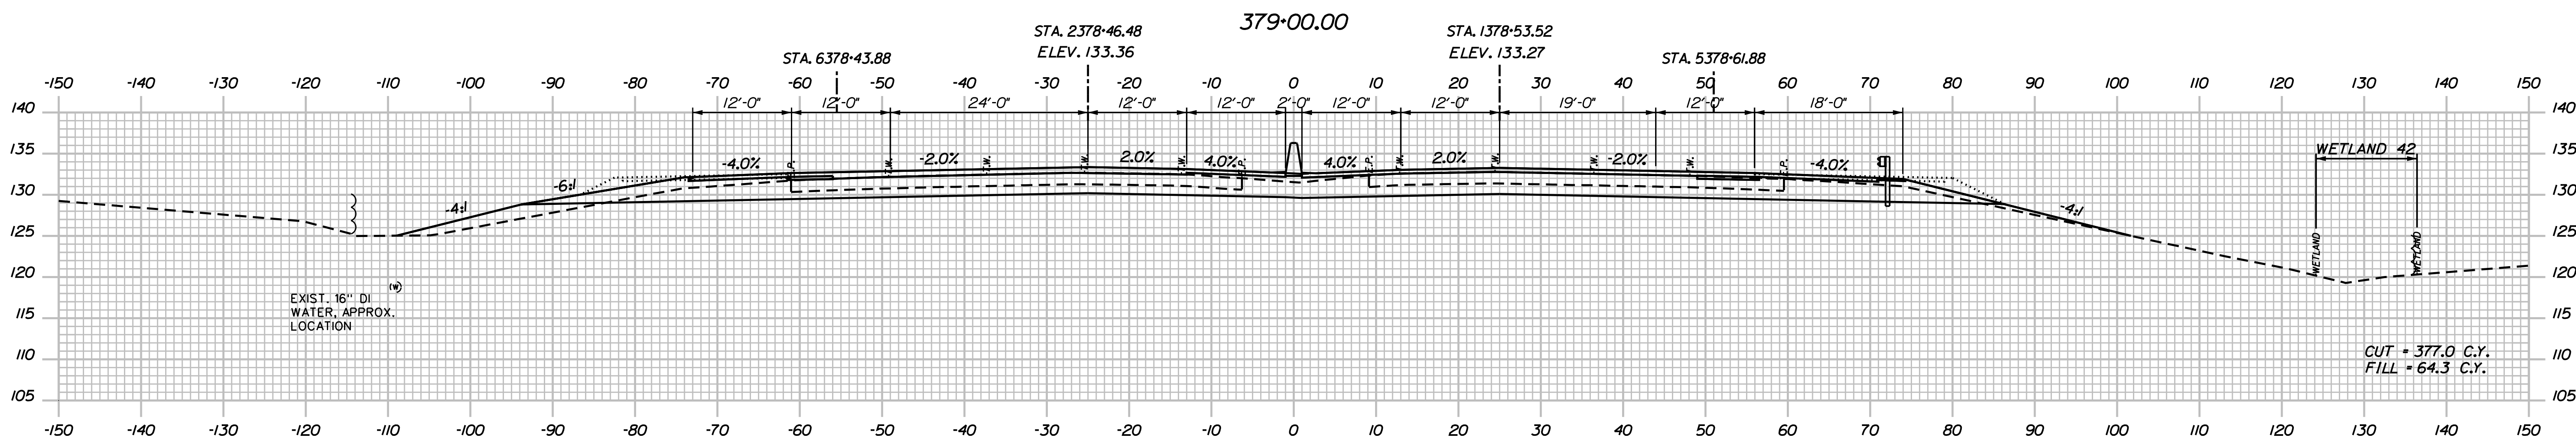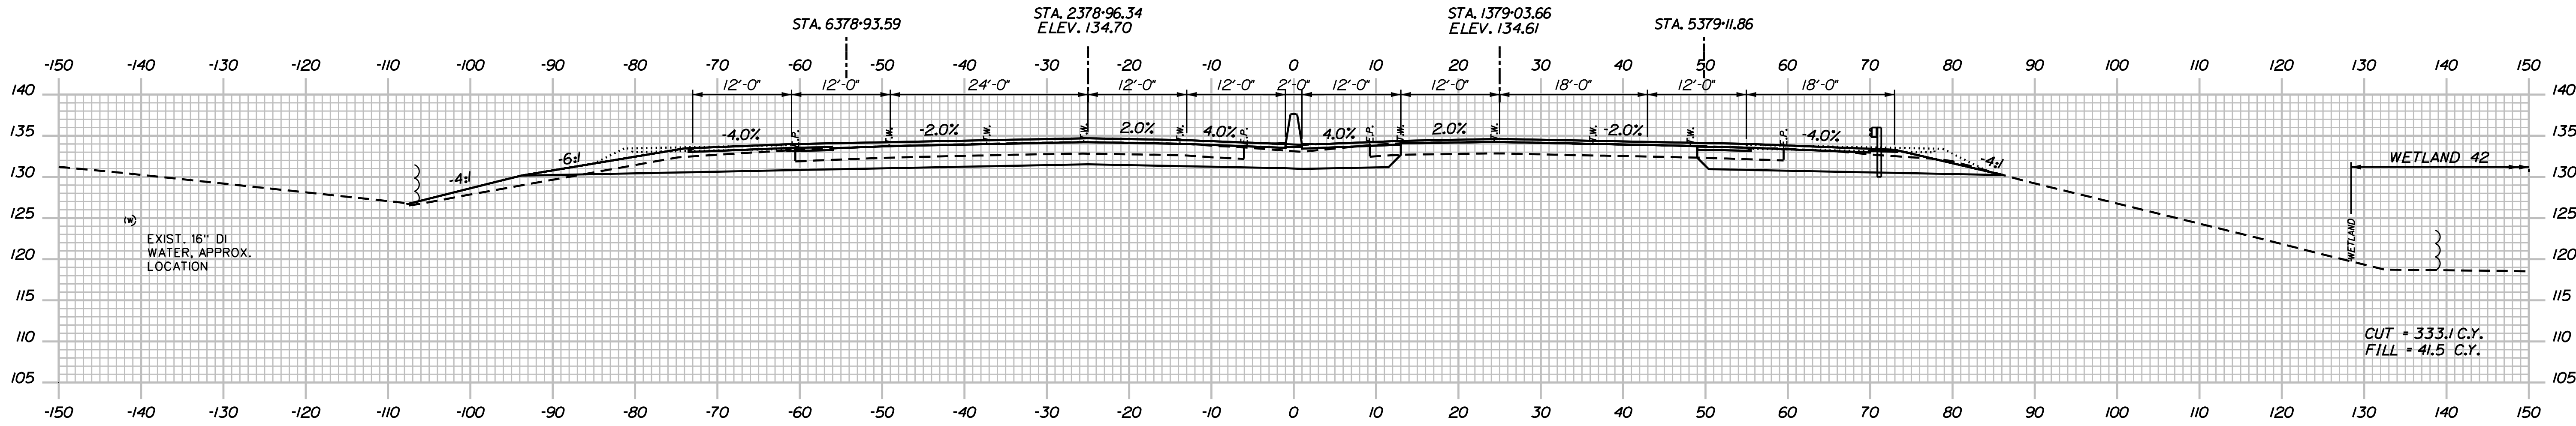

Scale:

No.	Revision	By	Date

Designed by:

JACOBS

CONSULTANT PROJECT MANAGER: T. MORIN

	By	Date		By	Date
Designed	AMS	7-18	Checked	CSM	7-18
Drawn	SMG	7-18	In Charge of	TWM	7-18

JACOBS ENGINEERING GROUP
 120 ST. JAMES AVENUE
 BOSTON, MA 02116
 TEL (617) 242-9222
 FAX (617) 242-9824

THE GOLD STAR MEMORIAL HIGHWAY

MTA PROJECT MANAGER: R. NORWOOD

YORK TOLL PLAZA

I-95 CROSS SECTIONS
 STA. 378+00 TO STA. 379+00




SHEET NUMBER: XS-80

CONTRACT: 2018.20

278 OF 489

Date: 8/28/2018

Filename: ...0259637\Xsect14_195.dgn

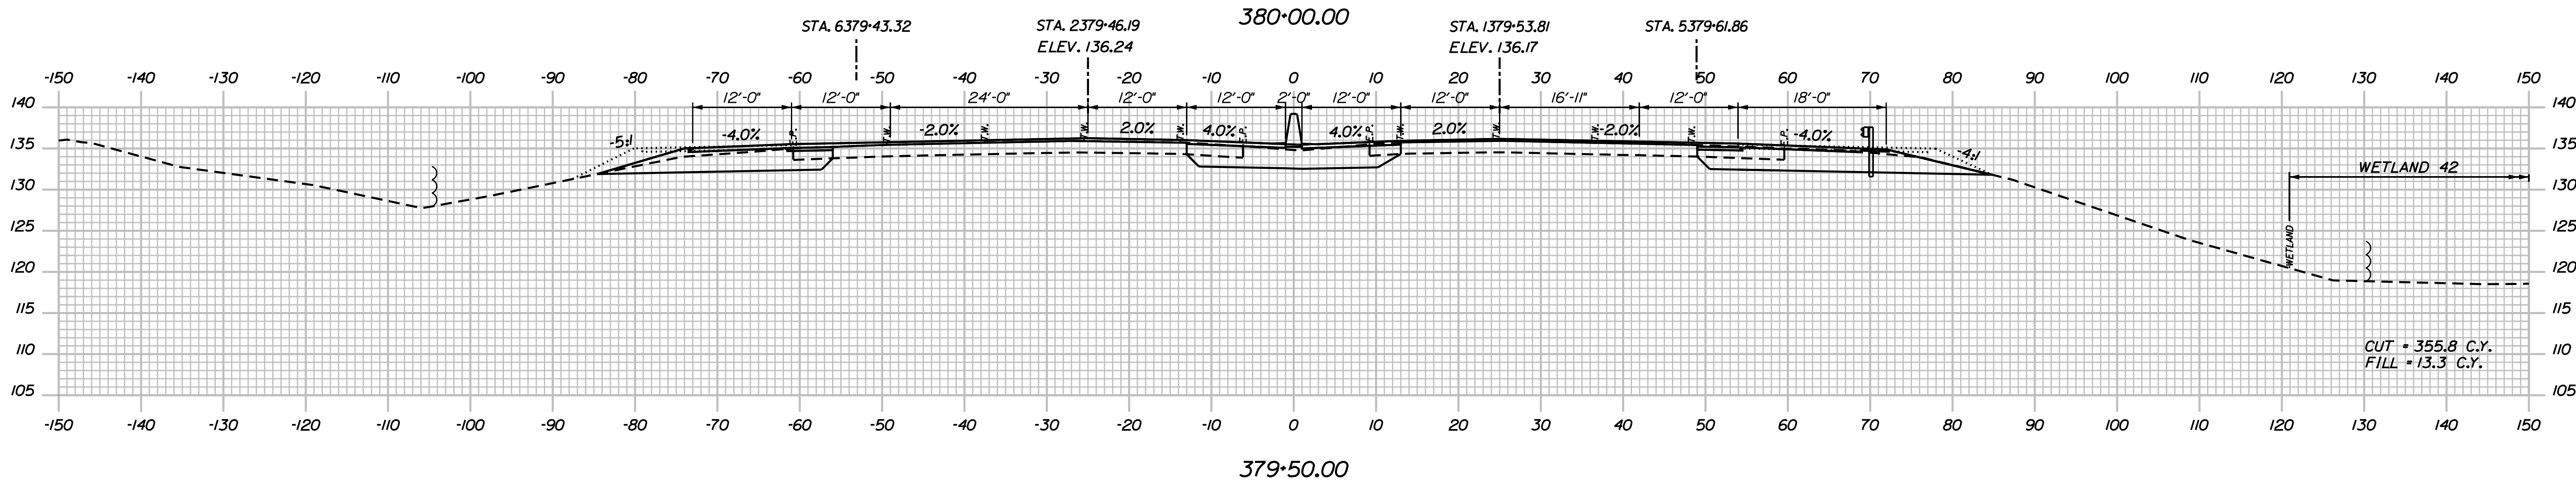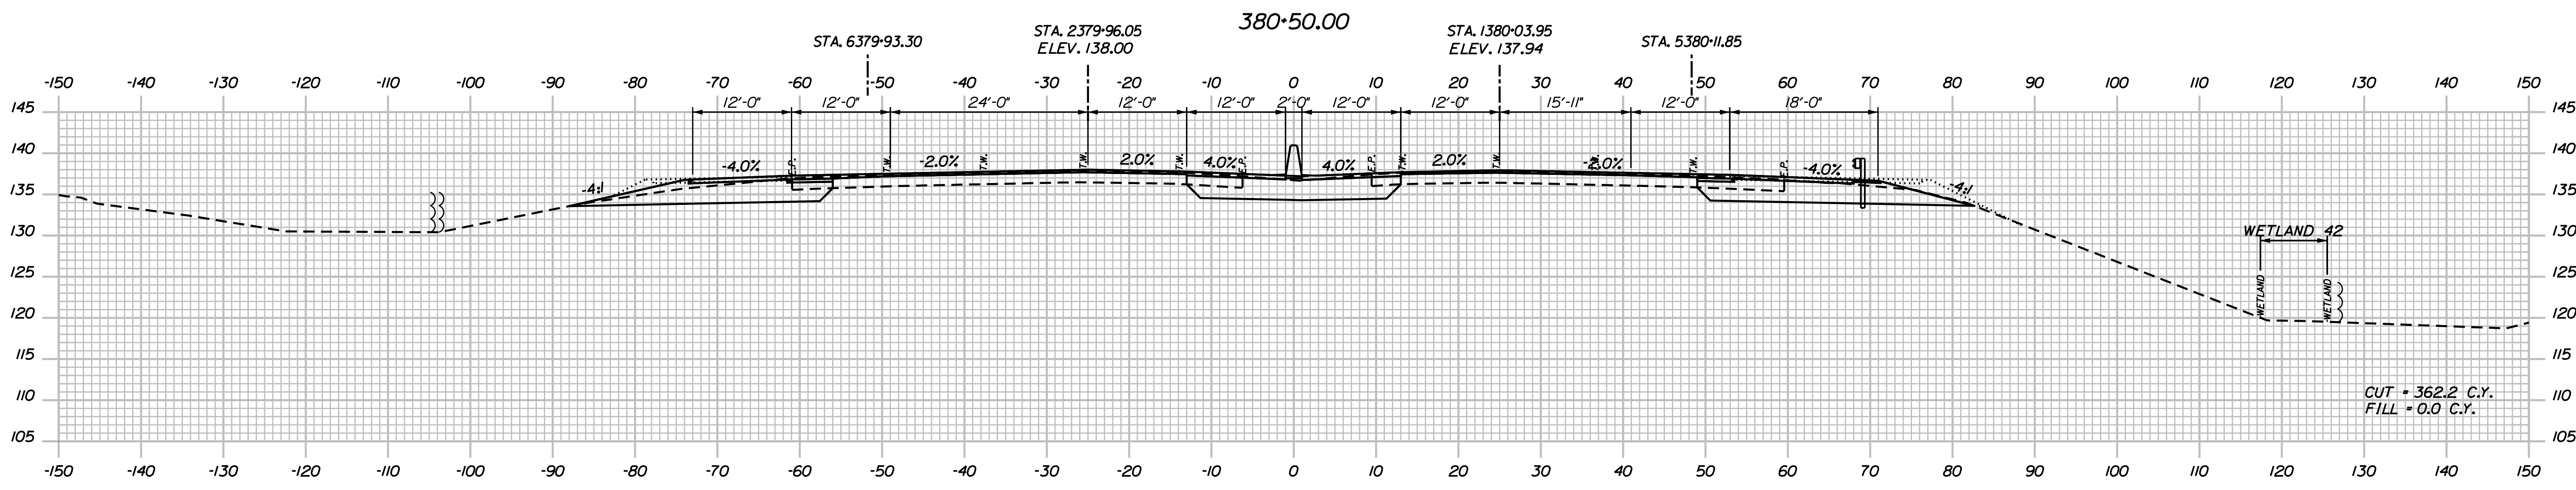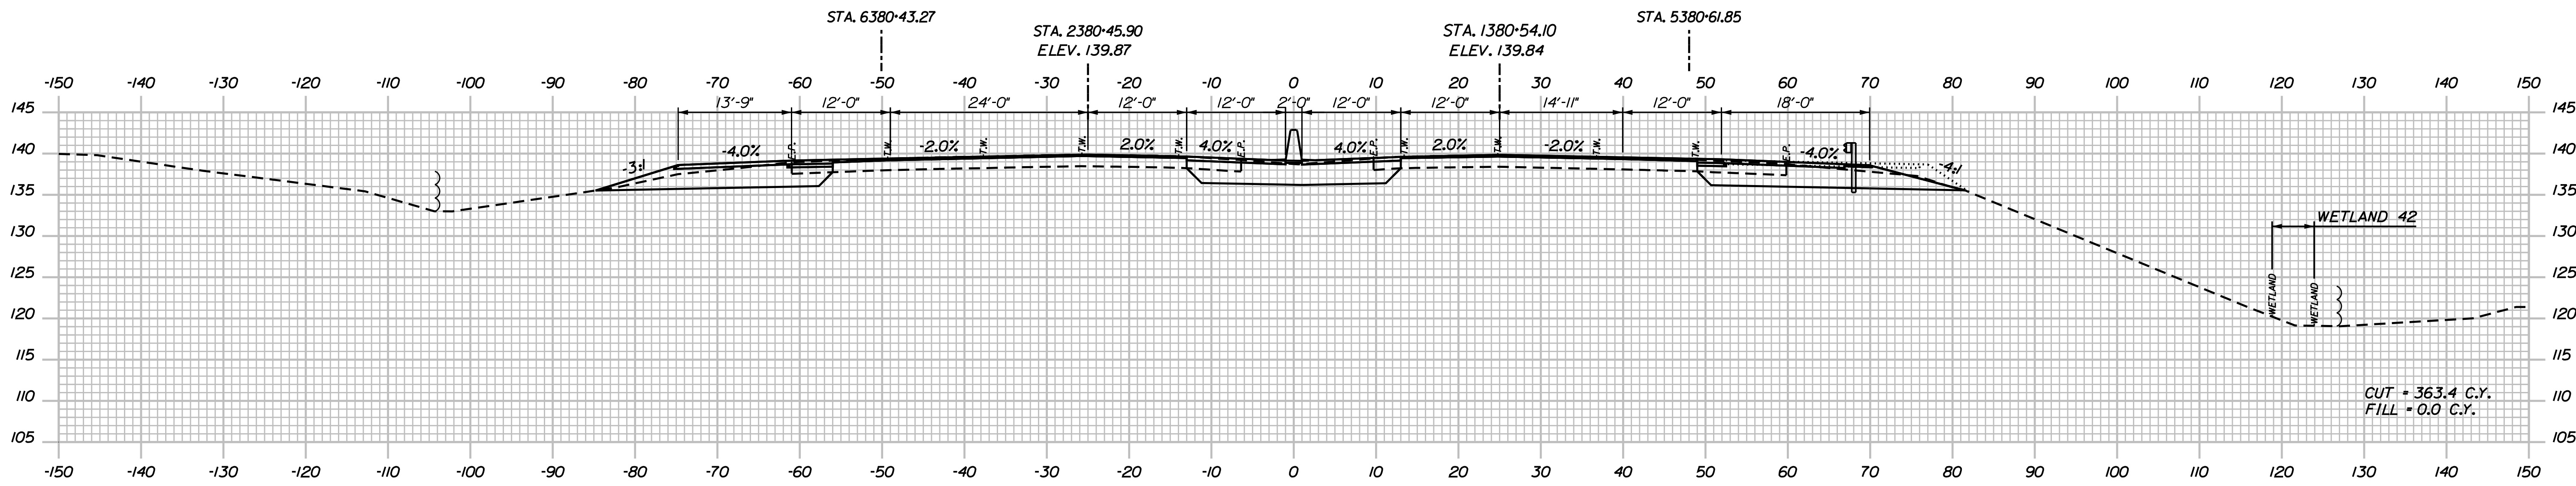

Scale: Scale of Feet

No.	Revision	By	Date

Designed by:

JACOBS

CONSULTANT PROJECT MANAGER: T. MORIN

	By	Date		By	Date
Designed	AMS	7-18	Checked	CSM	7-18
Drawn	SMG	7-18	In Charge of	TWM	7-18

JACOBS ENGINEERING GROUP
 120 ST. JAMES AVENUE
 BOSTON, MA 02116
 TEL (617) 242-9222
 FAX (617) 242-9824

MAINE TURNPIKE

THE GOLD STAR MEMORIAL HIGHWAY

MTA PROJECT MANAGER: R. NORWOOD

YORK TOLL PLAZA

I-95 CROSS SECTIONS
 STA. 379+50 TO STA. 380+50


SHEET NUMBER: XS-81

CONTRACT: 2018.20

279 OF 489

Date: 8/28/2018

Filename: ...02596371\Xsect14_195.dgn

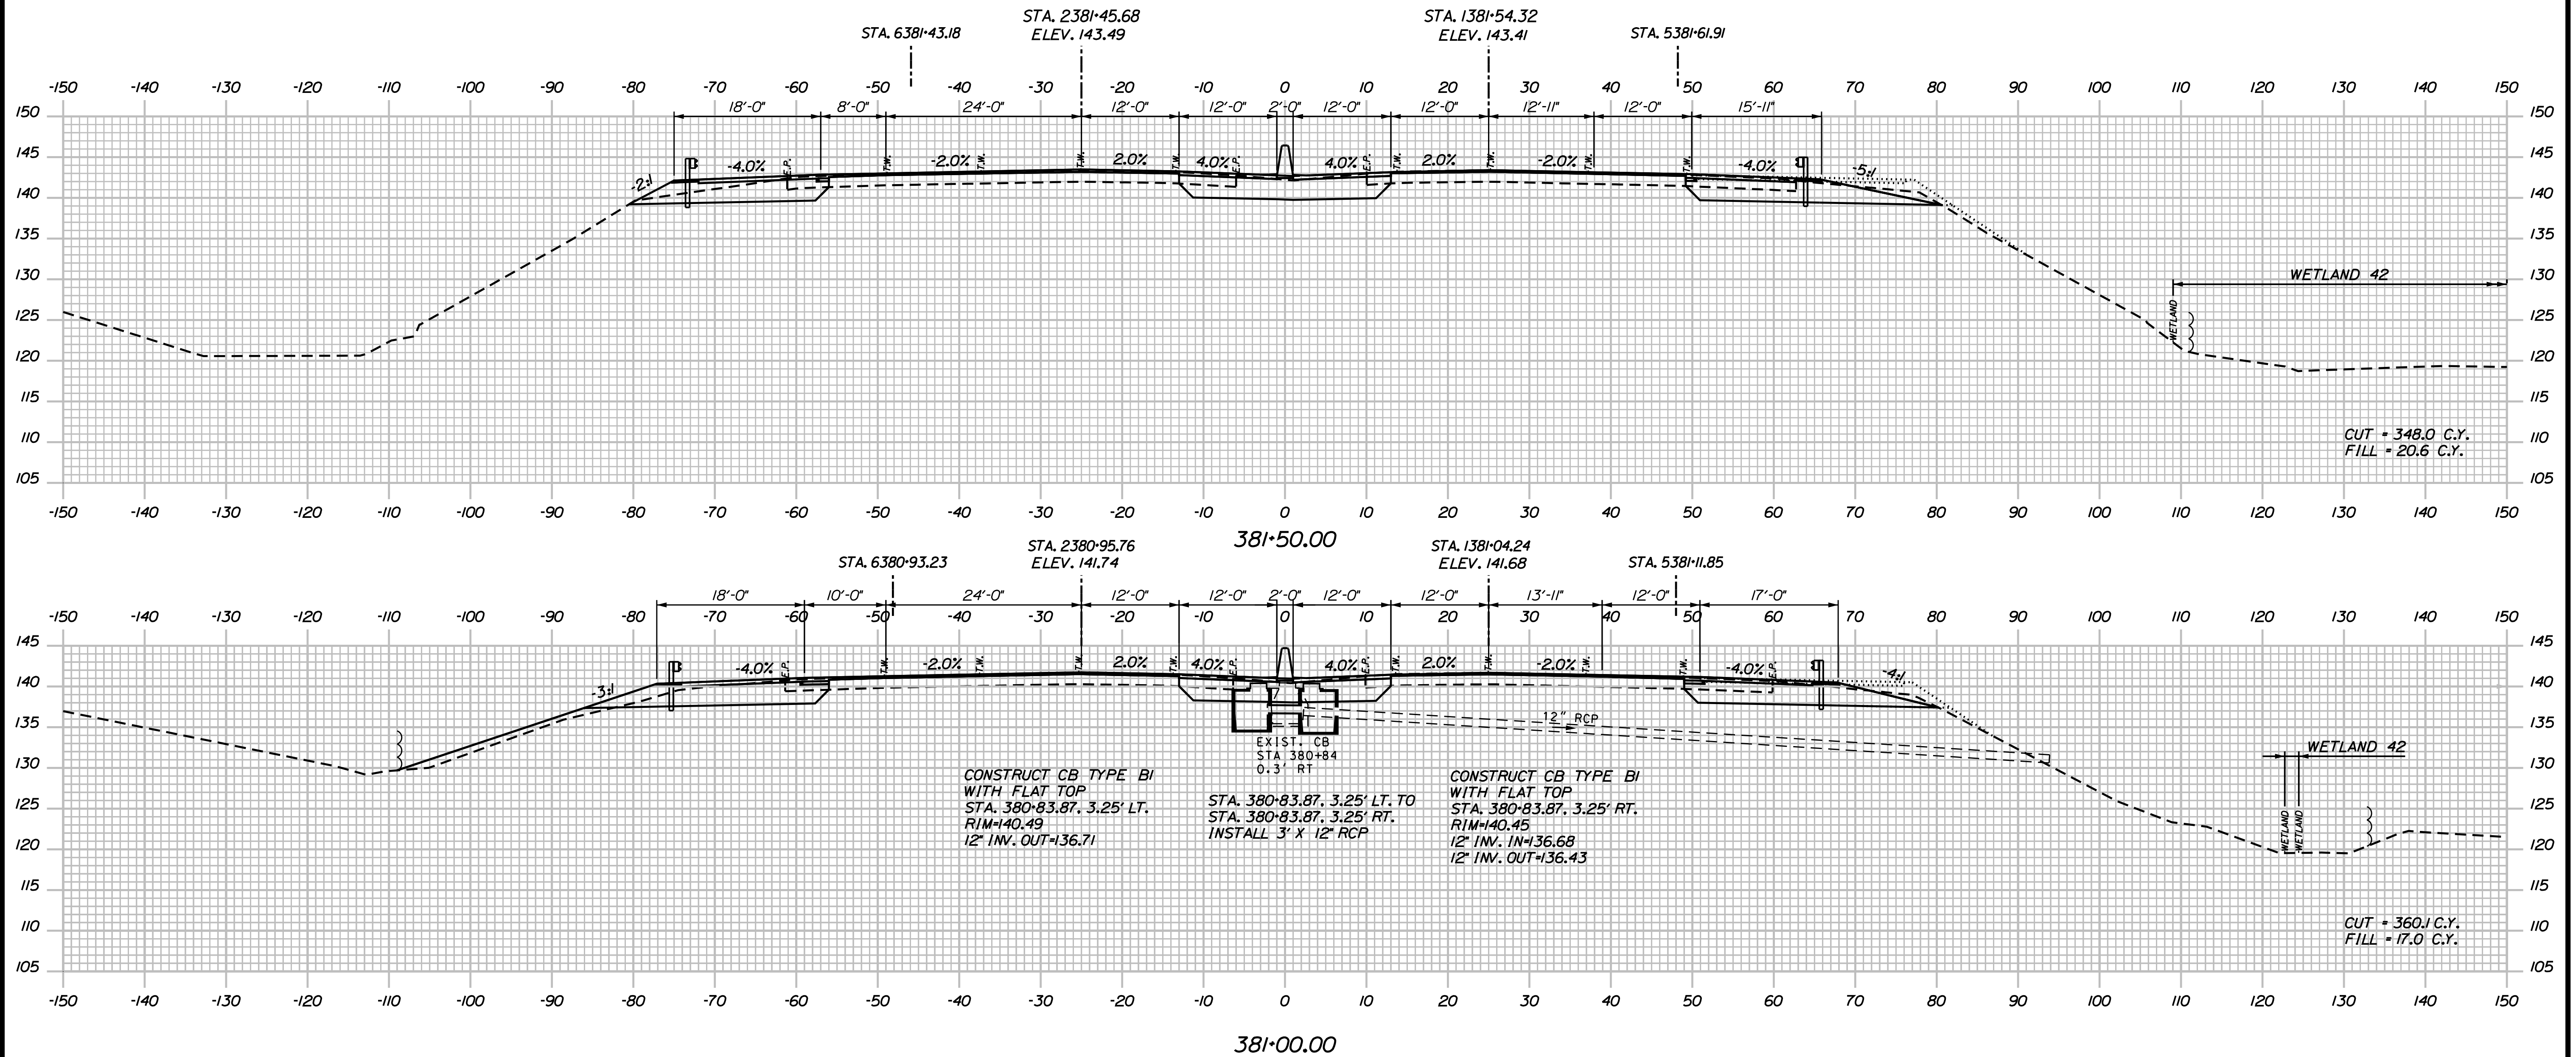

Scale:

No.	Revision	By	Date

Designed by:

JACOBS

CONSULTANT PROJECT MANAGER: T. MORIN

	By	Date		By	Date
Designed	AMS	7-18	Checked	CSM	7-18
Drawn	SMG	7-18	In Charge of	TWM	7-18

JACOBS ENGINEERING GROUP
 120 ST. JAMES AVENUE
 BOSTON, MA 02116
 TEL (617) 242-9222
 FAX (617) 242-9824

THE GOLD STAR MEMORIAL HIGHWAY

MTA PROJECT MANAGER: R. NORWOOD

YORK TOLL PLAZA

I-95 CROSS SECTIONS
 STA. 381+00 TO STA. 381+50



SHEET NUMBER: XS-82

CONTRACT: 2018.20

280 OF 489

Date: 8/28/2018

Filename: ...002596371\Xsect15_195.dgn

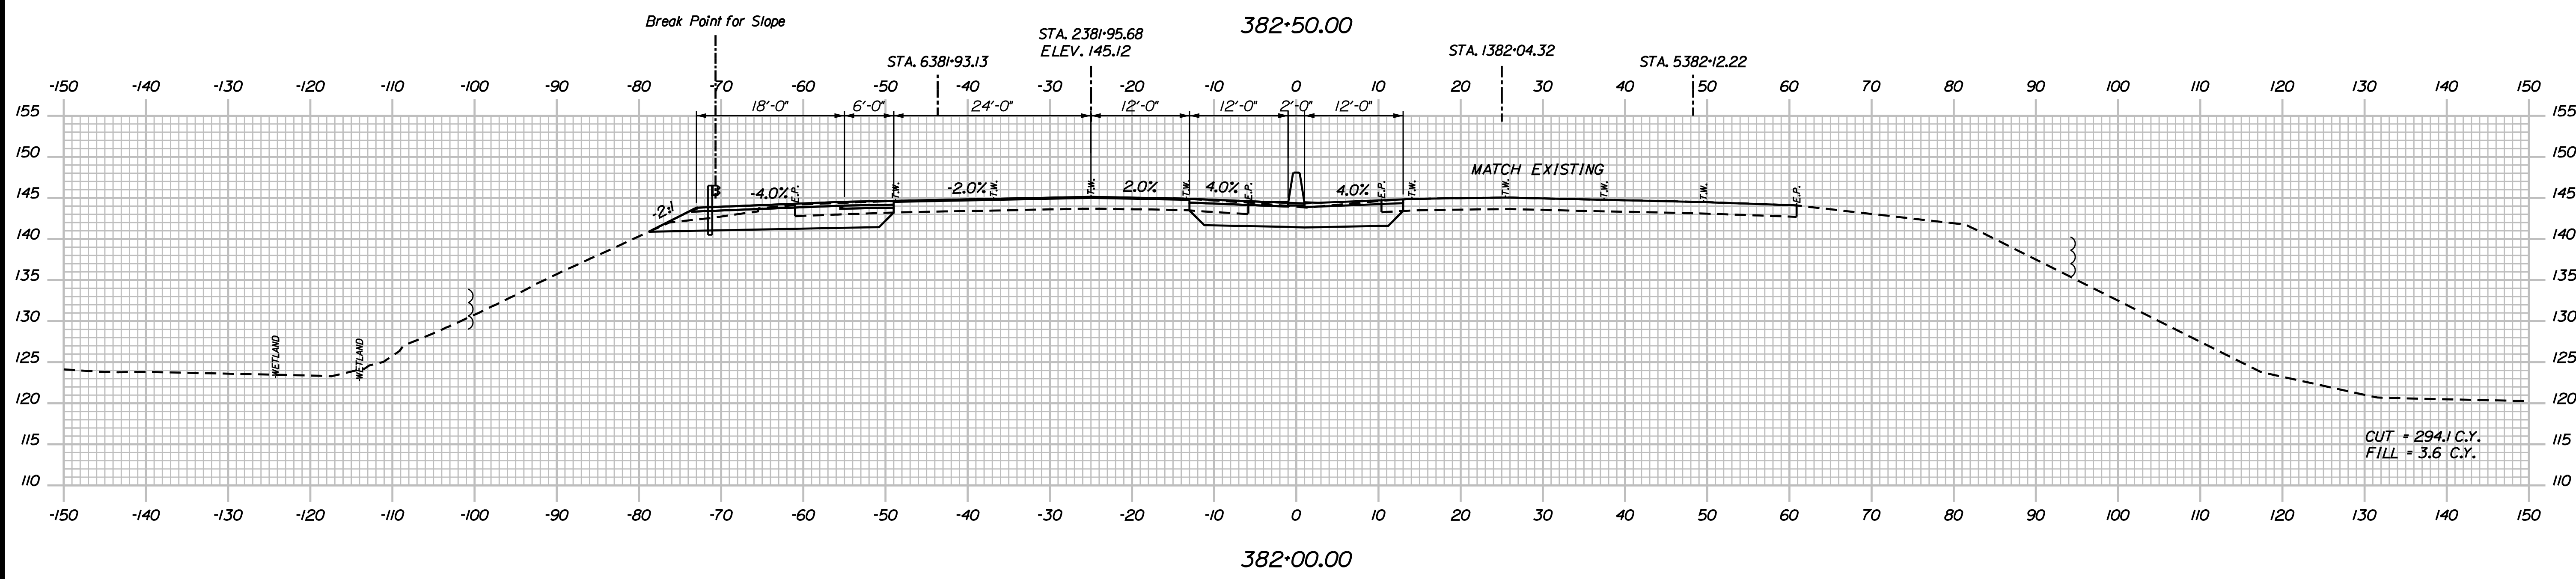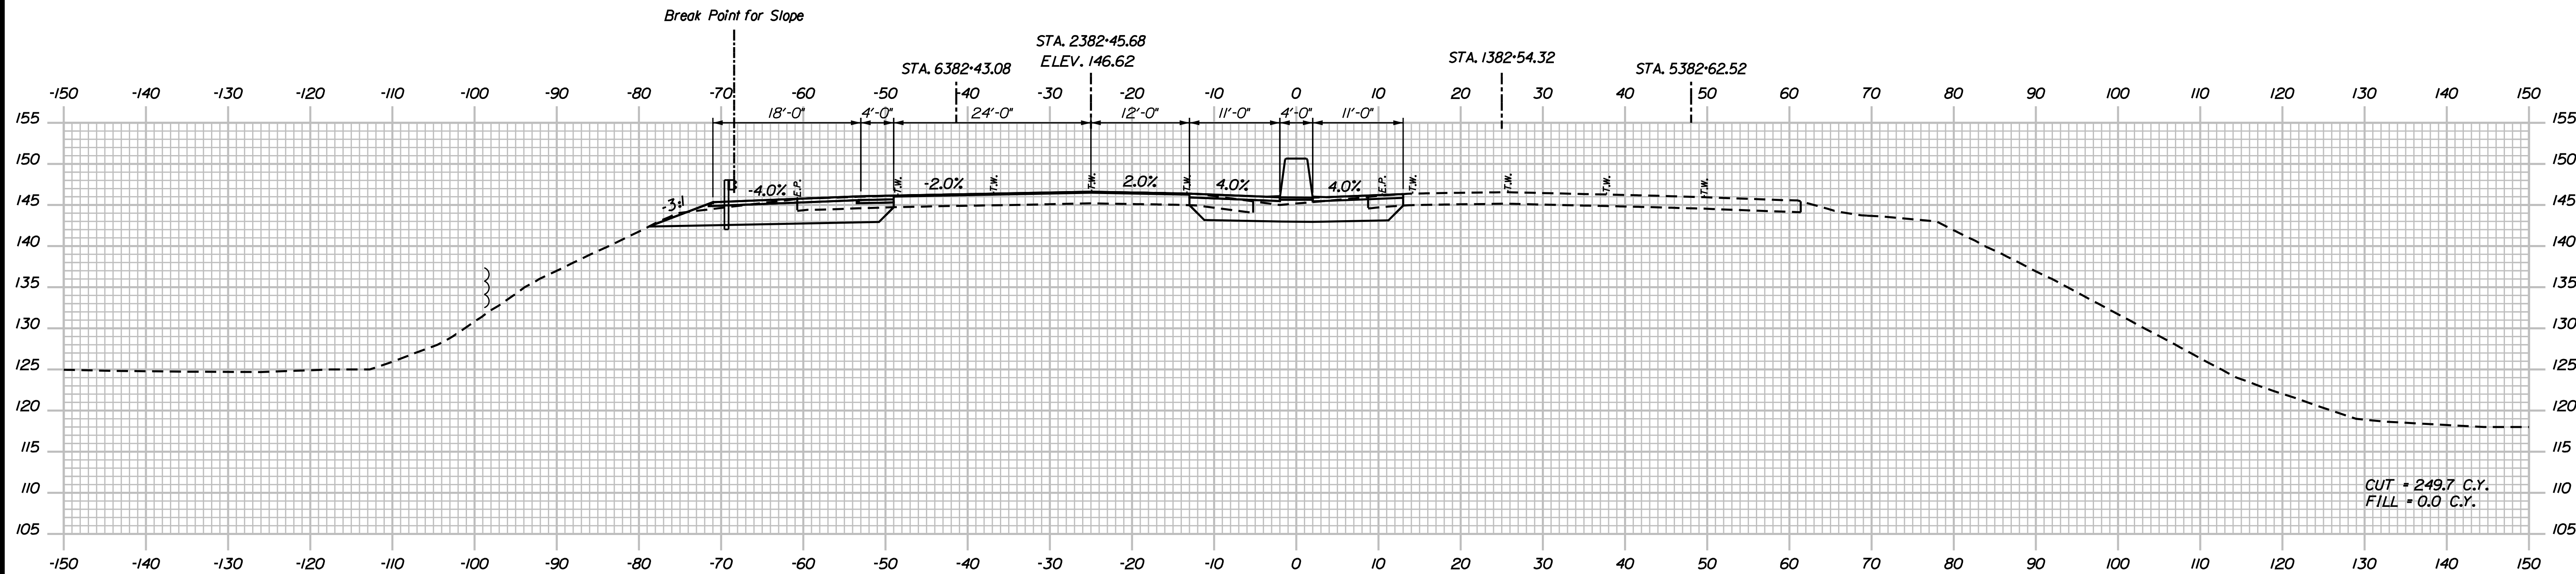

Scale: Scale of Feet

No.	Revision	By	Date

Designed by:

JACOBS

CONSULTANT PROJECT MANAGER: T. MORIN

	By	Date		By	Date
Designed	AMS	7-18	Checked	CSM	7-18
Drawn	SMG	7-18	In Charge of	TWM	7-18

JACOBS ENGINEERING GROUP
 120 ST. JAMES AVENUE
 BOSTON, MA 02116
 TEL (617) 242-9222
 FAX (617) 242-9824

**THE GOLD STAR
 MEMORIAL HIGHWAY**

MTA PROJECT MANAGER: R. NORWOOD

YORK TOLL PLAZA

1-95 CROSS SECTIONS
 STA. 382+00 TO 382+50


SHEET NUMBER: XS-83

CONTRACT: 2018.20

281 OF 489

Date: 8/28/2018

Filename: ...00259637\Xsect15_195.dgn

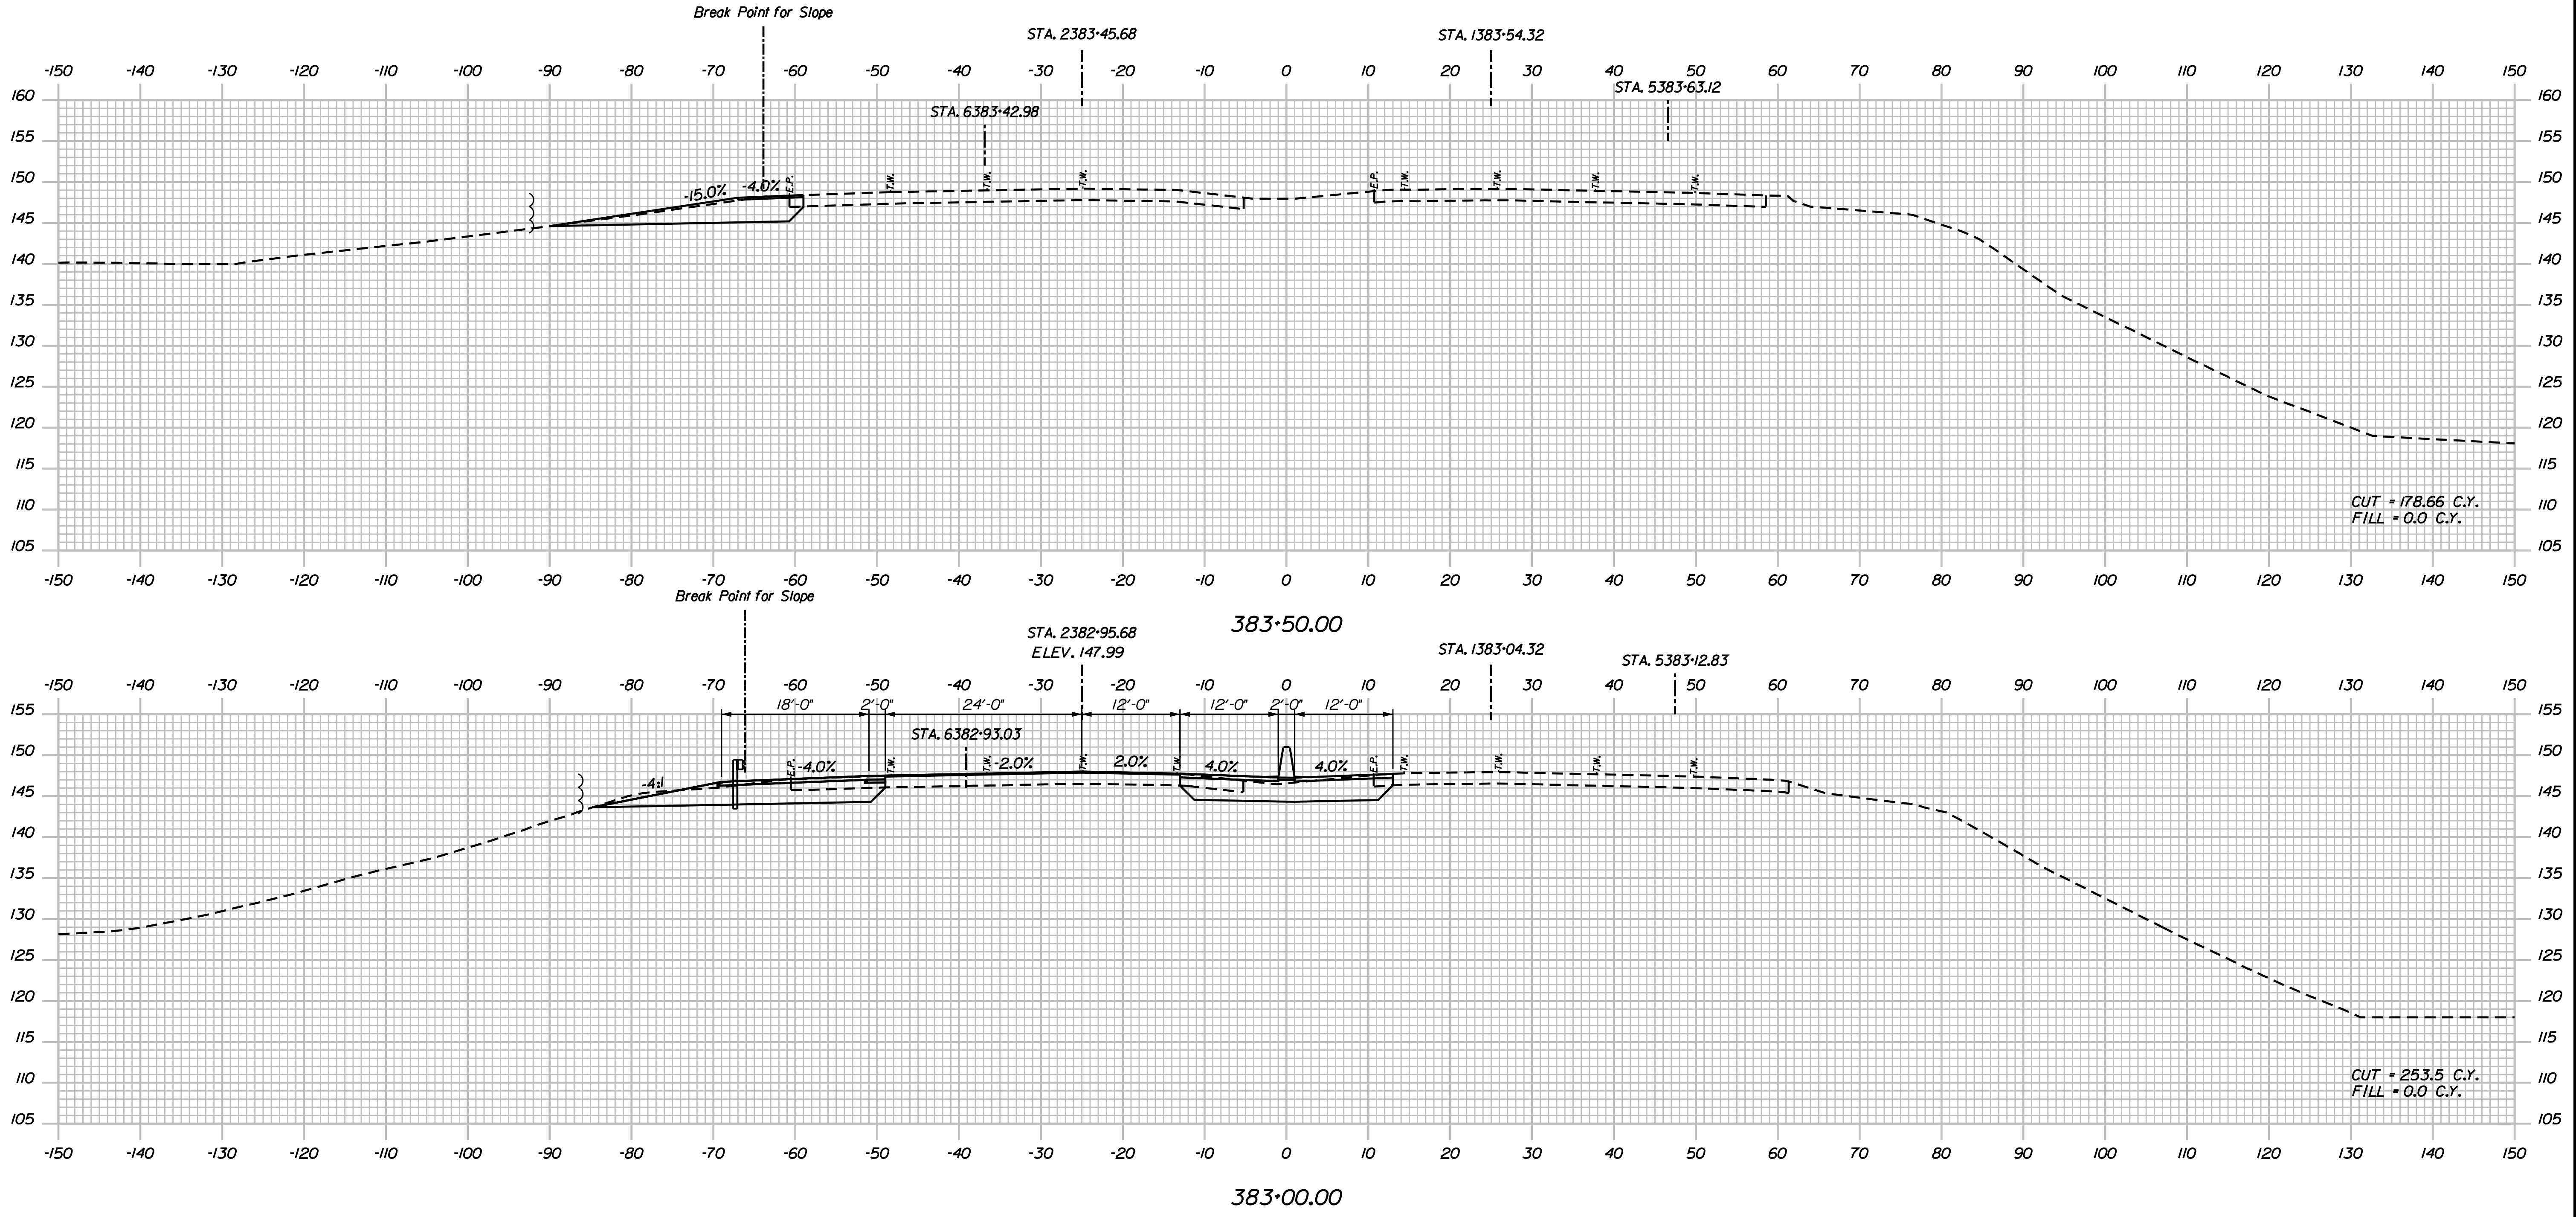

Scale:

No.	Revision	By	Date

Designed by:

JACOBS

CONSULTANT PROJECT MANAGER: T. MORIN

	By	Date		By	Date
Designed	AMS	7-18	Checked	CSM	7-18
Drawn	SMG	7-18	In Charge of	TWM	7-18

JACOBS ENGINEERING GROUP
 120 ST. JAMES AVENUE
 BOSTON, MA 02116
 TEL (617) 242-9222
 FAX (617) 242-9824

THE GOLD STAR MEMORIAL HIGHWAY

MTA PROJECT MANAGER: R. NORWOOD

YORK TOLL PLAZA

I-95 CROSS SECTIONS
 STA. 383+00 TO 383+50



SHEET NUMBER: XS-84

CONTRACT: 2018.20

282 OF 489

Date: 8/28/2018

Filename: ... \02596371\Xsect15_195.dgn

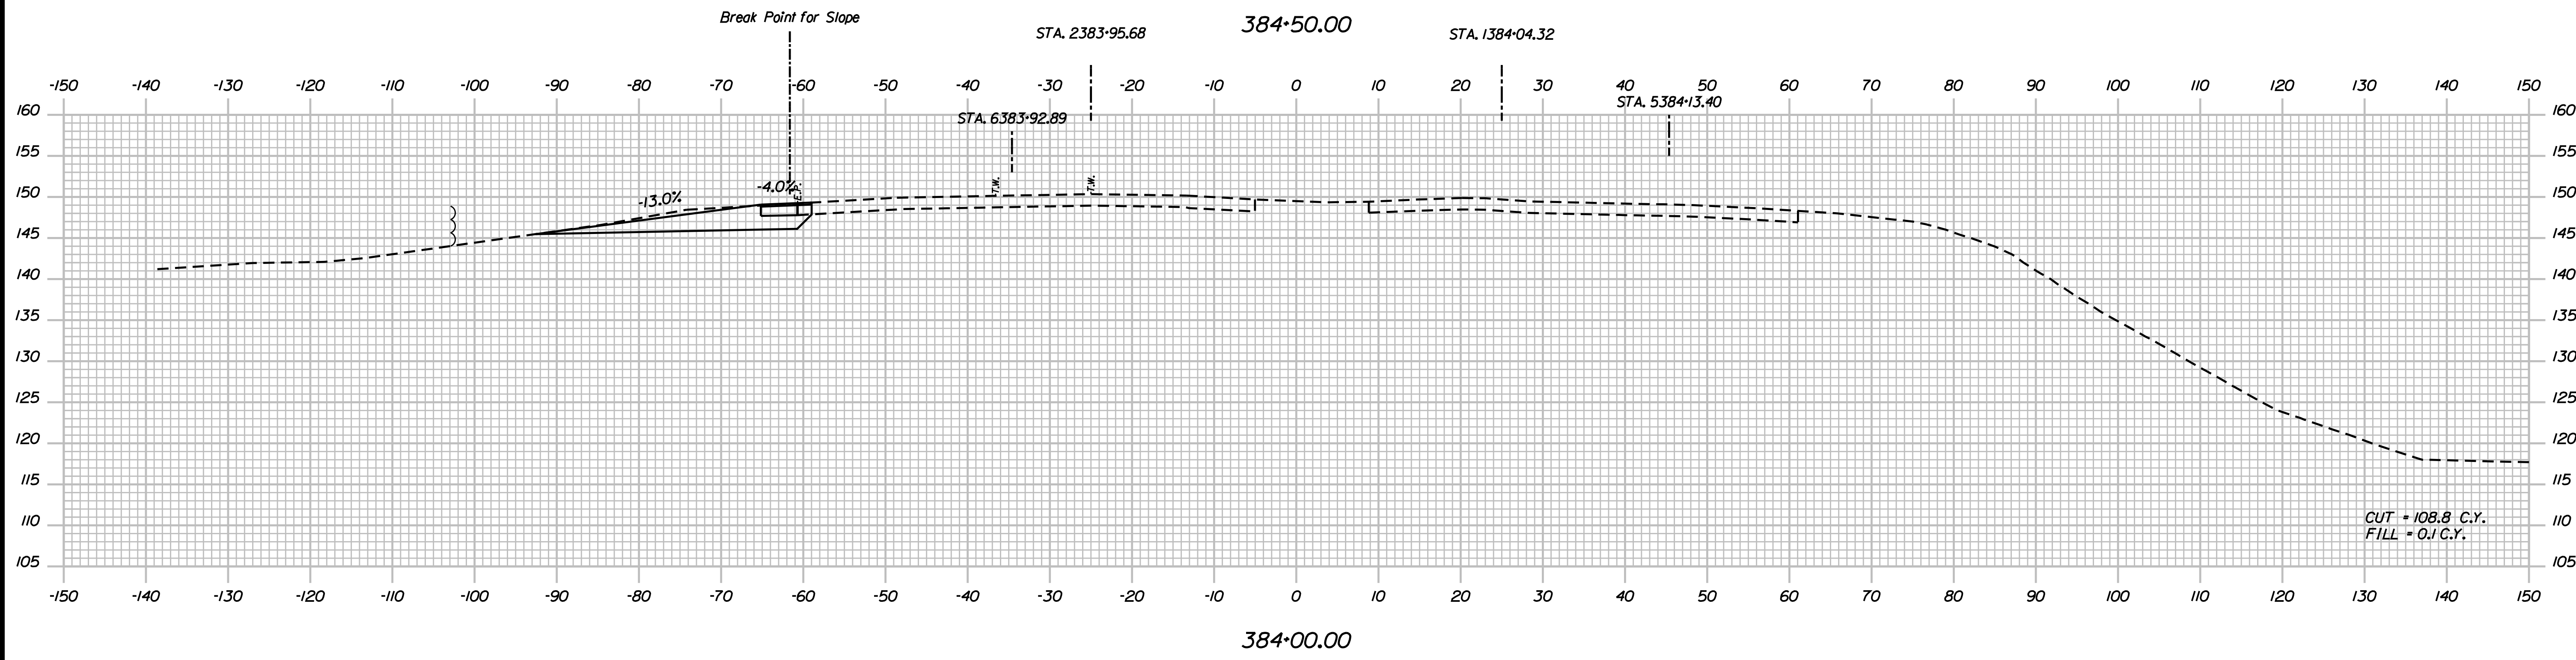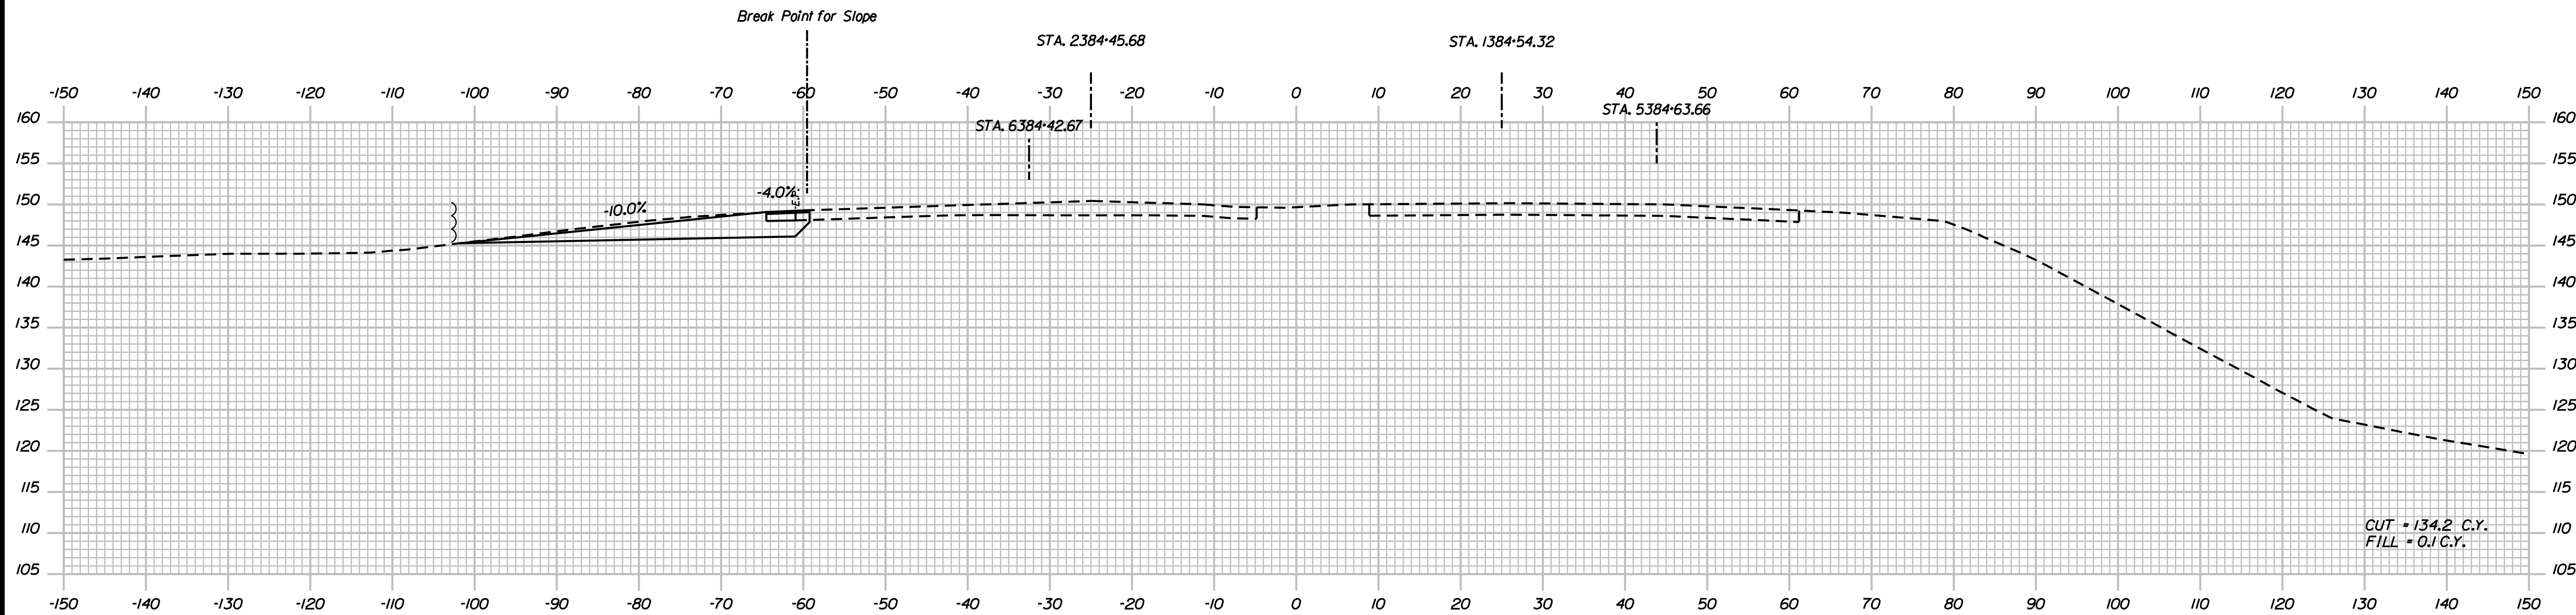

Scale: Scale of Feet

No.	Revision	By	Date

Designed by:

JACOBS

CONSULTANT PROJECT MANAGER: T. MORIN

	By	Date		By	Date
Designed	AMS	7-18	Checked	CSM	7-18
Drawn	SMG	7-18	In Charge of	TWM	7-18

JACOBS ENGINEERING GROUP
 120 ST. JAMES AVENUE
 BOSTON, MA 02116
 TEL (617) 242-9222
 FAX (617) 242-9824

THE GOLD STAR MEMORIAL HIGHWAY

MTA PROJECT MANAGER: R. NORWOOD

YORK TOLL PLAZA


I-95 CROSS SECTIONS
 STA. 384+00 TO 384+50

SHEET NUMBER: XS-85


CONTRACT: 2018.20

283 OF 489

Date: 8/28/2018

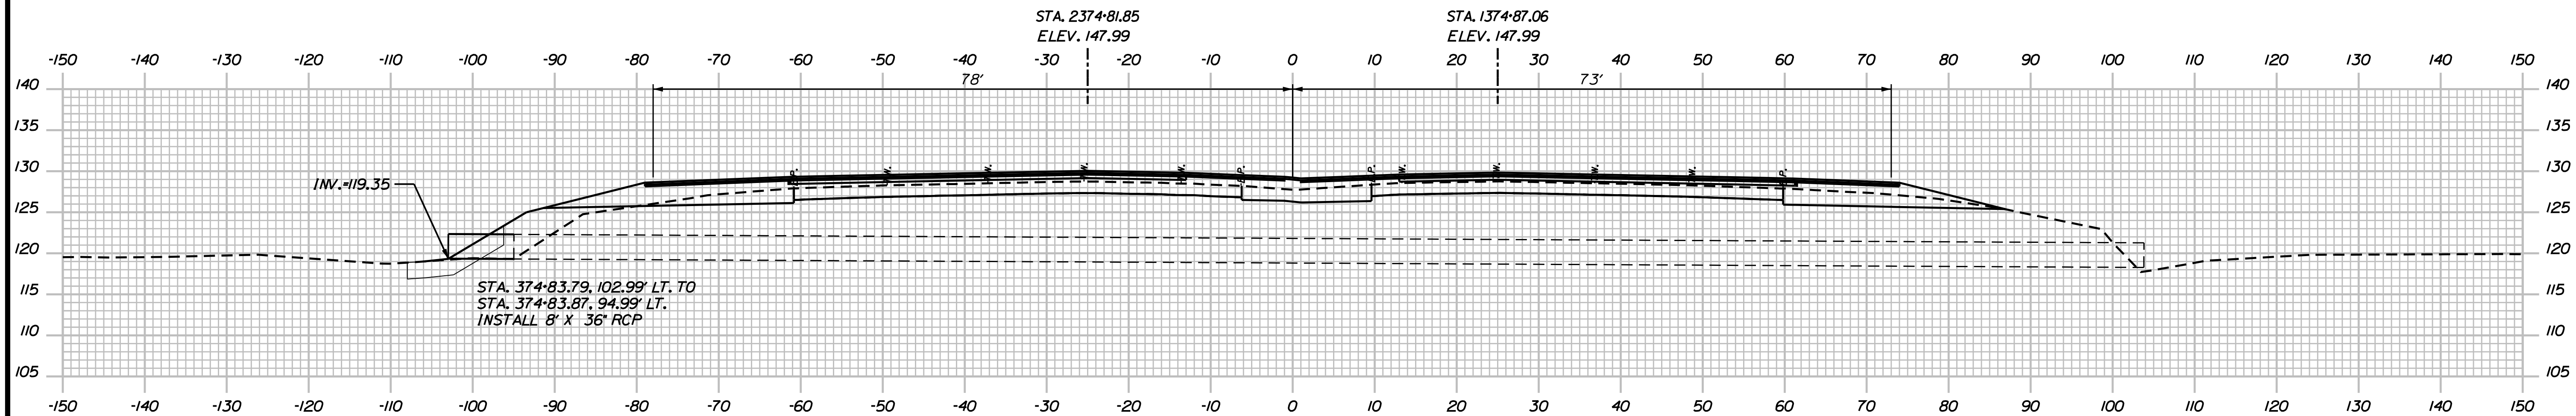

374+84.45 (SKEW)

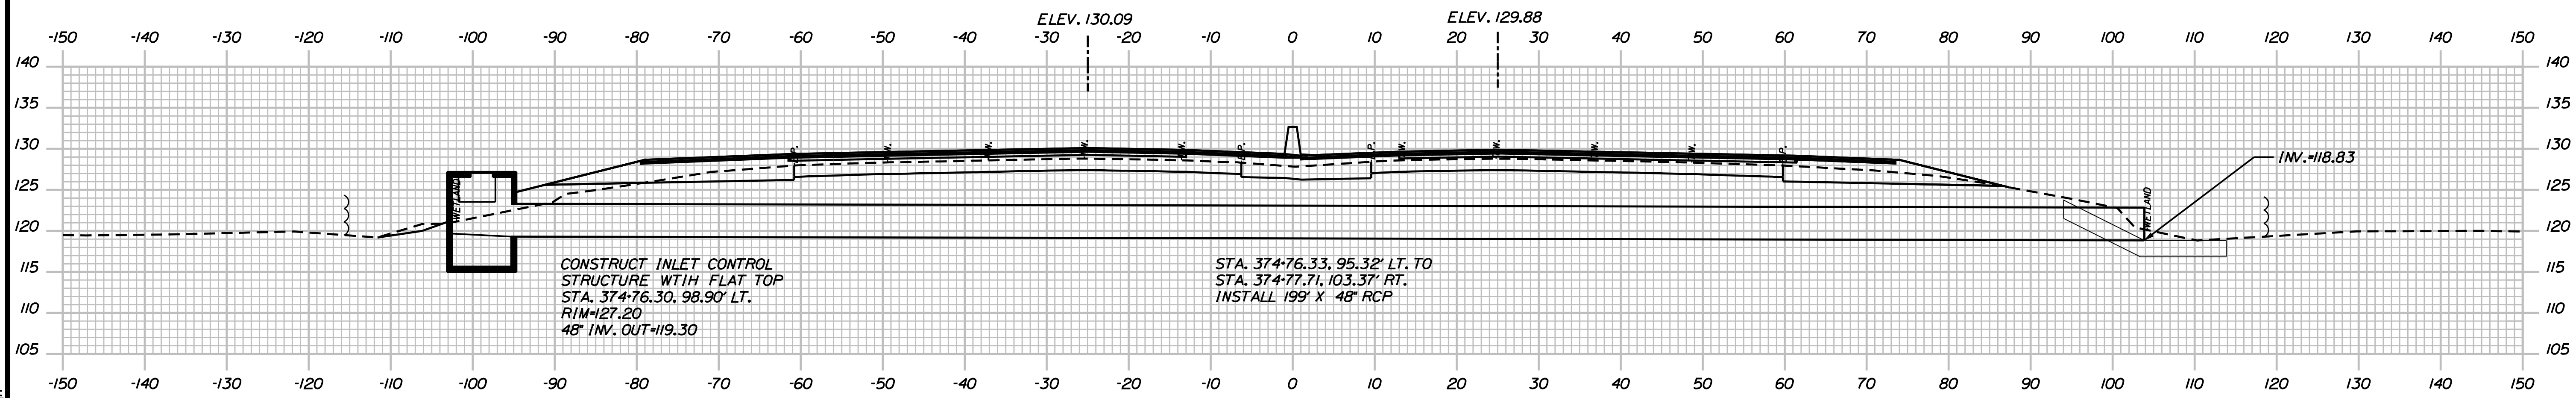

374+77.00, SKEWED

Scale: Scale of Feet

No.	Revision	By	Date

Designed by:

JACOBS

CONSULTANT PROJECT MANAGER: T. MORIN

	By	Date		By	Date
Designed	AMS	7-18	Checked	CSM	7-18
Drawn	SMG	7-18	In Charge of	TWM	7-18

JACOBS ENGINEERING GROUP
 120 ST. JAMES AVENUE
 BOSTON, MA 02116
 TEL (617) 242-9222
 FAX (617) 242-9824

**THE GOLD STAR
 MEMORIAL HIGHWAY**

MTA PROJECT MANAGER: R. NORWOOD

YORK TOLL PLAZA

I-95 DRAINAGE CROSS SECTIONS
 STA. 374+77 TO 374+84

SHEET NUMBER: XS-86


CONTRACT: 2018.20

284 OF 489


Filename: ...0259637\Xsect16_195.dgn

Date: 8/28/2018


Filename: ... \02596371\Xsect_Access Road.dgn

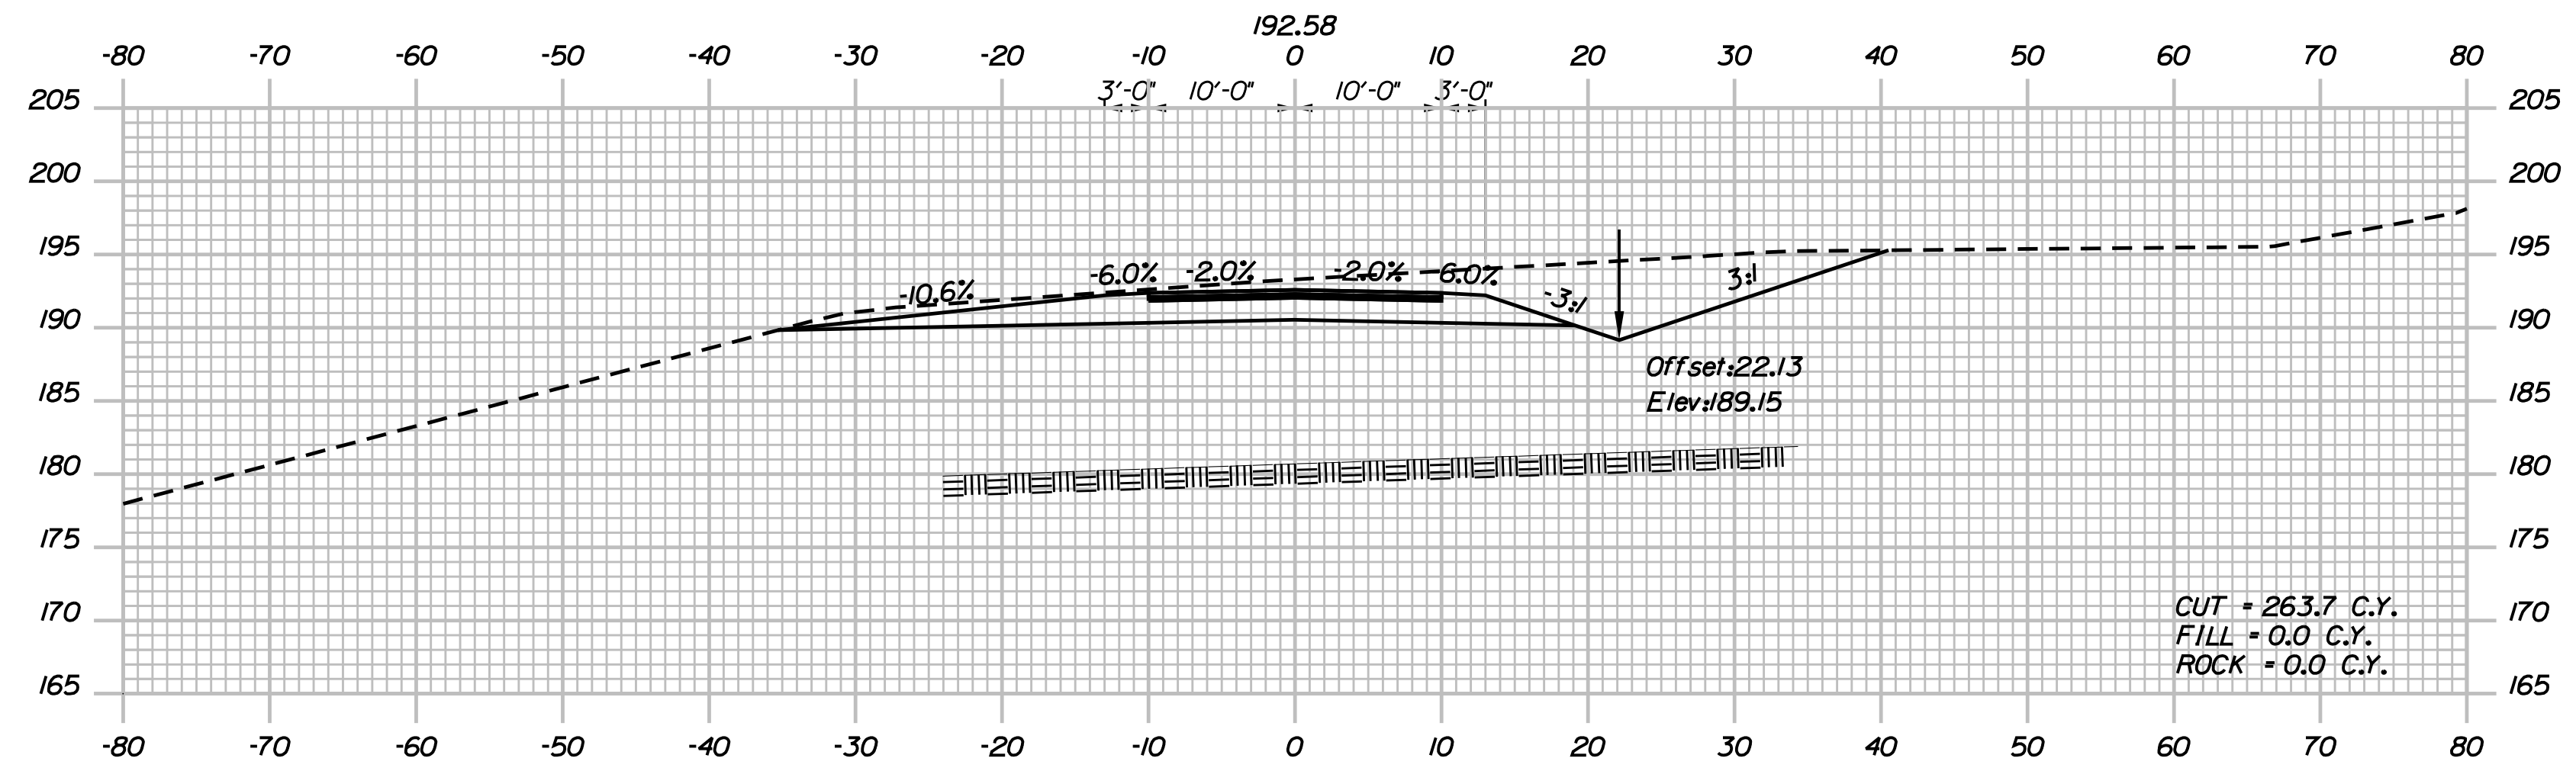


21+00.00

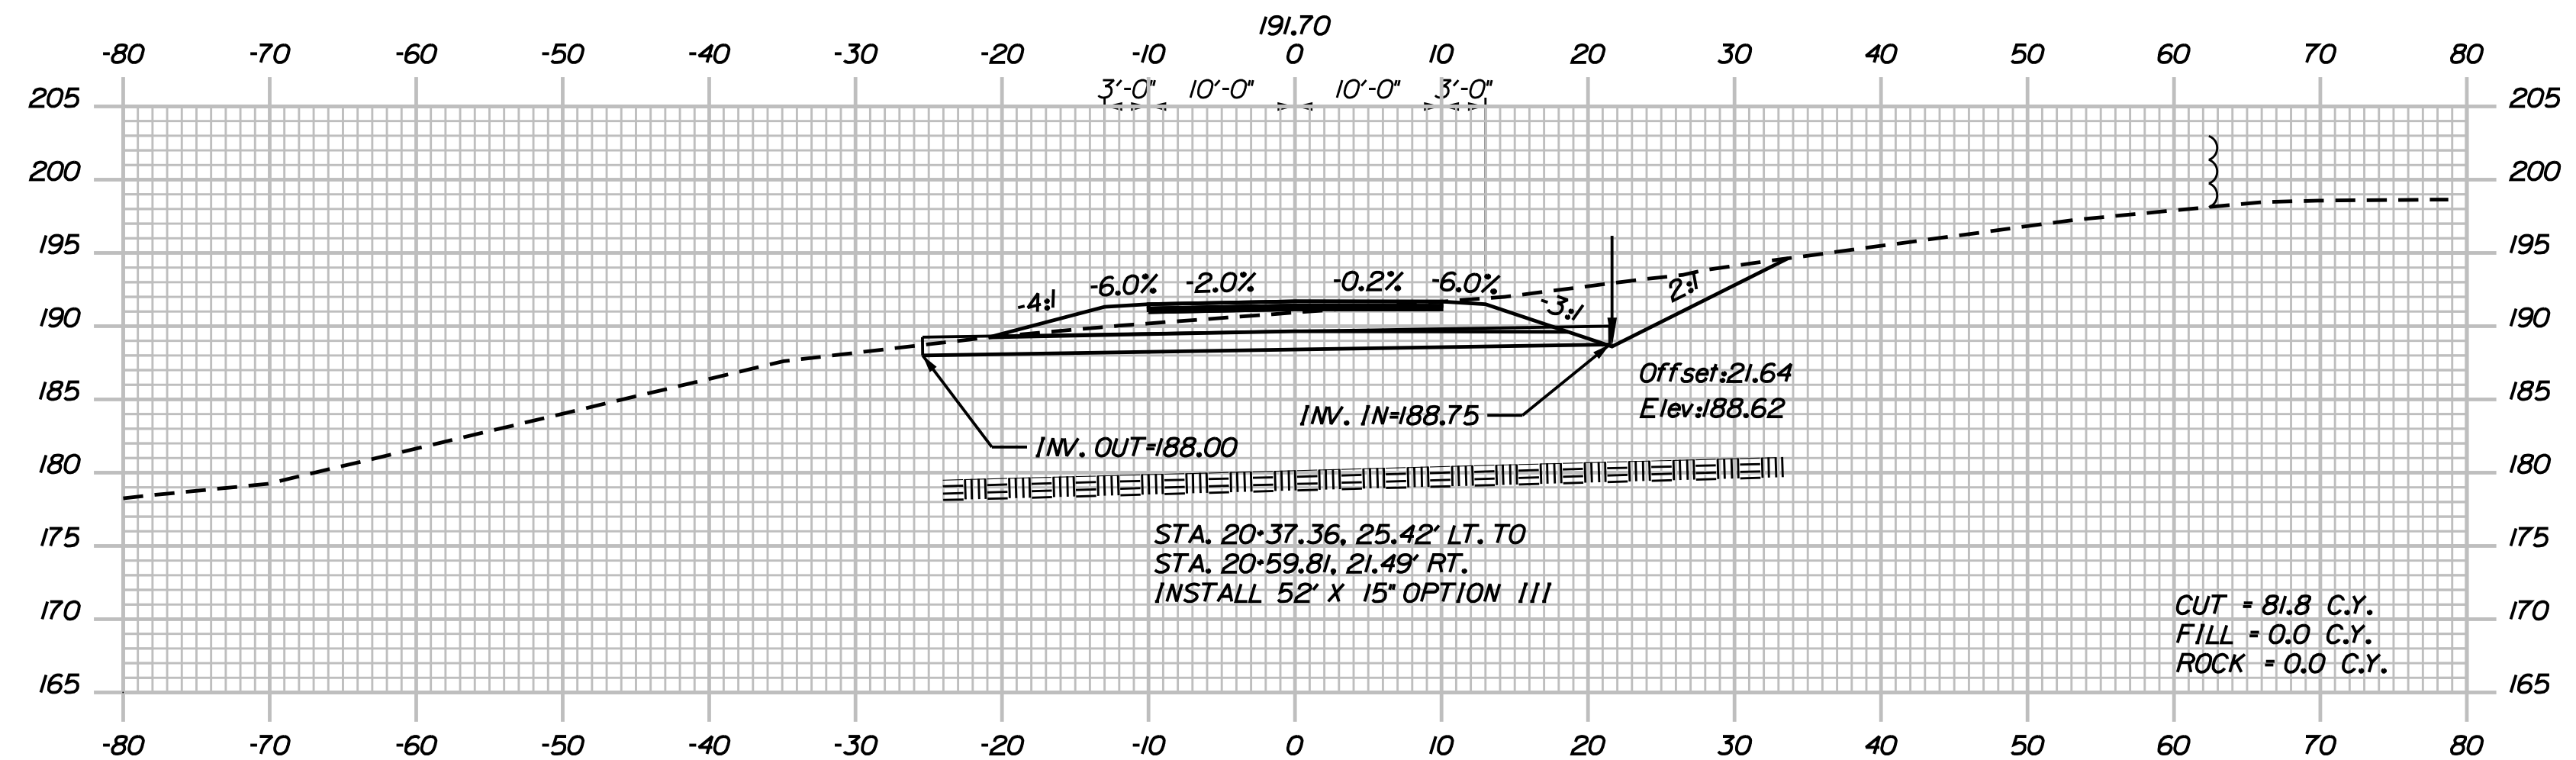

20+50.00

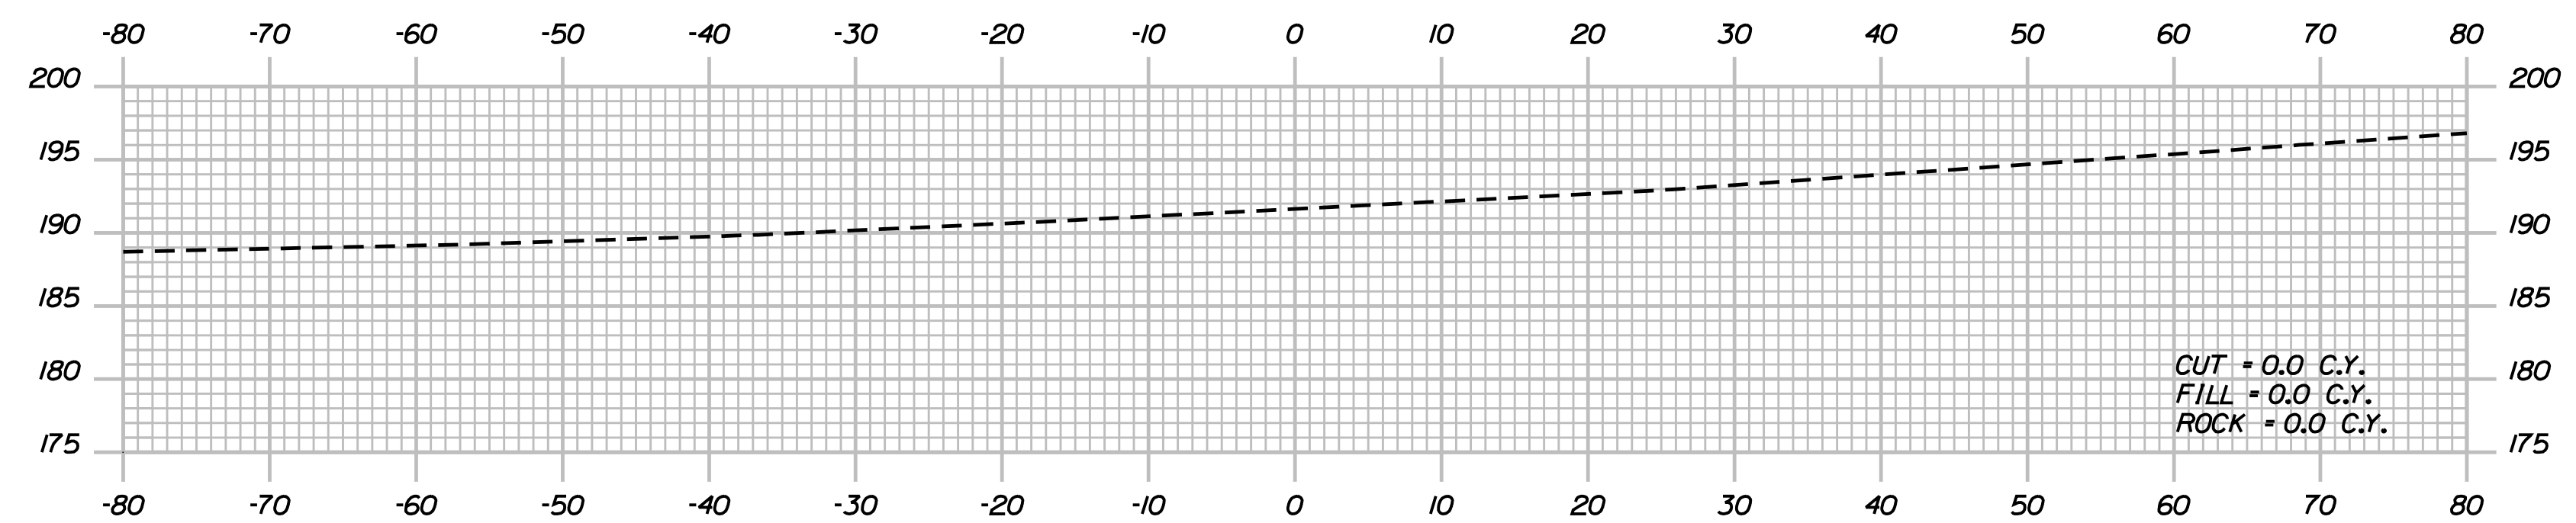

20+00.00

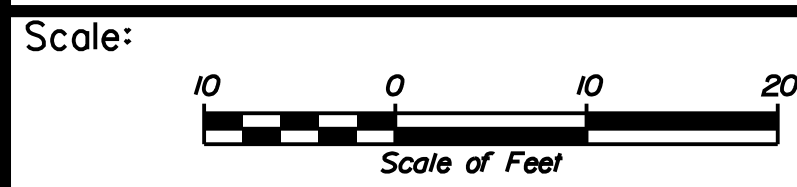

No.	Revision	By	Date

Designed by:

JACOBS

CONSULTANT PROJECT MANAGER: T. MORIN

	By	Date		By	Date
Designed	AMS	7-18	Checked	CSM	7-18
Drawn	SMG	7-18	In Charge of	TWM	7-18

JACOBS ENGINEERING GROUP
 120 ST. JAMES AVENUE
 BOSTON, MA 02116
 TEL (617) 242-9222
 FAX (617) 242-9824

**THE GOLD STAR
 MEMORIAL HIGHWAY**

MTA PROJECT MANAGER: R. NORWOOD

YORK TOLL PLAZA

ACCESS ROAD CROSS SECTIONS 1


SHEET NUMBER: XS-87

CONTRACT: 2018.20


285 OF 489

Date: 8/28/2018


Filename: ... \02596371\Xsect_Access Road.dgn

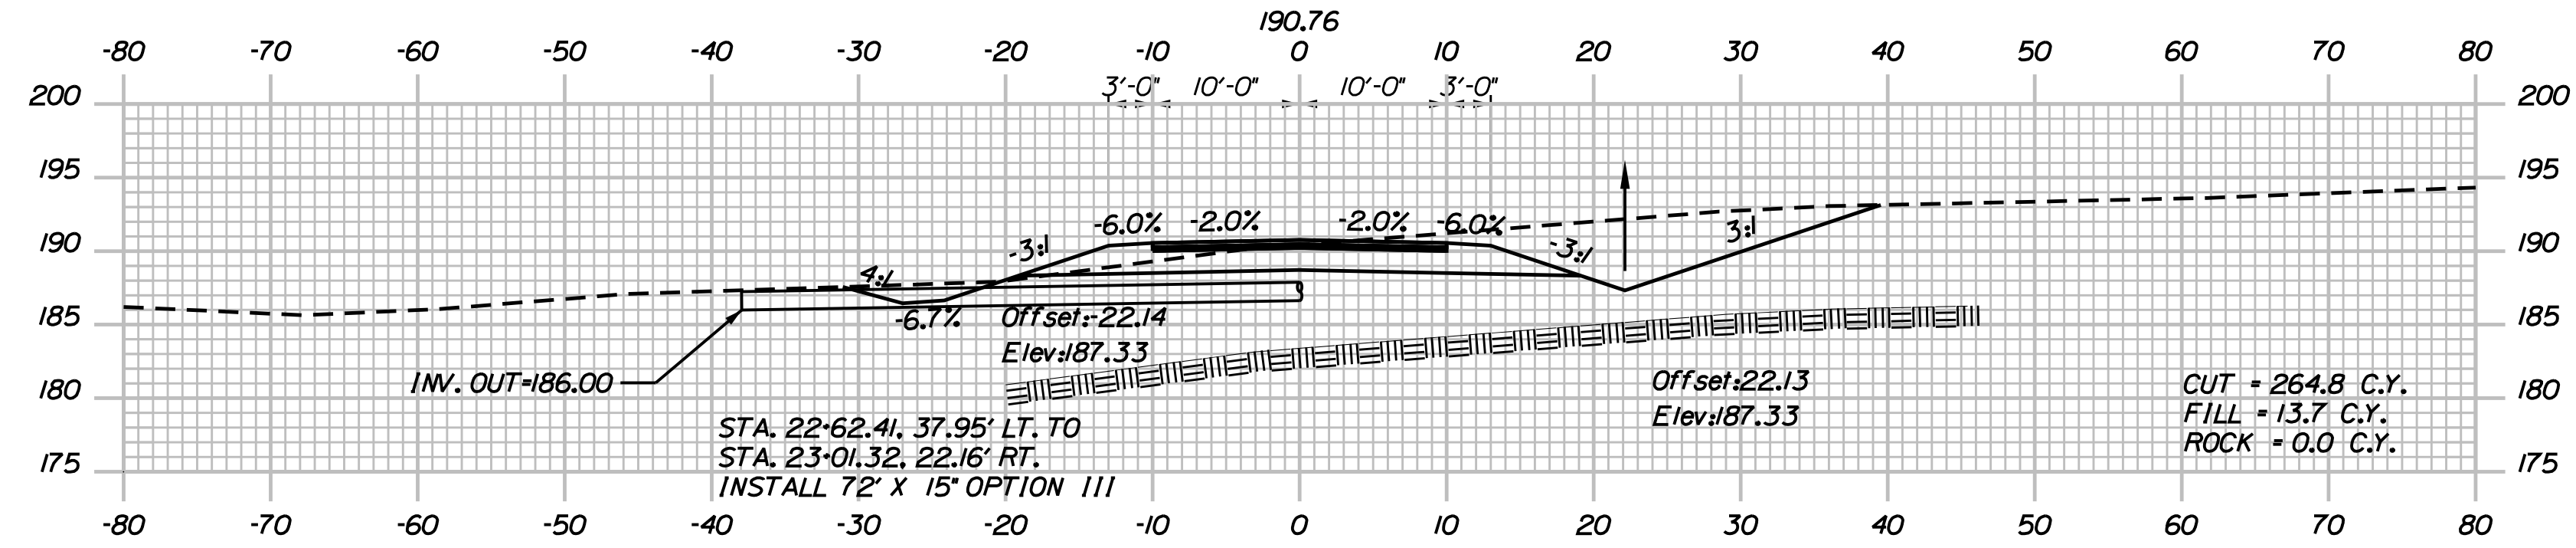


22+50.00

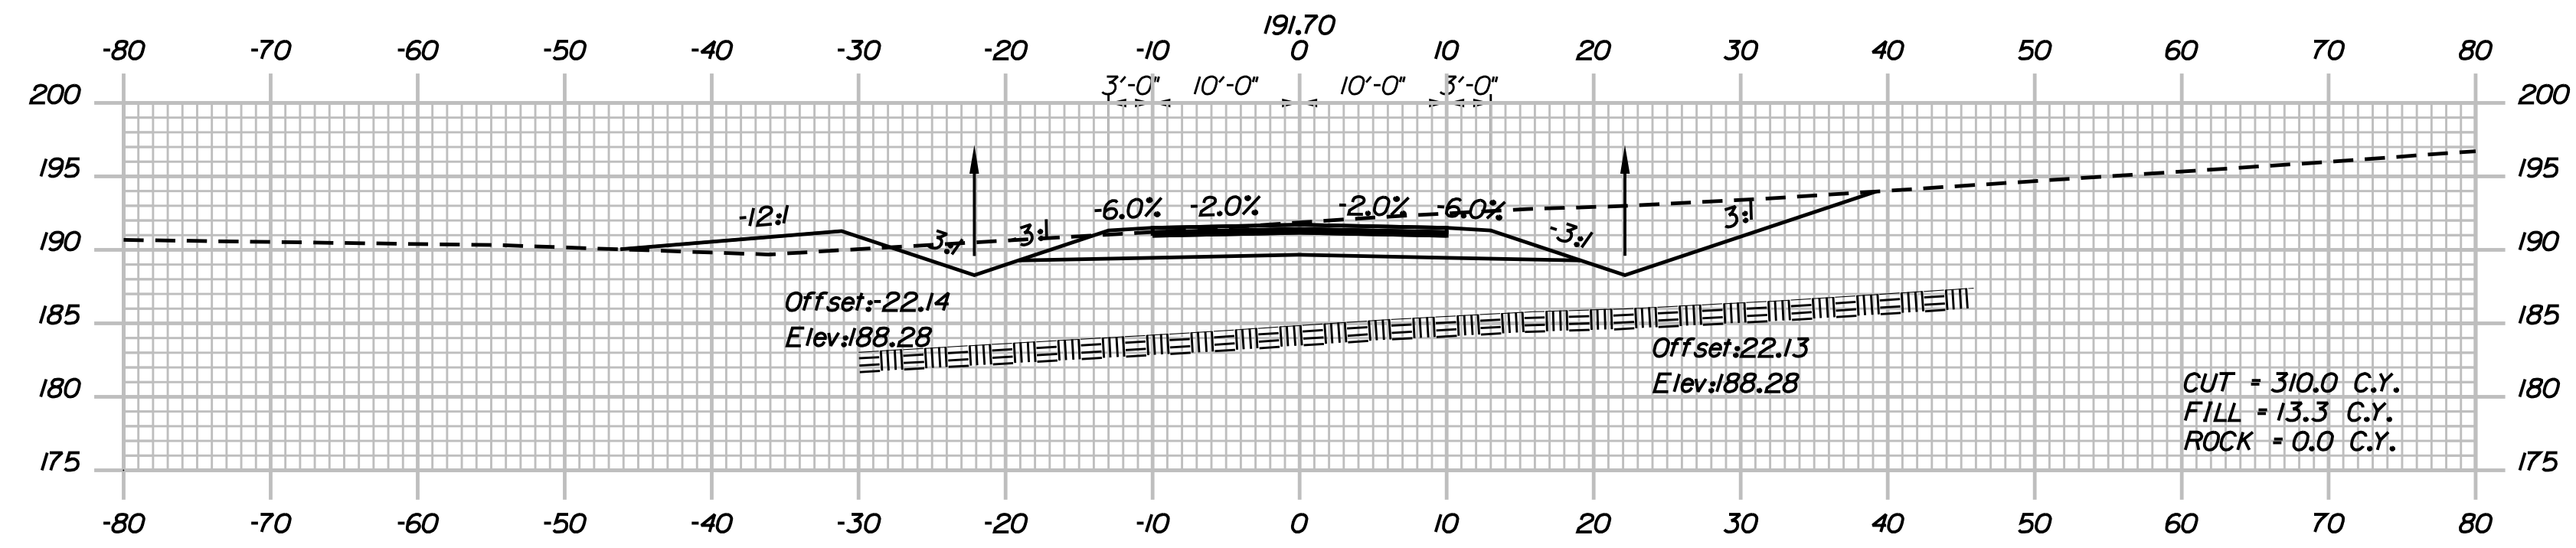

22+00.00

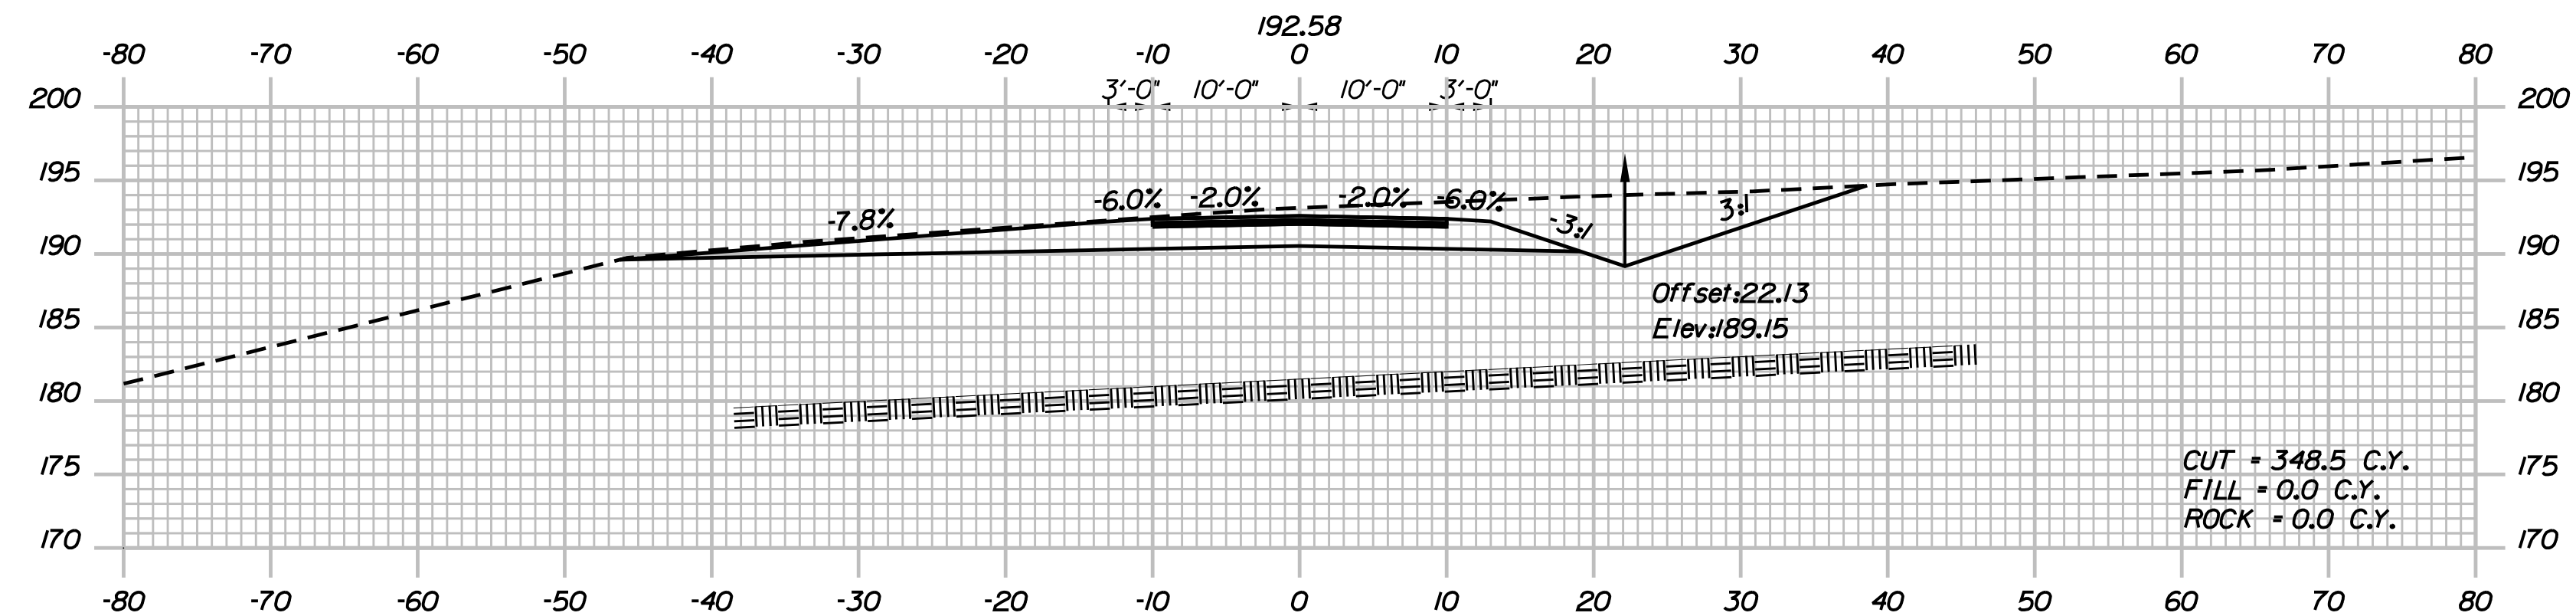

21+50.00

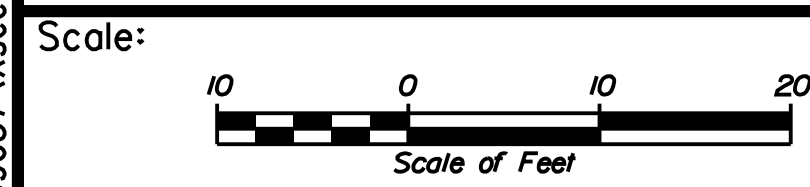

No.	Revision	By	Date

Designed by:

JACOBS

CONSULTANT PROJECT MANAGER: T. MORIN

	By	Date		By	Date
Designed	AMS	7-18	Checked	CSM	7-18
Drawn	SMG	7-18	In Charge of	TWM	7-18

JACOBS ENGINEERING GROUP
 120 ST. JAMES AVENUE
 BOSTON, MA 02116
 TEL (617) 242-9222
 FAX (617) 242-9824

**THE GOLD STAR
 MEMORIAL HIGHWAY**

MTA PROJECT MANAGER: R. NORWOOD

YORK TOLL PLAZA

ACCESS ROAD CROSS SECTIONS 2




SHEET NUMBER: XS-88

CONTRACT: 2018.20

286 OF 489

Date: 8/28/2018

Filename: ... \02596371\Xsect - Access Road.dgn

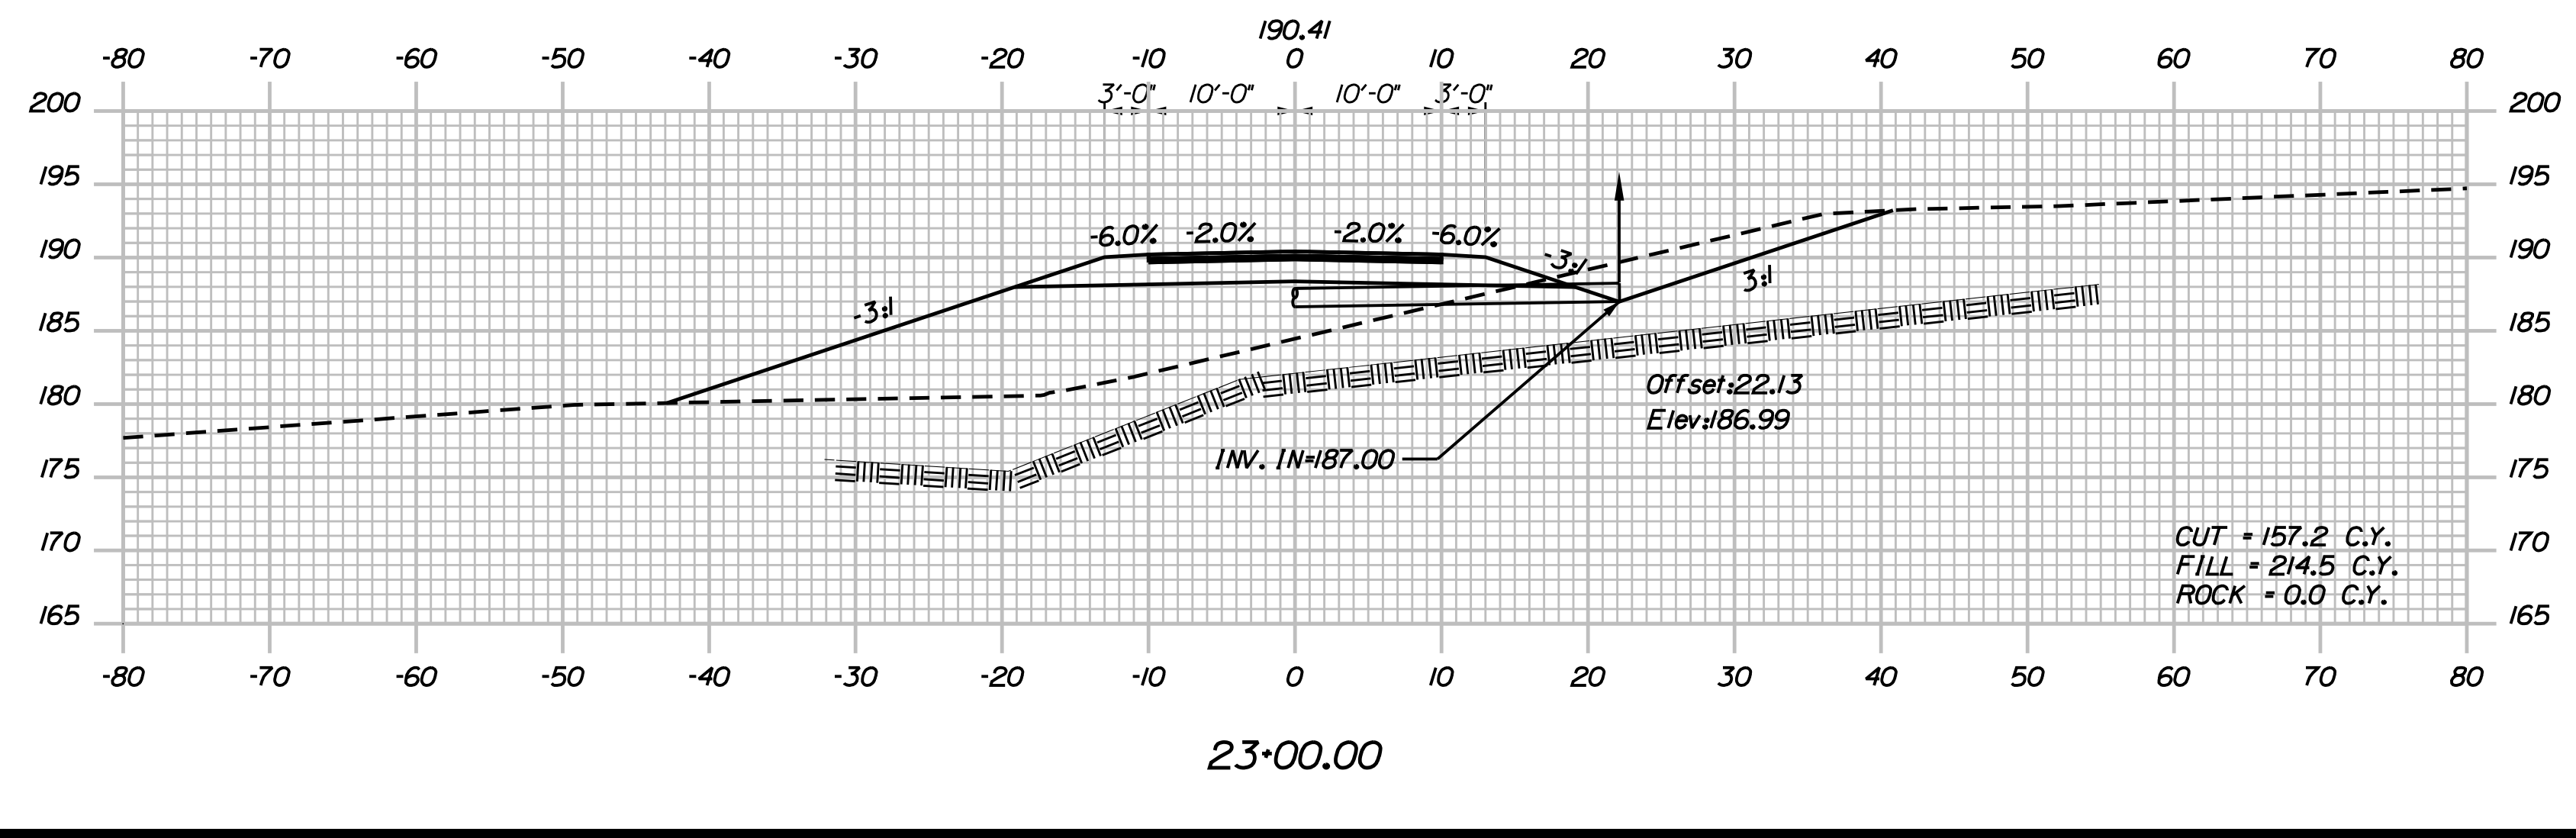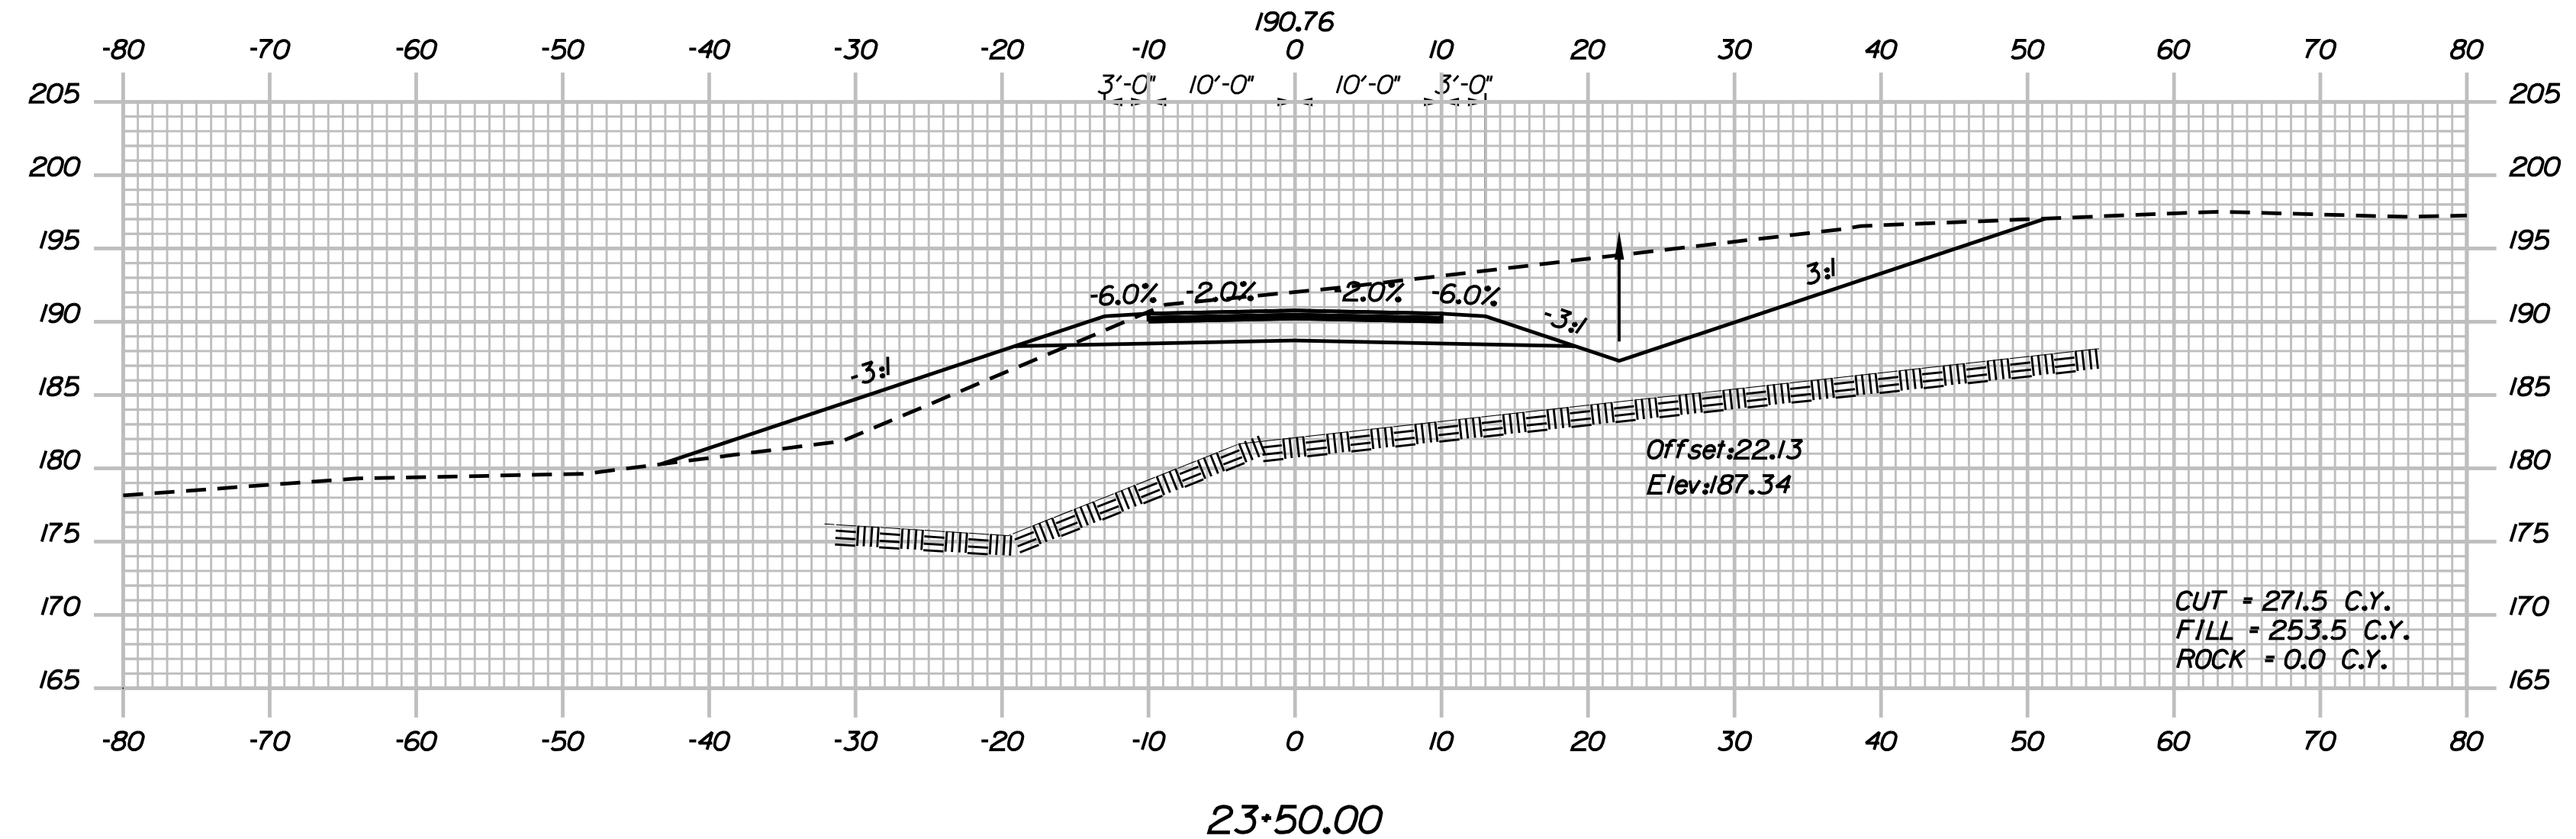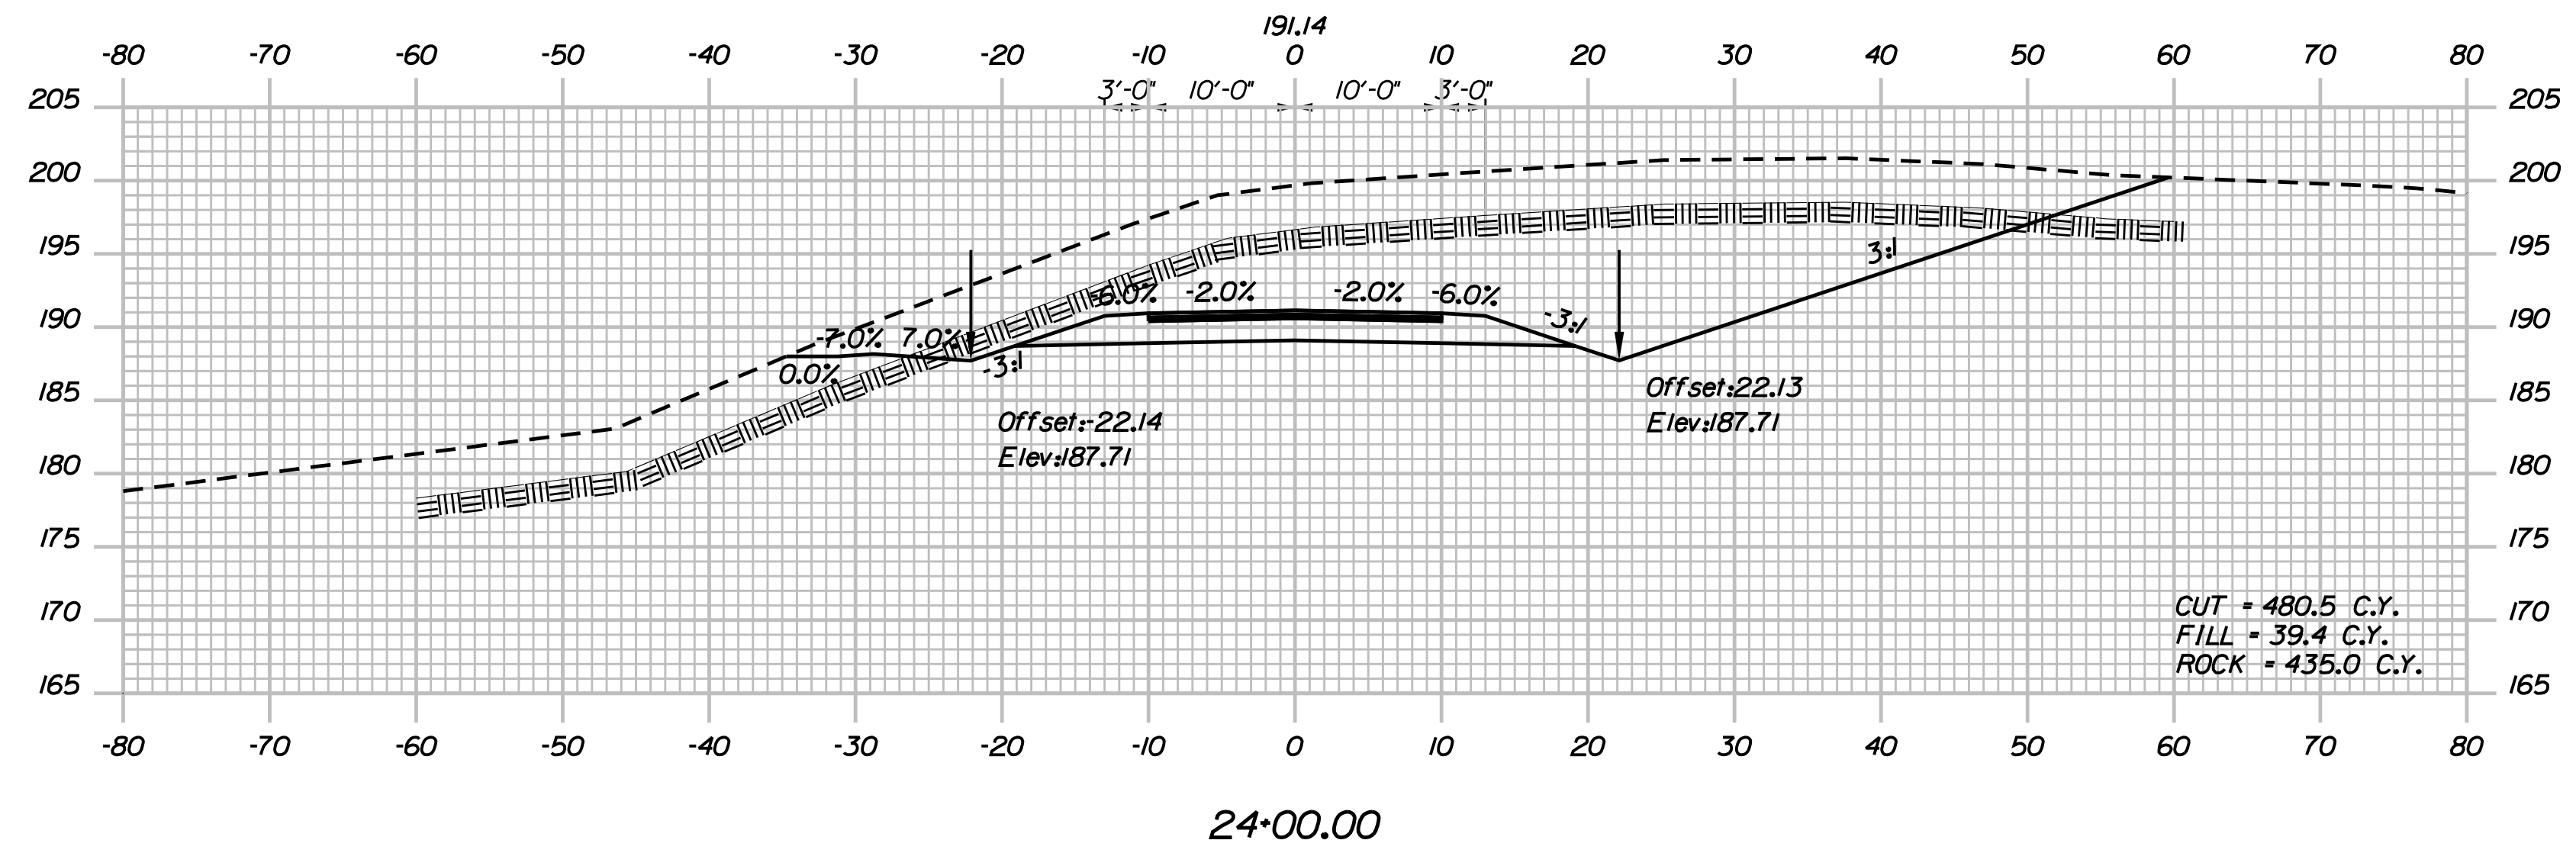

Scale: Scale of Feet

No.	Revision	By	Date

Designed by:

JACOBS

CONSULTANT PROJECT MANAGER: T. MORIN

	By	Date		By	Date
Designed	AMS	7-18	Checked	CSM	7-18
Drawn	SMG	7-18	In Charge of	TWM	7-18

JACOBS ENGINEERING GROUP
 120 ST. JAMES AVENUE
 BOSTON, MA 02116
 TEL (617) 242-9222
 FAX (617) 242-9824

**THE GOLD STAR
 MEMORIAL HIGHWAY**

MTA PROJECT MANAGER: R. NORWOOD


YORK TOLL PLAZA
 ACCESS ROAD CROSS SECTIONS 3

SHEET NUMBER: XS-89
 287 OF 489

CONTRACT: 2018.20


Date: 8/28/2018

Filename: ... \02596371\Xsect - Access Road.dgn

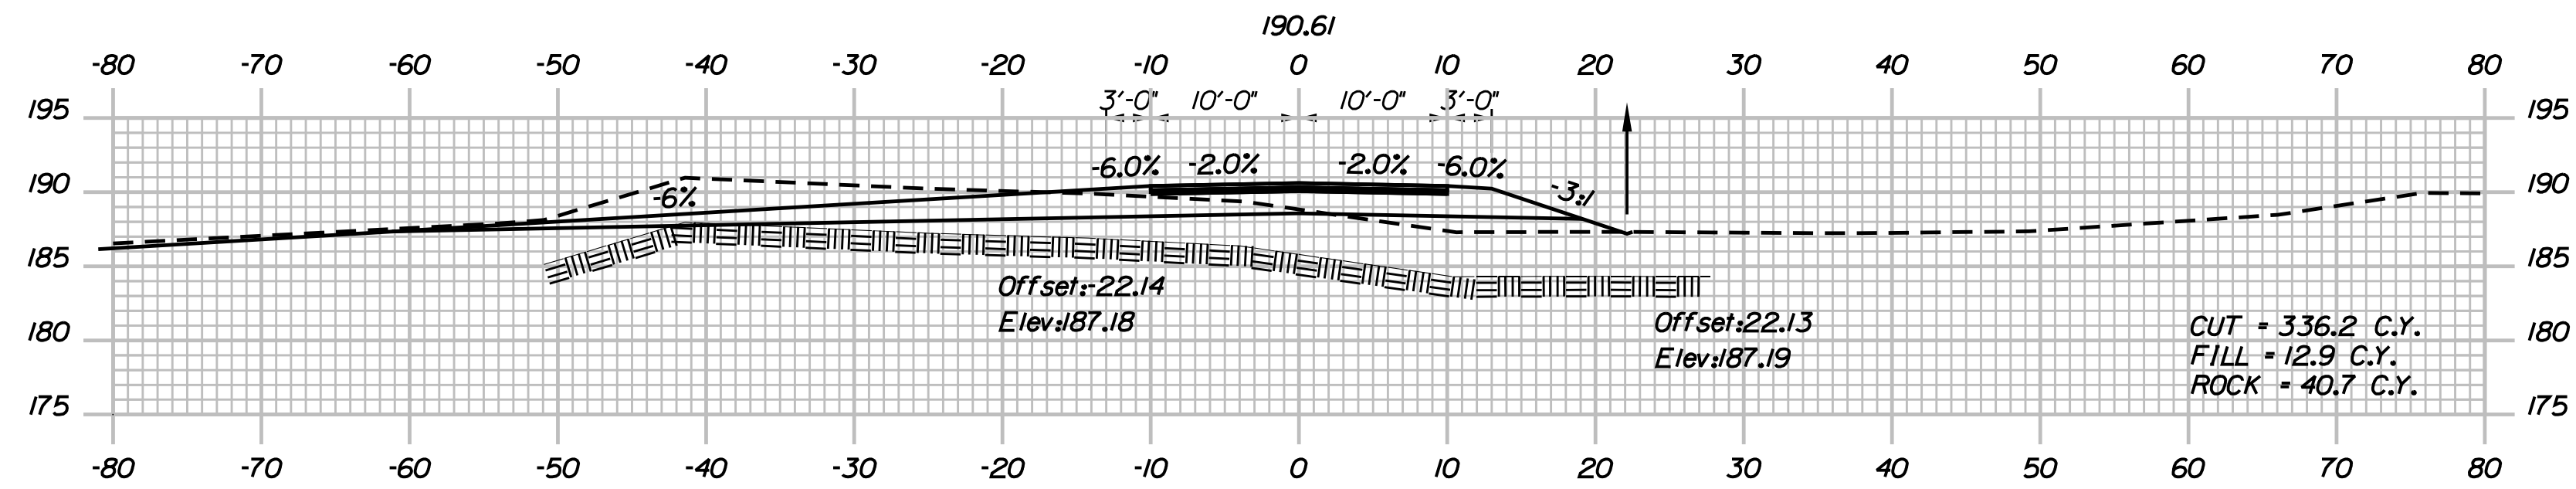


25+50.00

CUT = 336.2 C.Y.
FILL = 12.9 C.Y.
ROCK = 40.7 C.Y.

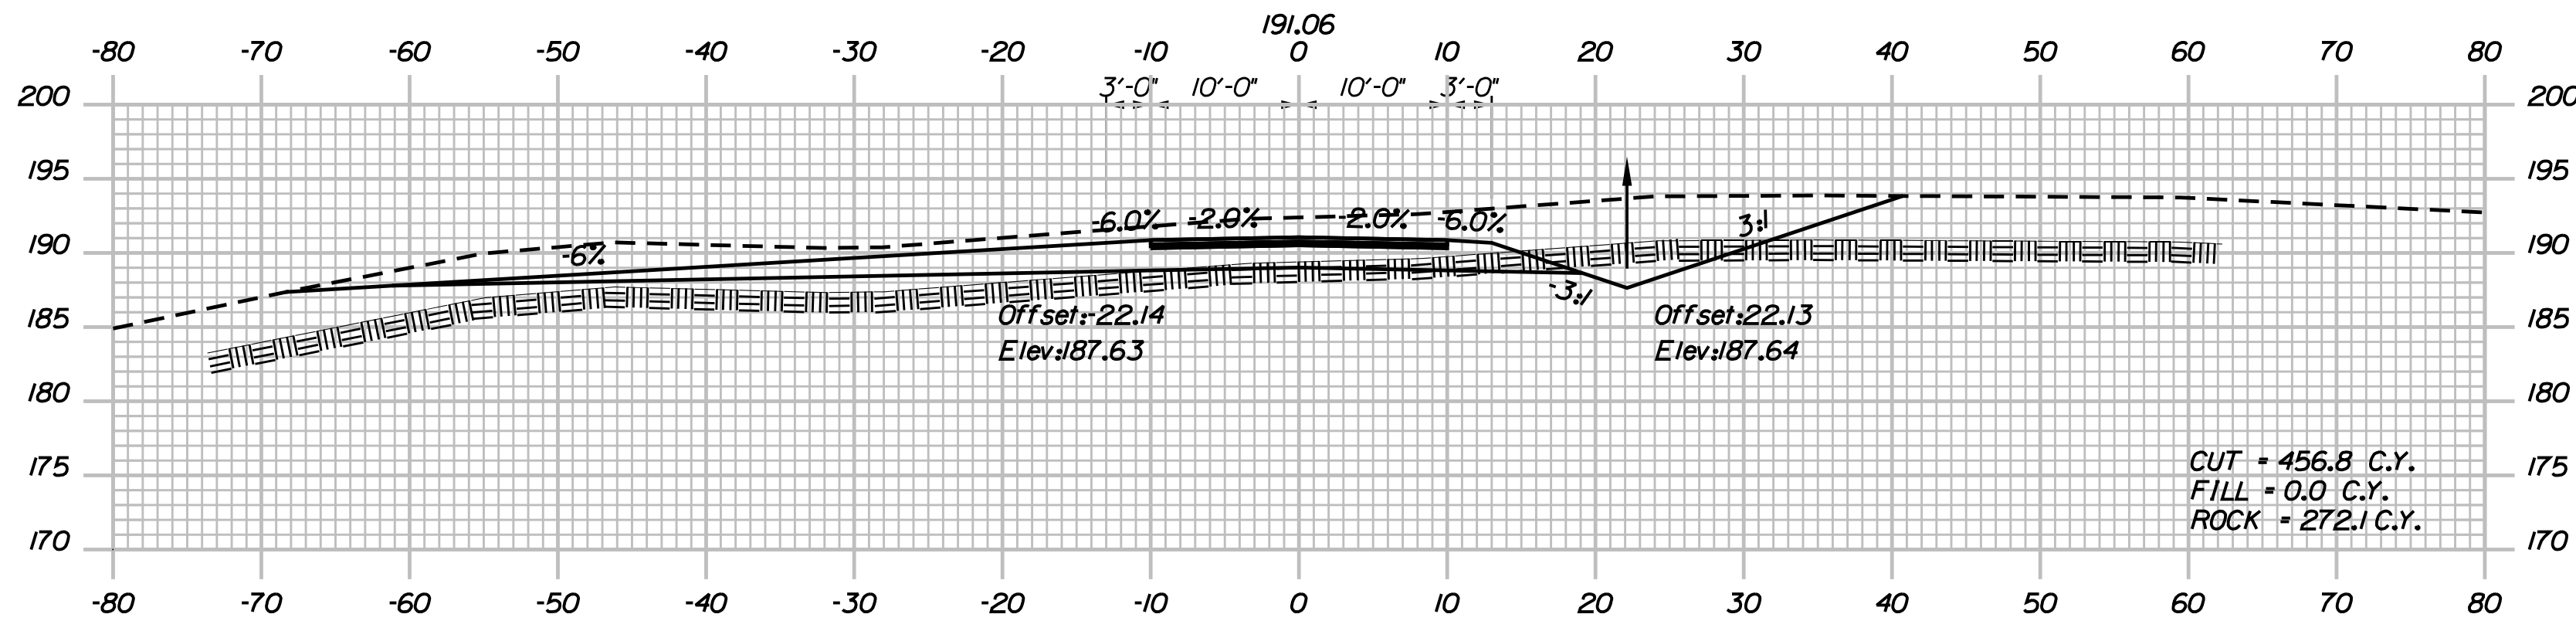


25+00.00

CUT = 456.8 C.Y.
FILL = 0.0 C.Y.
ROCK = 272.1 C.Y.

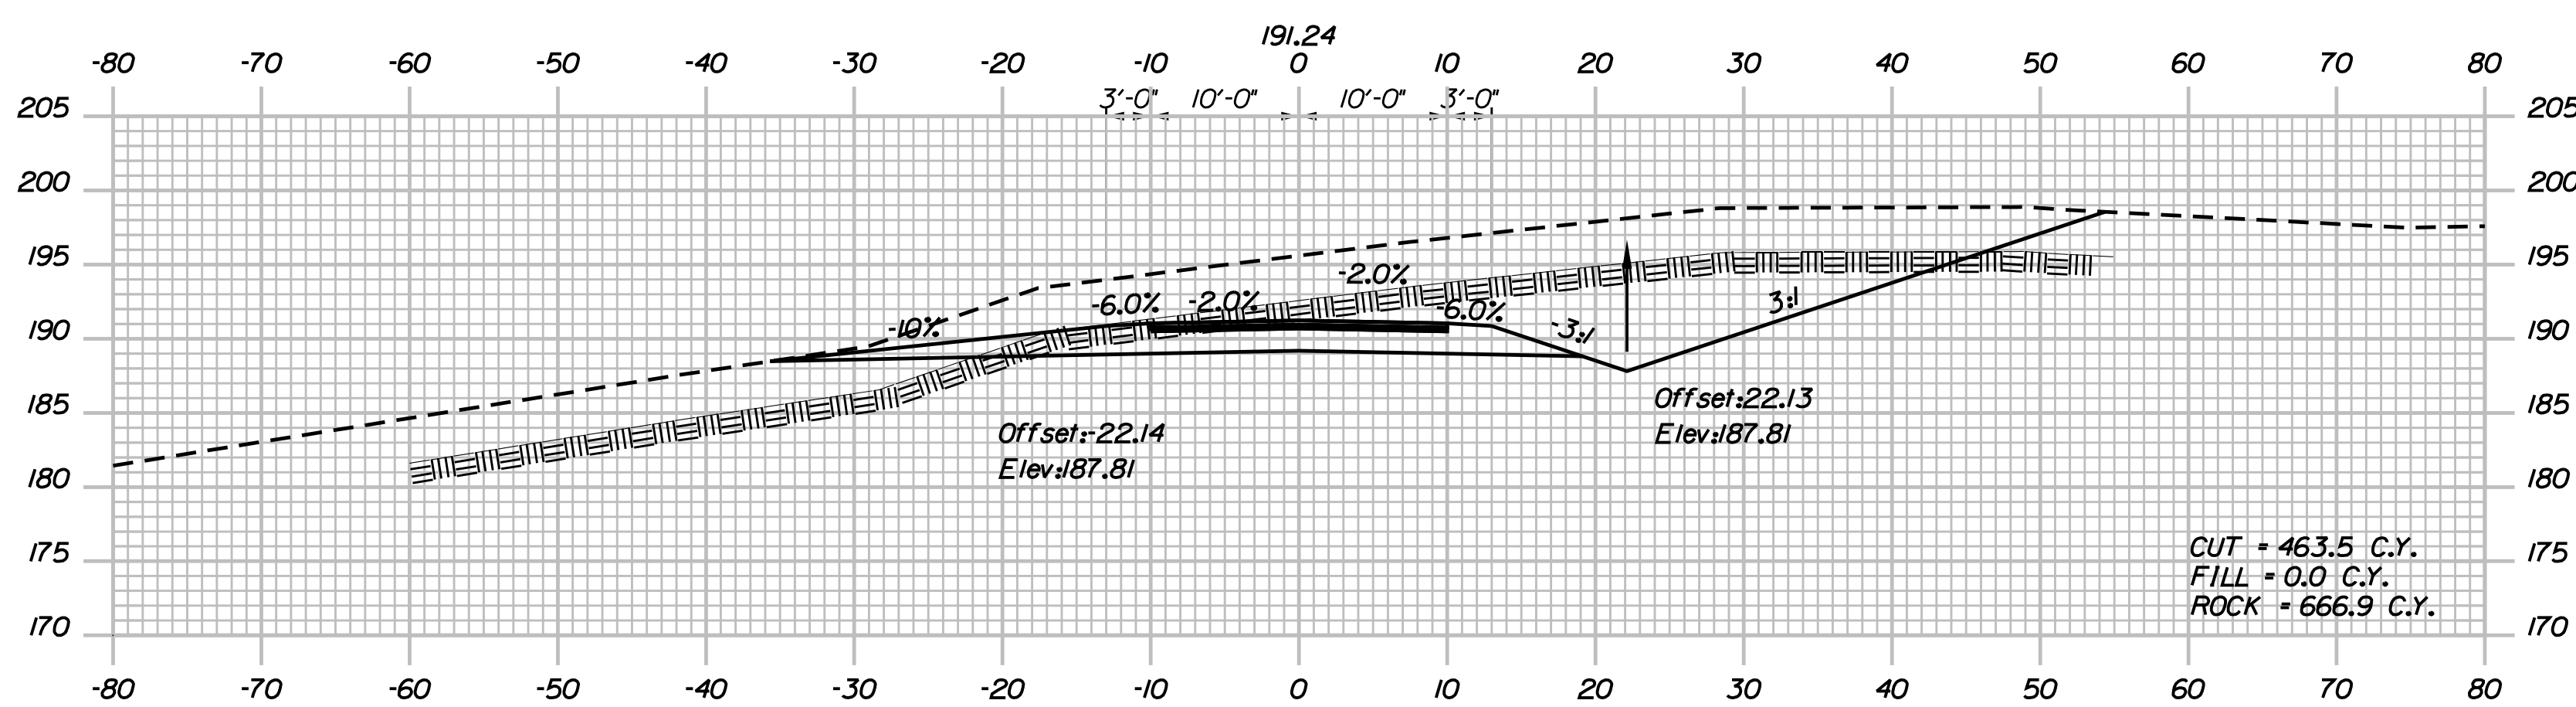

24+50.00

CUT = 463.5 C.Y.
FILL = 0.0 C.Y.
ROCK = 666.9 C.Y.

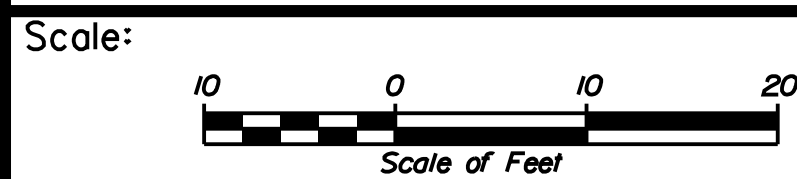

No.	Revision	By	Date

Designed by:

JACOBS

CONSULTANT PROJECT MANAGER: T. MORIN

	By	Date		By	Date
Designed	AMS	7-18	Checked	CSM	7-18
Drawn	SMG	7-18	In Charge of	TWM	7-18

JACOBS ENGINEERING GROUP
120 ST. JAMES AVENUE
BOSTON, MA 02116
TEL (617) 242-9222
FAX (617) 242-9824

THE GOLD STAR
MEMORIAL HIGHWAY

MTA PROJECT MANAGER: R. NORWOOD

YORK TOLL PLAZA

ACCESS ROAD CROSS SECTIONS 4


SHEET NUMBER: XS-90

CONTRACT: 2018.20

288 OF 489


Date: 8/28/2018

Filename: ... \02596371\Xsect_Access Road.dgn

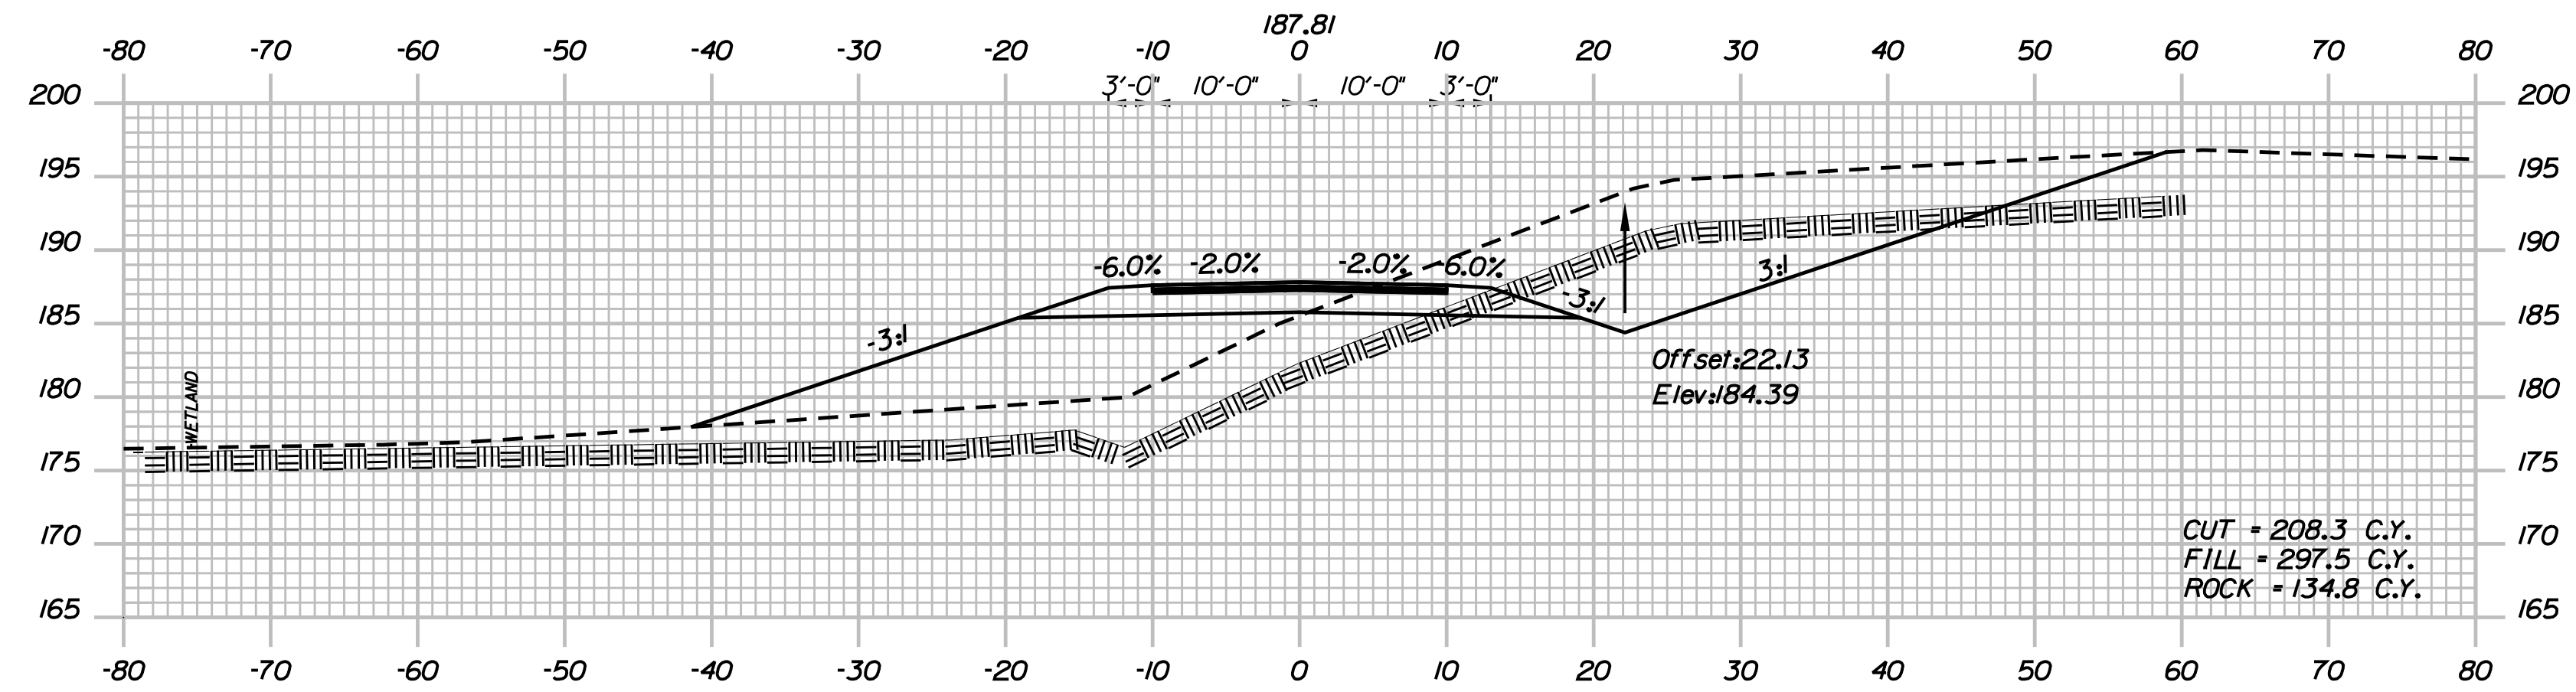


27+00.00

CUT = 208.3 C.Y.
FILL = 297.5 C.Y.
ROCK = 134.8 C.Y.

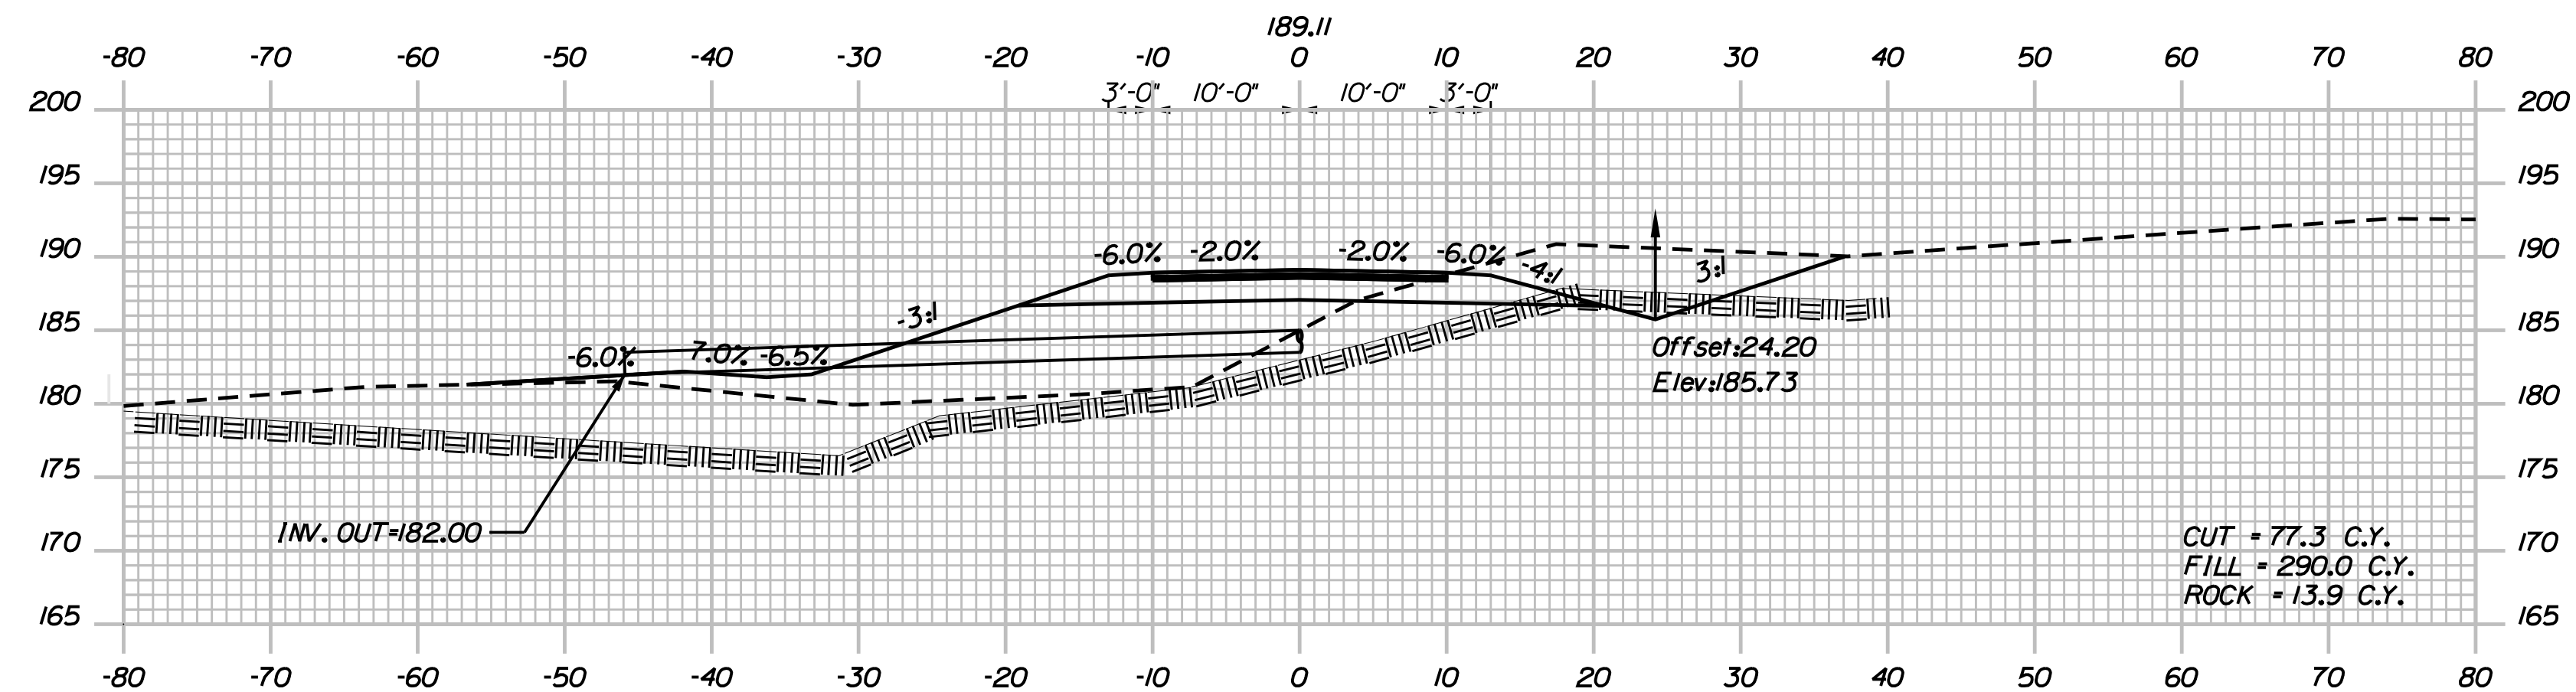

26+50.00


CUT = 77.3 C.Y.
FILL = 290.0 C.Y.
ROCK = 13.9 C.Y.

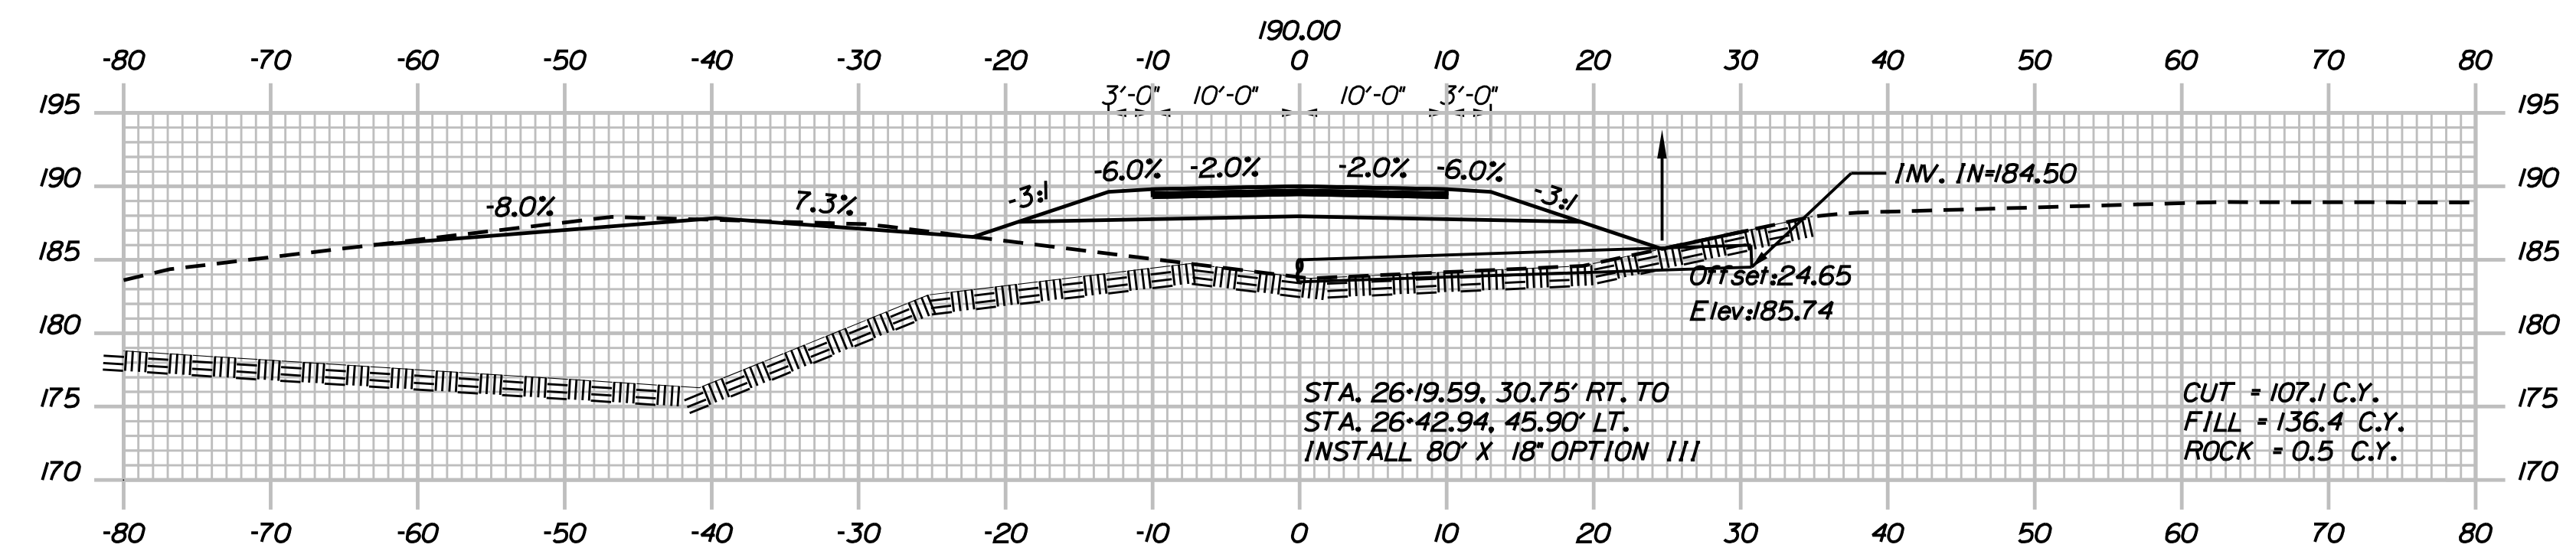

26+00.00

CUT = 107.1 C.Y.
FILL = 136.4 C.Y.
ROCK = 0.5 C.Y.

STA. 26+19.59, 30.75' RT. TO
STA. 26+42.94, 45.90' LT.
INSTALL 80' X 18' OPTION III

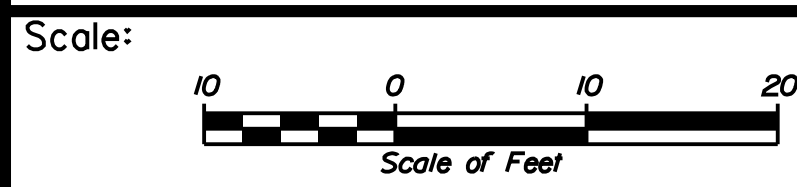

No.	Revision	By	Date

Designed by:

JACOBS

CONSULTANT PROJECT MANAGER: T. MORIN

	By	Date		By	Date
Designed	AMS	7-18	Checked	CSM	7-18
Drawn	SMG	7-18	In Charge of	TWM	7-18

JACOBS ENGINEERING GROUP
120 ST. JAMES AVENUE
BOSTON, MA 02116
TEL (617) 242-9222
FAX (617) 242-9824

**THE GOLD STAR
MEMORIAL HIGHWAY**

MTA PROJECT MANAGER: R. NORWOOD

YORK TOLL PLAZA

ACCESS ROAD CROSS SECTIONS 5



SHEET NUMBER: XS-91

CONTRACT: 2018.20

289 OF 489

Date: 8/28/2018

Filename: ... \02596371\Xsect_Access Road.dgn

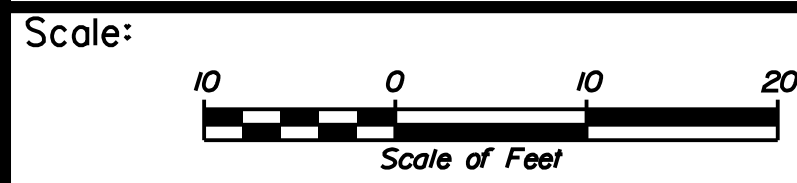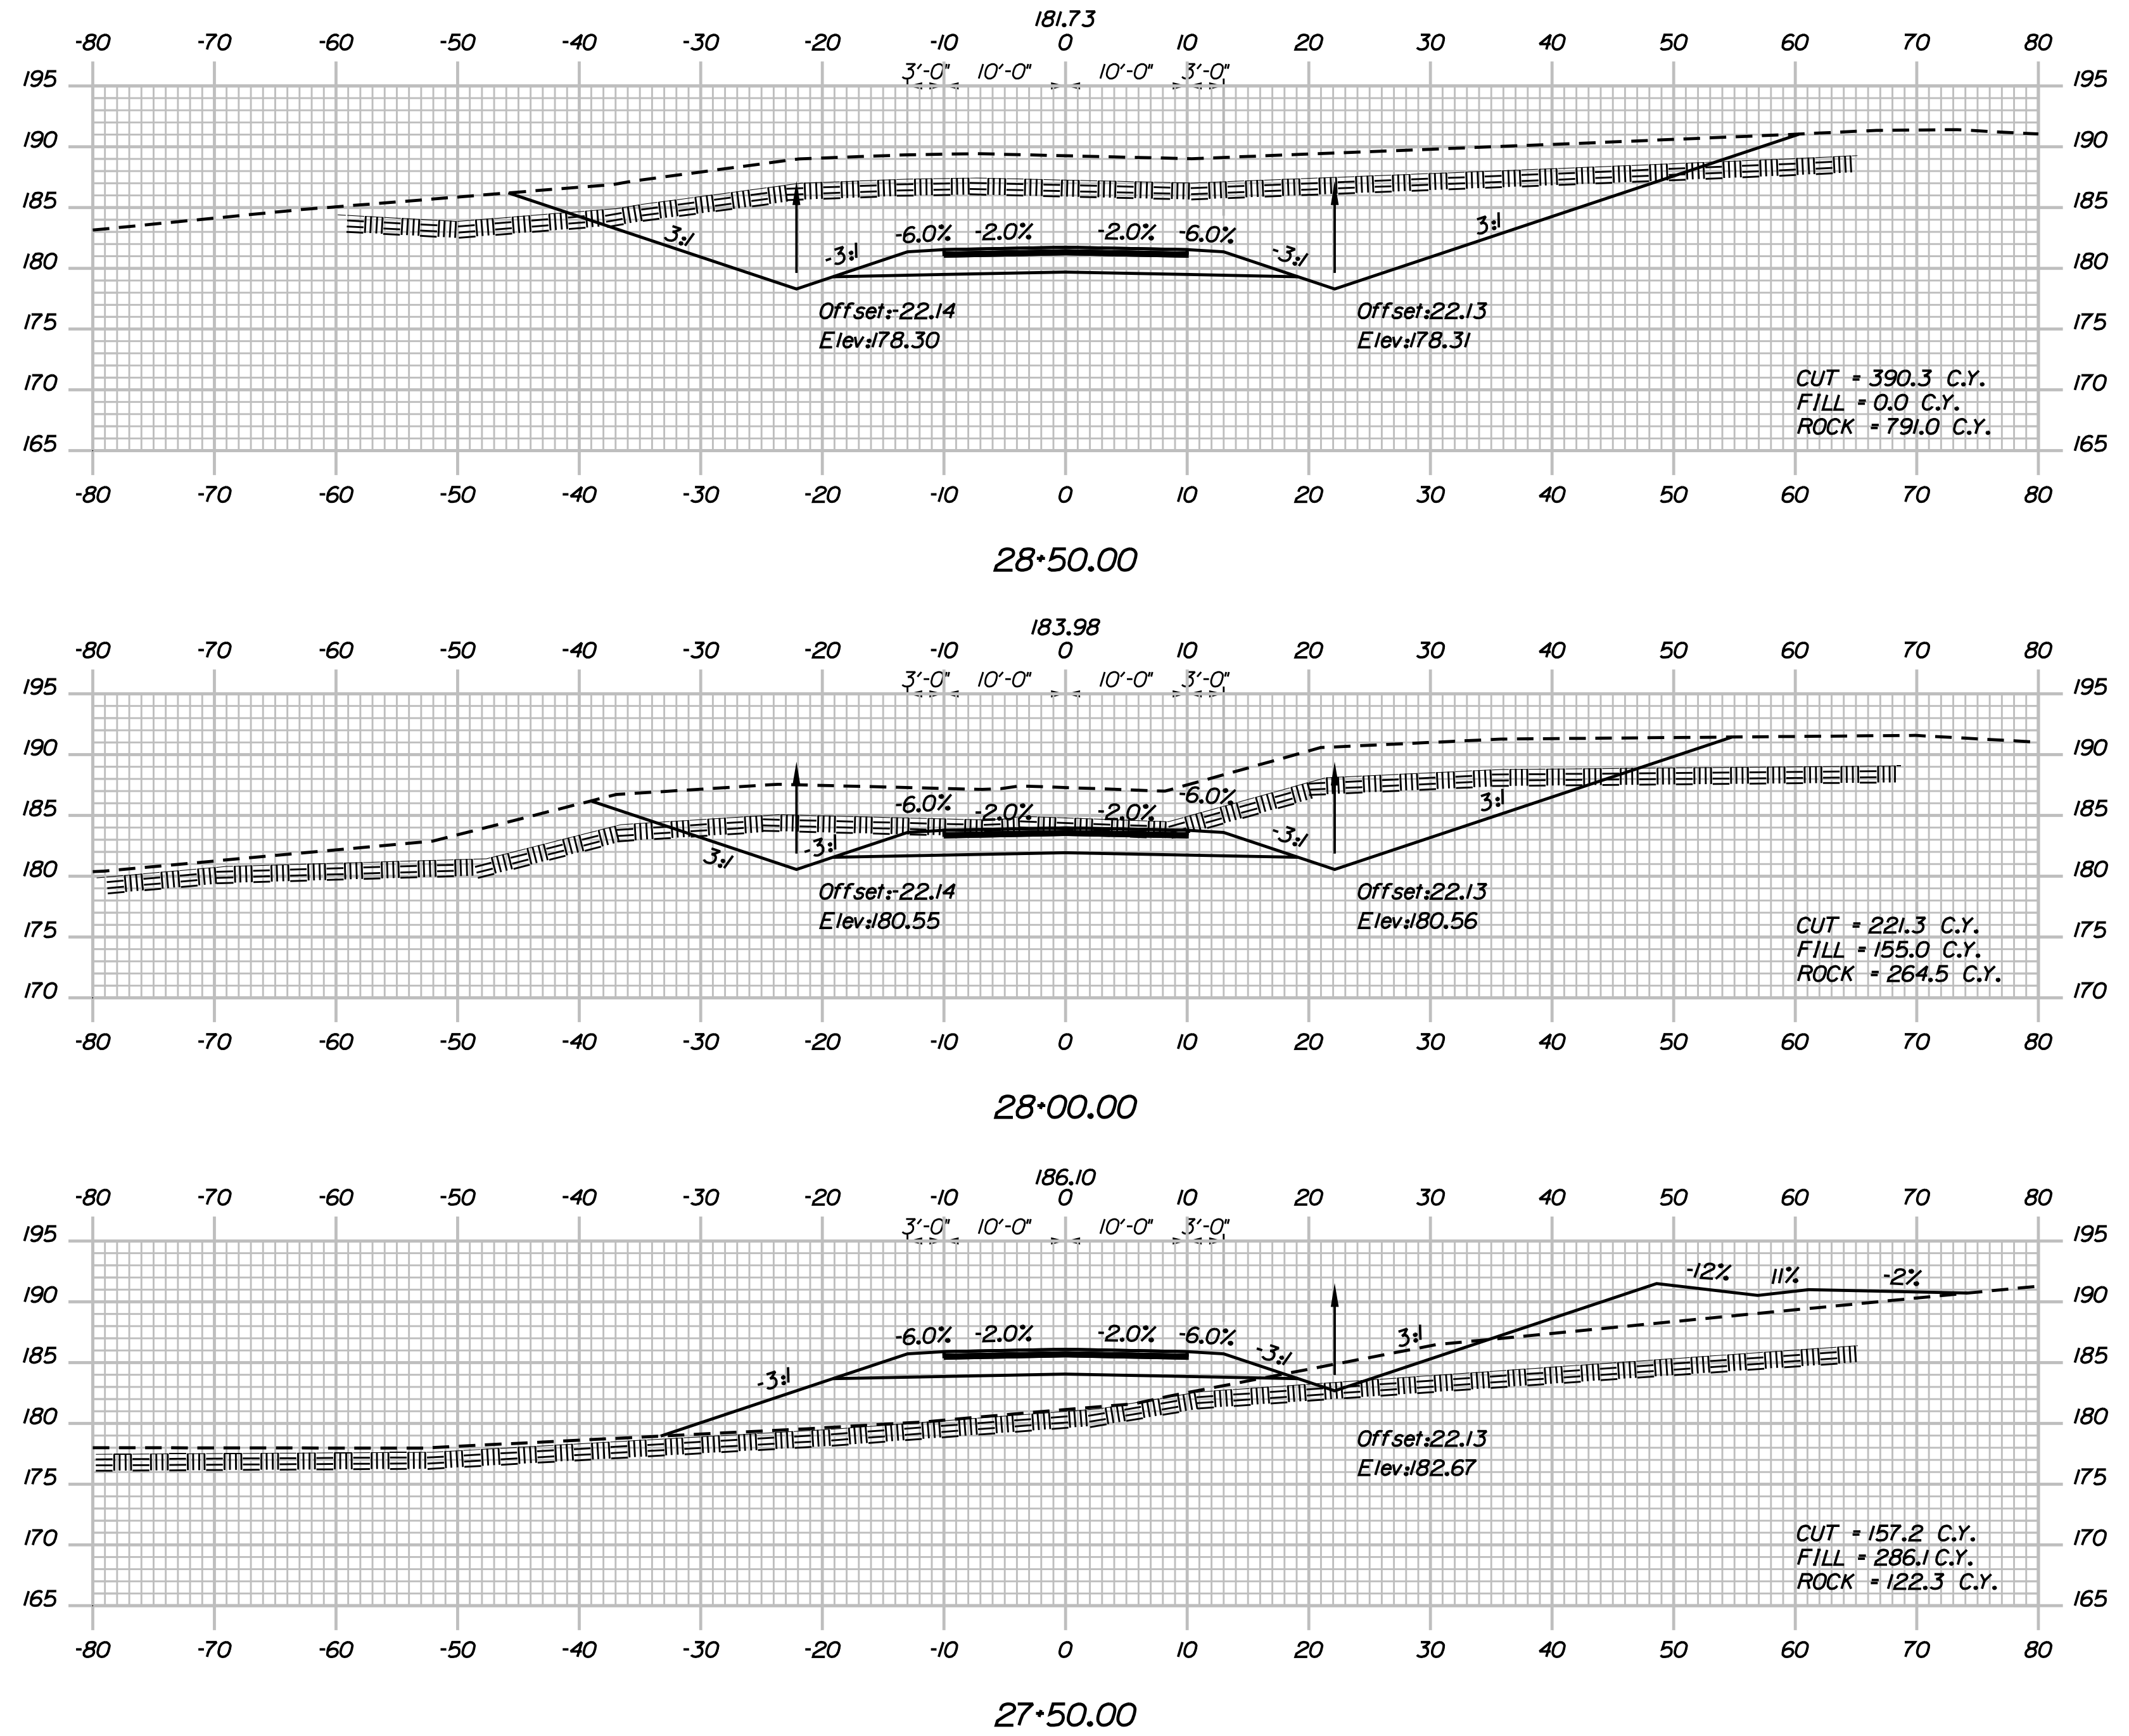

Designed by:



JACOBS ENGINEERING GROUP
 120 ST. JAMES AVENUE
 BOSTON, MA 02116
 TEL (617) 242-9222
 FAX (617) 242-9824



THE GOLD STAR
 MEMORIAL HIGHWAY

YORK TOLL PLAZA
 ACCESS ROAD CROSS SECTIONS 6

No.	Revision	By	Date

CONSULTANT PROJECT MANAGER: T. MORIN					
	By	Date		By	Date
Designed	AMS	7-18	Checked	CSM	7-18
Drawn	SMG	7-18	In Charge of	TWM	7-18

MTA PROJECT MANAGER: R. NORWOOD


CONTRACT: 2018.20

SHEET NUMBER: XS-92


290 OF 489

Date: 8/28/2018


Filename: ... \02596371\Xsect - Access Road.dgn

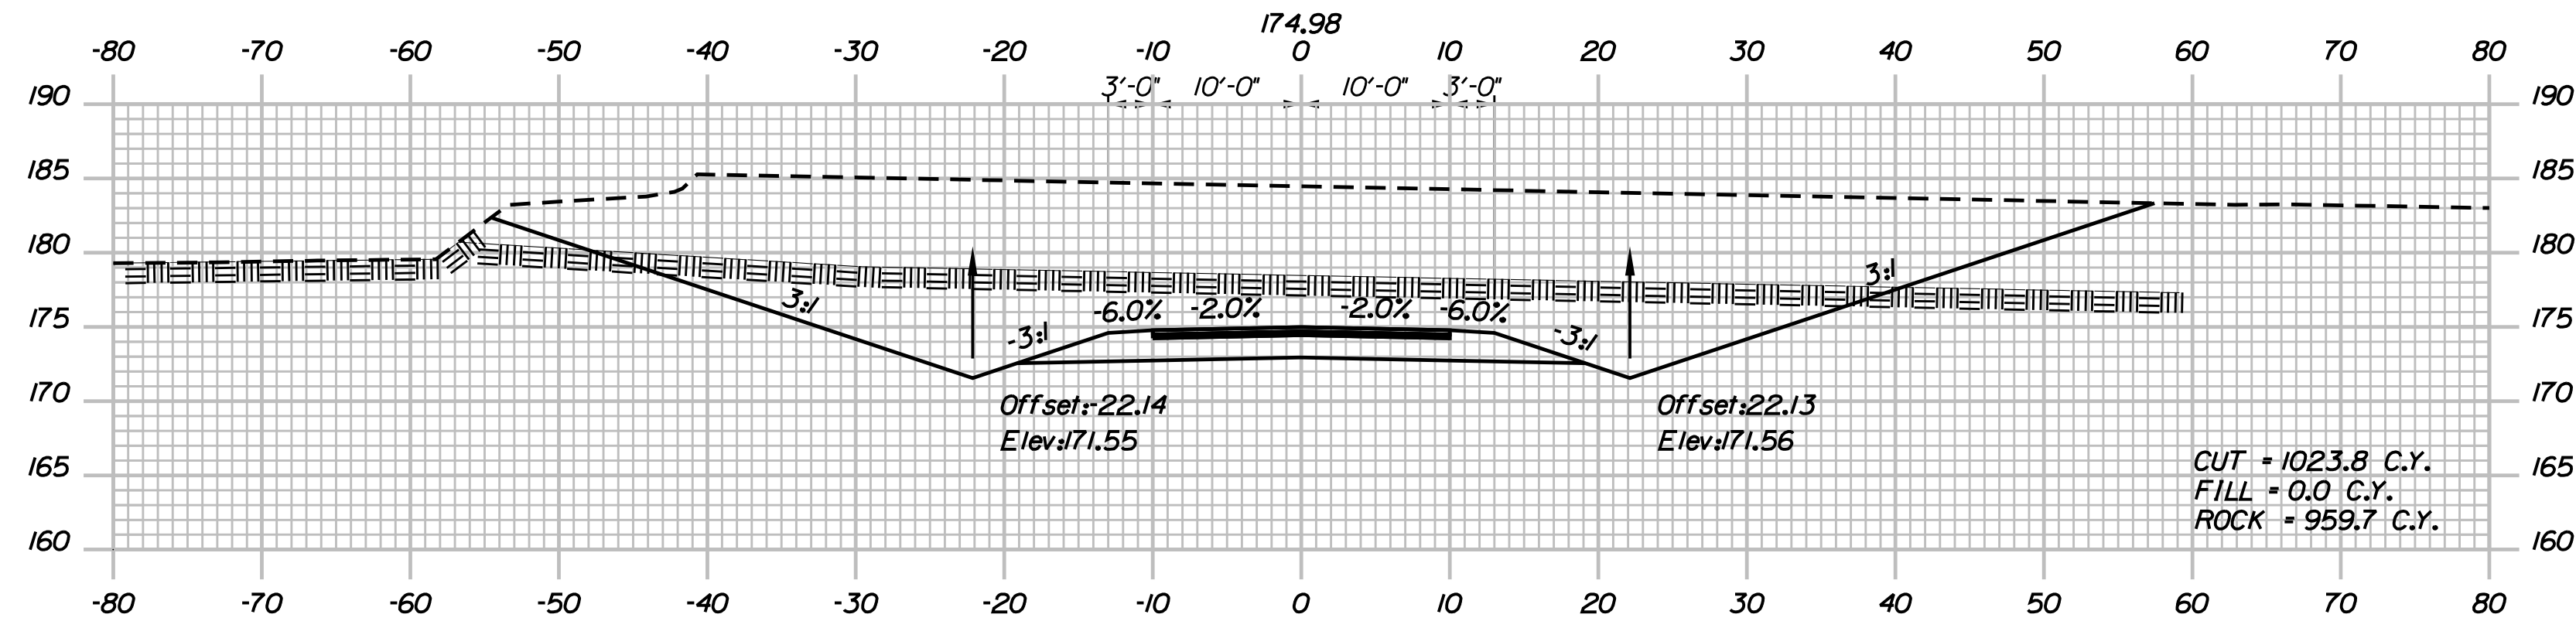


30+00.00

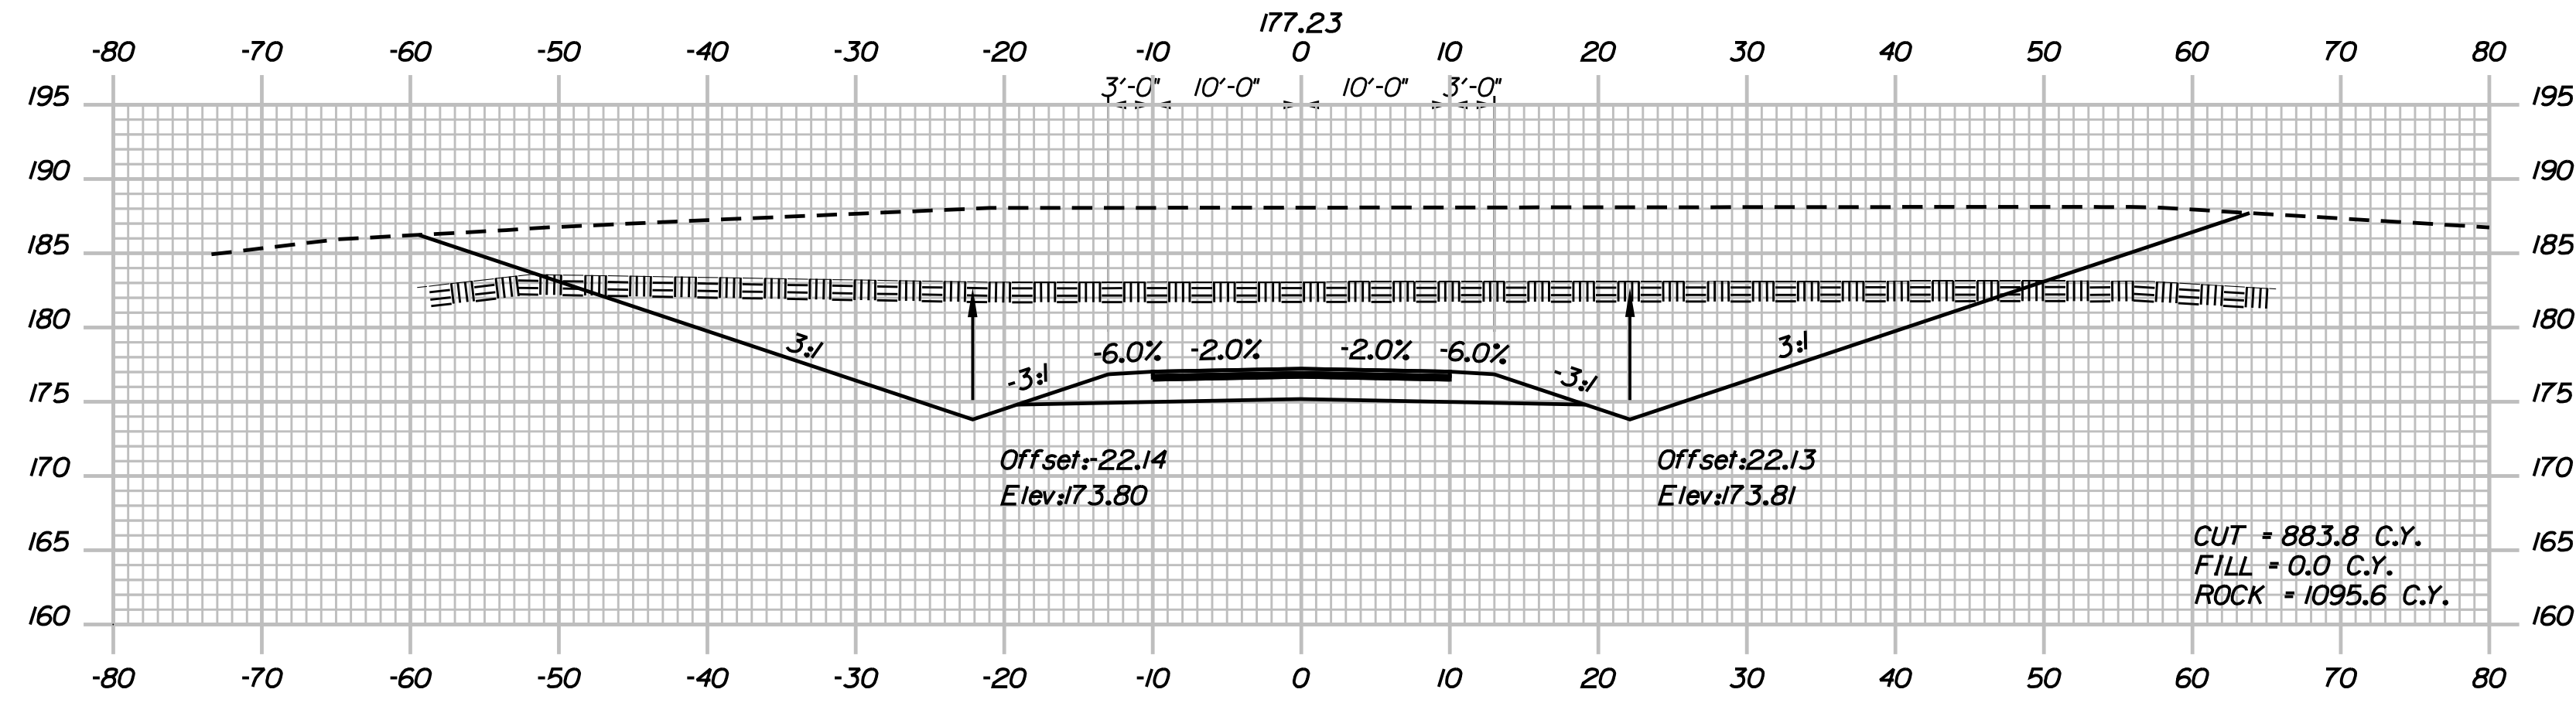

29+50.00

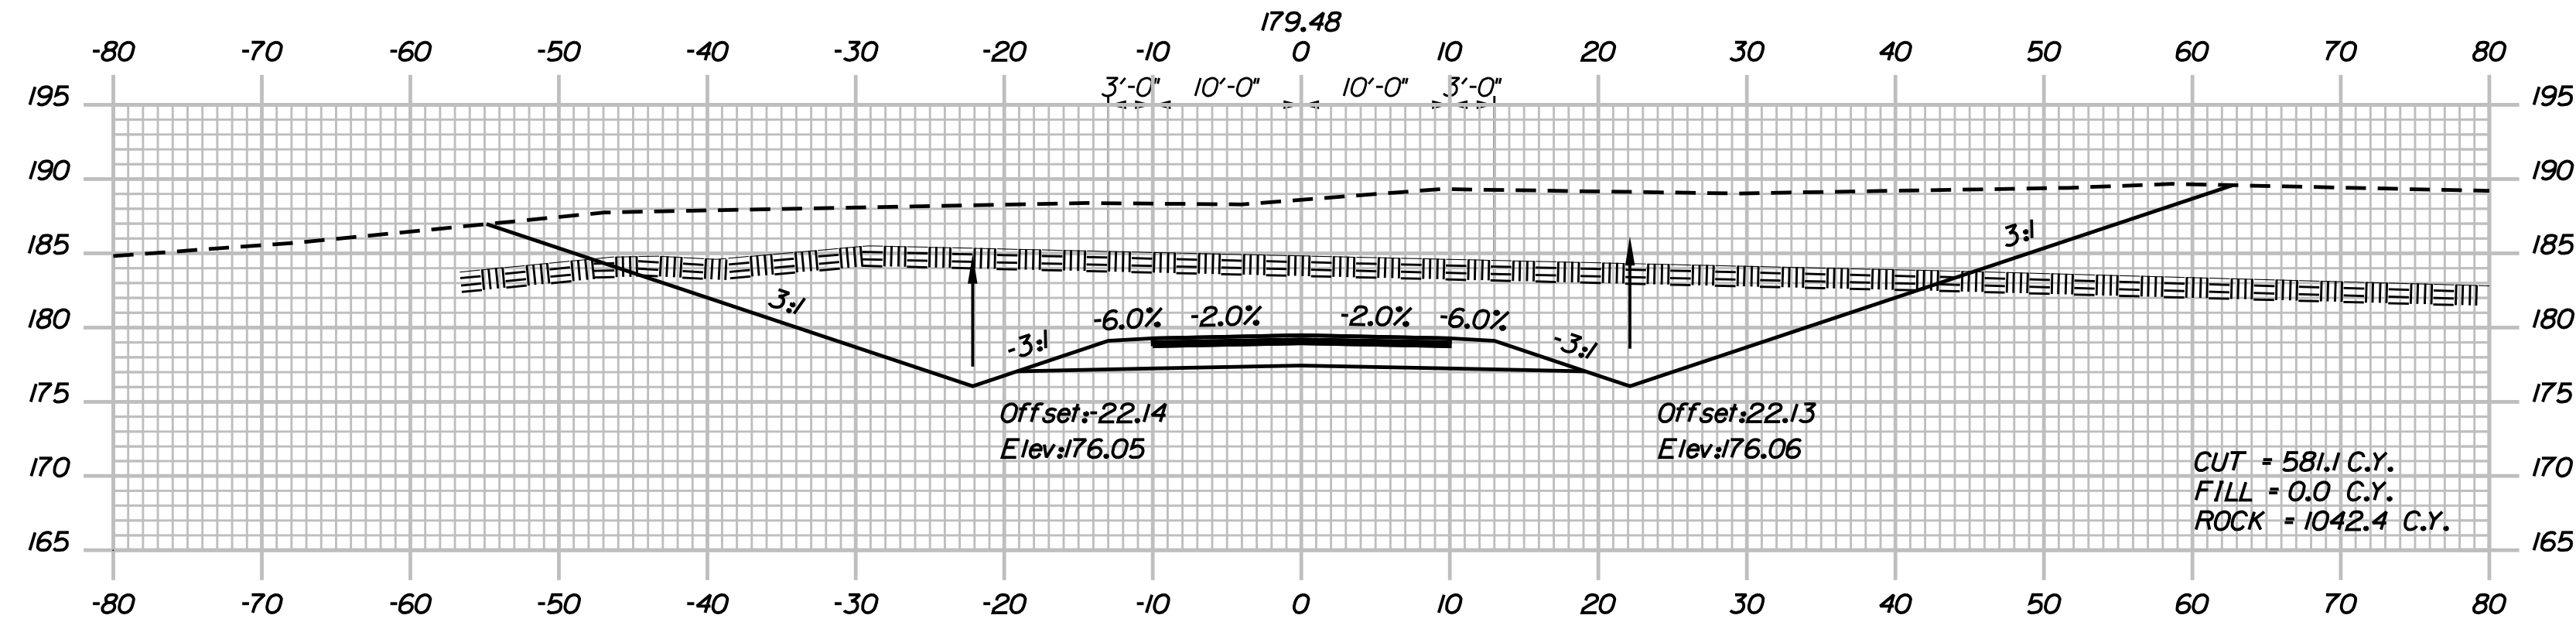

29+00.00

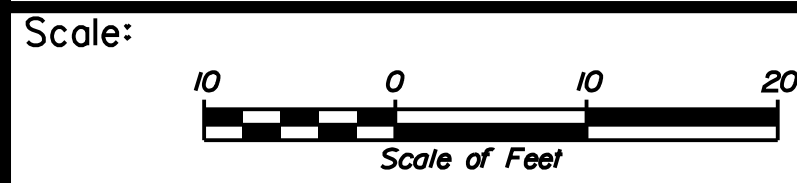

No.	Revision	By	Date

Designed by:

JACOBS

CONSULTANT PROJECT MANAGER: T. MORIN

	By	Date		By	Date
Designed	AMS	7-18	Checked	CSM	7-18
Drawn	SMG	7-18	In Charge of	TWM	7-18

JACOBS ENGINEERING GROUP
 120 ST. JAMES AVENUE
 BOSTON, MA 02116
 TEL (617) 242-9222
 FAX (617) 242-9824

THE GOLD STAR MEMORIAL HIGHWAY

MTA PROJECT MANAGER: R. NORWOOD

YORK TOLL PLAZA

ACCESS ROAD CROSS SECTIONS 7


SHEET NUMBER: XS-93

CONTRACT: 2018.20


291 OF 489

Date: 8/28/2018


Filename: ... \02596371\Xsect - Access Road.dgn

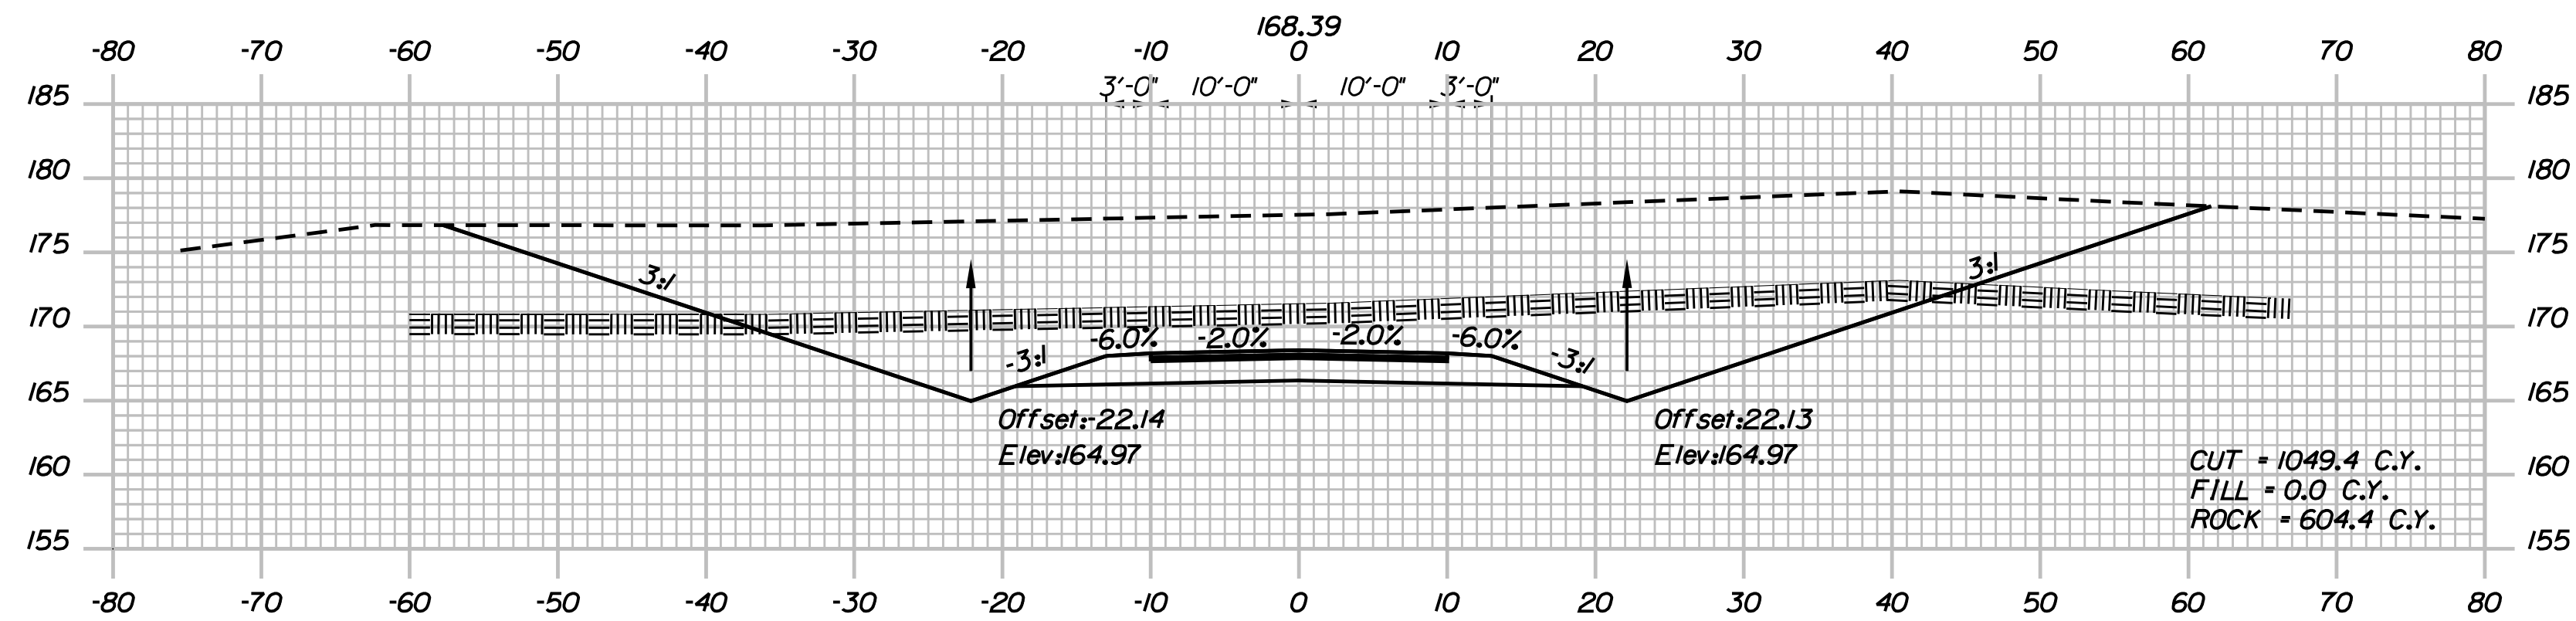


31+50.00

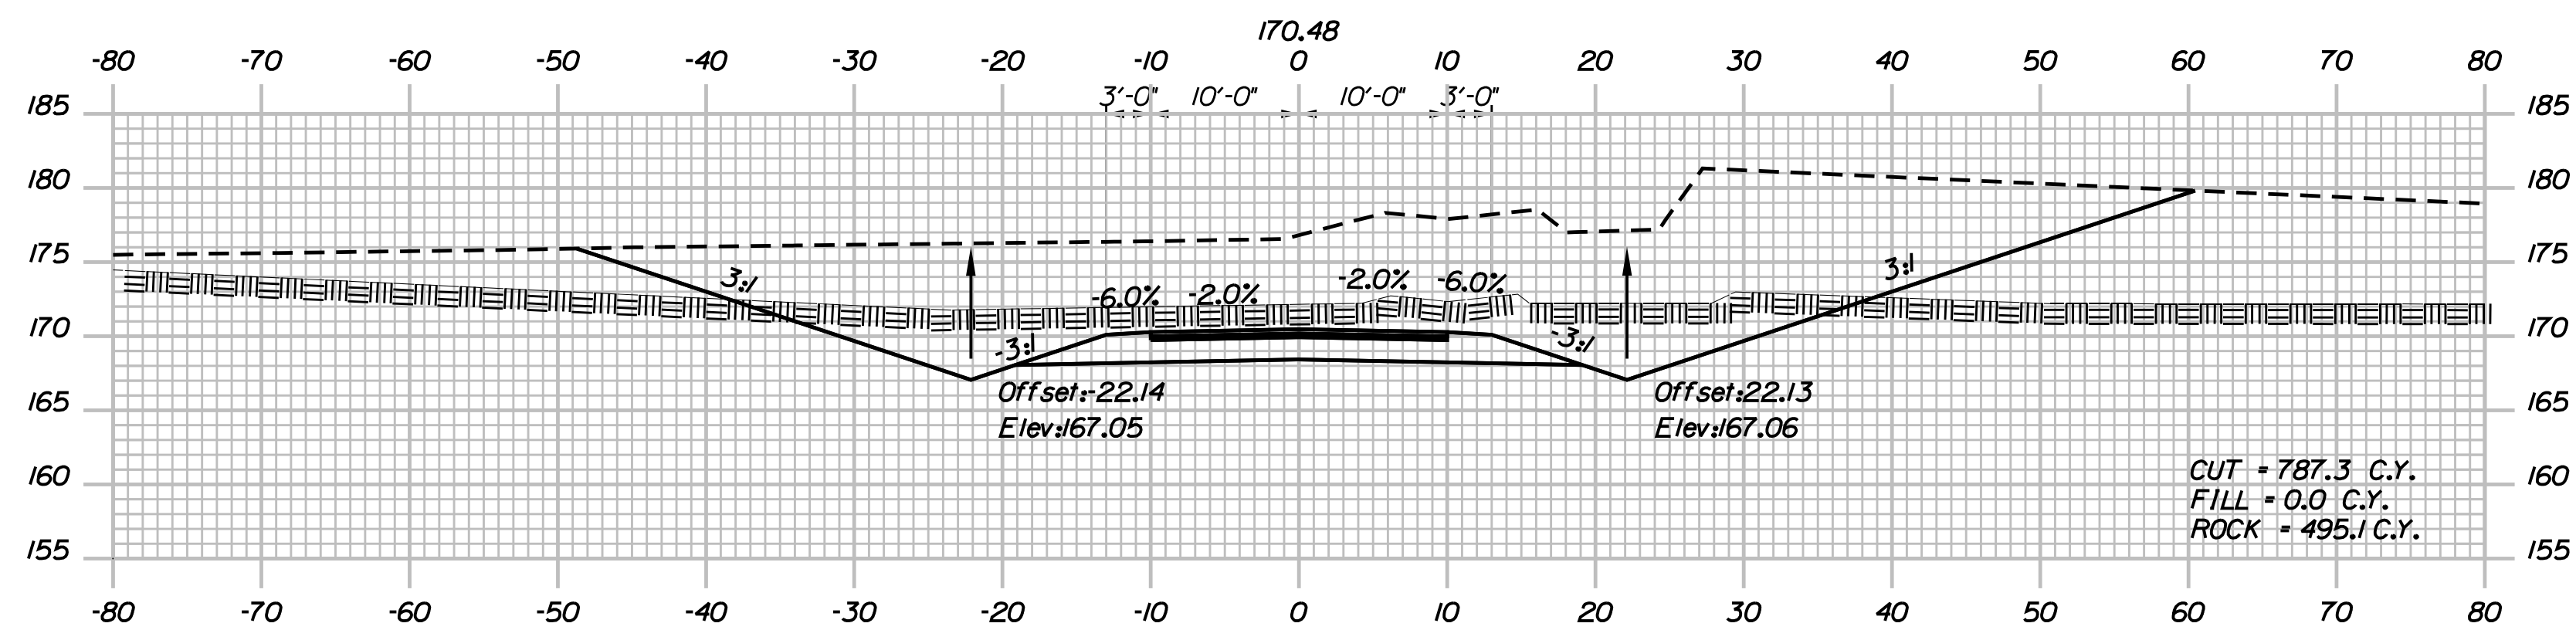

31+00.00

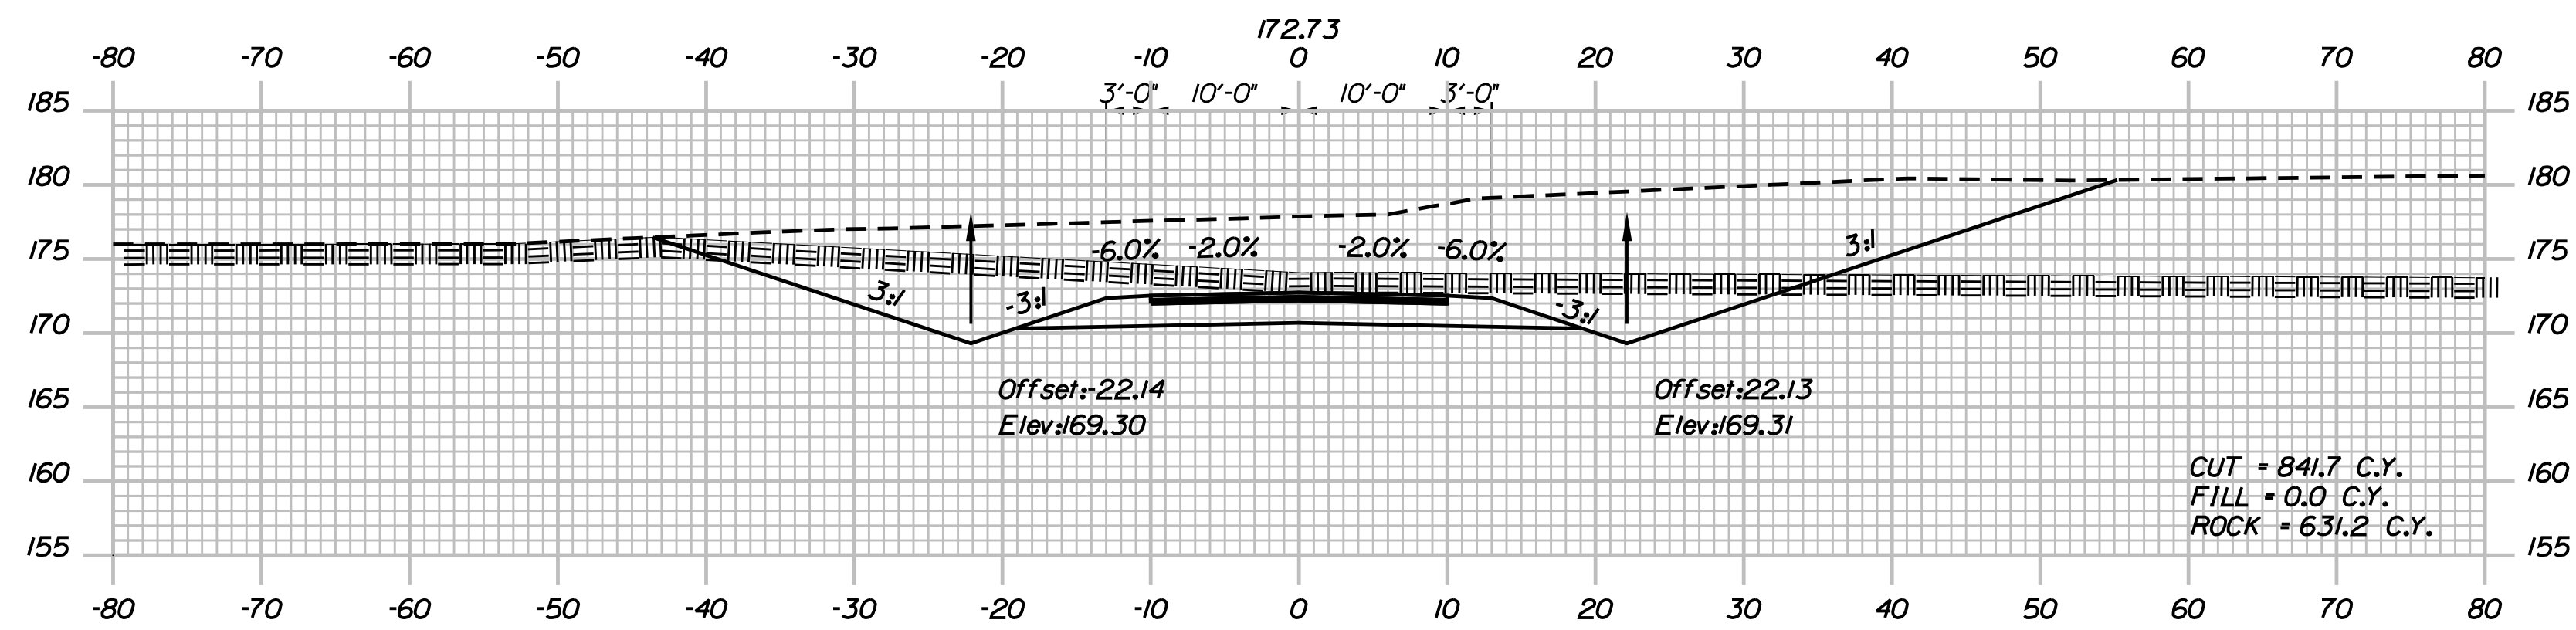

30+50.00

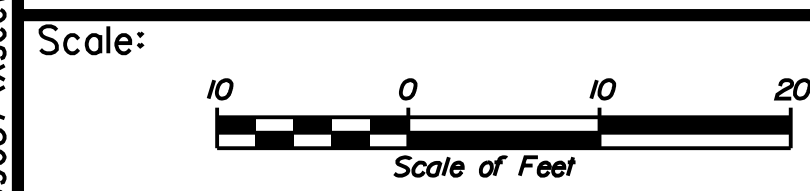

No.	Revision	By	Date

Designed by:

JACOBS

CONSULTANT PROJECT MANAGER: T. MORIN

	By	Date		By	Date
Designed	AMS	7-18	Checked	CSM	7-18
Drawn	SMG	7-18	In Charge of	TWM	7-18

JACOBS ENGINEERING GROUP
 120 ST. JAMES AVENUE
 BOSTON, MA 02116
 TEL (617) 242-9222
 FAX (617) 242-9824

**THE GOLD STAR
 MEMORIAL HIGHWAY**

MTA PROJECT MANAGER: R. NORWOOD

YORK TOLL PLAZA

ACCESS ROAD CROSS SECTIONS 8


SHEET NUMBER: XS-94

CONTRACT: 2018.20


292 OF 489

Date: 8/28/2018


Filename: ... \02596371\Xsect_Access Road.dgn

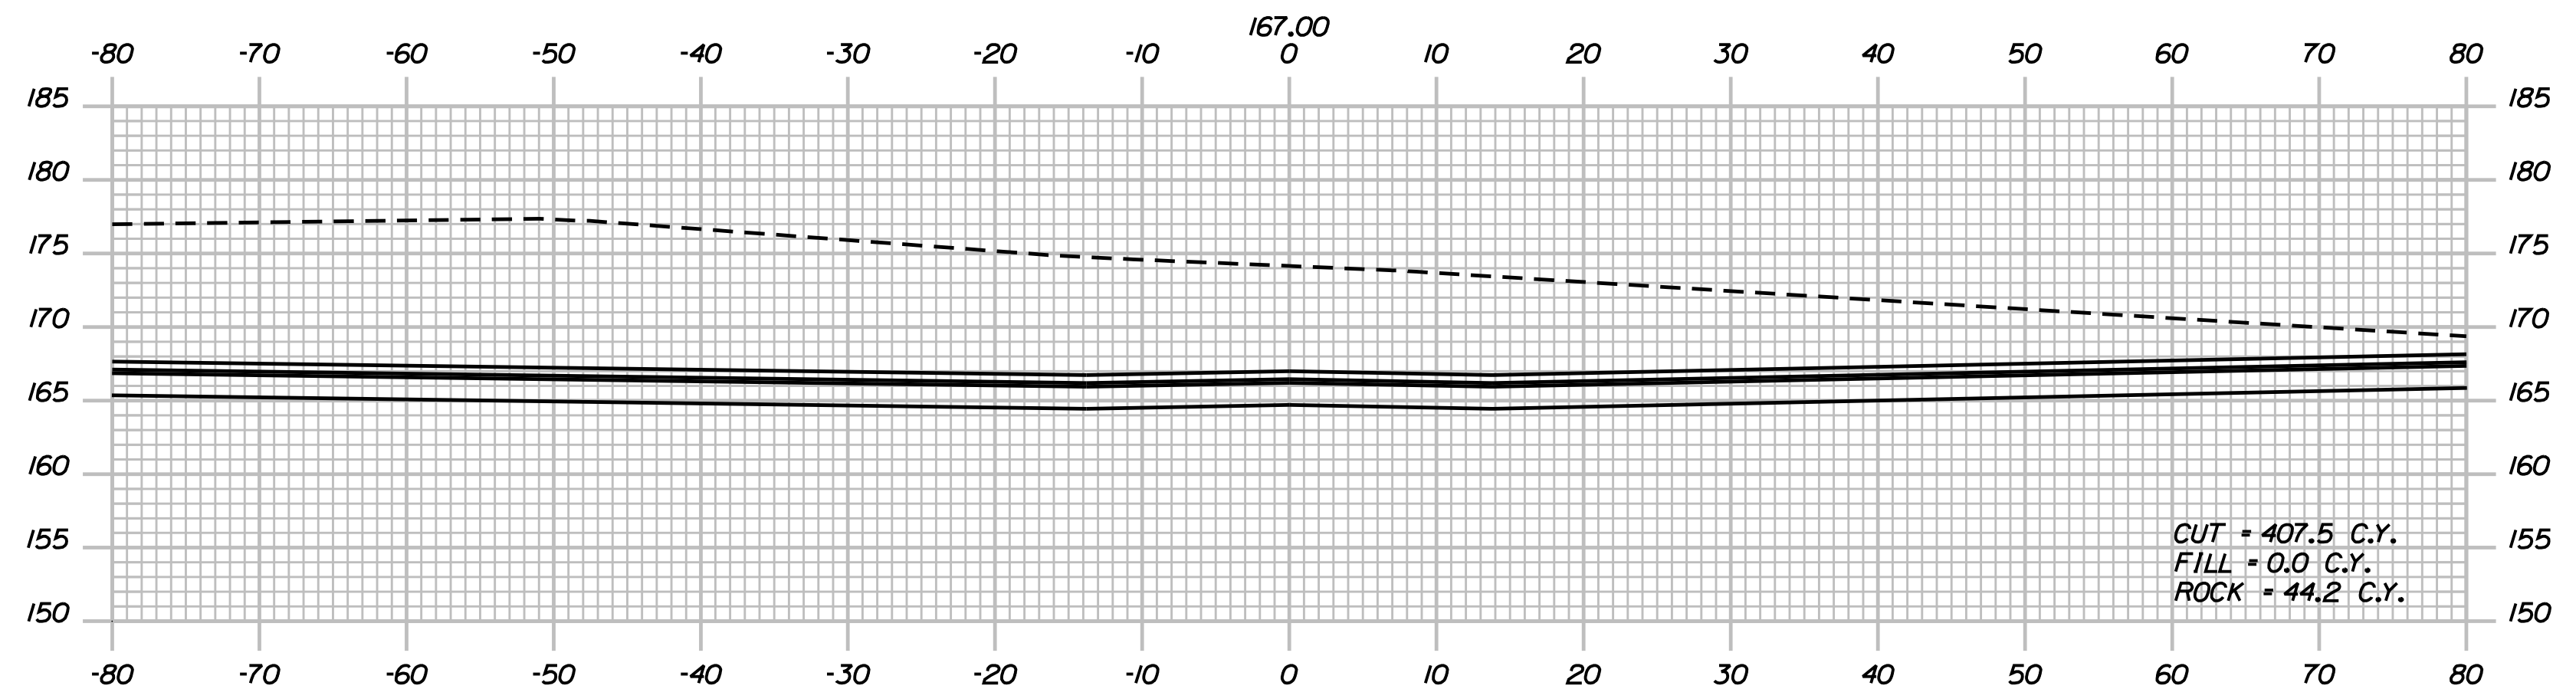

32+76.27

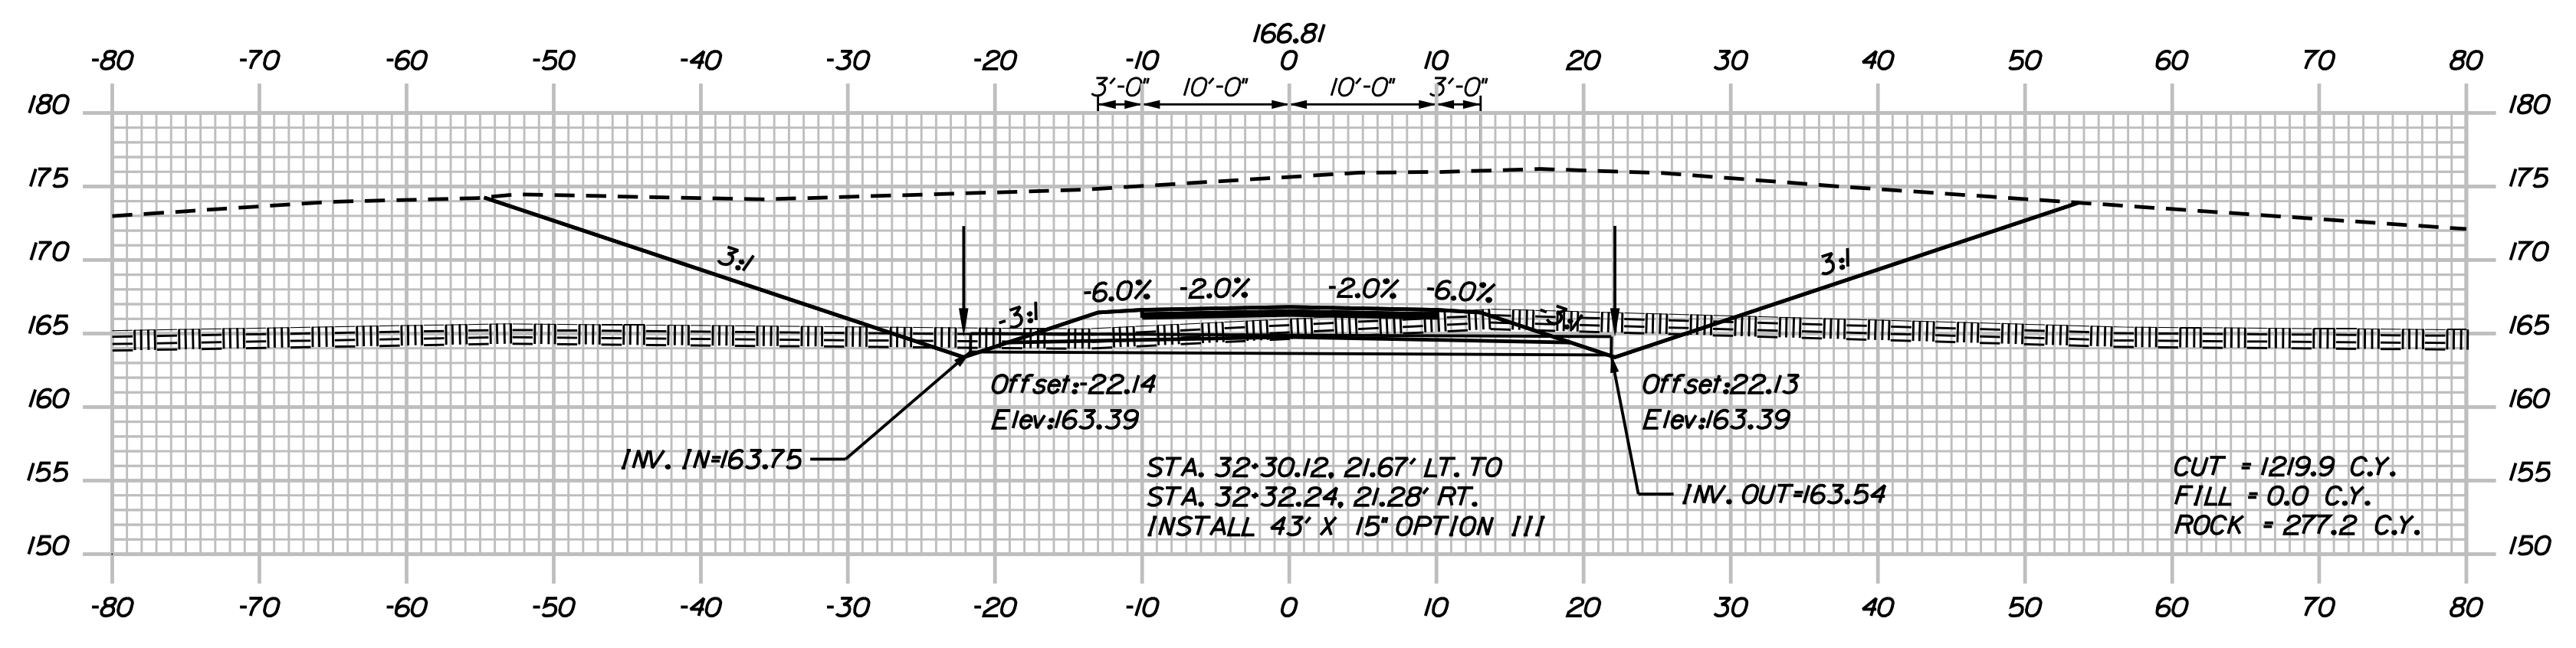

32+50.00

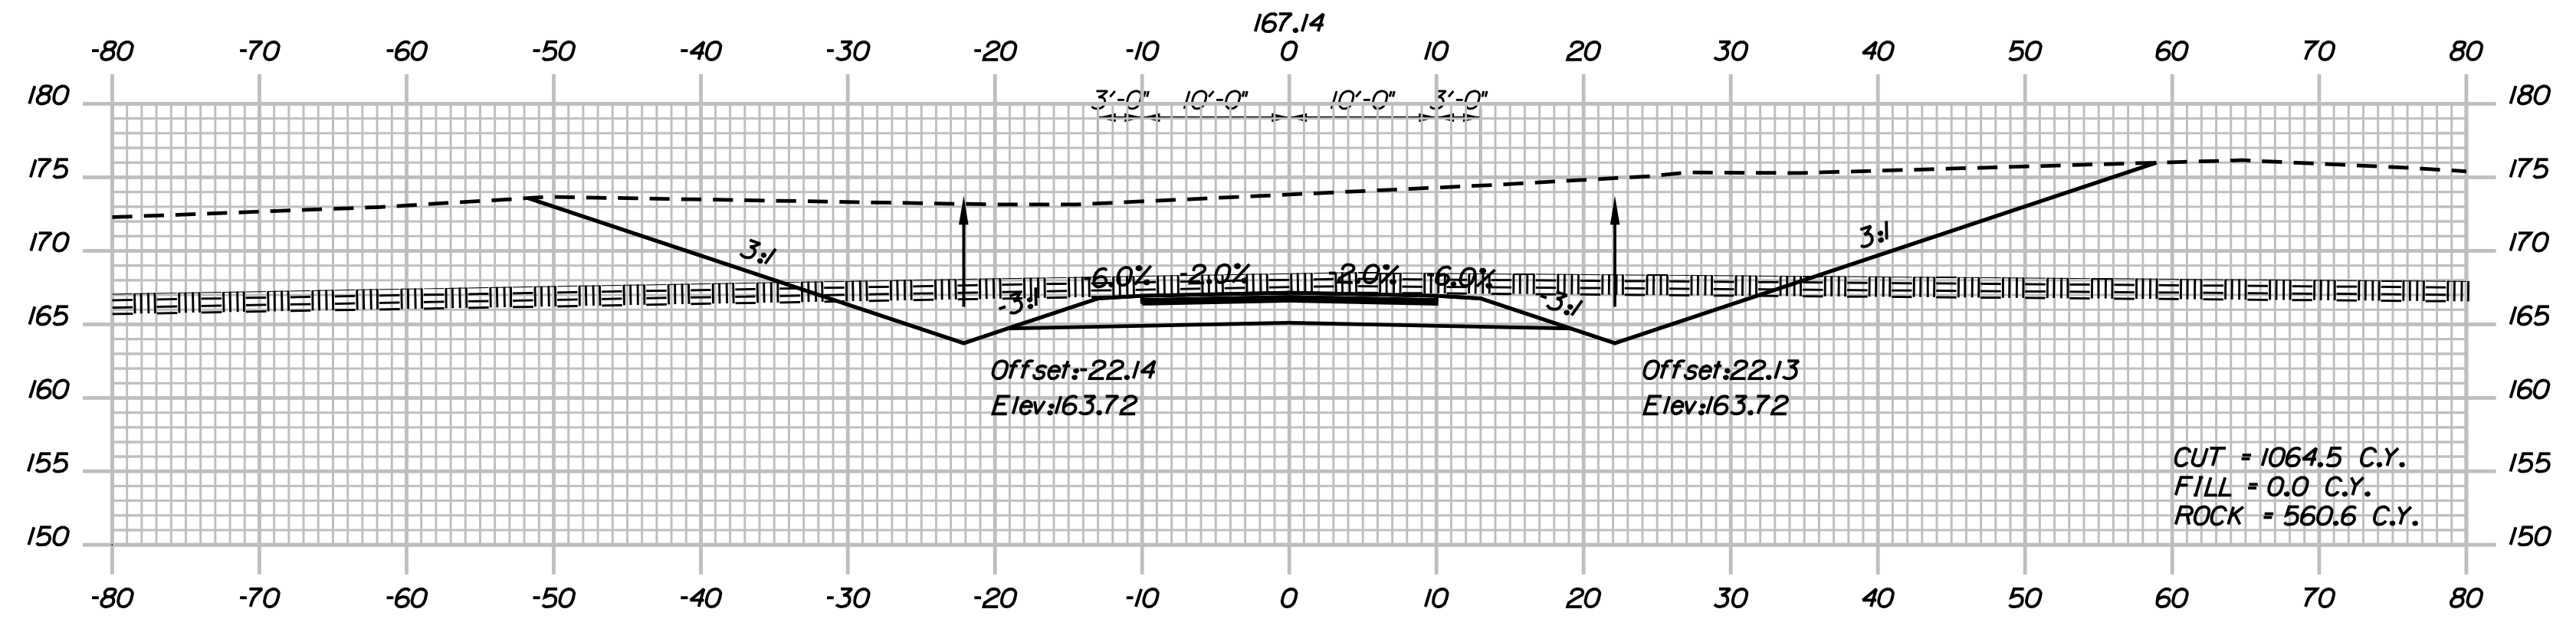

32+00.00

Scale: Scale of Feet

No.	Revision	By	Date

Designed by:

JACOBS

CONSULTANT PROJECT MANAGER: T. MORIN

	By	Date	Checked	By	Date
Designed	AMS	7-18	Checked	CSM	7-18
Drawn	SMG	7-18	In Charge of	TWM	7-18

JACOBS ENGINEERING GROUP
 120 ST. JAMES AVENUE
 BOSTON, MA 02116
 TEL (617) 242-9222
 FAX (617) 242-9824

THE GOLD STAR MEMORIAL HIGHWAY

MTA PROJECT MANAGER: R. NORWOOD

YORK TOLL PLAZA

ACCESS ROAD CROSS SECTIONS 9

SHEET NUMBER: XS-95

CONTRACT: 2018.20

293 OF 489